



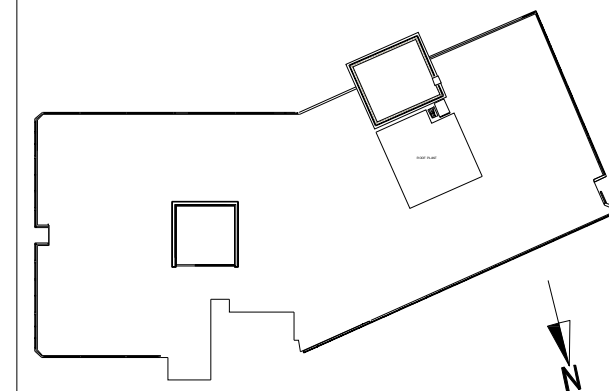

LOCATION PLAN
NOT TO SCALE

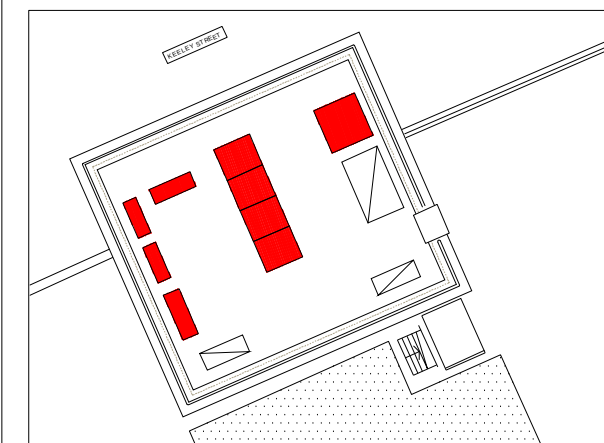

PROPOSED ROOF PLAN
NOT TO SCALE

KEY:	
NEW SPLIT CONDENSERS	
NEW VRV CONDENSER	
EXISTING PLANT	
EXISTING PIPEWORK	
NEW PIPEWORK	

65 KINGSWAY
LONDON WC2B 6TD

NAME: PIPE ROUTE_REV B
SCALE: 1:50
PAPER SIZE: A3

DATE: 01.04.10
DRAWN: MCL

THE **INTERIORS** GROUP