


NOTES:

9 AND 10 ST ANDREWS PLACE, TO BE PROVIDED WITH NEW FIRE ALARM SYSTEM TO L1 CATEGORY OF COVERAGE IN ACCORDANCE WITH BRITISH STANDARD 5839.

9 AND 10 ST ANDREWS PLACE TO BE PROVIDED WITH NEW EMERGENCY LIGHTING TO ALL ESCAPE ROUTES, COMMON AREAS AND BEDROOM TOILETS/BATH AREAS IN ACCORDANCE WITH BS 5266.

"YE" ADJACENT GENERAL PURPOSE LUMINAIRE INDICATES LUMINAIRE WITH 3 HOUR NON MAINTAINED SELF CONTAINED EMERGENCY LIGHTING FACILITY

"EXIT" INDICATES NON MAINTAINED 3 HOUR SELF CONTAINED ILLUMINATED EXIT SIGN.

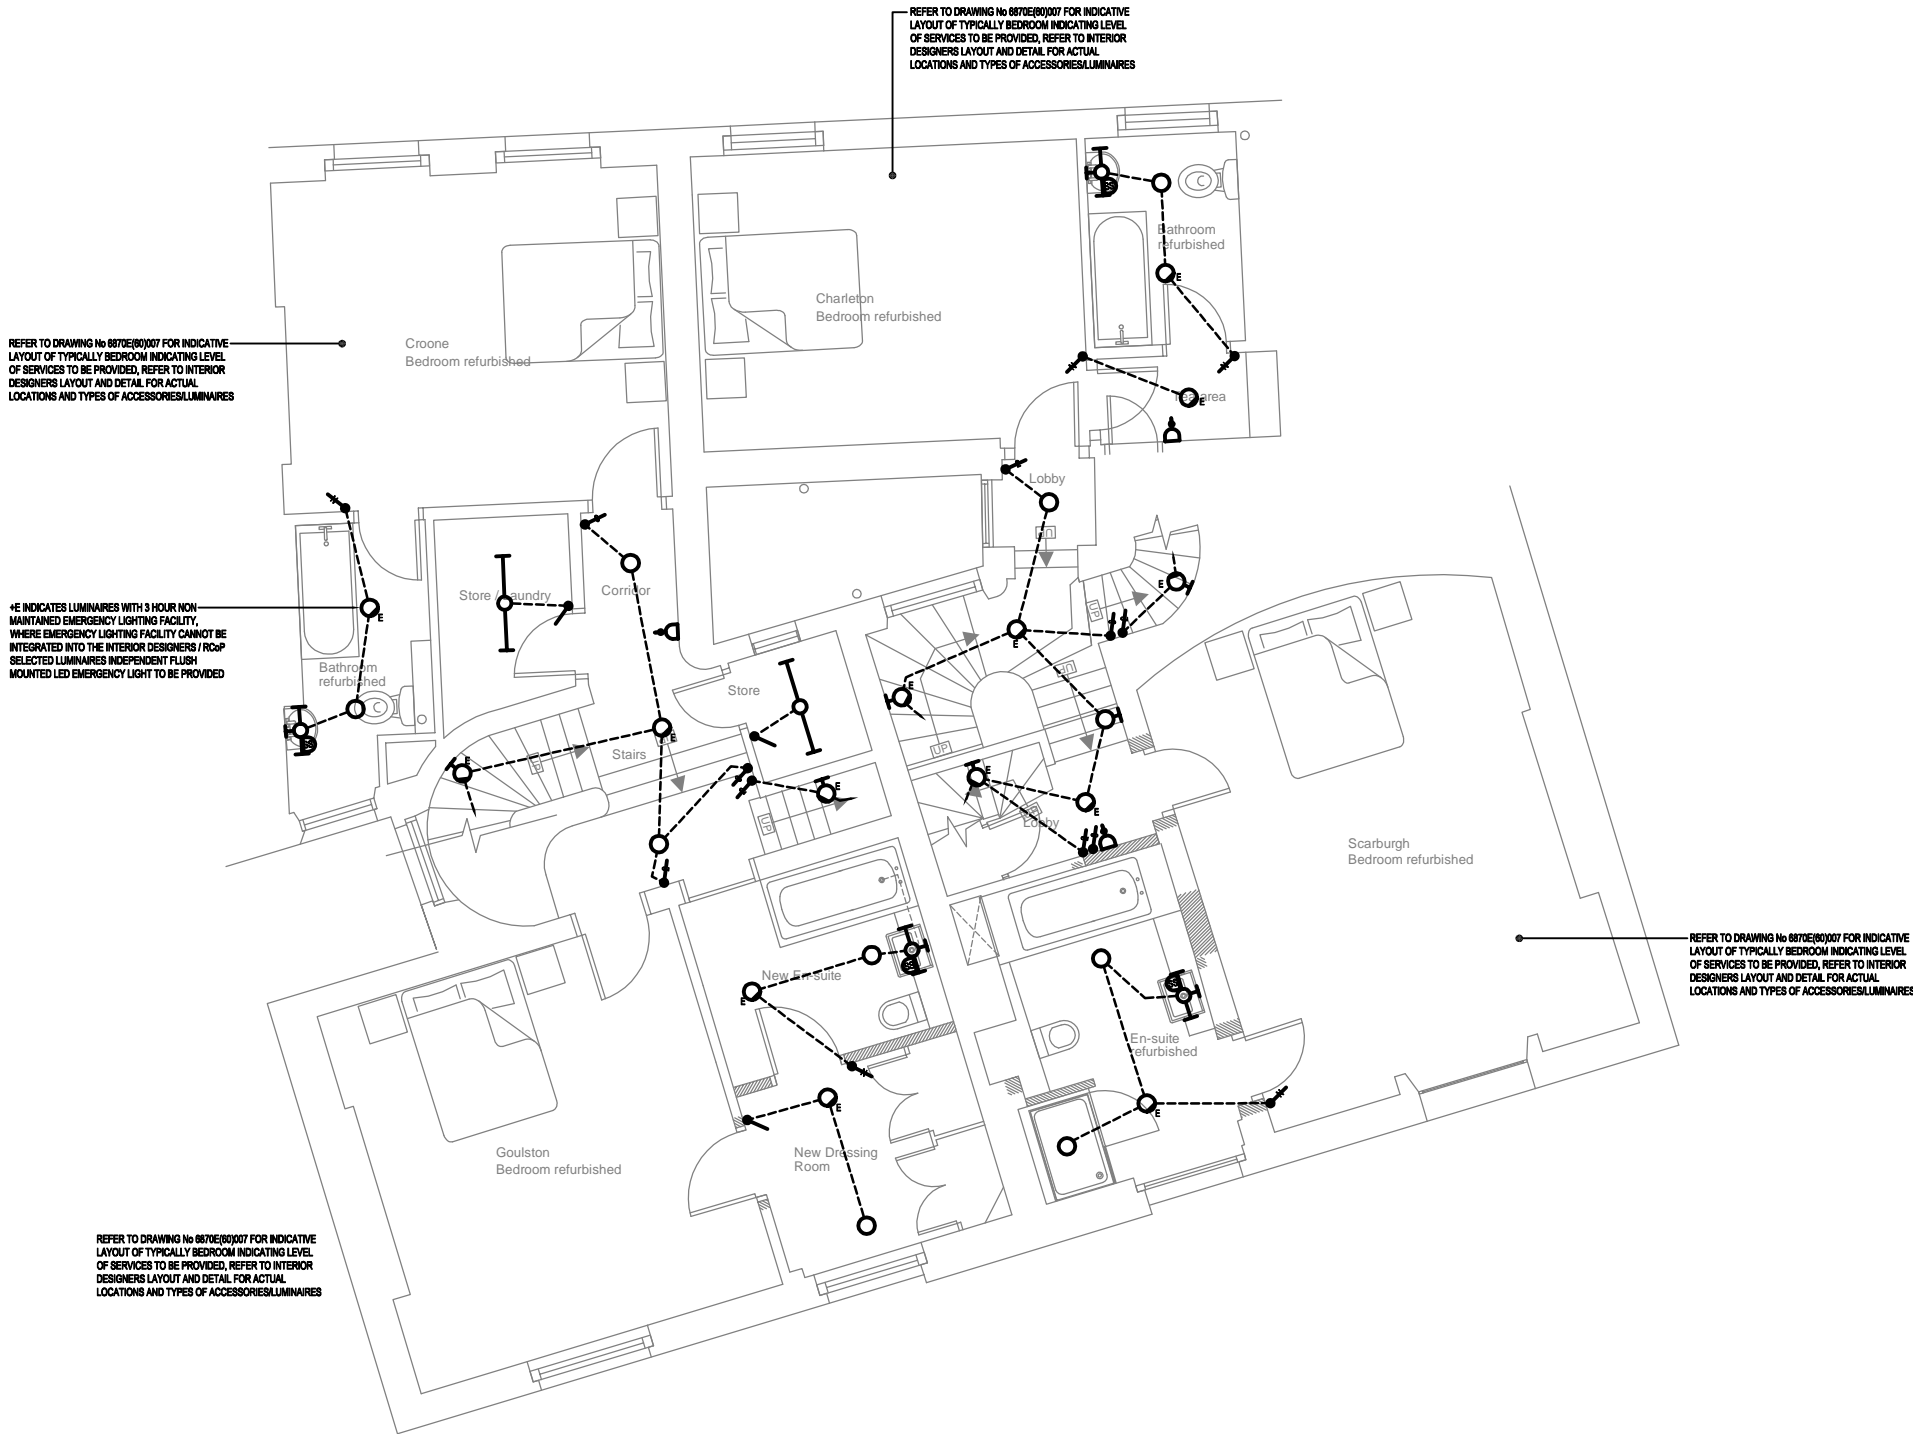

SECOND FLOOR PLAN

P2	07.05.10	SCALE BAR AND NORTH POINTER ADDED	CHK	JB	ADM
P1	06.05.10	FA AND EL GENERAL NOTES ADDED	CHK	JB	ADM
REV	DATE	DESCRIPTION	ALT	DO	ORIG
			CHK	CHK	CHK

TGA Consulting Engineers LLP
Armstrong House,
Norton Road
Stevenage
Hertfordshire, SG1 2LX
T: 01438 314422
F: 01438 314433
E: stevenage@tgace.co.uk



Project
ROYAL COLLEGE OF PHYSICIANS
9&10 ST ANDREWS PLACE

Title
ELECTRICAL ENGINEERING SERVICES
PROPOSED SECOND FLOOR PLAN
INDICATIVE LIGHTING & POWER

Architect
EDGINGTON SPINK-HYNE

Client
ROYAL COLLEGE OF PHYSICIANS

Drawing Number	Revision	Scale	
		A1	1:50
6870E(60)009	P2	A3	N.T.S.
		A4	N.T.S.

Path
J:\6870E(60)009

Architects Drawing Reference
4850-1203 Rev B

Drawn	DO Check	Originator	Approved
Date 2010 JAN	Status		