


22 Gordon Square

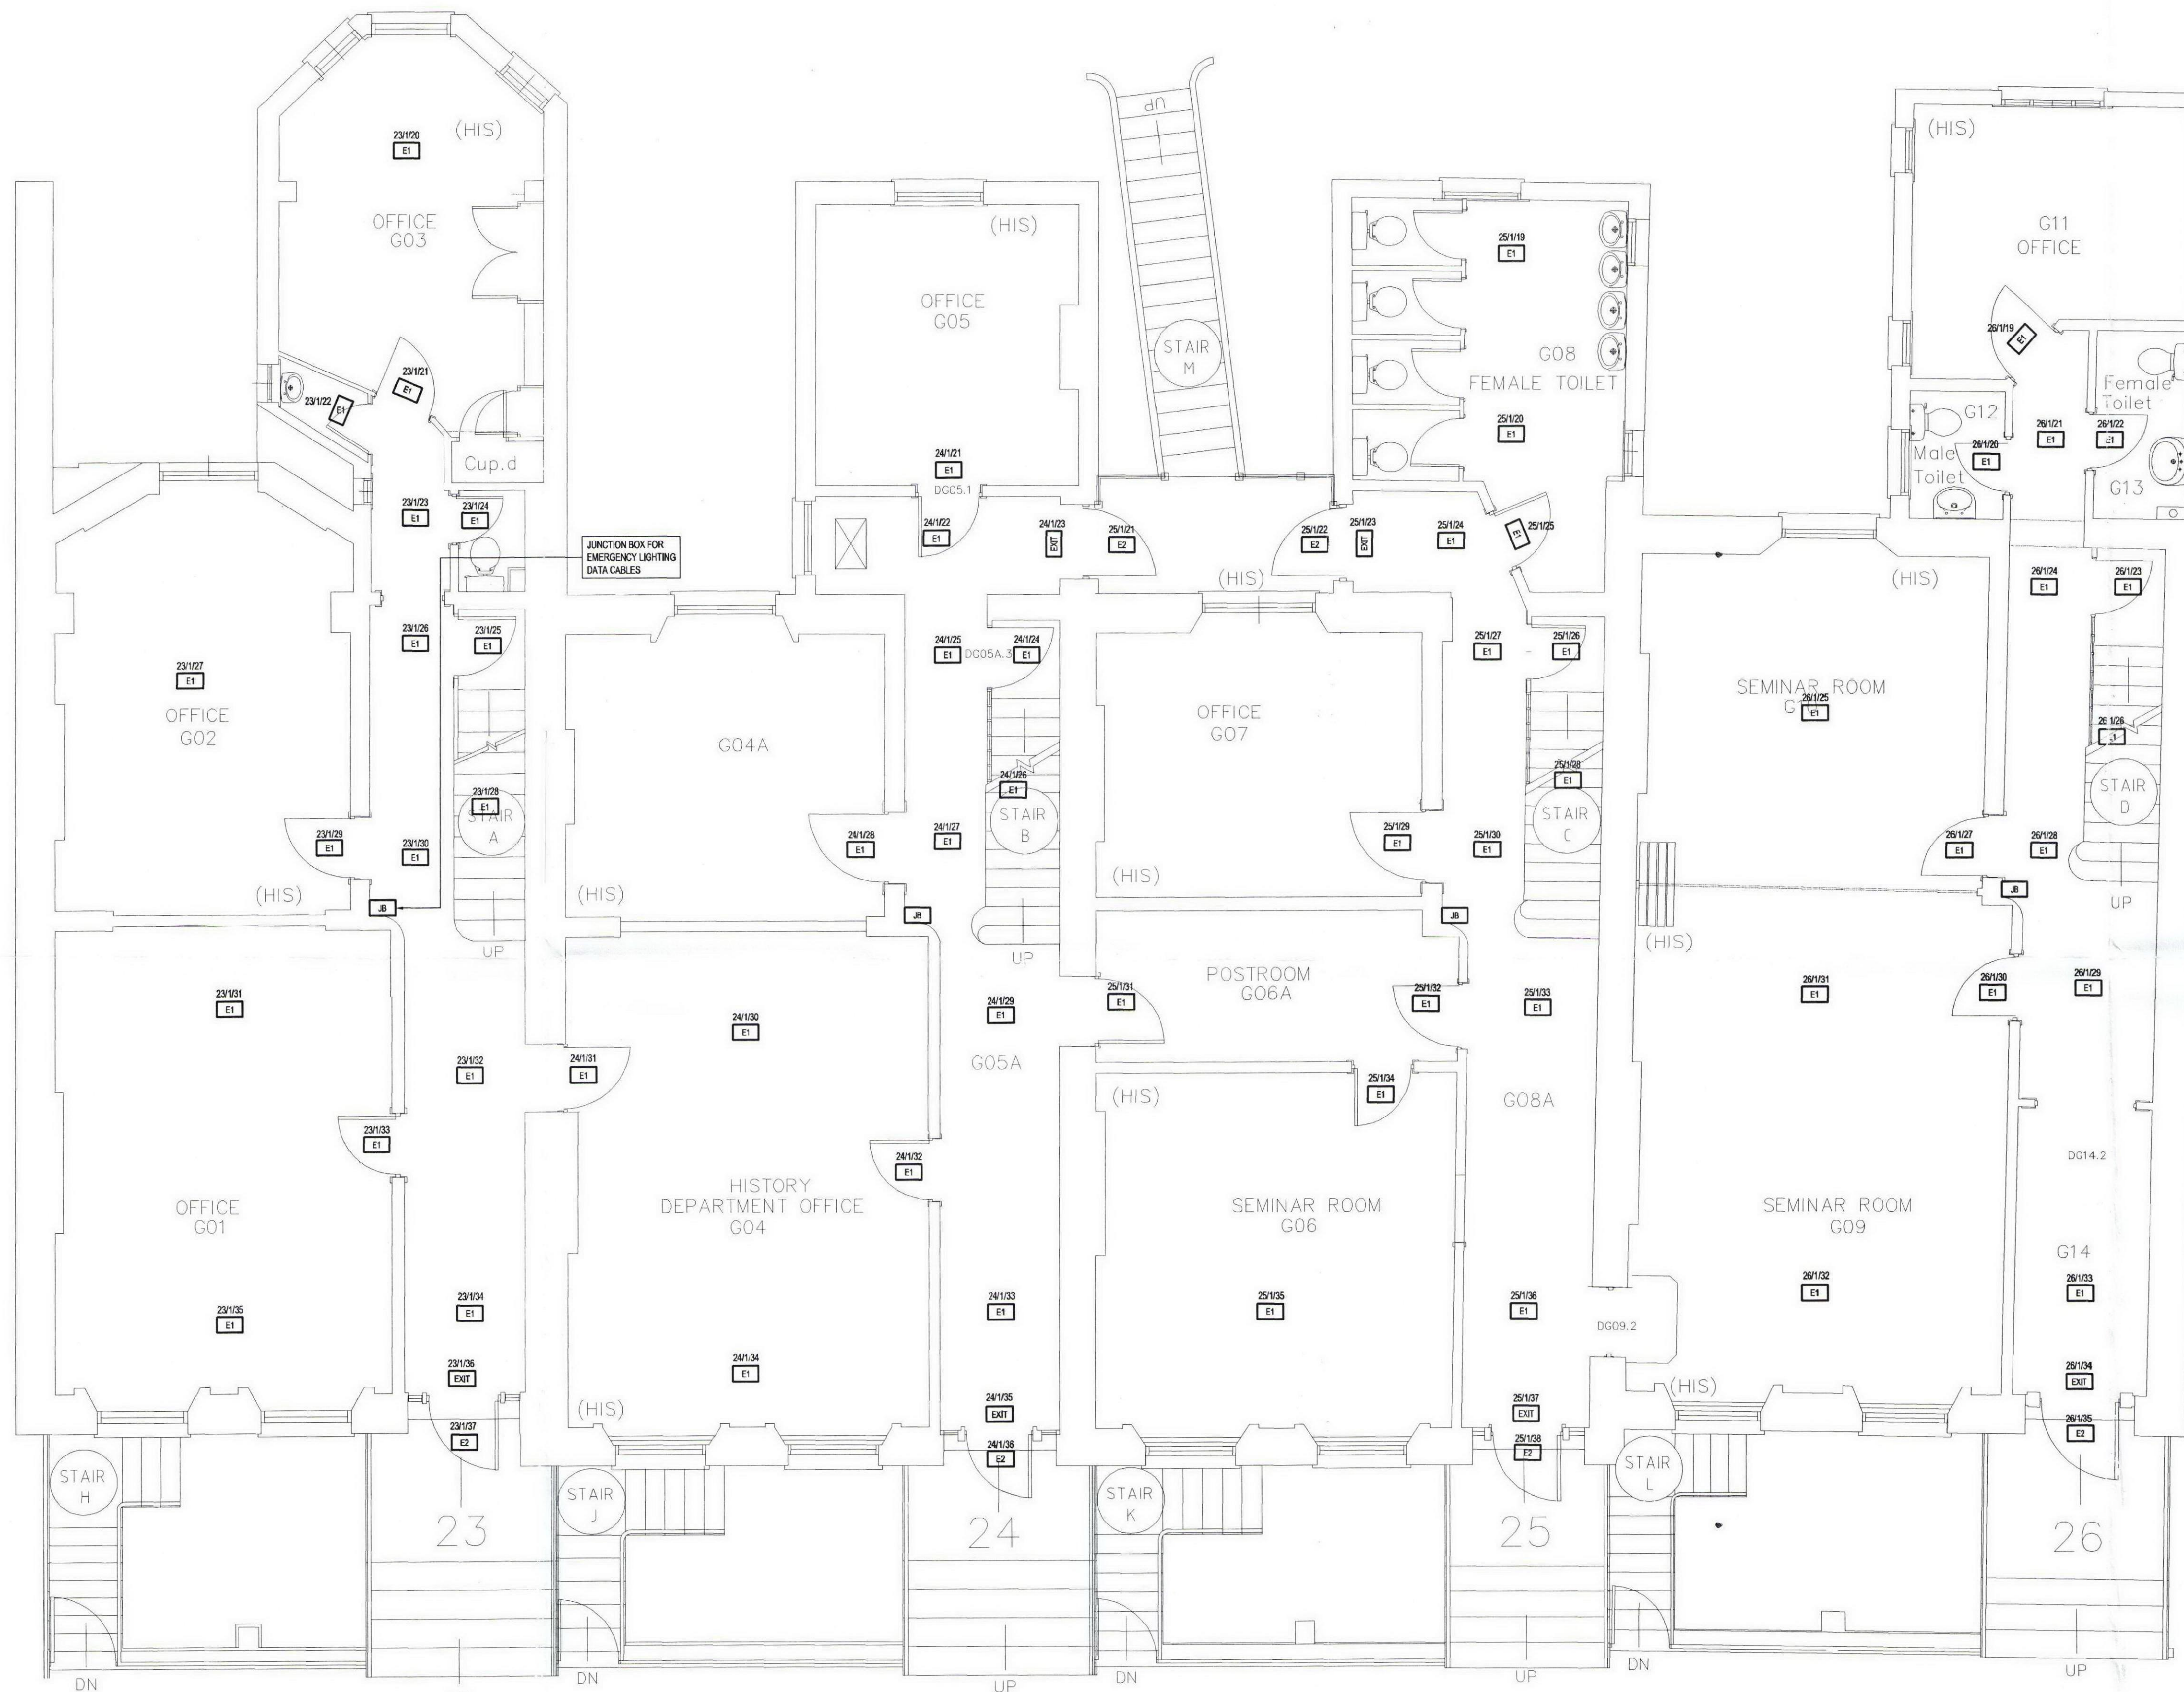


23 - Ground Floor

24 - Ground Floor

25 - Ground Floor

26 - Ground Floor

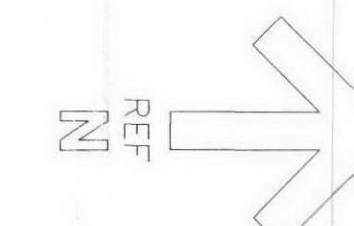

This drawing should be read in conjunction with the specification and shall not be used in lieu of the service contractors working drawings. At construction stage, the service contractors are required to prepare coordinated drawings for construction purposes under the terms of the contract.

A1

- LEGEND
- STAND ALONE EMERGENCY LUMINAIRE
 - STAND ALONE (EXTERNAL) EMERGENCY LUMINAIRE
 - ILLUMINATE EXIT SIGN
 - THORN EXPANDER PANEL
 - THORN DATA COMMS COMMUNICATOR
 - FUSED CONNECTION UNIT
 - JUNCTION BOX FOR DATA CABLES TO EMERGENCY LUMINAIRES
 - UCL NETWORK DATA POINT
 - EXISTING DISTRIBUTION BOARD

REV	DATE	DESCRIPTION	ALT	DO	ORIG	APP
-----	------	-------------	-----	----	------	-----

TGA Consulting Engineers LLP
Armstrong House,
Norton Road
Stevenage
Hertfordshire, SG1 2LX
T: 01438 314422
F: 01438 314433
E: stevenage@tgace.co.uk

tga
Consulting Engineers LLP

Project
UNIVERSITY COLLEGE LONDON
23-26 GORDON SQUARE HOUSES

Title
ELECTRICAL ENGINEERING SERVICES
GROUND FLOOR PLAN
REPLACEMENT EMERGENCY LIGHTING LAYOUT

Architect

Client
UCL ESTATES AND FACILITIES DIVISION.

Drawing Number
6888E(63)-016

Revision	Scale
A1	1:50
A3	N.T.S.
A4	N.T.S.

Path
J:\6888E\LEC\6888E(63)-015

Architects Drawing Reference

Drawn	DO Check	Originator	Approved
JB	GK	ED	ED

Date	Status
JAN 2010	TENDER

This drawing is the copyright of TGA Consulting Engineers LLP and must not be reproduced without their permission. This drawing shall not be scaled for construction purposes.