


22 Gordon Square

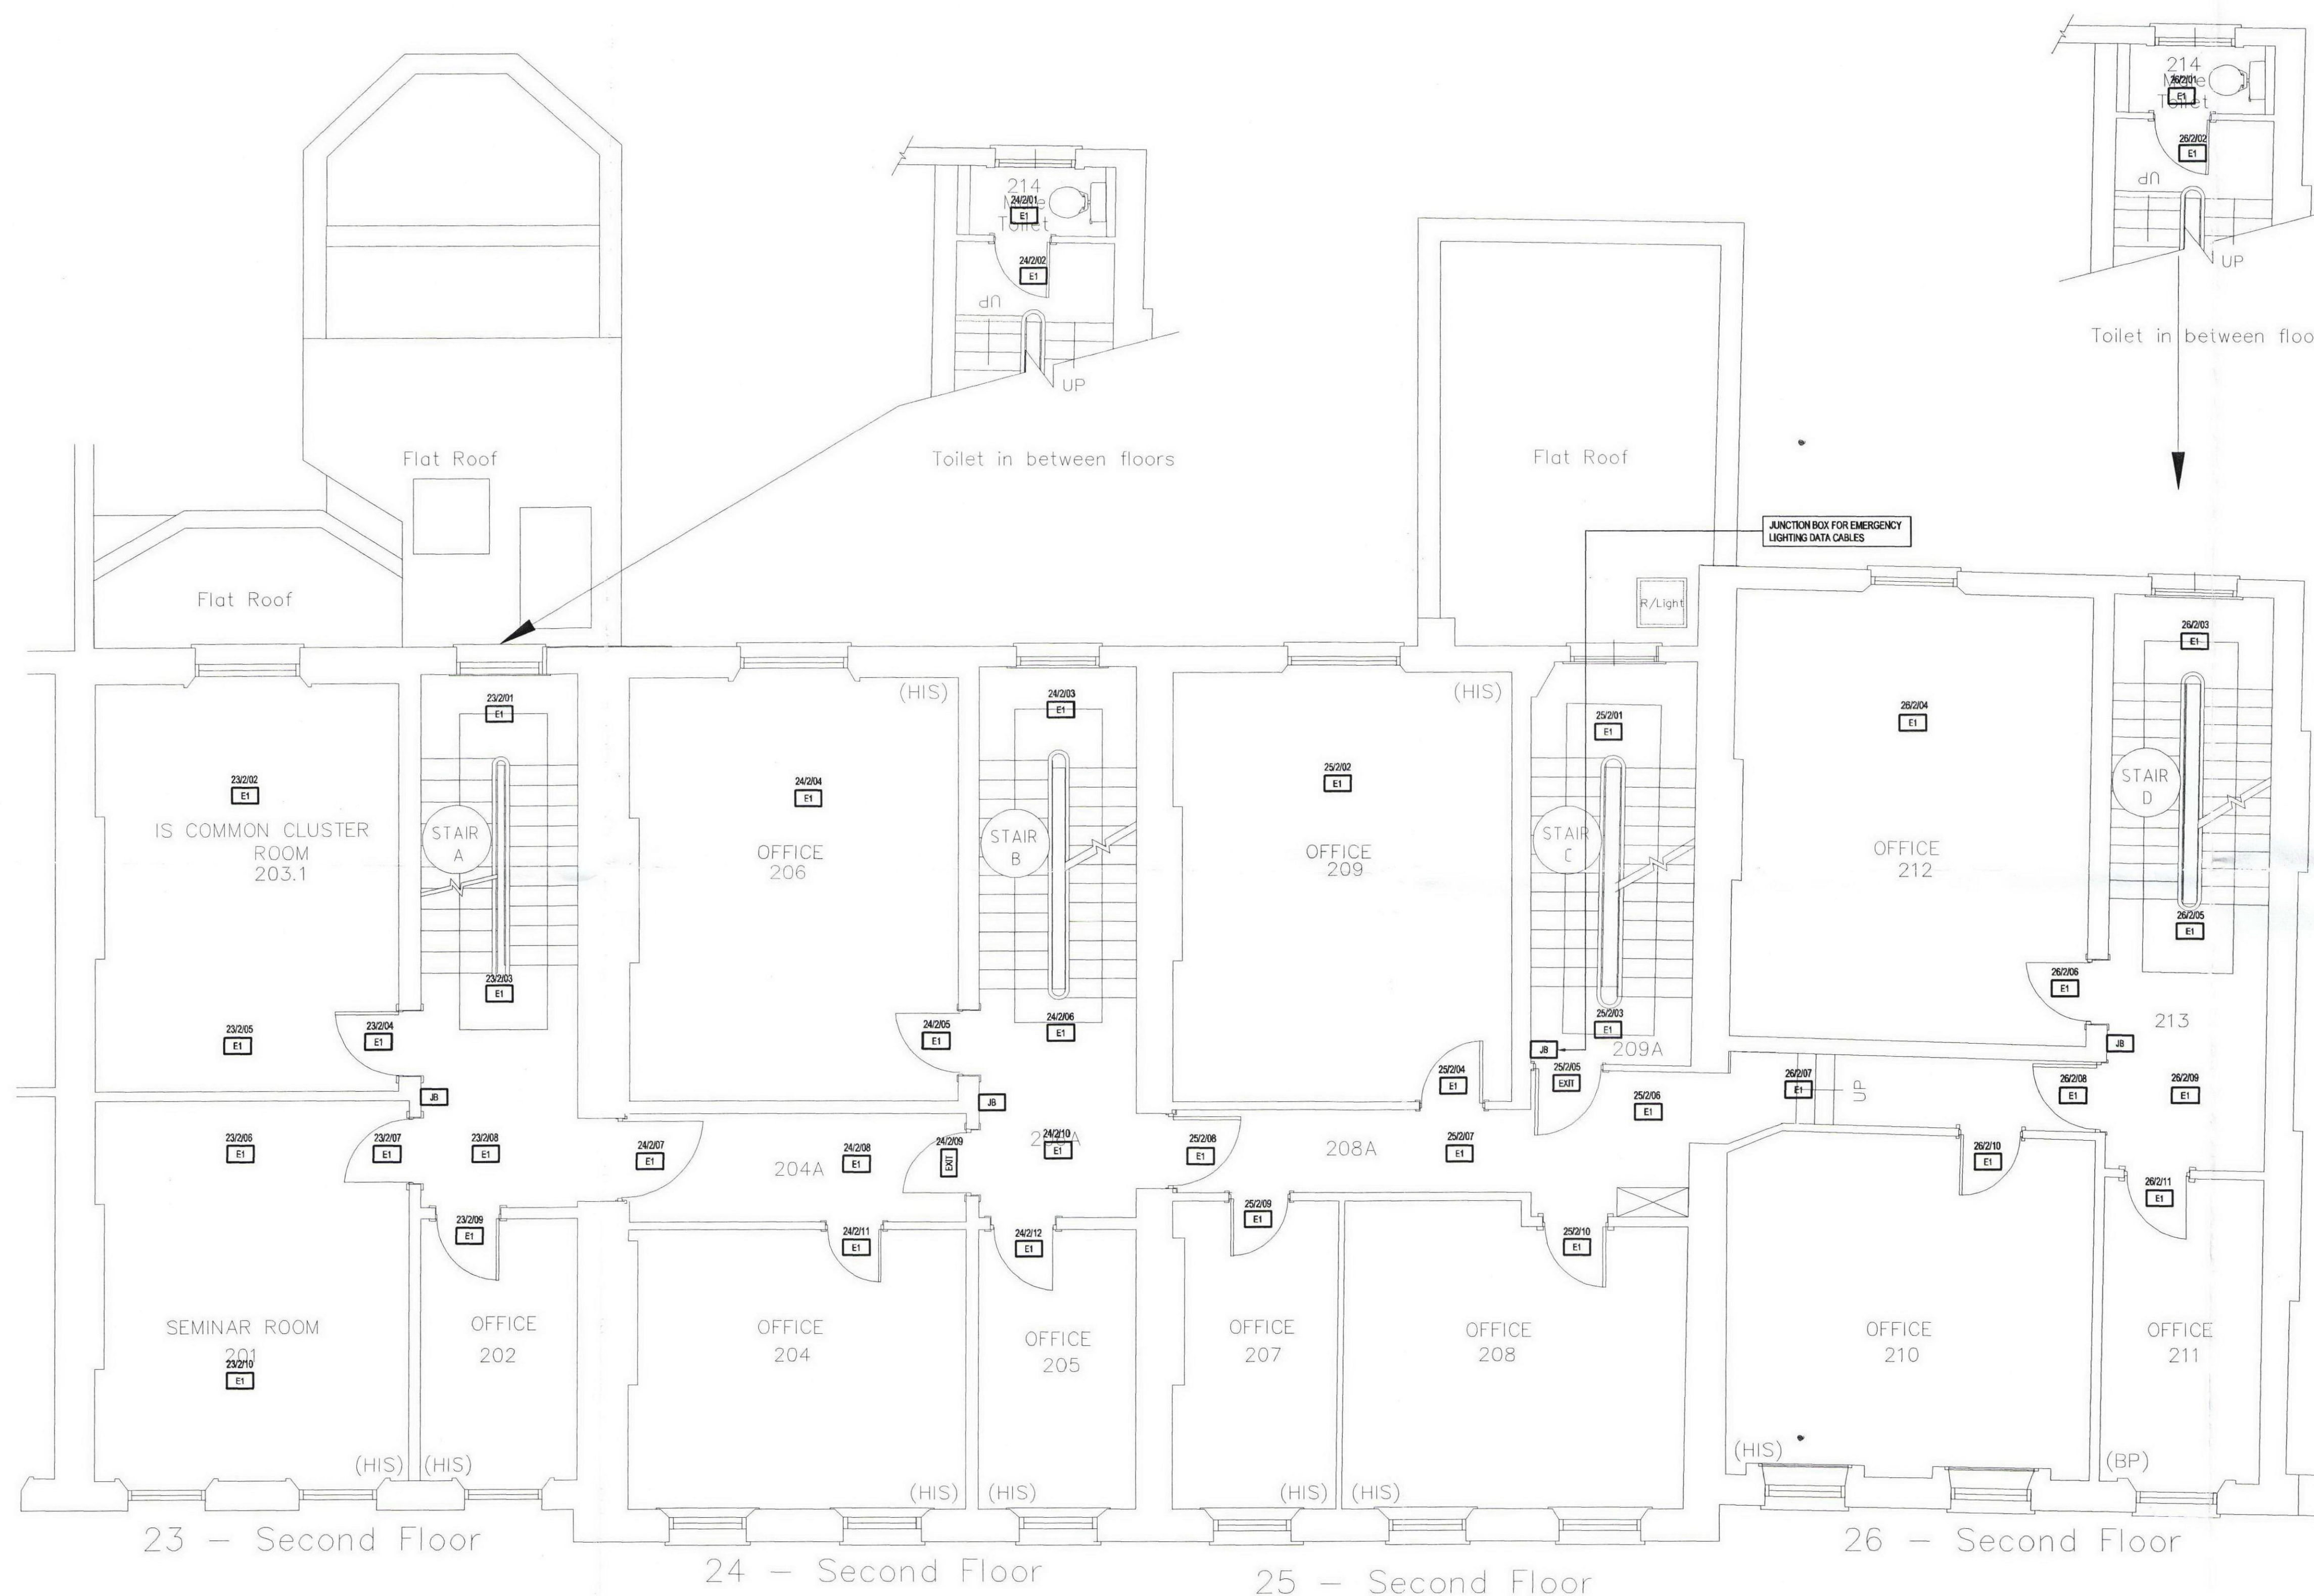

This drawing should be read in conjunction with the specification and shall not be used in lieu of the service contractors working drawings. At construction stage, the service contractors are required to prepare co-ordinated drawings for construction purposes under the terms of the contract.

A1

- LEGEND**
- STAND ALONE EMERGENCY LUMINAIRE
 - STAND ALONE (EXTERNAL) EMERGENCY LUMINAIRE
 - ILLUMINATE EXIT SIGN
 - THORN EXPANDER PANEL
 - THORN DATA COMMS COMMUNICATION
 - FUSED CONNECTION UNIT
 - JUNCTION BOX FOR DATA CABLE TO EMERGENCY LUMINAIRES
 - UCL NETWORK DATA POINT
 - EXISTING DISTRIBUTION BOARD

REV	DATE	DESCRIPTION	ALT	DO	ORIG	APP
-----	------	-------------	-----	----	------	-----

TGA Consulting Engineers LLP
 Armstrong House,
 Norton Road
 Stevenage
 Hertfordshire, SG1 2LX
 T: 01438 314422
 F: 01438 314433
 E: stevenage@tgace.co.uk

tga

Consulting Engineers LLP

Project
 UNIVERSITY COLLEGE LONDON
 23-26 GORDON SQUARE HOUSES

Title
 ELECTRICAL ENGINEERING SERVICES
 SECOND FLOOR PLAN
 REPLACEMENT EMERGENCY LIGHTING LAYOUT

Architect

Client
 UCL ESTATES AND FACILITIES DIVISION.

Drawing Number	Revision	Scale
6888E(63)-018		A1 1:50
		A3 N.T.S.
		A4 N.T.S.

Path
 J:\6888\ELEC\6888E(63)-018

Architects Drawing Reference

Drawn	DO Check	Originator	Approved
JB	GK	ED	ED
Date			Status
JAN 2010			TENDER

This drawing is the copyright of TGA Consulting Engineers LLP and must not be reproduced without their permission. This drawing shall not be scaled for construction purposes.