


22 Gordon Square

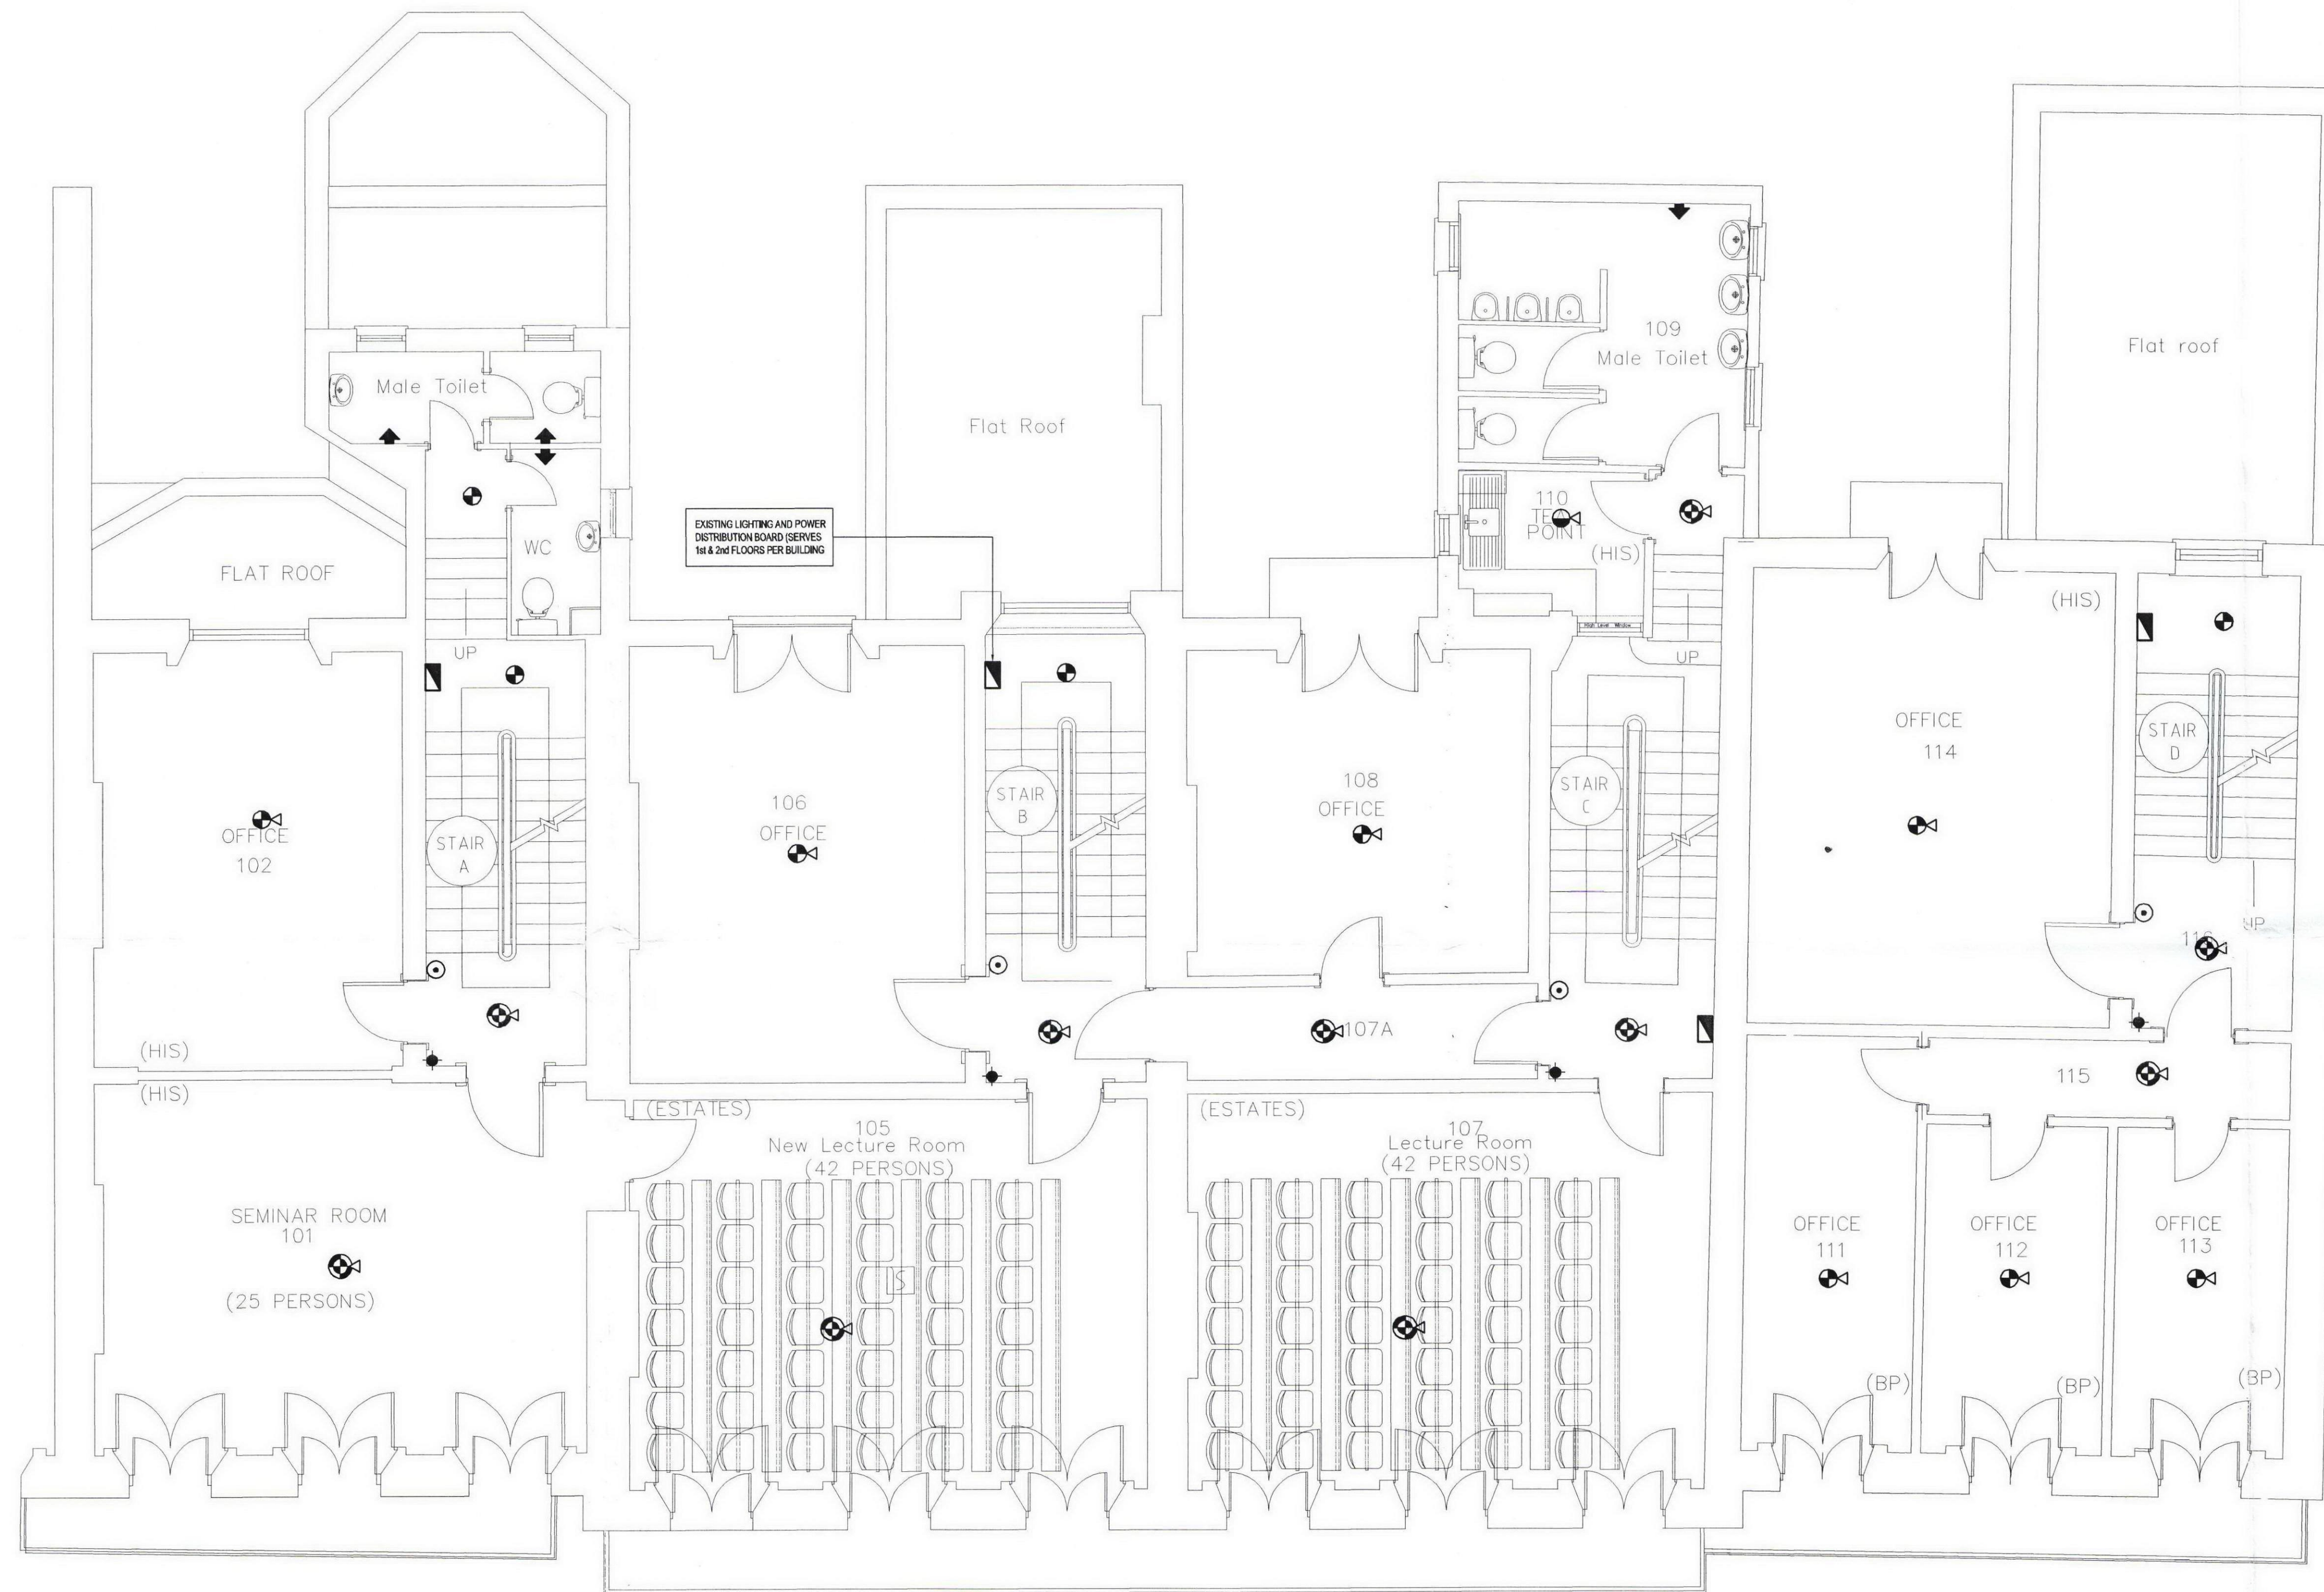

23 - First Floor

24 - First Floor

25 - First Floor

26 - First Floor

This drawing should be read in conjunction with the specification and shall not be used in lieu of the service contractors working drawings. At construction stage, the service contractors are required to prepare co-ordinated drawings for construction purposes under the terms of the contract.

A1

LEGEND AND NOTES

- BREAK GLASS CONTACT
- HEAT DETECTOR
- SMOKE DETECTOR
- LOOP INTERFACE
- COMBINED HEAT DETECTOR / SOUNDER BASE
- COMBINED SMOKE DETECTOR / SOUNDER BASE
- COMBINED SOUNDER / FLASHING BEACON
- REMOTE LED INDICATOR
- FUSED CONNECTION UNIT
- COMBINED HEAT DETECTOR / SOUNDER / FLASHING BEACON
- COMBINED SMOKE DETECTOR / SOUNDER / FLASHING BEACON
- COMBINED SMOKE DETECTOR AND FLASHING BEACON
- TRIO PAGE UNIT
- EXISTING DISTRIBUTION BOARD
- FIRE ALARM PANEL
- REPEATER FIRE ALARM PANEL
- UCL NETWORK DATA POINT
- 75mm DIA CORE DRILL: HOLE THROUGH FLOOR SLAB (FORM AND MAKE GOOD) POSITION FOR FIRE ALARM AND EMERGENCY LIGHTING DATA CABLES TO ALL FLOORS

REV	DATE	DESCRIPTION	ALT	DO	ORIG	APP
-----	------	-------------	-----	----	------	-----

TGA Consulting Engineers LLP
 Armstrong House,
 Norton Road
 Stevenage
 Hertfordshire, SG1 2LX
 T: 01438 314422
 F: 01438 314433
 E: stevenage@tgace.co.uk



Project
 UNIVERSITY COLLEGE LONDON
 23-26 GORDON SQUARE HOUSES

Title
 ELECTRICAL ENGINEERING SERVICES
 FIRST FLOOR PLAN
 REPLACEMENT FIRE ALARM LAYOUT

Architect

Client
 UCL ESTATES AND FACILITIES DIVISION.

Drawing Number	Revision	Scale
6888E(67)-009	A1	1:50
	A3	-
	A4	-

Path
 J:\6888\ELEC\6888E(67)-009

Architects Drawing Reference

Drawn	DO Check	Originator	Approved
AW	GK	ED	ED
Date			Status
JAN 2010			TENDER

This drawing is the copyright of TGA Consulting Engineers LLP and must not be reproduced without their permission. This drawing shall not be scaled for construction purposes.