


A

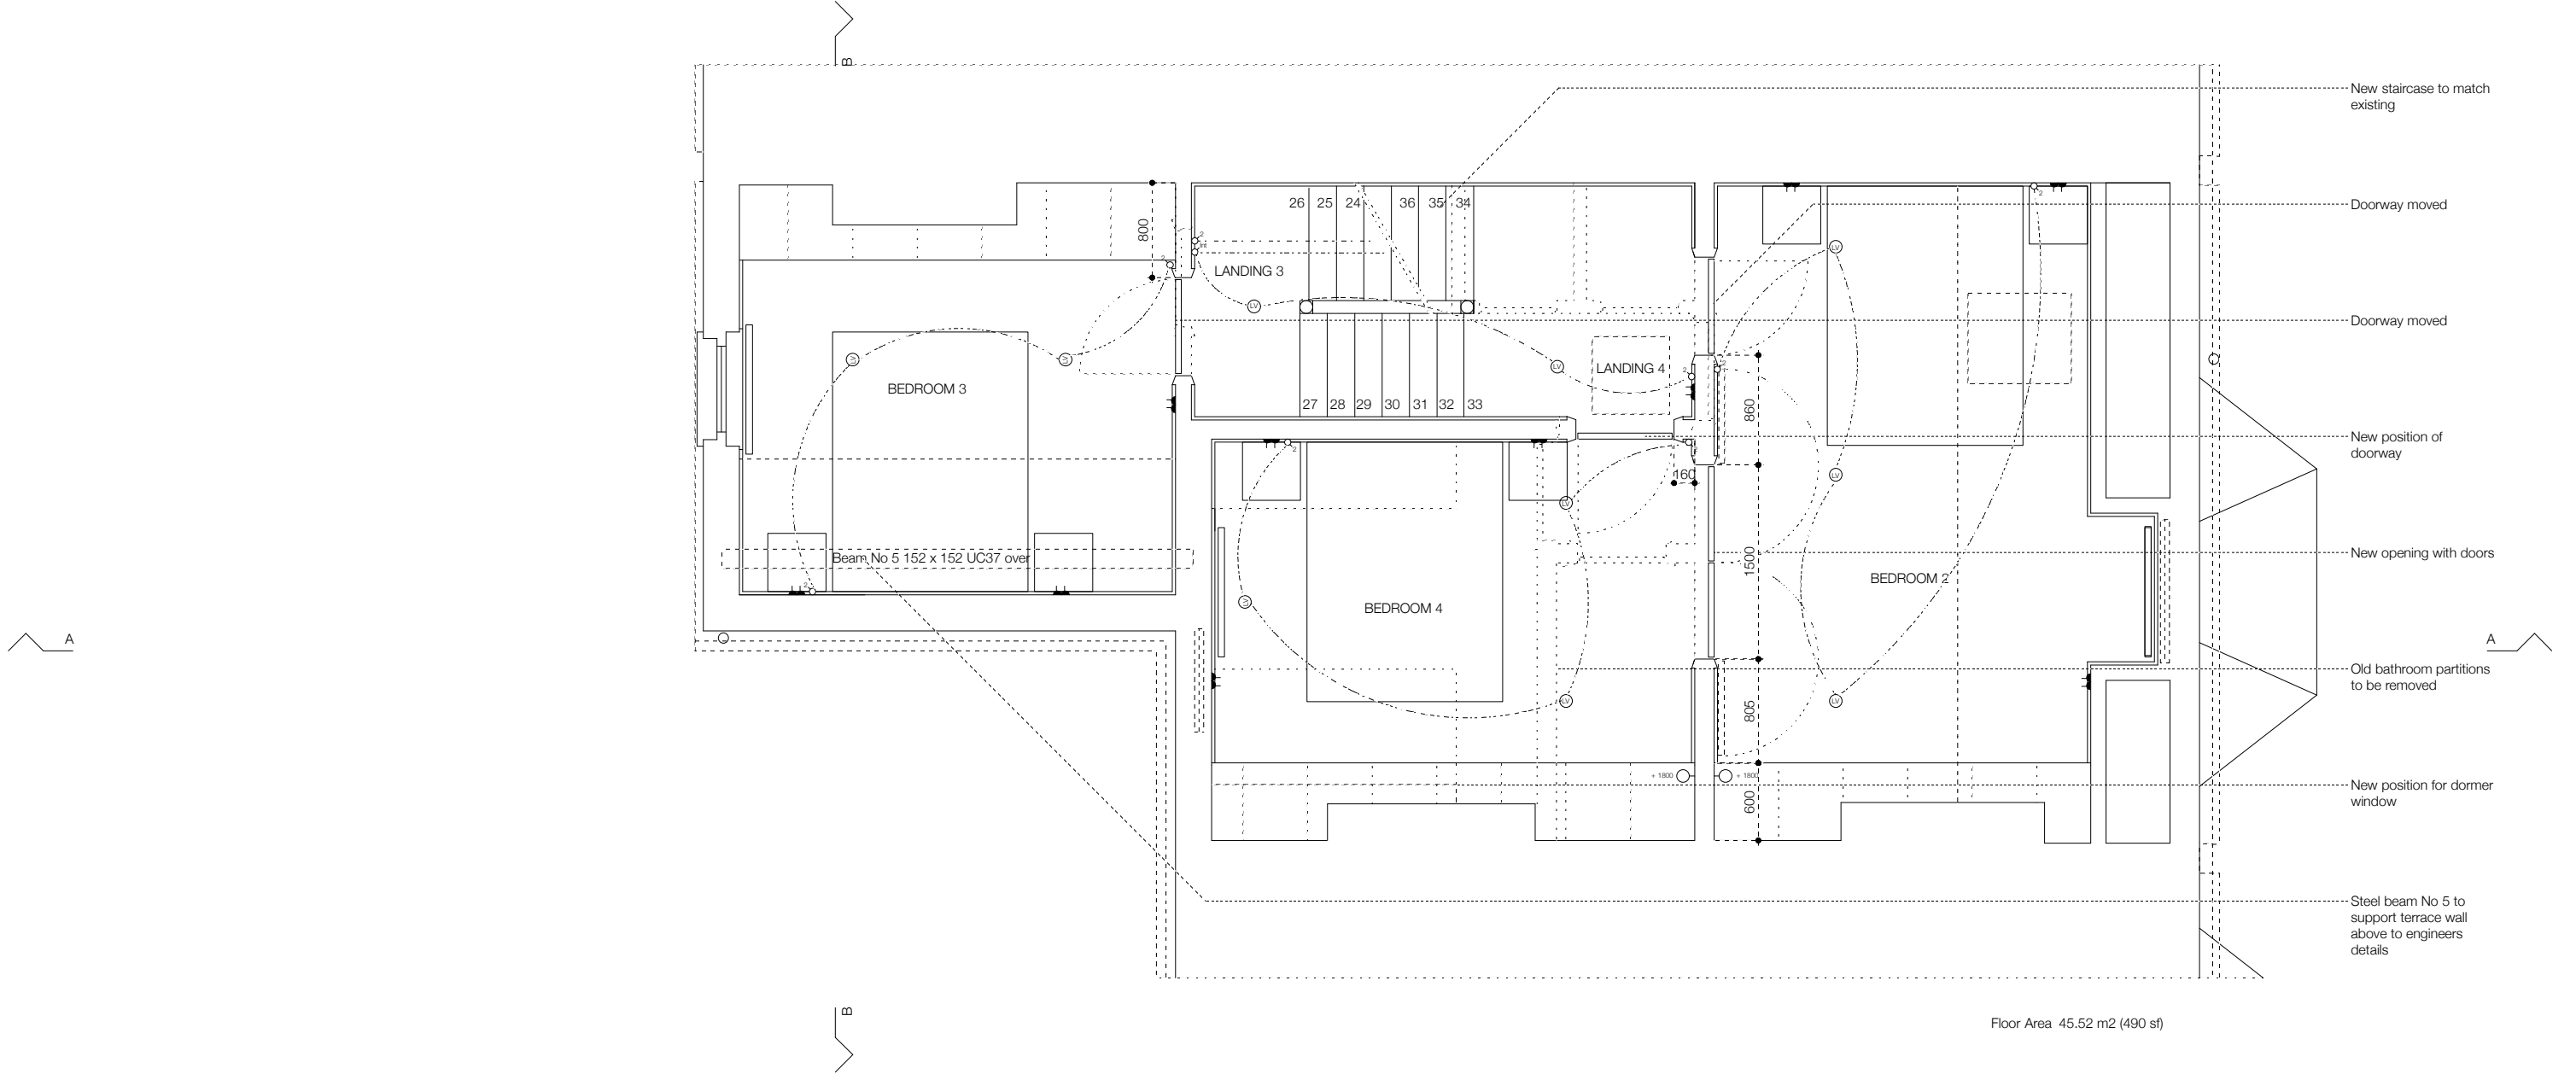

Floor Area 45.52 m2 (490 sf)

A



REVISIONS

	Socket outlet (double) at + 450		Lightswitch at + 1050		Pendant light		Extract fan
	Socket outlet (double) at + 1050		2 way lightswitch at + 1050		Wall light		Cooker control
	Socket outlet (single) at + 450		Intermediate lightswitch at + 1050		Low voltage fitting		Consumer unit
	Bell at + 2100		Dimmer switch at + 1050		Telephone outlet at + 450		Dual voltage shaver socket
	Bell push at + 1050		Pull switch		Television outlet		Cupboard door switch

1131.34

PETER BELL & PARTNERS ARCHITECTS 44 DALE STREET LONDON W4 2BL
42 COTLEIGH ROAD LONDON NW6 2NP
SECOND FLOOR PLAN CONSTRUCTION DETAILS
t 020 8994 3023 m 07967 971 639 scale 1:25 @ A1 & 1:50 @ A3 4 January 2010