

|         |                   |
|---------|-------------------|
| Date:   | 09/12/09          |
| Drawn:  | M.D.B             |
| Scale:  | 1:200<br>& 1:1250 |
| Job No: | CP0902            |

 



KINGS SECURITY SYSTEMS  
ATM DIVISION. UNIT 2  
ST DUNSTONS TECHNOLOGY PARK,  
OFF RIPLEY STREET  
BRADFORD.BD4 7HH  
T-01274 377517 / 377518  
E-planningpermission.atm@kingsltd.co.uk


Proposed installation at:

87 Chalic Farm Road  
Camden  
NW1 8AR

## LOCATION PLAN

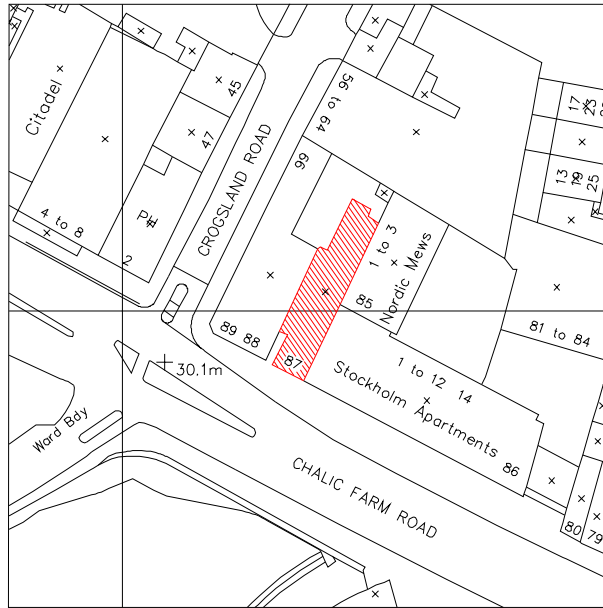

LOCATION PLAN 1/1250

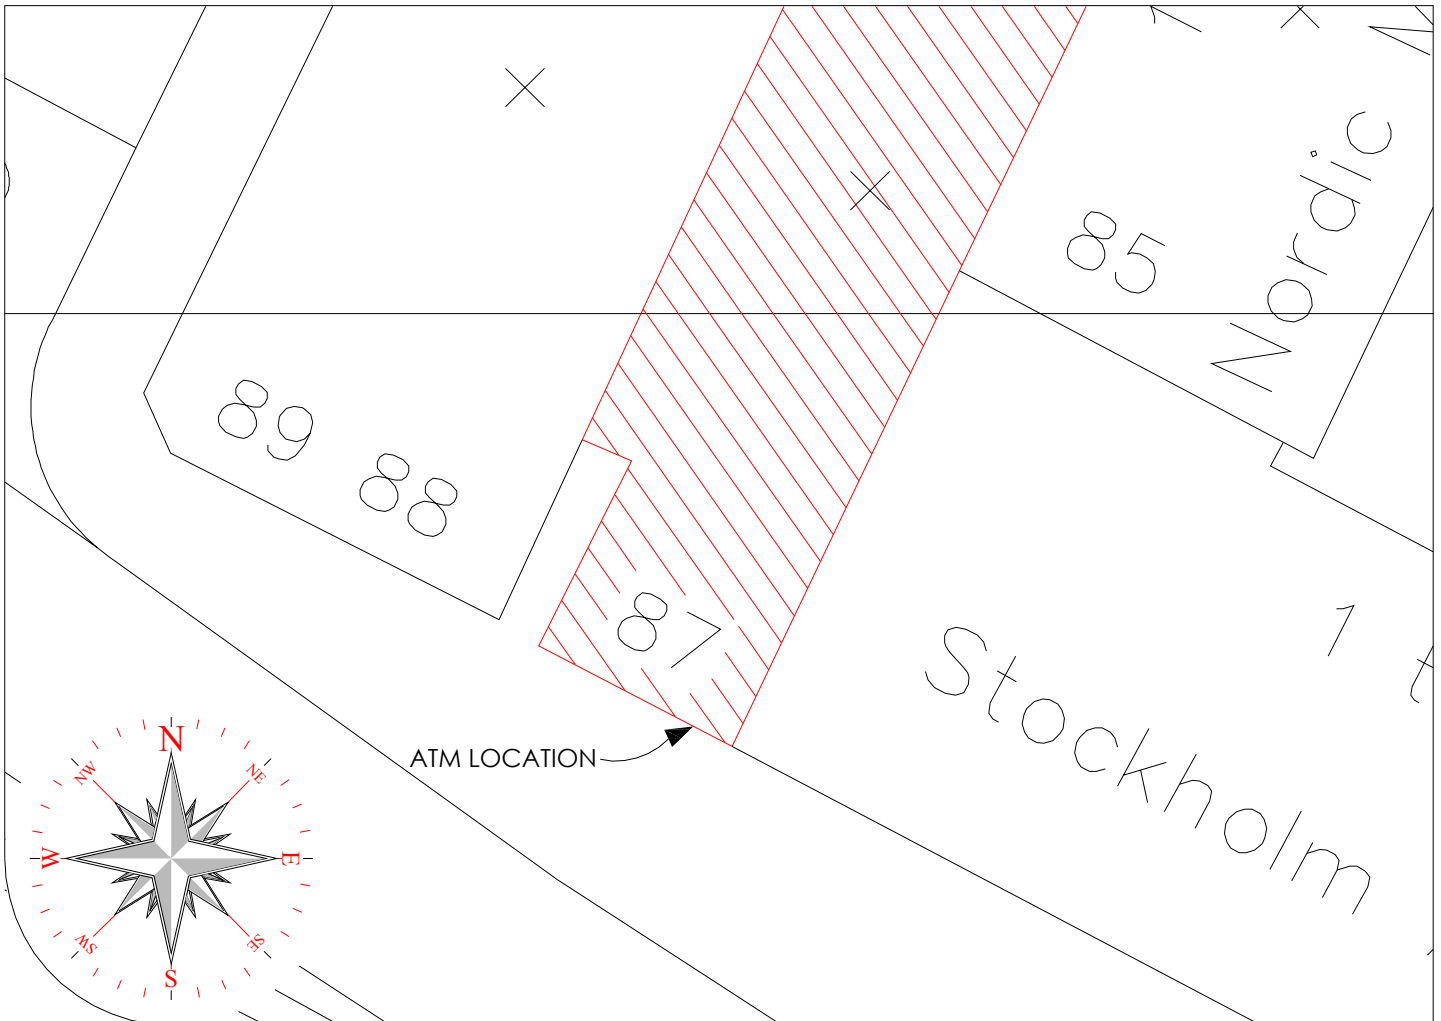

SITE PLAN 1/200