



Ground Floor

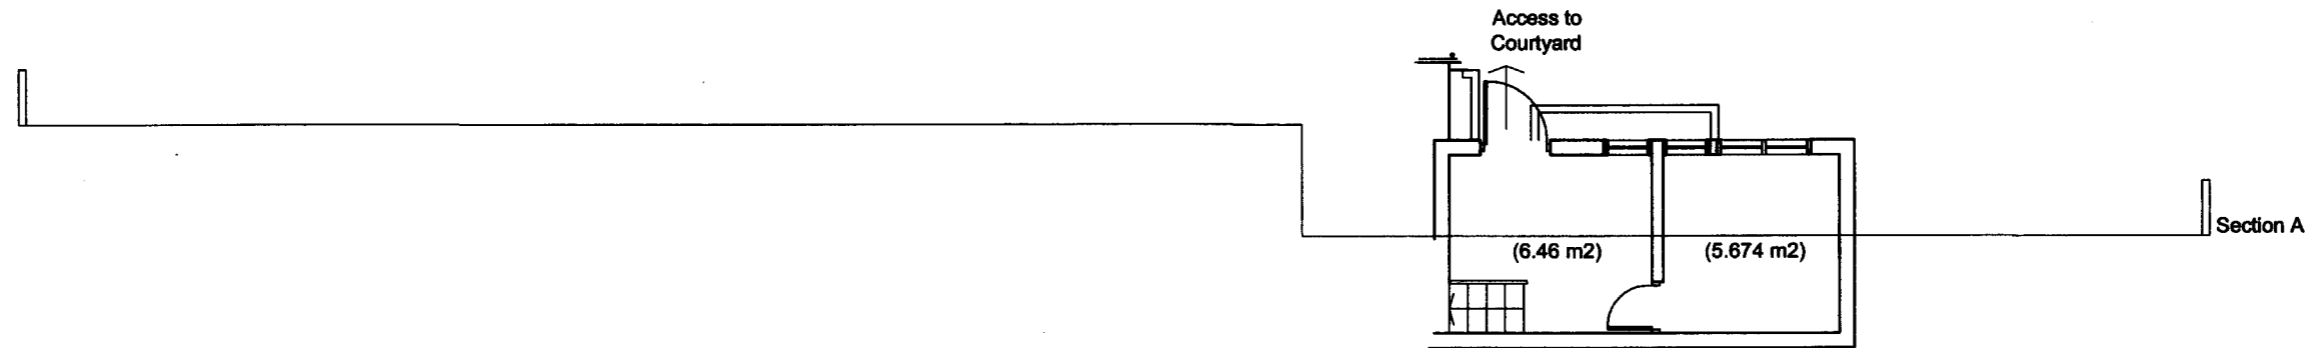

Lower Floor Level

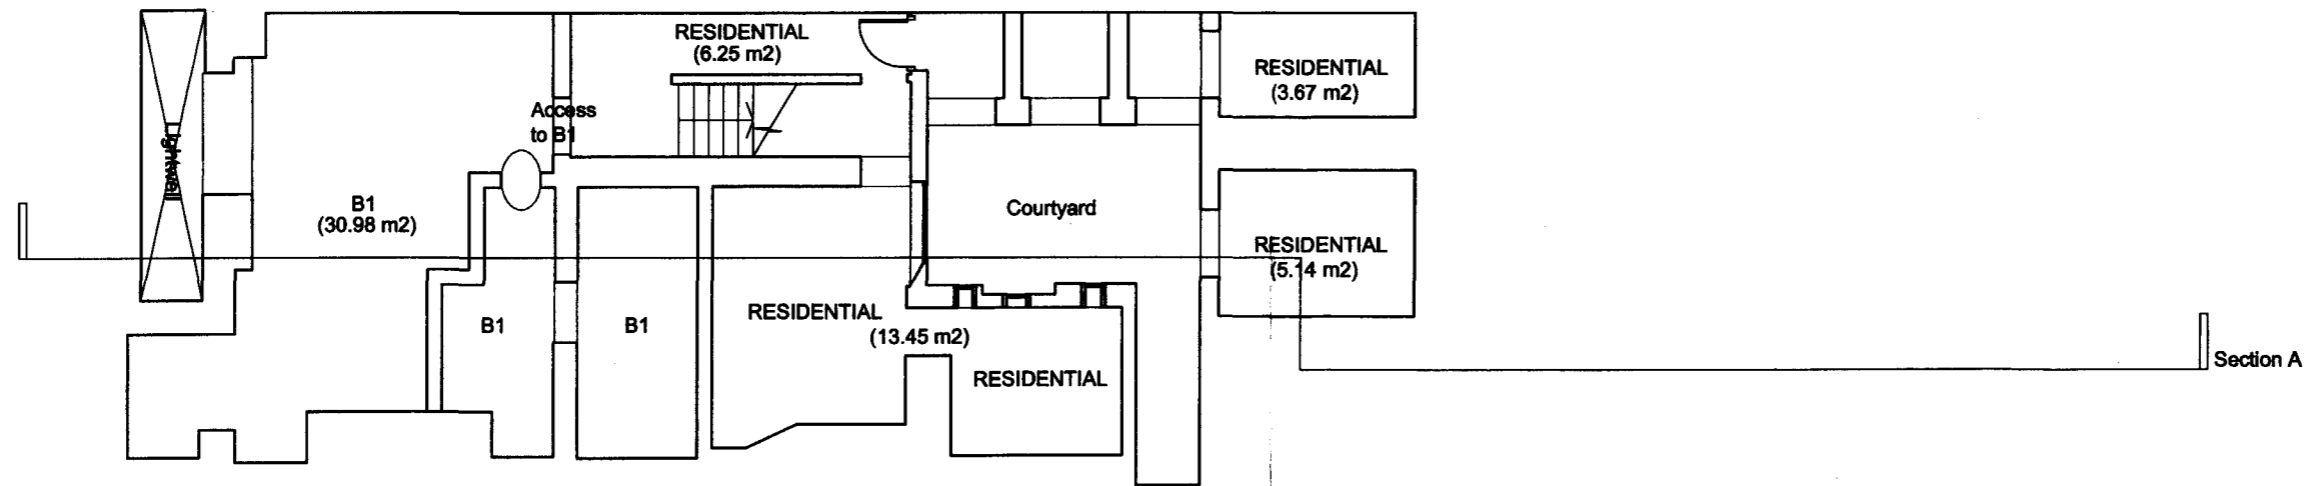

Lower Ground Floor

notes:

1. Steelwork setting out to Structural Engineers Details.
2. All dimensions to be checked on site.
3. All dimensions are to masonry unless otherwise stated. (NB: Not plaster finishes).
4. All information is to be checked and verified by the contractors and subcontractors for accuracy and fit.
5. Discrepancies or omissions to be brought to the attention of Douglas and King prior to construction.
6. Do not scale from this drawing.
7. Refer to detailed design drawings for electrical layout.

Douglas & King

Back Building 150 Curtain Road London EC2A 3AR
 t + 44 (020) 7613 1395
 f + 44 (020) 7613 1389
 info@douglasandking.com
 www.douglasandking.com

revision	date	notes
A	24.10.05	Hatching Removed.

project
 36-38 Lambs Conduit Street
 client
 Danny Pope

drawing title
 Proposed: Plans

scale
 1:100 @ A3
 date
 Feb 2004
 drawing no
LSC ga 001 A

survey