


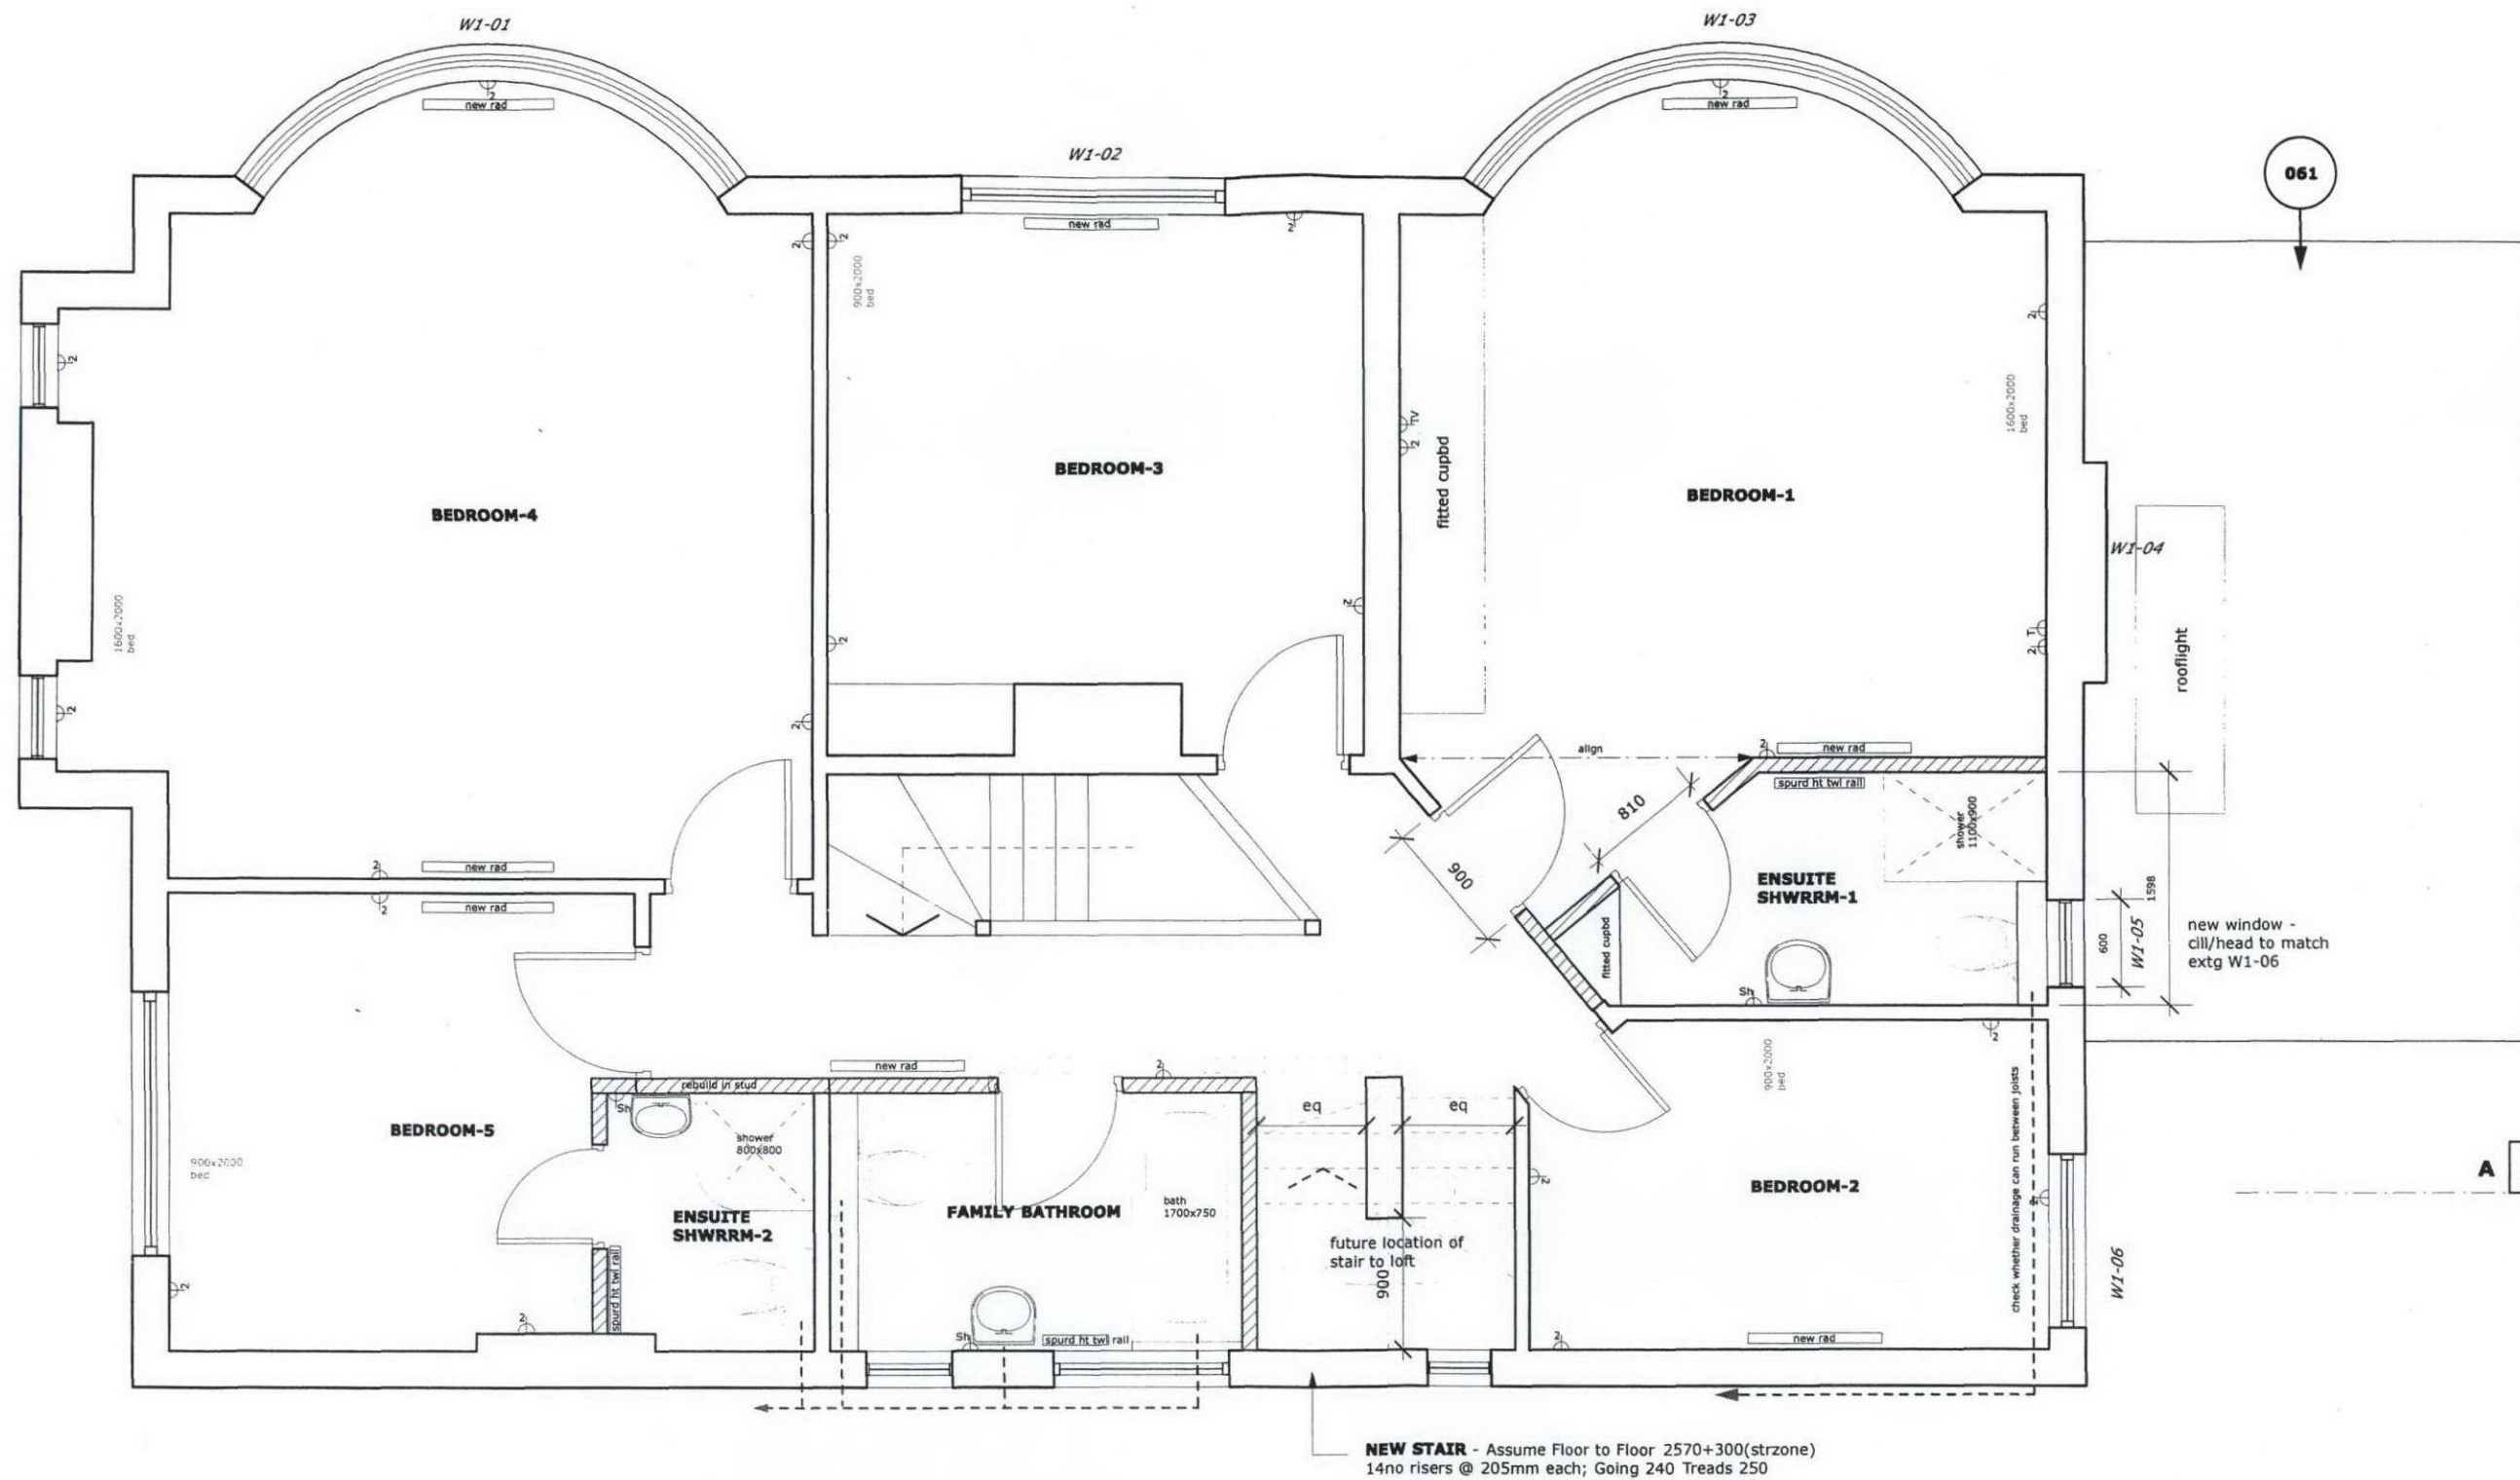

notes:



**ALL DIMENSIONS SHOWN ARE PURELY
INDICATIVE - TO BE CONFIRMED ON
SITE**

ELECTRICAL KEY

- double power socket
- 5amp power socket
- telephone socket
- TV aerial socket
- Shaver socket
- Network cable connect to router

revision:

- A - 18.6.09
- B - 15.7.09

square feet architects

A : 10 Perrins Court, London NW3 1QS
T : 0207 431 4500
E : studio@squarefeetarchitects.co.uk
W : www.squarefeetarchitects.co.uk

drawing title:

PROPOSED FIRST FLOOR PLAN

client:

31 SOMALI RD., NW2 3RN

project:

date:

MAY 2009

scale:

1:50 @ A3

drawing number:

0908_L_022

revision:

B