 


	Date	
*	26. 03. 08	first issue
a	09. 04. 09	demolition indicated, issued for planning

	structure existing
	project boundary
	demolition
	New Horizon Youth Centre
	Levite House and other buildings



Existing site plan
ISSUED FOR PLANNING

Scale 1:100 @ A1, 1:200 @ A3
09. 04. 09

	Date	
*	04. 02. 08	first issue
a	23. 05. 08	demolition indicated
b	28. 10. 08	NT amendments
c	23. 02. 09	Demolition clarified, surveyor's notes added
d	04. 03. 09	demolition notes and grid added
e	27. 03. 09	issued for building control
f	09. 04. 09	issued for planning

	structure existing
	demolition structural (assumed)
	demolition non-structural (assumed)
	break out floor slab
	extent of complete strip out

NOTES

1. DATUM DE

- PLAN DATA
- SURVEY ORIENTED TO APPROX NORTH. LOCAL METRIC: GND.
- HERST DATUM
- ALL LEVELS IN METERS AND RELATED TO ORDNANCE SURVEY BENCHMARK.
LOCATED ON OBSERVATION STREET, VALUE 19.36 METERS.
1. THIS DRAWING IS TO BE READ IN CONJUNCTION WITH
OTHER RELEVANT DRAWINGS AND DOCUMENTATION.
NAMELY:
- AKA/197874201 - TOPOGRAPHICAL SURVEY
AKA/197874202 - SURVEY
AKA/197874204-205 - ELECTIONS
AKA/197874206 - ELECTIONS
2. DO NOT SCALE FROM THIS DRAWING.
3. ALL MEASUREMENTS ARE IN METRES.
4. IF IN DOUBT ASK.
5. B, N, P, R, C, CH, CH, OH, CH, D, ME, T, MEASURED FROM FINISHED FLOOR
6. CRITICAL CLEARANCE DIMENSIONS AND HEIGHT MUST BE
CHECKED ON SITE PRIOR TO CONSTRUCTION.
7. MEASUREMENTS AT WALLS HAVE BEEN TAKEN TO BE MAIN
FACE AT APPROPRIATELY 1.5M ABOVE FLOOR LEVEL.
8. STAIR ARROWS ALWAYS POINT
9. CEILING ARROWS ALWAYS POINT UP.
10. FLOOR HEIGHT BE MEASURED IN MIDDLE OF OPERATOR, OTHER WITHOUT THE
FLOOR AND AS THE CASE ON THE CEILING.
11. LETTER 'E' OF THE SWITCH INDICATES LIGHTS ITS OPERATES.

LEGEND


- | | |
|-------|--------------------|
| 36.25 | SPOT LEVEL |
| | SURVEY STATION |
| | DOOR SWING |
| | STAIRS |
| | TOILET (SYMBOLIC) |
| | URINALS (SYMBOLIC) |
| | SINK (SYMBOLIC) |
| | LIGHTS |
| | RADIATOR |
| | SHOWER |

✱ EMERGENCY LIGHT

- SWITCH
- SWITCH (TWINNED)
- POWER SOCKET
- FIRE BELL
- FIRE DOOR RELEASE
- FIRE ALARM
- MOVEMENT DETECTOR
- SMOKE DETECTOR

ABBREVIATIONS

- | | |
|-----|---|
| BH | BEAM HEIGHT FROM FLOOR LEVEL |
| CH | CEILING HEIGHT FROM FLOOR LEVEL |
| COL | COLUMN |
| DH | DOOR HEIGHT FROM FLOOR LEVEL |
| DFL | DOWNPIPE |
| FL | FLOOR LEVEL |
| HC | WINDOW HEAD HEIGHT FROM FLOOR LEVEL |
| IC | INSPECTION COVER |
| JH | JOIST HEIGHT FROM FLOOR LEVEL |
| JOH | OPENING HEIGHT FROM FLOOR LEVEL |
| BH | WINDOW SILL HEIGHT FROM FLOOR LEVEL |
| SCB | SUSPENDED CEILING HEIGHT FROM FLOOR LEVEL |
| TA | TOP OF ARCH |
| THL | THRESHOLD LEVEL |
| UIS | UNDERGIRD |
| UTS | UNABLE TO SURVEY |
| H | FIXTURE HEIGHT FROM FLOOR LEVEL |
| CIC | CABLES IN CLADDING |

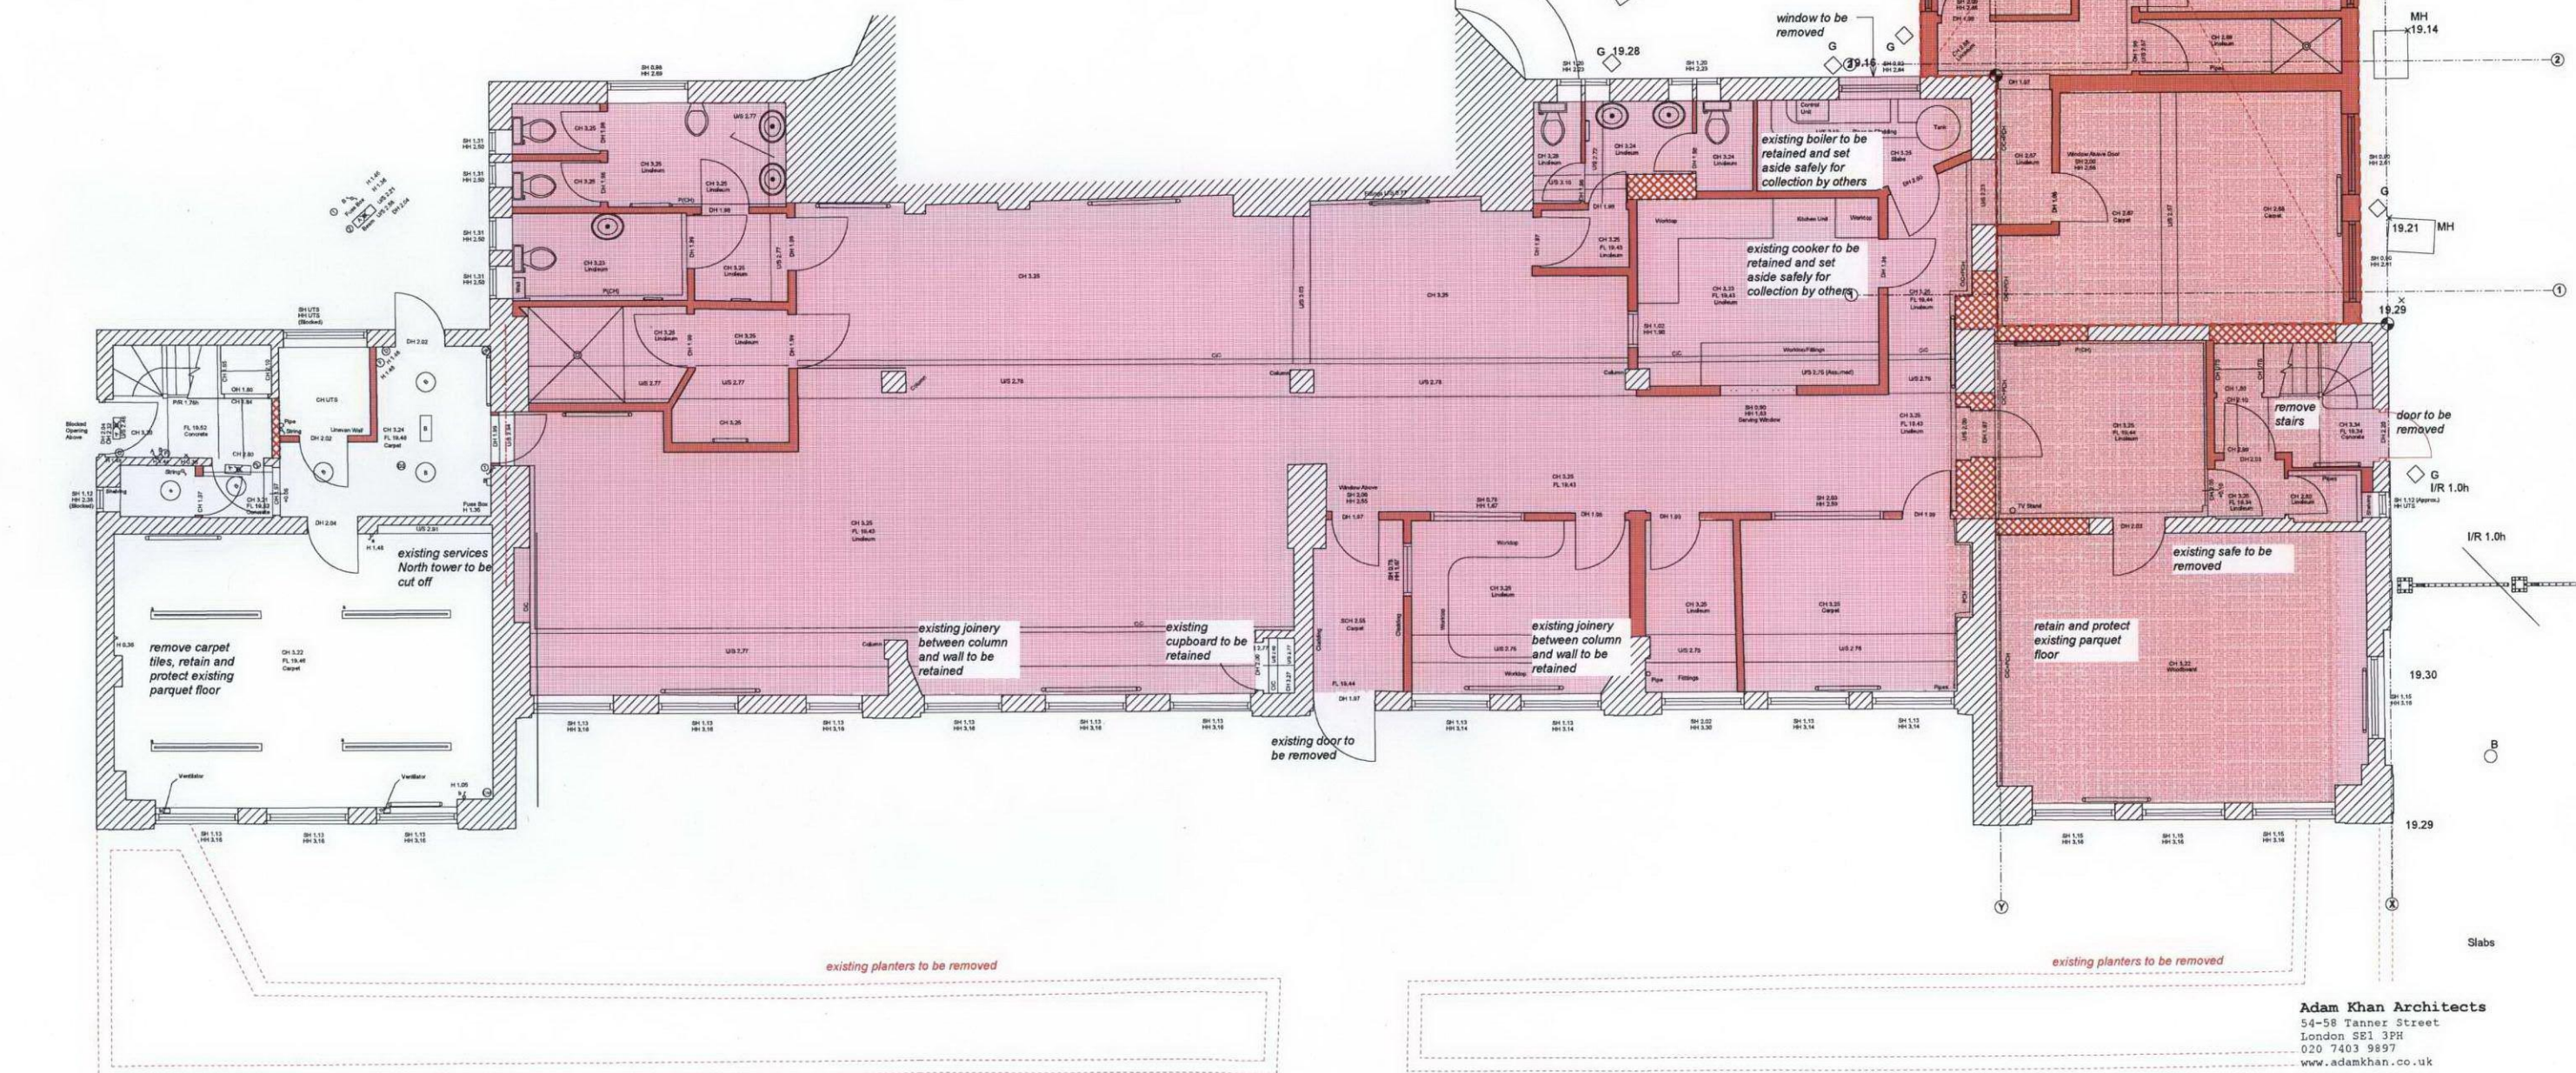

Adam Khan Architects
54-58 Tanner Street
London SE1 3PH
020 7403 9897
www.adamkhan.co.uk

New Horizon Youth Centre
022/L12/01f

Existing ground floor plan
ISSUED FOR PLANNING

Scale 1:50 @ A1, 1:100 @ A3
09. 04. 09



	Date	
*	04. 02. 08	first issue
a	23. 05. 08	demolition indicated
b	23. 02. 09	demolition clarified, surveyor's notes added
c	04. 03. 09	demolition notes and grid added
d	27. 03. 09	issued for building control
e	09. 04. 09	issued for planning

	structure existing
	demolition structural (assumed)
	demolition non-structural (assumed)
	break out floor slab
	extent of complete strip cut

NOTES

30-72	SPOT LEVEL
	SURVEY STATION
	DOOR SWING
	STAIRS
	TOILET (SYMBOLIC)
	URINALS (SYMBOLIC)
	SINK (SYMBOLIC)
	LIGHTS
	RADIATOR
	SHOWER

BH	BEAM HEIGHT FROM FLOOR LEVEL
CH	CEILING HEIGHT FROM FLOOR LEVEL
COL	COLUMN
DH	DOOR HEIGHT FROM FLOOR LEVEL
DF	DOWNPIPE
FL	FLOOR LEVEL
WH	WINDOW HEAD HEIGHT FROM FLOOR LEVEL
IC	INSPECTION COVER
JH	JOIST HEIGHT FROM FLOOR LEVEL
OH	OPENING HEIGHT FROM FLOOR LEVEL
SH	SHOULDER HEIGHT FROM FLOOR LEVEL
SDH	SHOULDER DRAINAGE HEIGHT FROM FLOOR LEVEL
TA	TOP OF ARCH
TH	THRESHOLD LEVEL
US	UNDERSIDE
UTS	UNABLE TO SURVEY
FC	FUTURE HEIGHT FROM FLOOR LEVEL
CIC	CABLES IN CLADDING
PCM	PIPES (CENTRAL HEATING)

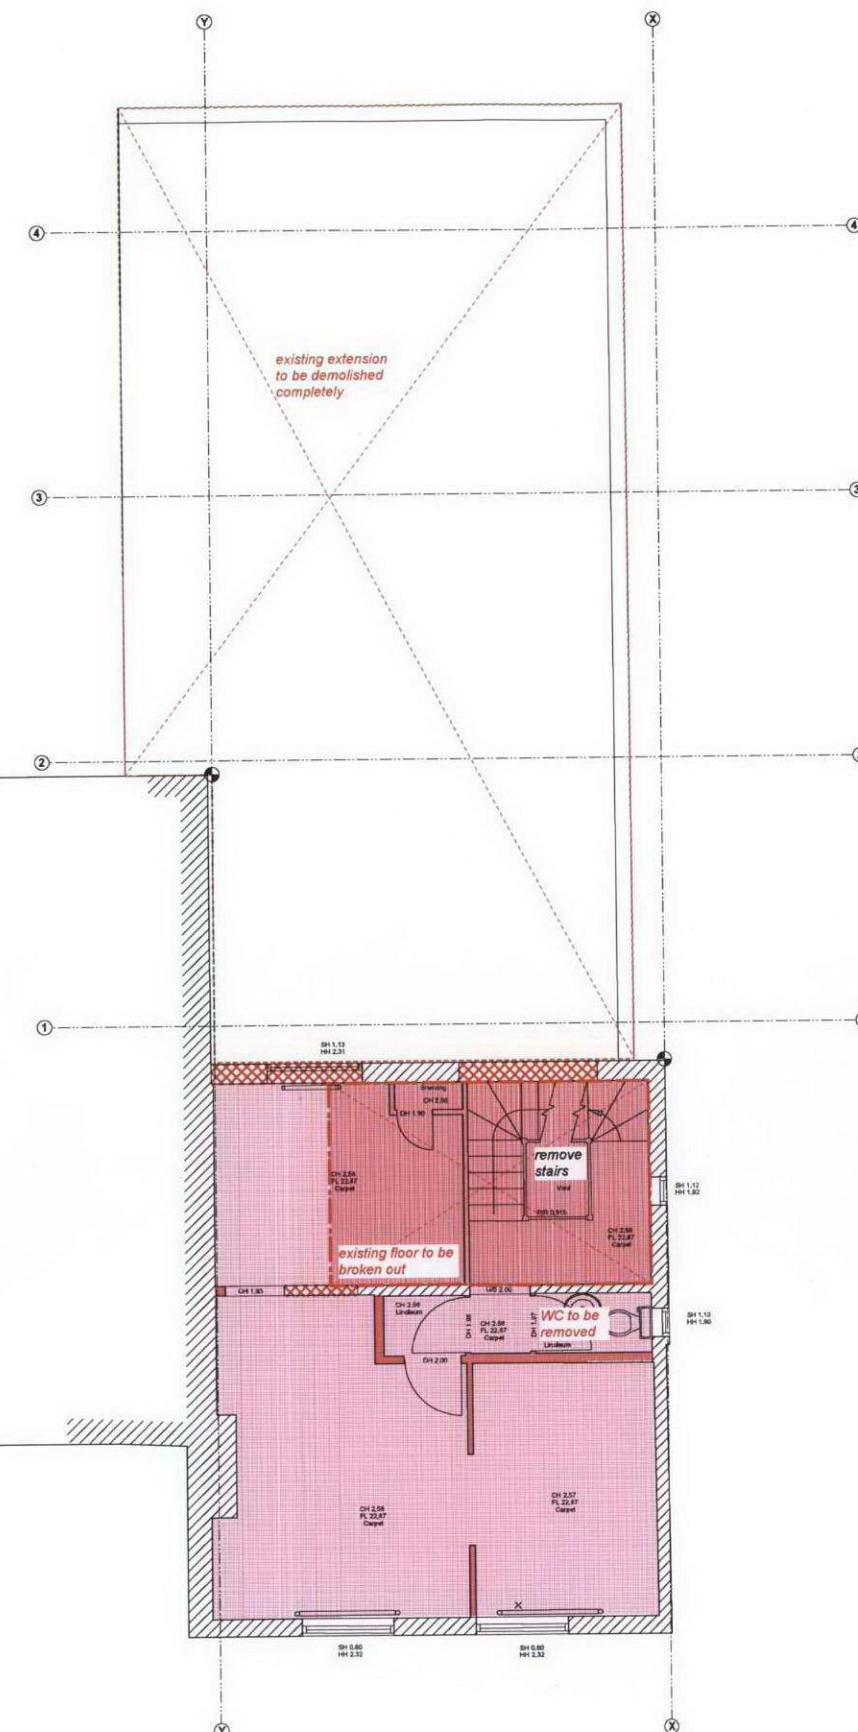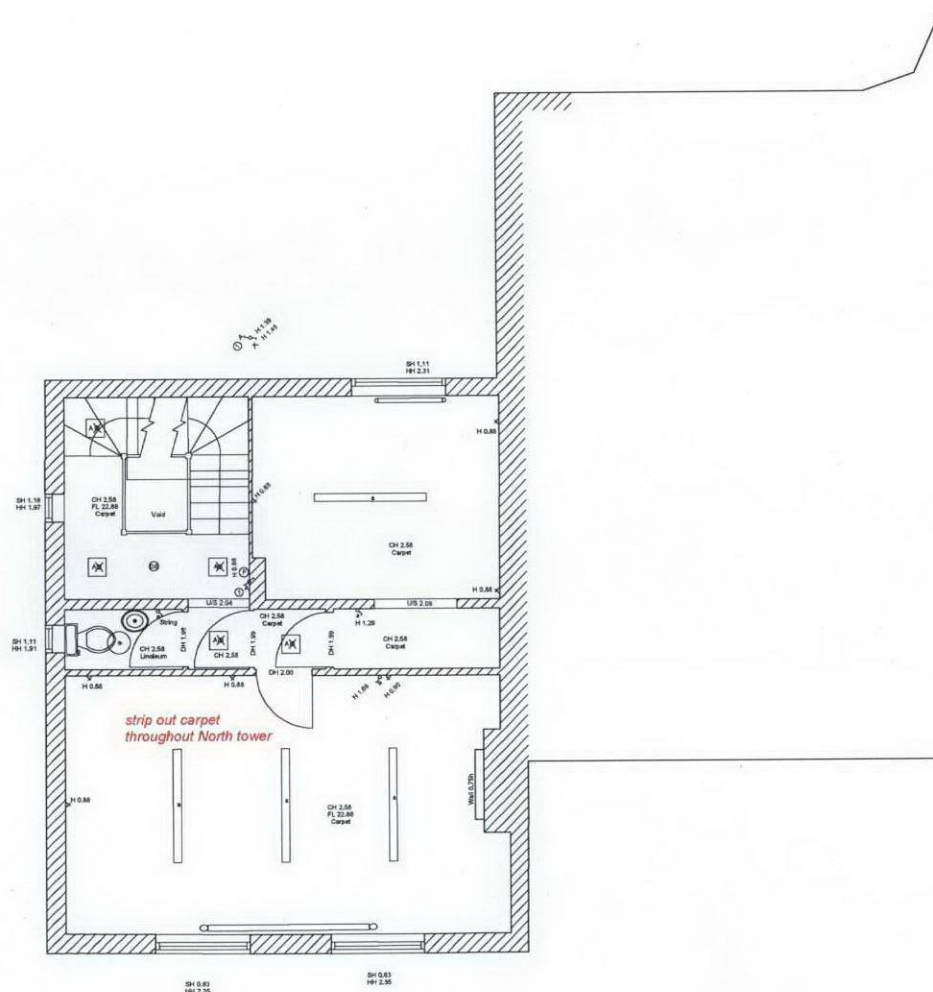

New Horizon Youth Centre
022/L12/02e
Existing first floor plan
ISSUED FOR PLANNING
Scale 1:50 @ A1, 1:100 @ A3
09. 04. 09

	Date	
a	04. 02. 08	first issue
a	23. 05. 08	demolition indicated
b	23. 02. 09	demolition clarified, surveyor's notes added
c	04. 03. 09	demolition notes and grid added
d	27. 03. 09	issued for building control
f	09. 04. 09	issued for planning

	structure existing
	demolition structural (assumed)
	demolition non-structural (assumed)
	break out floor slab
	extent of complete strip cut

NOTES



- [illegible]

LEGEND

- | | |
|--|--------------------|
| | SPOT LEVEL |
| | SURVEY STATION |
| | DOOR SWING |
| | STAIRS |
| | TOILET (SYMBOLIC) |
| | URINALS (SYMBOLIC) |
| | SINK (SYMBOLIC) |
| | LIGHTS |
| | RADIATOR |
| | SHOWER |

ABBREVIATIONS


- | | |
|------|---|
| BH | BEAM HEIGHT FROM FLOOR LEVEL |
| CH | CEILING HEIGHT FROM FLOOR LEVEL |
| COL | COLUMN |
| DH | DOOR HEIGHT FROM FLOOR LEVEL |
| DOOR | DOOR |
| FL | FLOOR LEVEL |
| HH | WINDOW HEAD HEIGHT FROM FLOOR LEVEL |
| IC | INSPECTION COVER |
| JCH | JOIST HEIGHT FROM FLOOR LEVEL |
| OH | OPENING HEIGHT FROM FLOOR LEVEL |
| BH | WINDOW SILL HEIGHT FROM FLOOR LEVEL |
| SCH | SUSPENDED CEILING HEIGHT FROM FLOOR LEVEL |
| TH | TOP OF ARCH |
| THL | THRESHOLD LEVEL |
| US | UNDERSIDE |
| UTS | UNABLE TO SURVEY |
| H | FIGURE HEIGHT FROM FLOOR LEVEL |
| CC | CABLES IN CULVERT |
| PCB | Pipes (CENTRAL HEATING) |

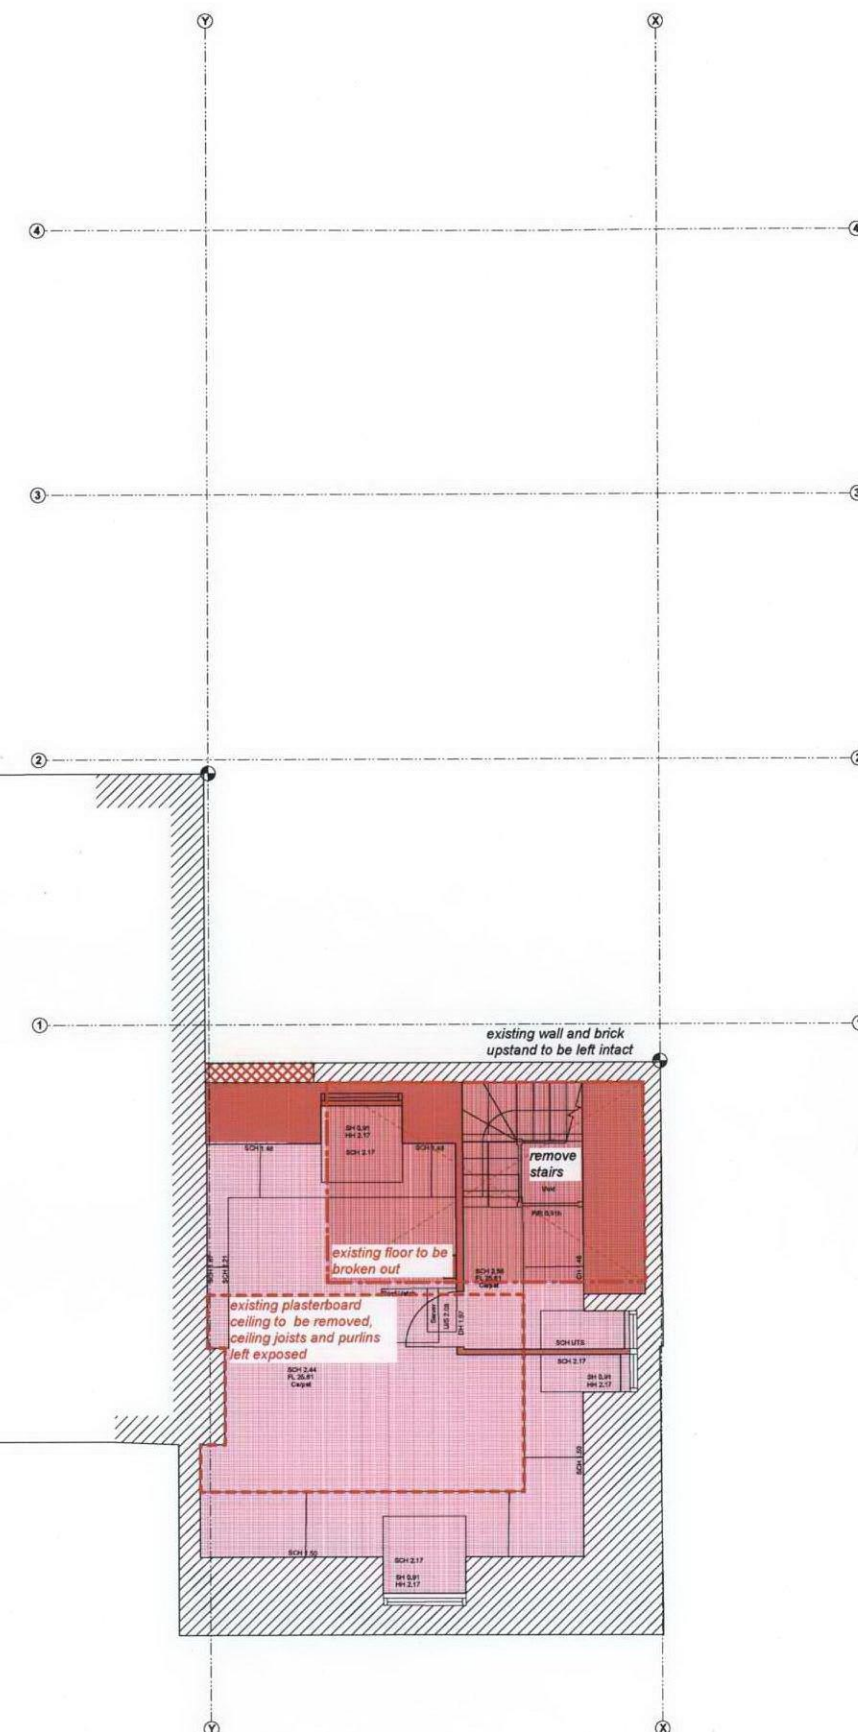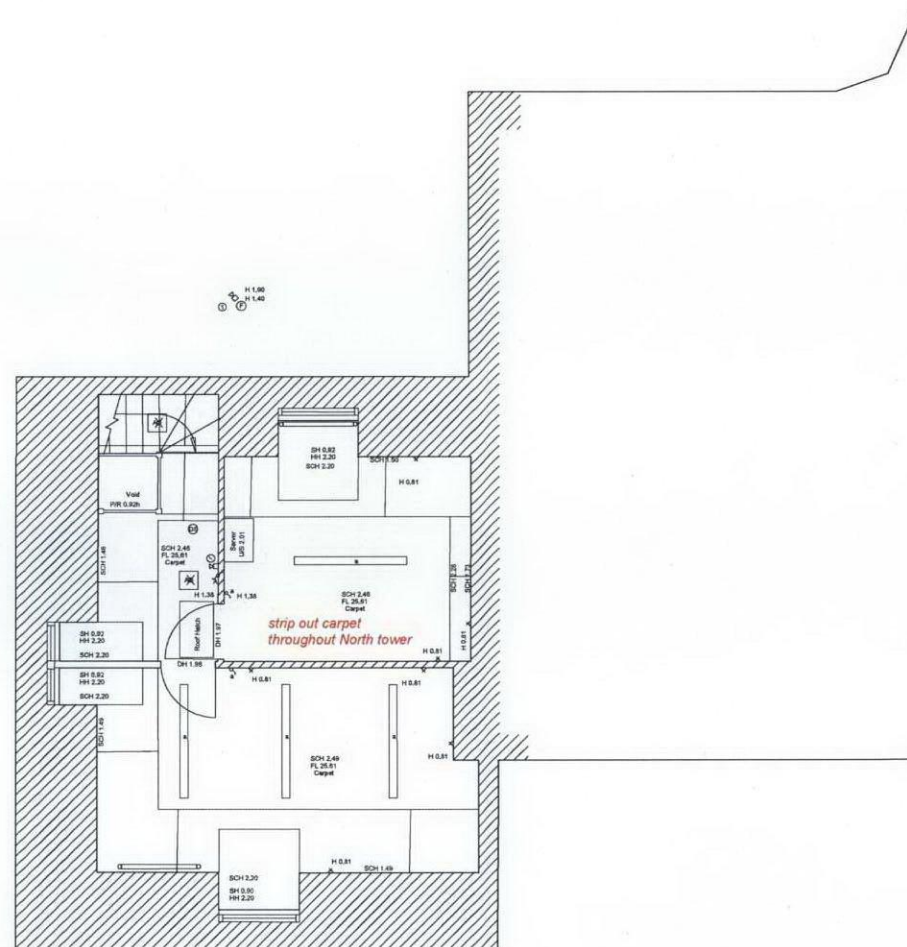

New Horizon Youth Centre
022/L12/03e
Existing second floor plan
ISSUED FOR PLANNING
Scale 1:50 @ A1, 1:100 @ A3
09. 04. 09

Revisions

	Date	
*	01. 03. 09	first issue
a	27. 03. 09	issued for building control
b	09. 04. 09	issued for planning

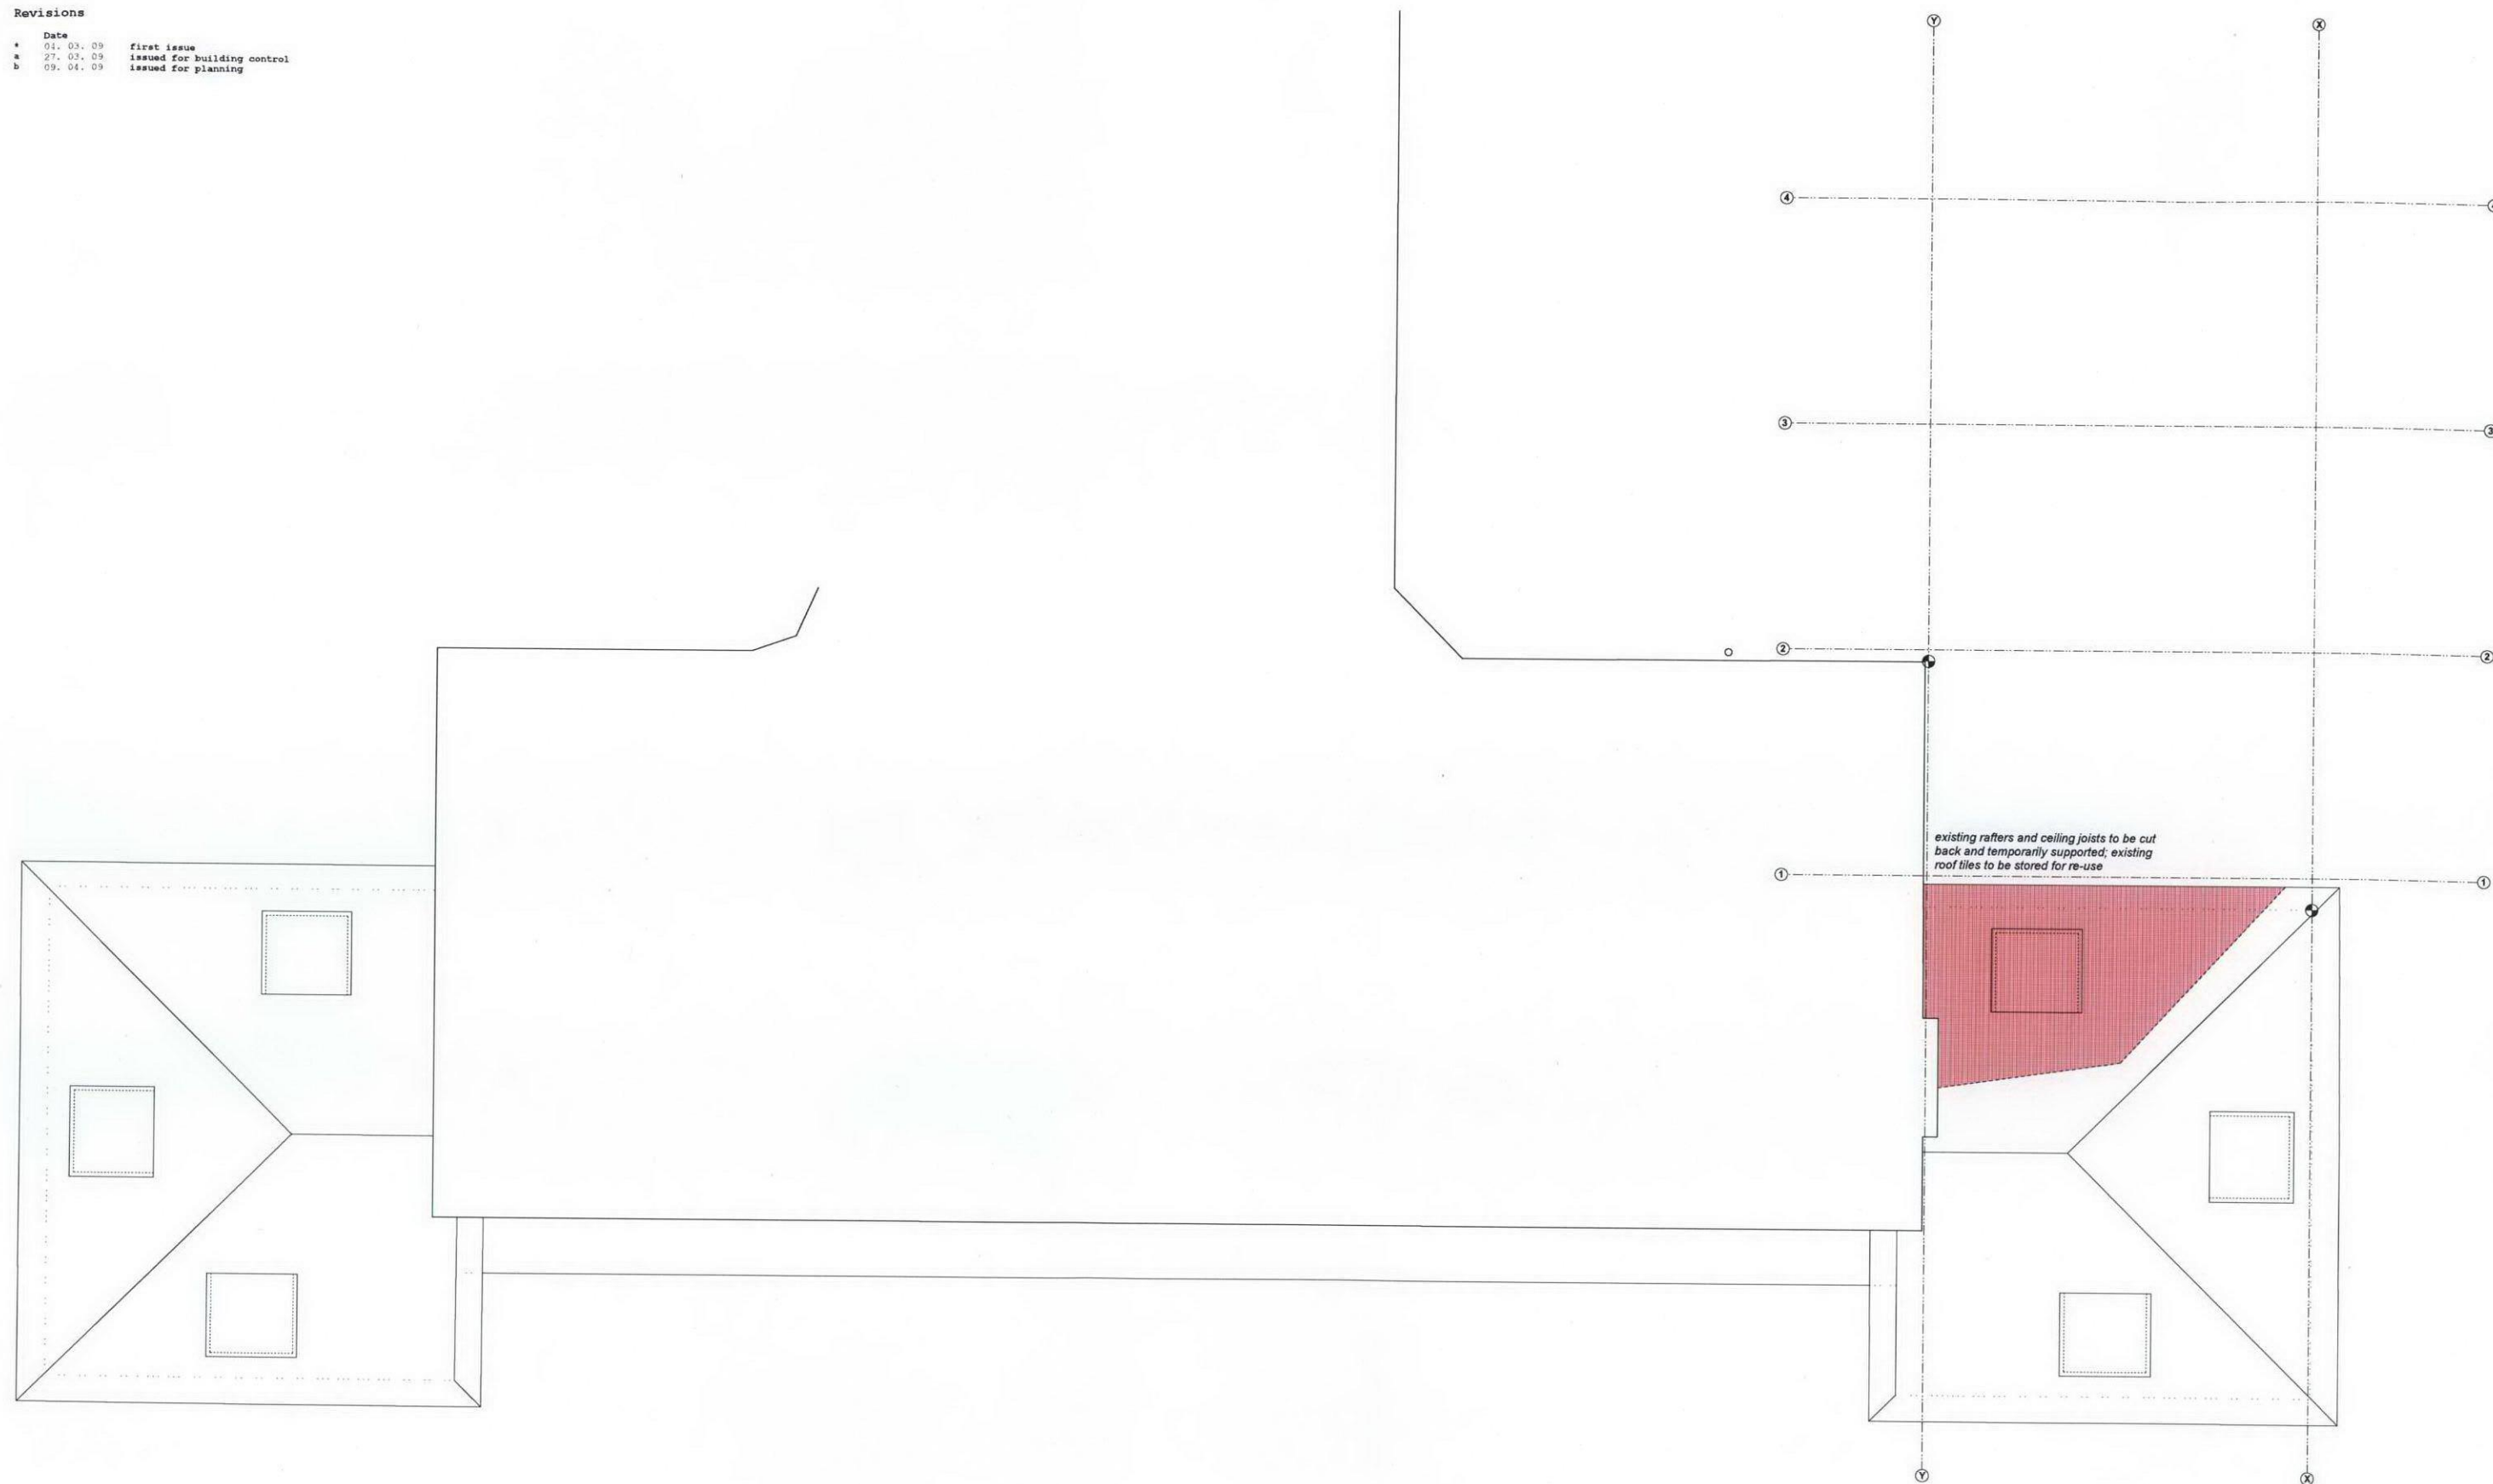

Adam Khan Architects
54-58 Tanner Street
London SE1 3PH
020 7403 9897
www.adamkhan.co.uk

New Horizon Youth Centre
022/L12/04b
Existing roof plan
ISSUED FOR PLANNING
Scale 1:50 @ A1, 1:100 @ A3
09. 04. 09

Revisions

	Date	
*	04.02.08	first issue
a	23.02.09	gate included
b	04.03.09	minor amendments
c	27.03.09	issued for building control
d	09.04.09	issued for planning


Key

 demolition

37.04 ridge
Levita House

30.79 ridge
north tower

25.78 eaves
south tower

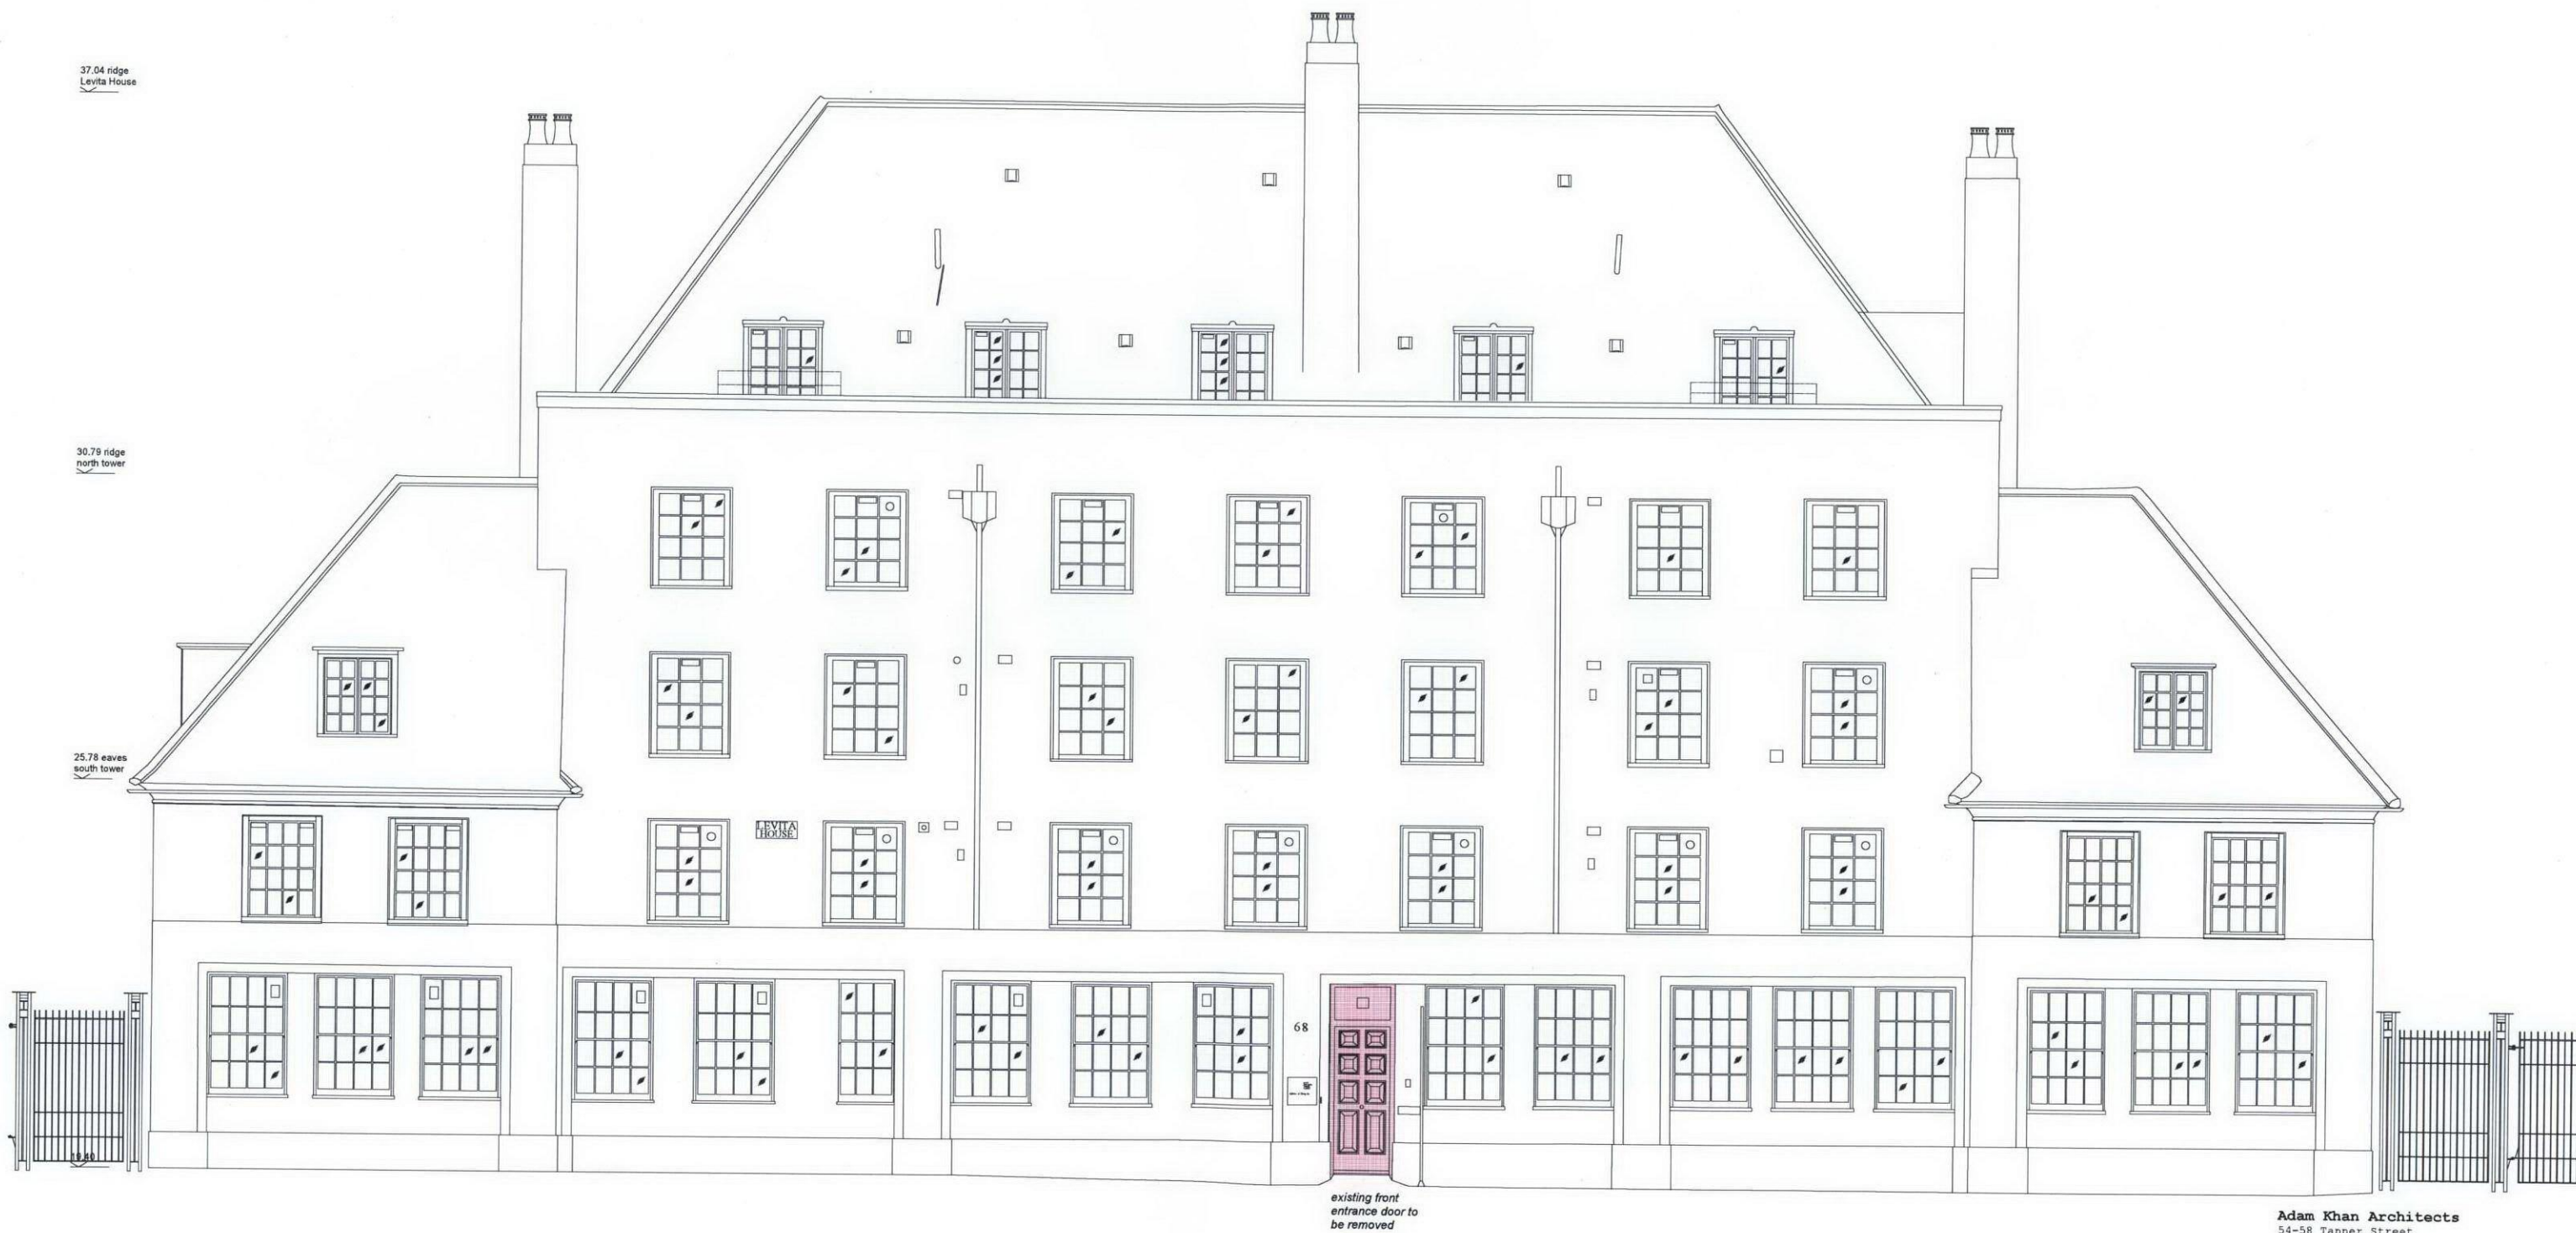

Adam Khan Architects
54-58 Tanner Street
London SE1 3PH
020 7403 9897
www.adamkhan.co.uk

New Horizon Youth Centre
022/L15/01d
Existing front elevation
ISSUED FOR PLANNING
Scale 1:50 @ A1
09.04.09

Revisions

Date		
04.02.08		first issue
23.05.08	a	demolition indicated
23.02.09	b	demolition clarified, grid added
04.03.09	c	minor amendments
27.03.09	d	issued for building control
09.04.09	e	issued for planning

Key

demolition


37.02 ridge
Levita House

30.82 ridge
south tower

25.79 eaves
south tower
25.61 ft
second floor

22.87 ft
first floor
22.87 eaves
existing extension

19.44 ft
ground floor

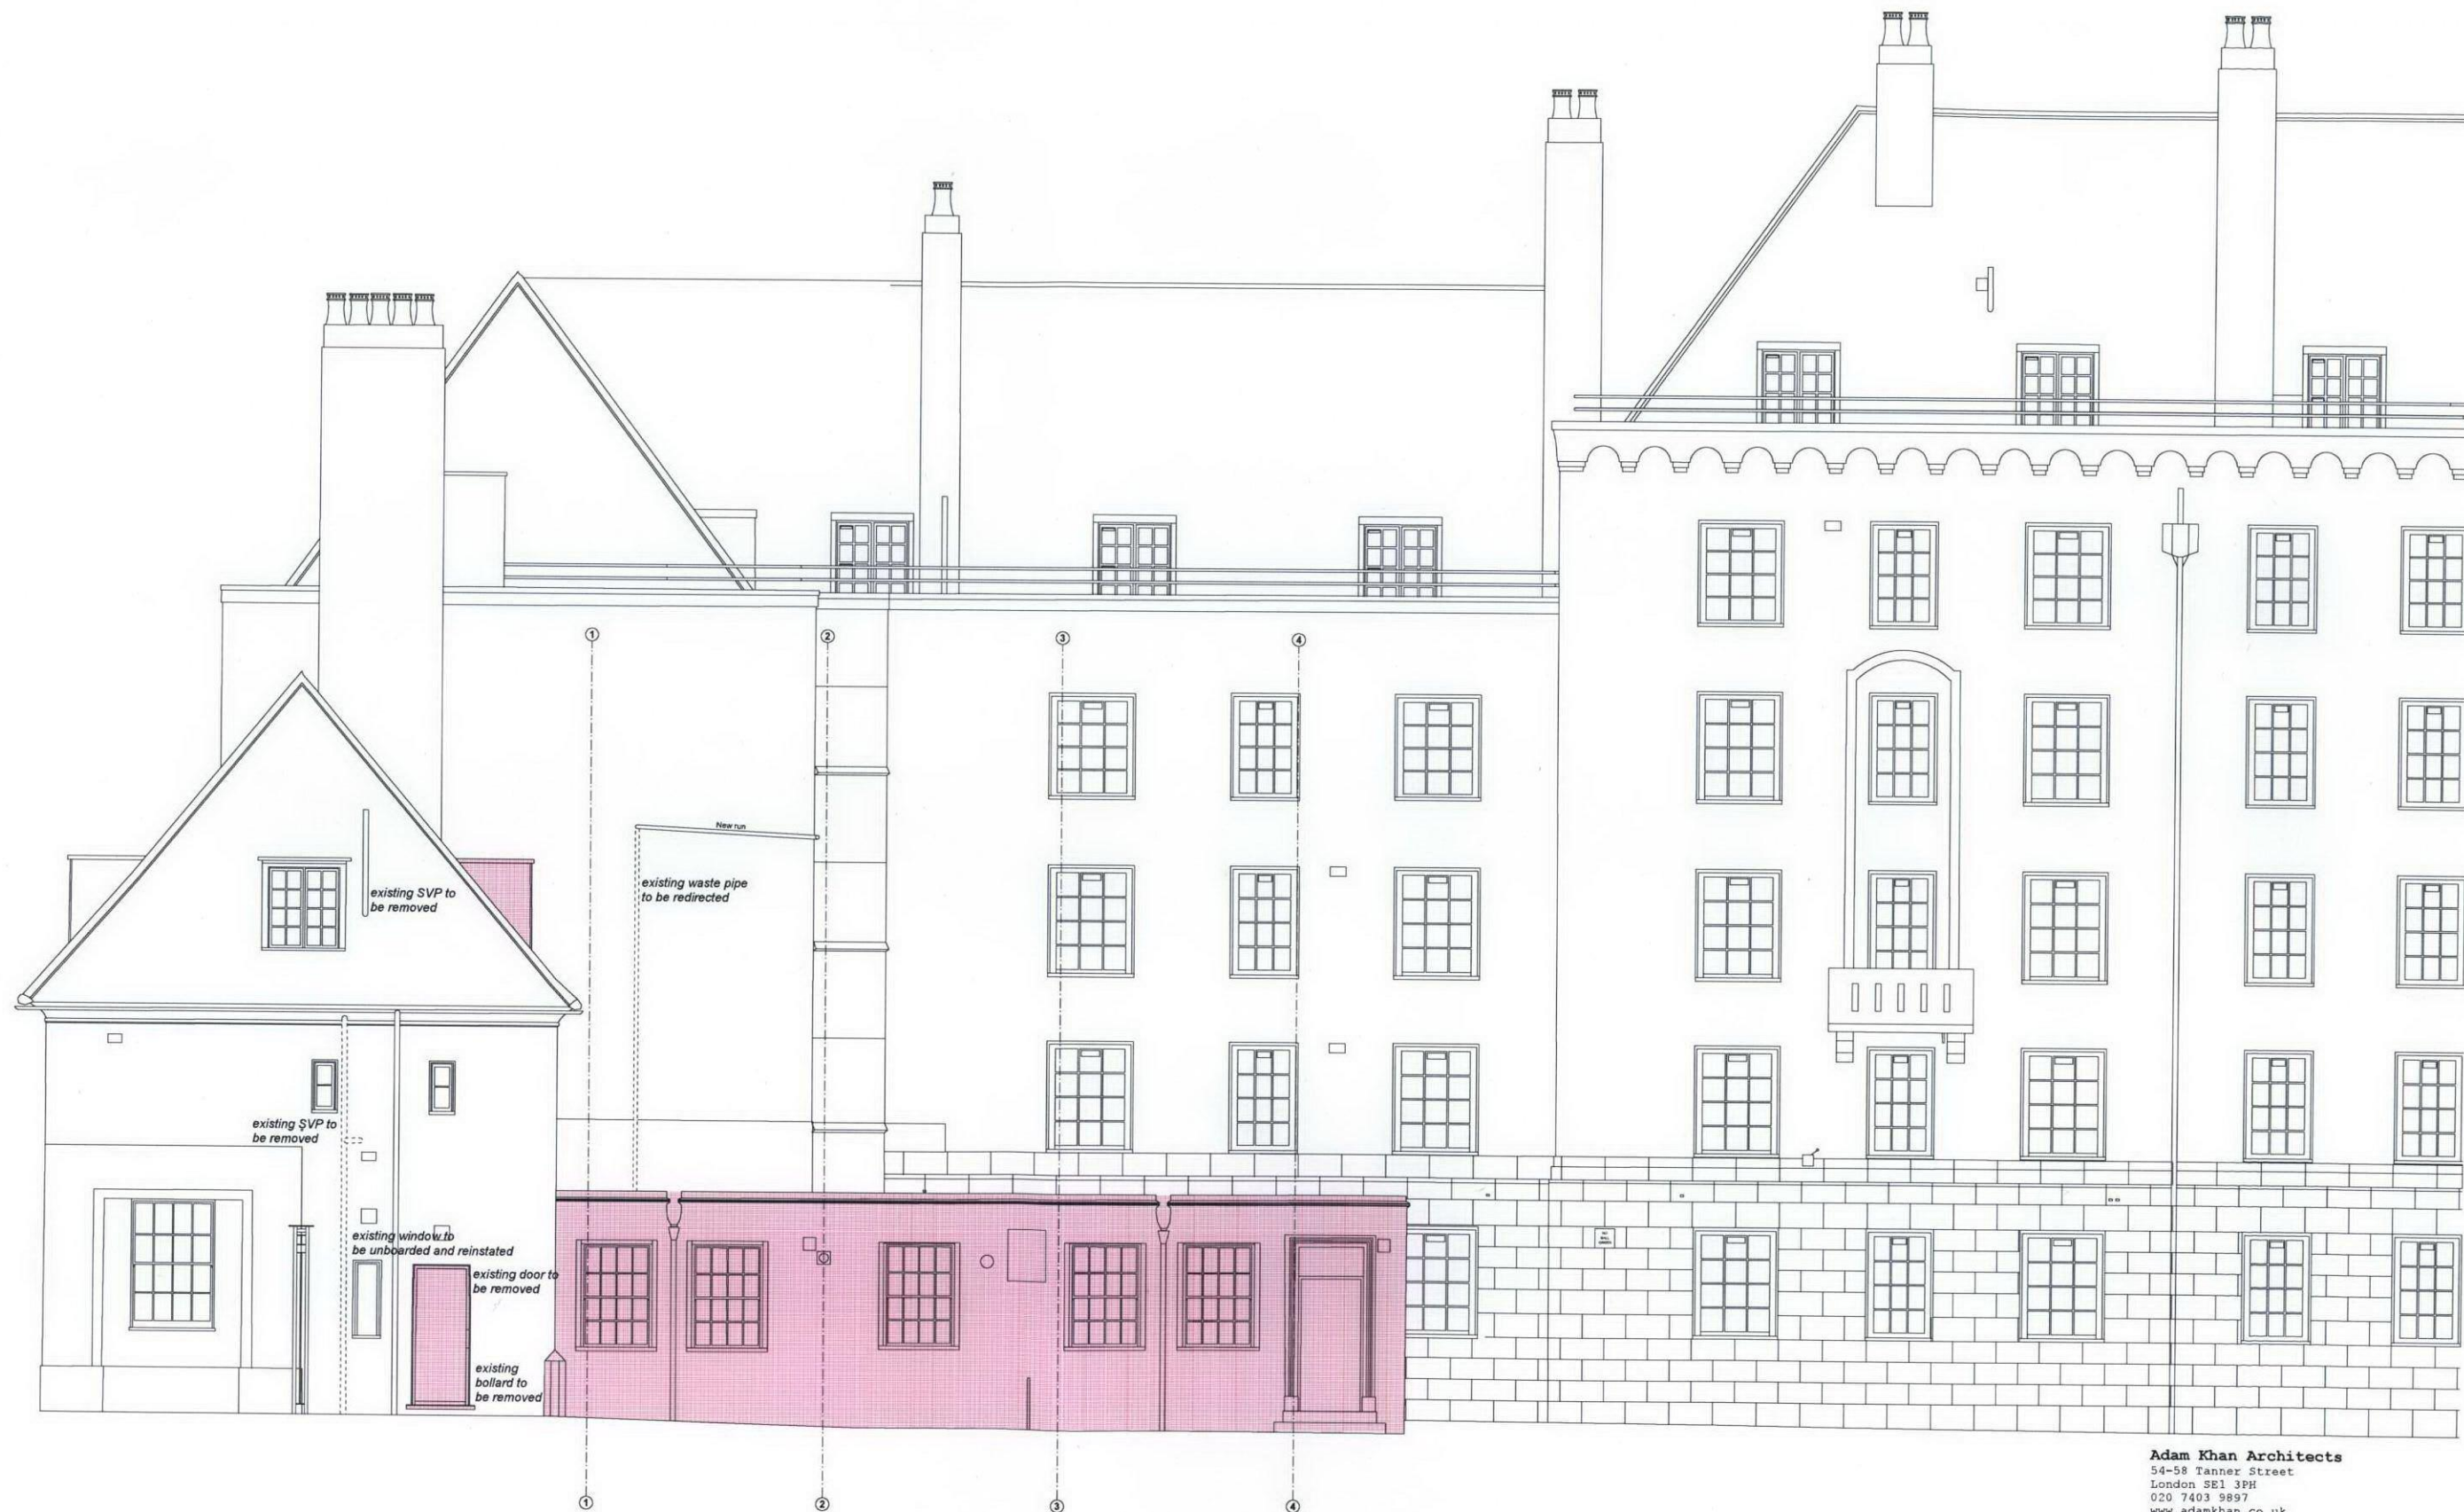

Adam Khan Architects
54-58 Tanner Street
London SE1 3PH
020 7403 9897
www.adamkhan.co.uk

New Horizon Youth Centre

022/L15/02e

Existing side elevation
ISSUED FOR PLANNING


Scale 1:50 @ A1
09.04.09

Revisions

	Date	
*	04. 02. 08	first issue
a	23. 05. 08	demolition indicated
b	23. 02. 09	demolition clarified
c	04. 03. 09	demolition clarified
d	27. 03. 09	issued for building control
e	09. 04. 09	issued for planning

Key

 demolition

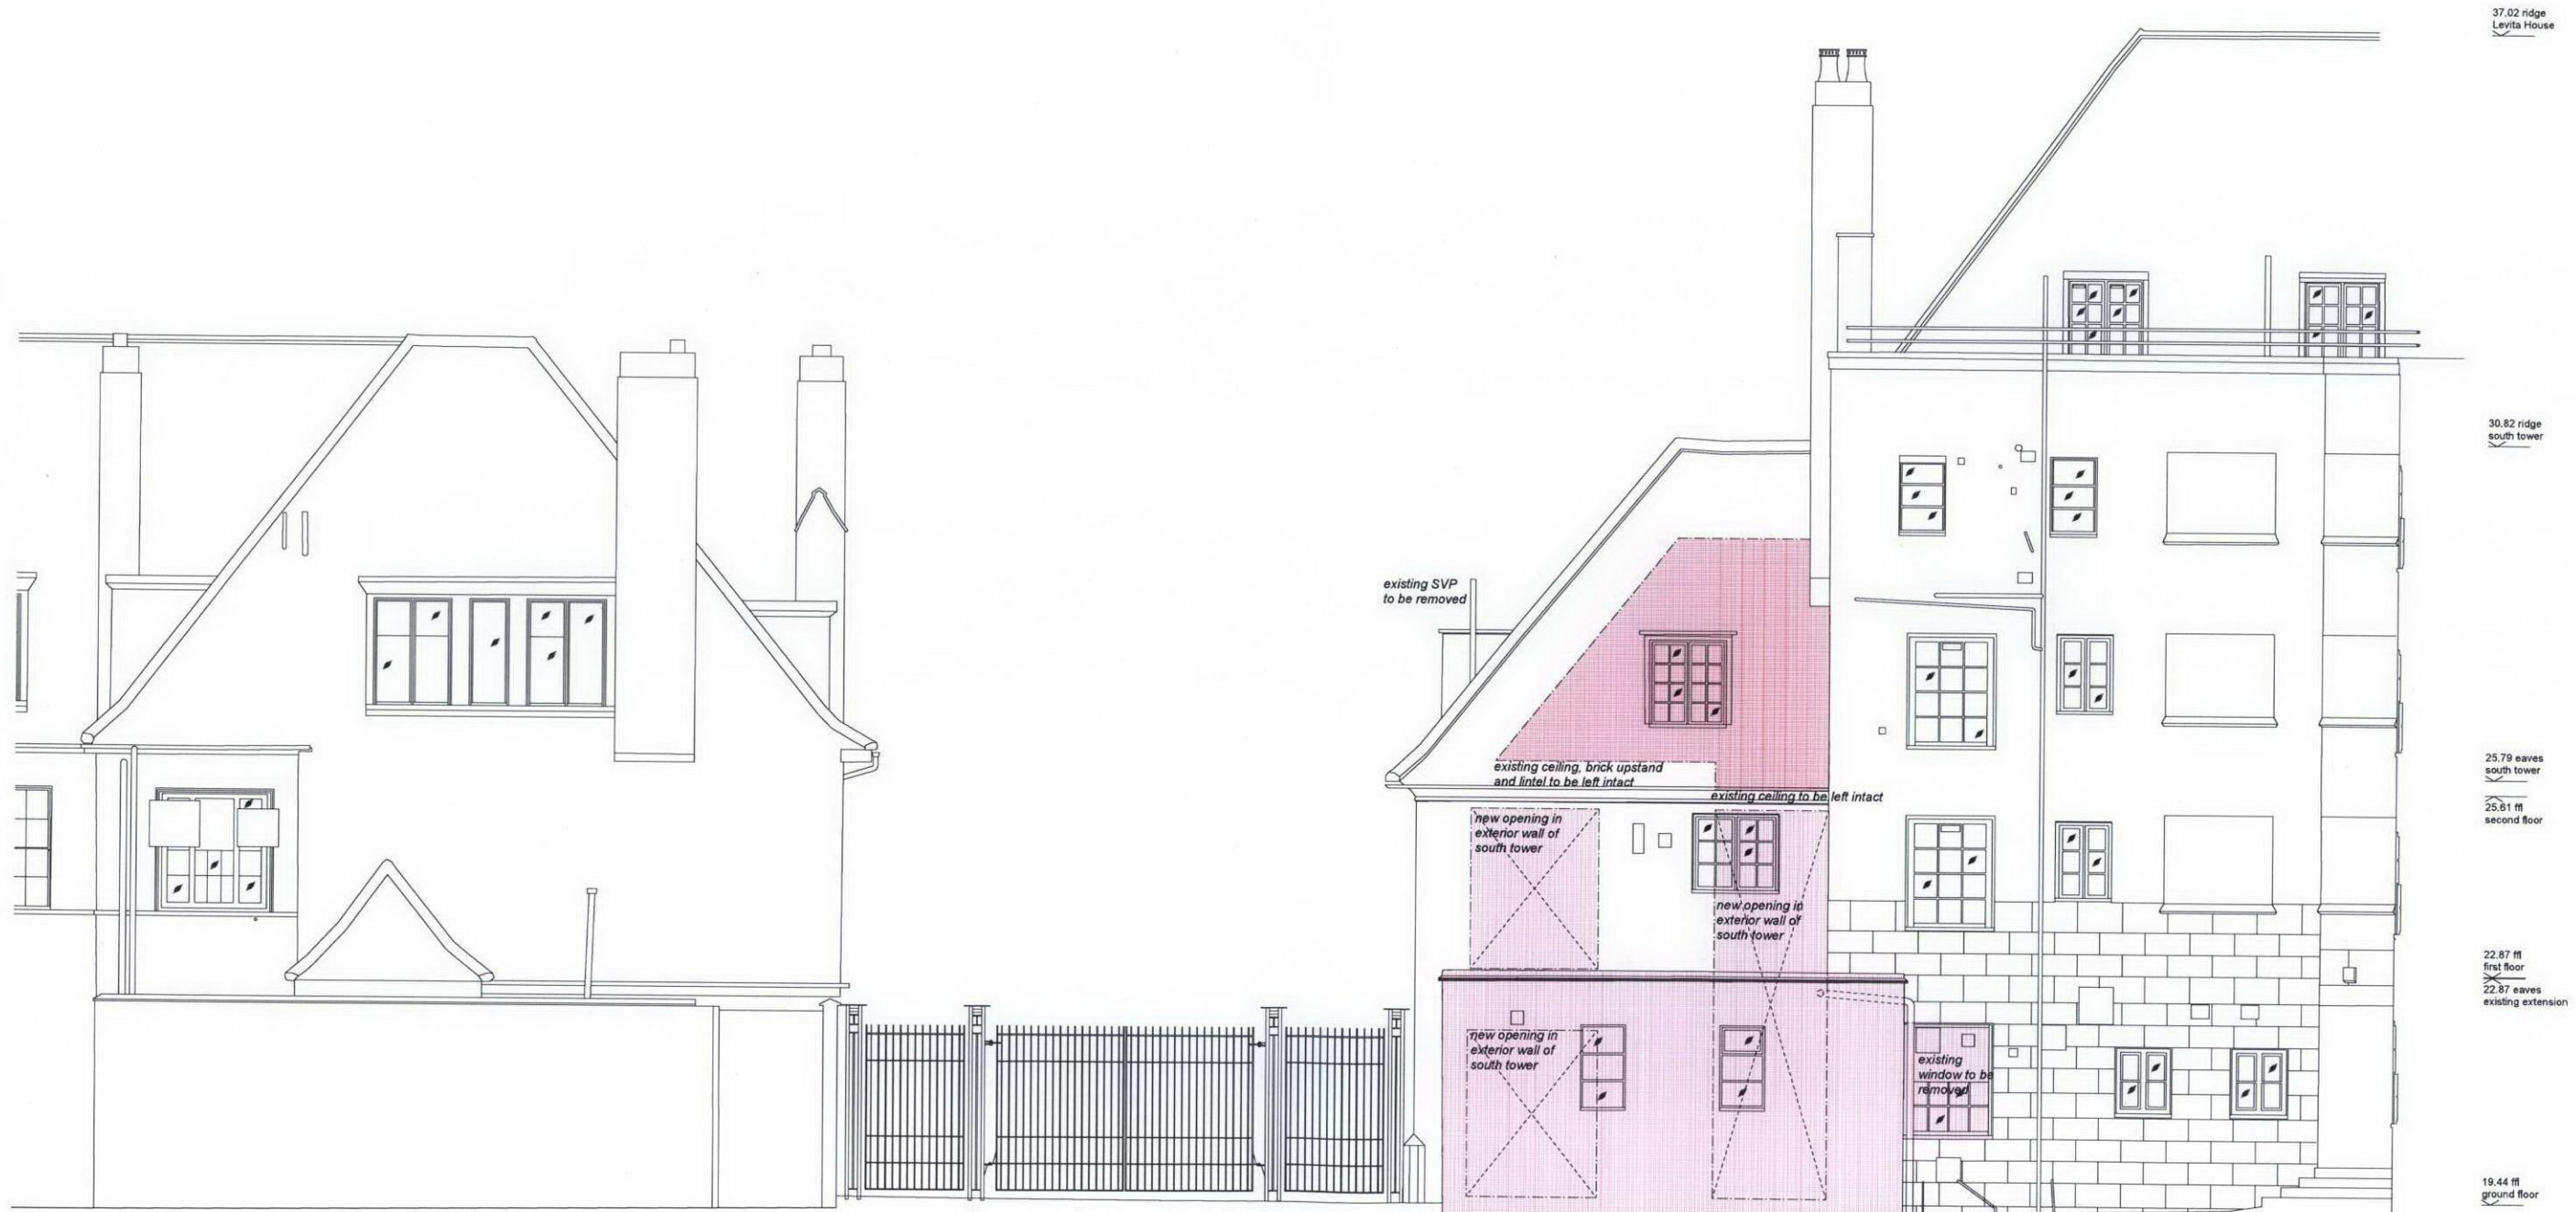

Adam Khan Architects
54-58 Tanner Street
London SE1 3PH
020 7403 9897
www.adamkhan.co.uk


New Horizon Youth Centre
022/L15/03e

Existing rear elevation
ISSUED FOR PLANNING

Scale 1:50 @ A1
09. 04. 09

Revisions

	Date	
*	23. 02. 09	first issue
a	04. 03. 09	minor amendments
b	10. 03. 09	issued for planning
c	27. 03. 09	issued for building control

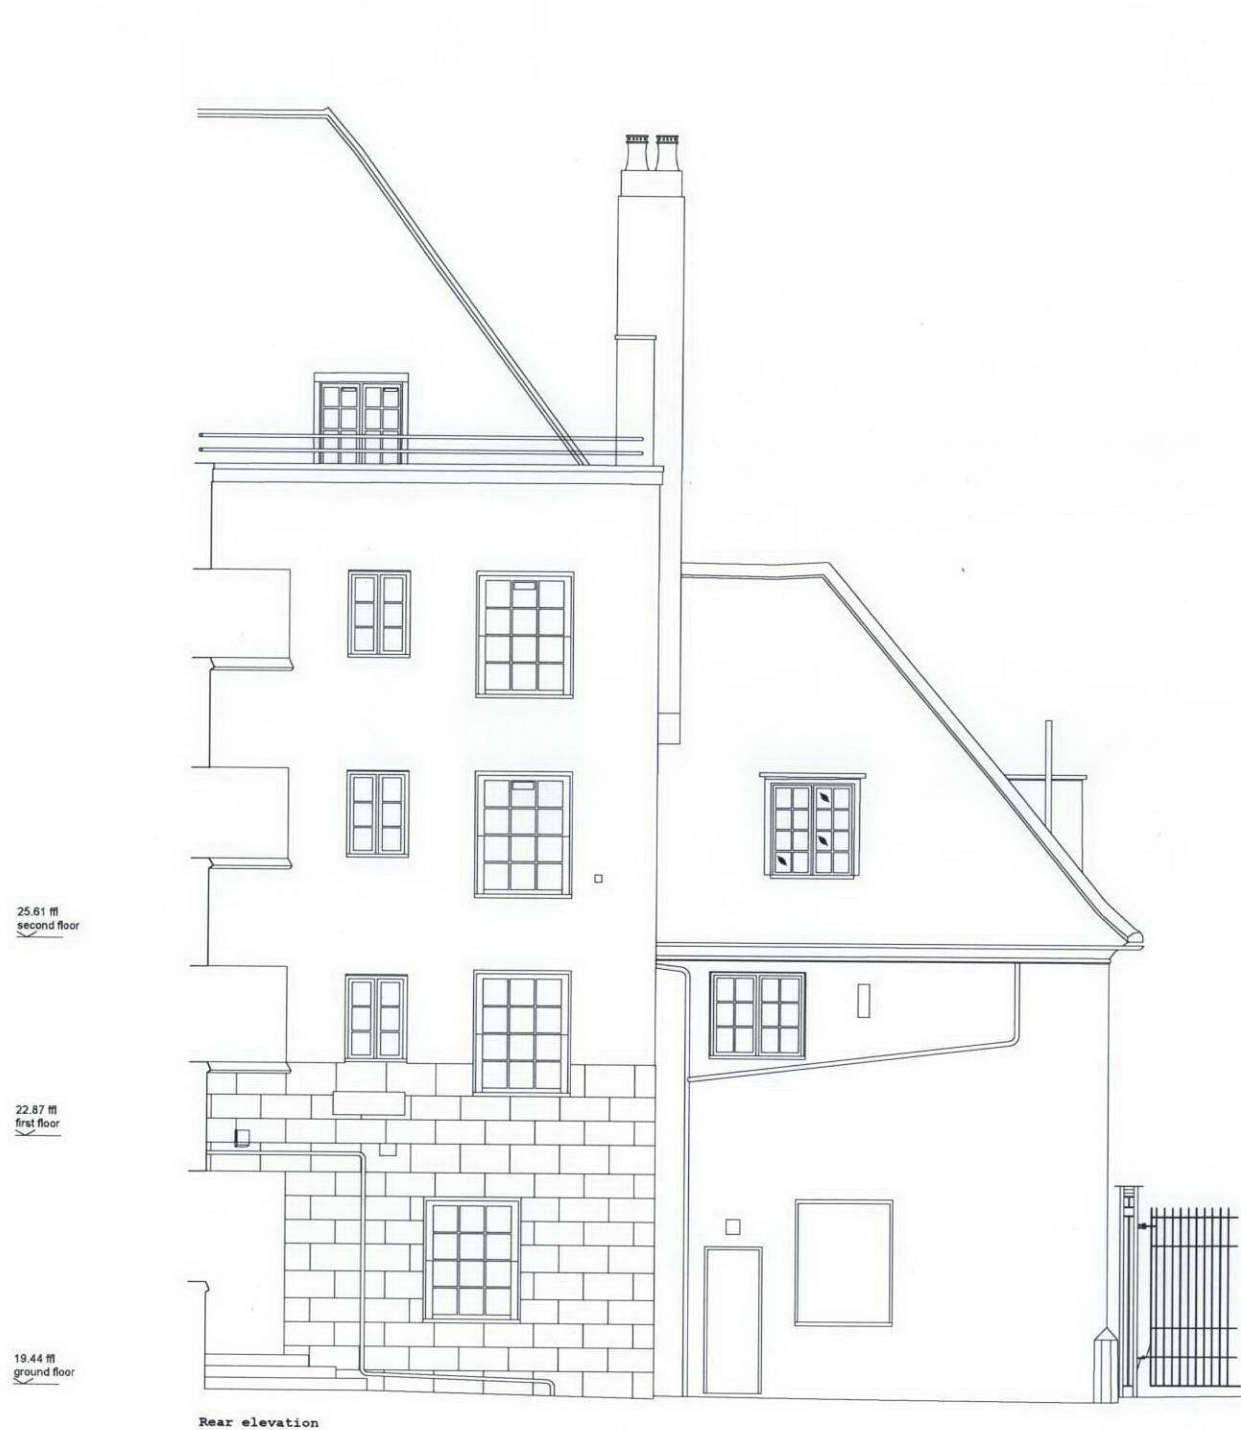

Adam Khan Architects
54-58 Tanner Street
London SE1 3PH
020 7403 9897
www.adamkhan.co.uk

New Horizon Youth Centre


022/L15/05d

Existing rear & side elevation NT
ISSUED FOR PLANNING

Scale 1:50 @ A1, 1:100 @ A3
09. 04. 09

	Date	
* a	04. 02. 08	first issue
b	23. 05. 08	demolition indicated
c	23. 02. 09	ramp amended, gate added, access to flats indicated
d	04. 03. 09	general amendments
e	10. 03. 09	issued for planning
f	27. 03. 09	issued for building control
g	09. 04. 09	issued for planning

	structure existing
	project boundary
	pedestrian access to be maintained
	New Horizon Youth Centre
	Levita House and other buildings

 


Proposed site plan
ISSUED FOR PLANNING

Scale 1:100 @ A1, 1:200 @ A3
09. 04. 09

Revisions

Date	Revisions
04.02.08	first issue
05.03.08	general amendments
10.03.08	minor amendments
17.03.08	minor amendments
22.04.08	general amendments
16.09.08	BR amendments
23.09.08	amendments to stair, lift
29.09.08	kitchen changed, lighting layout
06.10.08	minor amendments
10.10.08	general amendments, Stage D issue
16.10.08	minor amendments, Stage D issue
28.10.08	amendments to GP NT, serving counter
03.12.08	general amendments, Stage E issue
24.02.09	general amendments
04.03.09	general amendments, detail notes added
10.03.09	issued for planning
27.03.09	issued for building control
09.04.09	issued for planning

Key	Structure
	structure existing
	structure new
Lighting	Heating
	Radiator
	Grille above radiator
	F/R heating pipes risers
Drainage	
	Existing soil ventilated pipe
	Existing rainwater pipe
	New soil ventilated pipe
	New rainwater pipe

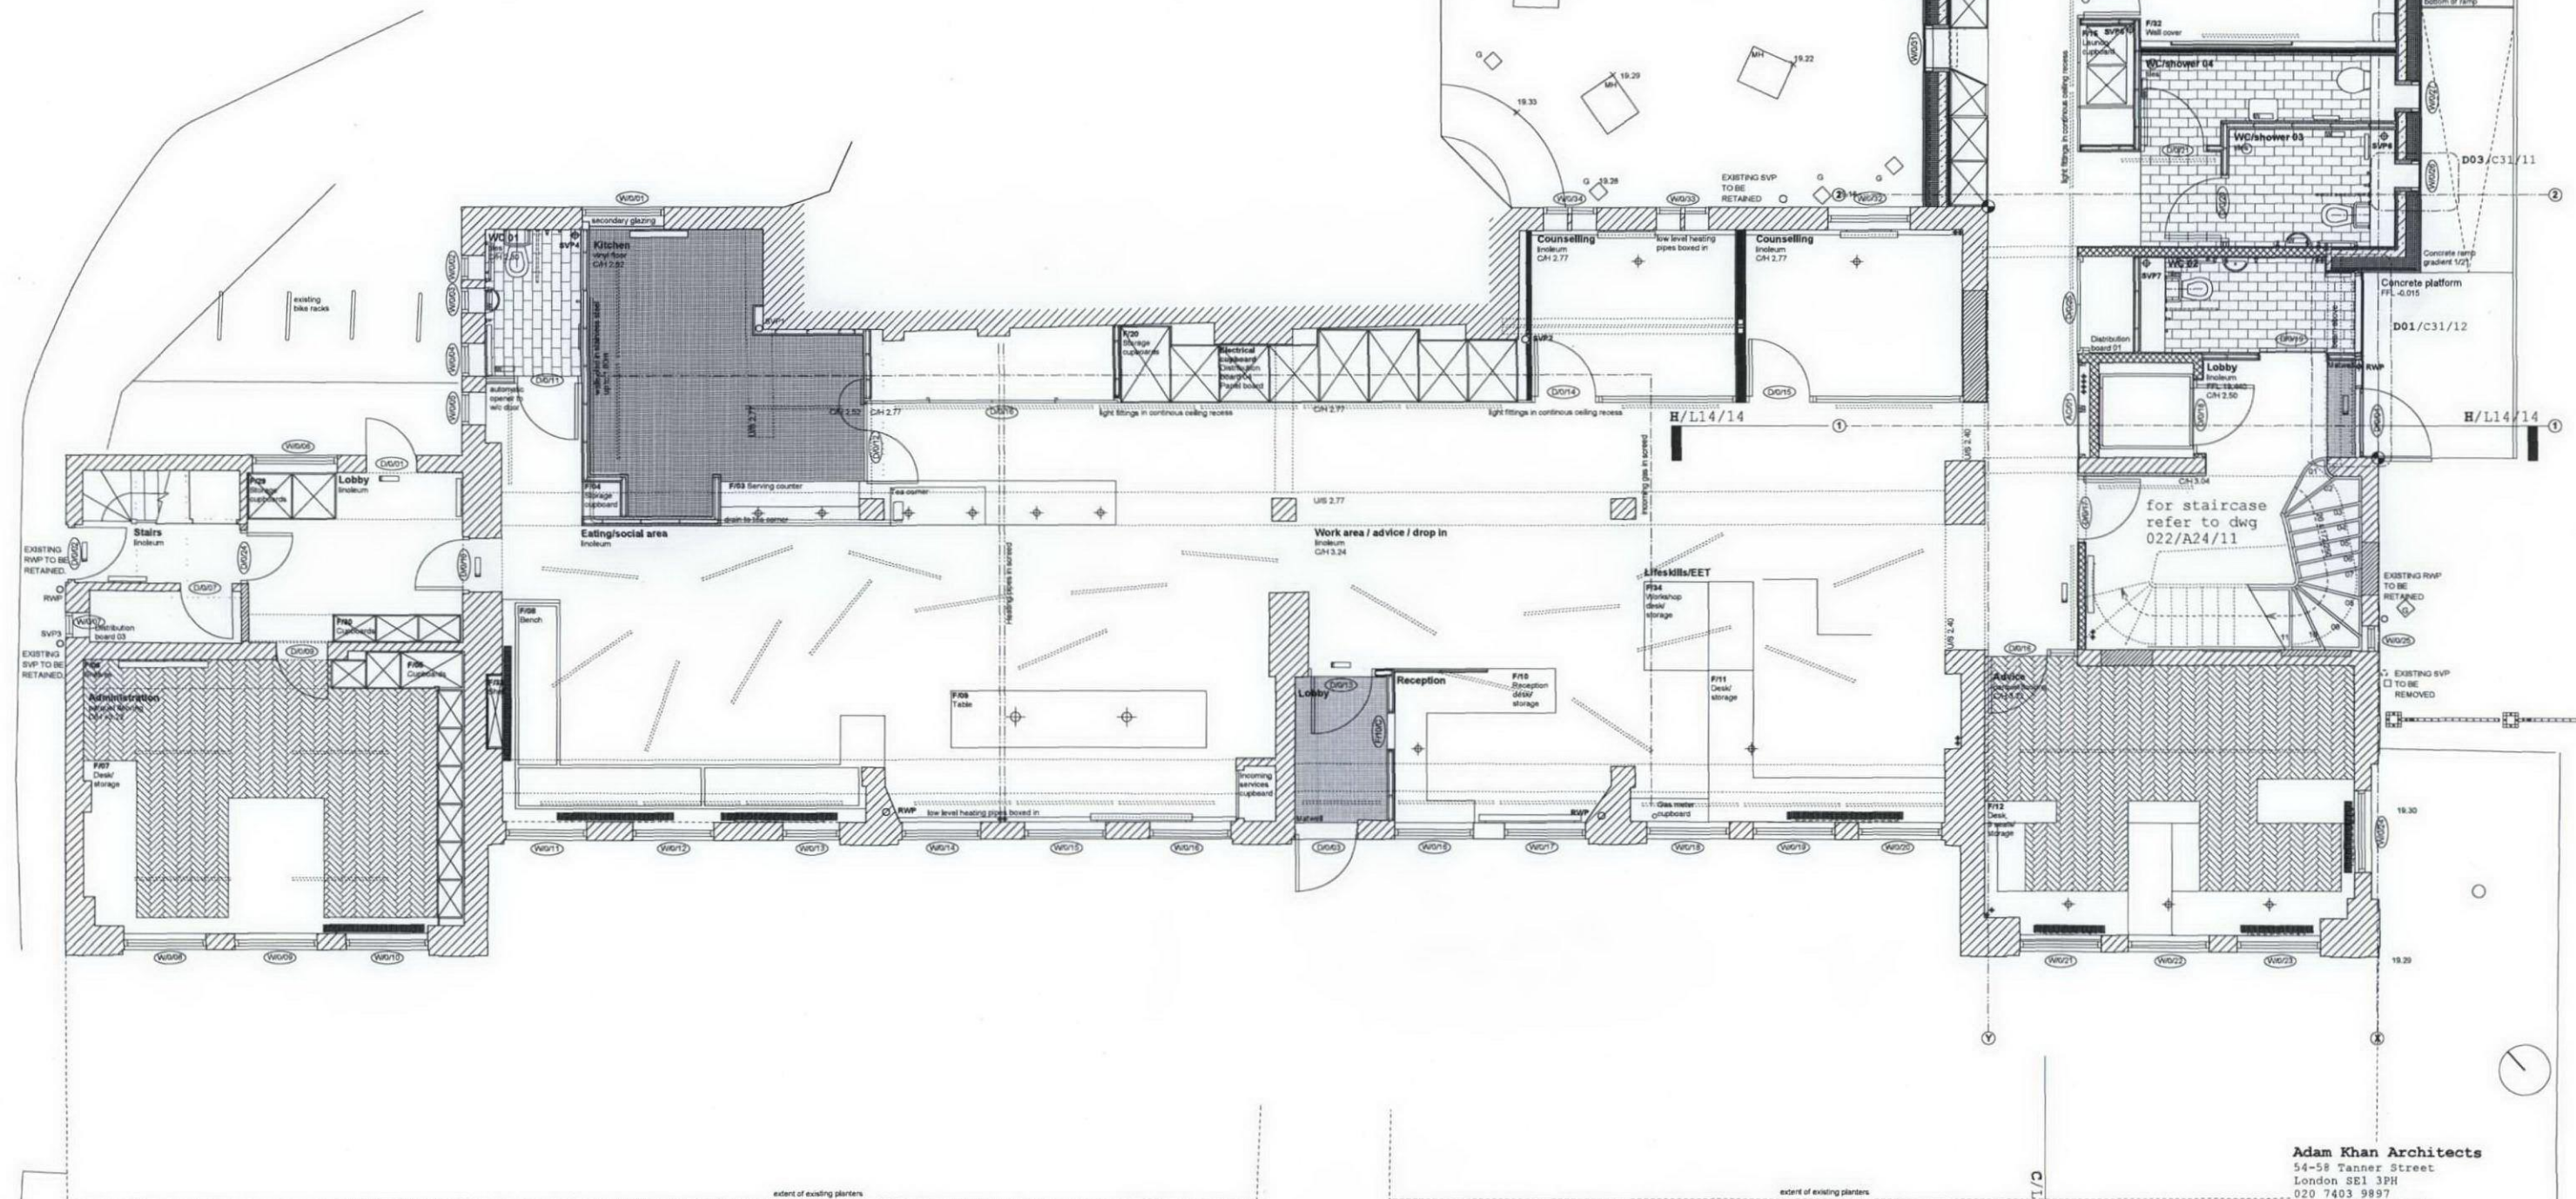

Adam Khan Architects
54-58 Tanner Street
London SE1 3PH
020 7403 9897
www.adamkhan.co.uk

New Horizon Youth Centre
022/L12/11r
Proposed ground floor plan
ISSUED FOR PLANNING
Scale 1:50 @ A1, 1:100 @ A3
09.04.09