

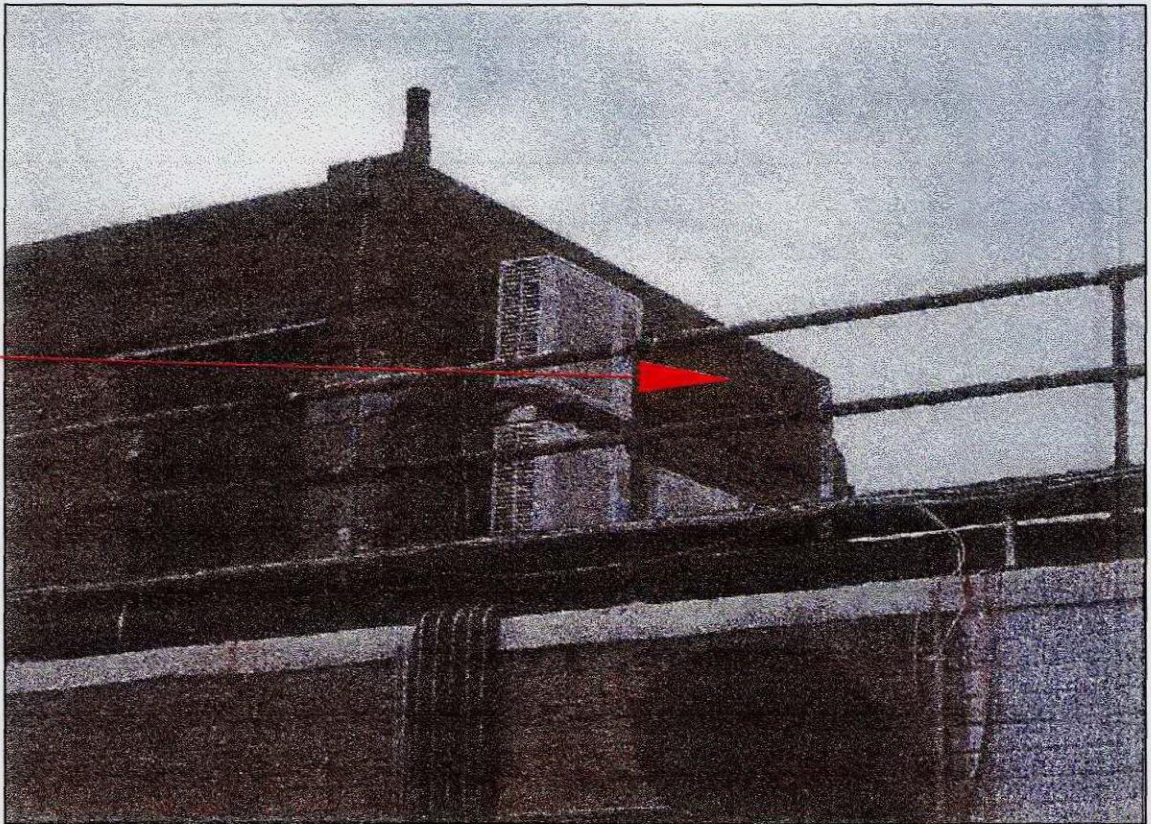


Condenser Details:

Dimensions: W:800mm, D:285mm, H:550mm
Weight: 31 kg
Noise 47dBA
Electrical supply: 220-240V,50Hz single phase
System power input:1,075kW nominal
Running current:5A

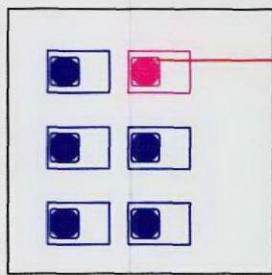

View A


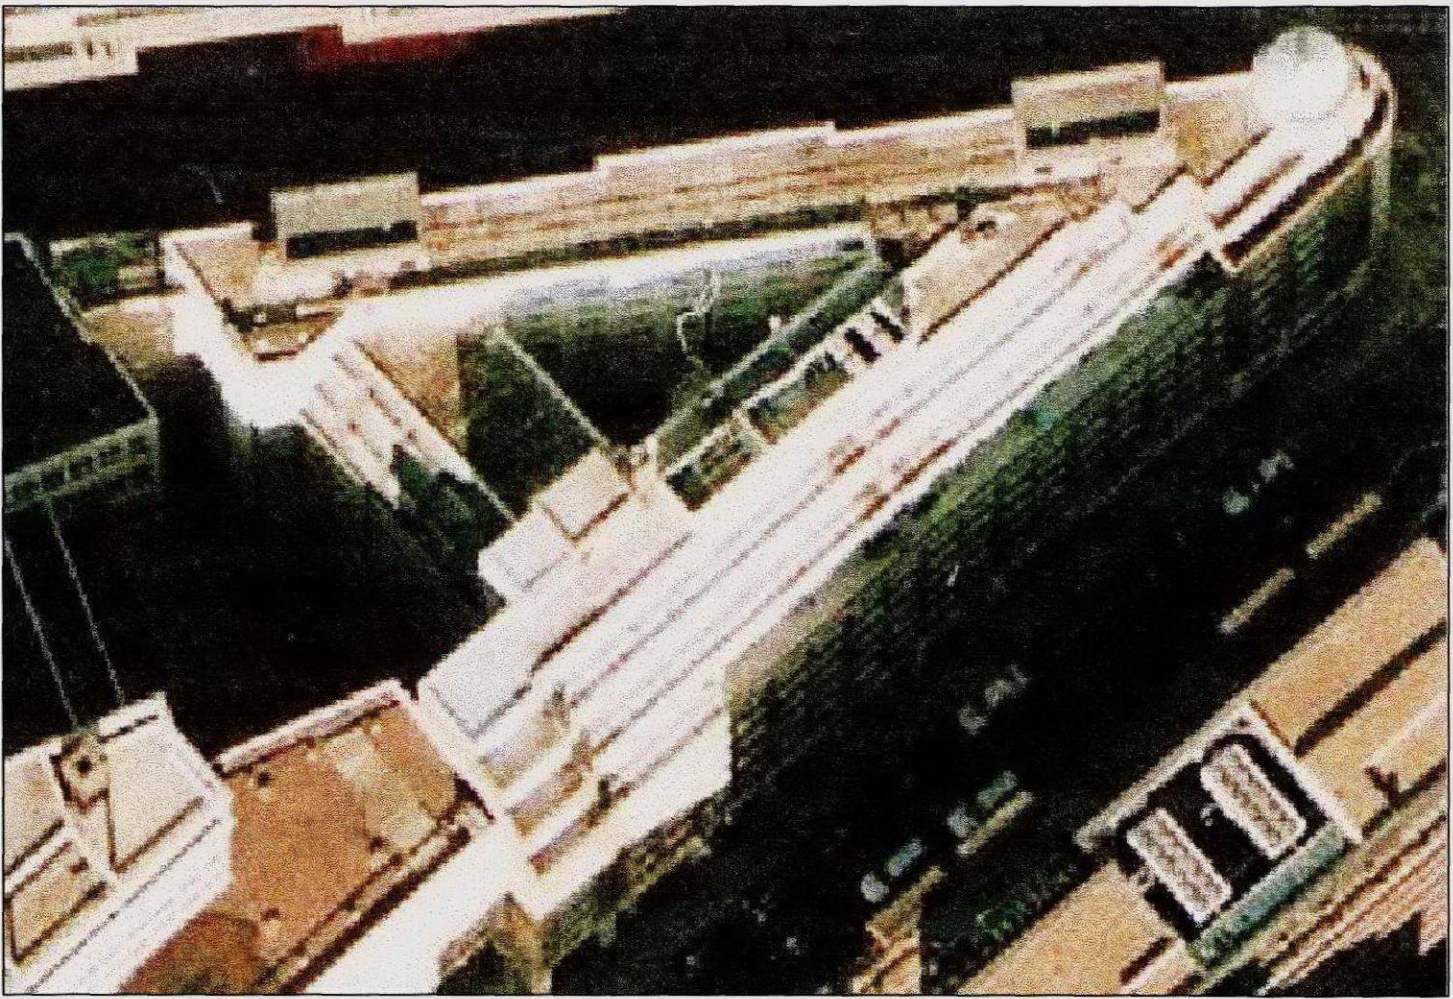


Satelite View

Key

	Existing Condenser Unit
	Proposed Condenser Unit

Elevation A

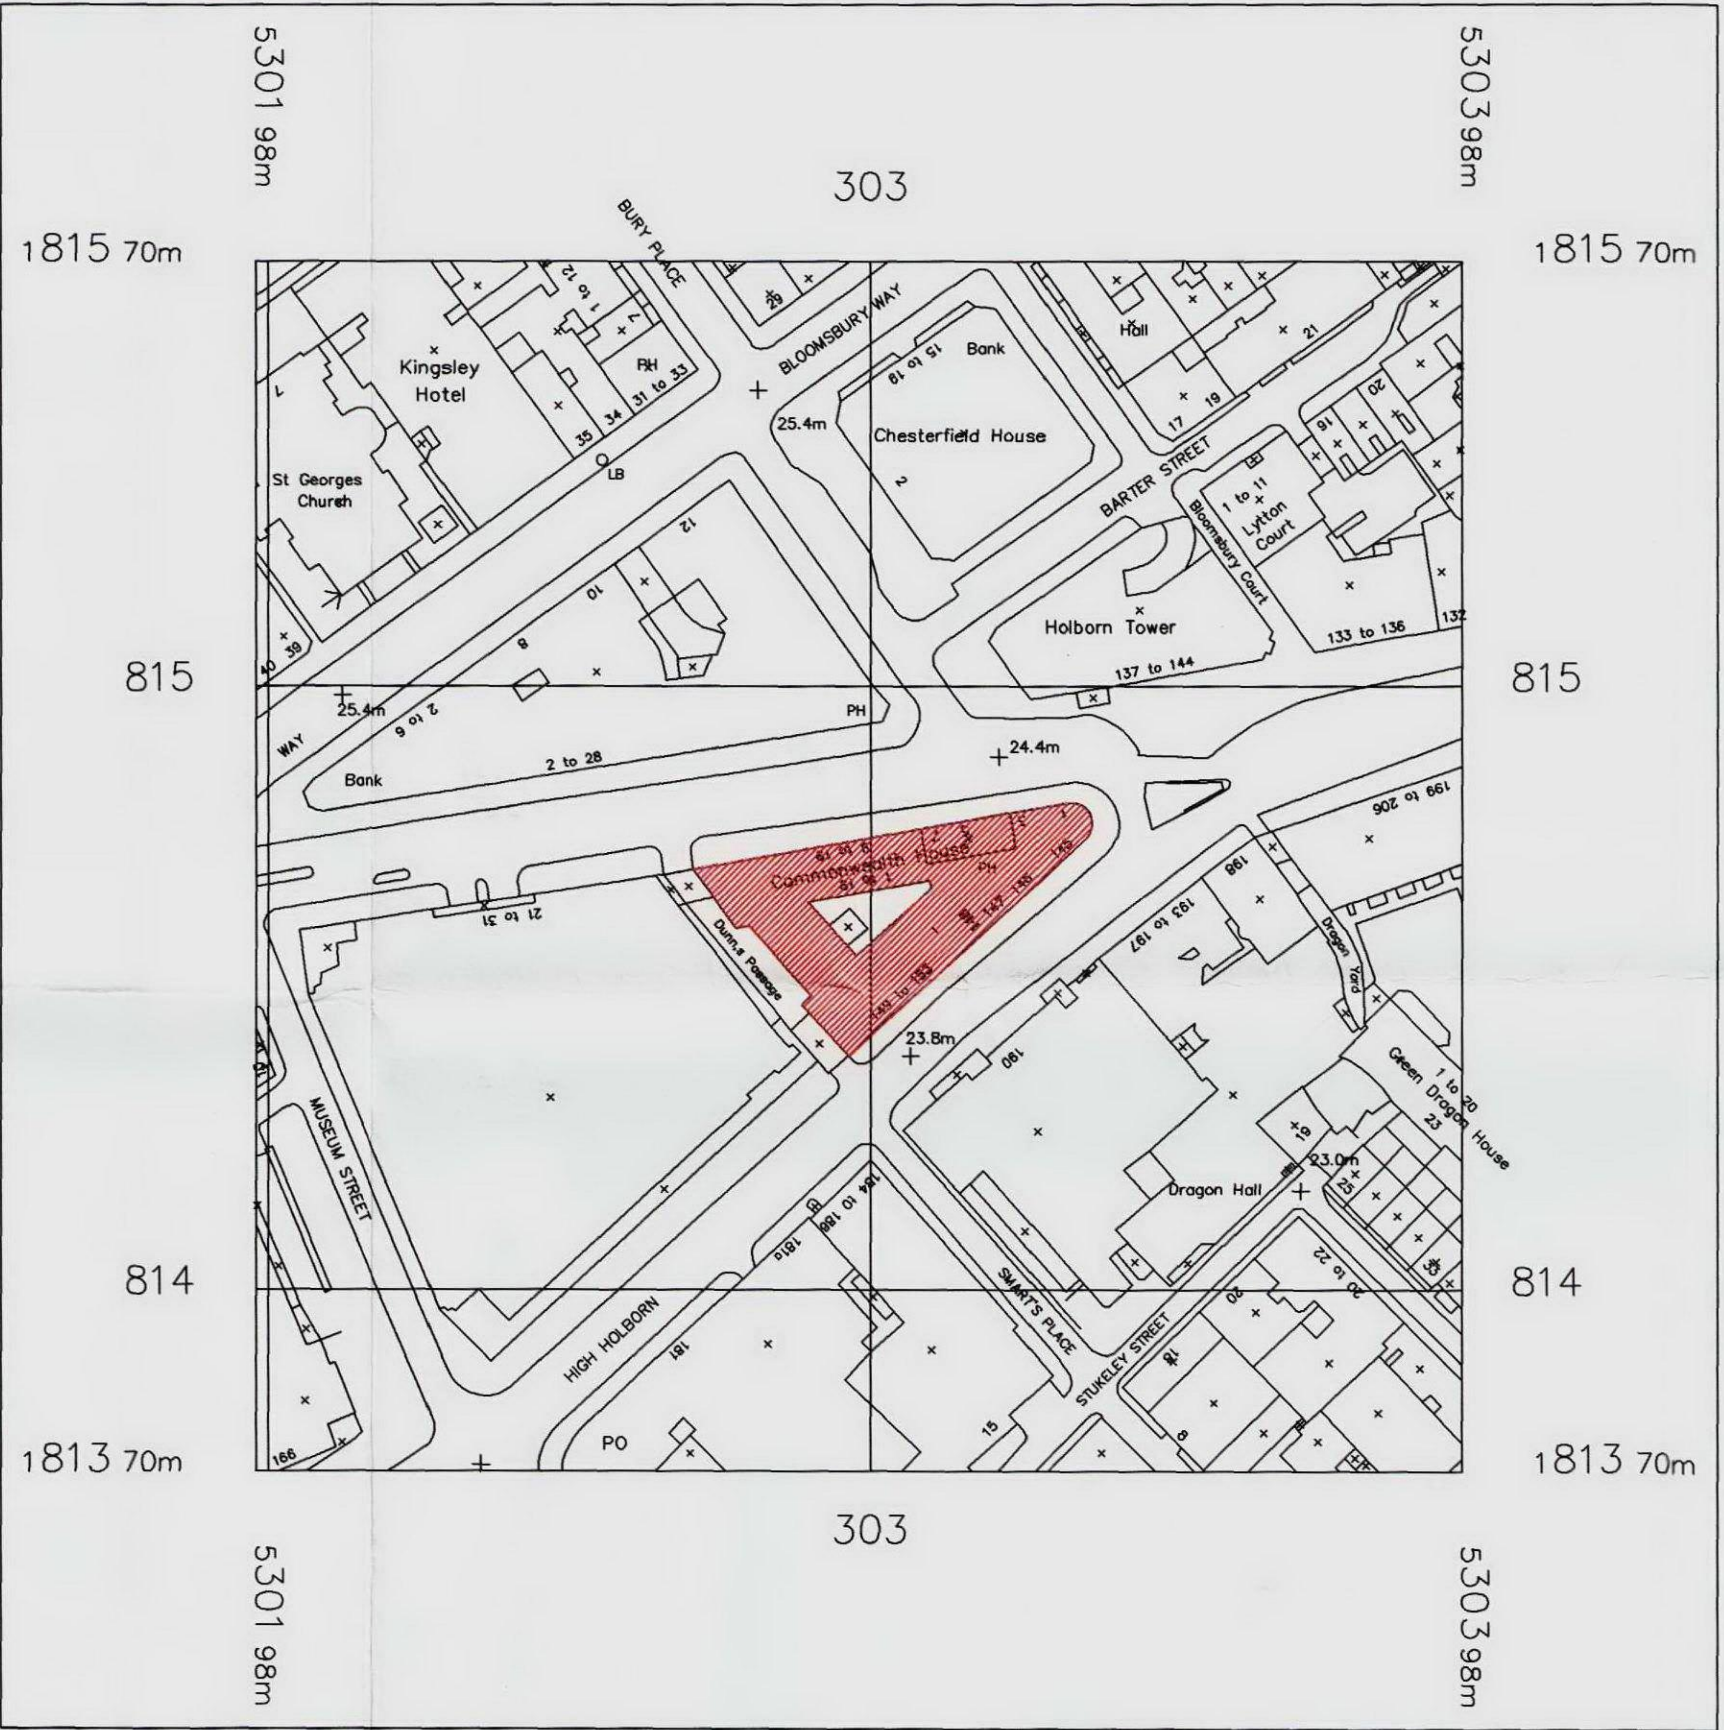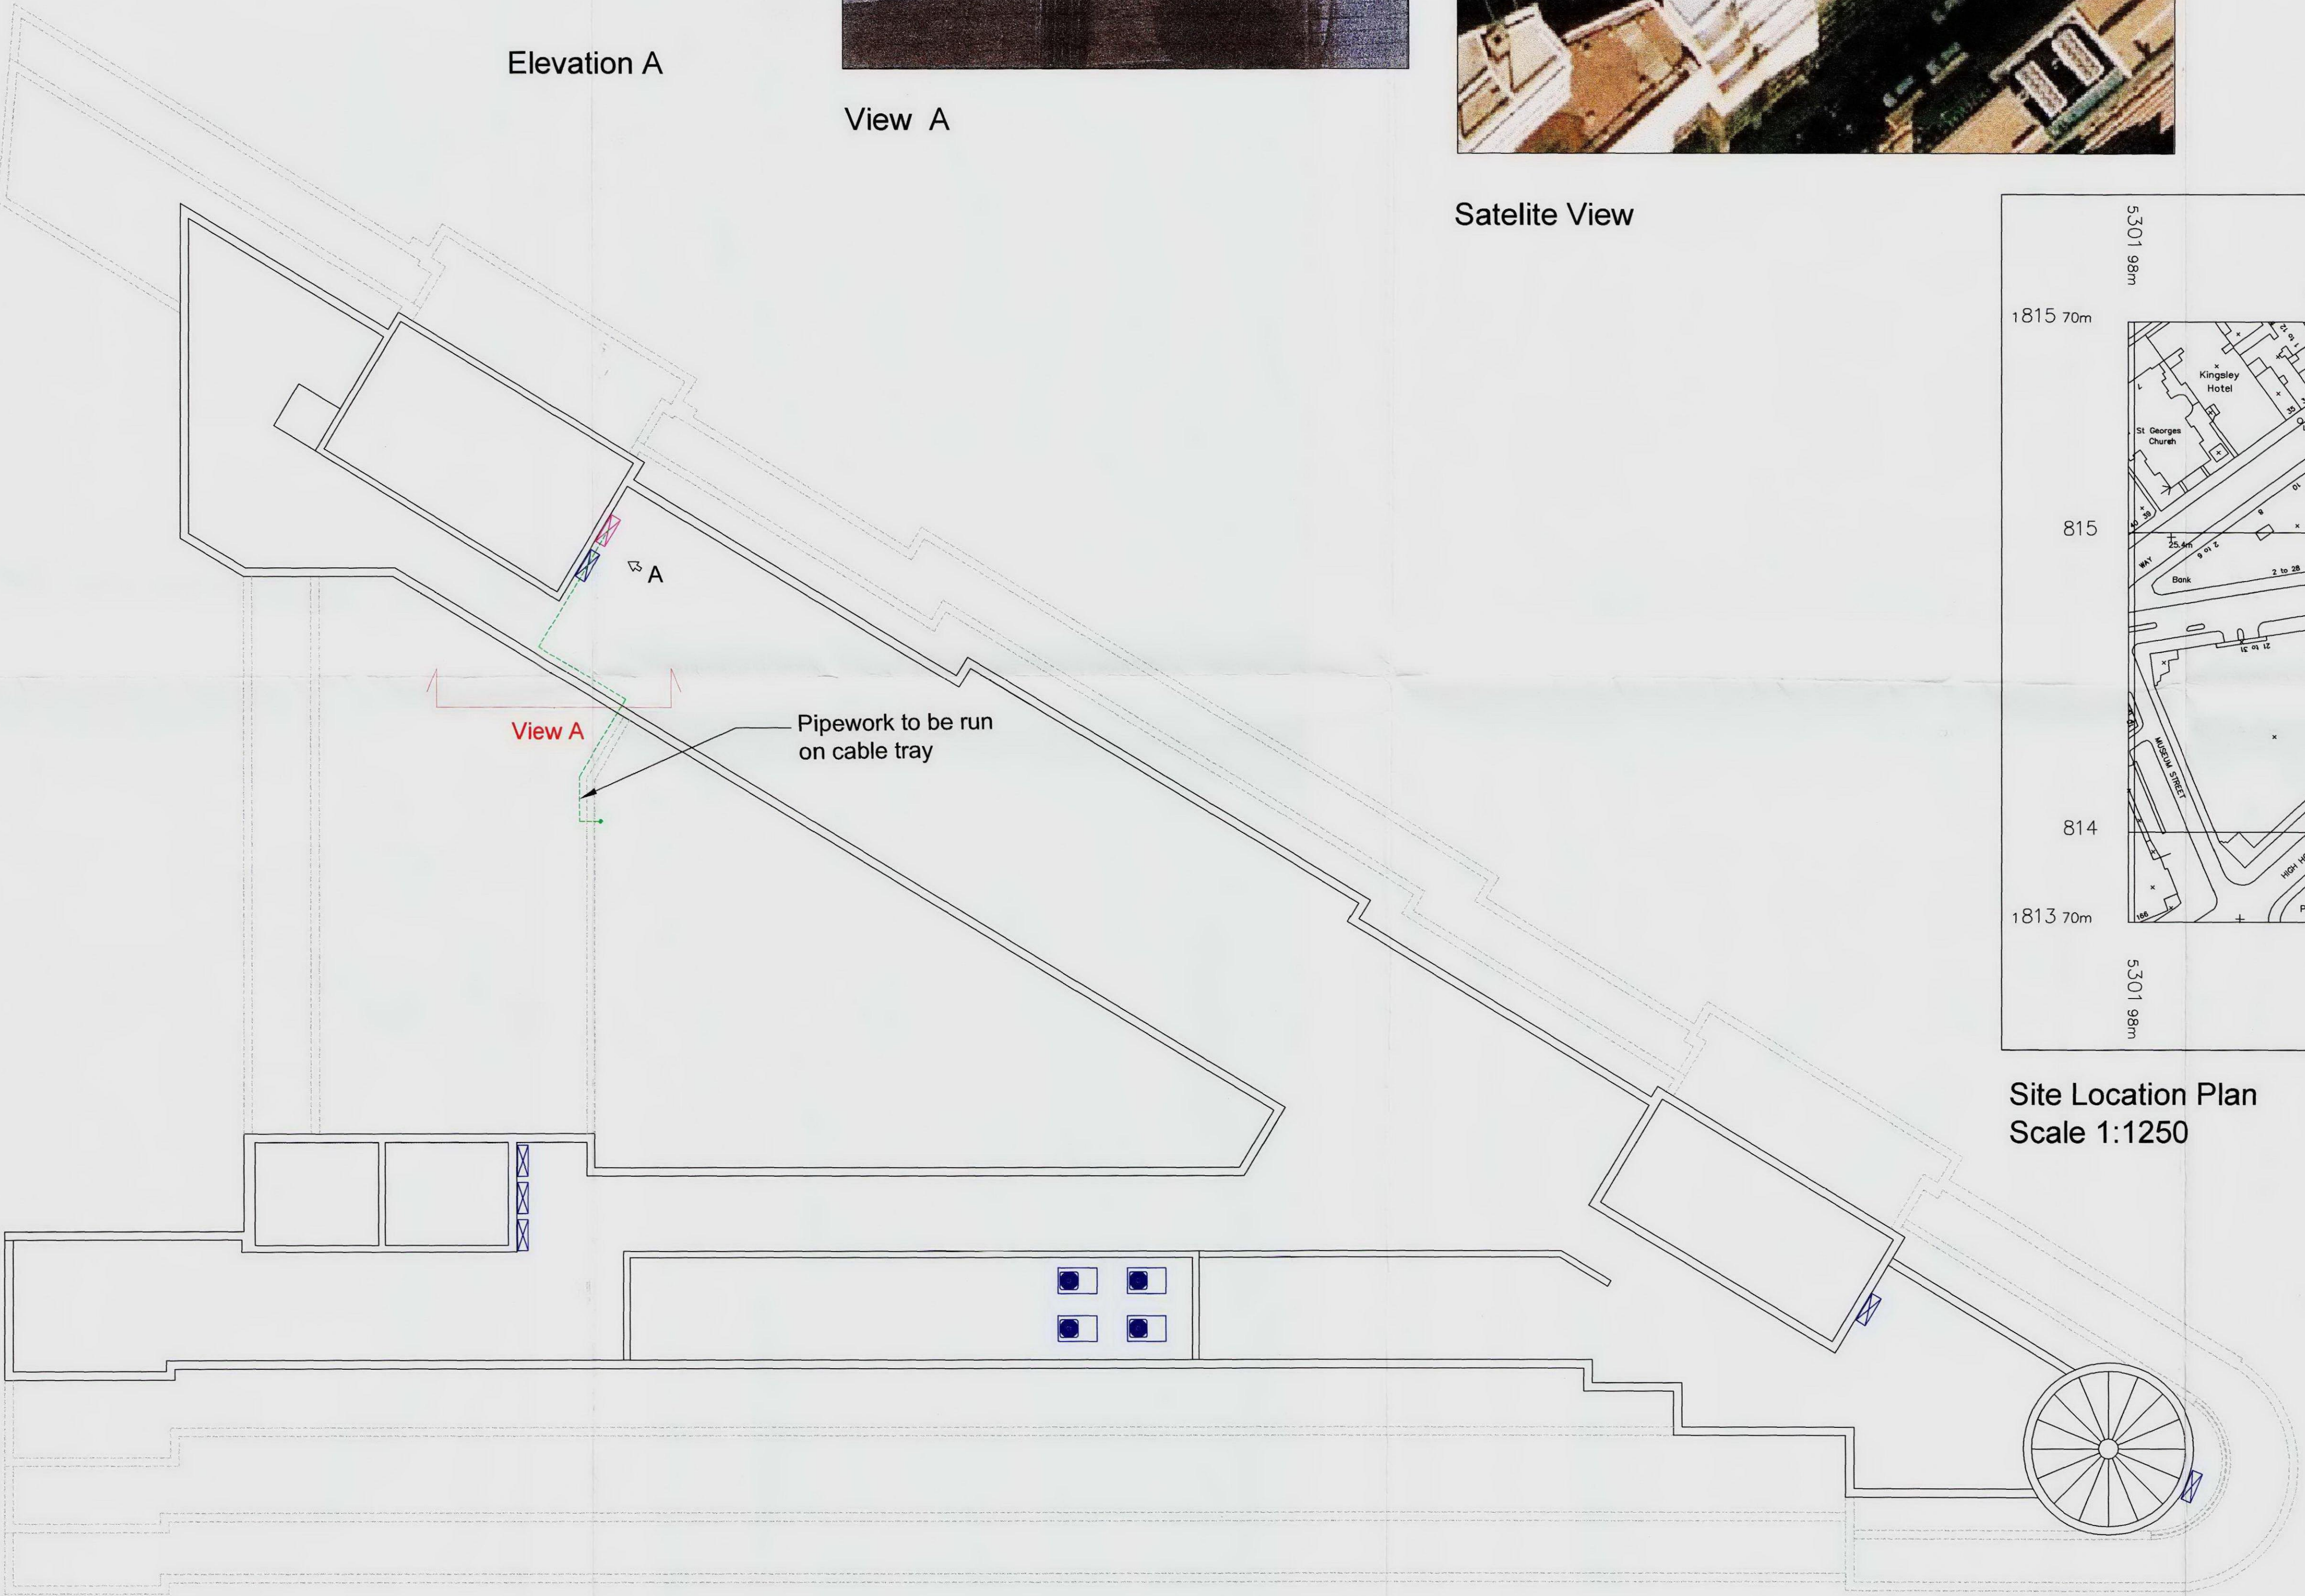

Site Location Plan
Scale 1:1250

A SITE LOCATION PLAN ADDED 10.03.09 J.D
REV DESCRIPTION DATE BY

MorrCo
The Office Fit-out and Relocation Specialist

MorrSpace Ltd
1.09 Bridge House
Three Mills Studios
Three Mill Lane
Bromley-Bow
London E3 3DU
t : +44 (0) 20 8709 8440
f : +44 (0) 20 8709 8441
e : info@morrpace.co.uk

CLIENT

DRAWING PROPOSED ROOF PLAN

PROJECT COMMONWEALTH HOUSE
BUILDING NEW OXFORD STREET
LONDON WC1

JOB No. --- DATE 24.02.09

SCALE 1:100 @A1 CAD REF COMM1-03A

DRG.No. COMM1-03A

Proposed Roof Plan
Scale 1:100 @ A1