


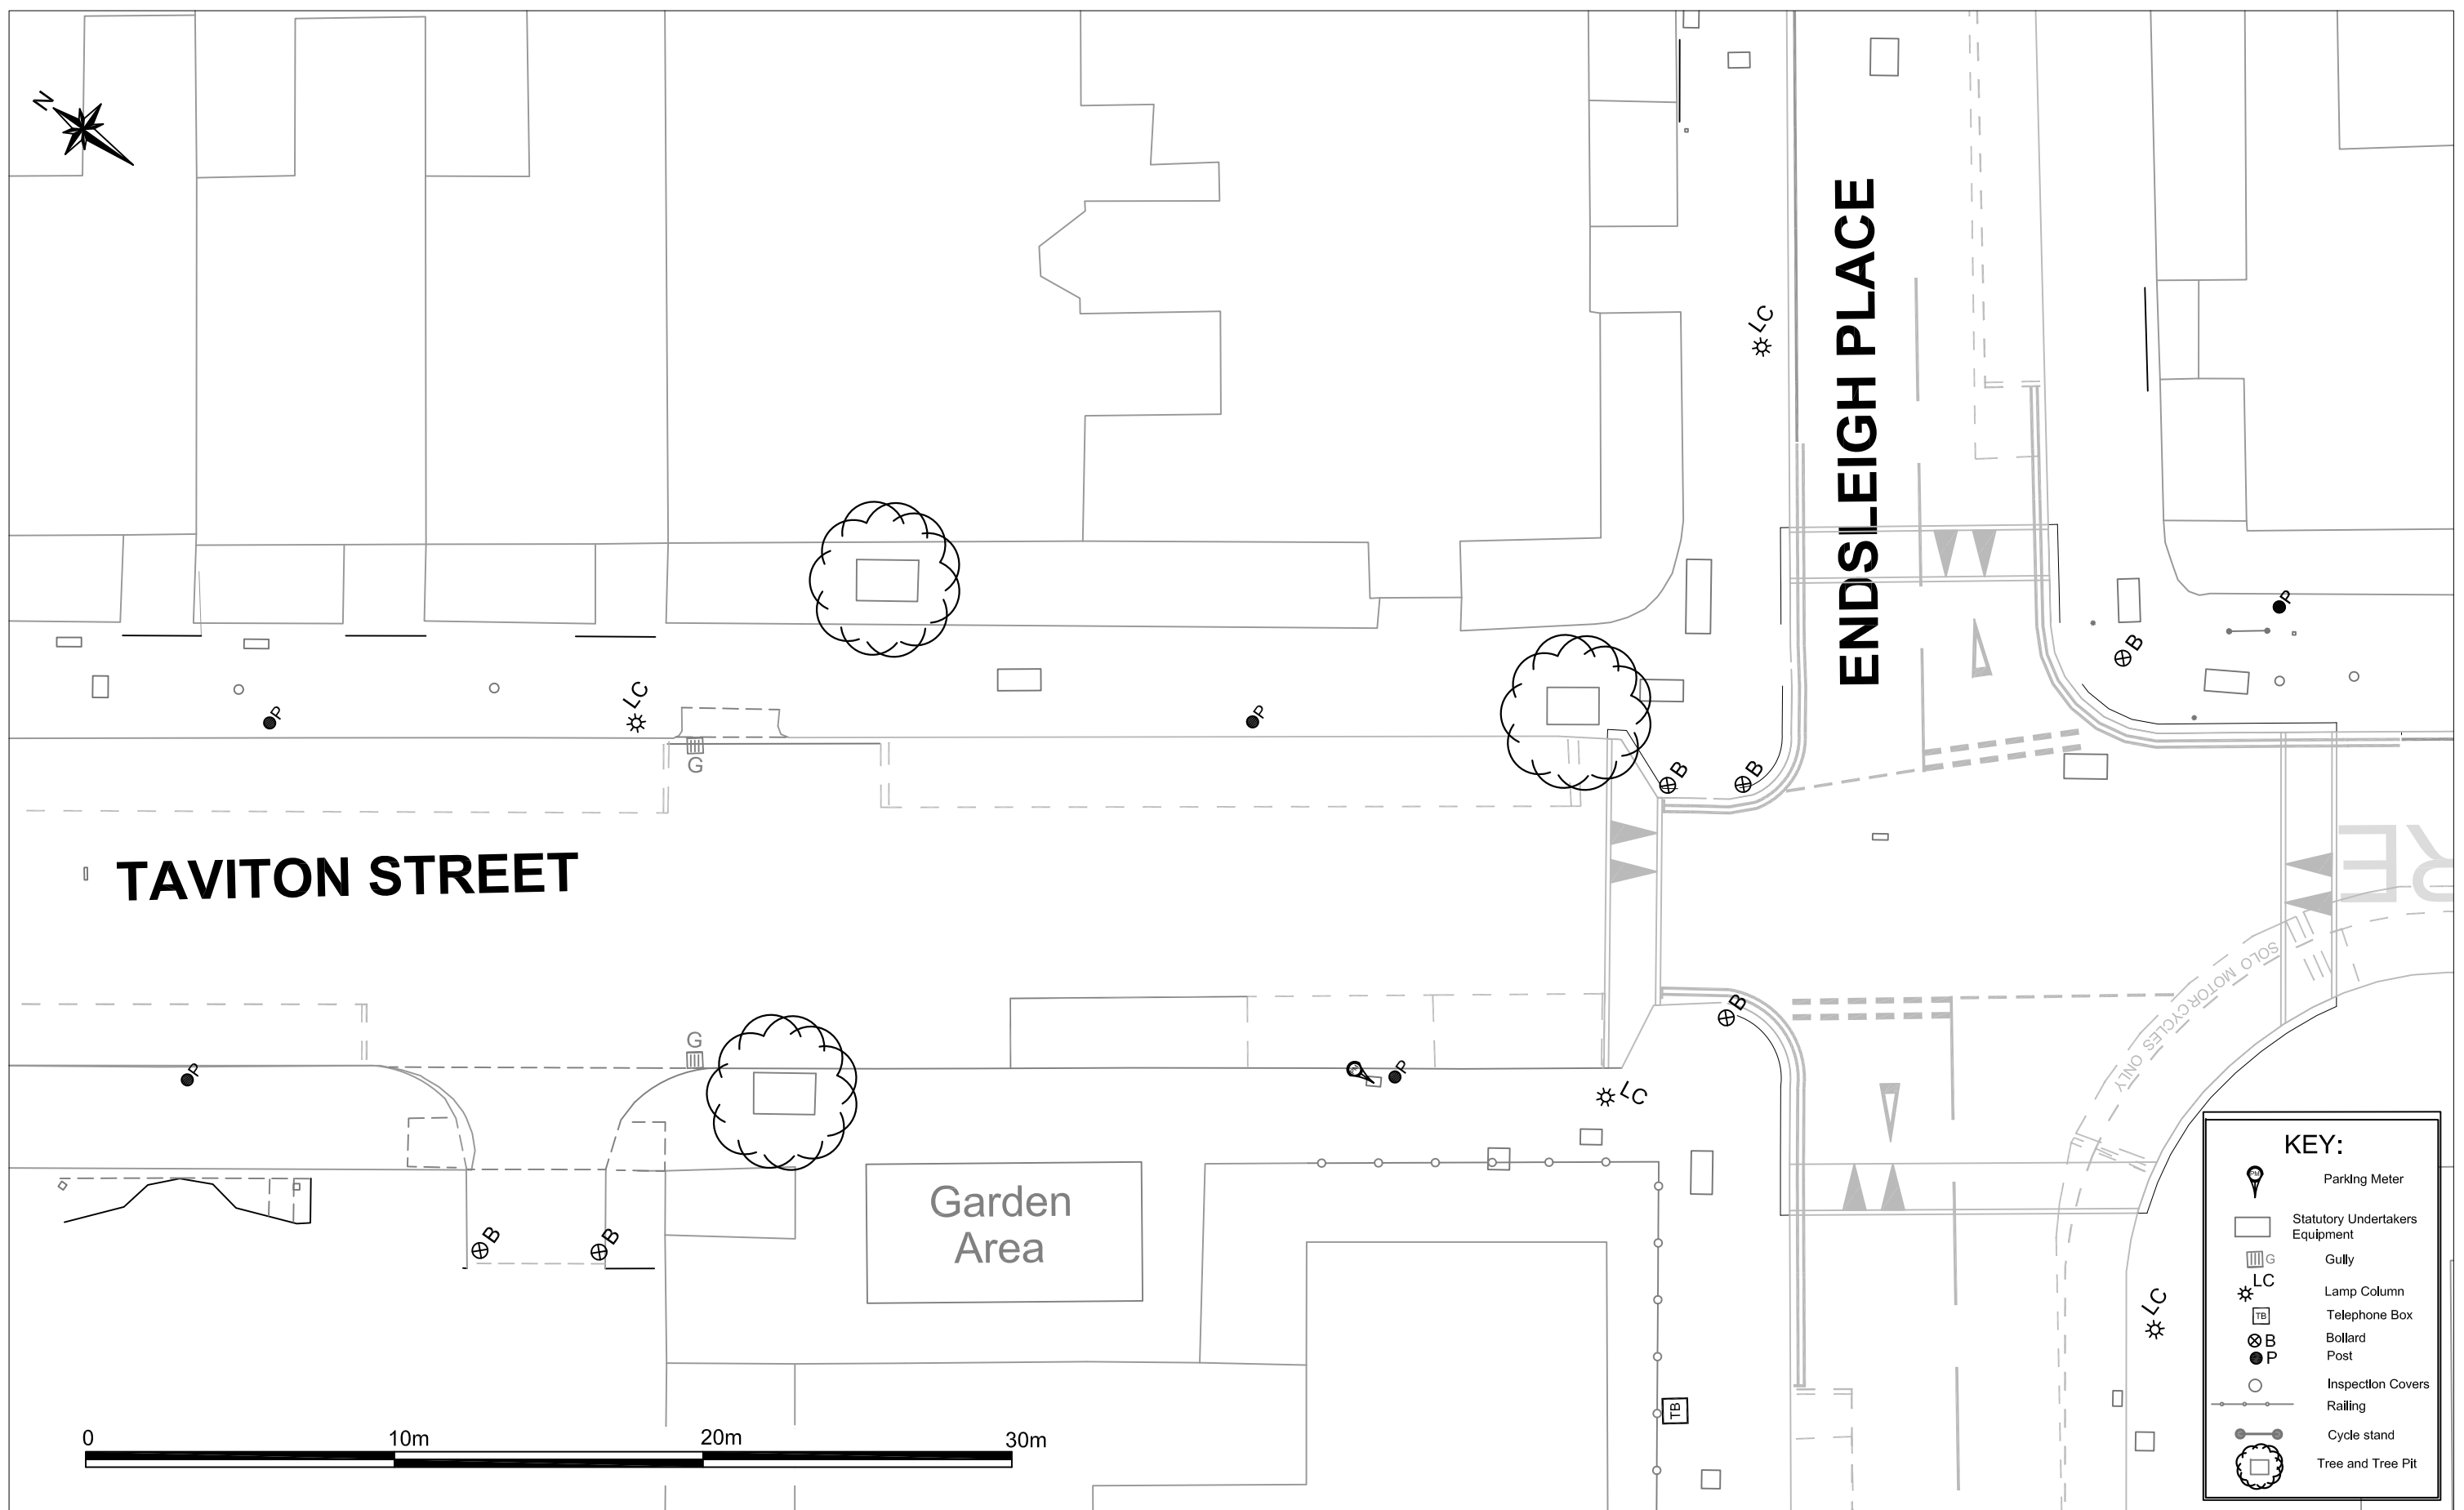

KEY:

Parking Meter

Statutory Undertakers Equipment

Gully

Lamp Column

Telephone Box

Bollard

Post

Inspection Covers

Railing

Cycle stand

Tree and Tree Pit

Engineering Service
London Borough of Camden
Town Hall, Argyle Street
London WC1H 8EQ
Tel 020 7278 4444
Fax 020 7974 6952
DX 2106 Euston
Minicom 020 7974 6866

Awarded for excellence
INVESTOR IN PEOPLE

Project	EXISTING SITE PLAN LONDON CYCLE HIRE SCHEME
Drawing Title	Site 80 Taviton Street

C	J.M.Q	12.06.09	Minor Amendments by TtL
B	R.P.	01.04.09	Minor Amendments by TtL
A	K.B.	27.02.09	Preliminary
Rev	By	Date	Amendments

Scale	1 :200 @ A3	Date	May 09
Drawn By	K.B.	File Ref	TE596PI0080-E
Checked By	J.B	Dwg Name	TE596PI0080-E
Drawing Location	P:\TE\TE596PI0080-E	SFM Ref	02/610245
Drawing Number	TE596PI0080-E	Post Code	WC1
		Rev.	C