


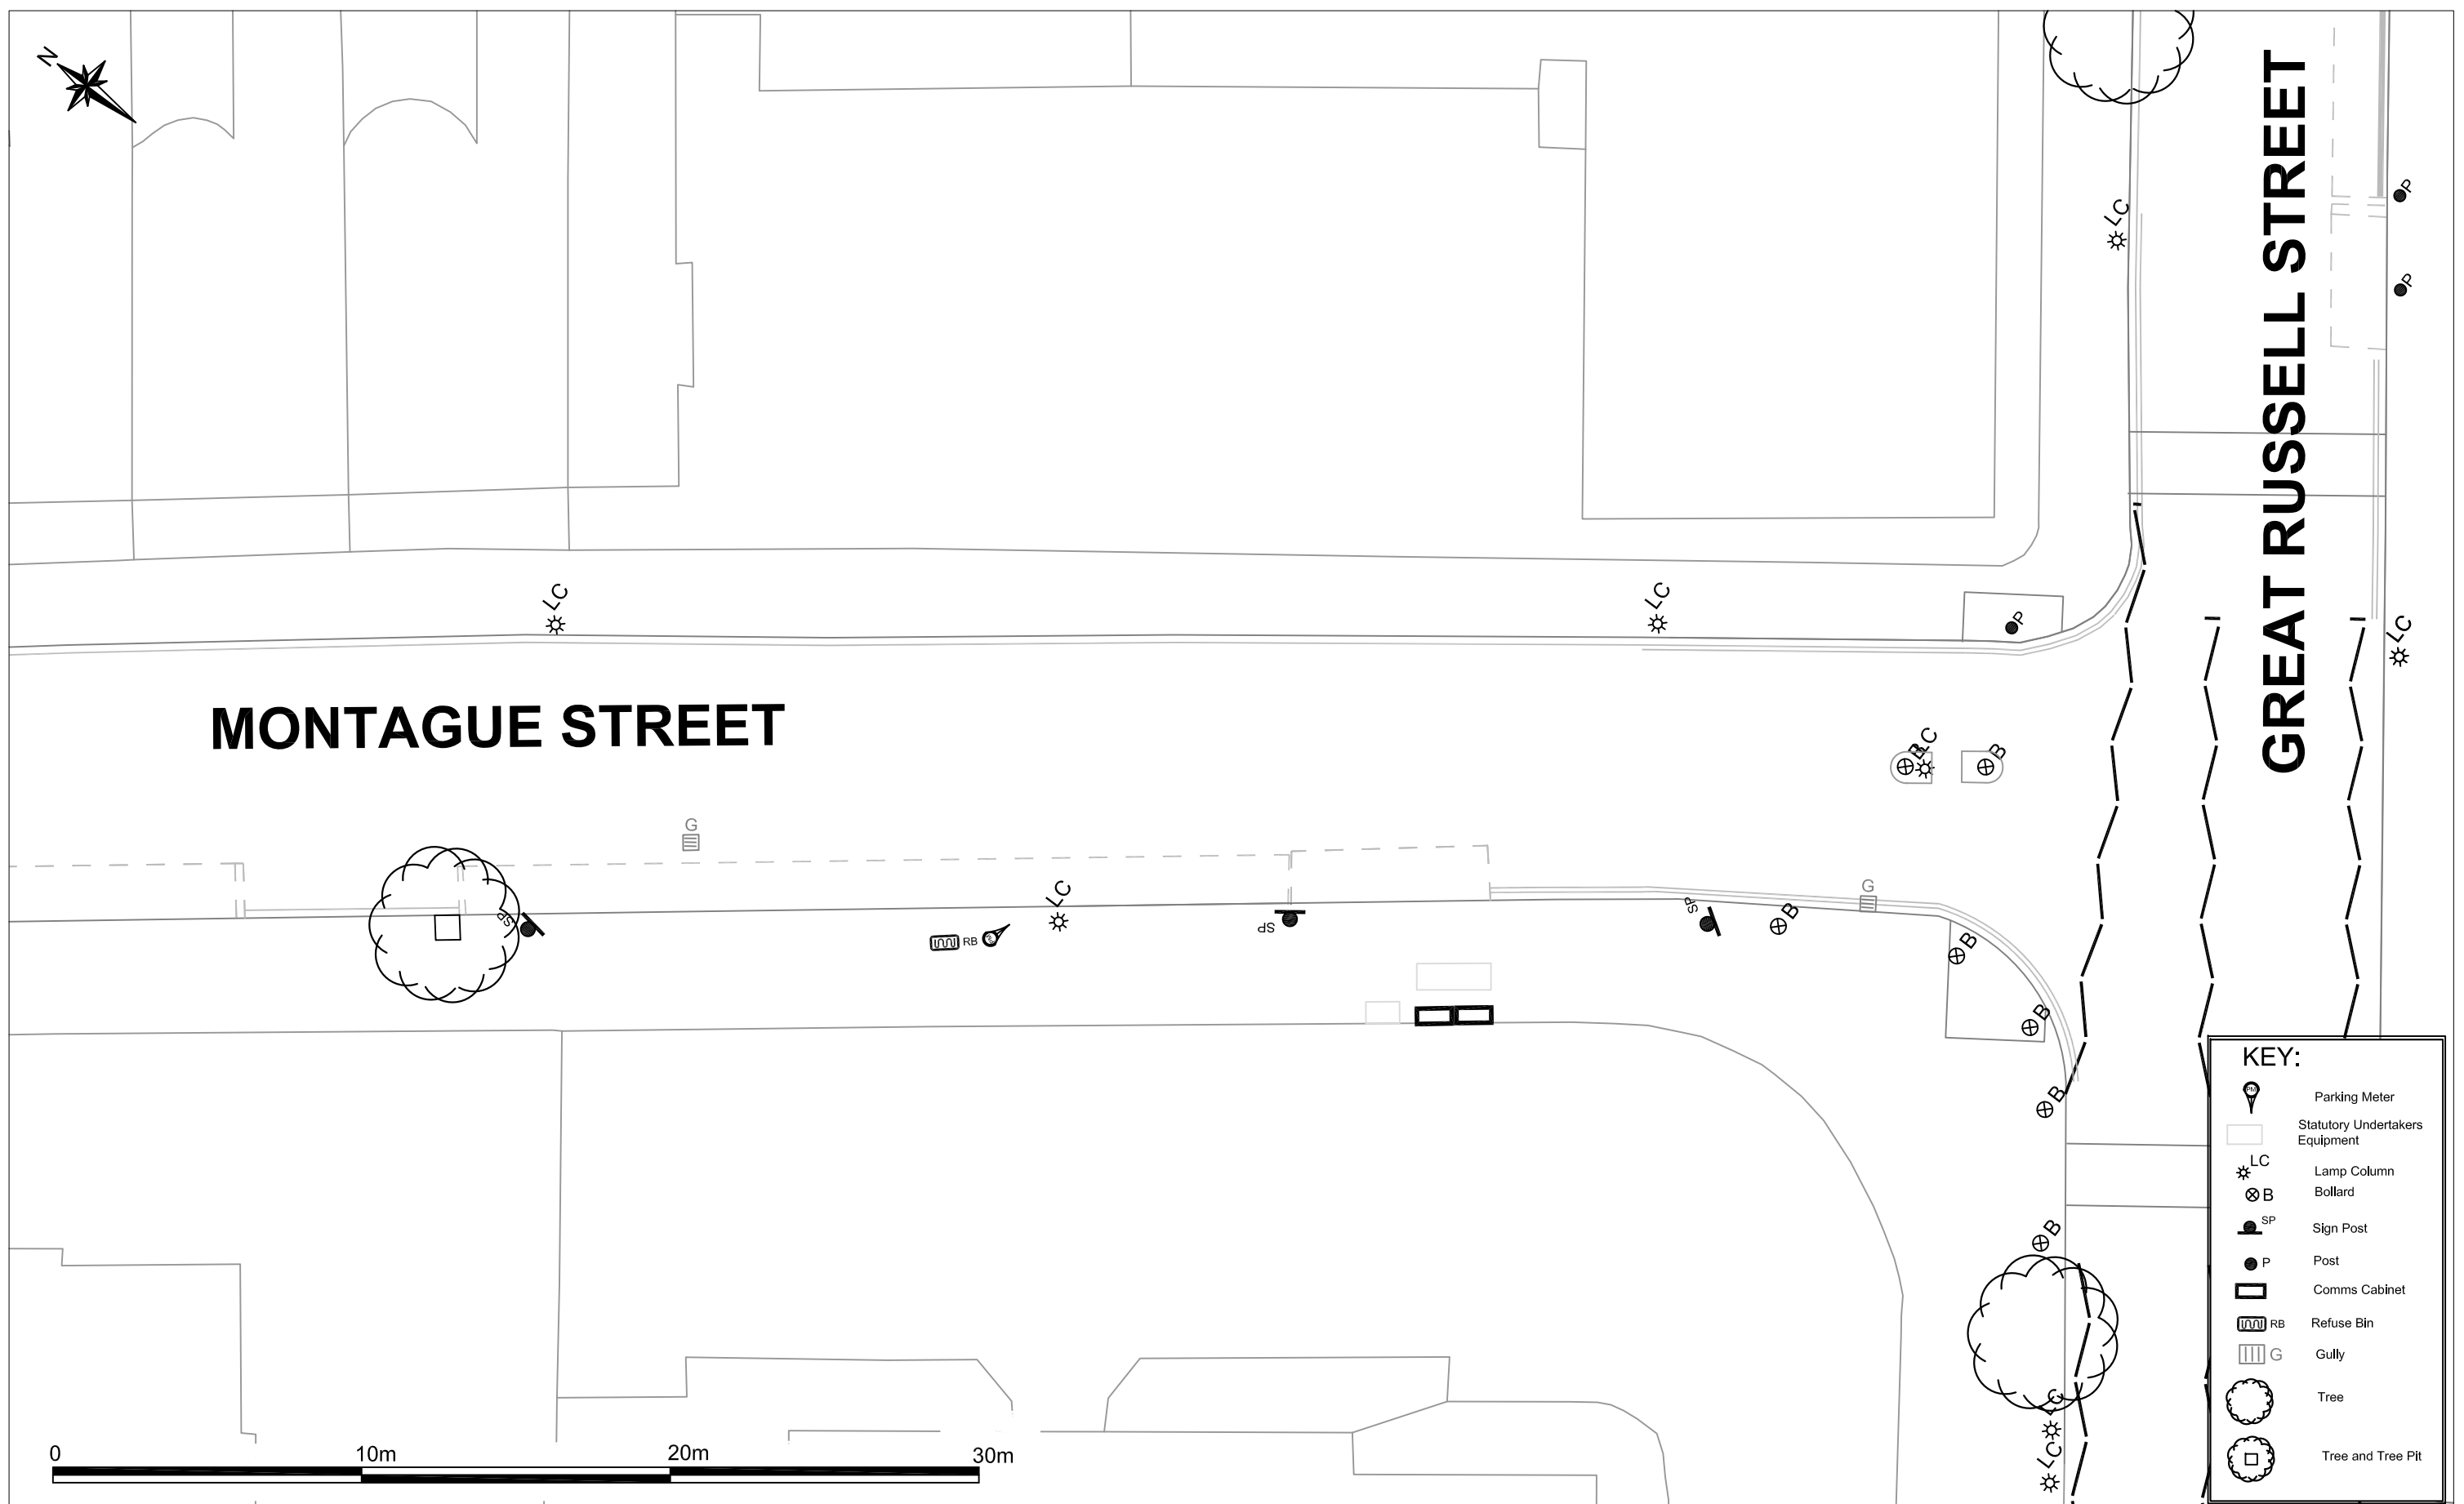

MONTAGUE STREET

GREAT RUSSELL STREET



KEY:

- Parking Meter
- Statutory Undertakers Equipment
- LC Lamp Column
- B Bollard
- SP Sign Post
- P Post
- C Comms Cabinet
- RB Refuse Bin
- G Gully
- Tree
- Tree and Tree Pit

Camden
 Engineering Service
 London Borough of Camden
 Town Hall, Argyle Street
 London WC1H 8EQ
 Tel 020 7278 4444
 Fax 020 7974 6952
 DX 2106 Euston
 Minicom 020 7974 6866



Project
**EXISTING SITE PLAN
 LONDON CYCLE
 HIRE SCHEME**

Drawing Title
**Site 85
 Montague Street**

Rev	By	Date	Amendments
C	J.M.Q	12.06.09	Minor Amendments by TfL
B	R.P.	01.04.09	Minor Amendments by TfL
A	K.B.	27.02.09	Preliminary

Scale	1:200 @ A3
Drawn By	K.B.
Checked By	J.B.
Drawing Location	P:\TE\TE596PI0085-E
Drawing Number	TE596PI0085-E

Date	May 09
File Ref	TE596PI0085-E
Dwg Name	TE596PI0085-E
SFM Ref	02/610248
Post Code	WC1
Rev.	C