


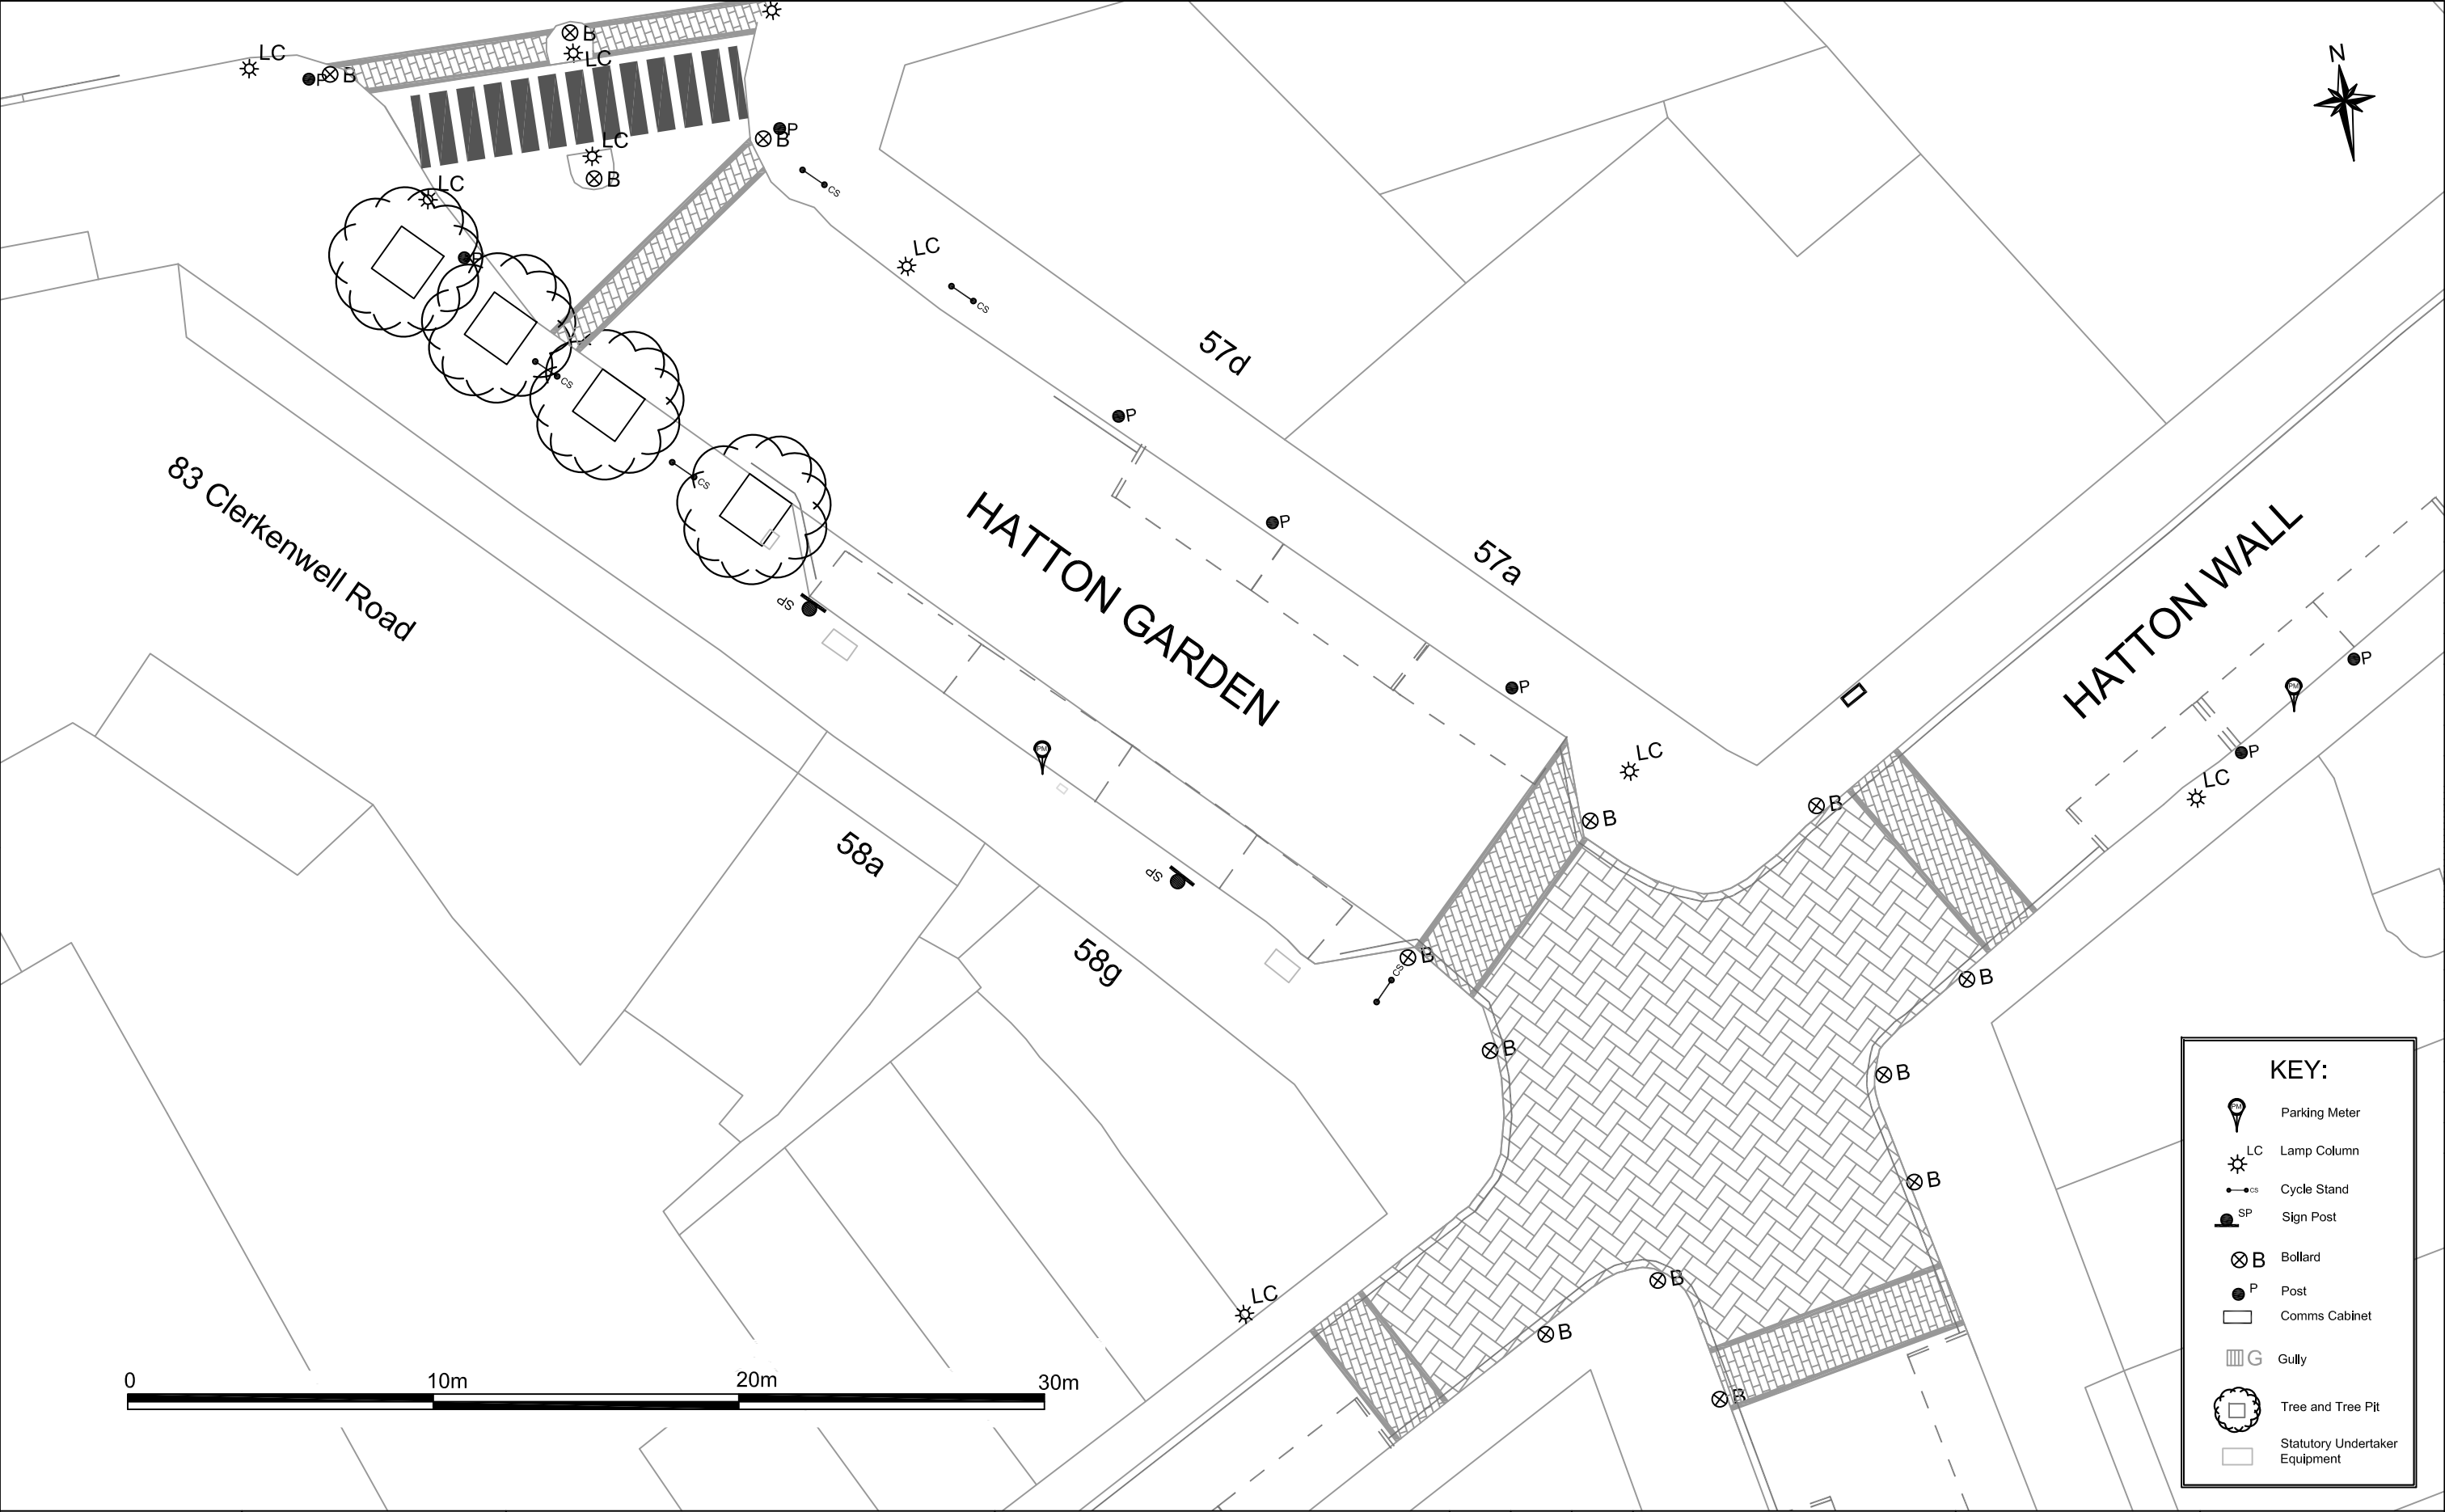

KEY:

Parking Meter

Lamp Column

Cycle Stand

Sign Post

Bollard

Post

Comms Cabinet

Gully

Tree and Tree Pit

Statutory Undertaker Equipment

Engineering Service
London Borough of Camden
Town Hall, Argyle Street
London WC1H 8EQ
Tel 020 7278 4444
Fax 020 7974 6952
DX 2106 Euston
Minicom 020 7974 6866

INVESTOR IN PEOPLE

Project

EXISTING SITE PLAN
LONDON CYCLE
HIRE SCHEME

Drawing Title

Site 42
Hatton Garden

C	J.M.Q	12/06/09	Minor Amendments by TfL
B	R.P.	26.03.09	Minor Amendments by TfL
A	K.B.	27.02.09	Preliminary
Rev	By	Date	Amendments

Scale	1 :200 @ A3	Date	May 09
Drawn By	K.B.	File Ref	TE596PI044-E
Checked By	J.B	Dwg Name	TE596PI044-E.dwg
Drawing Location	P:\TE\TE596PI044-E	SFM Ref	02/610223
Drawing Number	TE596PI044-E	Post Code	EC1
		Rev.	C