



Judd Street

Wakefield Street

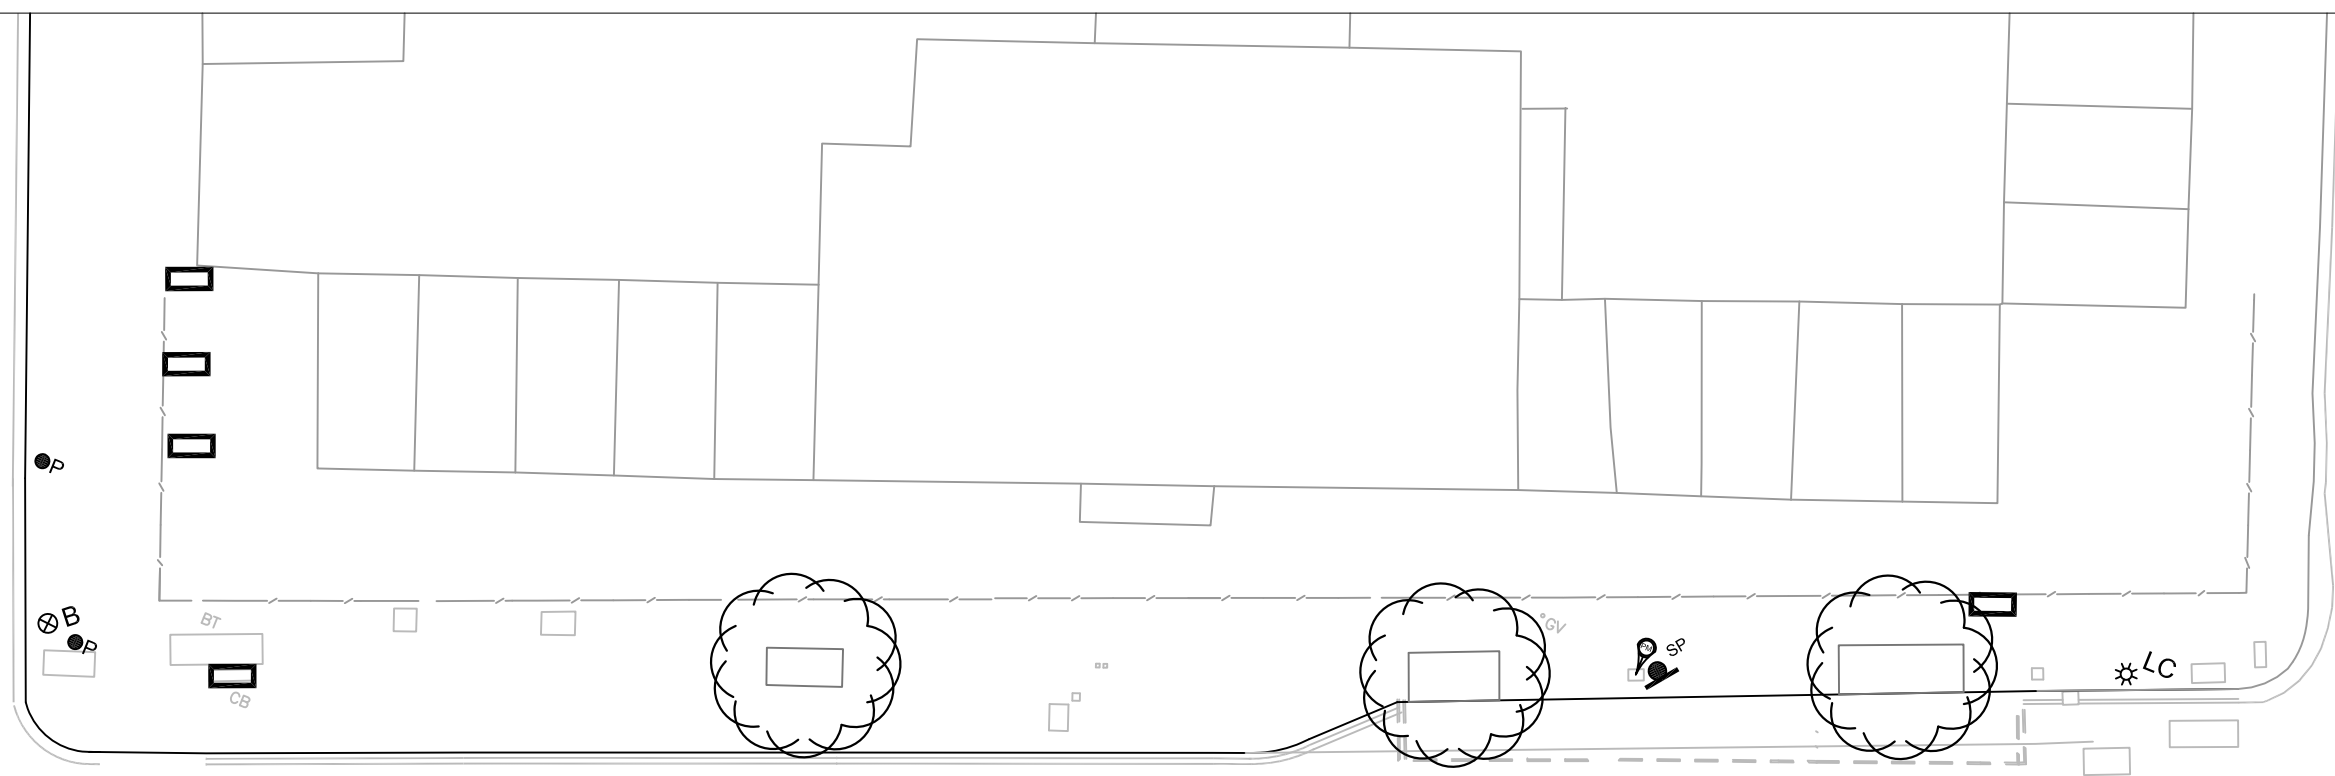

Tavistock Place

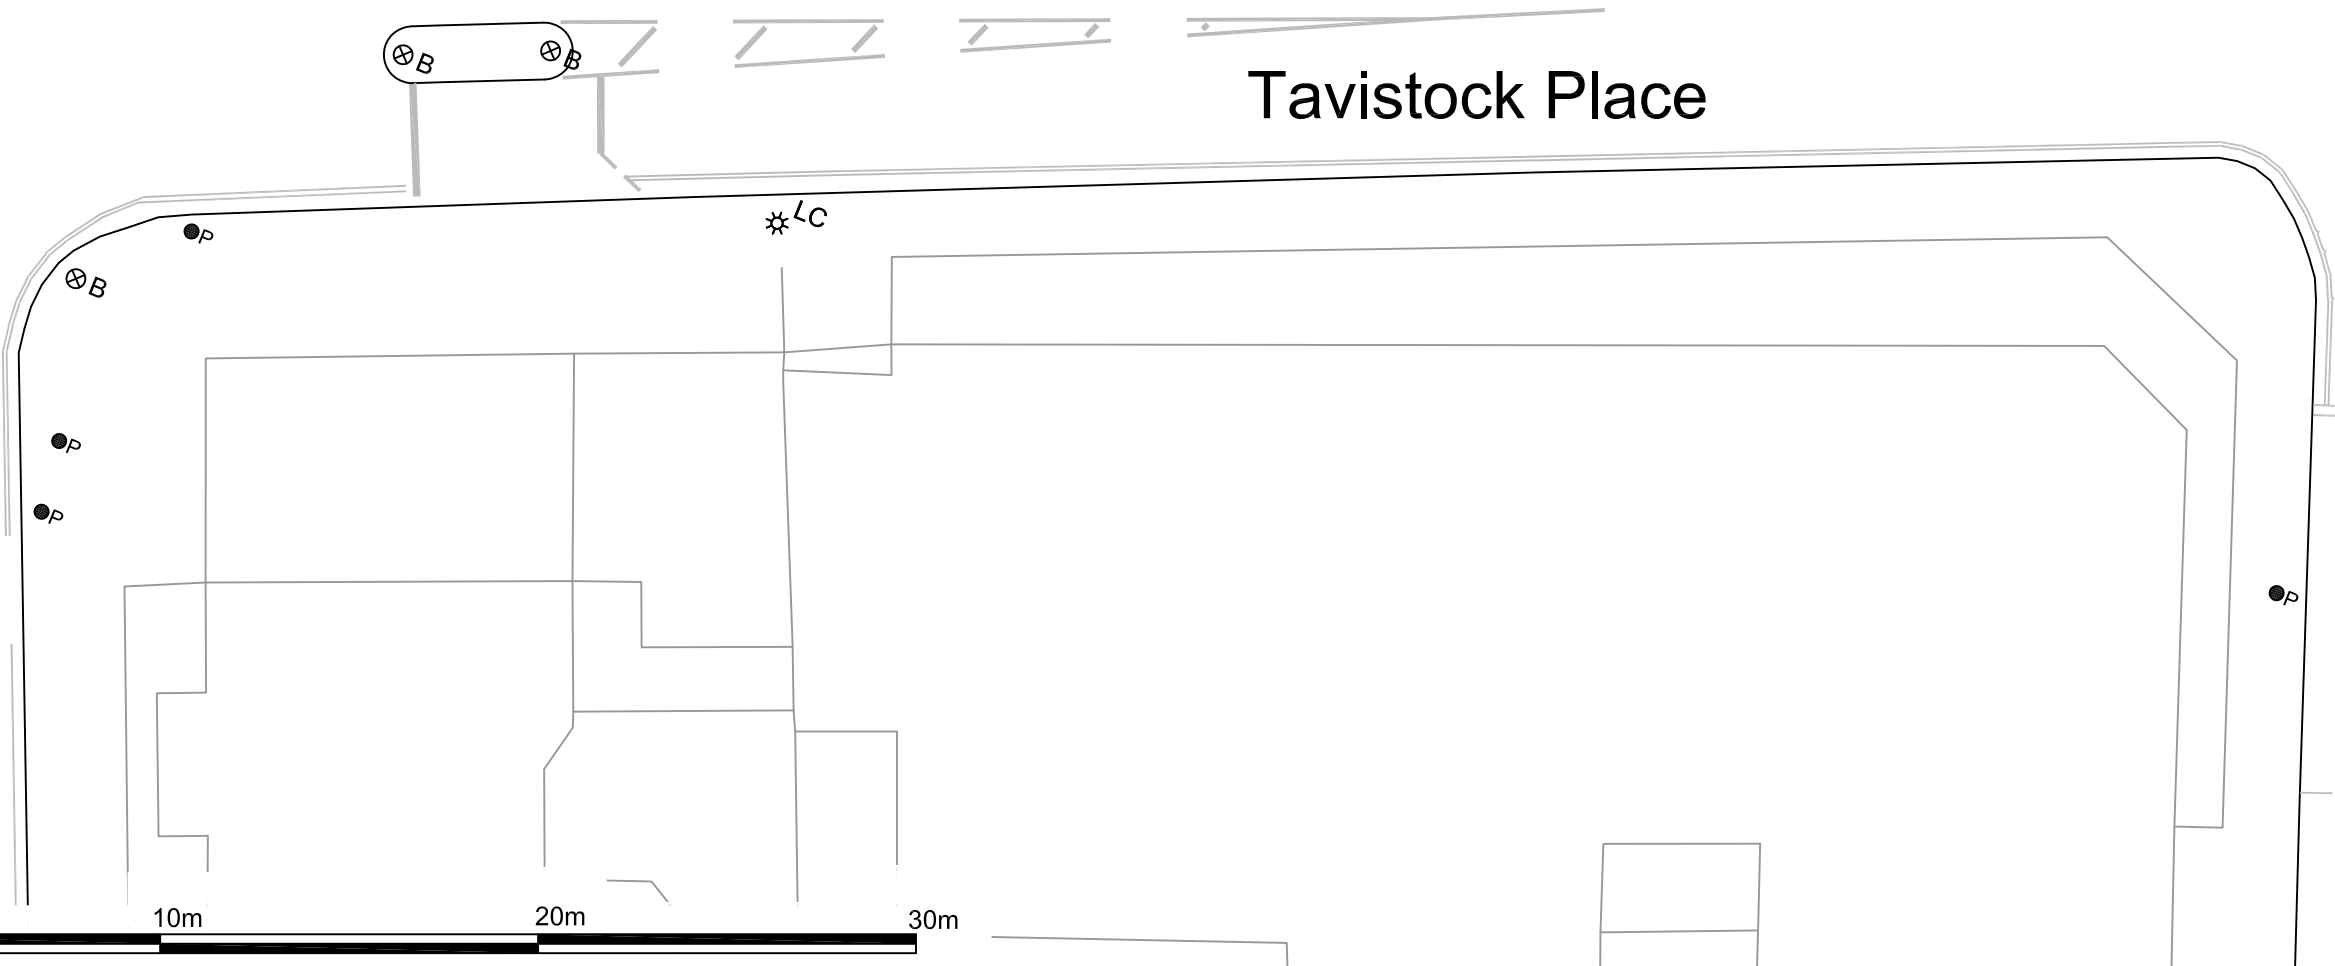

KEY:

- Parking Meter
- Lamp Column
- Sign Post
- Bollard
- Post
- Comms. Cabinet
- Statutory Undertakers Equipment
- Tree and Tree Pit

Camden
 Engineering Service
 London Borough of Camden
 Town Hall, Argyle Street
 London WC1H 8EQ
 Tel 020 7278 4444
 Fax 020 7974 6952
 DX 2106 Euston
 Minicom 020 7974 6866



Project
**EXISTING SITE PLAN
 LONDON CYCLE HIRE SCHEME**

Drawing Title
**Site 98
 Tavistock Place**

Rev	By	Date	Amendments
B	R.P.	01.04.09	Minor Amendments by TTL
A	K.B.	27.02.09	Preliminary

Scale 1:200 @ A3	Date Feb 09
Drawn By K.B.	File Ref TE596PI0098-E
Checked By J.B.	Dwg Name TE596PI0098-E
Drawing Location P:\TE\TE596PI0098-E	SFM Ref 02/610254
Drawing Number TE596PI0098-E	Post Code WC1
	Rev. B