


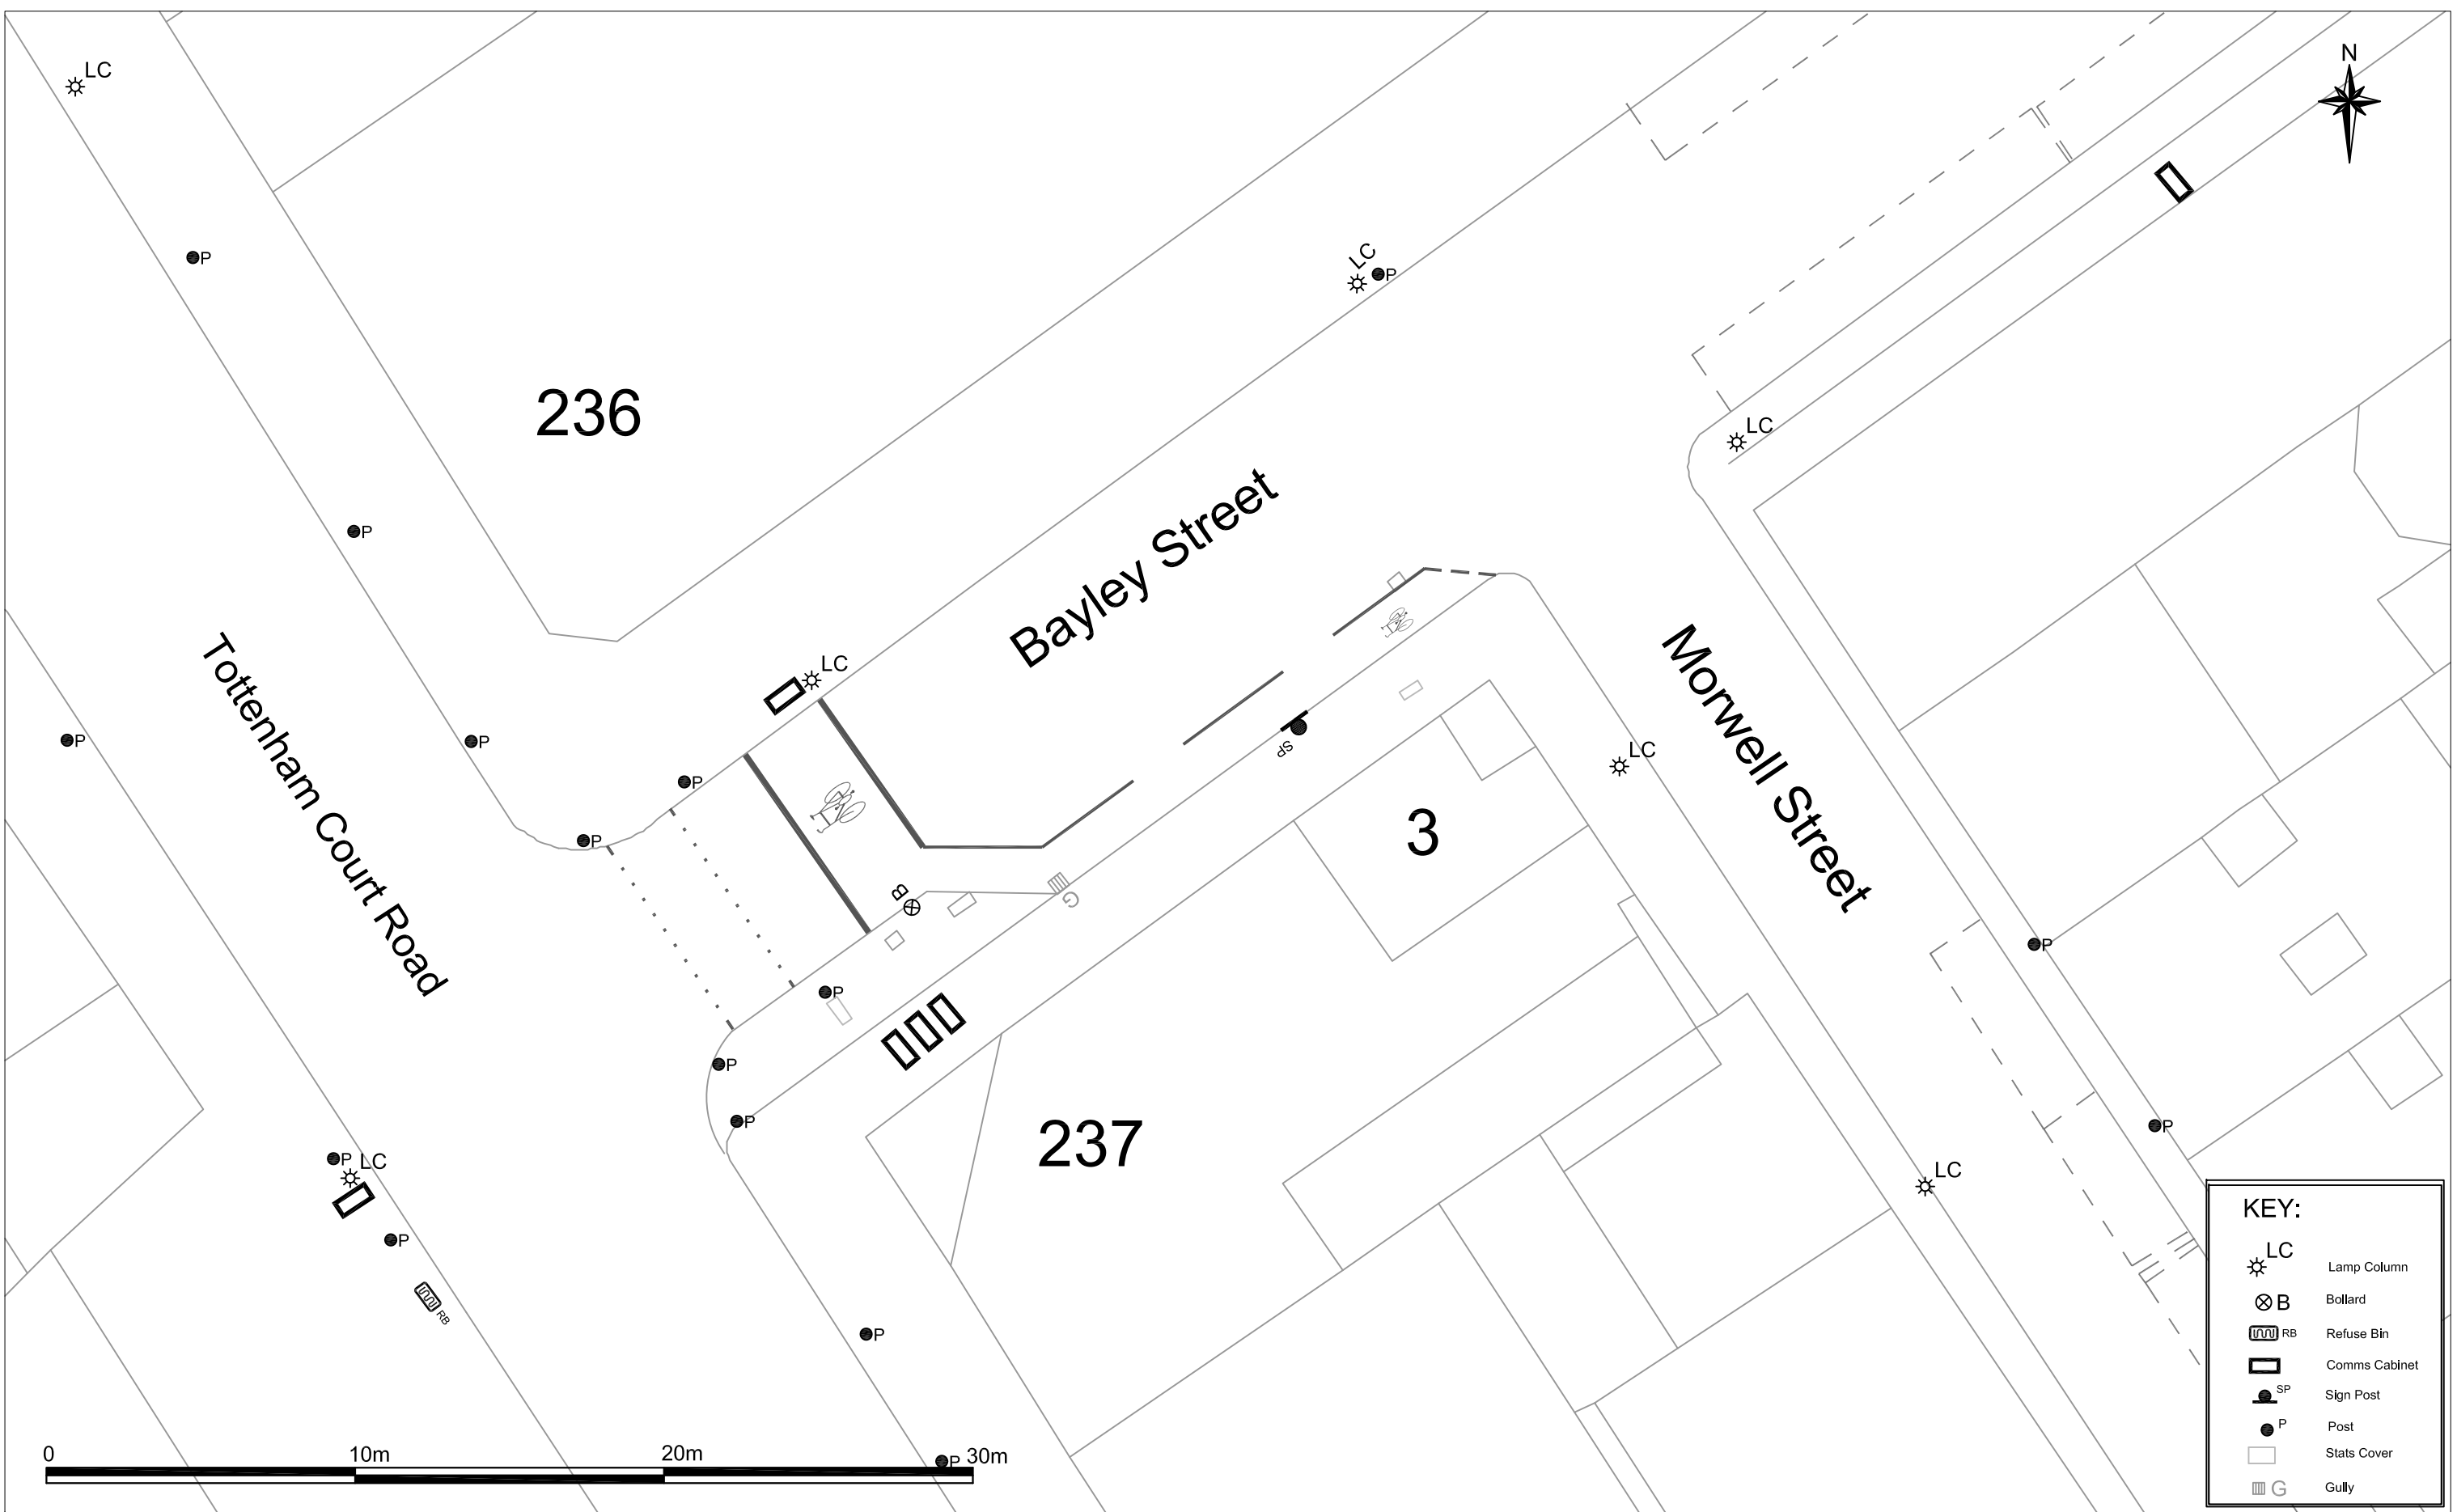

KEY:

LC

Lamp Column

B

Bollard

RB

Refuse Bin

Comms Cabinet

SP

Sign Post

P

Post

Stats Cover

G

Gully

Engineering Service  
London Borough of Camden  
Town Hall, Argyle Street  
London WC1H 8EQ  
Tel 020 7278 4444  
Fax 020 7974 6952  
DX 2106 Euston  
Minicom 020 7974 6866

Awarded for excellence INVESTOR IN PEOPLE

|               |                                                   |
|---------------|---------------------------------------------------|
| Project       | EXISTING SITE PLAN<br>LONDON CYCLE<br>HIRE SCHEME |
| Drawing Title | Site 15<br>Bayley Street                          |

|     |      |          |                          |
|-----|------|----------|--------------------------|
|     |      |          |                          |
|     |      |          |                          |
|     |      |          |                          |
|     |      |          |                          |
| B   | R.P. | 01.04.09 | Minor Ammendments by TfL |
| A   | K.B. | 27.02.09 | Preliminary              |
| Rev | By   | Date     | Amendments               |

|                  |                     |           |                   |
|------------------|---------------------|-----------|-------------------|
| Scale            | 1 :200 @ A3         | Date      | Feb 09            |
| Drawn By         | W.O                 | File Ref  | TE596PI0015-E     |
| Checked By       | J.B                 | Dwg Name  | TE596PI0015-E.dwg |
| Drawing Location | P:\TE\TE596PI0015-E | SFM Ref   | 02/610215         |
| Drawing Number   | TE596PI0015-E       | Post Code | W1                |
|                  |                     | Rev.      | B                 |