


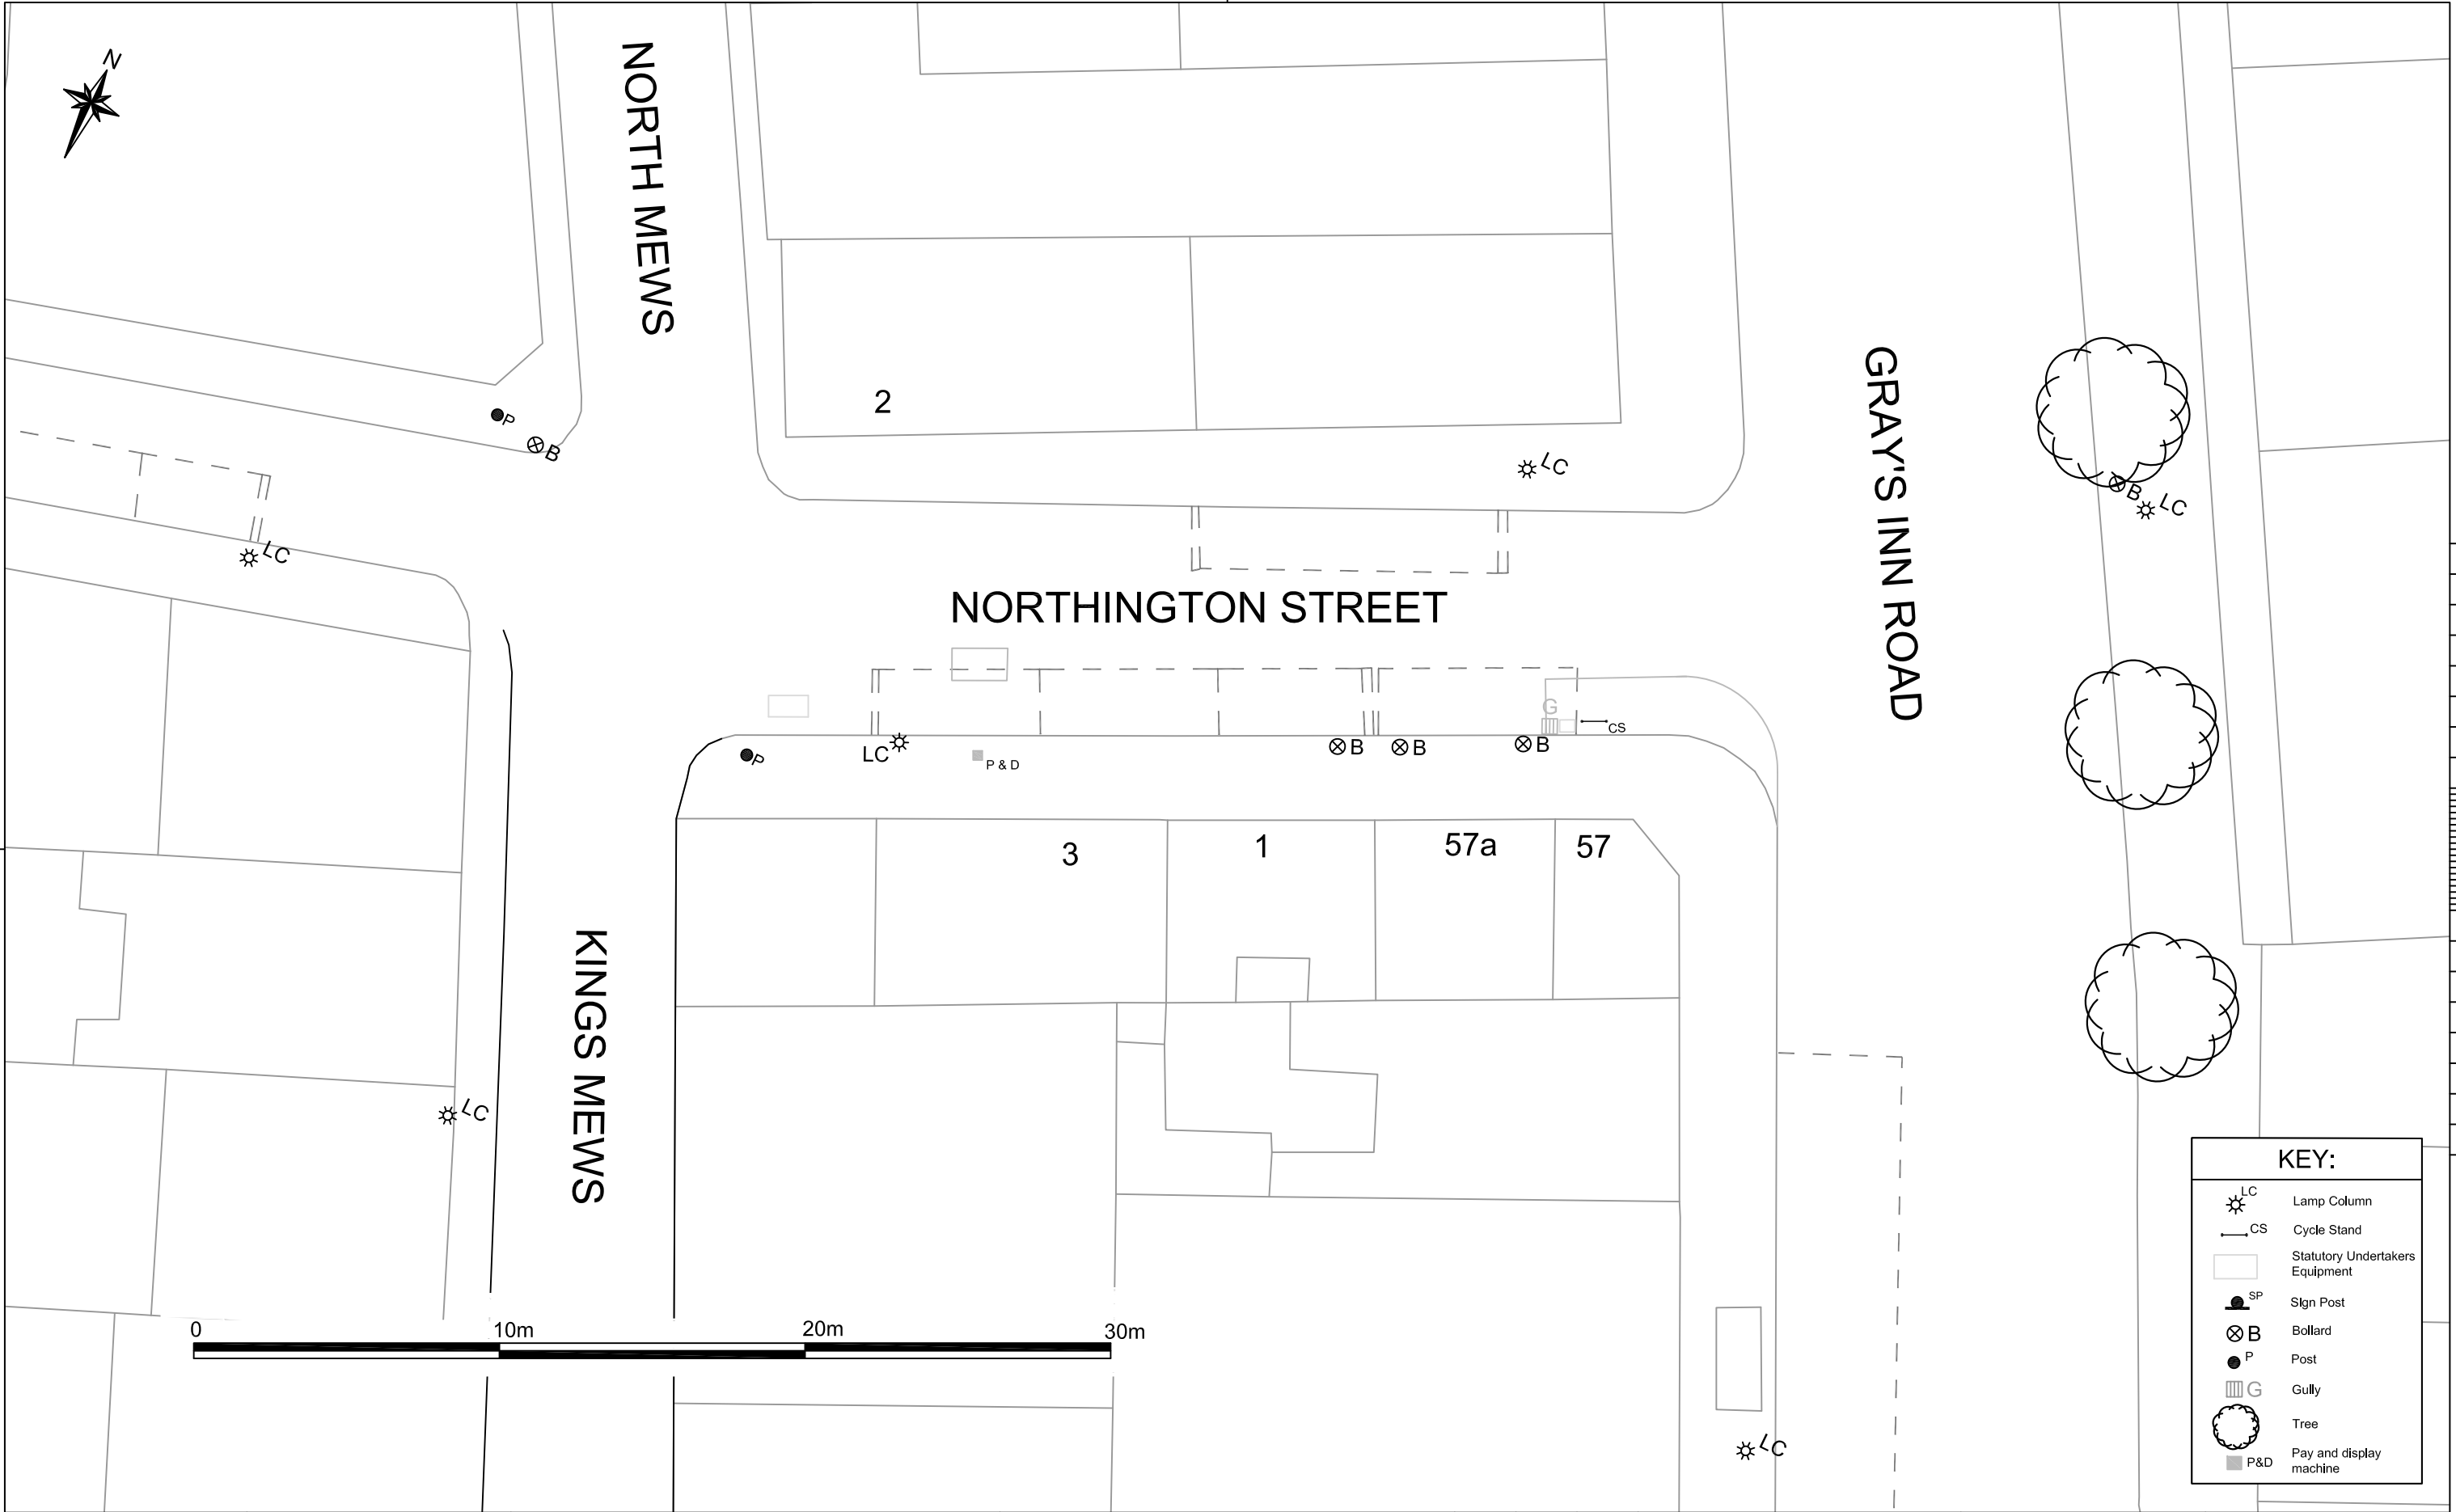

KEY:


LC

Lamp Column


CS

Cycle Stand



Statutory Undertakers Equipment


SP

Sign Post


B

Bollard


P

Post


G

Gully



Tree


P&D

Pay and display machine

**Camden**
Engineering Service
London Borough of Camden
Town Hall, Argyle Street
London WC1H 8EQ
Tel 020 7278 4444
Fax 020 7974 6952
DX 2106 Euston
Minicom 020 7974 6866


Awarded for excellence INVESTOR IN PEOPLE

Project
EXISTING SITE PLAN
LONDON CYCLE
HIRE SCHEME

Drawing Title
Site39
Northmington Street

B	R.P.	26.03.09	Minor Amendments by TIL
A	K.B.	27.02.09	Preliminary
Rev	By	Date	Amendments

Scale 1 :200 @ A3	Date Feb 09
Drawn By K.B.	File Ref TE596PI039-1
Checked By J.B	Dwg Name TE596PI039-1.dwg
Drawing Location P:\TE\TE596PI039-1	SFM Ref 02/610222
Drawing Number TE596PI039-1	Post Code WC1
	Rev. B