


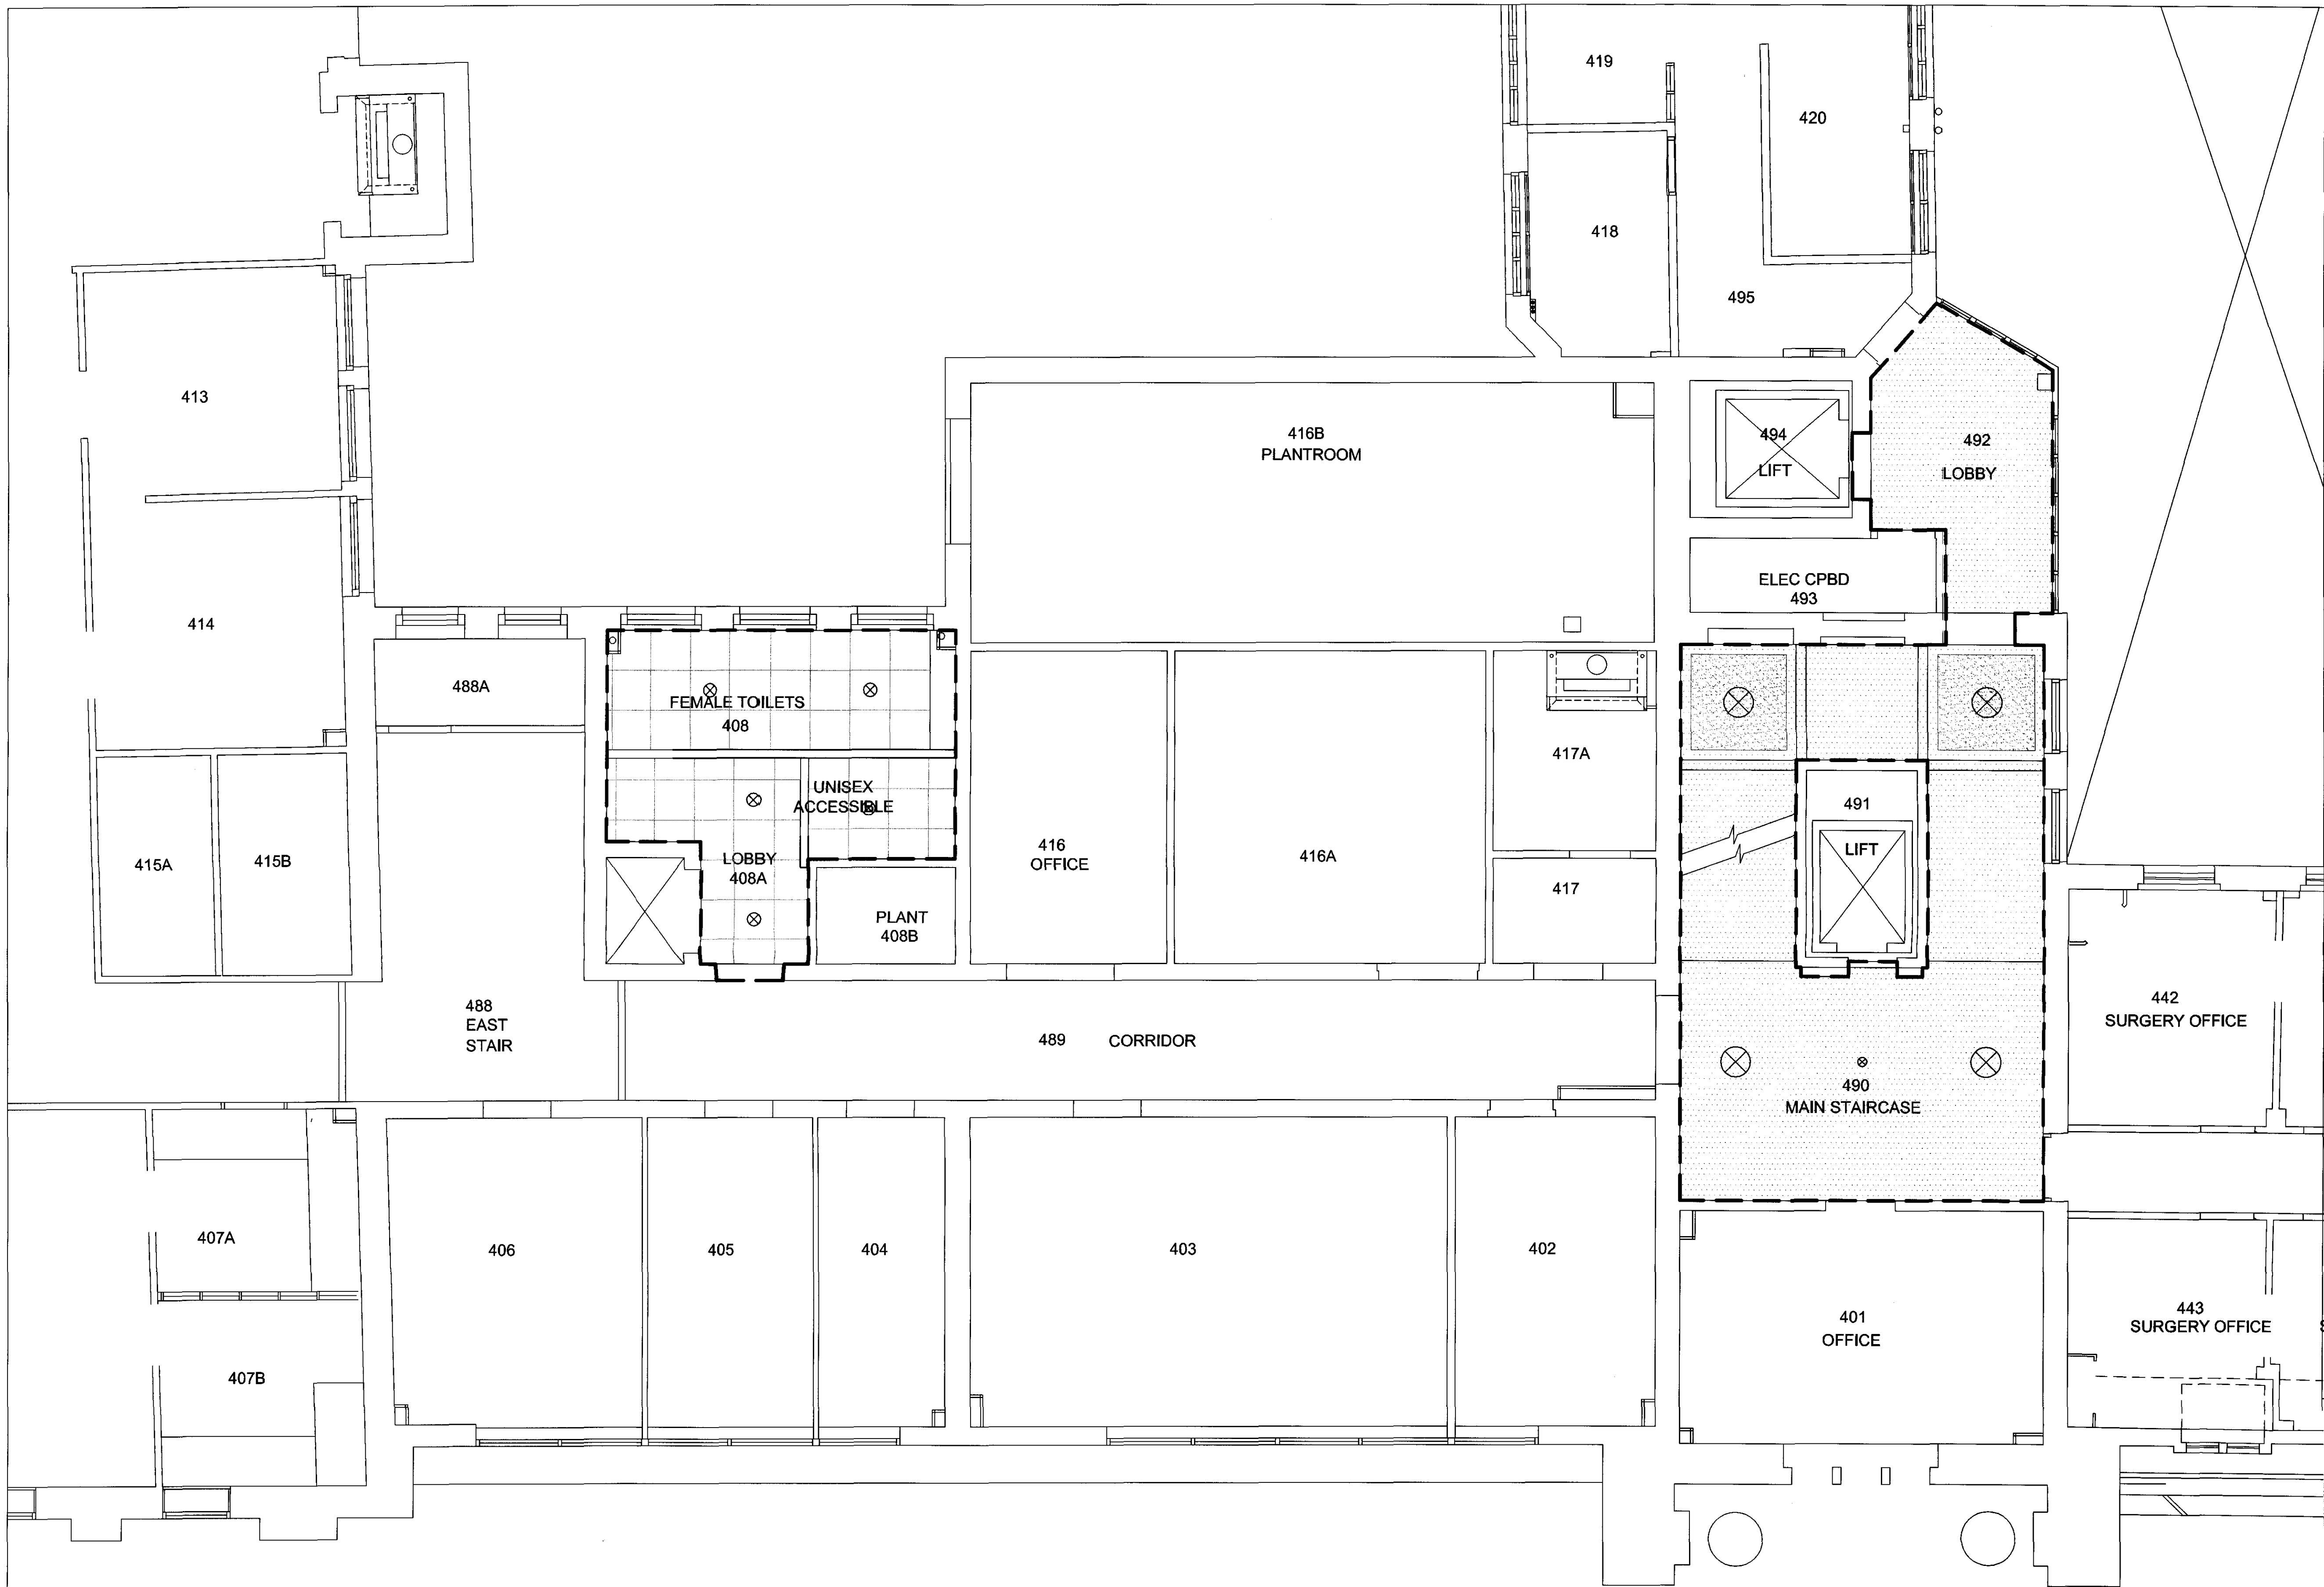

NOTES
DO NOT SCALE OFF THIS DRAWING.
ALL DIMENSIONS MUST BE CHECKED ON SITE
PRIOR TO ANY WORK BEING PUT IN HAND.
ANY DISCREPANCIES ARE TO BE BROUGHT TO
THE ATTENTION OF THE PROJECT MANAGER
IMMEDIATELY UPON DISCOVERY.

- Key**
- Extent of refurbishment works
 - New Suspended Grid
 - Plastered re-painted soffit
 - New suspended plasterboard painted
 - New Light Fitting
 - + 3.0m Suspended Ceiling Level

PLANNING APPLICATION

P	25.03.09	Issued for Planning & Listed Building
Rev.	Date	Description

UCL
University College London
1-19, Torrington Place, London WC1E 7HB
Project Officer : Naweed Khan
Tel : 020 7679 1226
Fax : 020 7813 0524
Email : @ucl.ac.uk
Drawn: N.K.
Date: Feb 2009
Scale: 1:50 @ A1
PROJECT No. 201/032

201 ROCKEFELLER BUILDING

Common Areas Refurbishment

**Fourth Floor Reflected Ceiling Plan
As Proposed**

DWG. NO. **201032-156** **P**
rev