



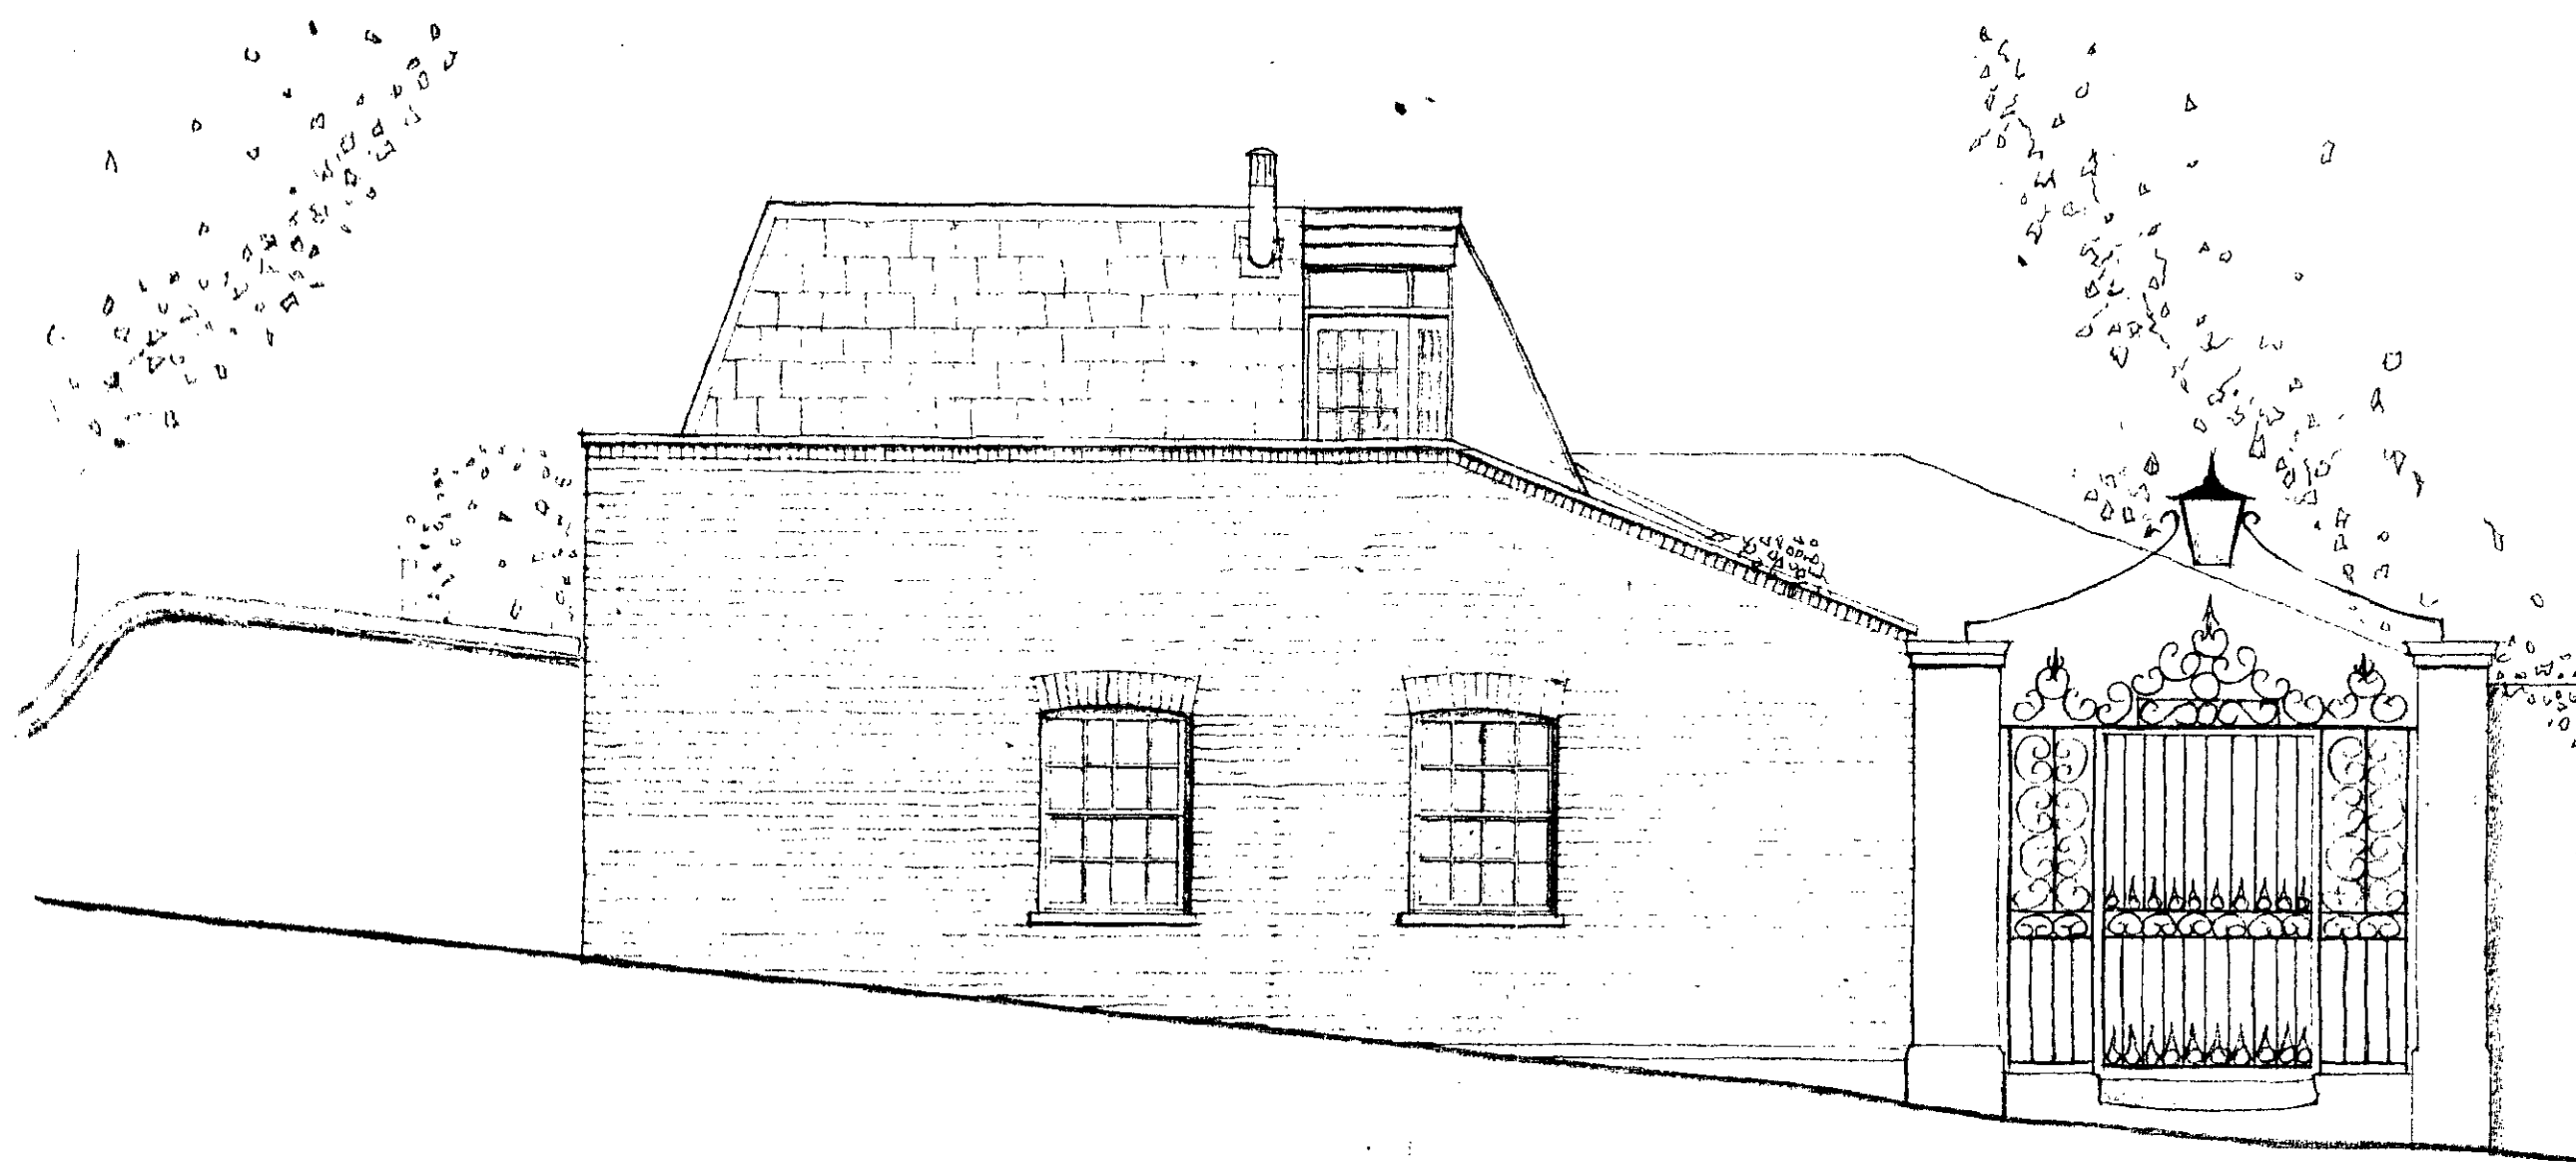


WEST HILL ELEVATION

MATERIALS
 NEW SLATE CLAD PARAPET ROOF RE USING
 EXISTING SLATES WHERE POSSIBLE. FLAT ROOF
 TO BE CLAYED. EIGHT IN FEET ROOFING OR
 SIMILAR APPROVED.
 FLASHING 2 CHECKS TO BE IN LEAD
 FACIAS OVER JOISTS TO BE SHINGLED OR PLY
 PAINTED.
 AREAS OF RENDER TO MATCH EXISTING
 CARPENTRY & SILL TO HEAD ENTRANCE TO
 BE IN P.E. CAST CONC.
 NEW BRICKWORK TO REAR VERANDA TO
 BE IN STONE. HAND RAILING TO
 MATCH EXISTING.

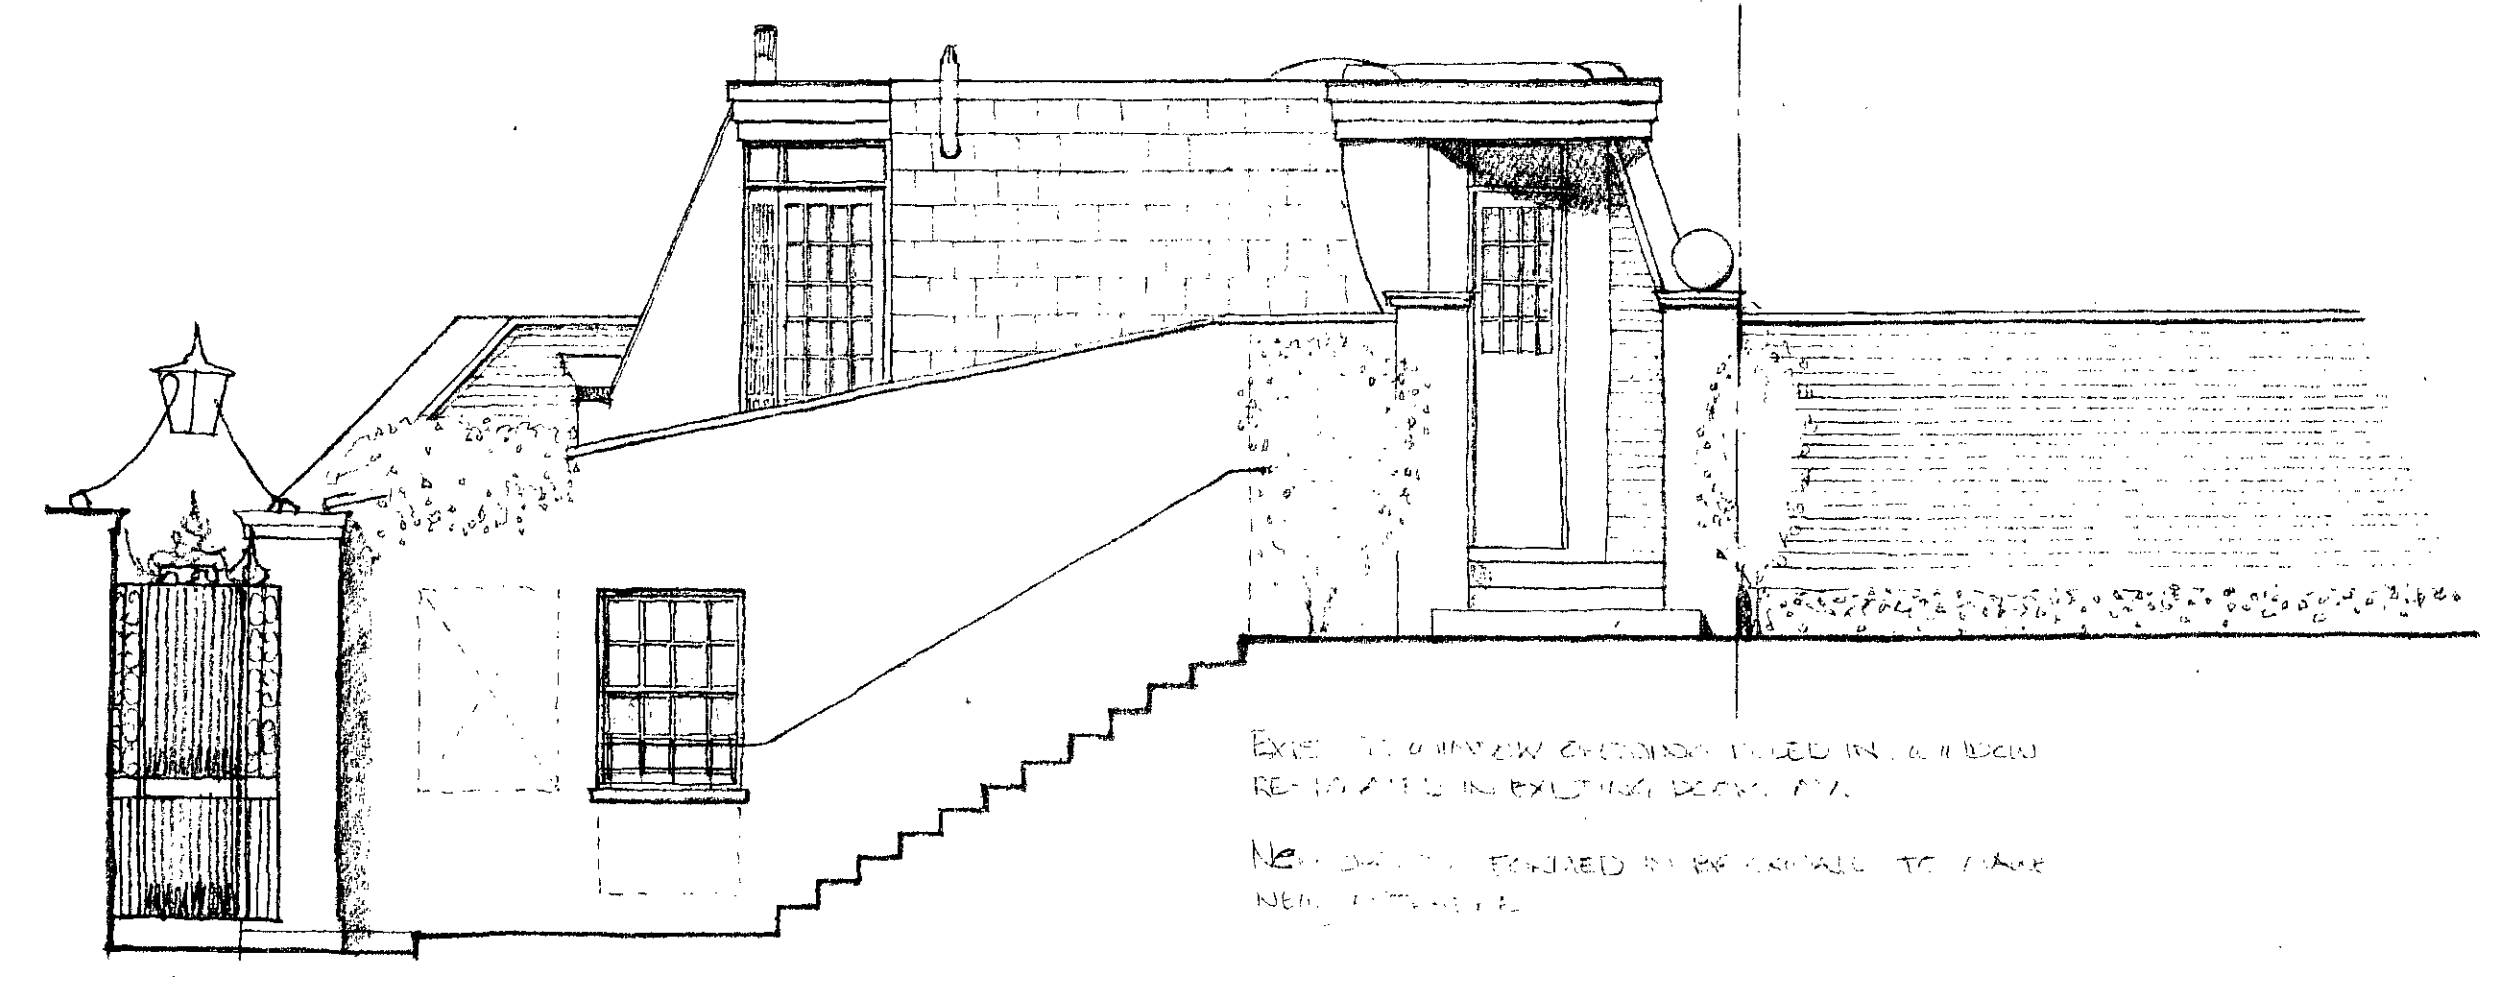

HOLLY TERRACE ELEVATION


EXISTING WINDOW OVERLOOKING VERANDA
 RE-PAINTED IN EXISTING DECORATIVE
 NEW SLATE REQUIRED TO BE SUPPLIED TO MATCH
 NEW TERRACE.

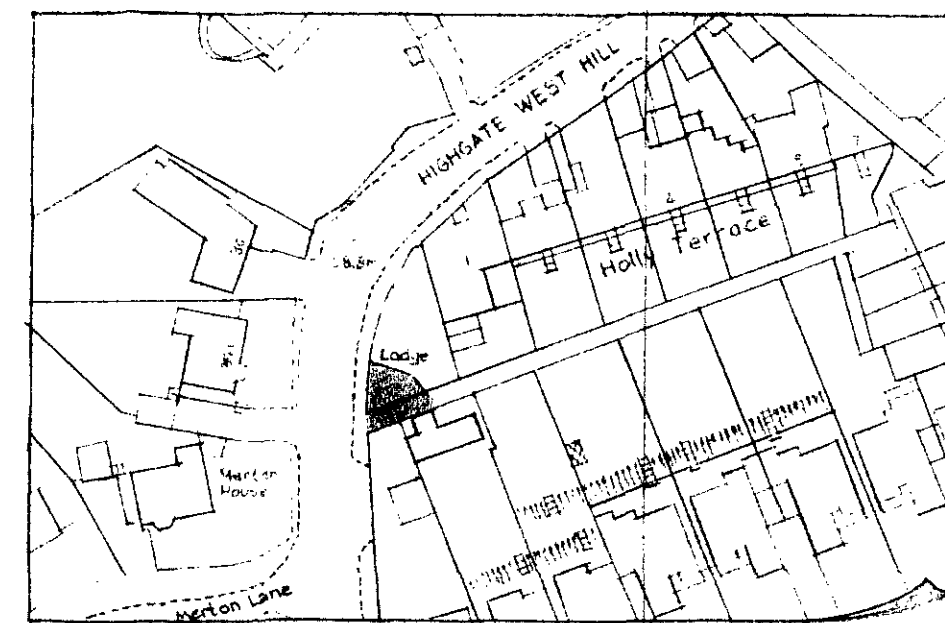


location plan 1:1250



VIEW FROM MERTON LANE

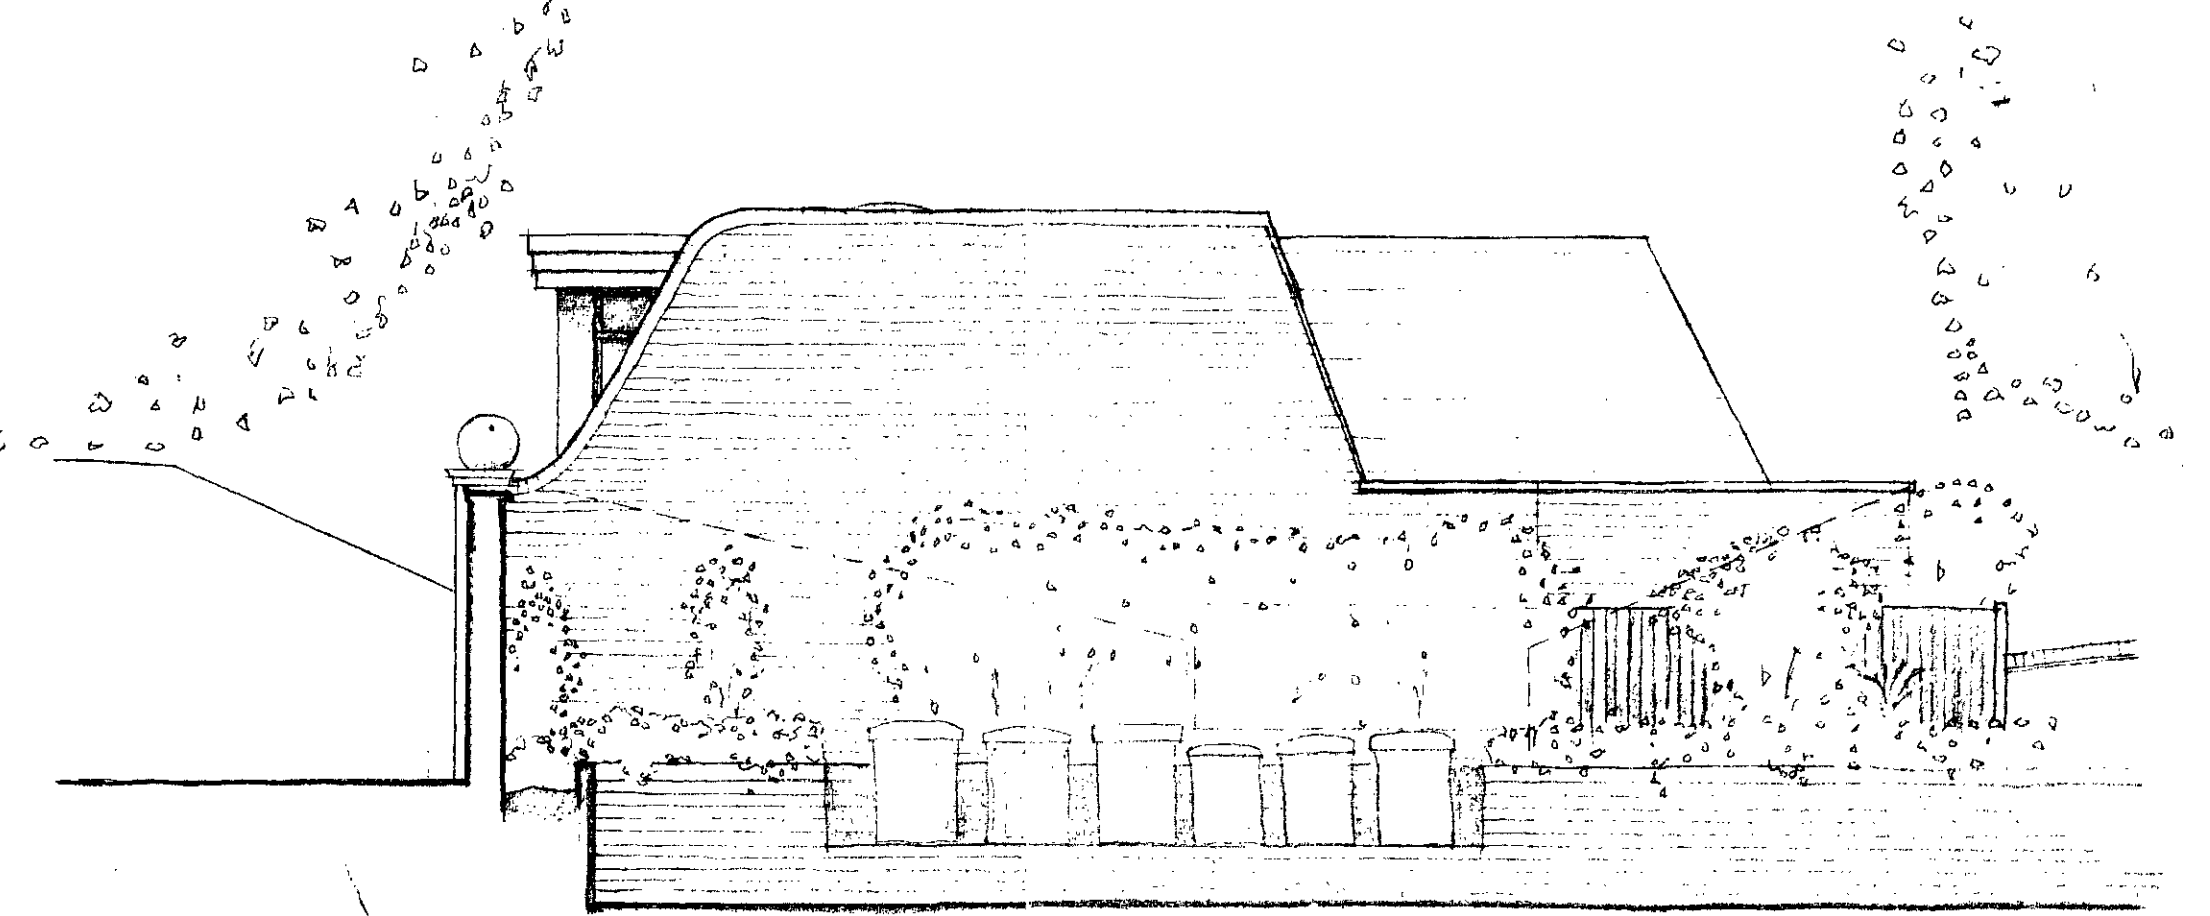


REAR ELEVATION

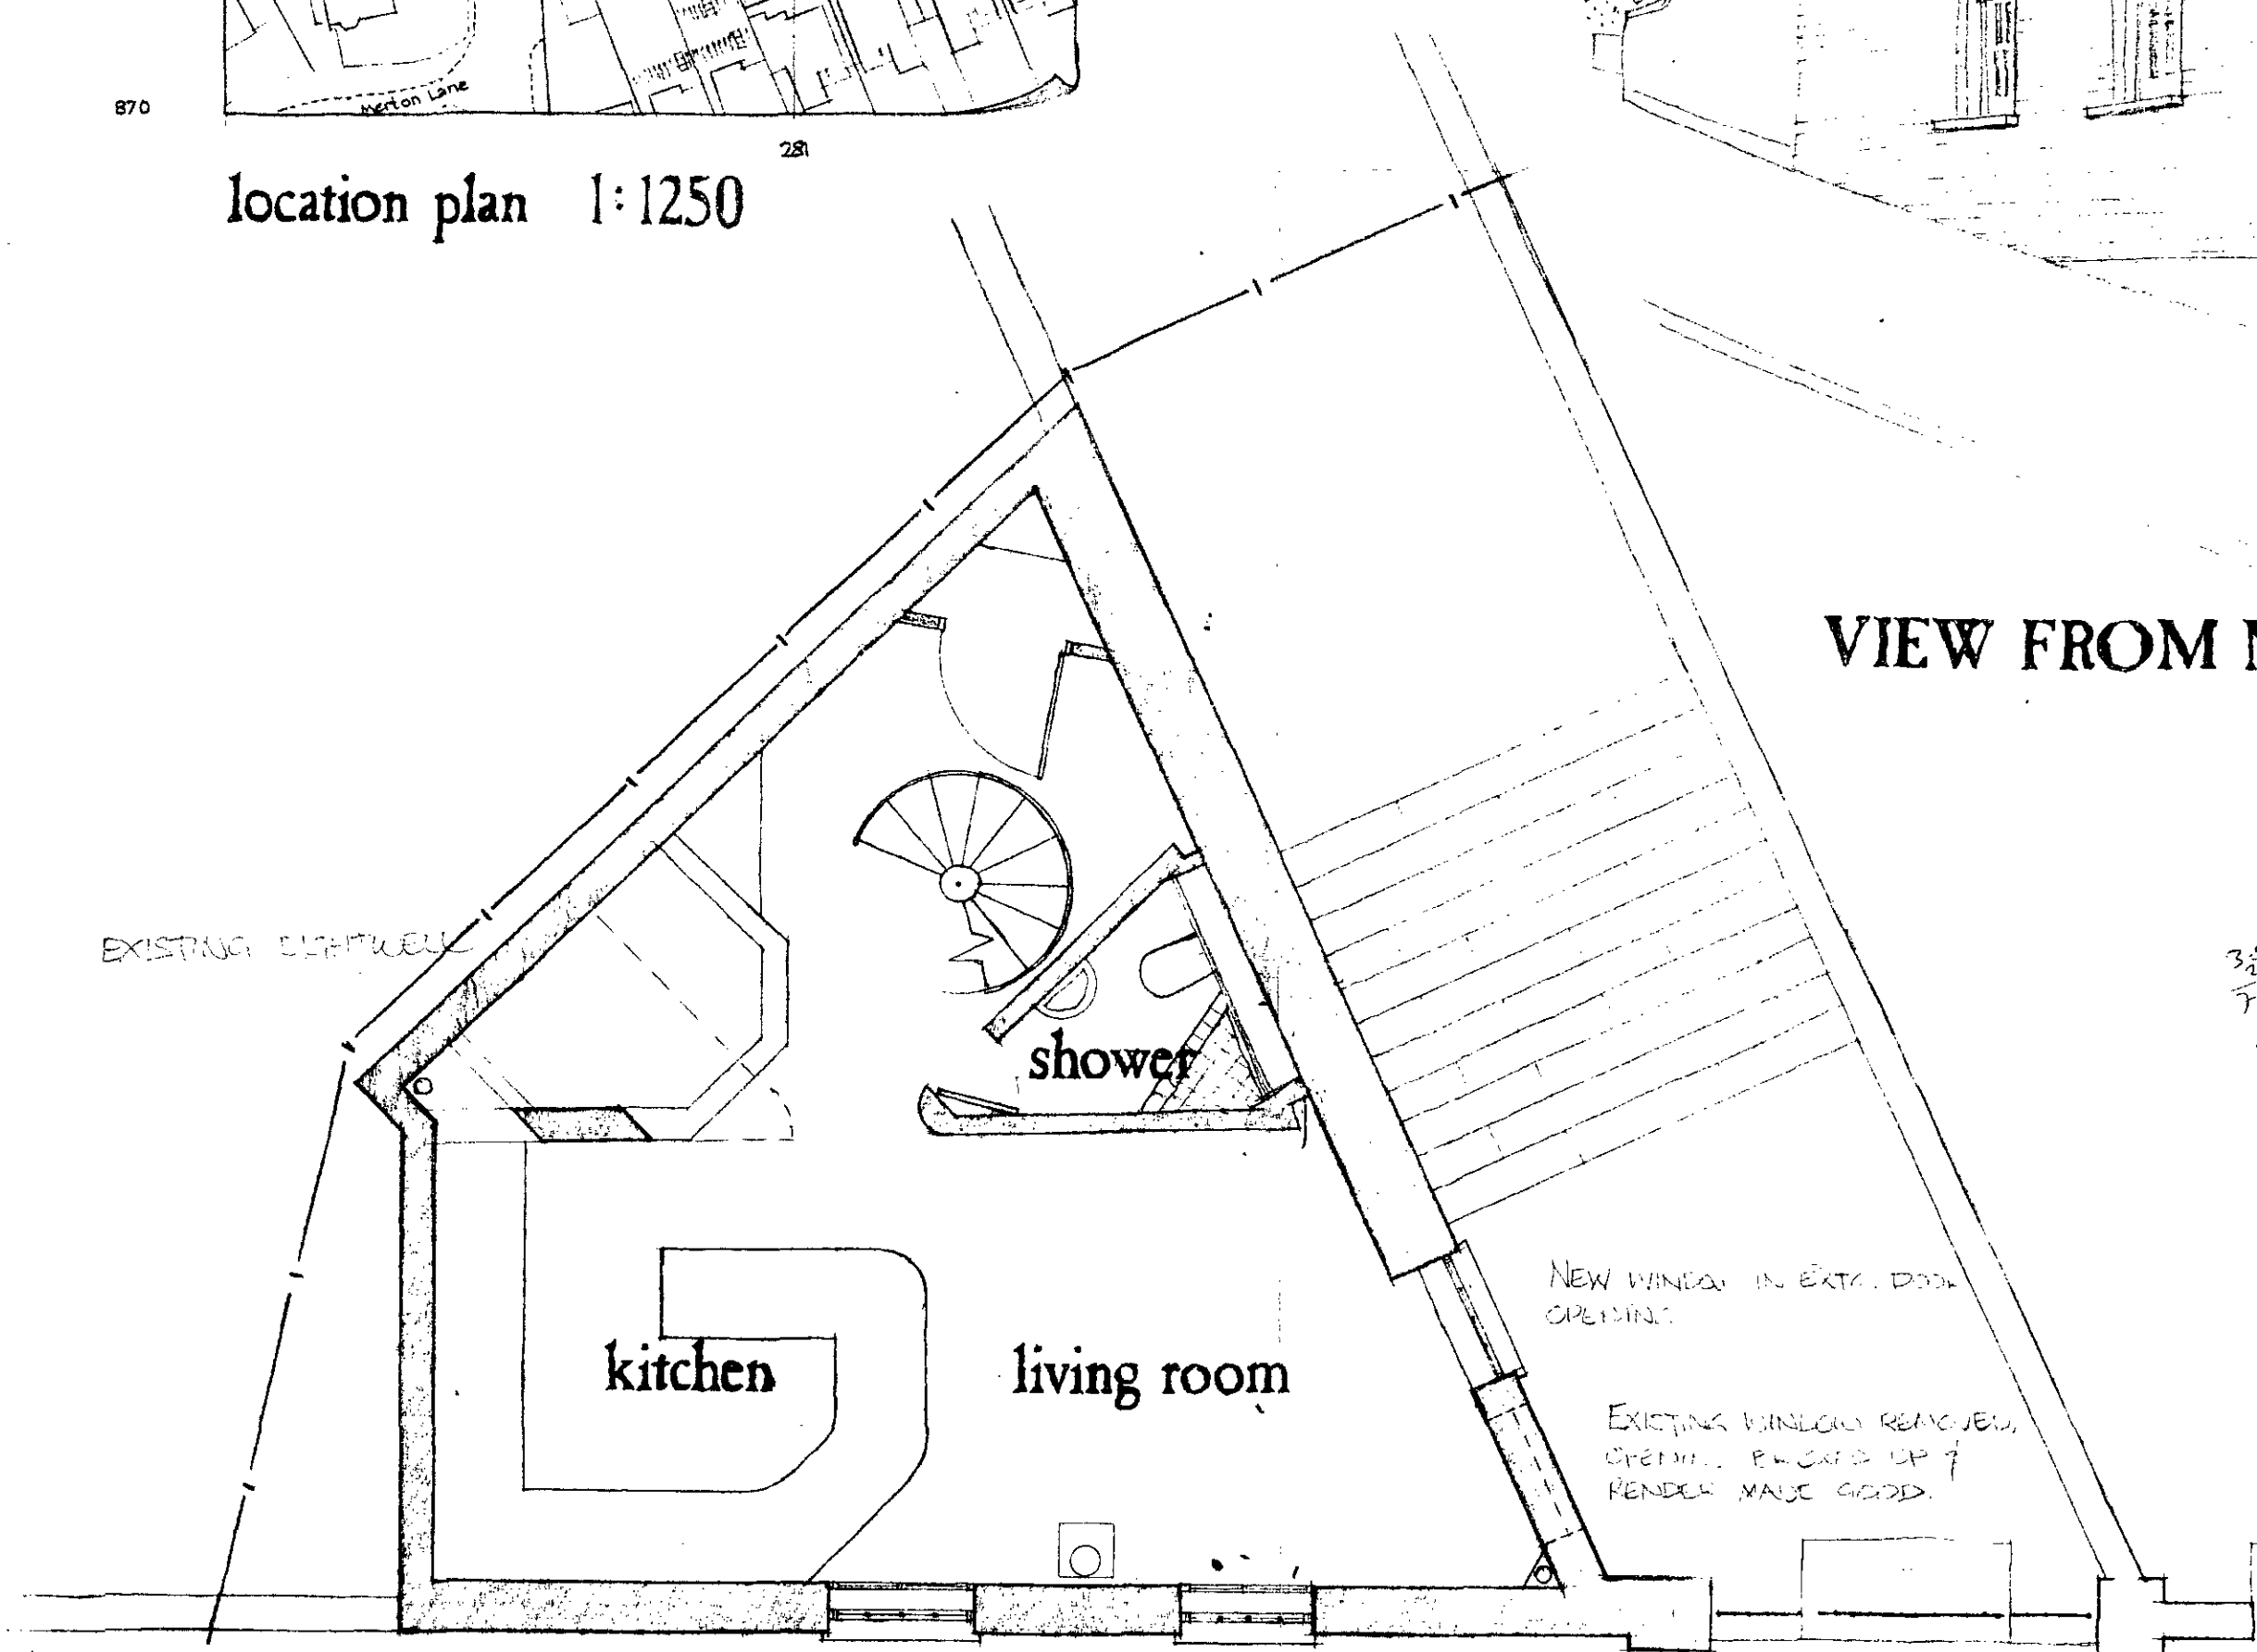


GROUND FLOOR PLAN

19.25
 16.55
 38.80
 70.
 38.5
 25.
 96.0

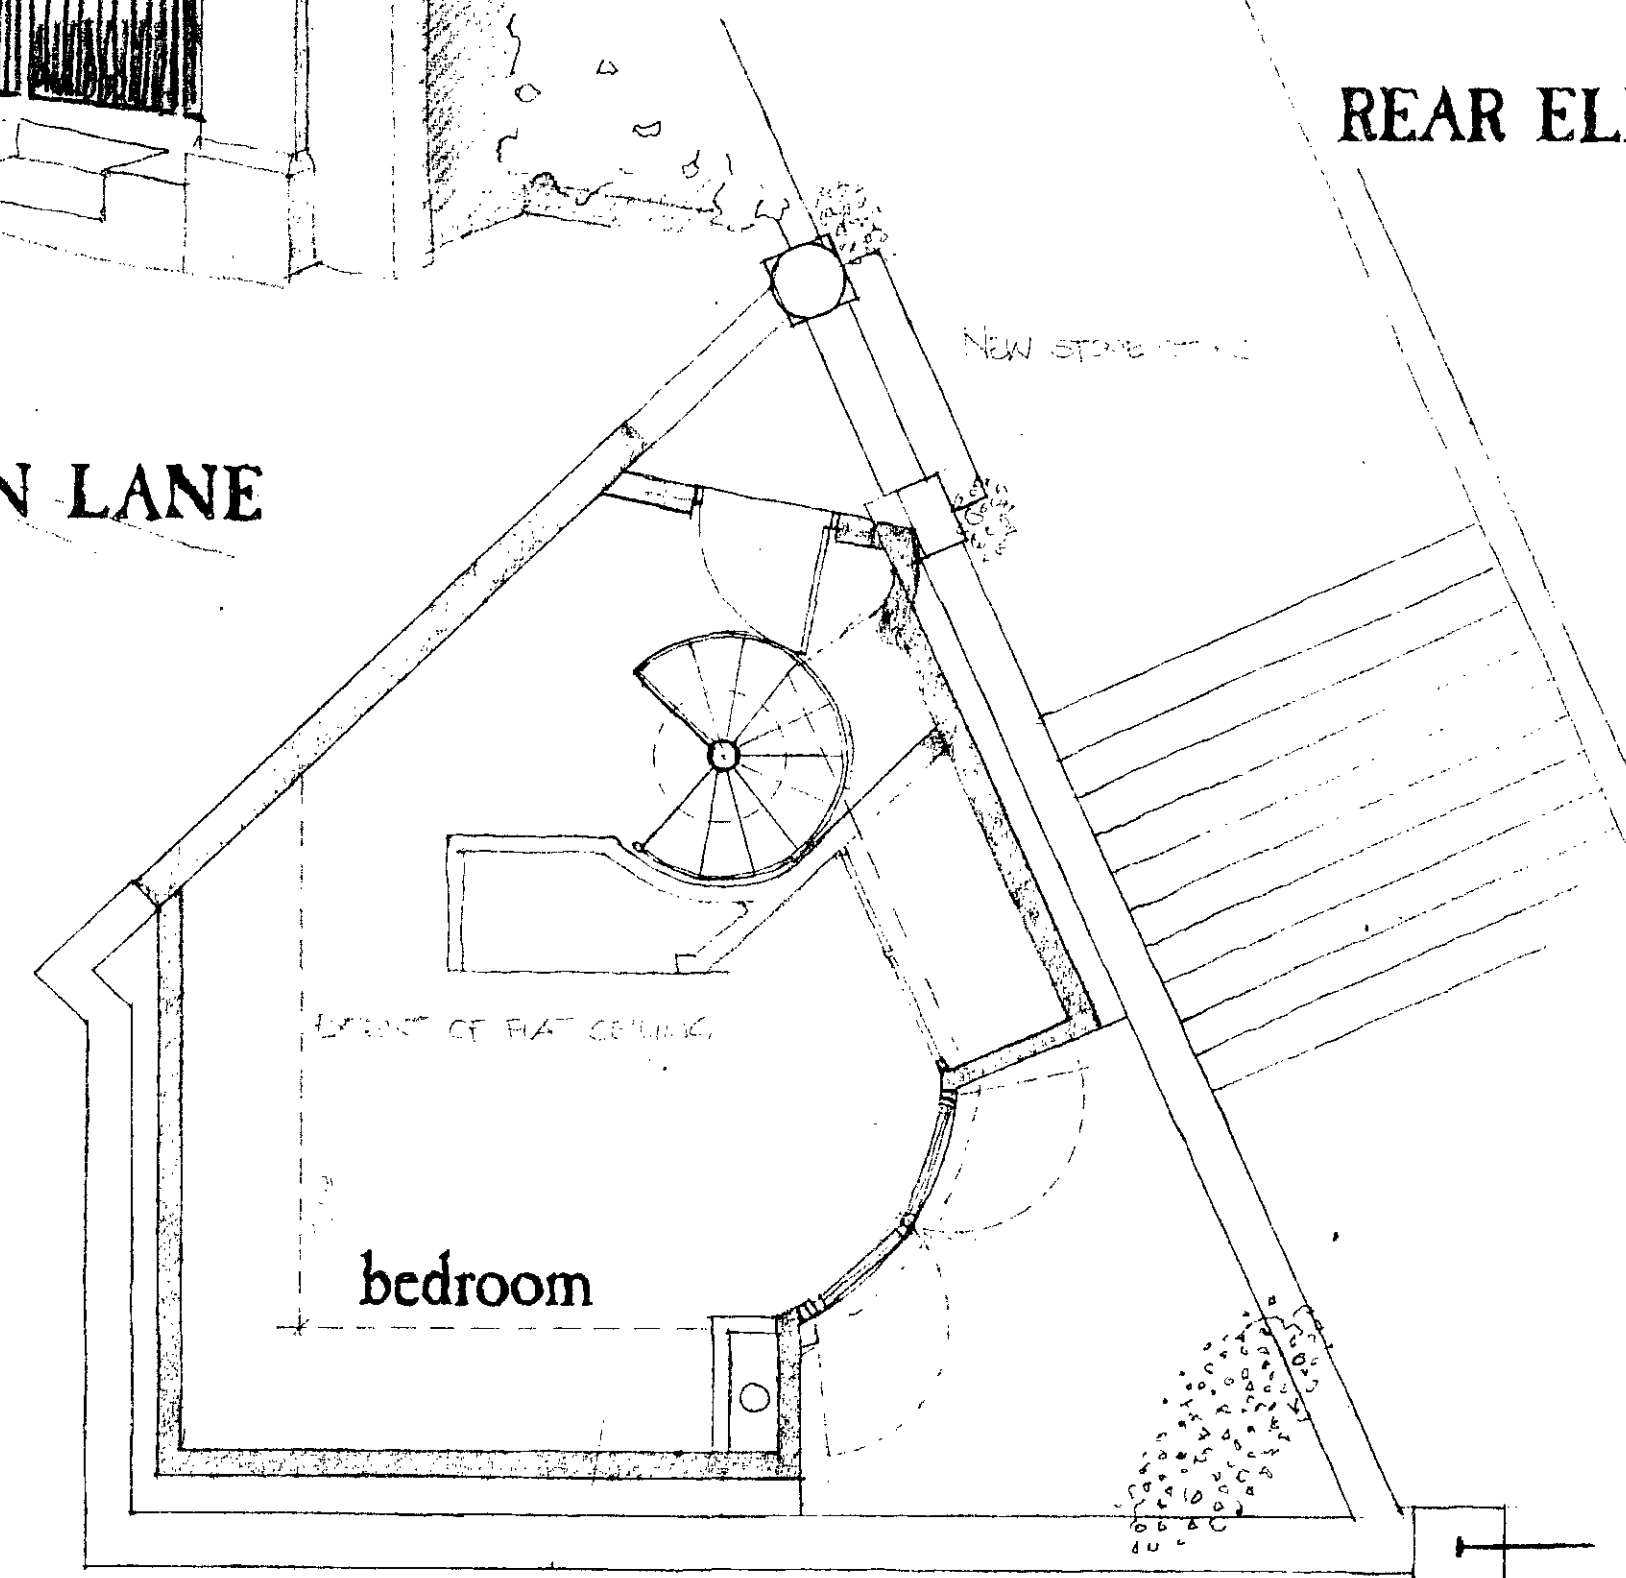

FIRST FLOOR PLAN

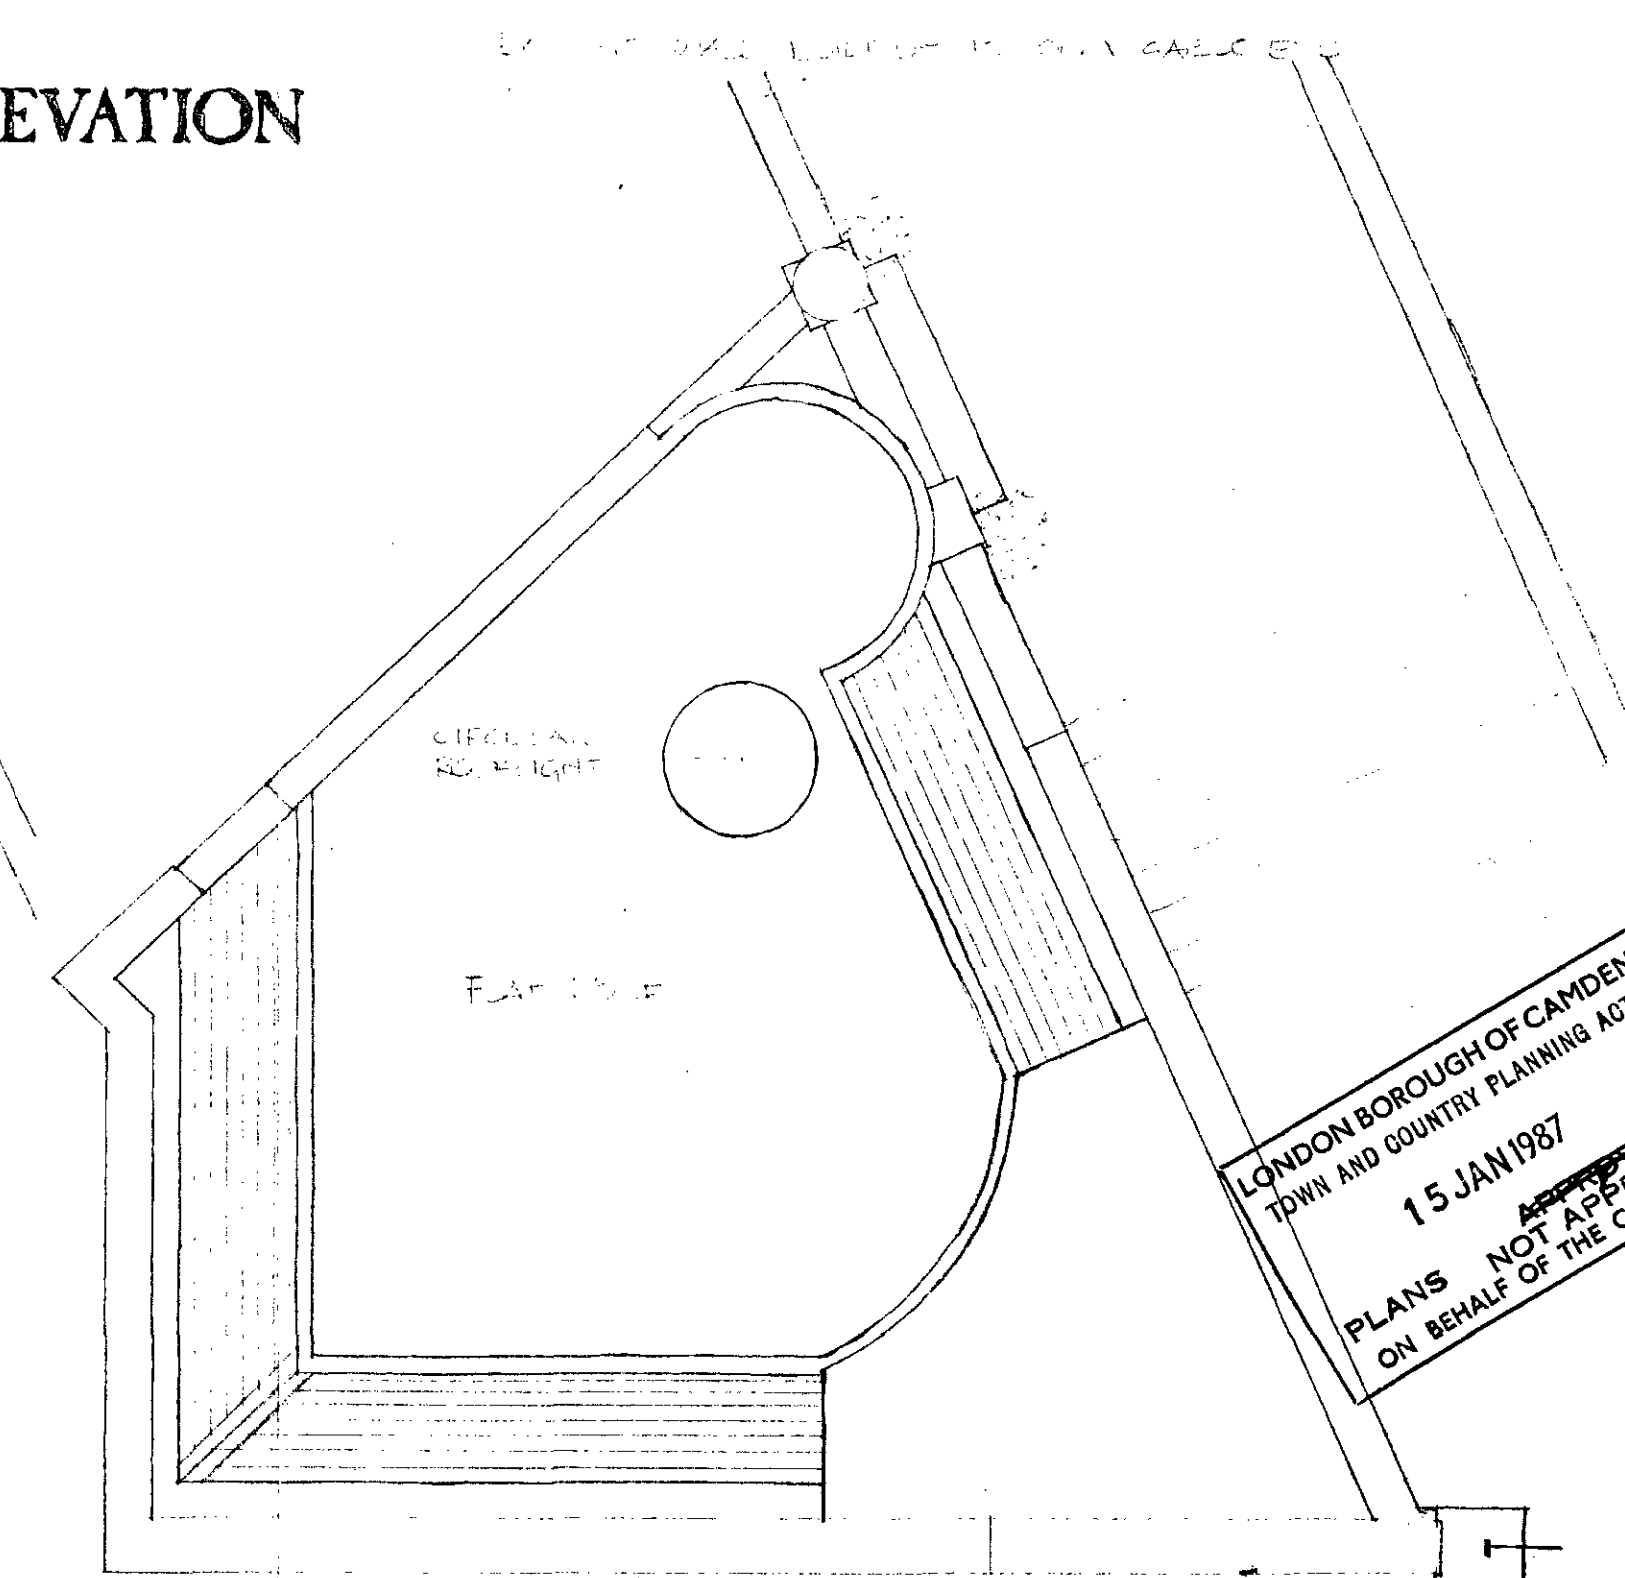

ROOF PLAN

HB 8670374





LONDON BOROUGH OF CAMDEN
 TOWN AND COUNTRY PLANNING ACTS
 15 JAN 1987
 PLANS NOT APPROVED
 ON BEHALF OF THE COUNCIL

The Lodge: Holly Terrace. Highgate West Hill. N6.


telephone 349-1762

richard i. barrett, architect.
 255 Squires Lane, London N3 2QS

Project no.	Drawing no.	Revision
P36	1	

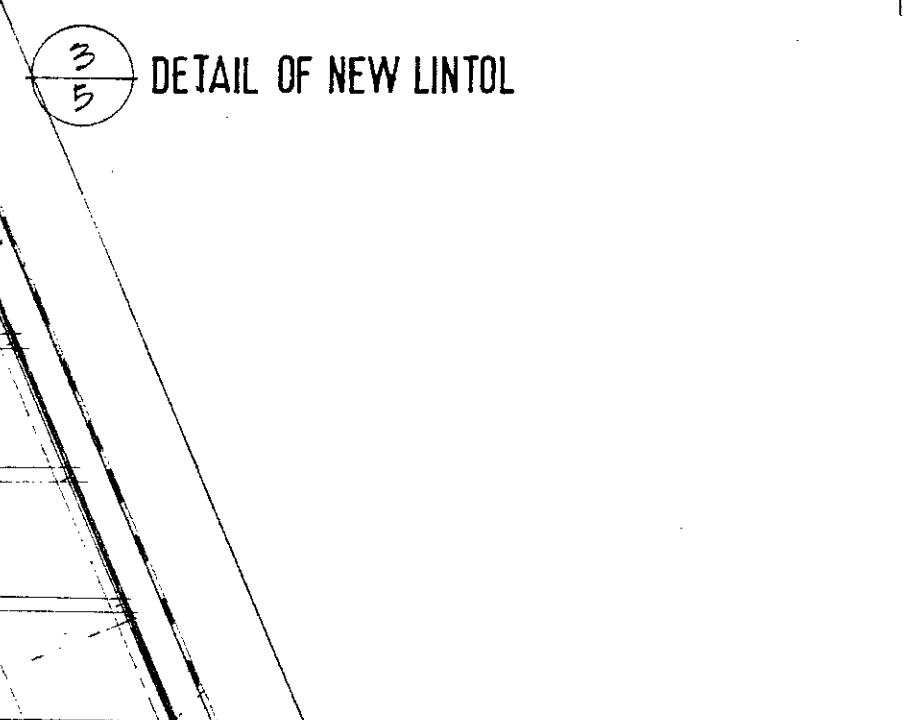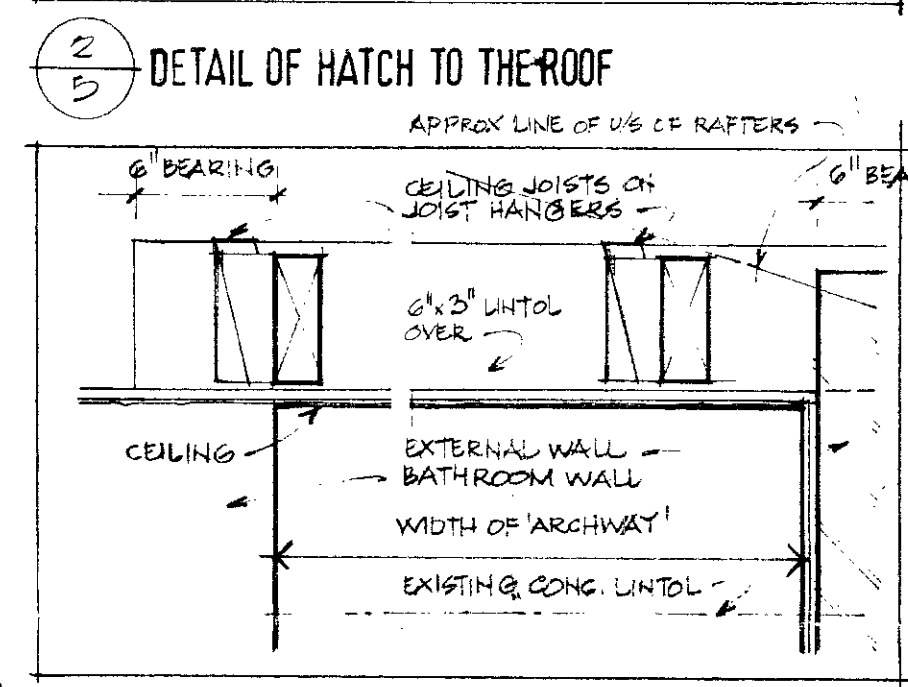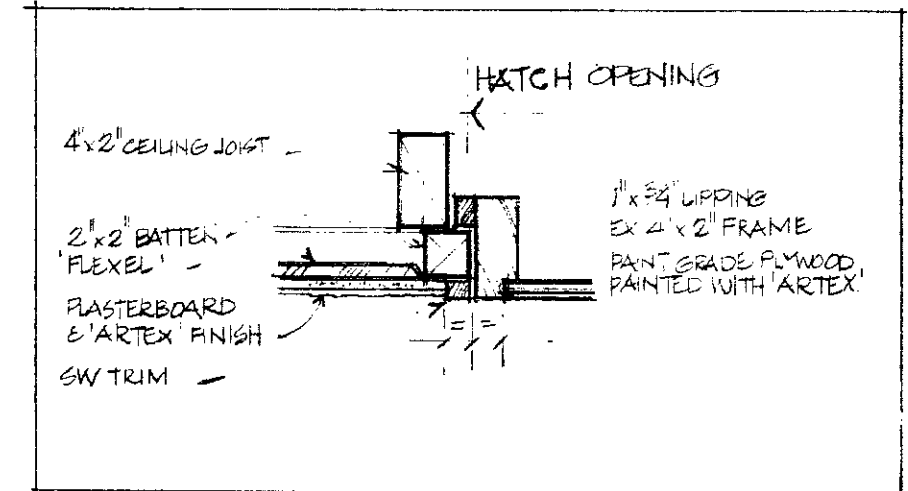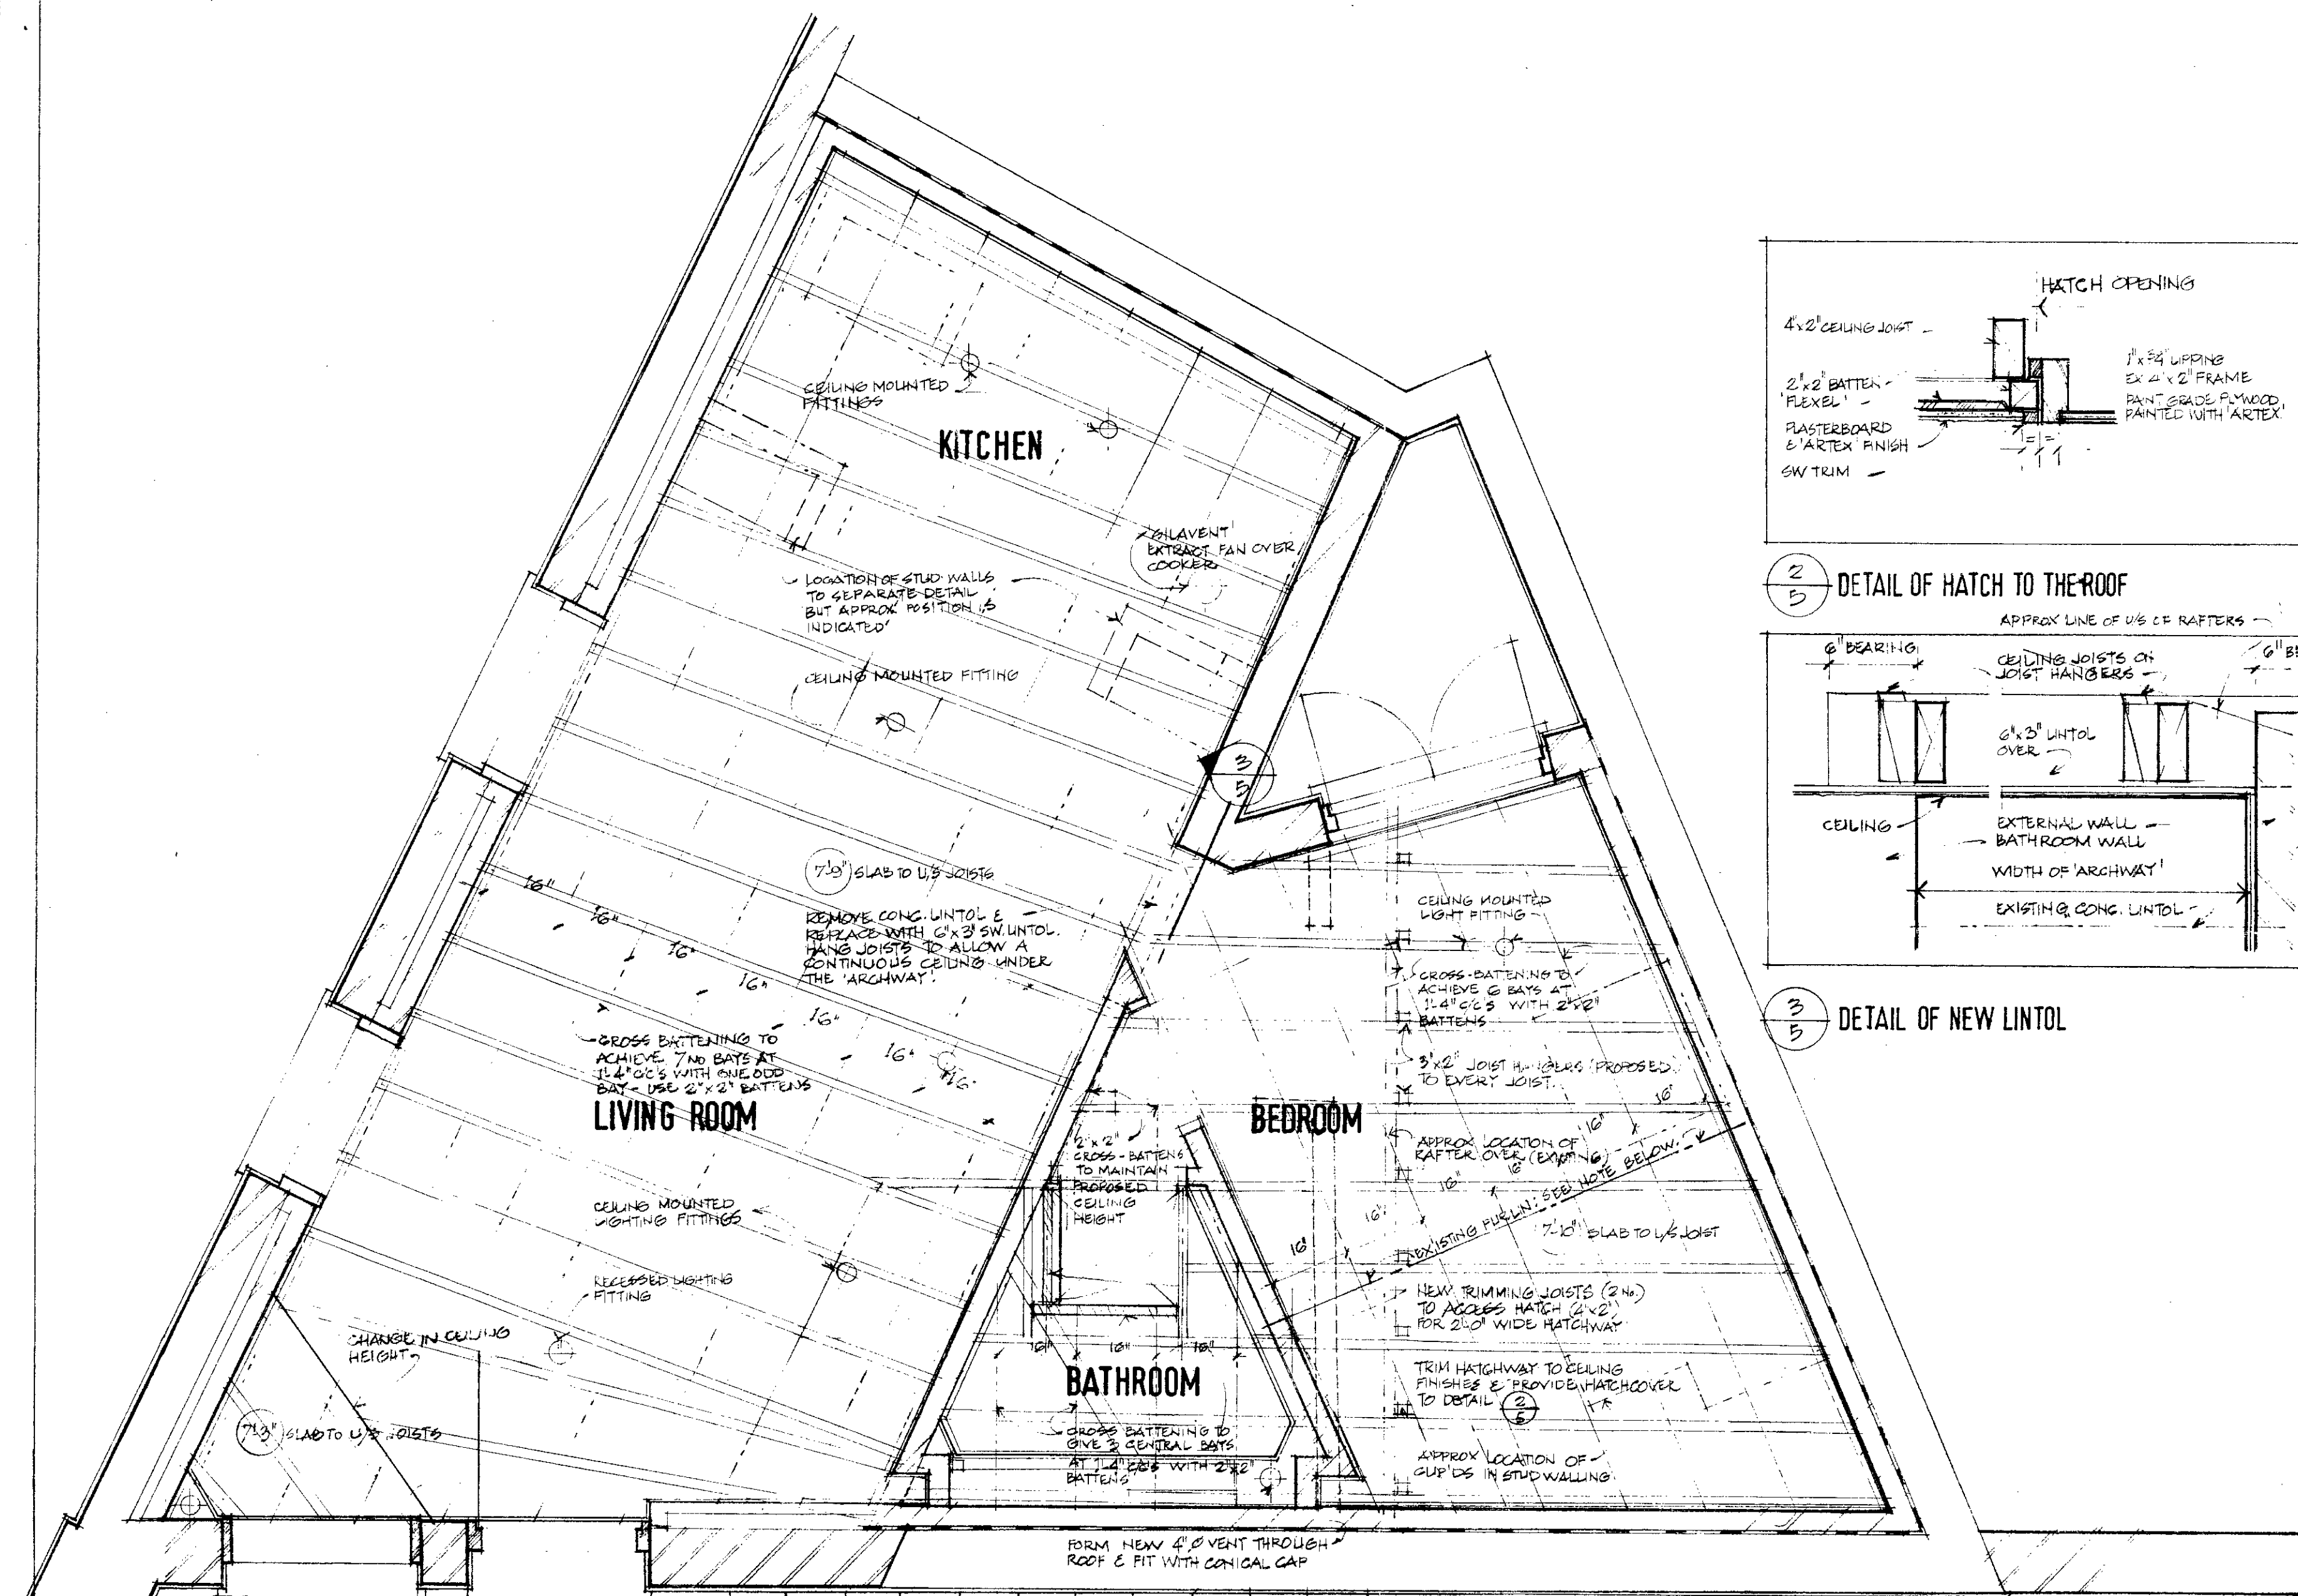

1
5 REFLECTED CEILING PLAN

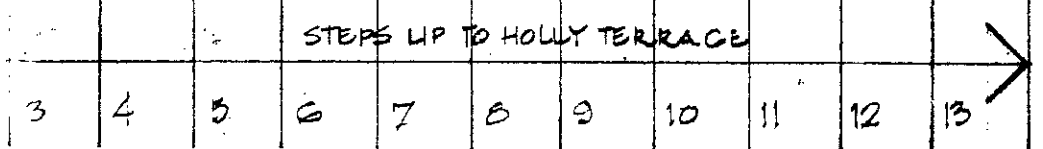

NOTE: EXISTING PURLIN TO THE ROOF OVER THE BEDROOM IS TO LOAD ONTO THE 4" WALL PROPOSED TO REPLACE EXISTING PARTITION. IF THE PURLIN IS TOO SHORT, IT SHOULD BE LENGTHENED WITH 2 NO. 9"x2" TIMBERS BOLTED TWICE TOGETHER WITH TIMBER CONNECTORS.

Révision	Date
Date printed	30 APR 1974
Date drawn	JANUARY 1974
Scale	1" represents 2'-0"

Drawing

REFLECTED CEILING PLAN

NOTE: CROSS BATTENING TO RECEIVE FLEXEL HEATING ELEMENTS TO BE POSITIONED CAREFULLY AT 16" O/C'S AS DIRECTED


Project

**THE LODGE
HOLLY TERRACE
HIGHGATE WEST HILL
(INTERIOR DECORATION ONLY)**

Kellard/Reeves Partnership
Architects and Consultant Planners

35/37 High Street Wheathampstead
Hertfordshire AL4 8BB
Wheathampstead 2721/2

Project no.	Drawing no.	Revision
P36	5	

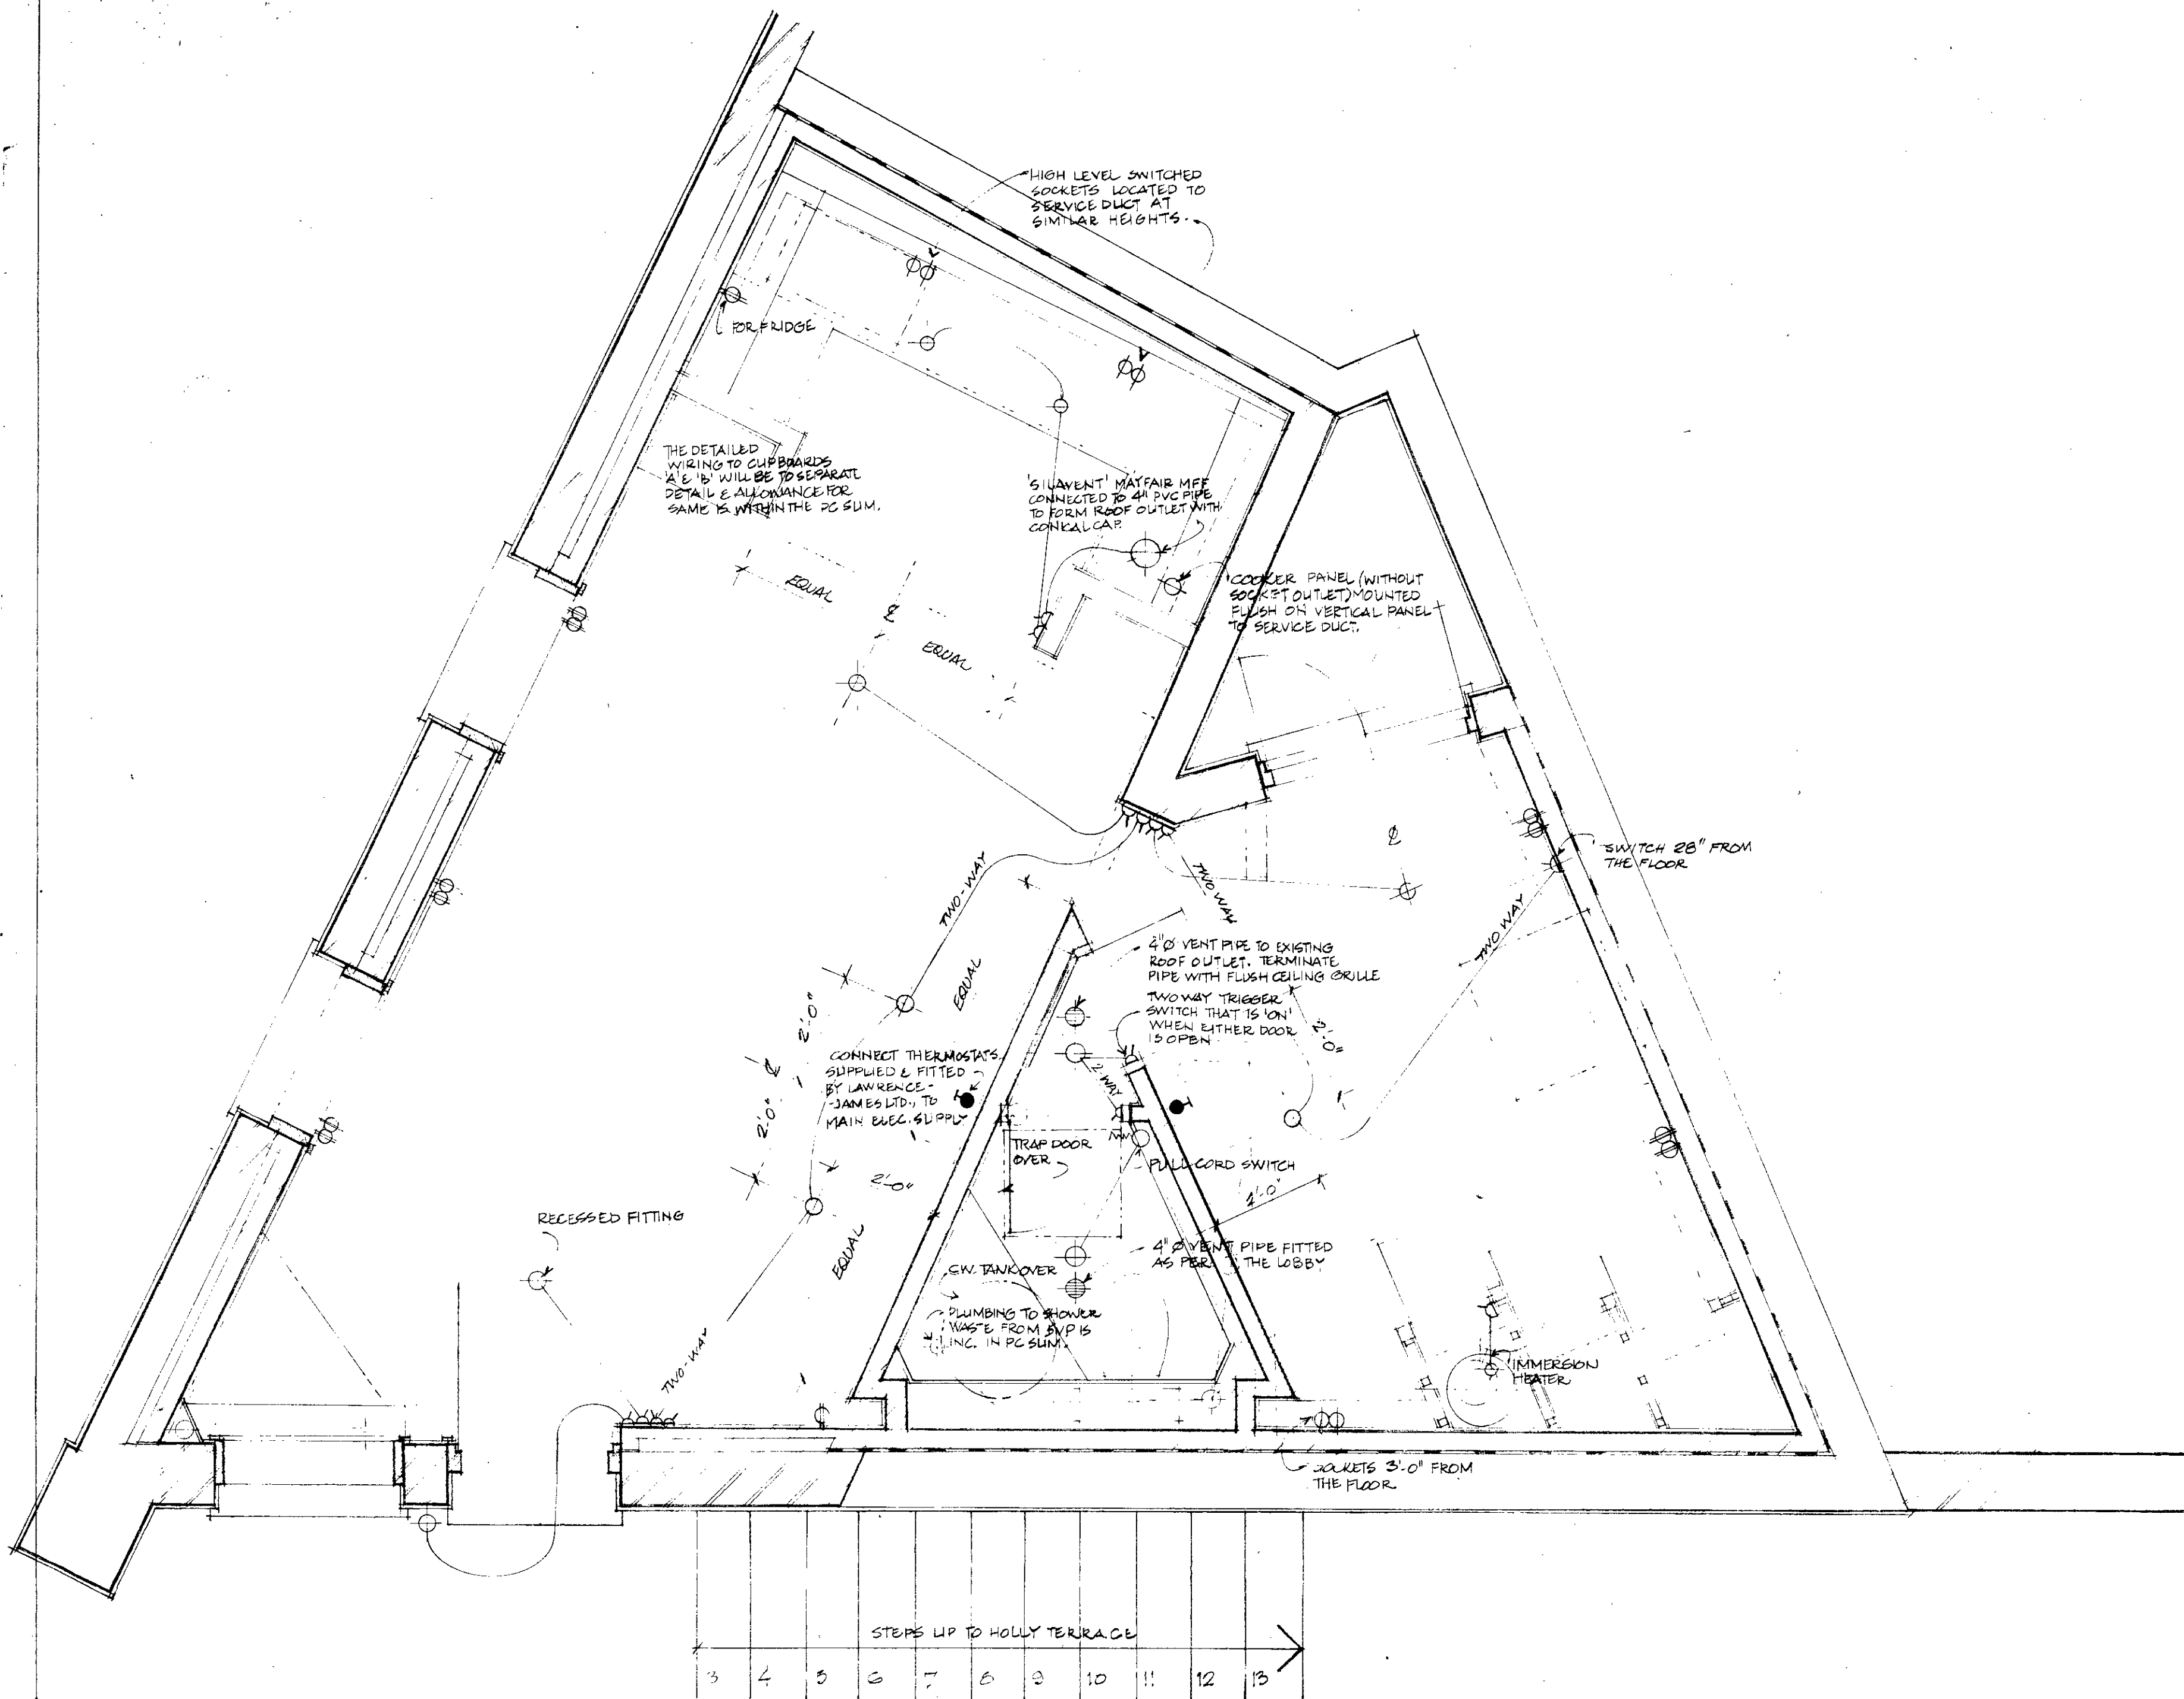

ELECTRICAL LEGEND :

- ⊙ 4" VENT PIPE OUTLET
- ⊙ CEILING LIGHT
- ⊙ PULL-OPERATED SWITCH
- ⊙ SINGLE (OR MULTI-GANG) SWITCH
- ⊙ HIGH LEVEL SOCKET OUTLET
- ⊙ LOW LEVEL SOCKET OUTLET

Révision	Date
Date printed	Reference
130 APR 1974	MK
Date drawn	North
JANUARY 1974	
Scale	
1" represents 2'-0"	

Drawing FLOOR PLAN (SERVICES)

Project	THE LODGE HOLLY TERRACE HIGHGATE WEST HILL (INTERIOR DECORATION ONLY)
Kellard/Reeves Partnership Architects and Consultant Planners	
35/37 High Street Wheathampstead Hertfordshire AL4 8BB Wheathampstead 2721/2	
Project no. P36	Drawing no. / 6
Revision	