


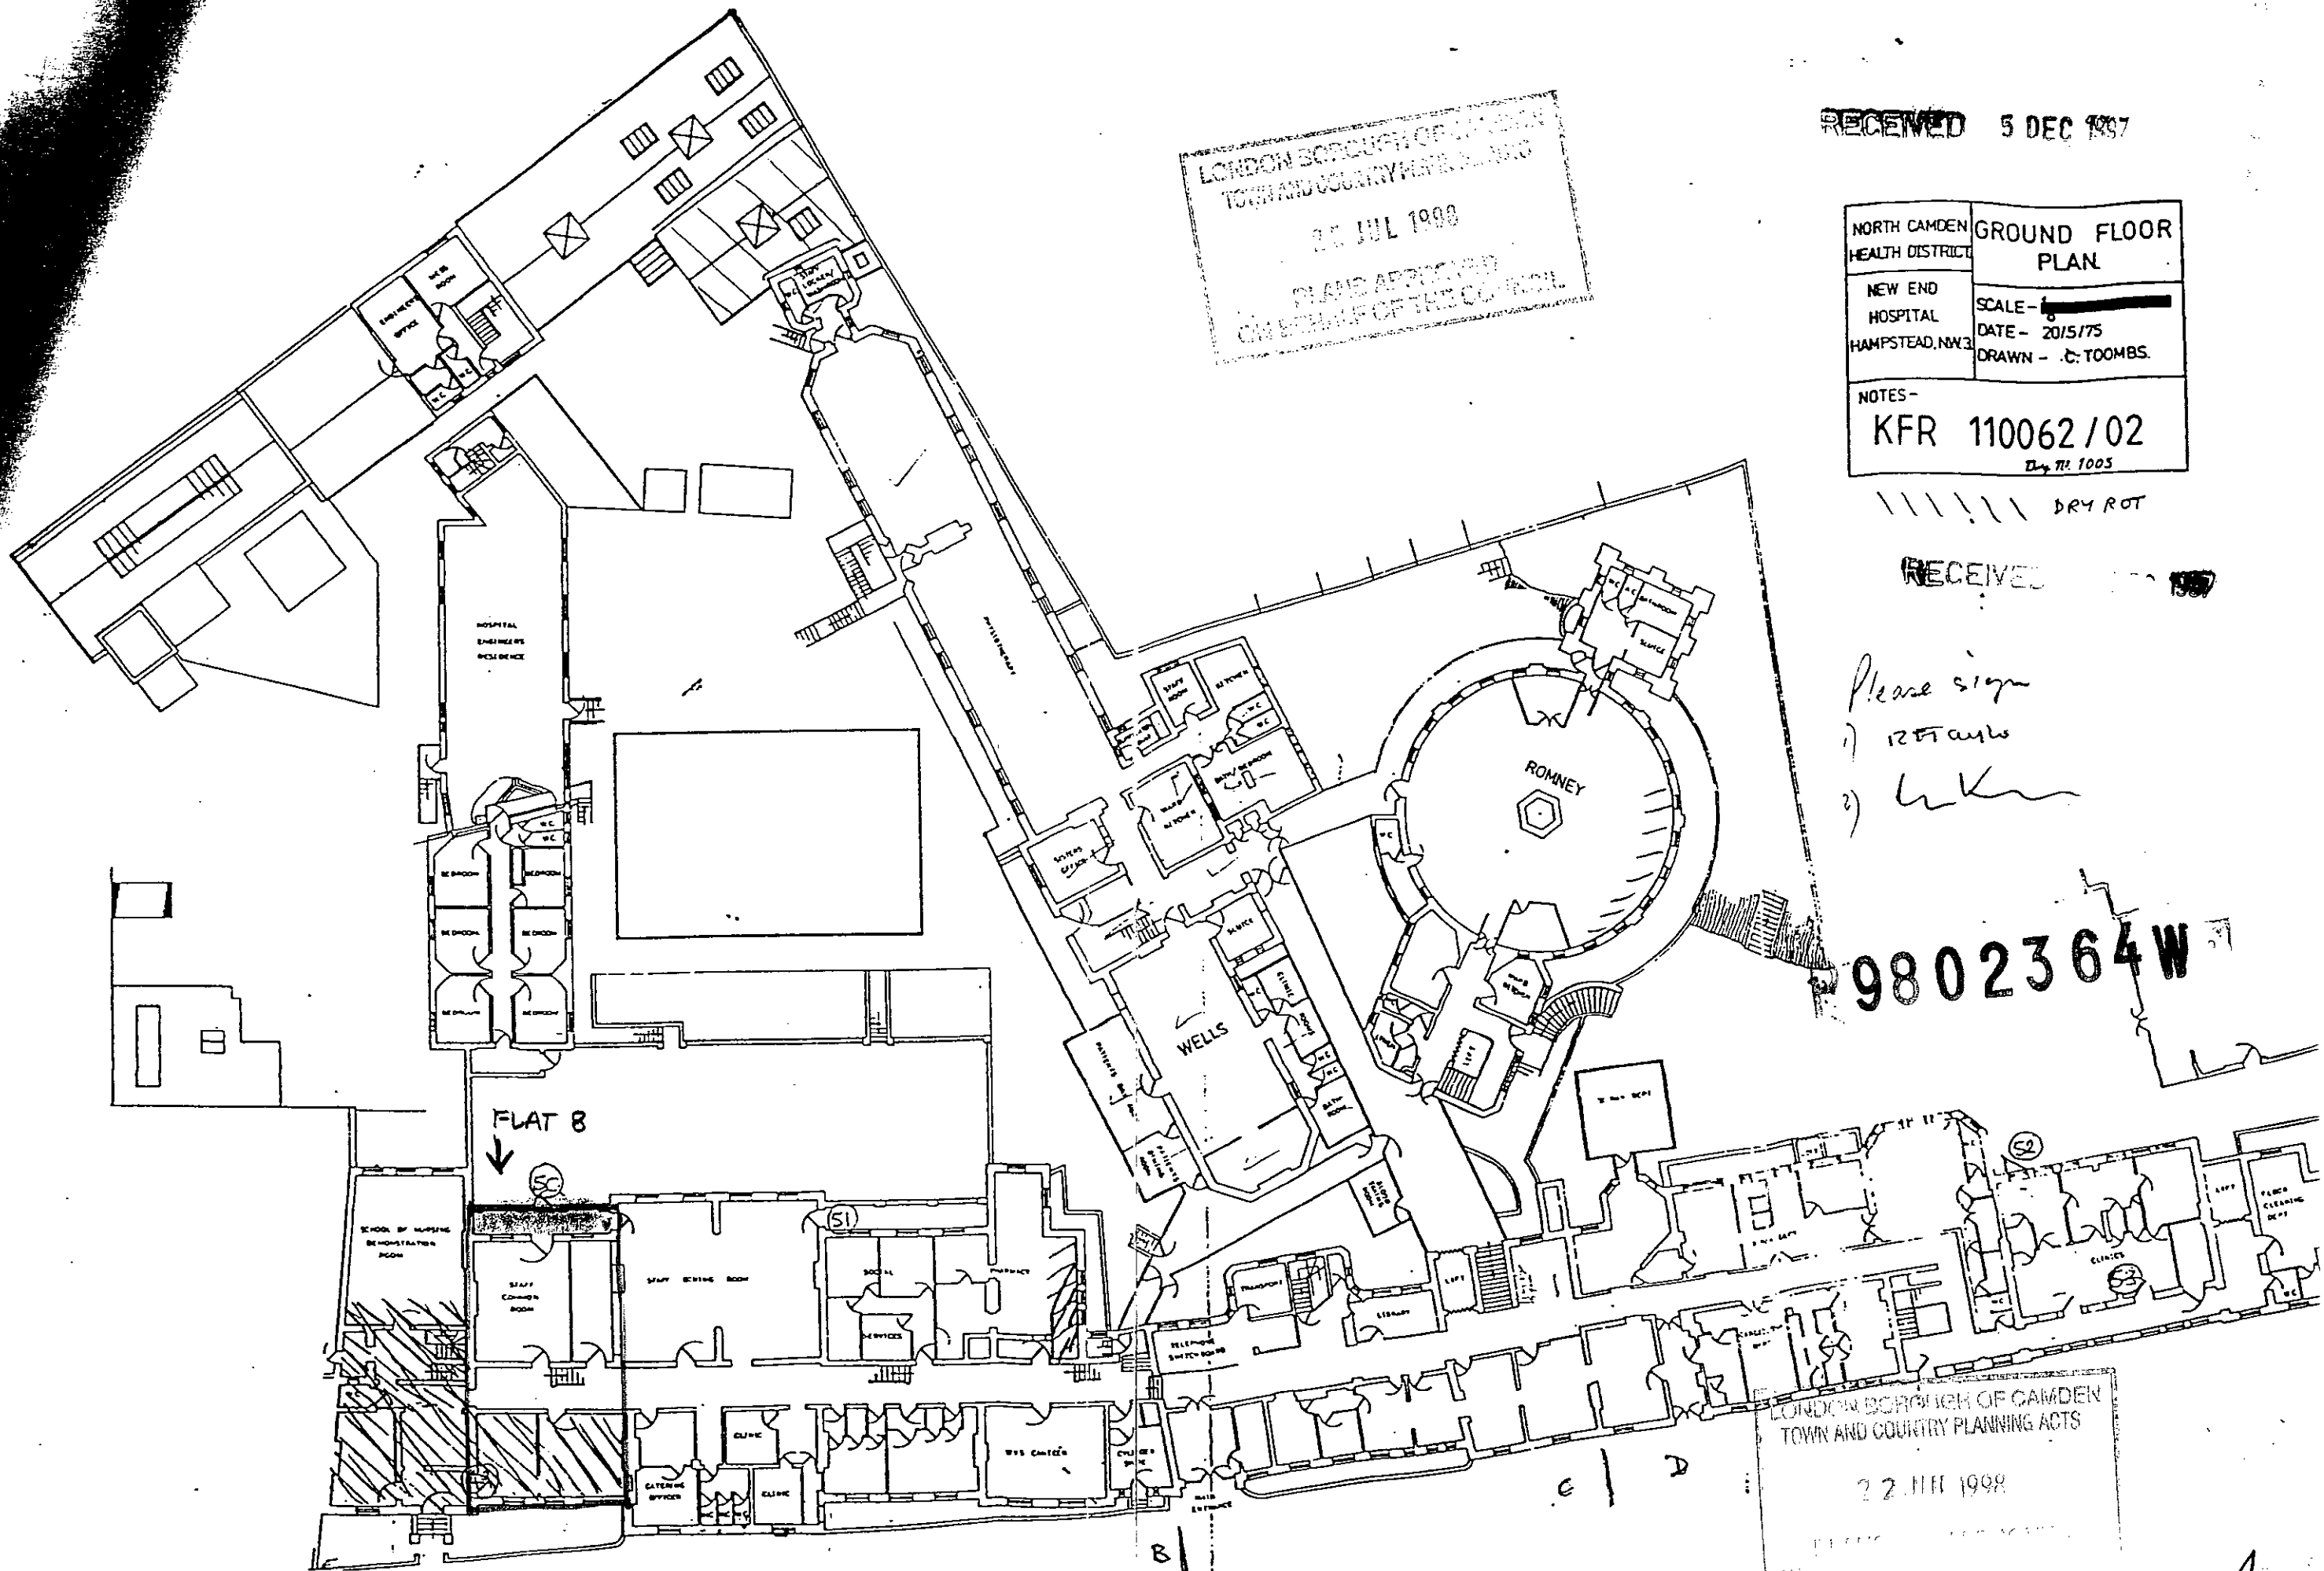

LONDON BOROUGH OF CAMDEN
TOWN AND COUNTRY PLANNING ACTS
22 JUL 1998
PLAN APPROVED
ON BEHALF OF THE COUNCIL

RECEIVED 5 DEC 1997

NORTH CAMDEN HEALTH DISTRICT	GROUND FLOOR PLAN
NEW END HOSPITAL HAMPSTEAD, NW3	SCALE - 1:1000 DATE - 20/5/75 DRAWN - C. TOOMBS
NOTES - KFR 110062/02 By M. 1005	

DRY ROT


RECEIVED

Please sign
1) 12th April
2) 12th April



9802364W

LONDON BOROUGH OF CAMDEN
TOWN AND COUNTRY PLANNING ACTS


22 JUL 1998

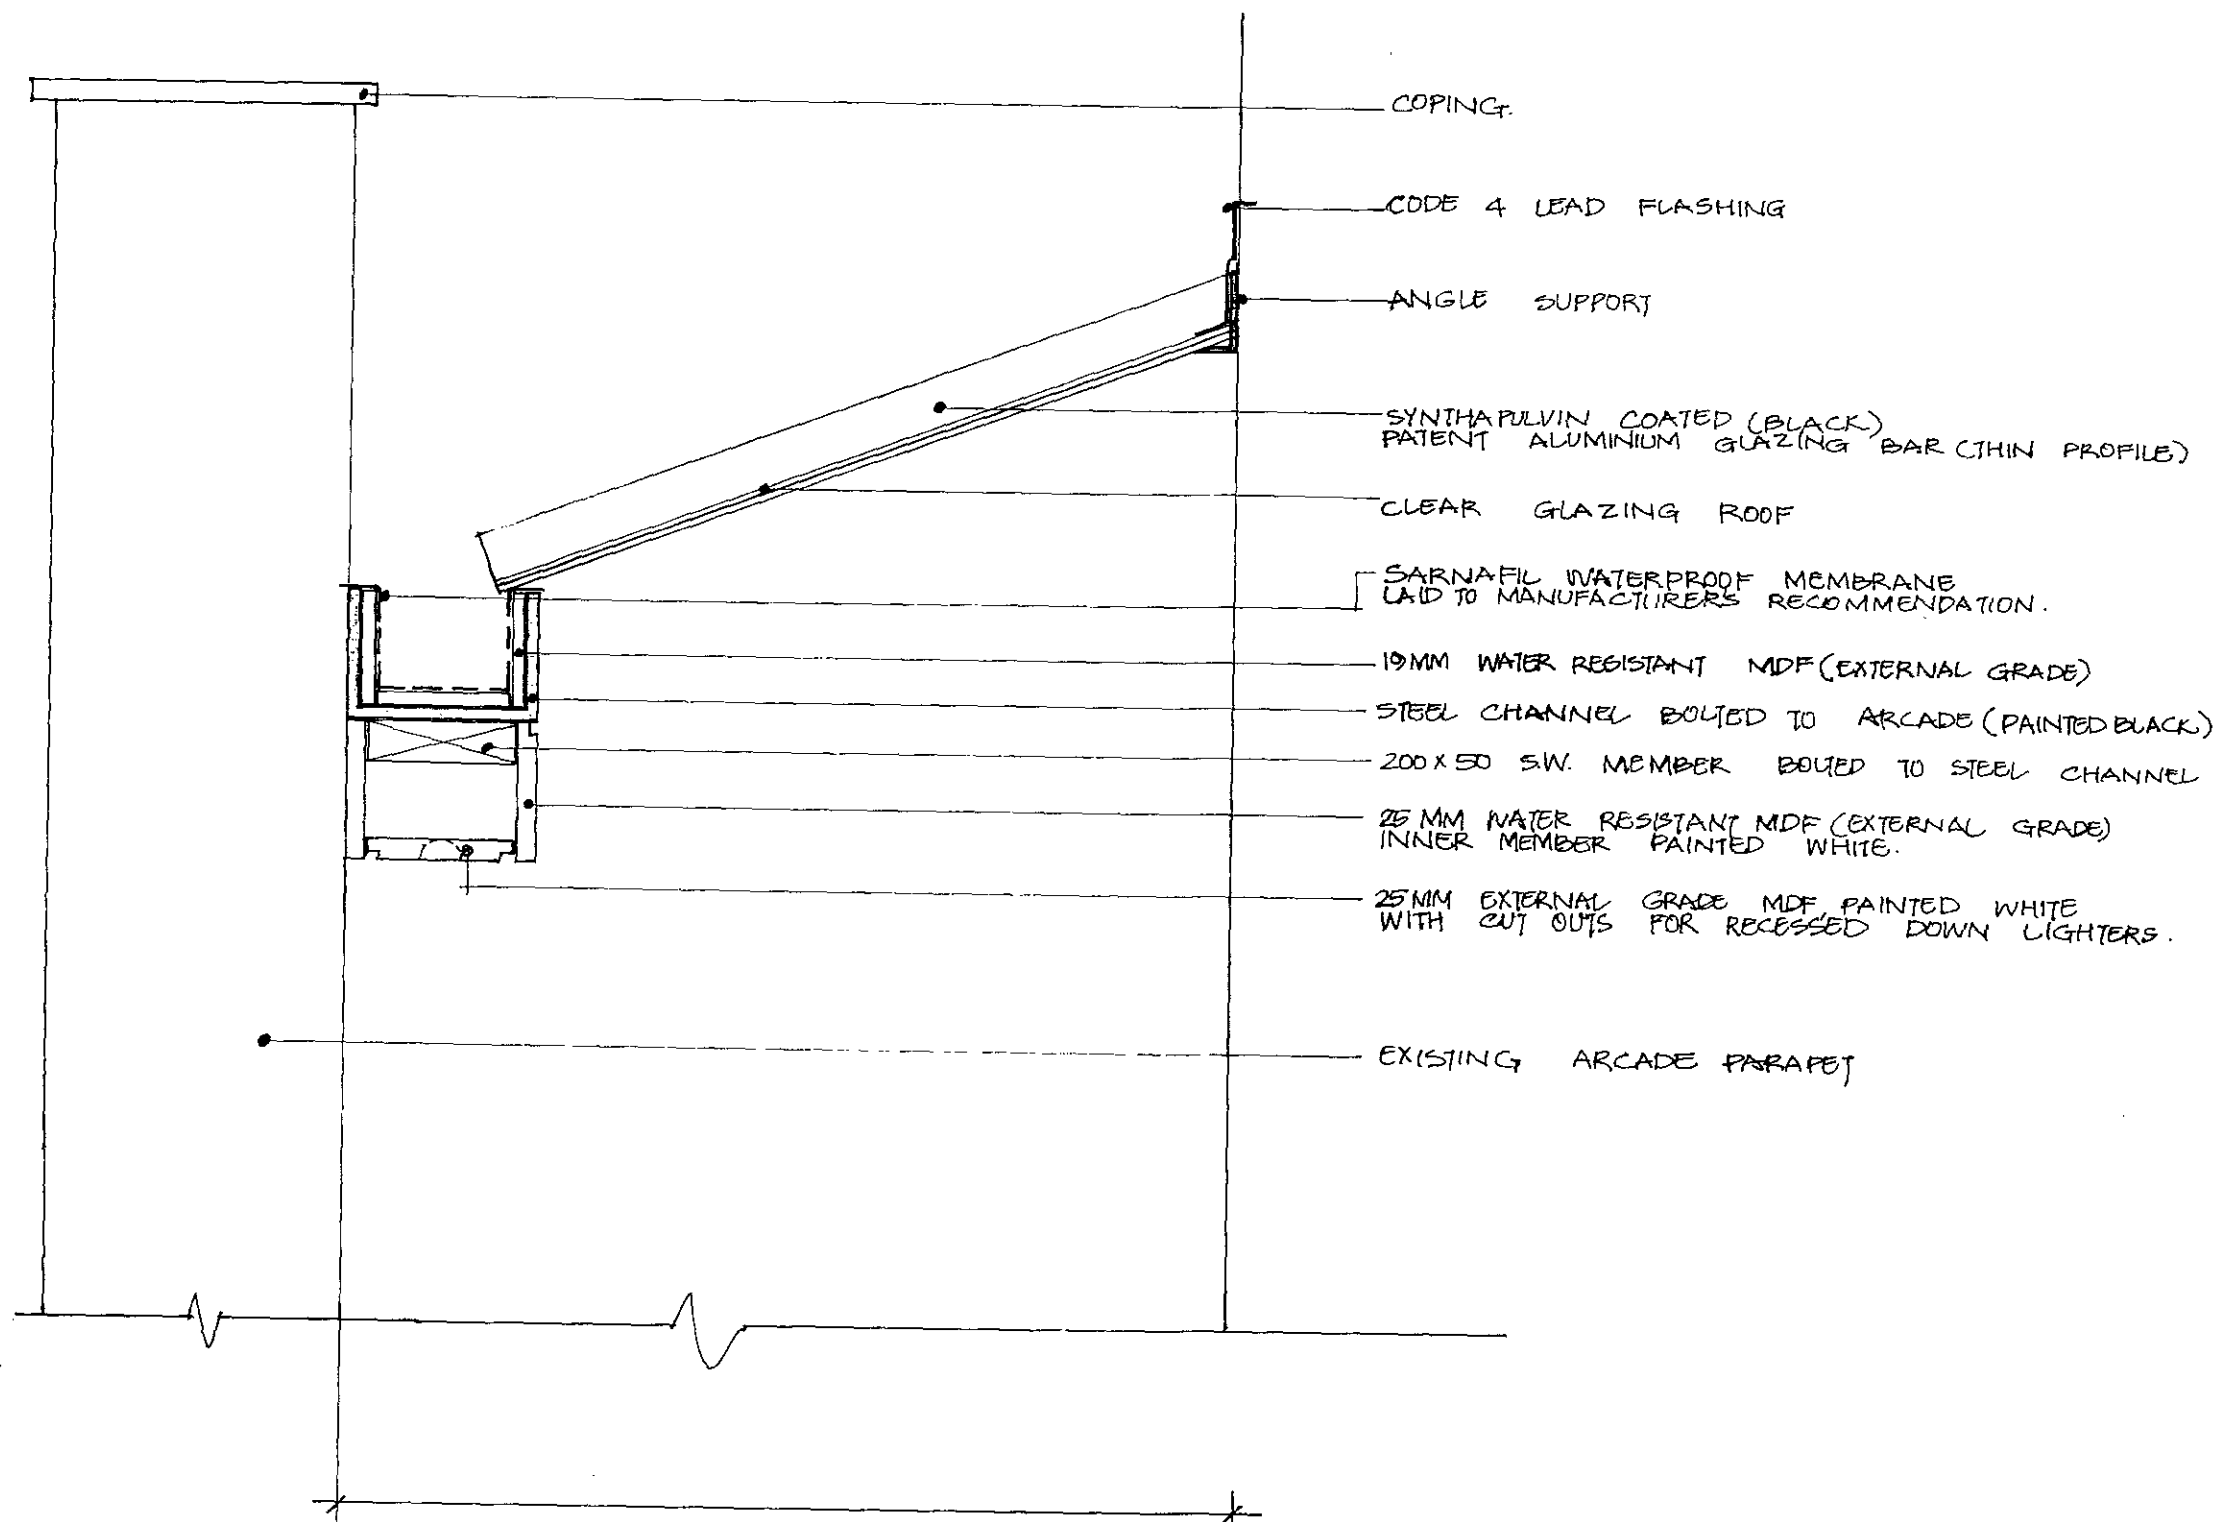



SECTION SCALE 1:10

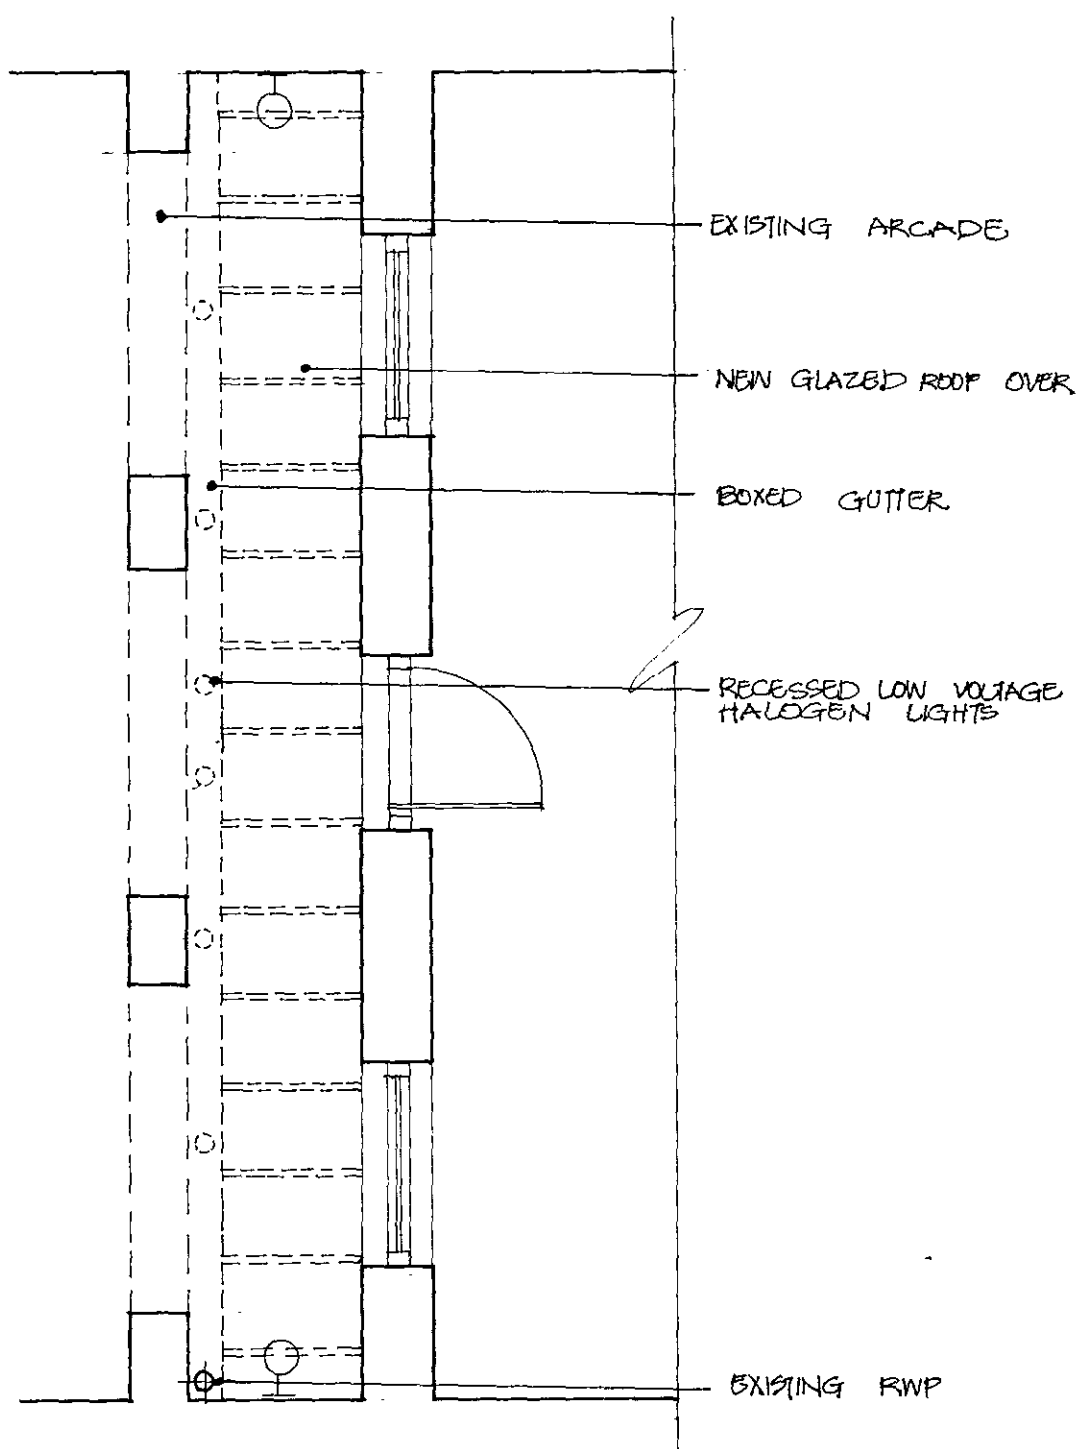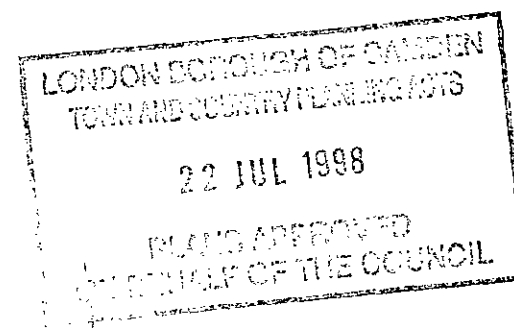

PLAN

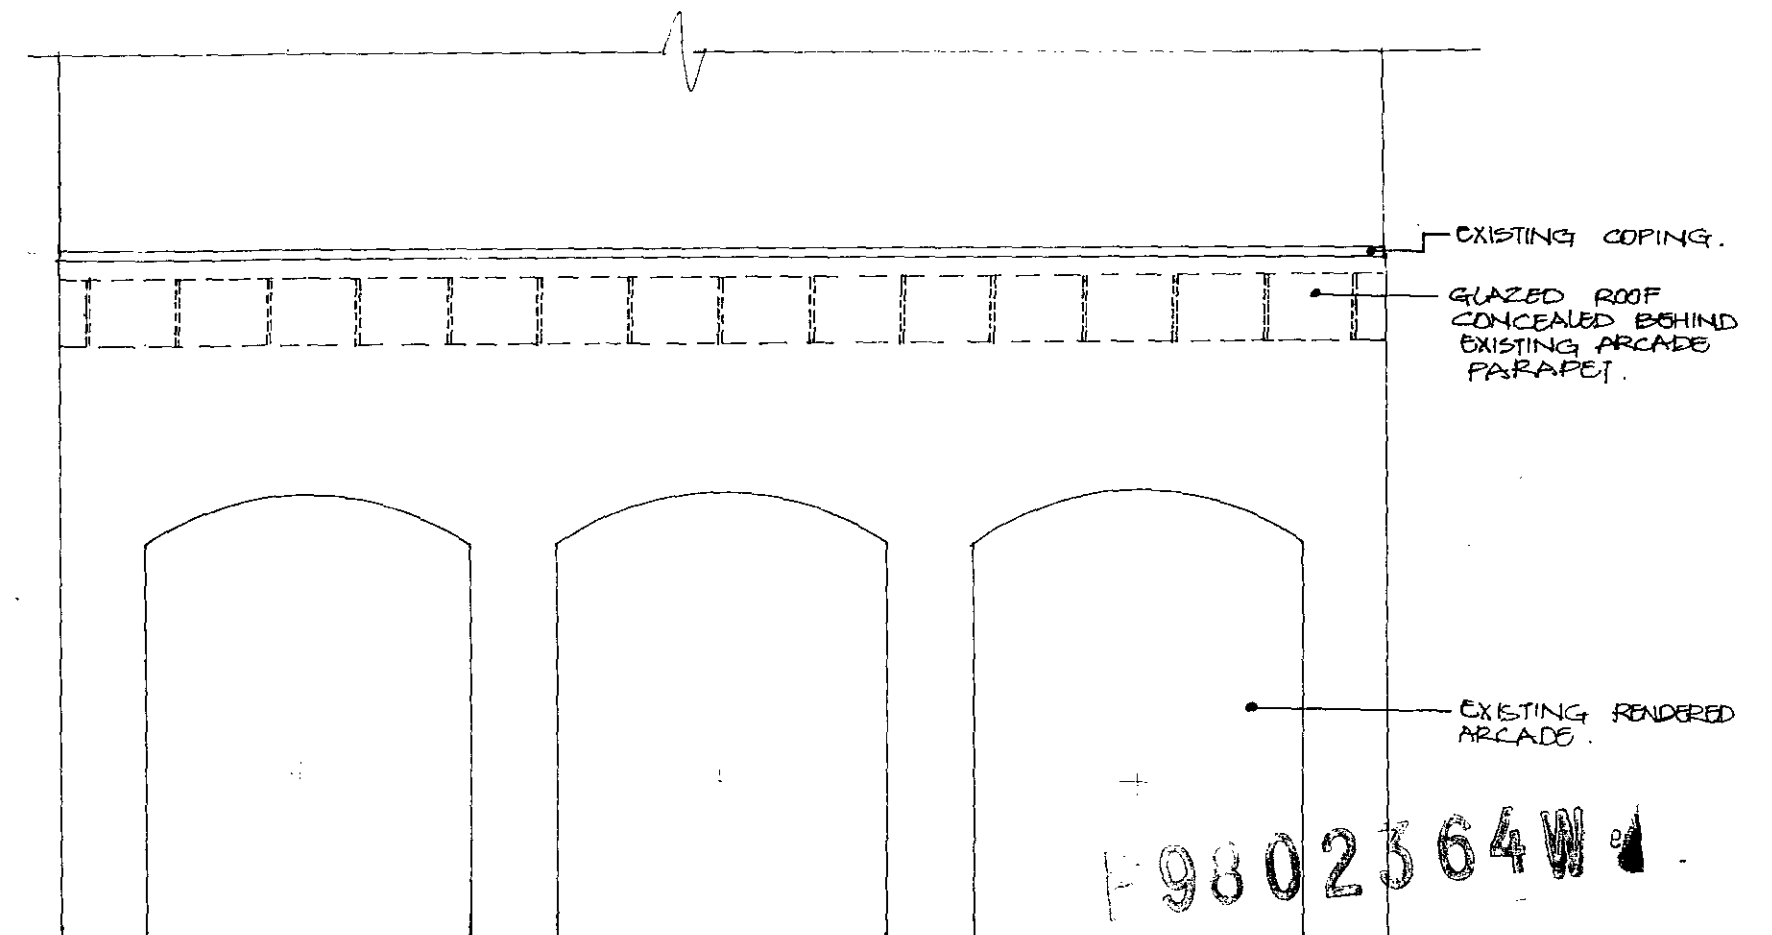

ELEVATION

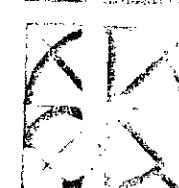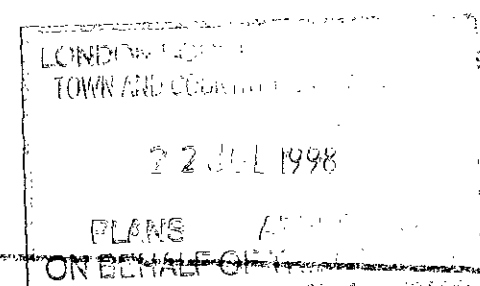

8 NEW END ROAD

LONDON NW3

GLAZED ROOF COVERING TO LOGGIA

CLARKE
KEEN &
CHALCHURI
ARCHITECTS

22 04 98

1:50 / 1:10

NBK

REVISIONS

A	2	3	5	3	P	D	1	0	2
---	---	---	---	---	---	---	---	---	---





REVISIONS



NOTES

ALL DIMENSIONS TO BE CHECKED ON SITE
DO NOT SCALE DRAWING

145 mm x 145 mm
(200 mm x 200 mm)
145 mm x 145 mm
= 15 mm x 15 mm

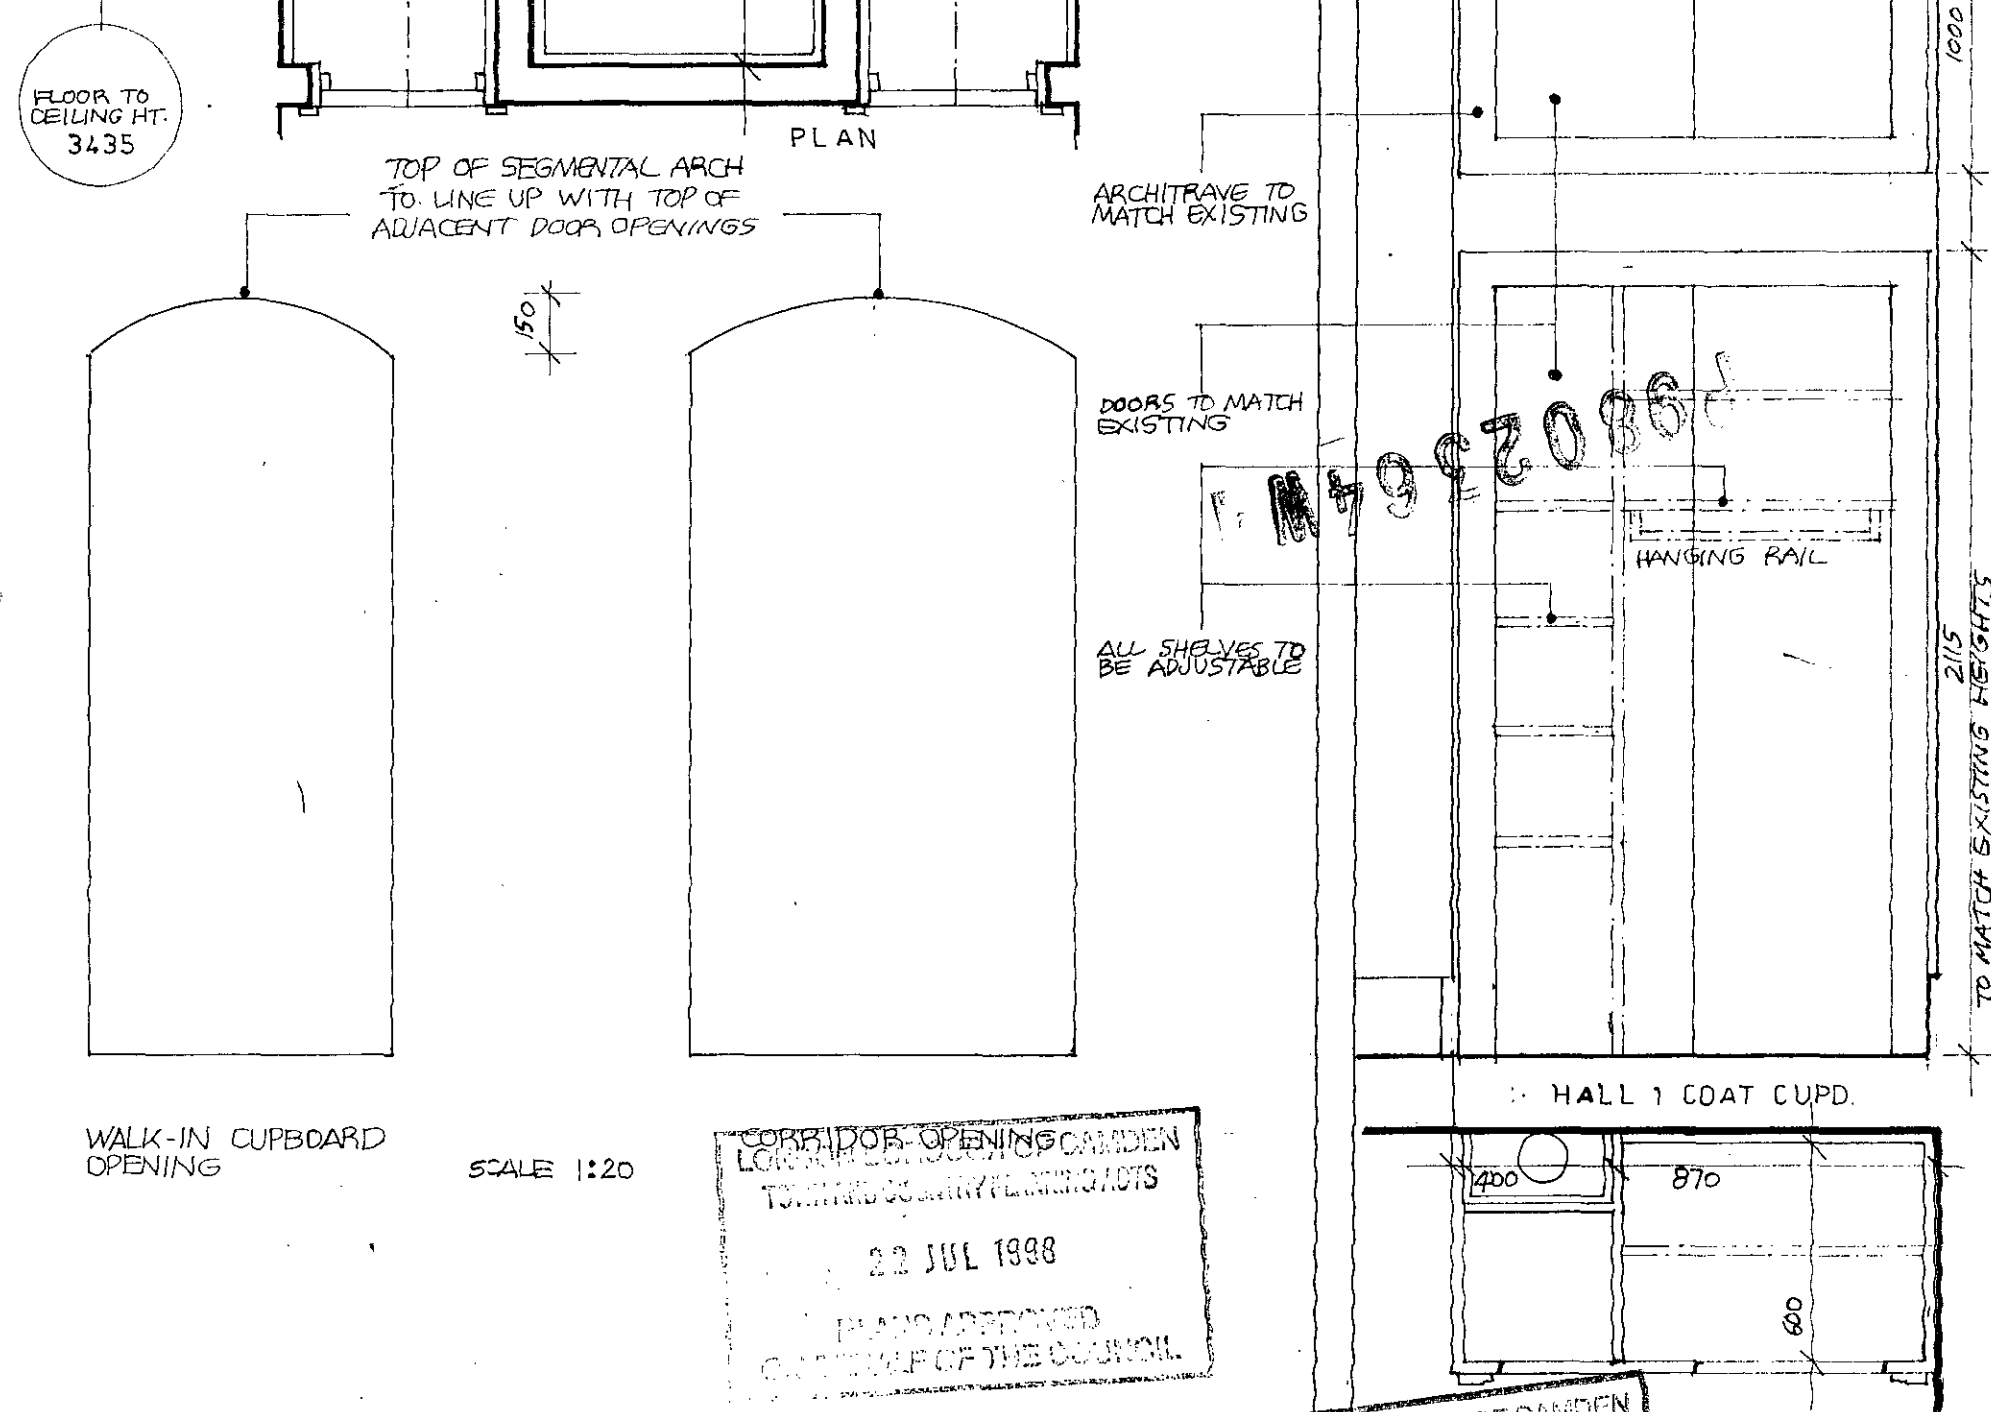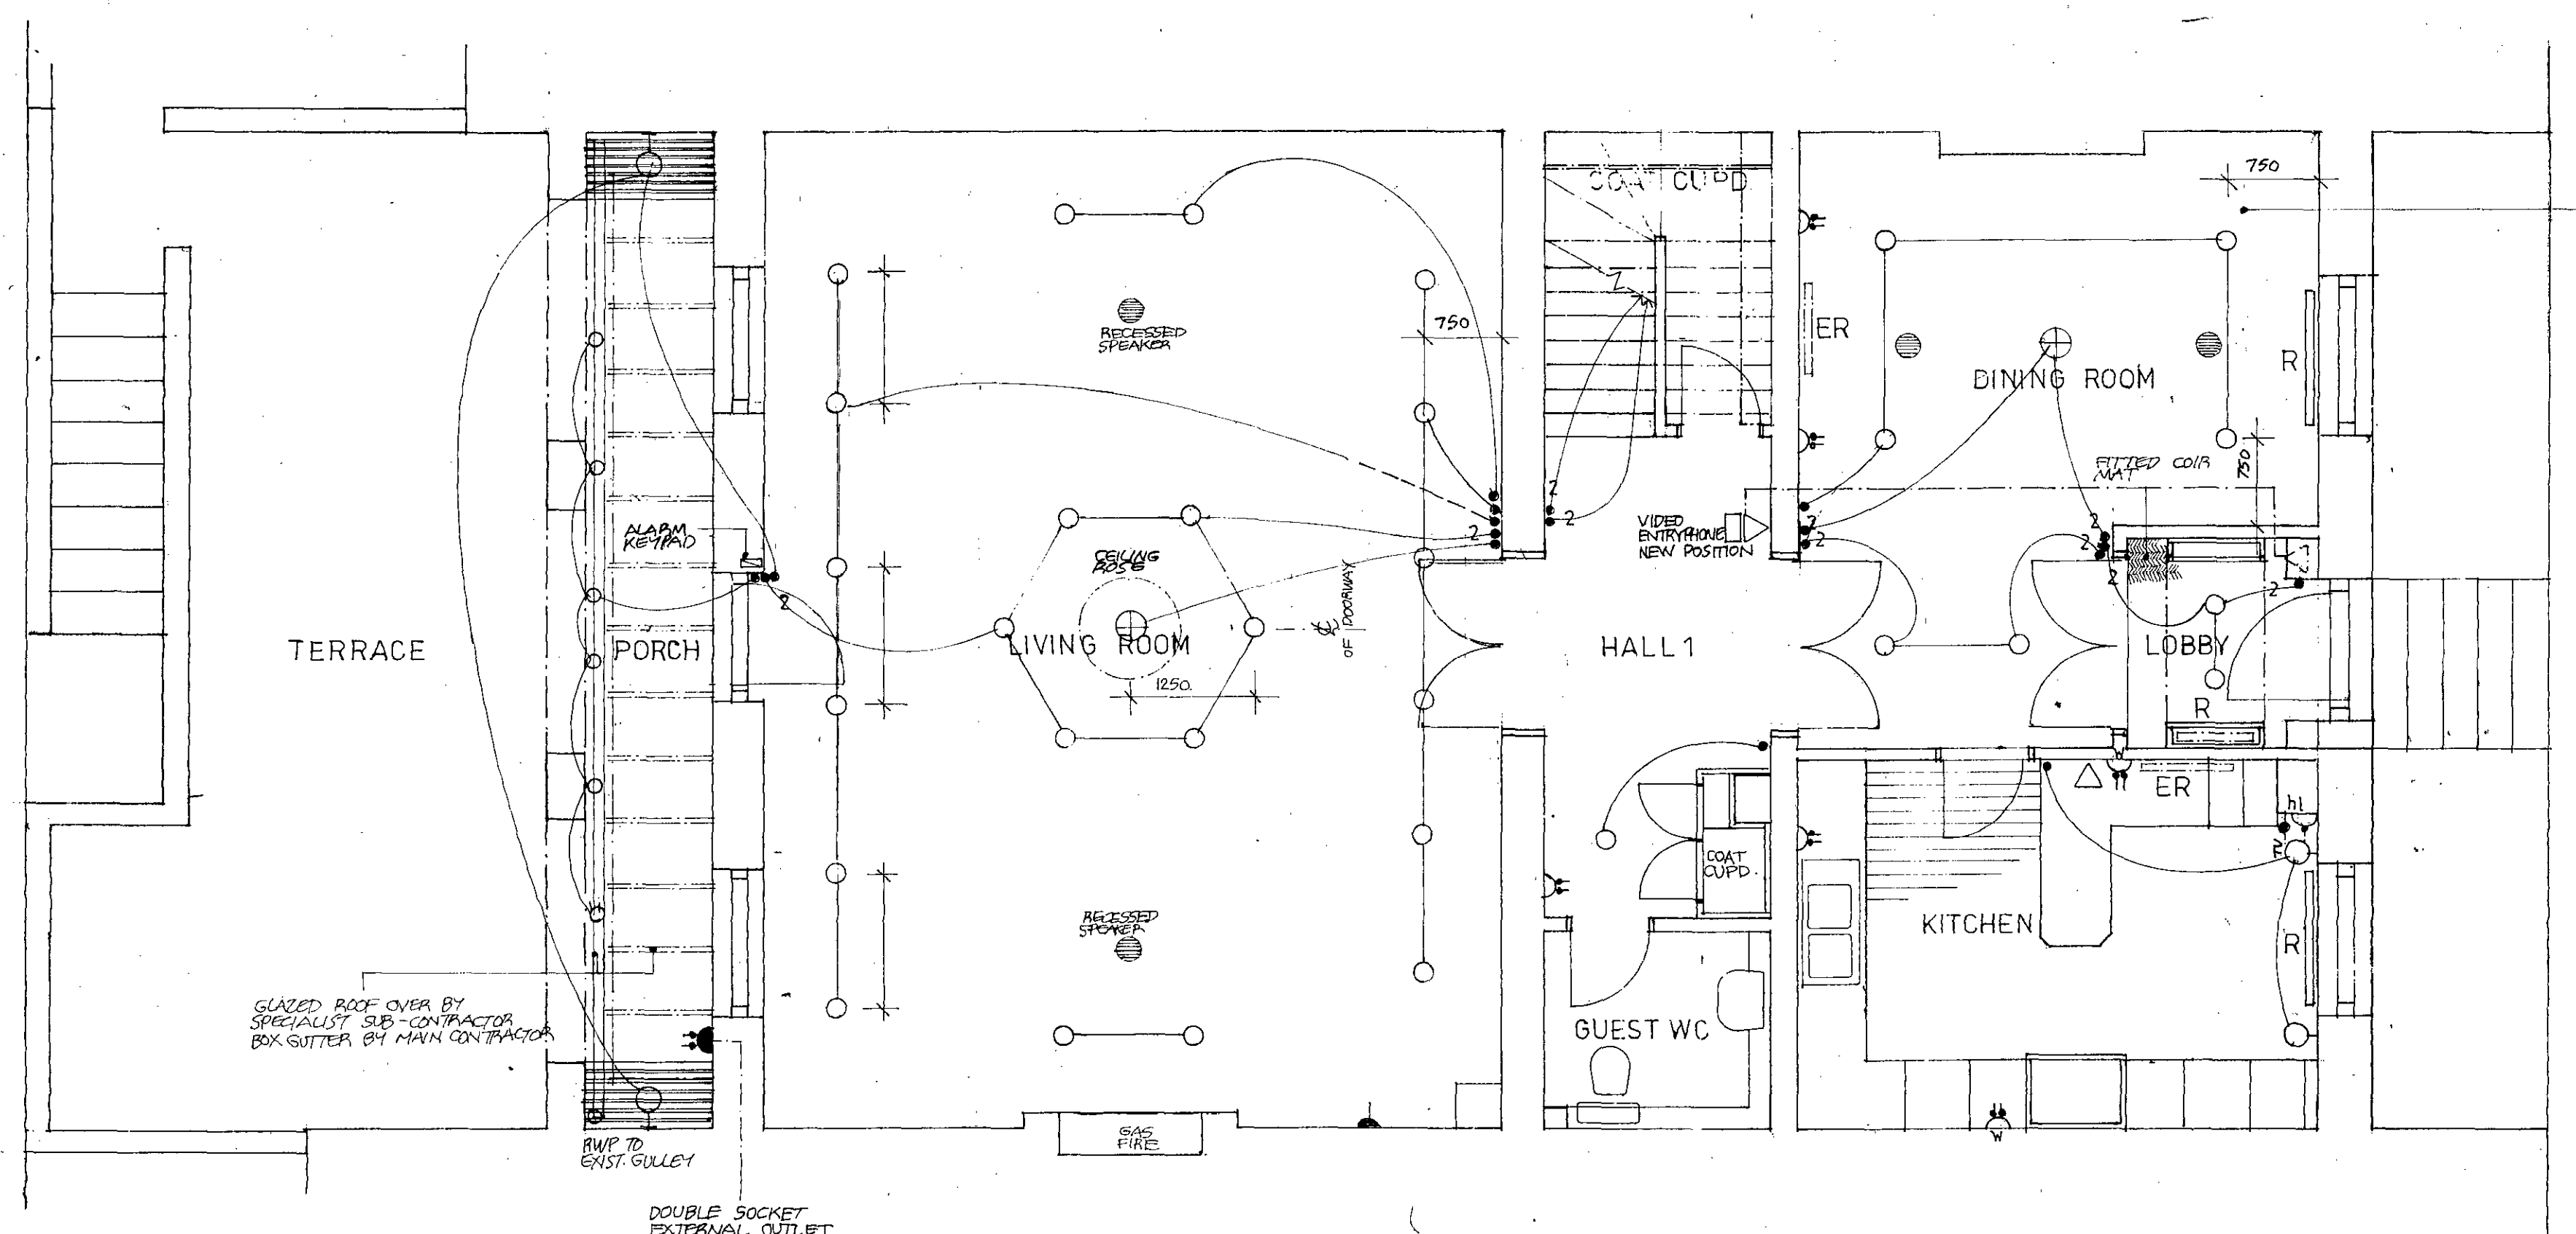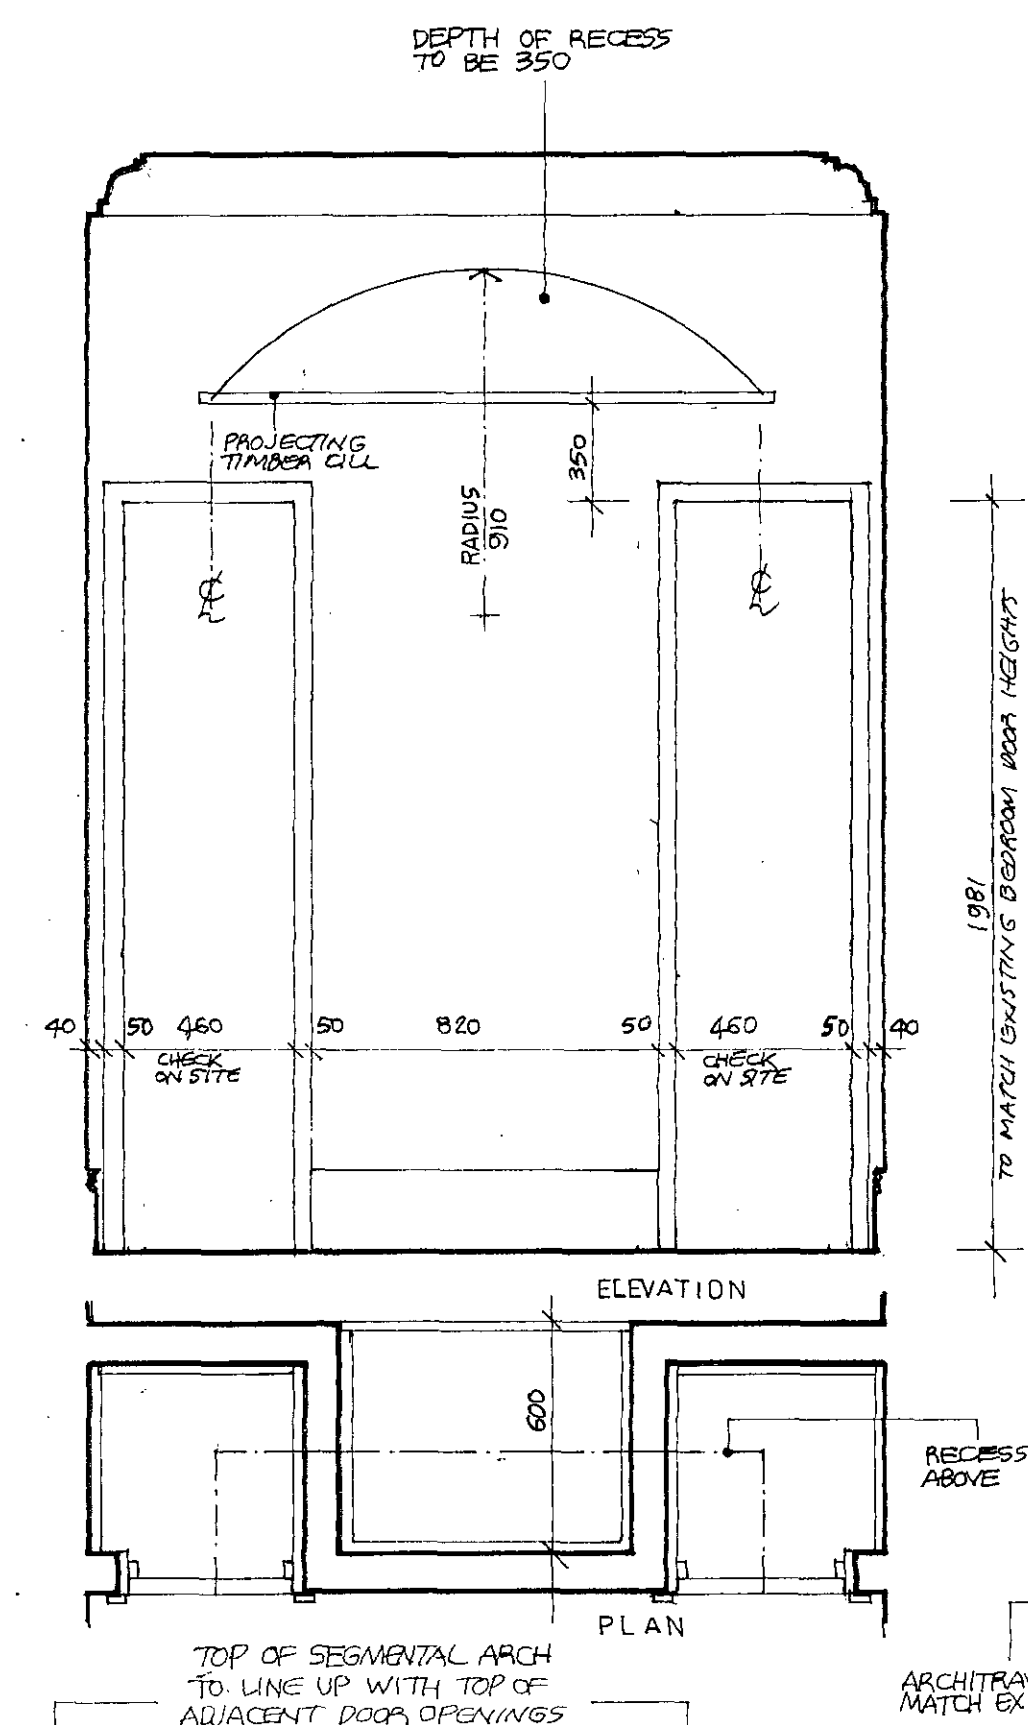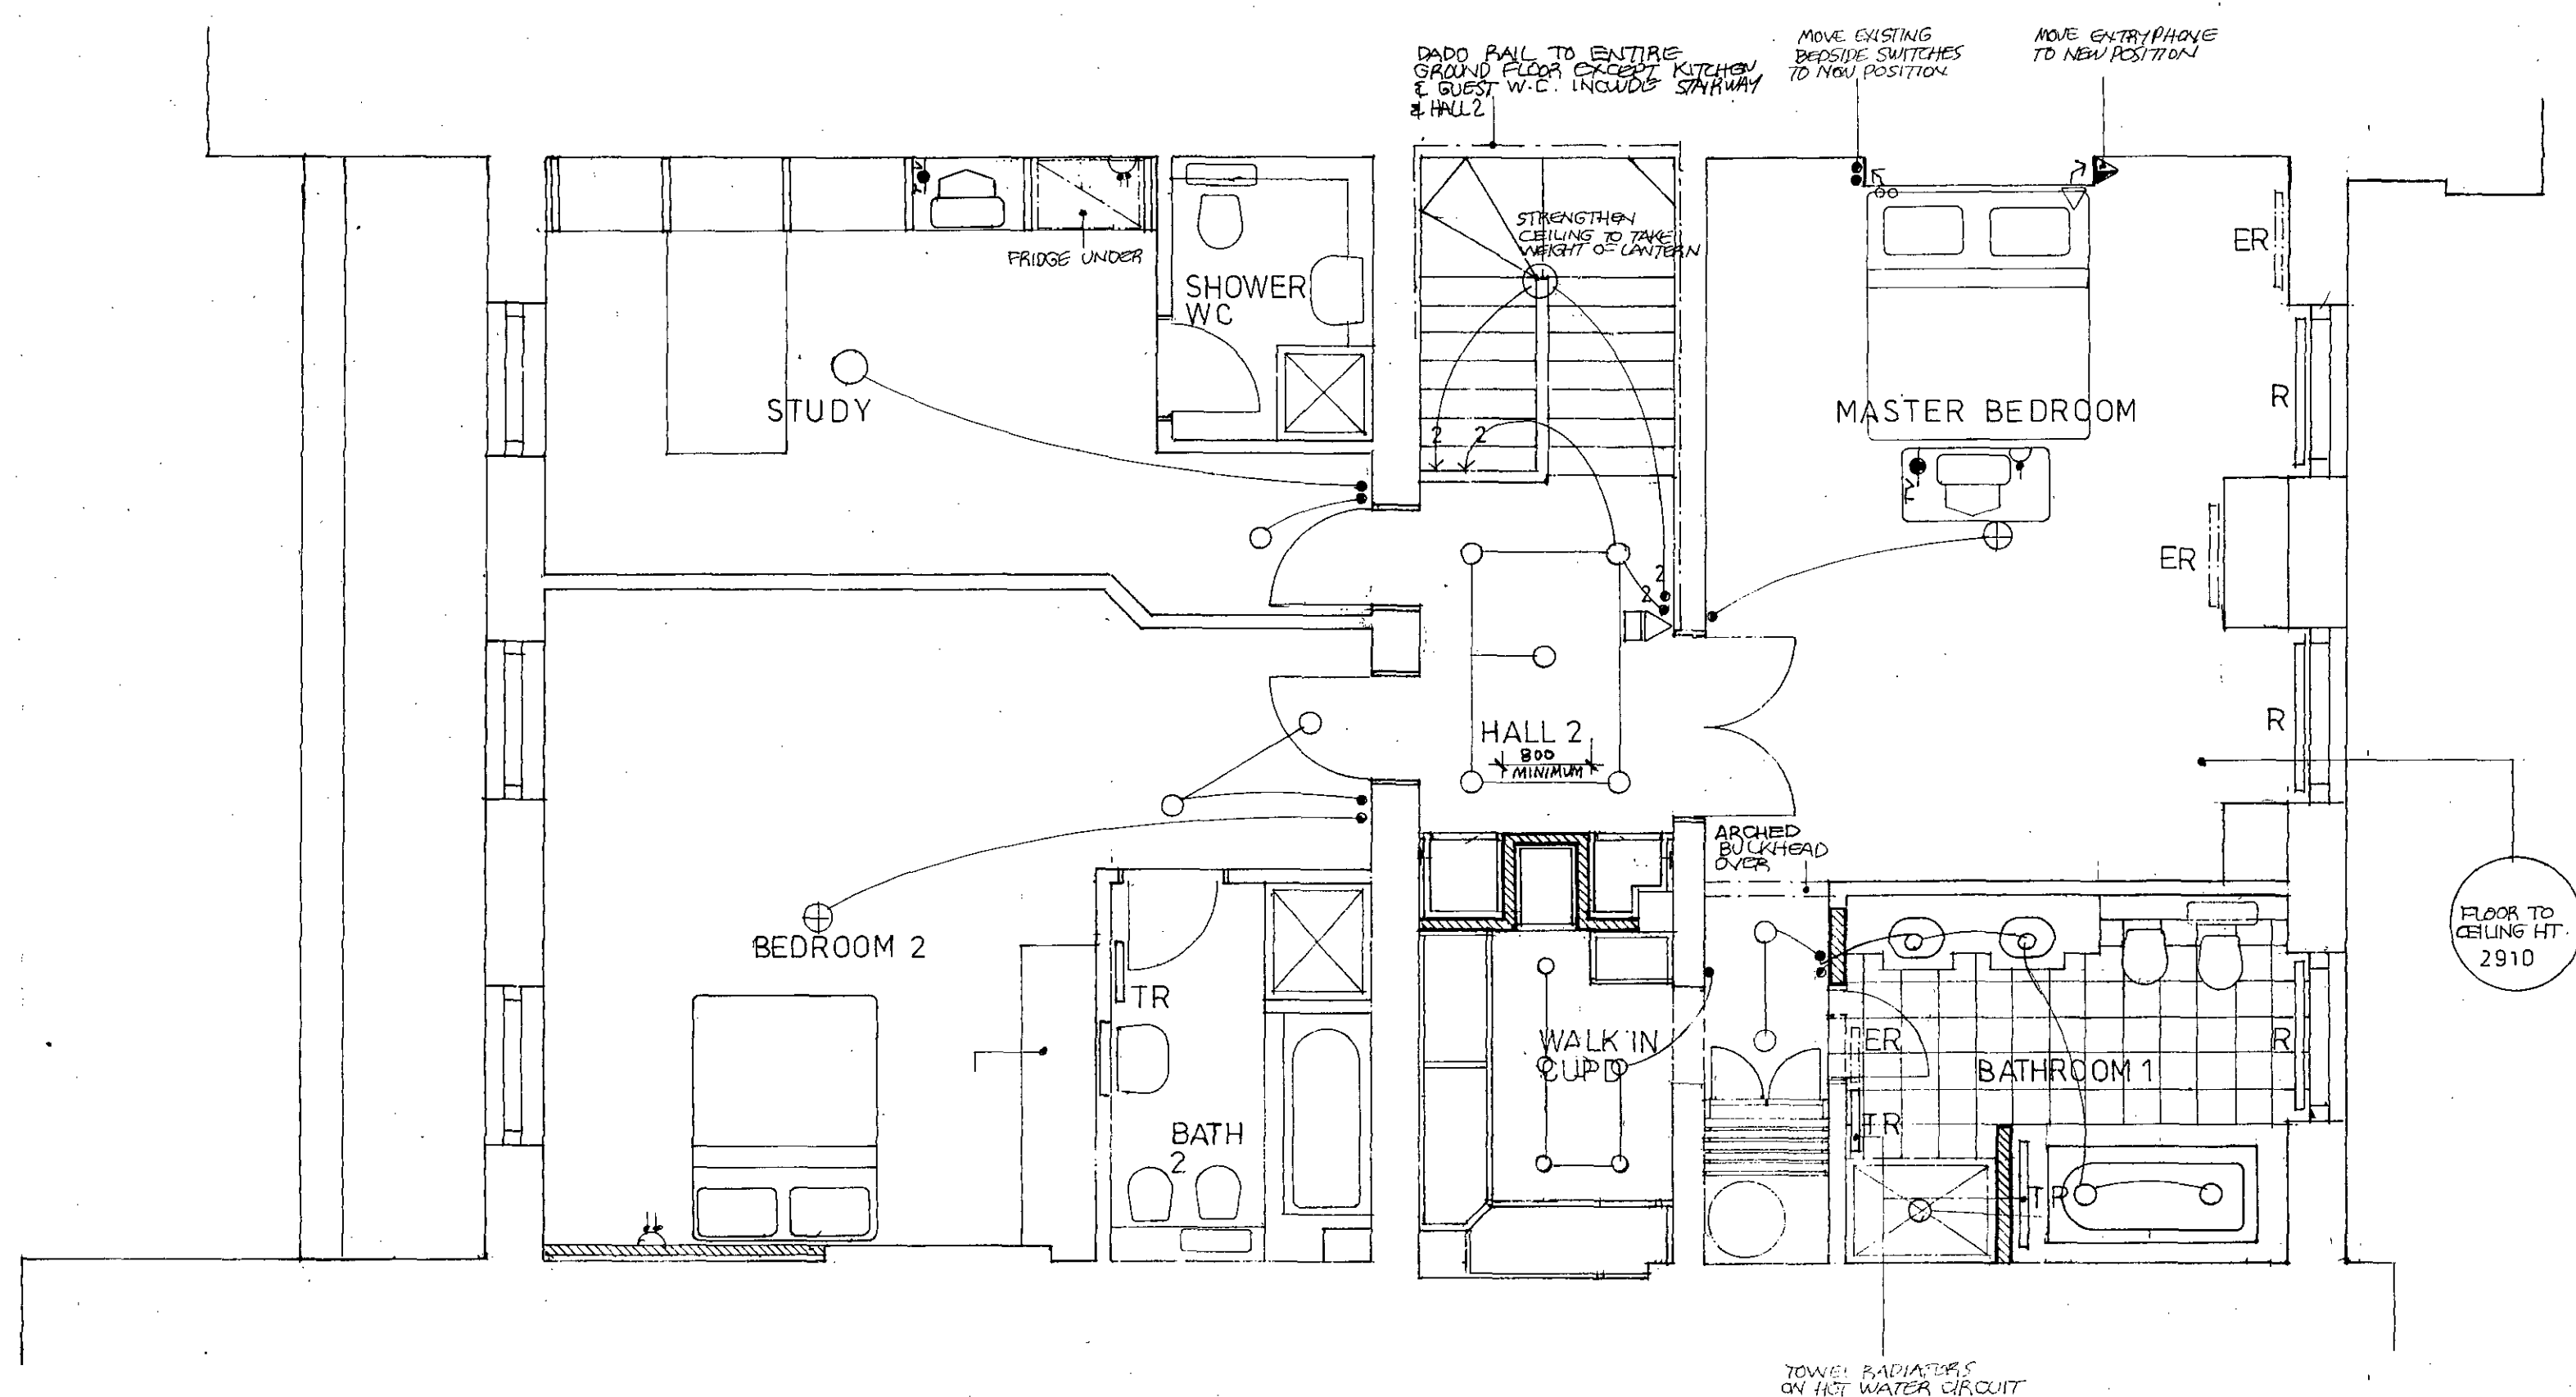

KEY TO ELECTRICAL SYMBOLS

GENERAL REFERENCES		PREFIX REFERENCES	
	partition removed	 CE	cleaning eye
	new stud partition	 GU	gully
	new blockwork	 ET	brick built-in gully
	new brickwork	 WS	water stopcock
	new cavity wall	 DR	drinking tap
	new brick opening	 ER	EXISTING RADIATOR TO BE REMOVED
	new brick opening		
	new stud opening		
	fireplace bricked in		
	gas point	 CW	cold water tank
	gas meter	 ET	expansion test tank
	radiator	 WS	water stopcock
	heated towel rail	 DR	drinking tap
	gas-fired boiler		
	ensuing drainage		
	new down-pipe		
	new wastes		
	hot water cylinder		

NO	DATE	REVISIONS		
A	11-11-98	ELECTRICAL ADD'D DRAWING COMPLETED	F	3-2-98 HALL 2 FITTING DEPICTED
B	26-1-98	ADD ITEMS AS PER CLIENT REQUEST AT MEETING HELD ON 22-1-98	G	
C	9-1-98	DRAWING TITLE ALTERED FROM EXISTING PLANS TO PROPOSALS		
D	16-2-98	LIGHTING LAYOUT TO LIVING ROOM ALTERED. ADD LIGHTS TO DINING ROOM. ADD RADIATOR TO HALL 2 REMOVE CURD. NIB. TO BEDROOM 2.		
E	17-2-98	ARCHES INDICATED, PART LIGHTING ALTERED, ETC.		

 CLARKE KEINE & CHAUDHURI ARCHITECTS	JOB TITLE 8 NEW END RDAD NW3	TOWN AND COUNTRY 22 JUL 1998	
	DRAWING TITLE PROPOSALS	PLANNING PERMISSION DRAWING NUMBER 123456789	
DATE - SD 7.11.97	DATE - PD 1.50	DRAWN BY <i>Henry Klein</i>	REVISION NUMBER ABDEF6
5 DRYDEN STREET, COVENT GARDEN, LONDON WC2N 6WG. TELEPHONE 01 829 8460			THIS DRAWING IS THE PROPERTY OF CLARKE KEINE & CHAUDHURI ARCHITECTS