



NOTES

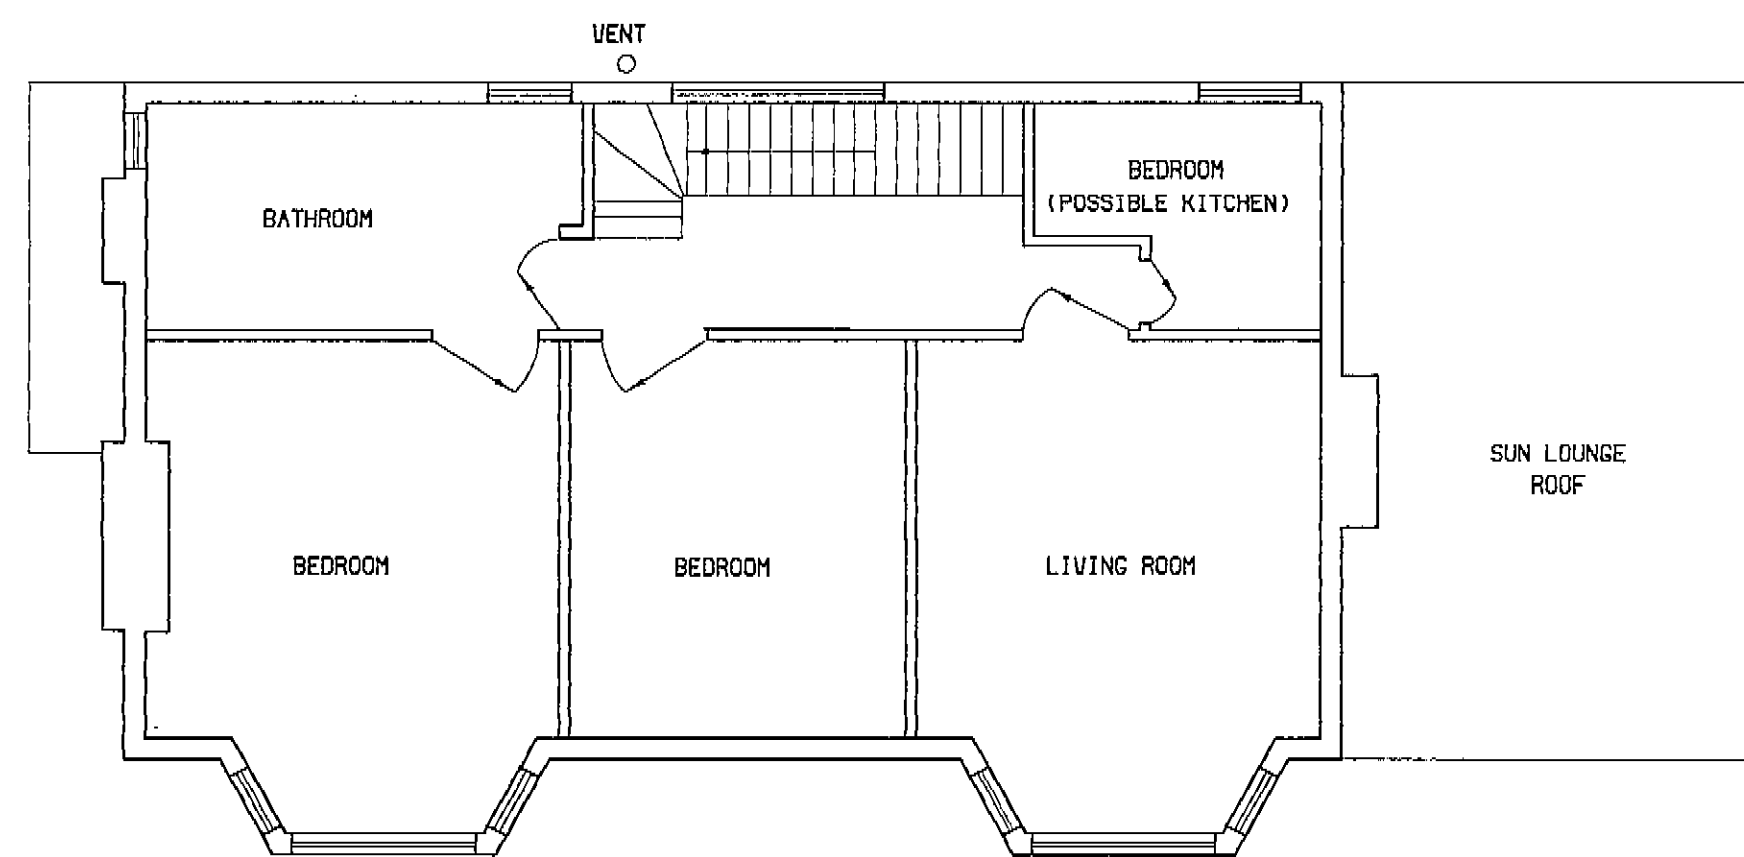


FIRST FLOOR

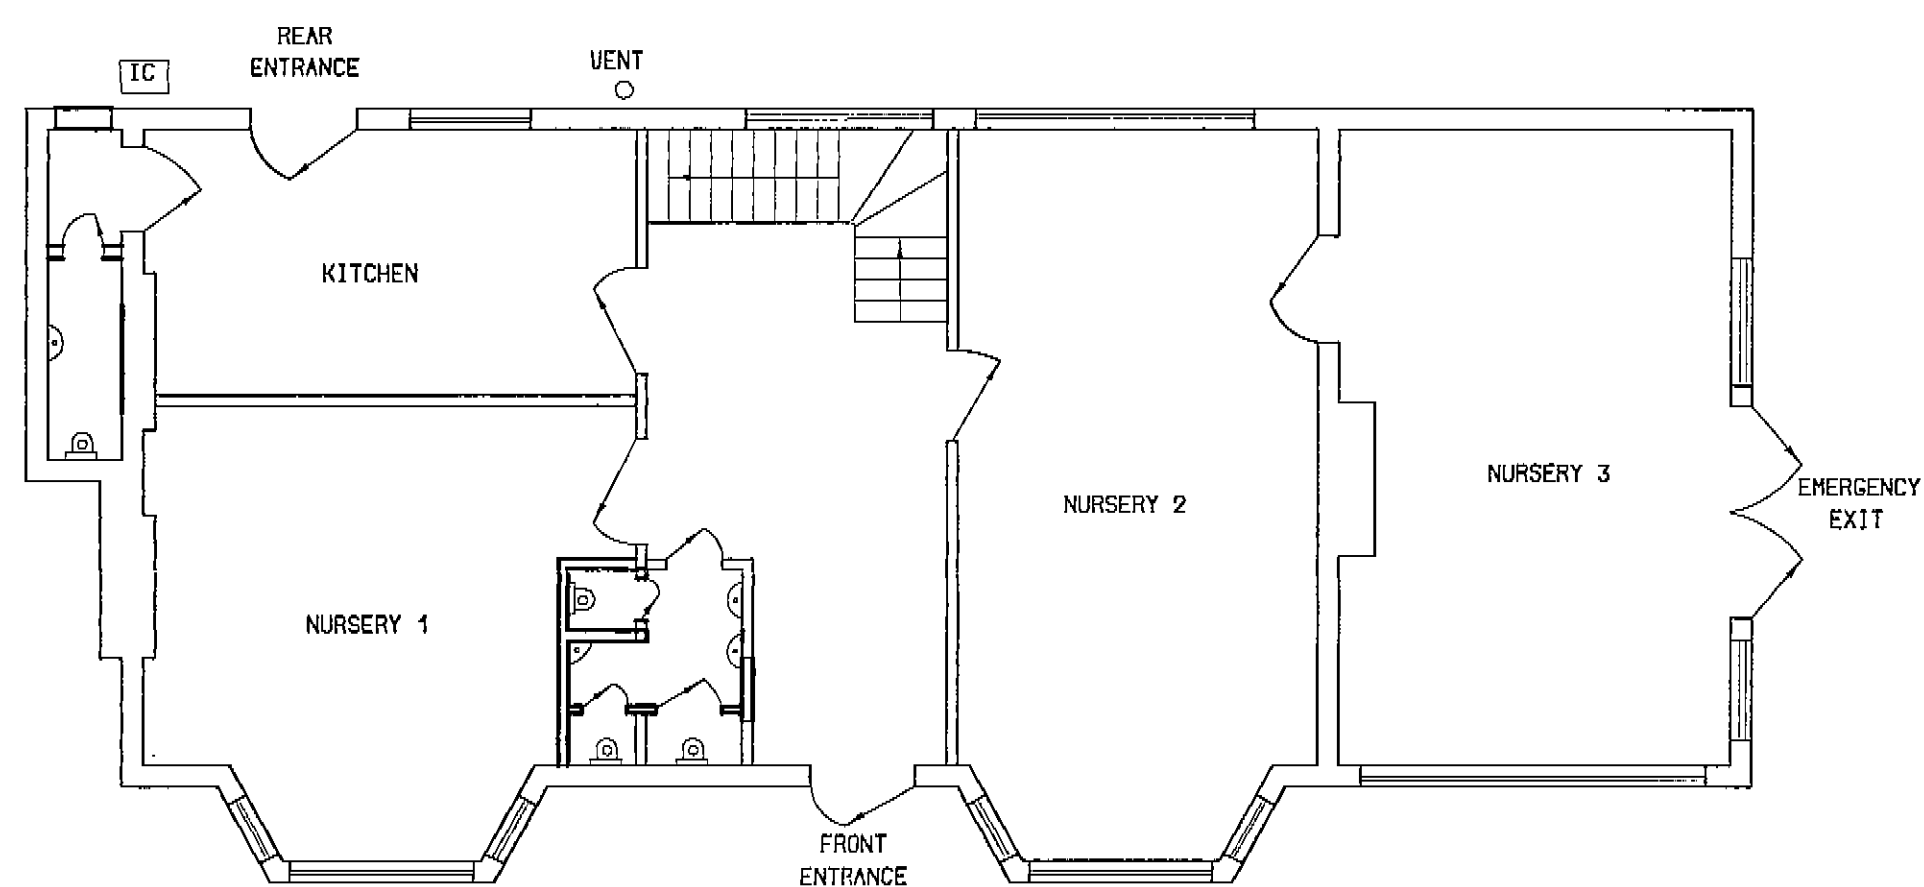

GROUND FLOOR



FRONT ELEVATION

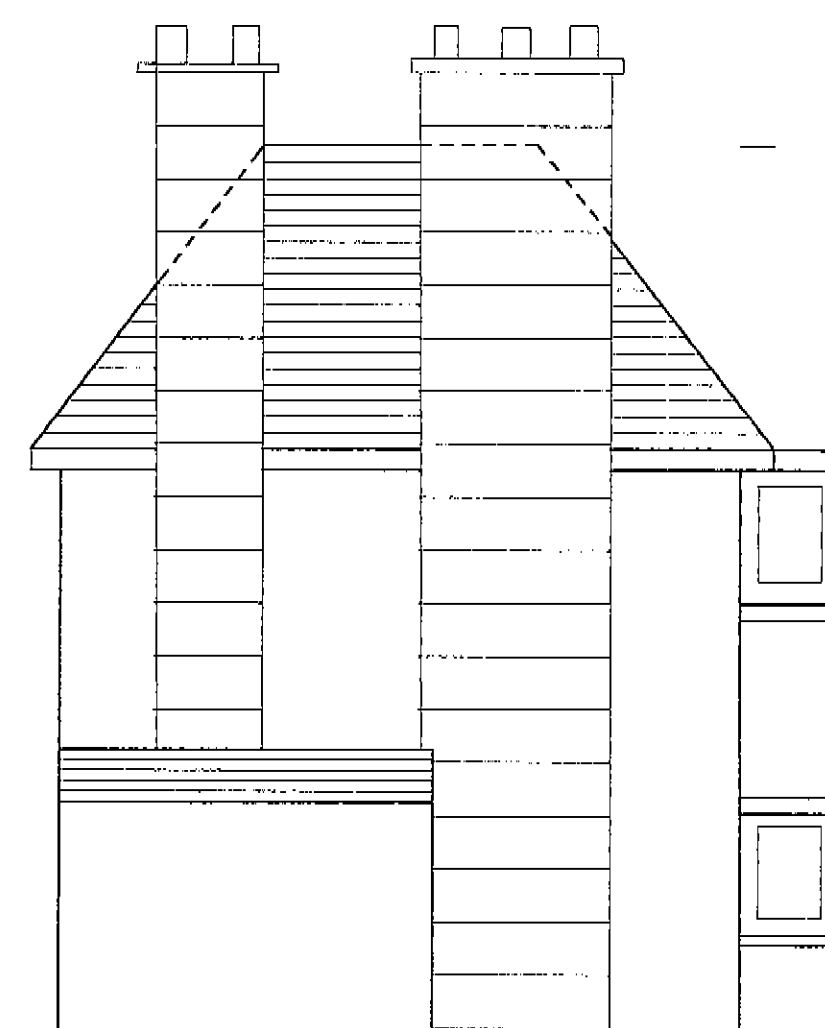

SIDE ELEVATION 'A'

REFERENCE DRAWINGS

DDC. CLASS		X	REC. No		X
JB/E/C APPROVAL	CLIENT				
	PROJECT MANAGER				
	PROJECT ENGINEER				
	SAFETY				
	PIPELINES				
	VESSELS				
	PIPING				
	PROCESS				
	INSTRUMENTS				
	MECHANICAL				
ELECTRICAL					
CIVIL					

SUBMITTED TO	'APPROVED' OR 'REVISE'	INITIALS	DATE

JOHN BROWN

John Brown Engineers & Constructors Ltd.
70 Froisbourne Terrace
London W2 6LE

PROJECT:

TITLE:

80, WESTBERE ROAD
WEST HEMSTEAD
LONDON NW2

ISSUE	DRN	ISSUE	DRN	ISSUE	DRN	ISSUE	DRN	ISSUE	DRN	SCALE:	DRAWN BY:	CHECKED BY:	APPROVED BY:	DRAWING NO.	ISSUE
•	CHK	•	CHK	•	CHK	•	CHK	•	CHK	7:50	"			MN / 002	X