
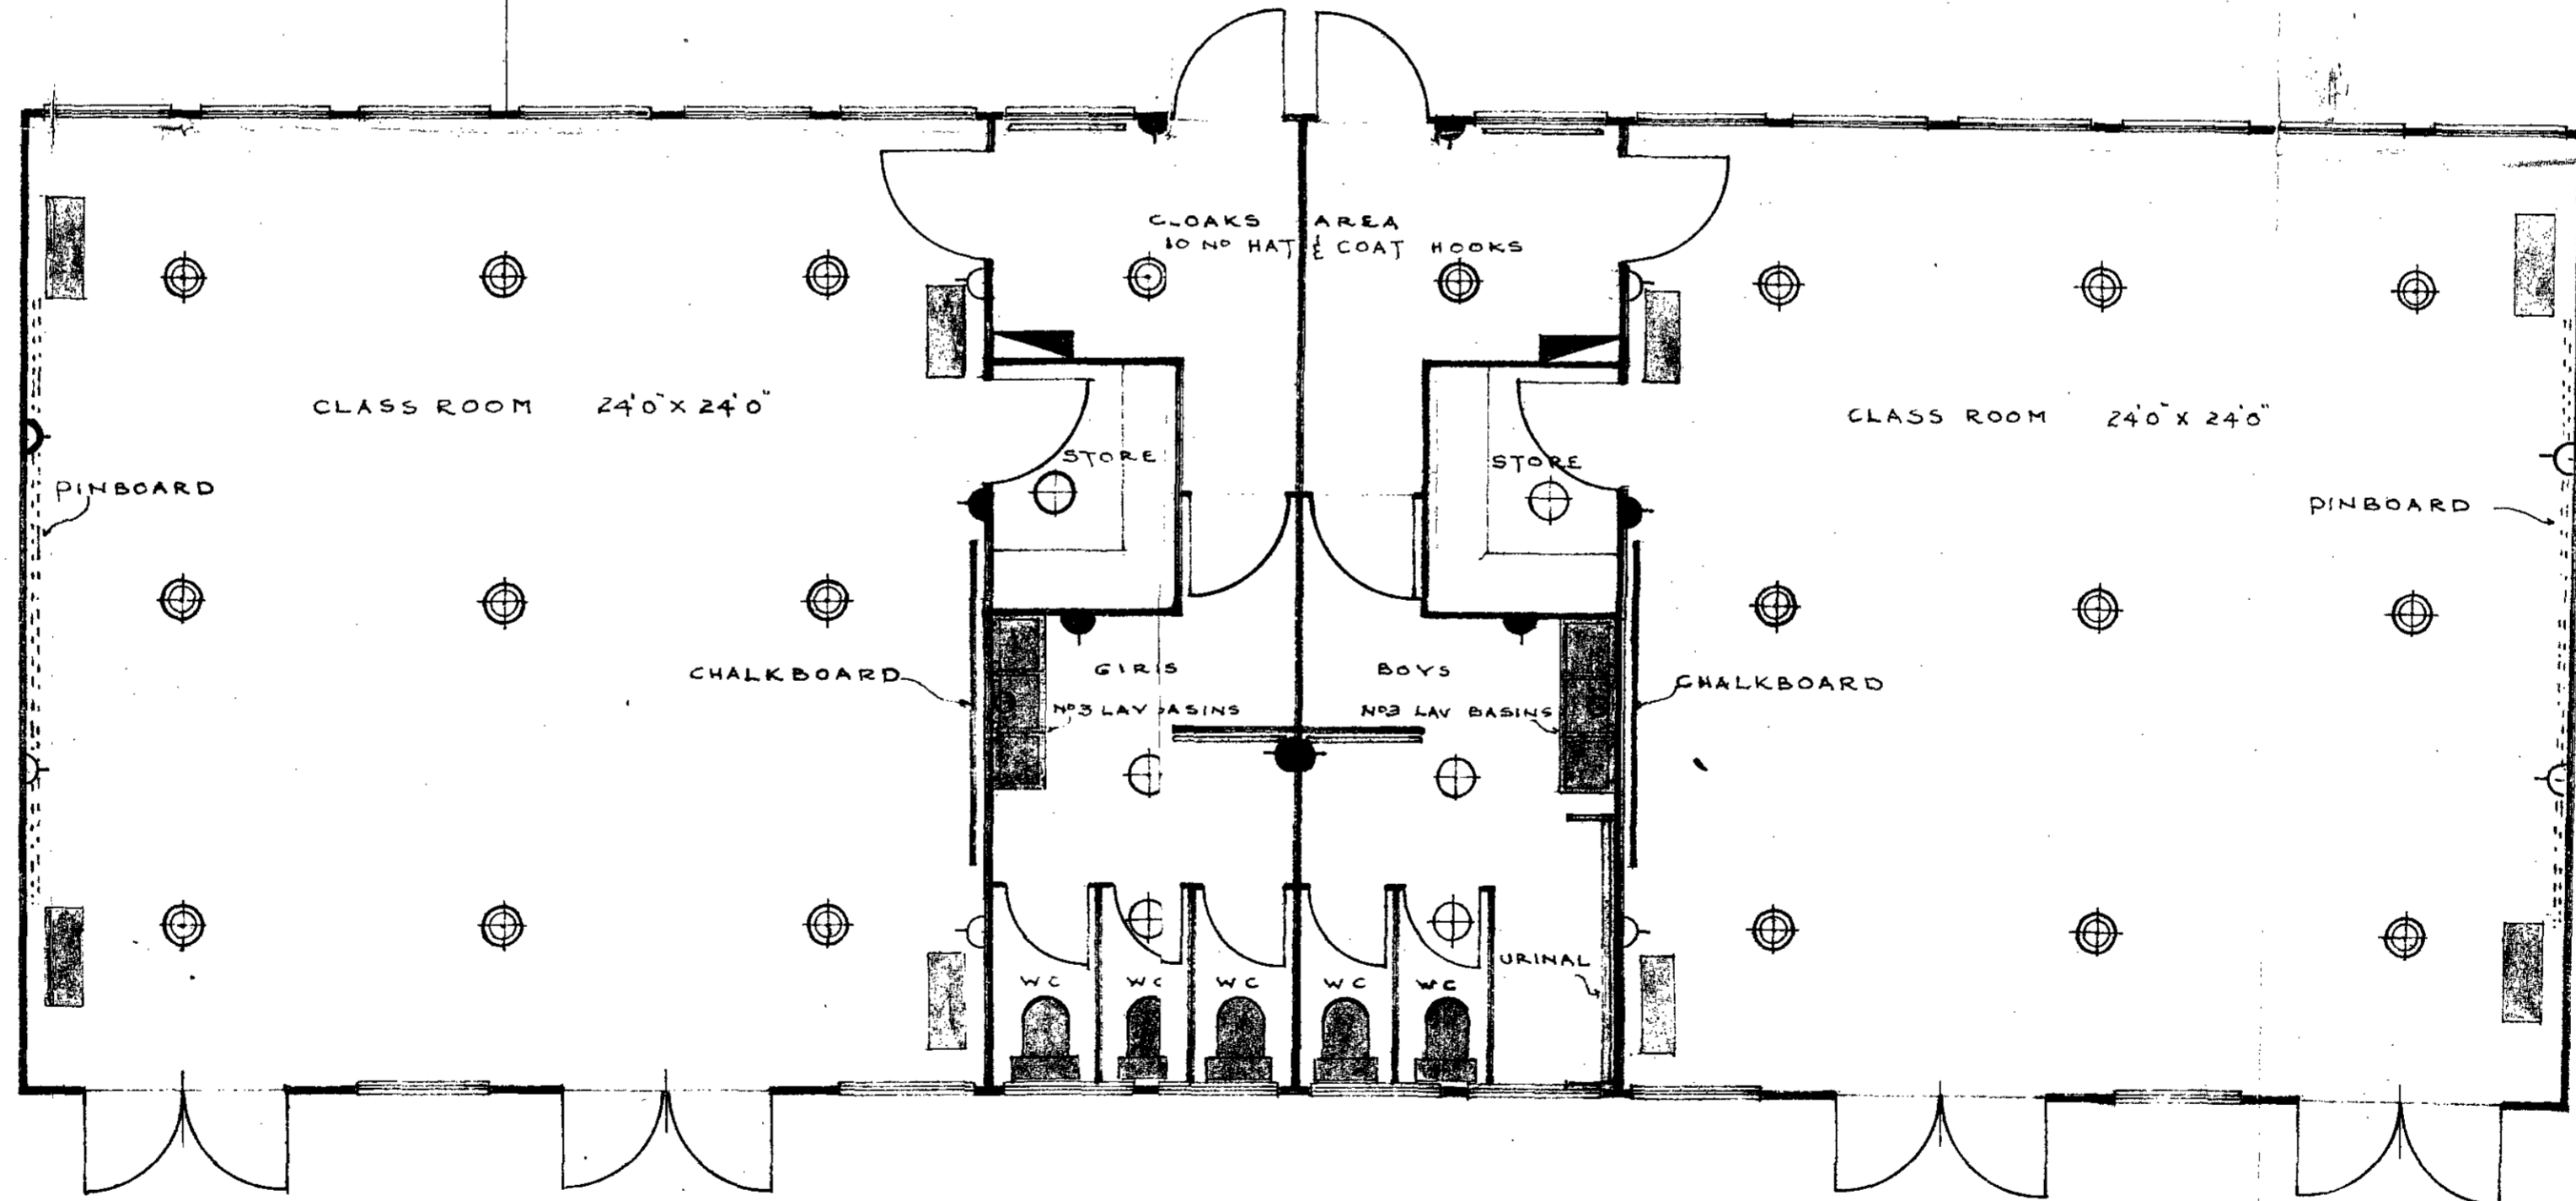



PLAN

- ⊙ HUME ATKINS DIAKON 147c FITTING 5/8" 150WT
- ⊕ 9" COOLICON PLASTIC SHADE 5/8" 100WT
- ⊖ 15 AMP SWITCHED SOCKET OUTLET
- ⊙ 15 AMP SWITCHED SOCKET OUTLET
- ▭ 2 1/2 KW EKCO WM 25 CONVECTOR HEATER
- ▭ 1 1/2 KW BELLING ZENITH HEATER
- ▭ CONSUMER CONTROL UNIT
- ⊙ 2.2 GAL SADI'A WATER HEATER

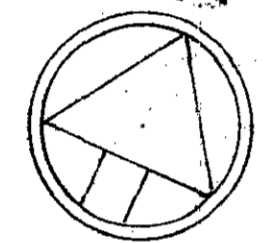

PLAN

SCALE 1" = 4'0"

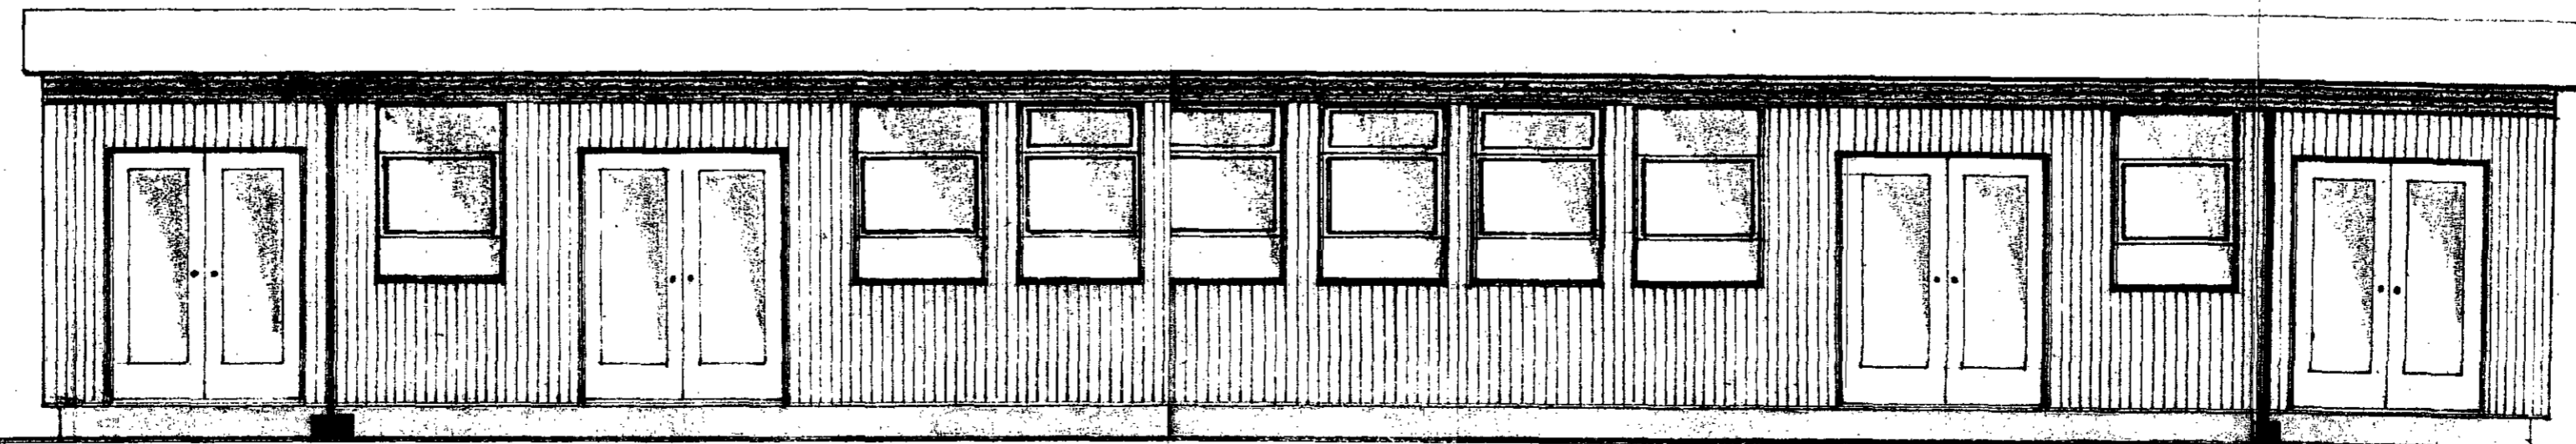

SOUTH ELEVATION

ARCHITECT L.O.O.  
 No. 362  
 10 APR 1963  
 REF TO ACKD.