



11 MARQUIS ROAD, NW1

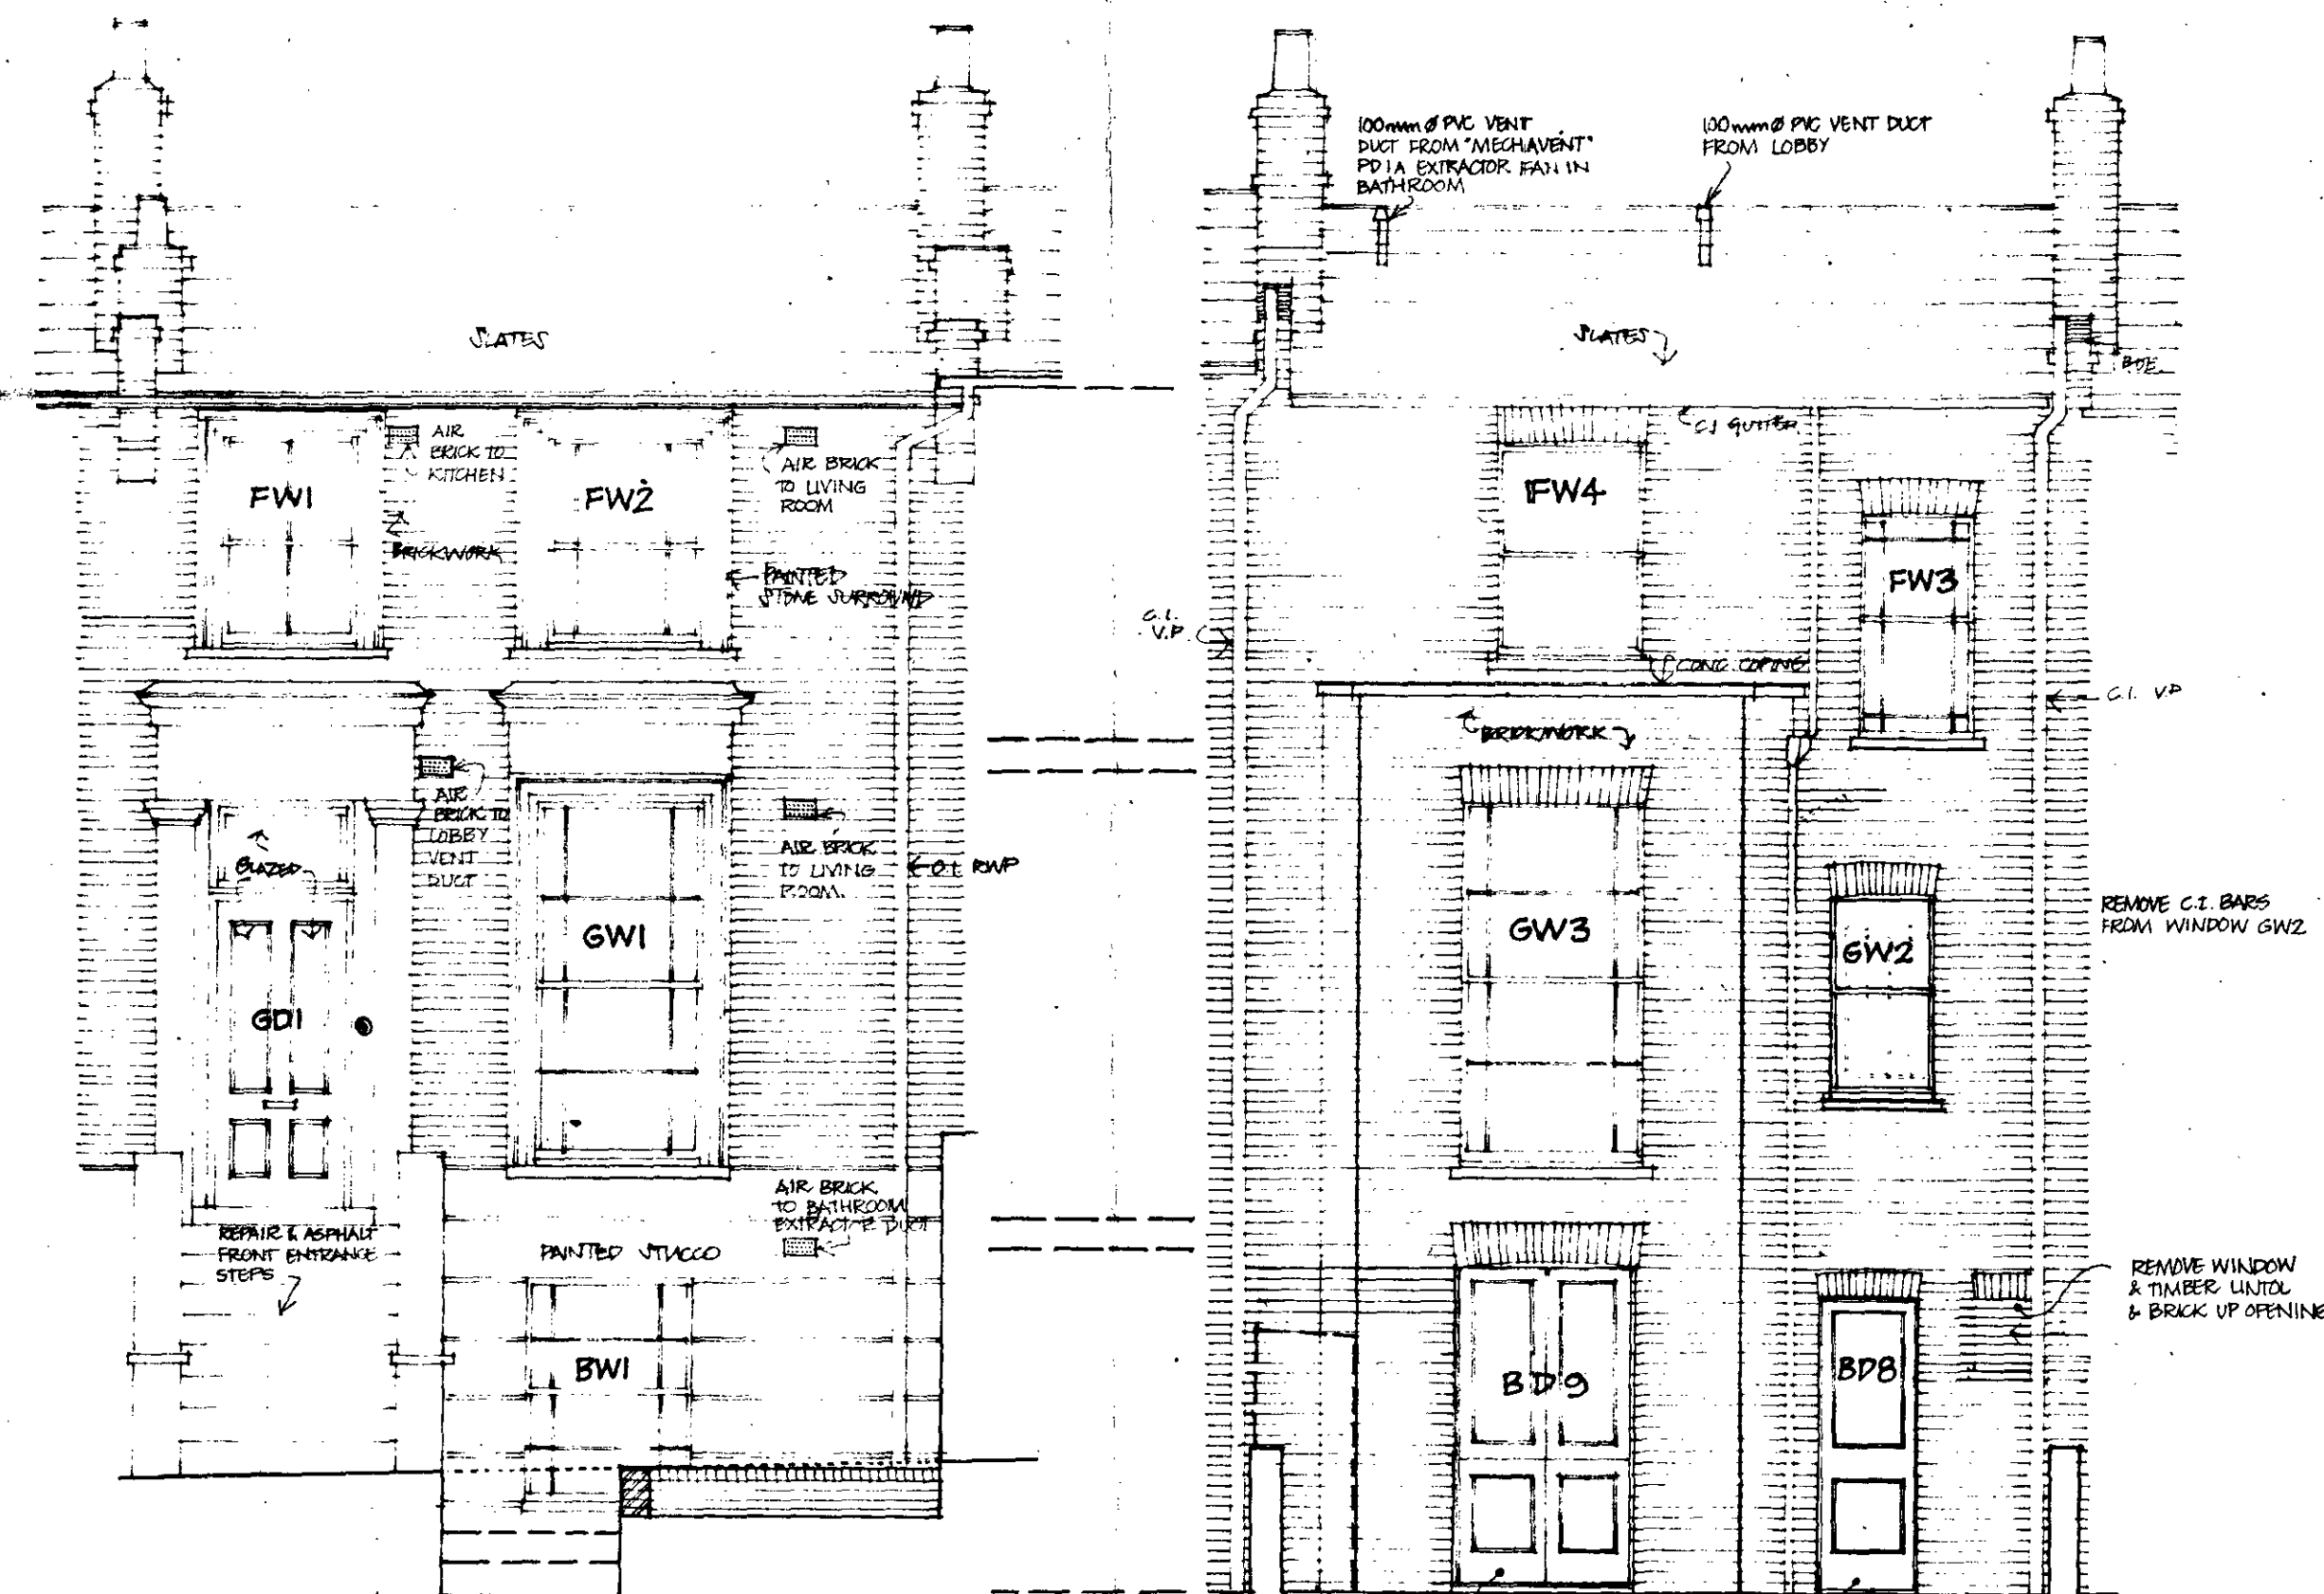

STREET ELEVATION

REAR ELEVATION

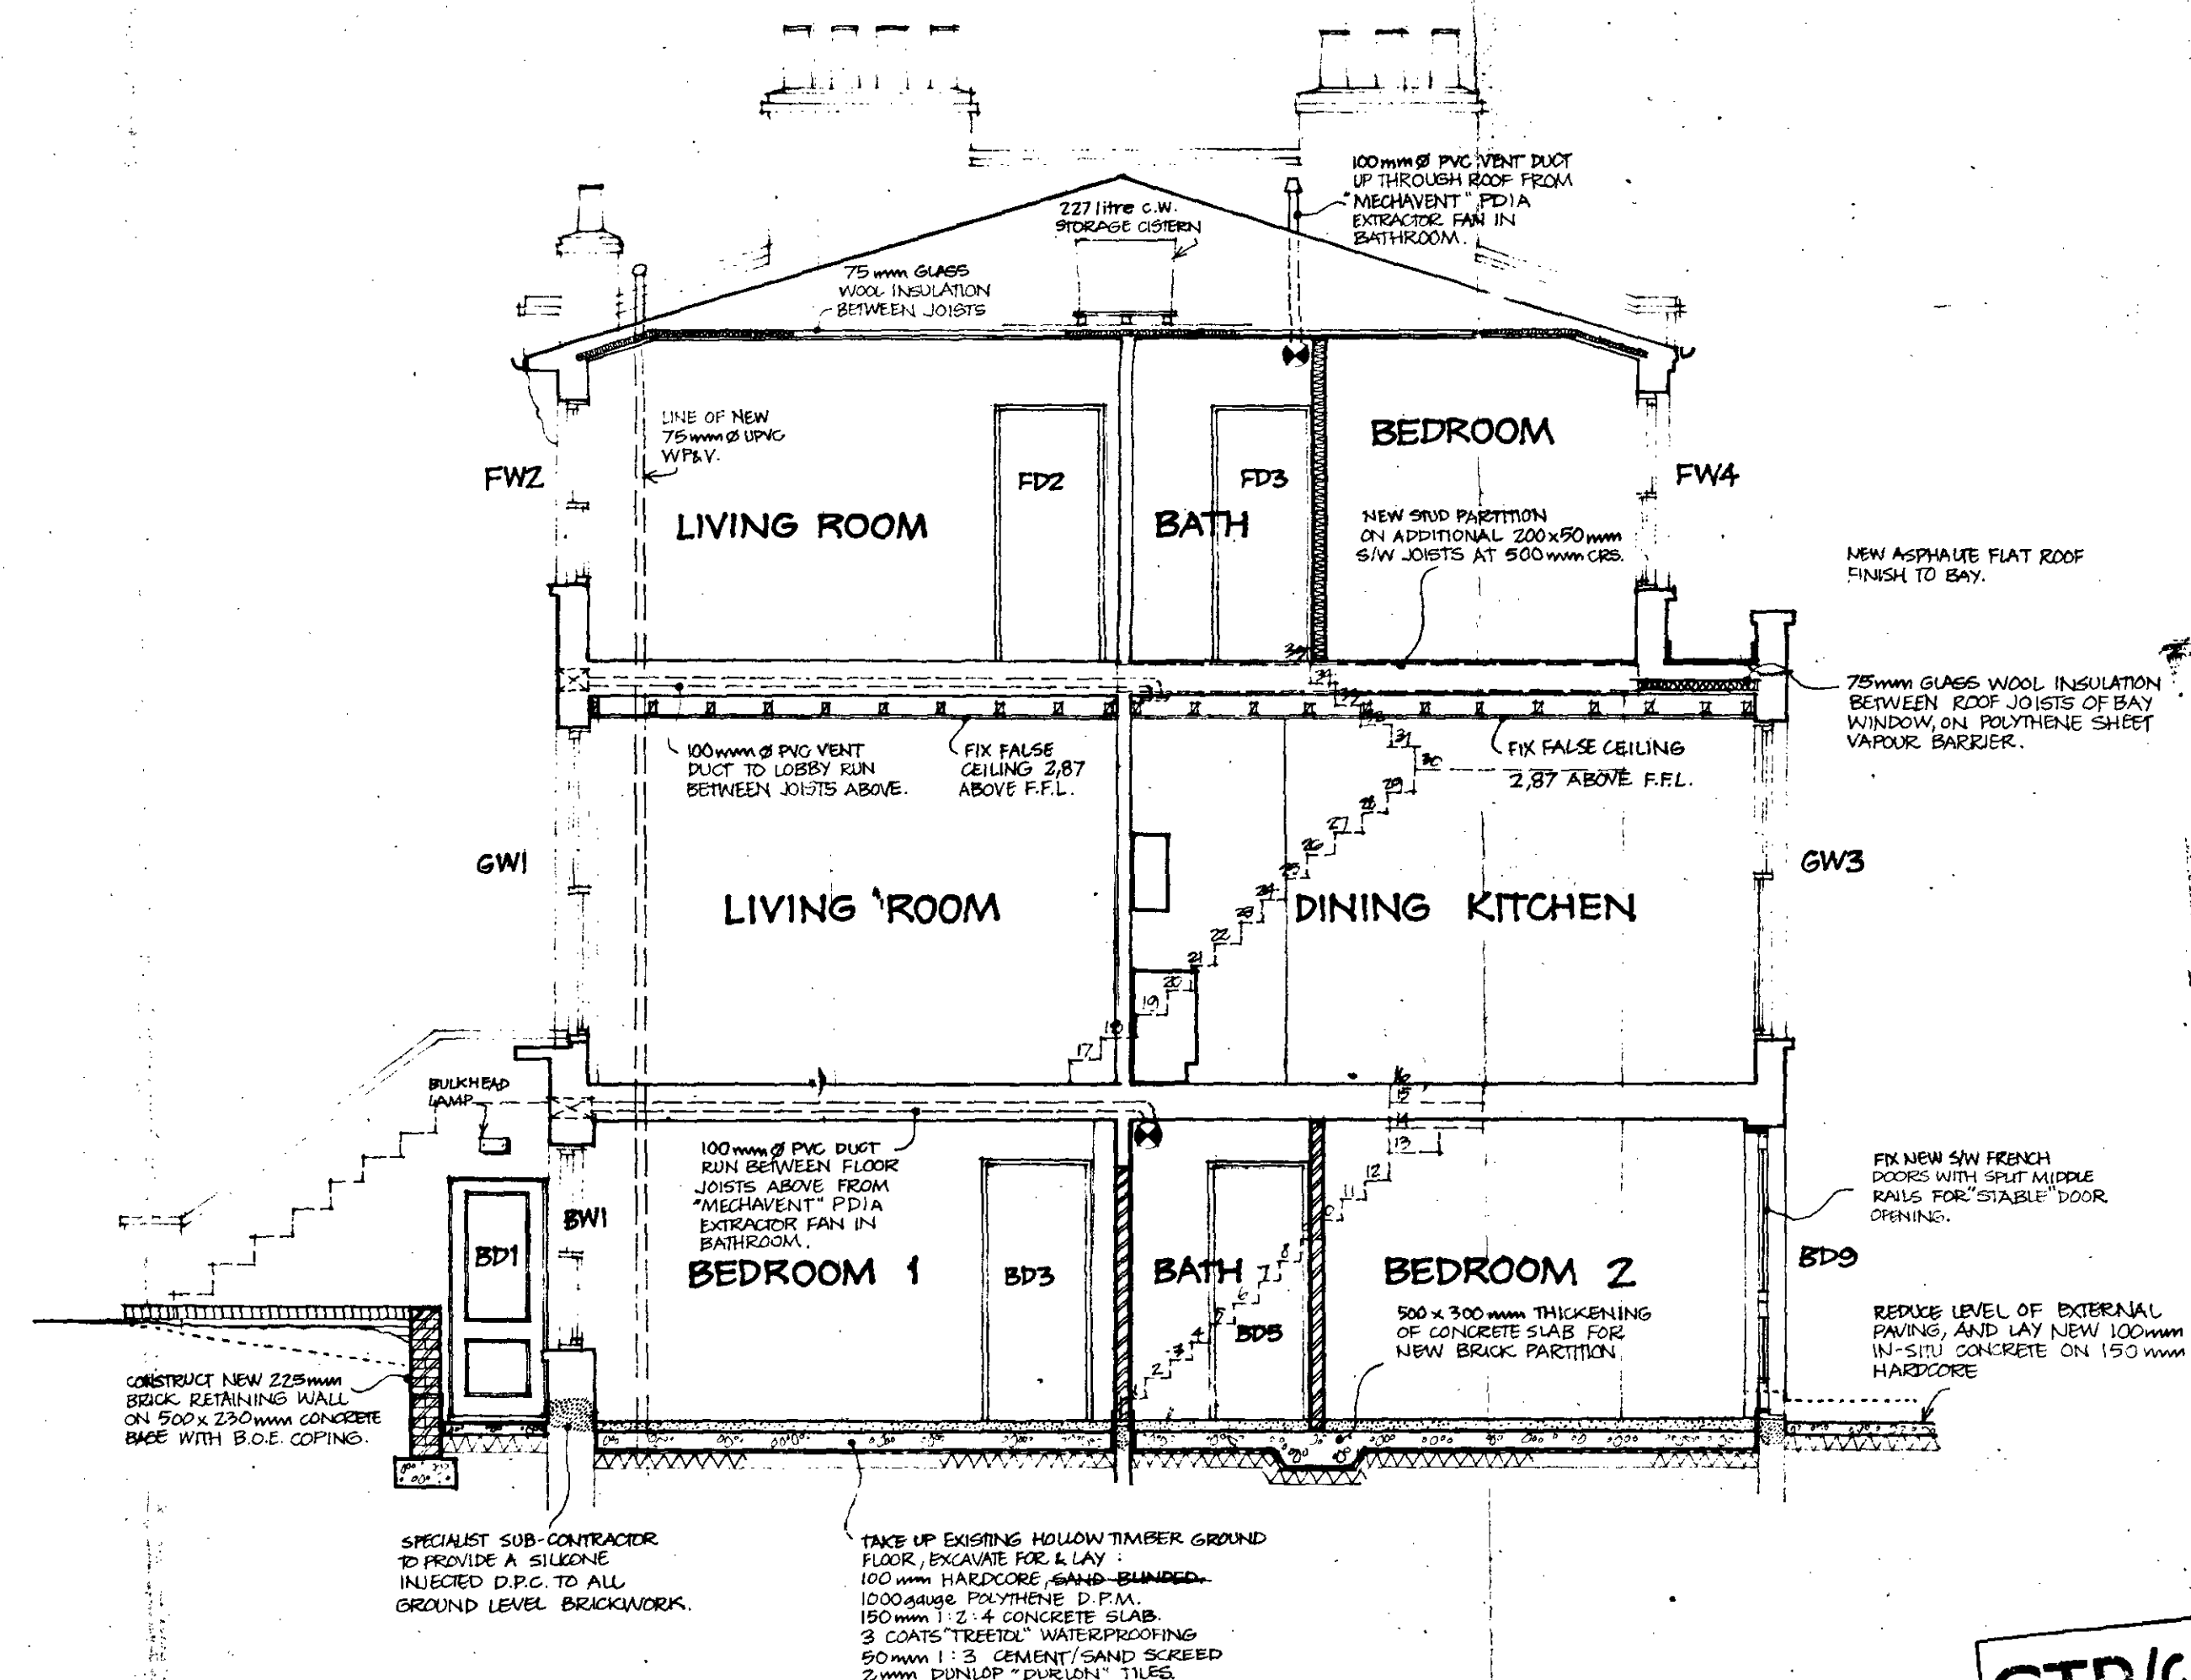


SECTION

LONDON BOROUGH OF CAMDEN
DEPT. OF THE COUNCIL
26 AUG 1982

LONDON BOROUGH OF CAMDEN
TOWN AND COUNTRY PLANNING ACTS
13 OCT 1982
APPROVED
PLANS AND SECTIONS
ON BEHALF OF THE COUNCIL



CTP/913/28/4 /34834

Pollard Thomas and Edwards		ARCHITECTS - DESIGNER	
11 JERUSALEM PASSAGE ST. JOHN'S SQUARE LONDON EC1	01-253 4941 01-253 4942 01-253 9723	DEC 79	1:50
JOB TITLE	V&J.P.	DATE	SCALE
CAMDEN SQUARE			
PROPOSED ELEVATIONS & SECTION :			
11 MARQUIS ROAD, NW1.			
DRAWING TITLE			

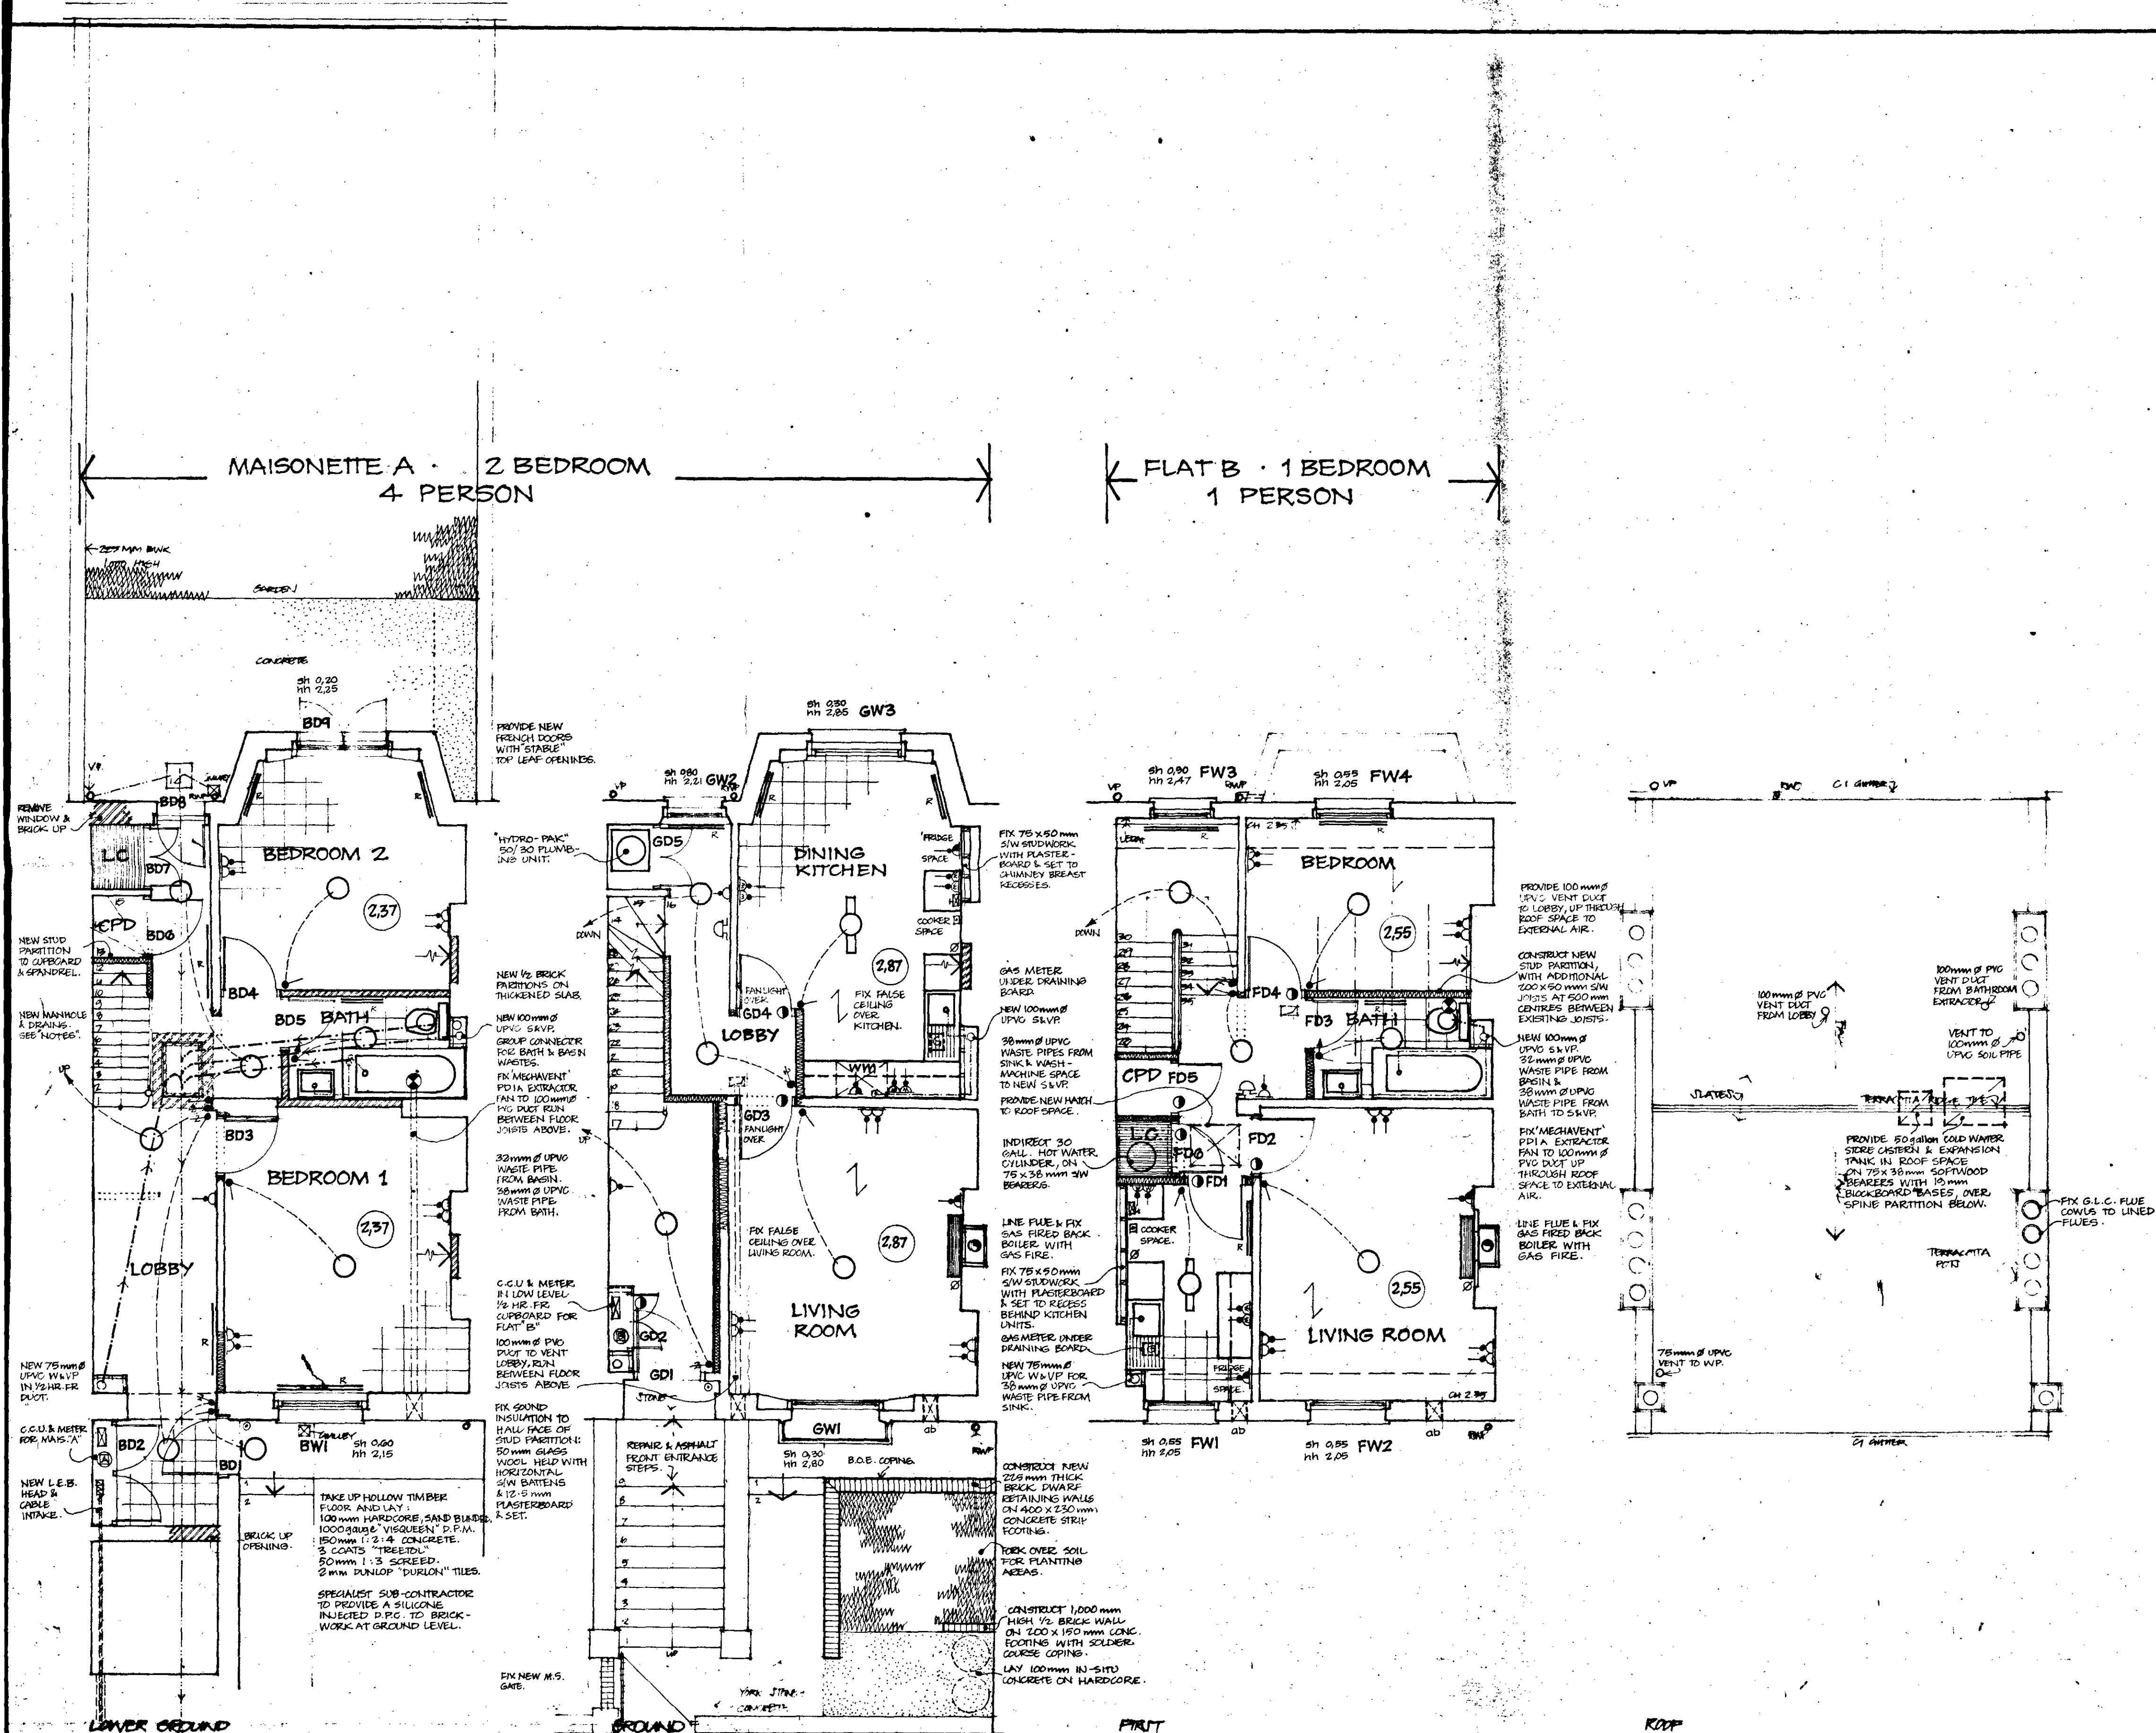


NOTES :

- 1) NEW MANHOLE TO BE CONSTRUCTED ON A 150mm CONCRETE BASE, WITH 225mm THICK "SOUTHWATER" BRICK CHAMBER, INCLUDING 3/4 SECTION CHANNEL BENDS SET IN FINE CONCRETE BENCHING. FIX BURNS BROS. "ROTUNDA" DOUBLE SEAL/DOUBLE COVER, AS SHOWN ON DRAWING DO/10.
- 2) NEW DRAINS TO BE 100mm Ø GLAZED STONEWARE, JOINTED WITH TARRED HEMP GASKET & CAULKED WITH 1:2 MORTAR. ALL NEW DRAINS TO FALL AT 1:80 AND TOTALLY ENCASED IN 150mm CONCRETE.
- 3) BATHS, WASH BASINS & SINKS TO HAVE 75mm DEEP SEAL POLYPROPYLENE BOTTLE TRAPS TO BS. 3943.
- 4) INTERNAL FACES OF BATHROOM STUD PARTITIONS TO HAVE "EXPANET" LATHING AND 1:3 CEMENT/SAND RENDER WITH "SIRAPITE" SETTING COAT.
- 5) ALL NEW CARCASSING TIMBER TO BE IMPREGNATED AGAINST ROT & DECAY.
- 6) MECHAVENT® PD1A EXTRACTOR FANS TO BATHROOMS TO BE OPERATED OFF THE LIGHT SWITCH WITH A 20 MINUTE OVER-RUN.
- 7) (2.80) = FINISHED FLOOR TO CEILING HEIGHT.
- 8) sh = INTERNAL WINDOW SILL HEIGHT ABOVE F.F.L.
- hh = INTERNAL WINDOW HEAD HEIGHT ABOVE F.F.L.
- 9) SEE DRAWING NO. DO/5B FOR ENTRANCE GATE PATTERN.
- 10) SEE DRAWING NO. DO/9 FOR ROOF SPACE ACCESS HATCH.
- 11) SEE DRAWING NO. DO/14 FOR DETAIL OF FALSE CEILINGS.
- 12) SEE DRAWING NO. DO/10 FOR INTERNAL MANHOLE COVER.
- 13) THE USE OF "CARLITE" BONDING AND FINISHING PLASTERS ARE ONLY PERMITTED UPON SPECIFIC INSTRUCTION FROM THE ARCHITECT.

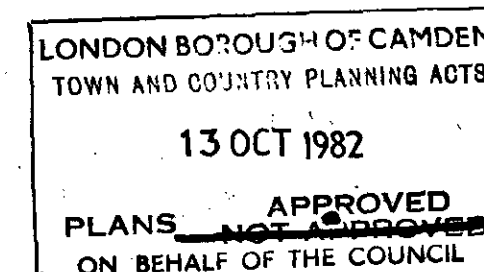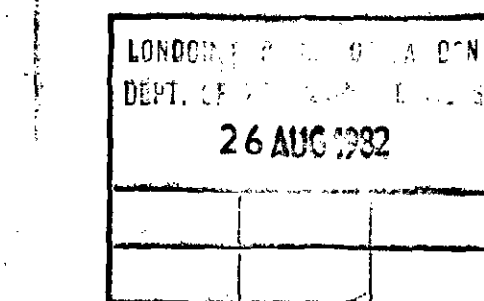

CTP/913/28 / 4 / 34834

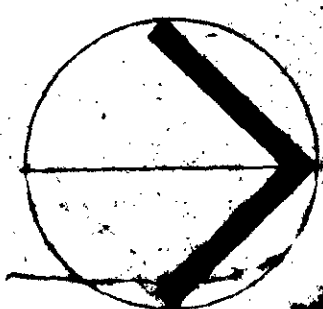

ELECTRICAL	CONSTRUCTION	CENTRAL HEATING	GAS	MISCELLANEOUS	NOTES
meter	new brickwork	boiler (wall mounted)	gas meter	extending	scaled dimensions are not to be taken from the drawings
consumer unit	new blockwork	single radiator	gas meter multipoint	clothes drier	all dimensions must be checked on site before any work is carried out or components ordered
main switch + meter	new stud partition	double radiator	gas point	cooker space	any discrepancies are to be referred to the architect for clarification
ceiling		towel rail		fridge space	
wall				washing machine space	
fluorescent				EXIST. DRAINS	
switches				NEW DRAINS	
one way					

two way intermediate pull cord key	single switched workshop level apparatus	immersion htr.	gas meter	extending	scaled dimensions are not to be taken from the drawings
weatherproof outlets (13 amp)	switched spur	storage heater	gas meter multipoint	clothes drier	all dimensions must be checked on site before any work is carried out or components ordered
socket	pilot lamp	thermostat	gas point	cooker space	any discrepancies are to be referred to the architect for clarification
single	cooker control	bell push		fridge space	
double	cooker connect	bell transformer		washing machine space	
single switched	fixed apparatus	landlord supply		EXIST. DRAINS	
double switched	extract fan	one way switch		NEW DRAINS	
		socket outlet			
		lighting outlet			

two way intermediate pull cord key	single switched workshop level apparatus	immersion htr.	gas meter	extending	scaled dimensions are not to be taken from the drawings
weatherproof outlets (13 amp)	switched spur	storage heater	gas meter multipoint	clothes drier	all dimensions must be checked on site before any work is carried out or components ordered
socket	pilot lamp	thermostat	gas point	cooker space	any discrepancies are to be referred to the architect for clarification
single	cooker control	bell push		fridge space	
double	cooker connect	bell transformer		washing machine space	
single switched	fixed apparatus	landlord supply		EXIST. DRAINS	
double switched	extract fan	one way switch		NEW DRAINS	
		socket outlet			
		lighting outlet			

two way intermediate pull cord key	single switched workshop level apparatus	immersion htr.	gas meter	extending	scaled dimensions are not to be taken from the drawings
weatherproof outlets (13 amp)	switched spur	storage heater	gas meter multipoint	clothes drier	all dimensions must be checked on site before any work is carried out or components ordered
socket	pilot lamp	thermostat	gas point	cooker space	any discrepancies are to be referred to the architect for clarification
single	cooker control	bell push		fridge space	
double	cooker connect	bell transformer		washing machine space	
single switched	fixed apparatus	landlord supply		EXIST. DRAINS	
double switched	extract fan	one way switch		NEW DRAINS	
		socket outlet			
		lighting outlet			

two way intermediate pull cord key	single switched workshop level apparatus	immersion htr.	gas meter	extending	scaled dimensions are not to be taken from the drawings
weatherproof outlets (13 amp)	switched spur	storage heater	gas meter multipoint	clothes drier	all dimensions must be checked on site before any work is carried out or components ordered
socket	pilot lamp	thermostat	gas point	cooker space	any discrepancies are to be referred to the architect for clarification
single	cooker control	bell push		fridge space	
double	cooker connect	bell transformer		washing machine space	
single switched	fixed apparatus	landlord supply		EXIST. DRAINS	
double switched	extract fan	one way switch		NEW DRAINS	
		socket outlet			
		lighting outlet			

Pollard Thomas and Edwards ARCHITECTS · DESIGNER

11 JERUSALEM PASSAGE
ST. JOHN'S SQUARE
LONDON EC1 V4JP

01 253 4941
01 253 4942
01 253 9723

NOV 1979 1:50

CAMDEN SQUARE

PROPOSED PLANS:
11 MARQUIS ROAD, NW1

NO 114 039/3