



3570307

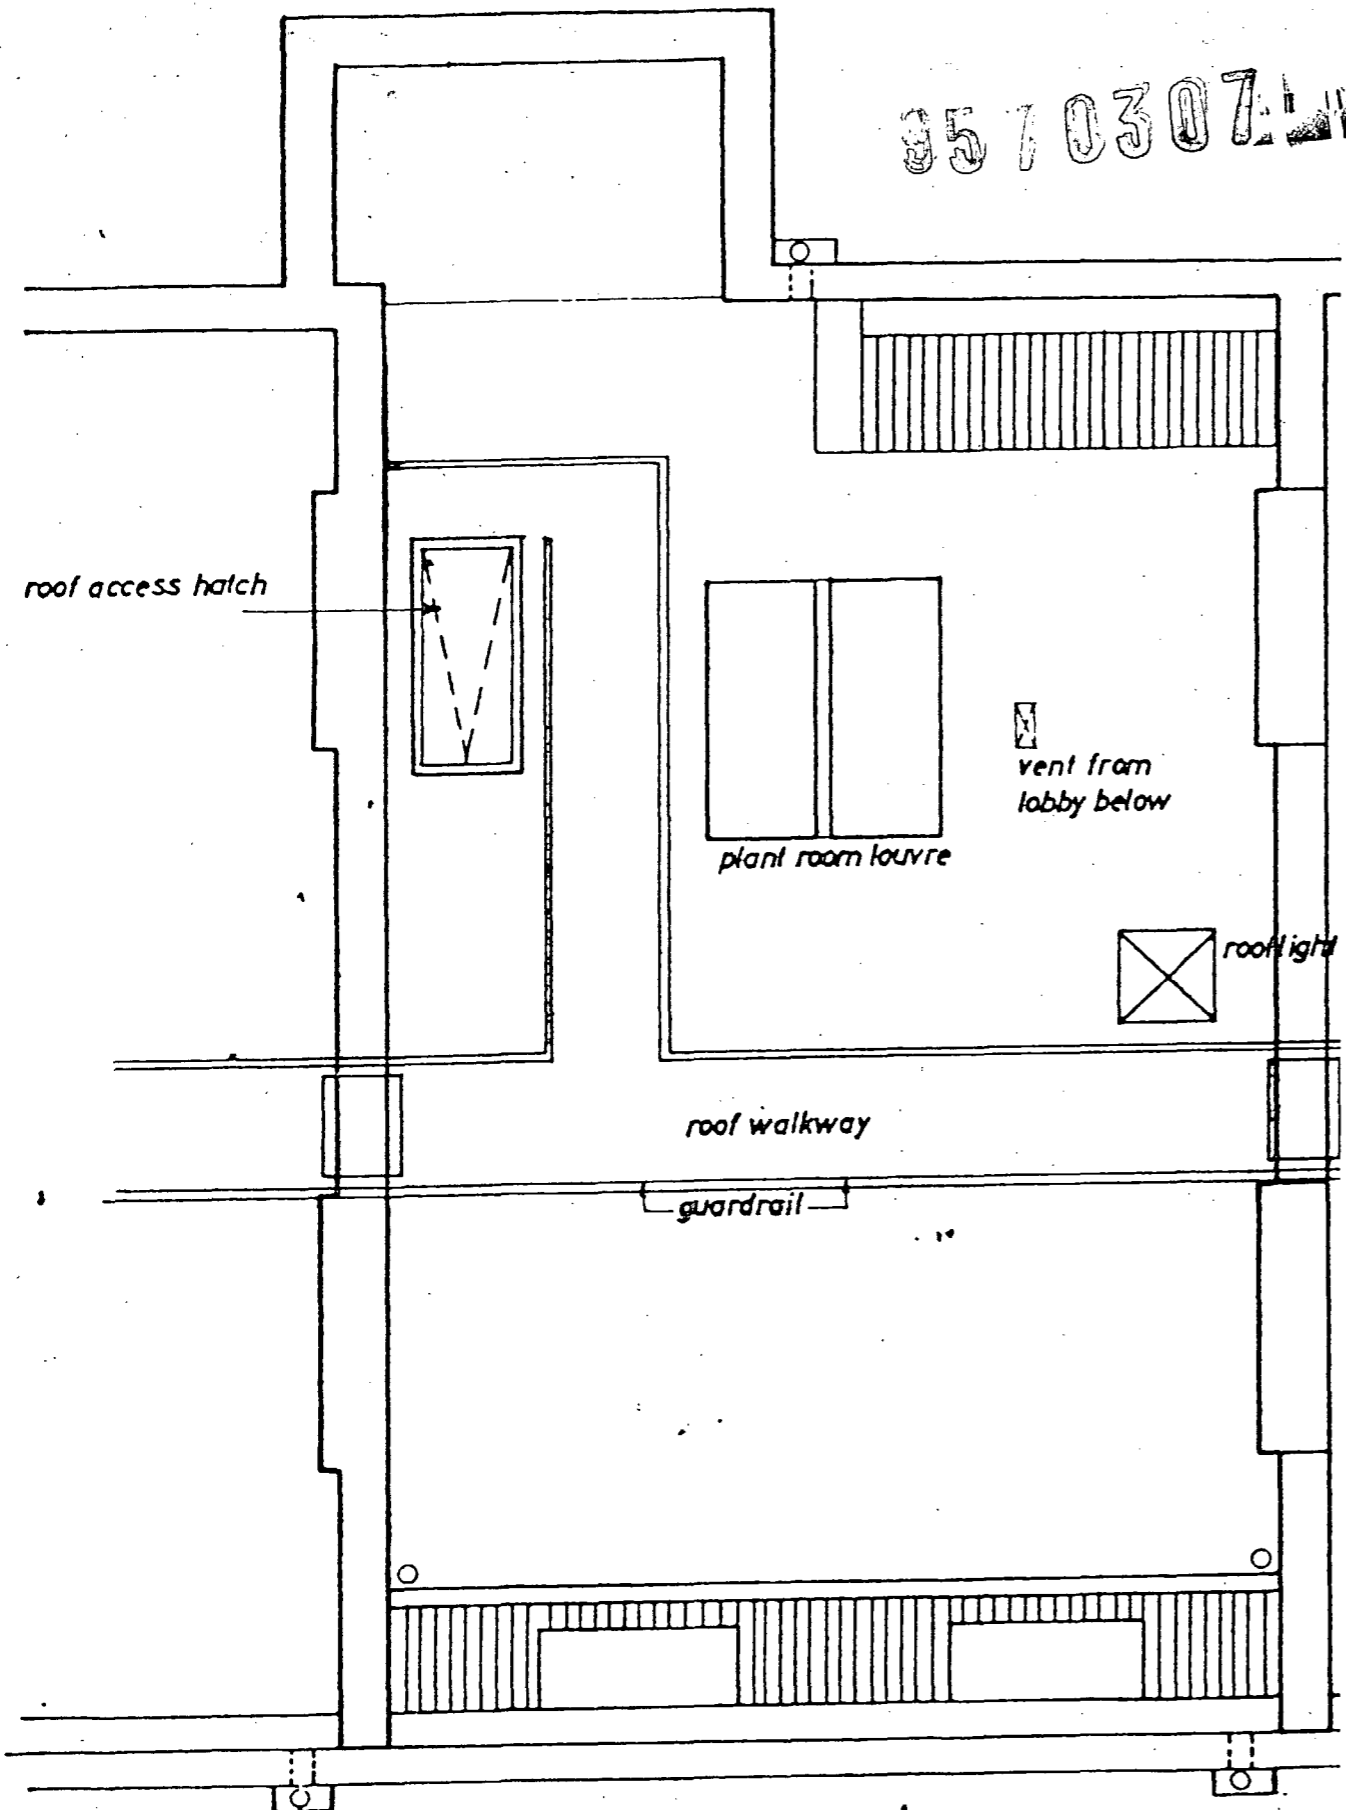



ROOF PLAN AS EXISTING

SCALE 1:50

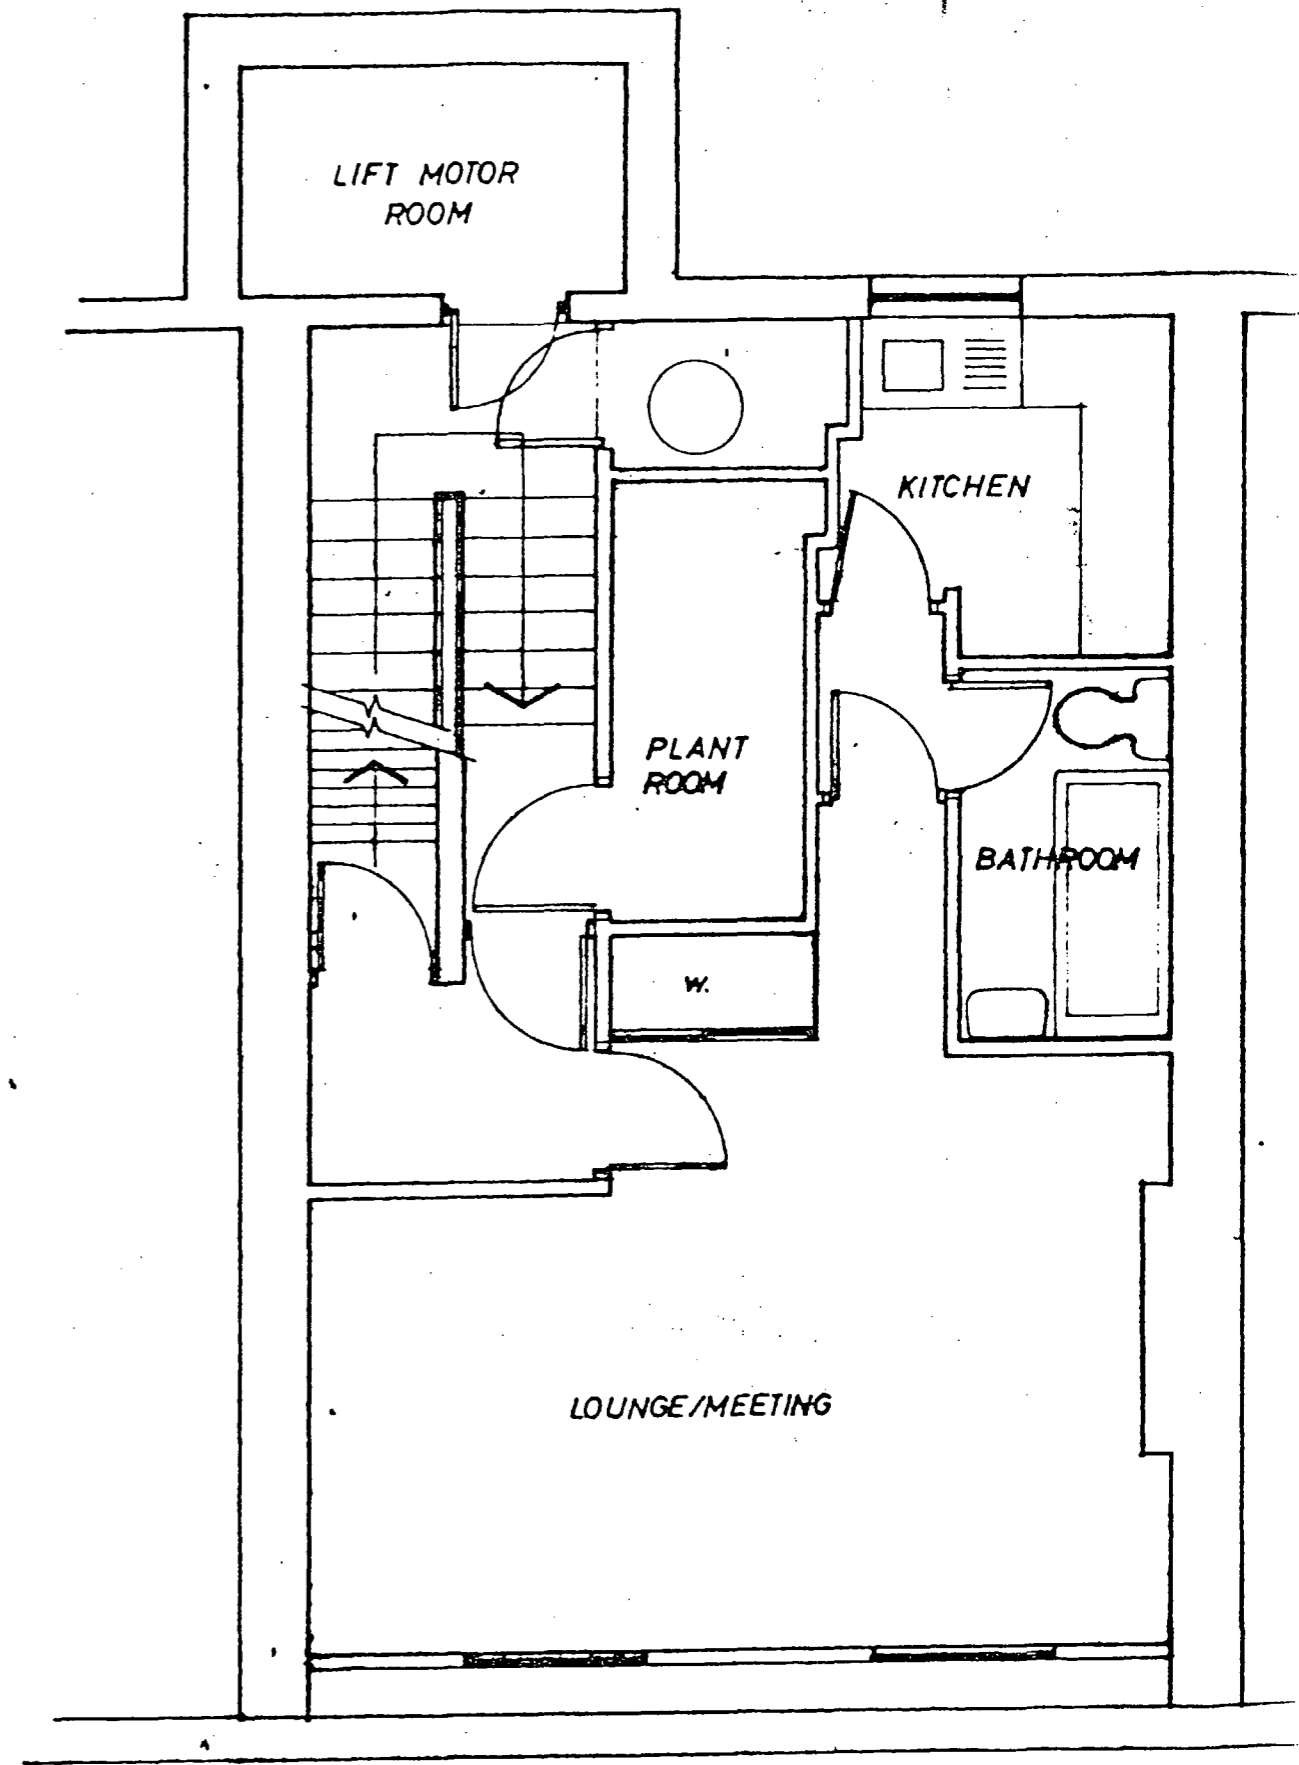


FOURTH FLOOR PLAN AS EXISTING

1030159 951307

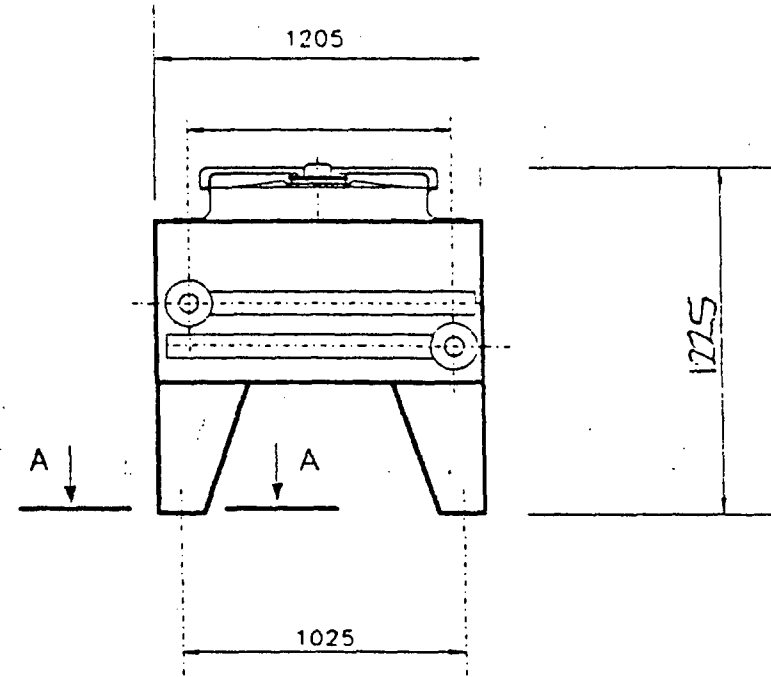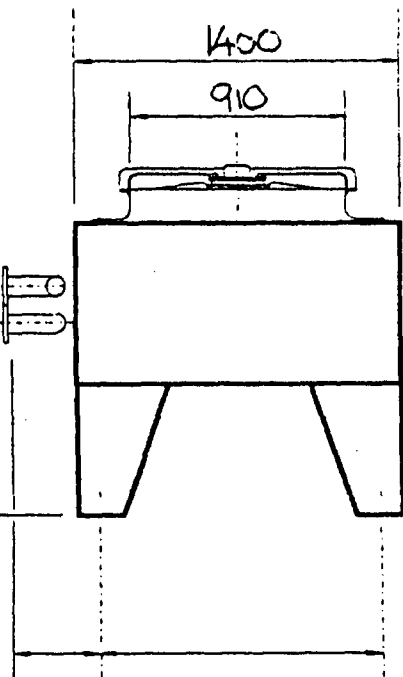

SECTION A--A

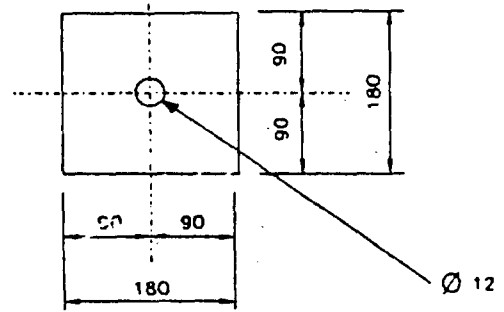

FOOT DETAIL

- NOTES**
1. DRAWING NOT TO SCALE
  2. TOLERANCES  $\pm 10$ mm OVERALL
  3. DIMENSIONS IN MILLIMETRES

DESIGN	TRACED	CHECKED	APPROVED	DATE

UNIT C-SAR 1-65

CLIENT

PROJECT I Broomfield Sc.


HEAT REJECTION:  
MEDIUM:  
FLOW RATE:  
PRESSURE DROP:  
INLET TEMPERATURE:  
OUTLET TEMPERATURE:  
AMBIENT TEMPERATURE:

POWER SUPPLY:  
CONTROL VOLTAGE:  
FAN SPEED:  
MOTOR RATING:  
POWER ABSORBED:  
FULL LOAD AMPS:  
WINTERISATION INPUT:



DRY WEIGHT:  
OPERATING WEIGHT:  
INTERNAL VOLUME:  
TEST PRESSURE:  
WORKING PRESSURE:  
CONNECTION SIZE INLET:  
CONNECTION SIZE OUTLET:

DRAWING No.  
**AIREVAPCOOL LTD.**  
36 Brockenhurst Avenue  
Maidstone  
Kent ME15 7ED  
Telephone: (01622) 677296  
Fax: (01622) 688658



9570307

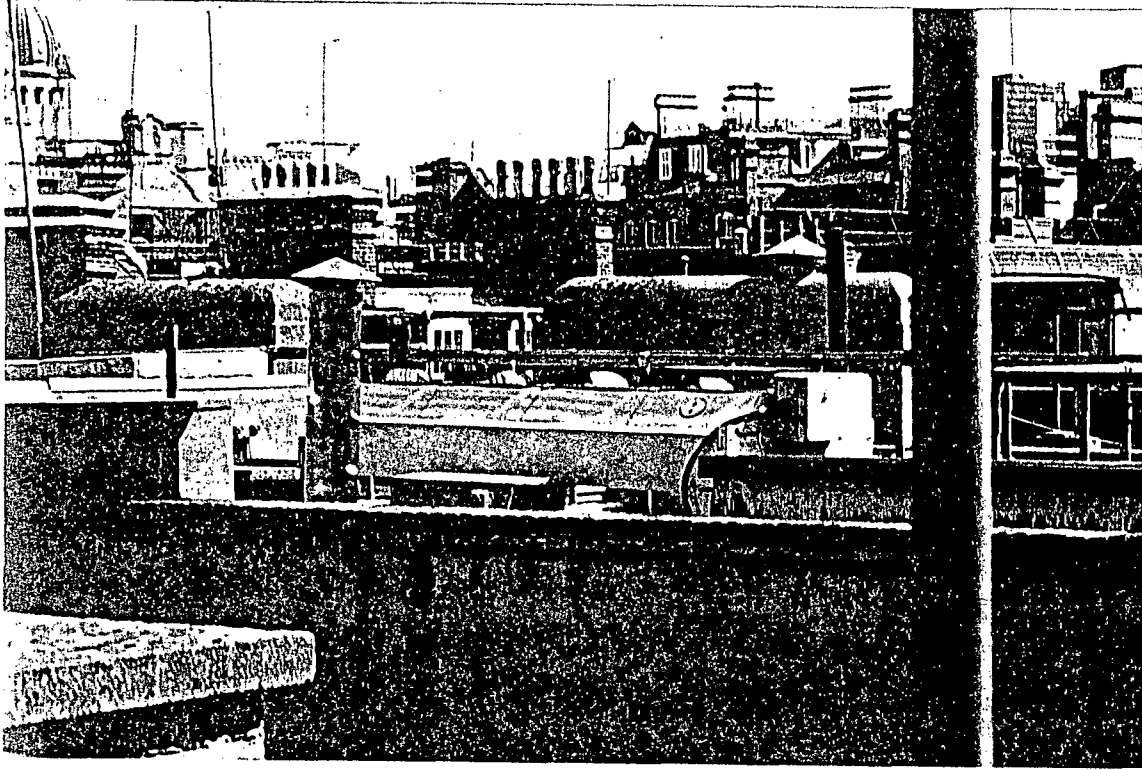

VIEW OF NEIGHBOURING ROOFTOPS.

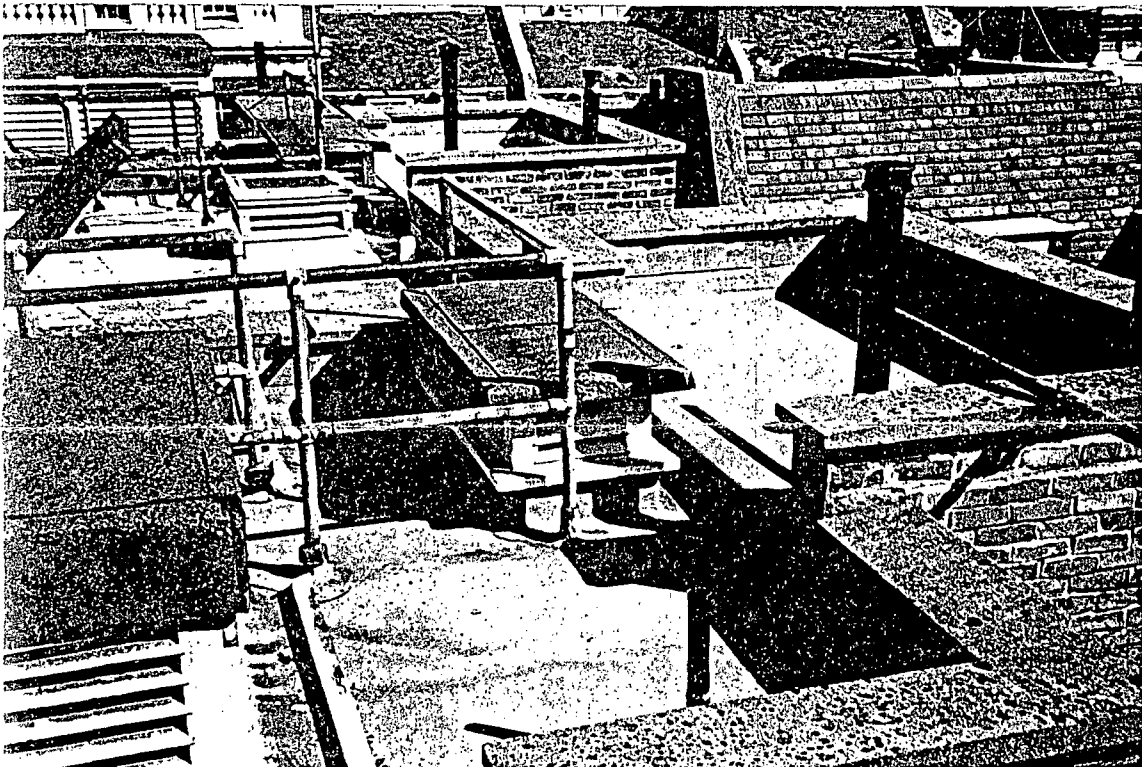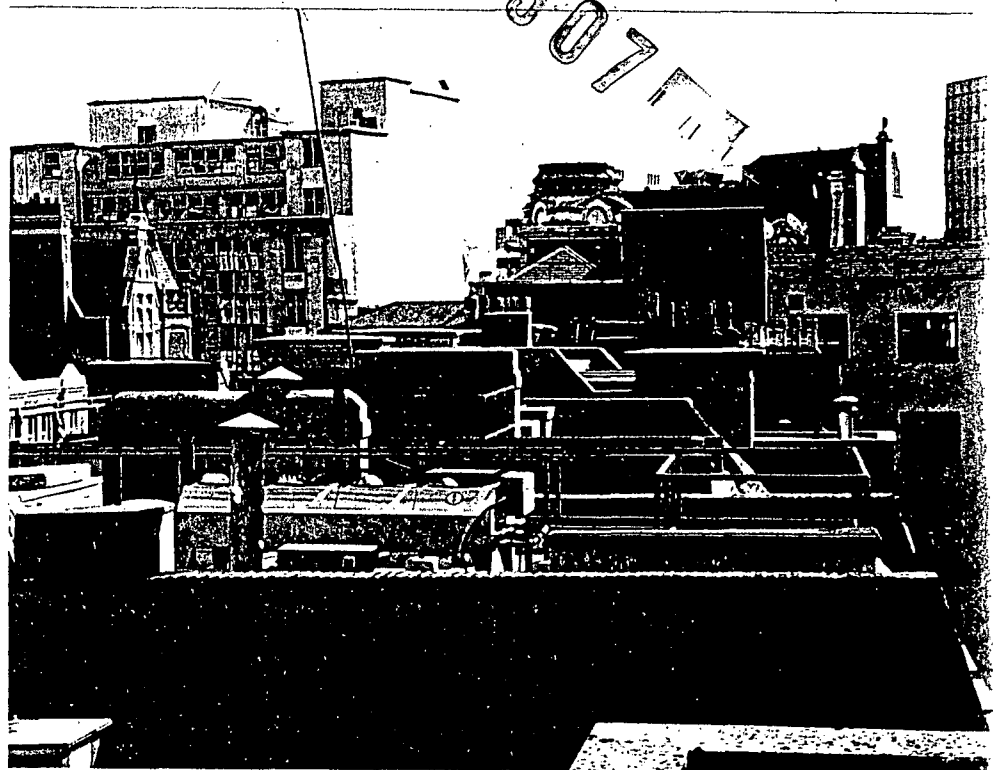

ROOFTOP OF 1 BLOOMSBURY SQUARE

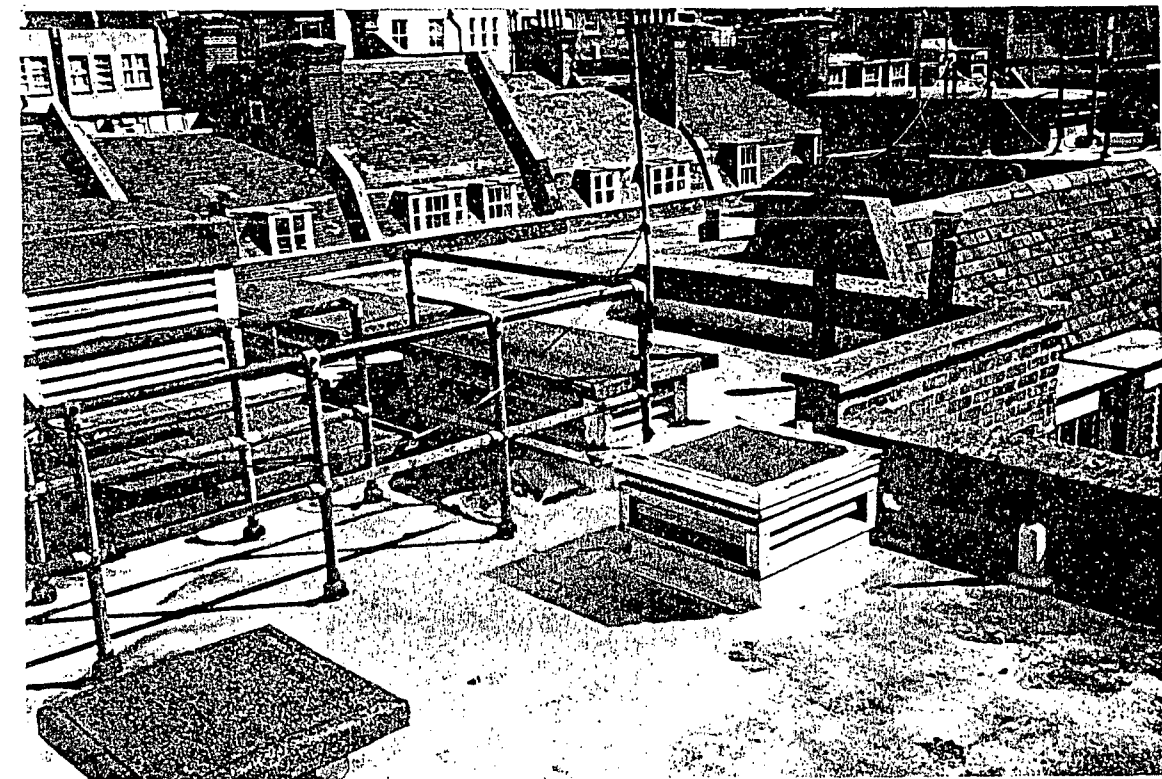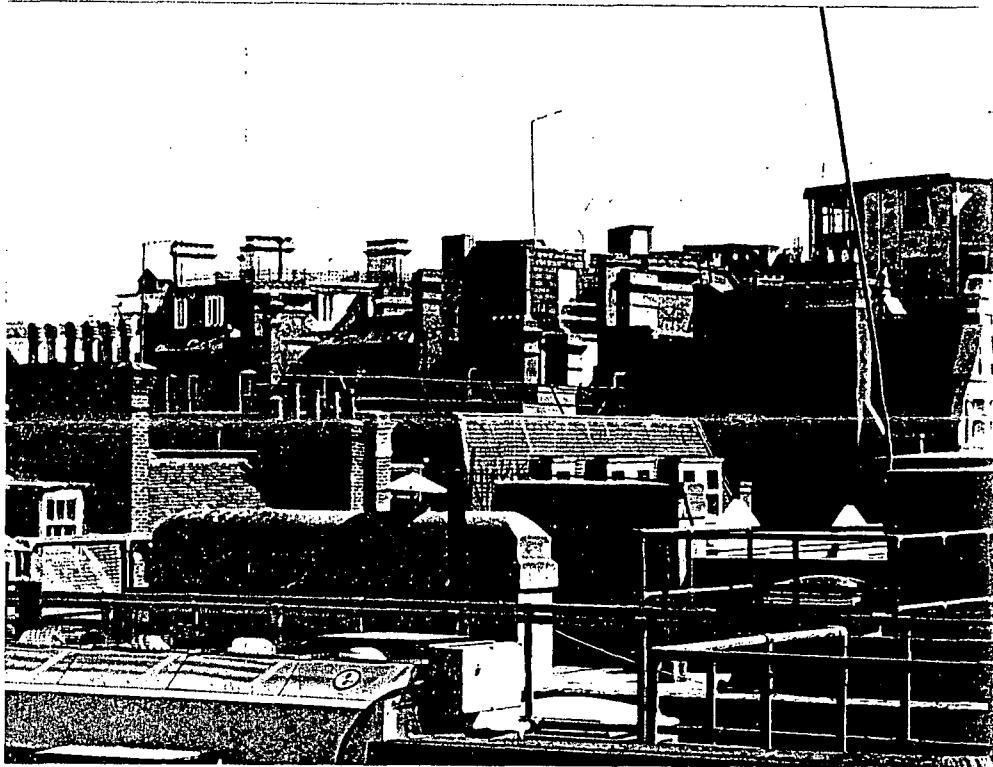

ROOFTOP OF 1 BLOOMSBURY SQUARE

