


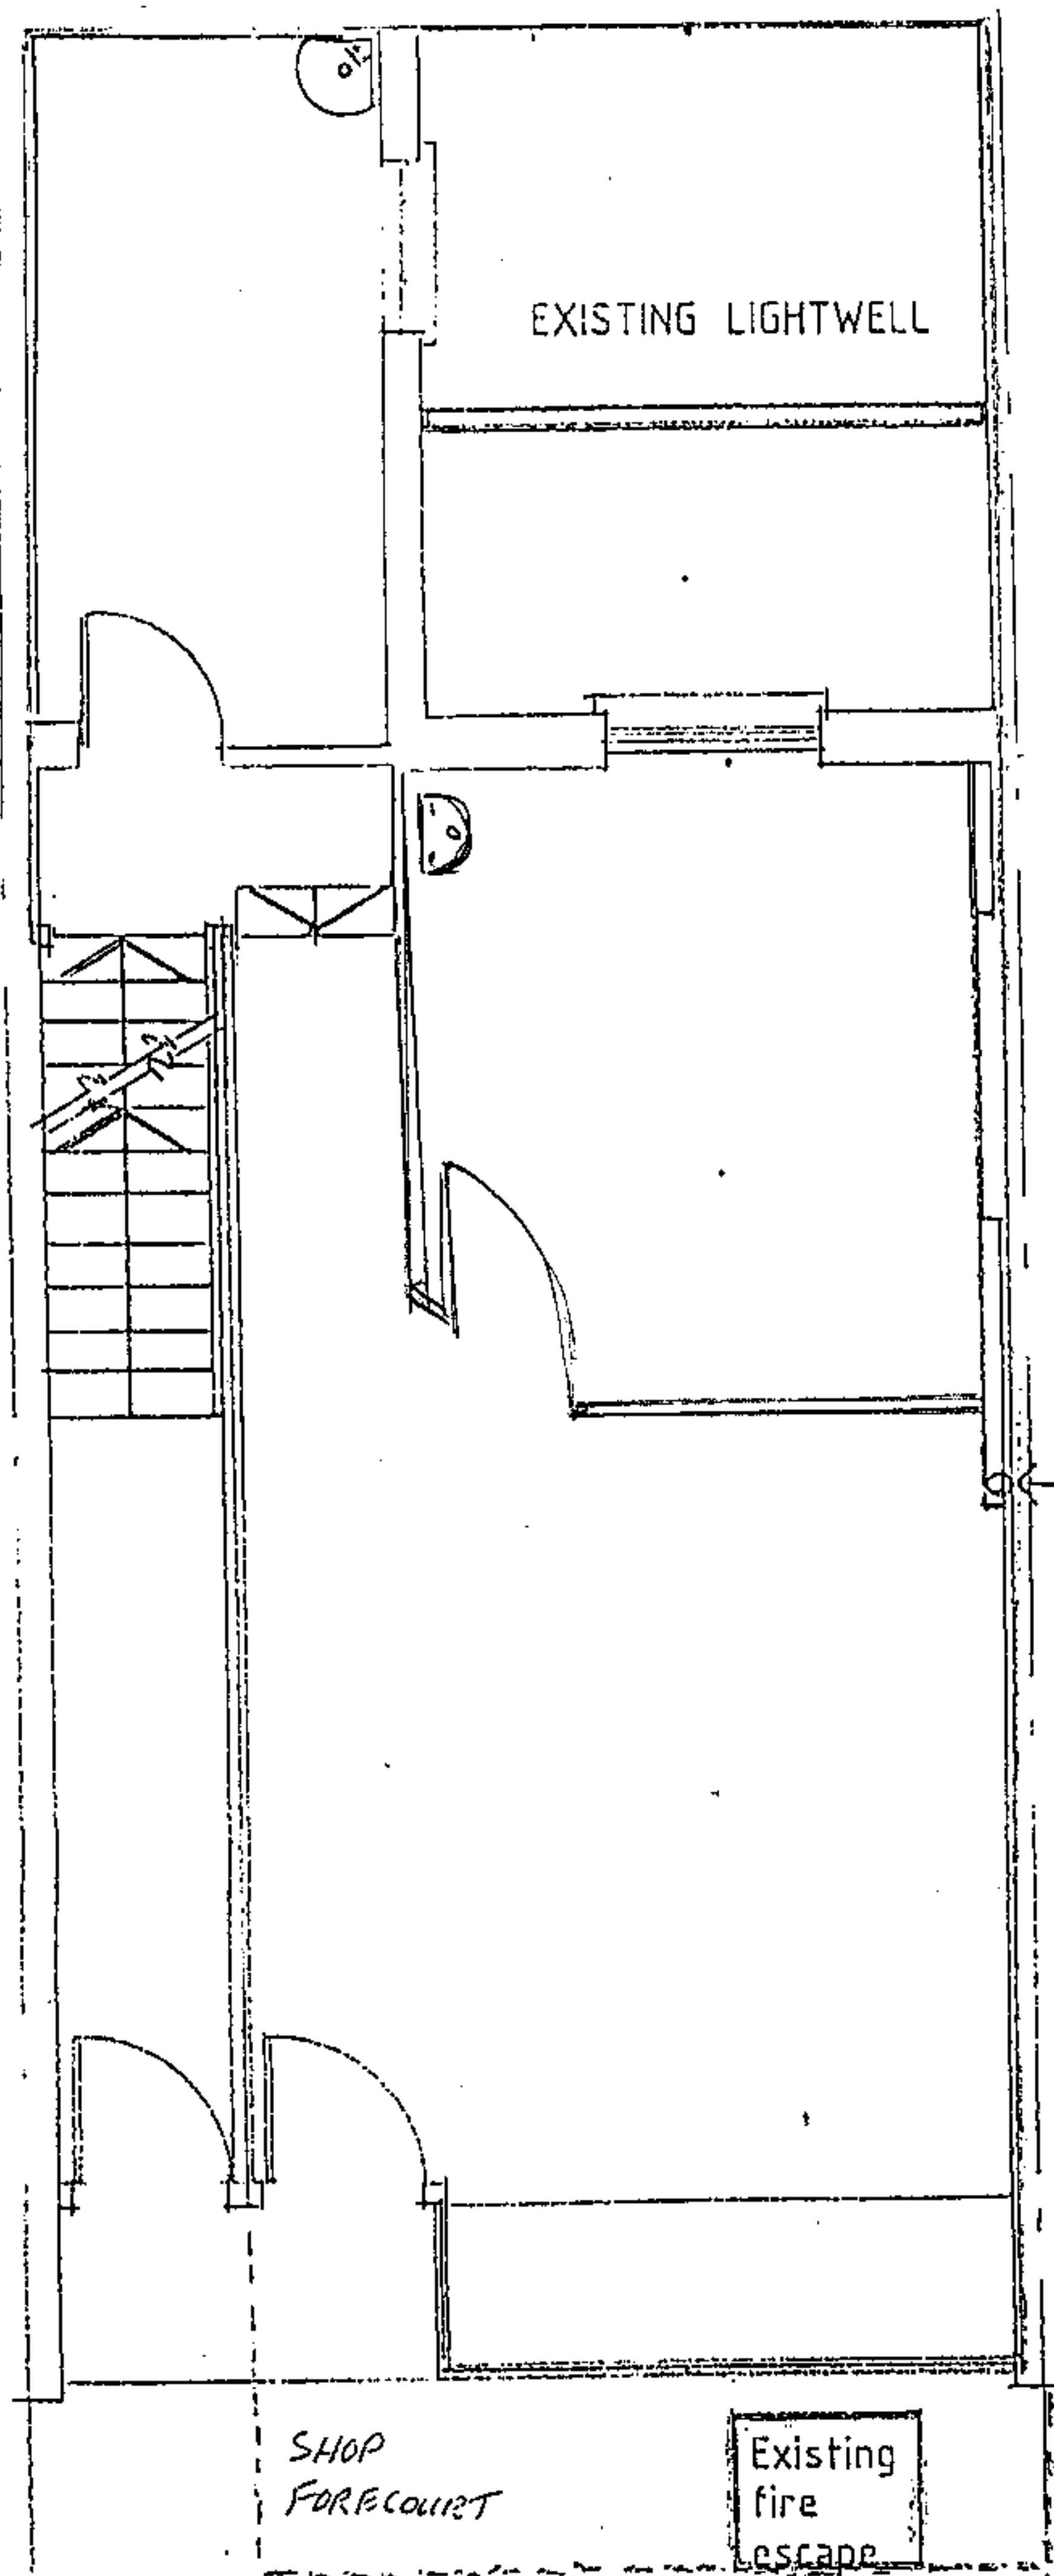

Existing s. & v. pipe

SHOP
FORECOURT

Existing
fire
escape

Al


EXISTING GROUND FLOOR PLAN
16 ENGLANDS LANE, LONDON, N.W.3
SCALE: 1:50

DRWG. EL/01

RECEIVED
- 6 FEB 2008

S

DIAN
TEL 0207722 7256
FAX - - 3736

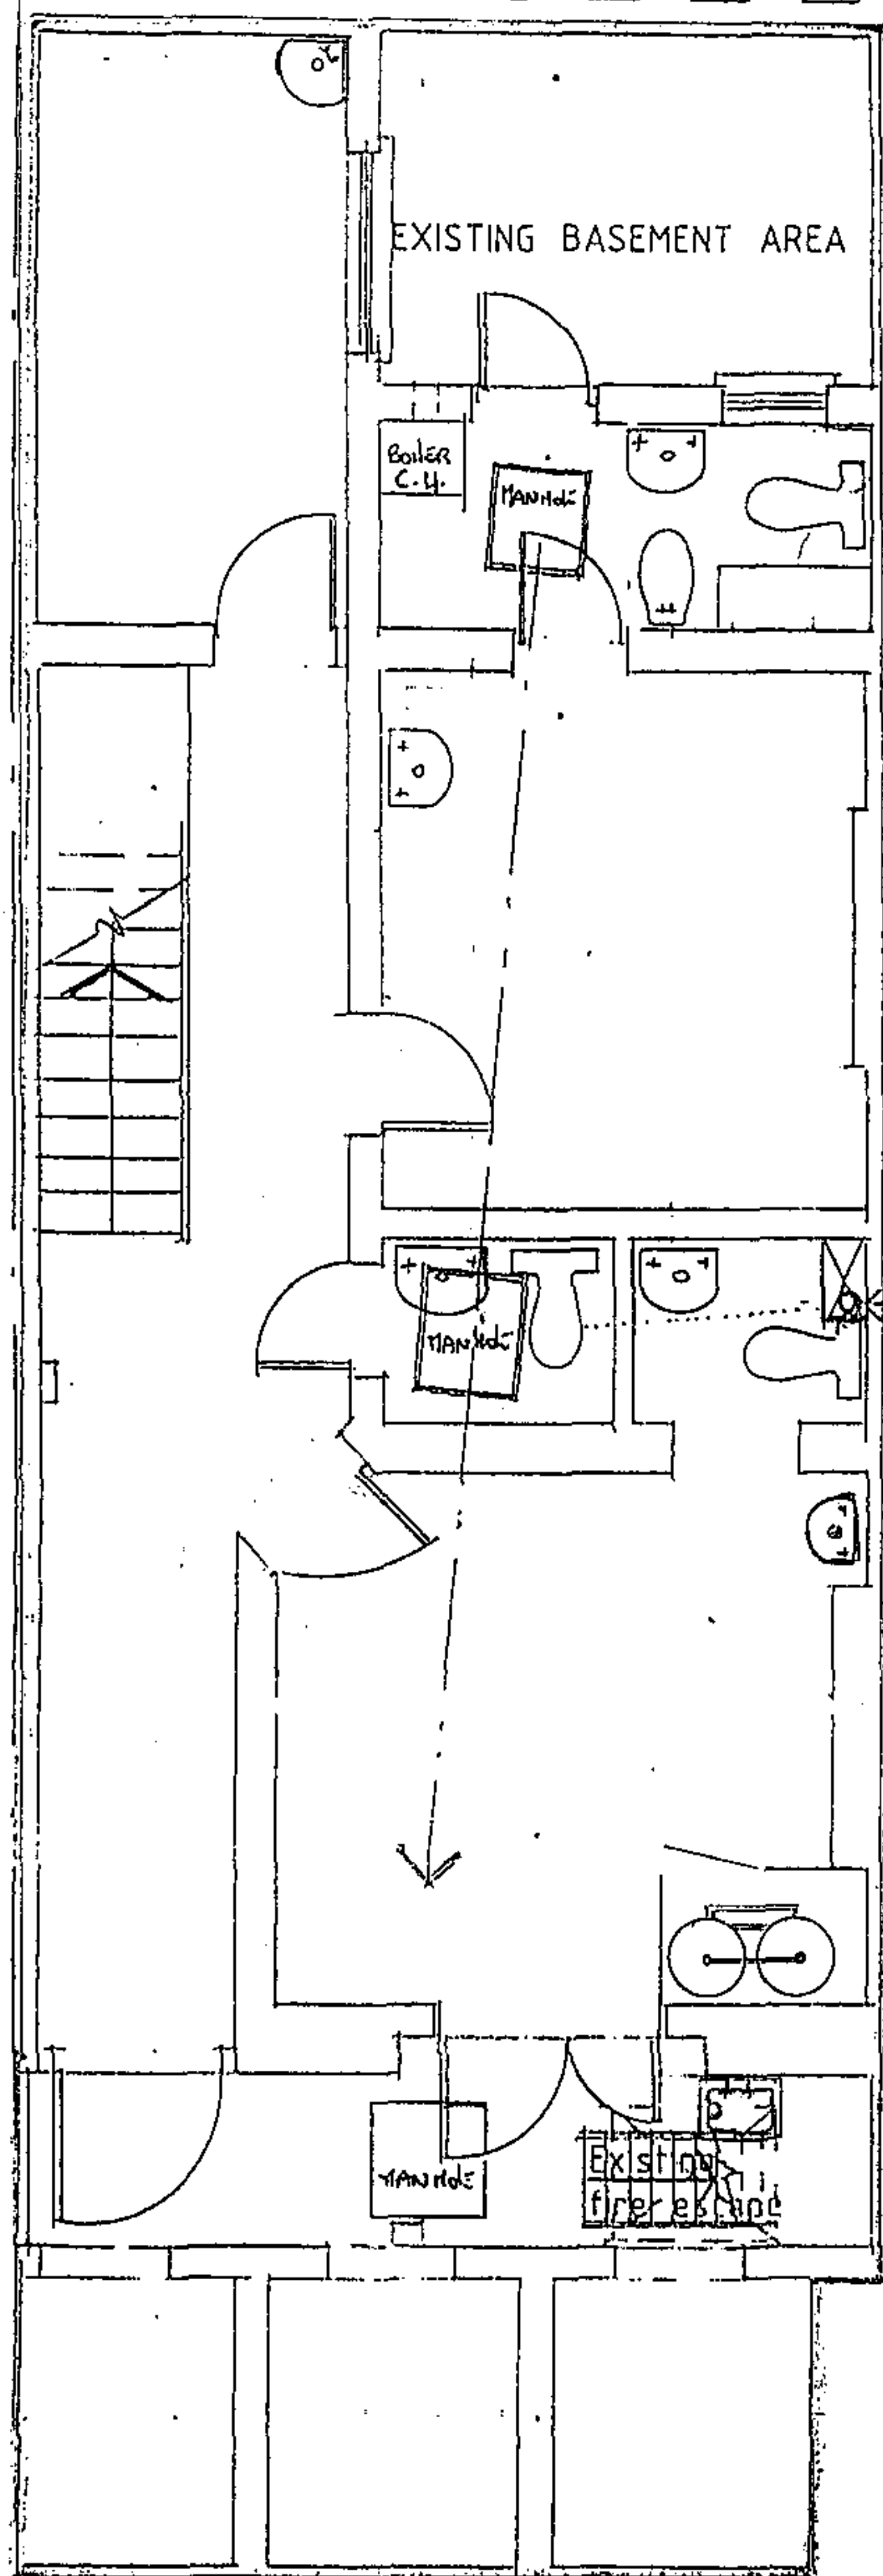

Existing s. & v. pipe.

MEGAFLOW
IMMERSION
HEATERS

BELFAST
PUMP

"PROTIM"
WATERPROOFED
CULVERTS x3

EXISTING BASEMENT PLAN
16 ENGLANDS LANE, LONDON, N.W.3
SCALE: 1:50

DRWG. EL / 02

RECEIVED
- 6 FEB 2008