


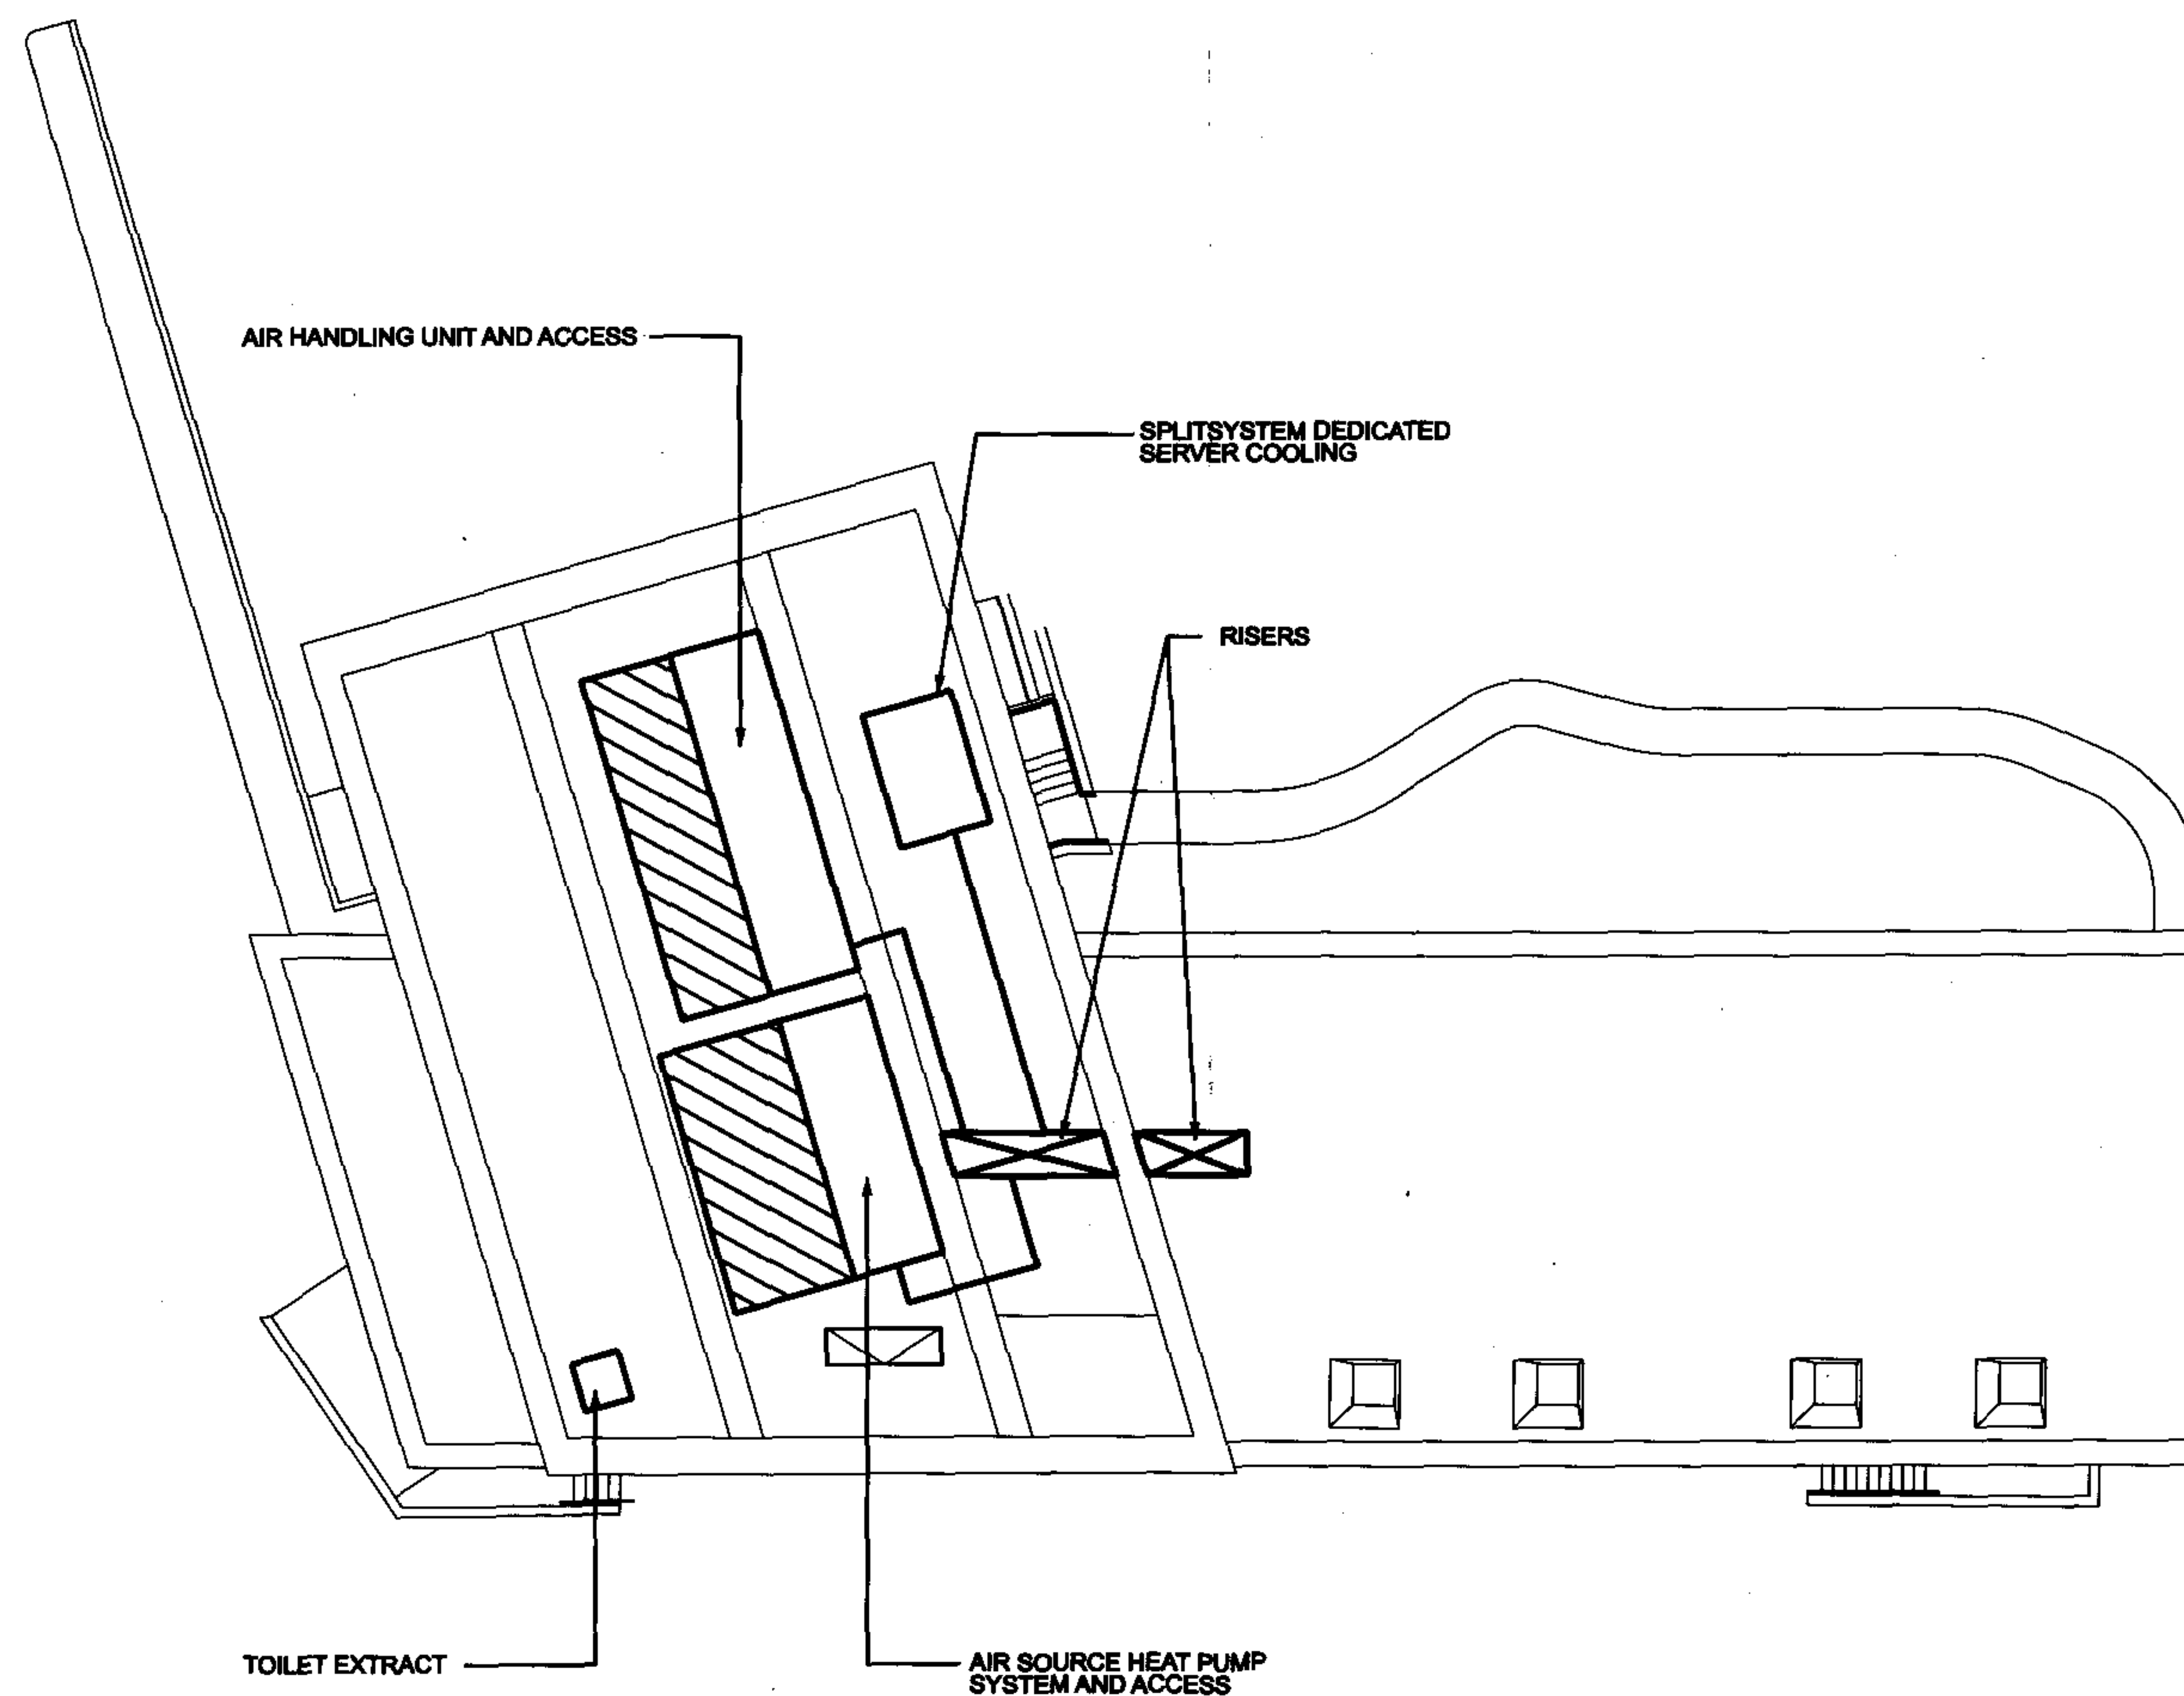

AREAS:

AHU = 32m²
 HEAT PUMP = 27m²
 TOILET EXTRACT = 1.25m²
 SPLIT SYSTEM = 6m²
 ALL AREAS INCLUDE MAINTENANCE
 ACCESS REQUIREMENTS AND AREA
 FOR SOUND ATTENUATION

Issue	Date	Comments	Drawn	Checked	Archived	Notes	● LONDON 62 - 68 ROSEBURY AVENUE LONDON EC1R 4RR TELEPHONE: 44 (0) 20 7620 1300 FACSIMILE: 44 (0) 20 7620 1365 ○ EDINBURGH 16 OLD FISHMARKET CLOSE EDINBURGH EH1 1RW TELEPHONE: 44 (0) 131 228 0220 FACSIMILE: 44 (0) 131 228 0229 ○ SPAIN CARRETERA DEL TIOLE 1370 DEVA 33304 GUON ASTURIAS TELEPHONE: 34 98 519 5080 FACSIMILE: 34 98 519 5187 ○ E-MAIL mail@fulcrumint.com ○ WEBSITE www.fulcrumint.com FULCRUM CONSULTING				
B	11/12/07	ISSUED FOR PLANNING	LvE	CE			Client TINDALL OVERSEAS Engineer CE Drawn By LvE Date DEC 07 Scale 1:200 @A3				
							Project OASIS OFFICE BUILDING				
							Drawing Title MECHANICAL PLANT LAYOUT - ROOF LEVEL Drawing Number 3551/MSK/501 Issue B				