


Revisions:
Suffix / Date / Drawn/ Description

GENERAL
Do not scale drawings, Report any dimensional discrepancies.

©This drawing is the property of Philip Bailey Architects and must not be copied or reproduced in full or in part without express written

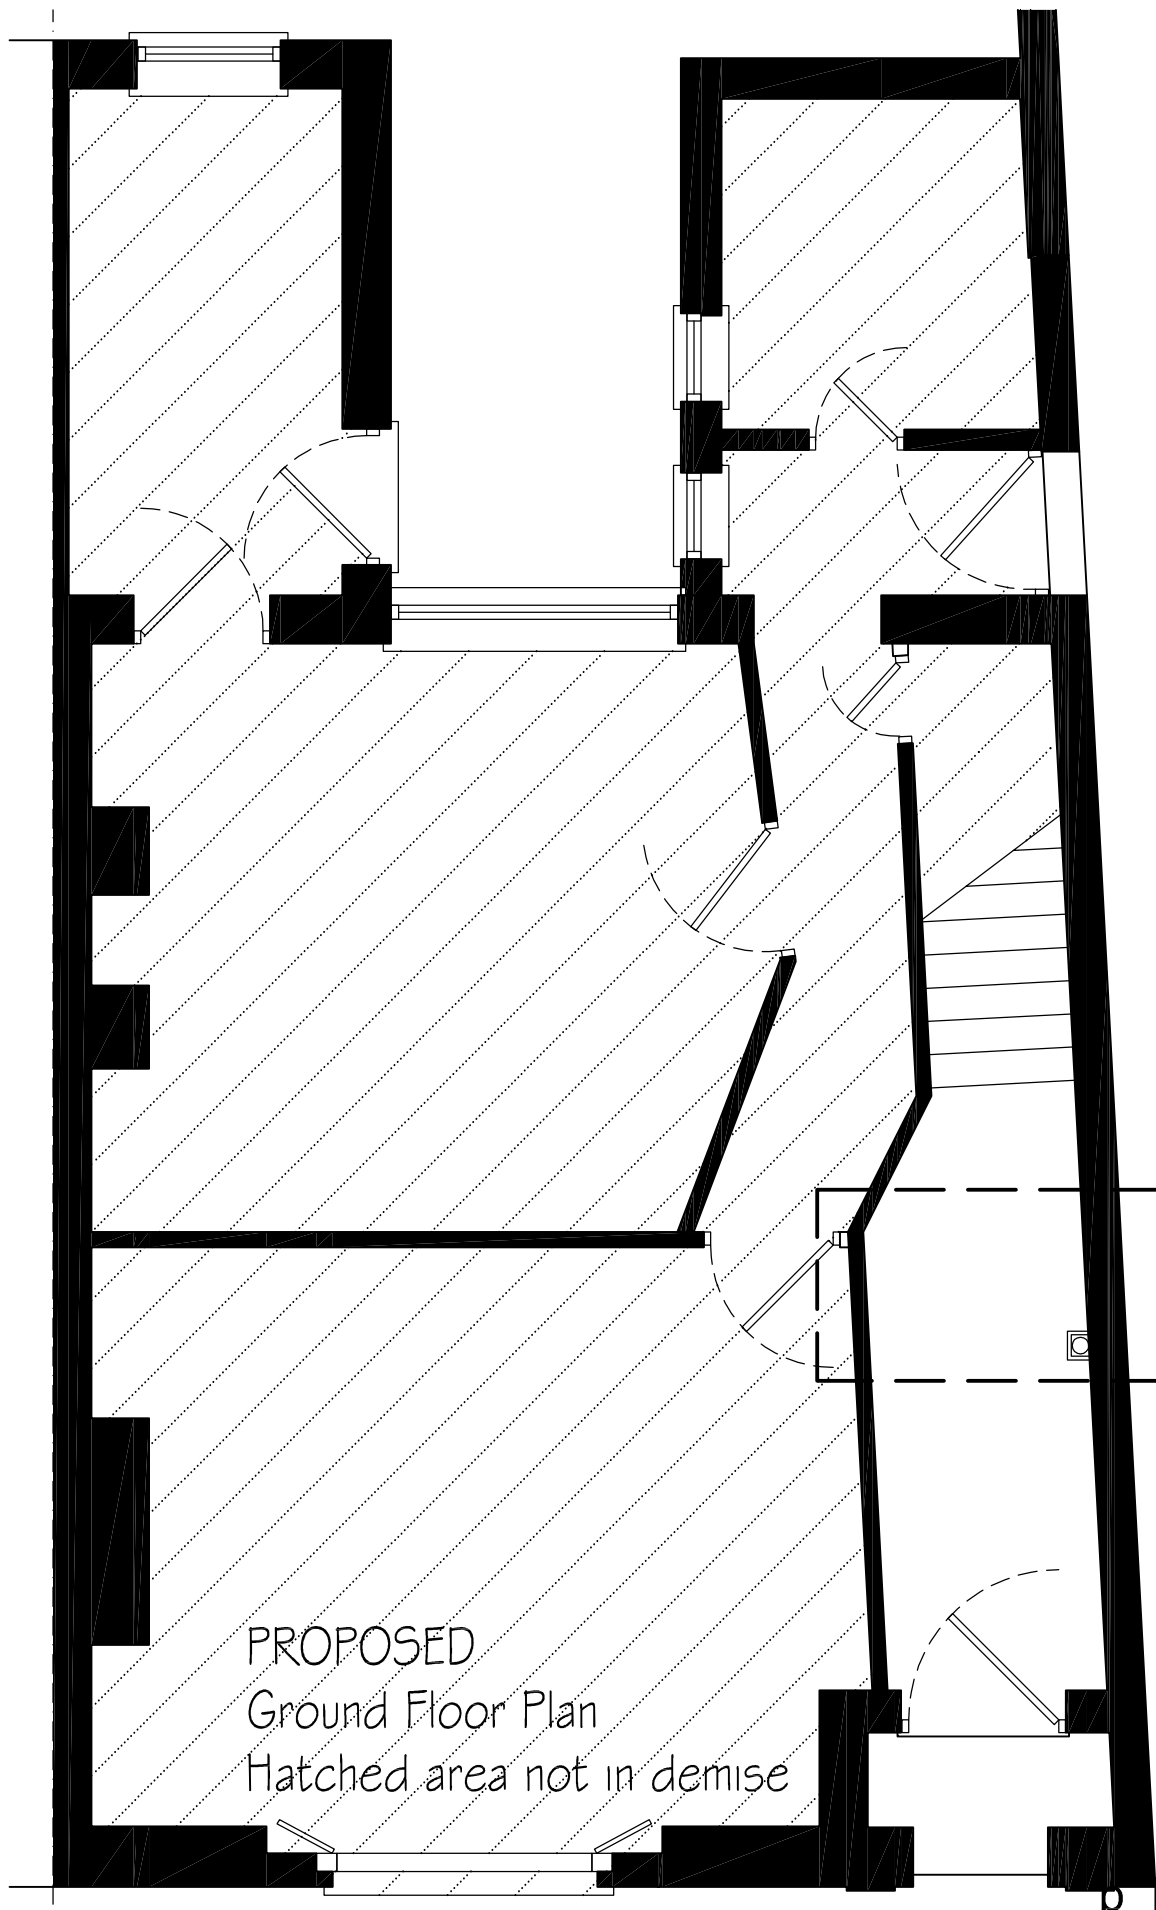

Remove door, frame and wall in entrance hall adjust electrical layout and make good all finishes

- Approval
- Preliminary
- Information
- Tender
- Construction
- As Built

Project 15B Willmott Place NW5
Drawing Ground Floor Plans

Client Vanilla POD
Scale 1:50@A3
Date Nov 07

Project Ref. 422
Drawing No. 01
Revision

philip bailey
architects

11 Beaumont Gate
Shenley Hill
Radlett
Herts WD7 7AR
Tel: 01923 289960
Fax: 01923 289961