


EXISTING
First Floor Plan

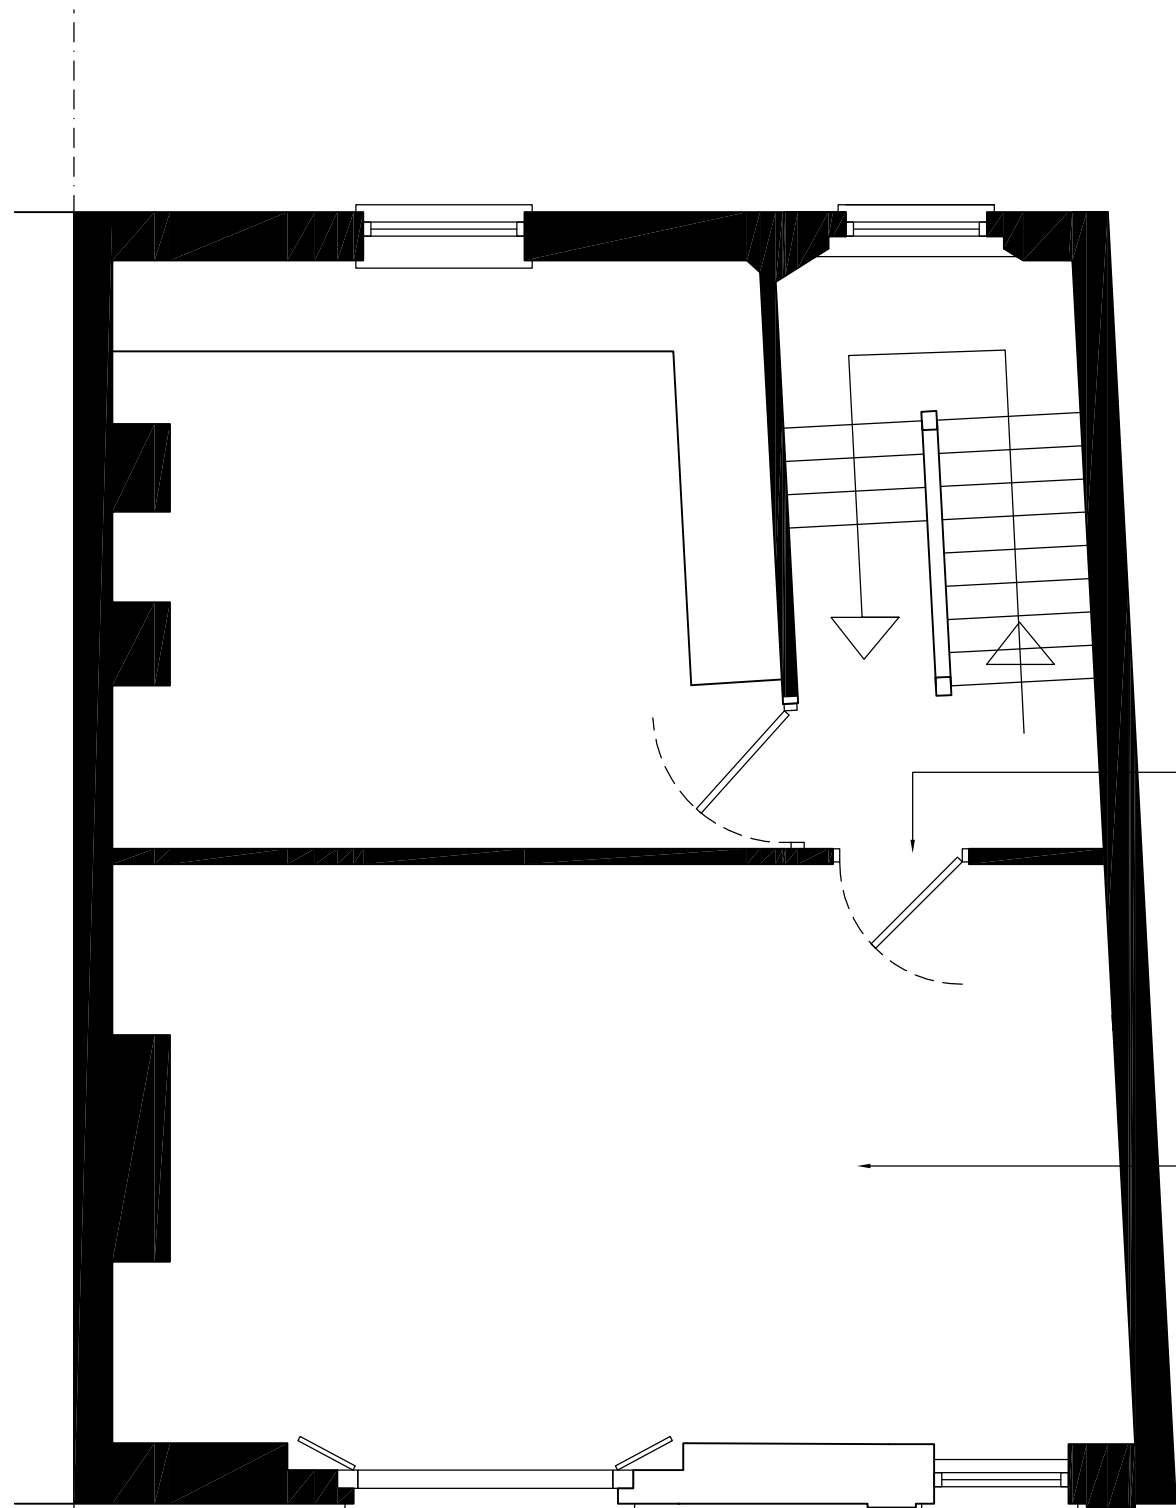

PROPOSED
First Floor Plan

Fit new door to existing opening to 30/30s rating

Remove internal partitions doors and fittings completely. Refit electrical and heating layout to suit.

Revisions:
Suffix / Date / Drawn/ Description

GENERAL
Do not scale drawings, Report any dimensional discrepancies.

©This drawing is the property of Philip Bailey Architects and must not be copied or reproduced in full or in part without express written permission

- Approval
- Preliminary
- Information
- Tender
- Construction
- As Built

Project 15B Willmott Place NW5

Drawing First Floor Plans

Client Vanilla POD

Scale 1:50@A3

Date Nov 07

Project Ref. 422

Drawing No. 02

Revision

philip bailey
architects

11 Beaumont Gate
Shenley Hill
Radlett
Herts WD7 7AR
Tel: 01923 289960
Fax: 01923 289961