



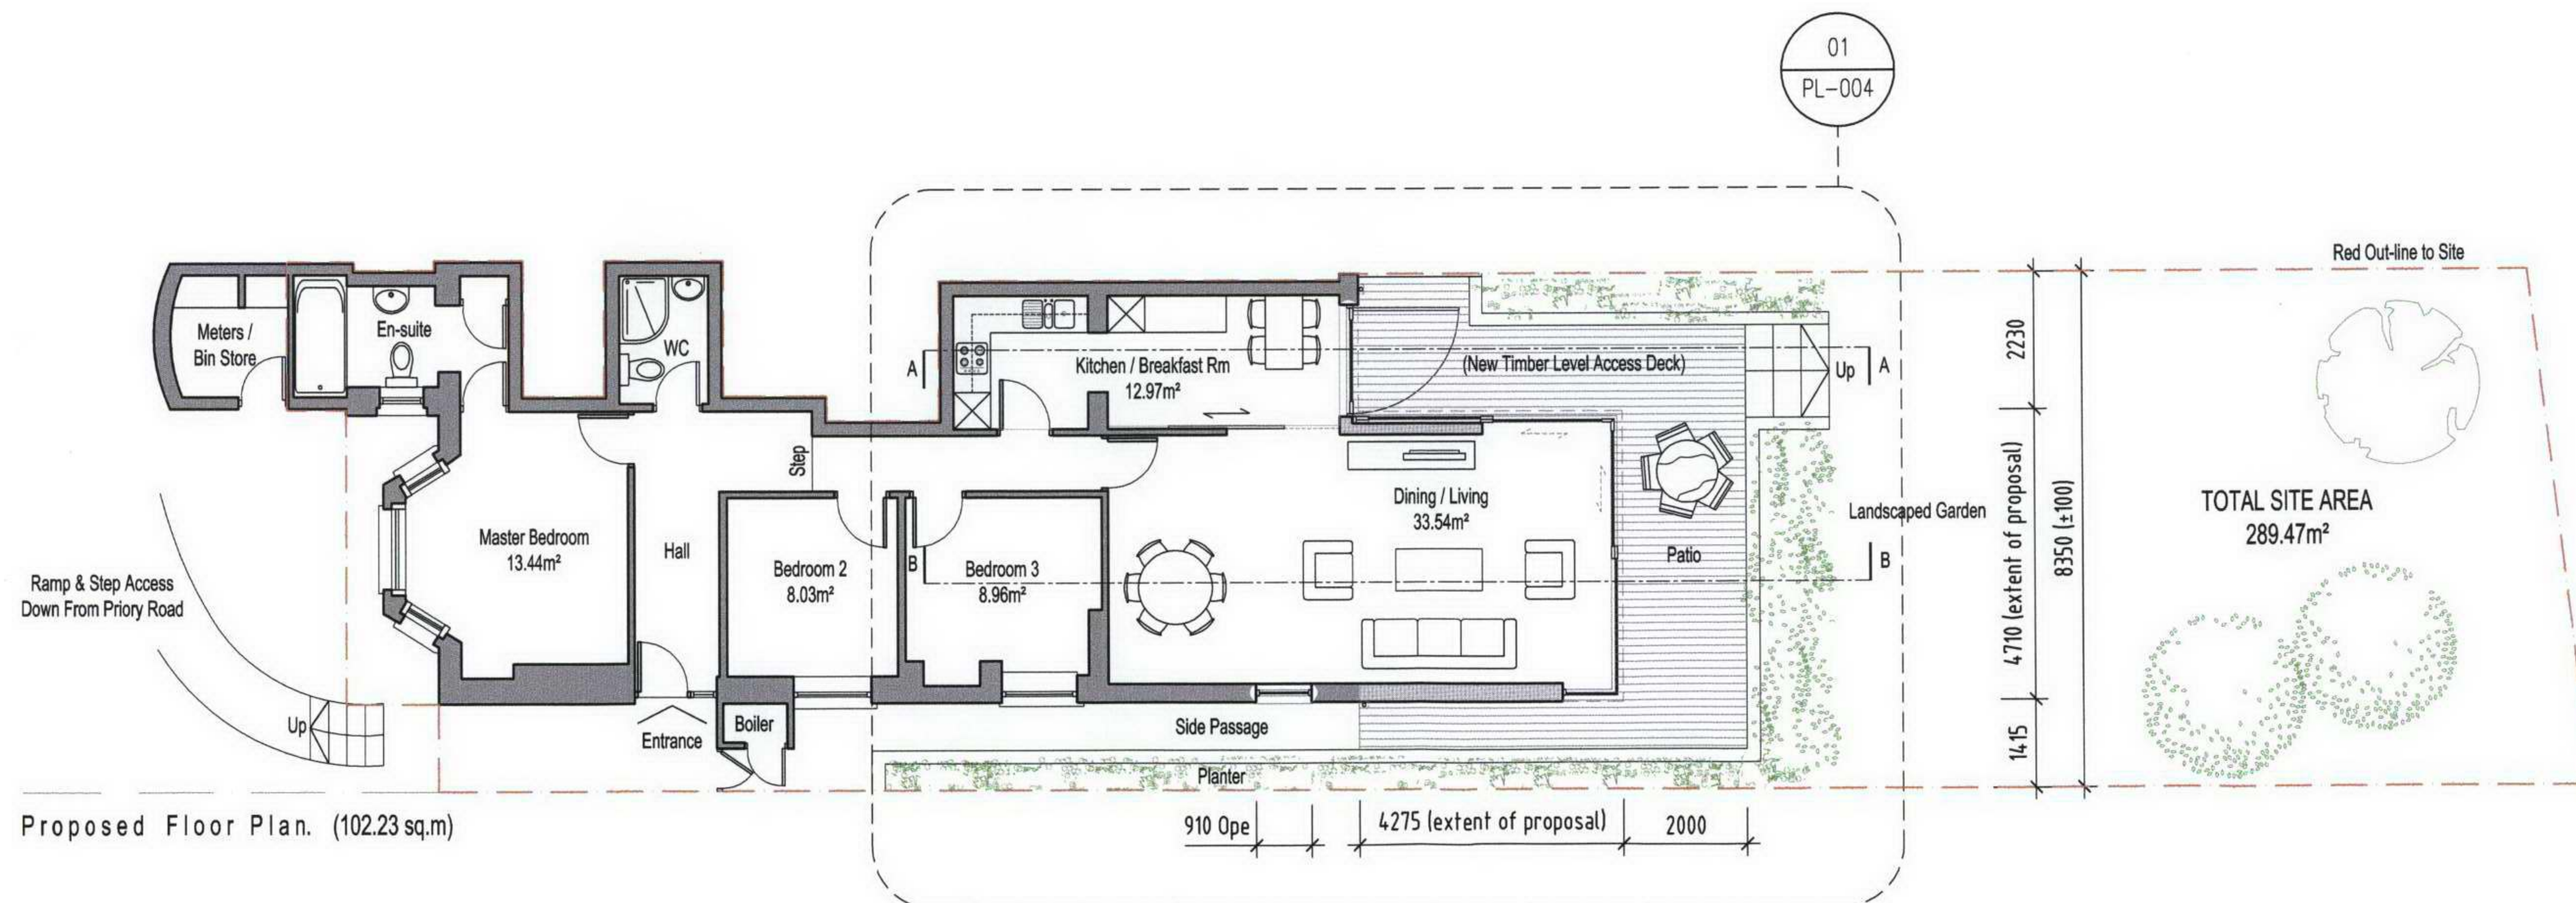

| NOTES                                                                                                                               | Rev: | Date:      | Note:                         | Initial: | Rev: | Date: | Note: | Initial: |
|-------------------------------------------------------------------------------------------------------------------------------------|------|------------|-------------------------------|----------|------|-------|-------|----------|
| 1. Copyright reserved.                                                                                                              | A    | 30 Oct '07 | Issued for Planning Approval. | DS       |      |       |       |          |
| 2. Work to figured dimensions only. Do not scale drawing.                                                                           |      |            |                               |          |      |       |       |          |
| 3. For Structural, Mechanical & Electrical details, refer to Engineers drawings.                                                    |      |            |                               |          |      |       |       |          |
| 4. Proprietary items shall be fixed in strict accordance with the Manufacturers Instructions.                                       |      |            |                               |          |      |       |       |          |
| 5. Sizes of proprietary items shall be checked with Manufacturer.                                                                   |      |            |                               |          |      |       |       |          |
| 6. The Contractor is responsible for checking all levels and dimensions on site and shall refer all discrepancies to the Architect. |      |            |                               |          |      |       |       |          |

|                       |                                                                                                        |                |          |               |                                                                                       |
|-----------------------|--------------------------------------------------------------------------------------------------------|----------------|----------|---------------|---------------------------------------------------------------------------------------|
| <b>Project:</b>       | 07 131 - Proposed Rear Extension to Flat 2, 68 Priory Road, NW6 3RE<br>For Karl Noonan & Sophie Molloy |                |          |               |  |
| <b>Drawing Title:</b> | Existing & Proposed Ground Floor Plans (General Arrangement)                                           |                |          |               |                                                                                       |
| <b>Drawing No:</b>    | 07131 - PL - 001                                                                                       | <b>Rev:</b>    | A        | <b>Scale:</b> | 1:125 @ A3                                                                            |
| <b>Drawn By:</b>      | Des Smyth                                                                                              | <b>Status:</b> | Planning | <b>Date:</b>  | 30 th Oct '07                                                                         |

SOR Architects, 32 Strandville Avenue, North Strand, Dublin 3. **telephone** +353 (0)1 819 6716 **email** info@sorarch.ie

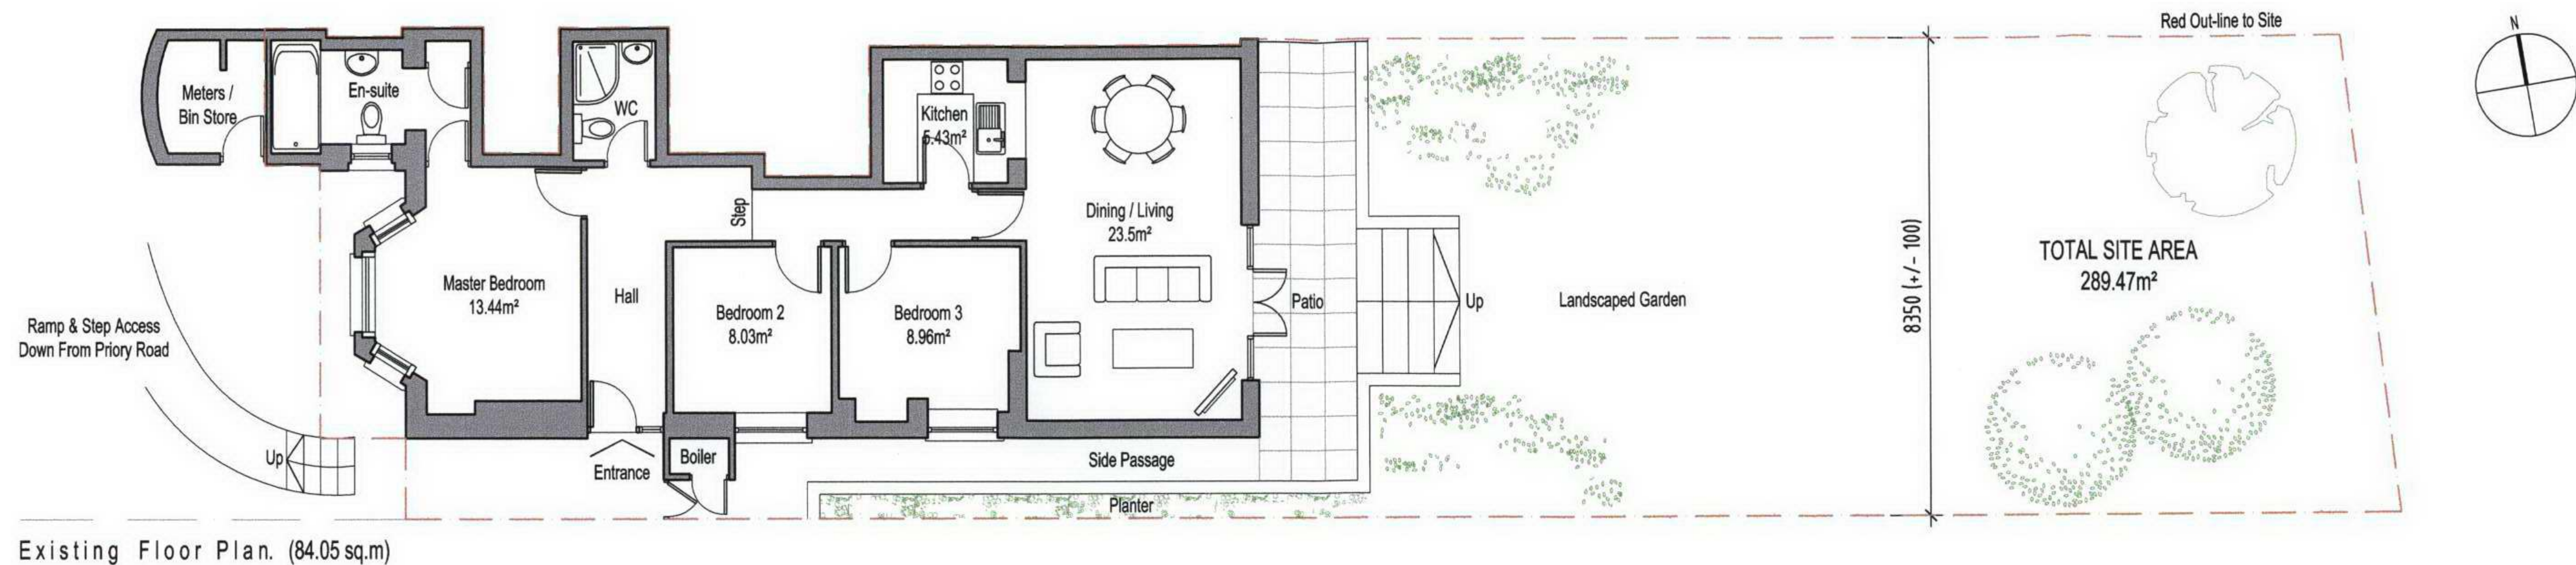

Existing Rear Elevation.(East)




Existing Side Elevation.(South)

| NOTES                                                                                                                               | Rev: | Date:      | Note:                         | Initial: | Rev: | Date: | Note: | Initial: |
|-------------------------------------------------------------------------------------------------------------------------------------|------|------------|-------------------------------|----------|------|-------|-------|----------|
| 1. Copyright reserved.                                                                                                              | A    | 30 Oct '07 | Issued for Planning Approval. | DS       |      |       |       |          |
| 2. Work to figured dimensions only. Do not scale drawing.                                                                           |      |            |                               |          |      |       |       |          |
| 3. For Structural, Mechanical & Electrical details, refer to Engineers drawings.                                                    |      |            |                               |          |      |       |       |          |
| 4. Proprietary items shall be fixed in strict accordance with the Manufacturers Instructions.                                       |      |            |                               |          |      |       |       |          |
| 5. Sizes of proprietary items shall be checked with Manufacturer.                                                                   |      |            |                               |          |      |       |       |          |
| 6. The Contractor is responsible for checking all levels and dimensions on site and shall refer all discrepancies to the Architect. |      |            |                               |          |      |       |       |          |

|                       |                                                                                                        |                |          |               |                                                                                       |
|-----------------------|--------------------------------------------------------------------------------------------------------|----------------|----------|---------------|---------------------------------------------------------------------------------------|
| <b>Project:</b>       | 07 131 - Proposed Rear Extension to Flat 2, 68 Priory Road, NW6 3RE<br>For Karl Noonan & Sophie Molloy |                |          |               |  |
| <b>Drawing Title:</b> | Existing Elevations (General Arrangement)                                                              |                |          |               |                                                                                       |
| <b>Drawing No:</b>    | 07131 - PL - 002                                                                                       | <b>Rev:</b>    | A        | <b>Scale:</b> | 1:125 @ A3                                                                            |
| <b>Drawn By:</b>      | Des Smyth                                                                                              | <b>Status:</b> | Planning | <b>Date:</b>  | 30th Oct '07                                                                          |


SOR Architects, 32 Strandville Avenue, North Strand, Dublin 3. telephone +353 (0)1 819 6716 email info@sorarch.ie

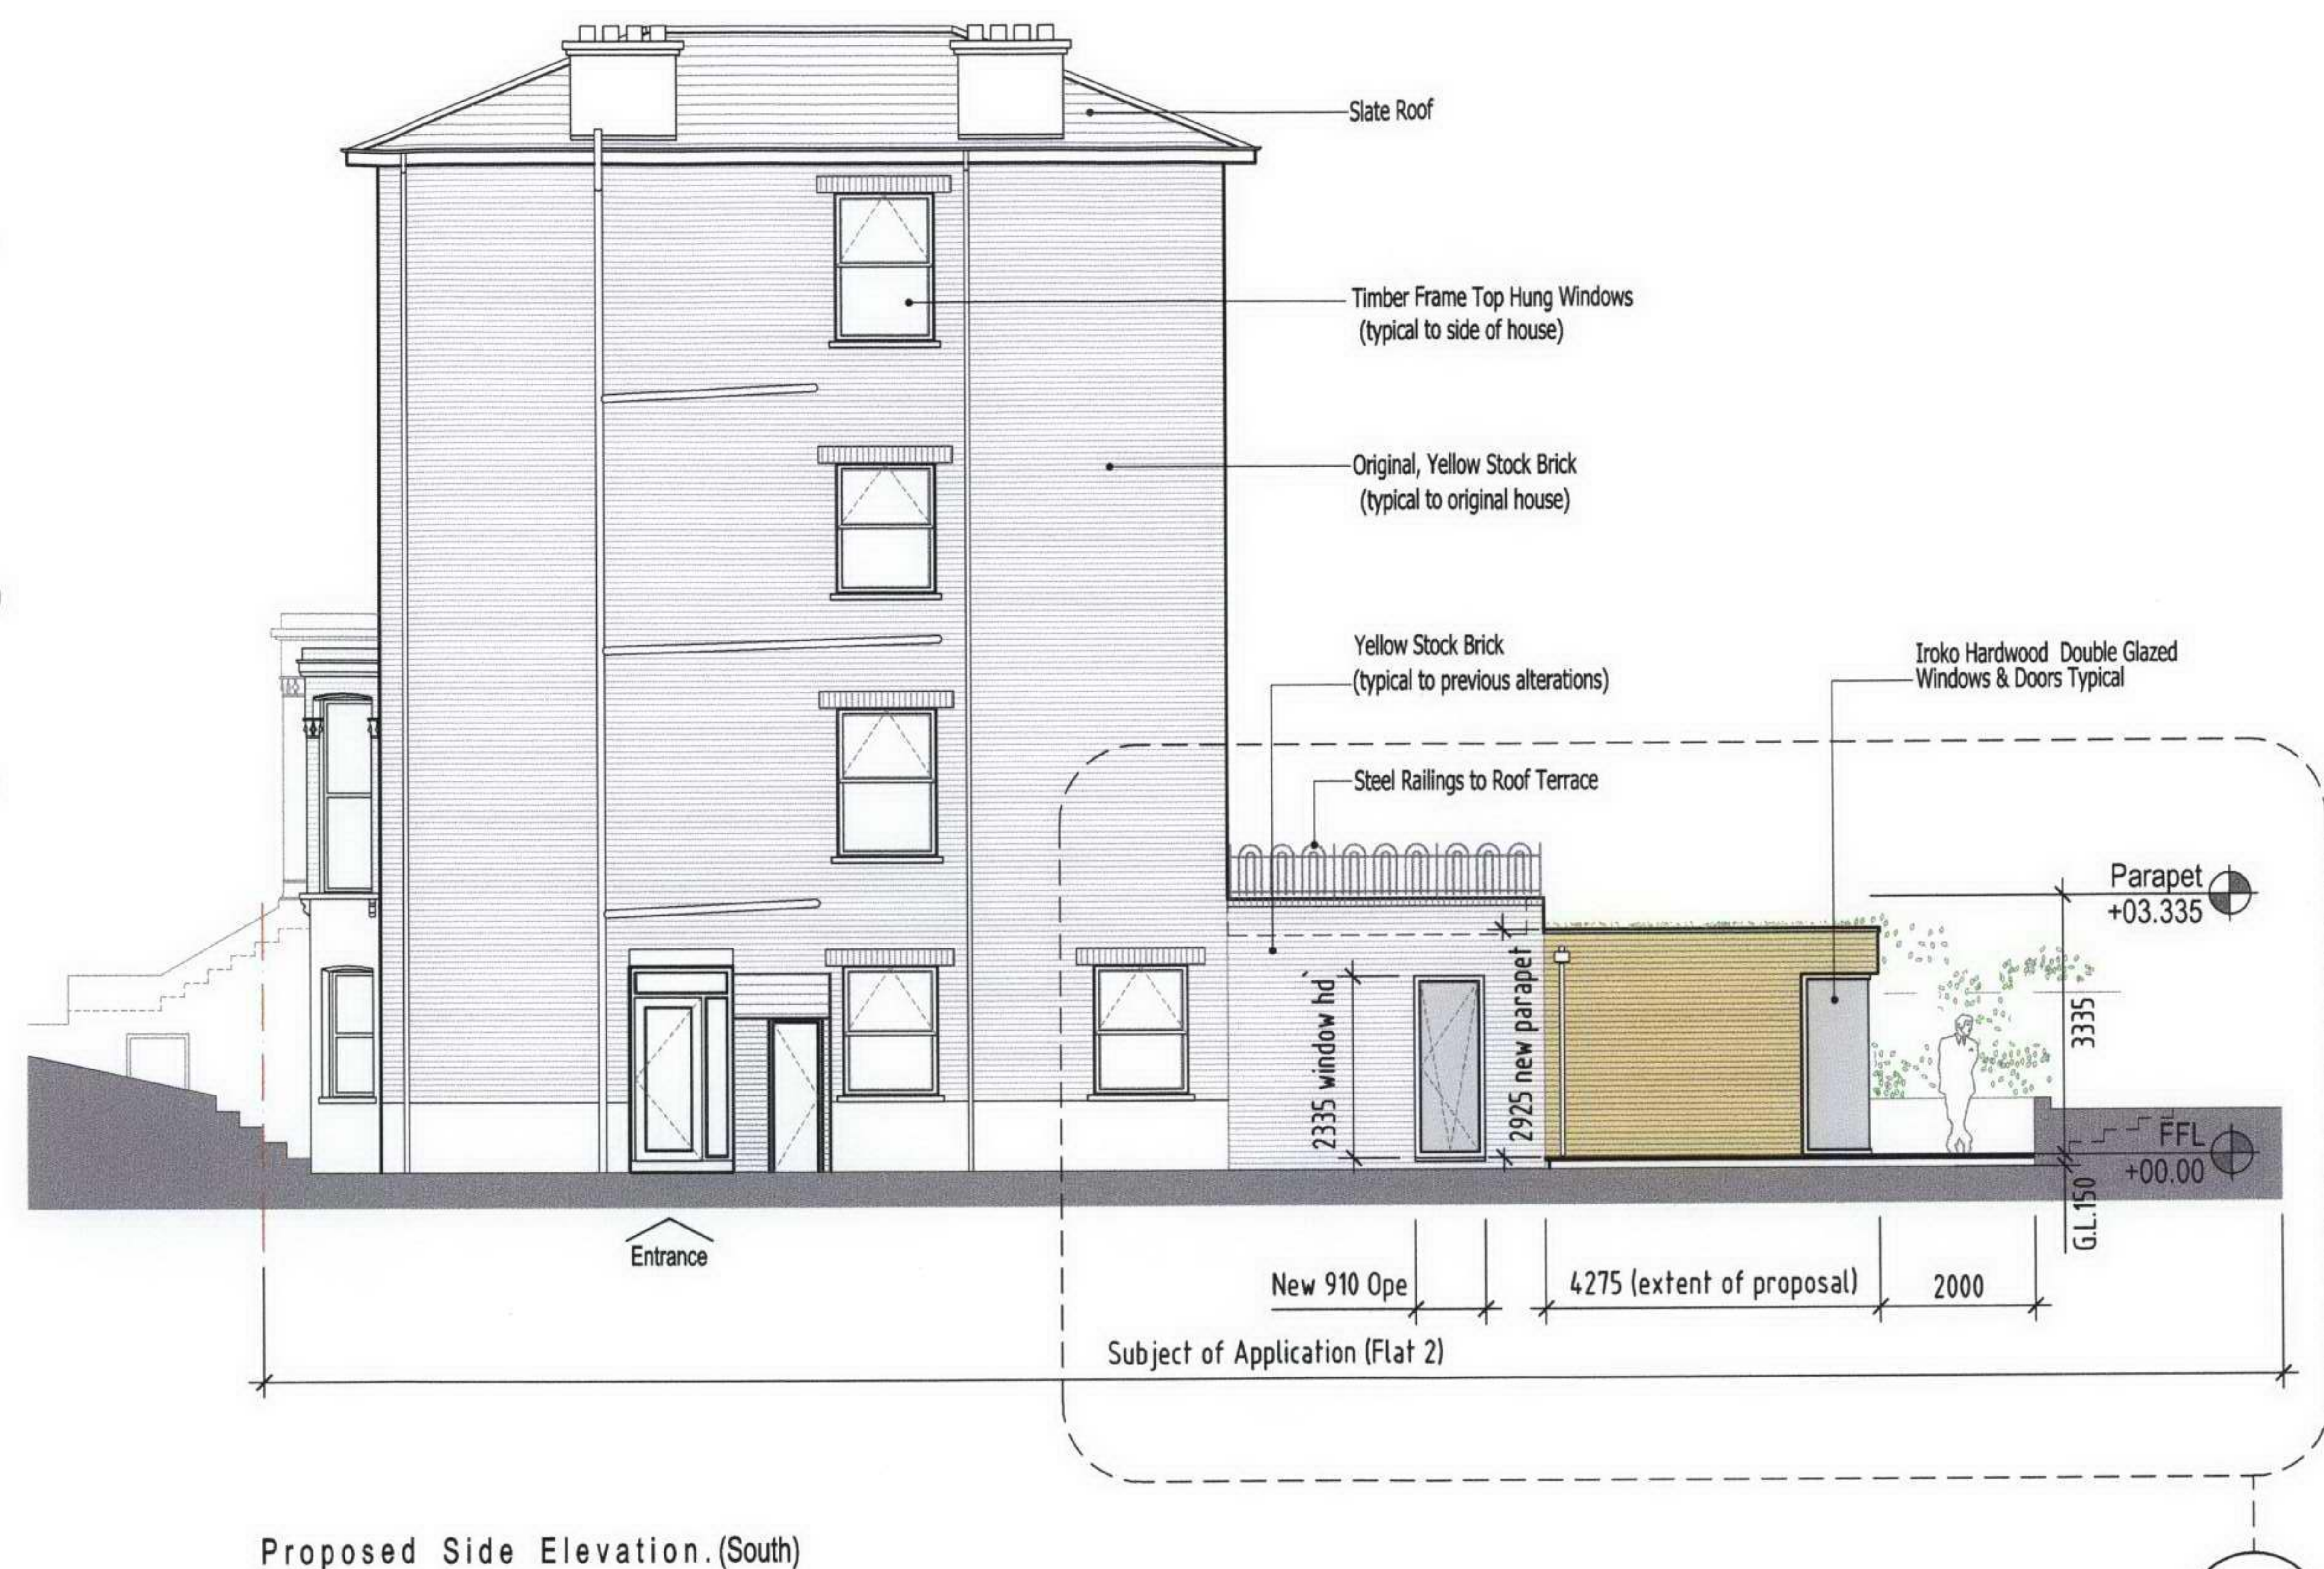


| NOTES                                                                                                                               | Rev: | Date:      | Note:                         | Initial: | Rev: | Date: | Note: | Initial: |
|-------------------------------------------------------------------------------------------------------------------------------------|------|------------|-------------------------------|----------|------|-------|-------|----------|
| 1. Copyright reserved.                                                                                                              | A    | 30 Oct '07 | Issued for Planning Approval. | DS       |      |       |       |          |
| 2. Work to figured dimensions only. Do not scale drawing.                                                                           |      |            |                               |          |      |       |       |          |
| 3. For Structural, Mechanical & Electrical details, refer to Engineers drawings.                                                    |      |            |                               |          |      |       |       |          |
| 4. Proprietary items shall be fixed in strict accordance with the Manufacturers Instructions.                                       |      |            |                               |          |      |       |       |          |
| 5. Sizes of proprietary items shall be checked with Manufacturer.                                                                   |      |            |                               |          |      |       |       |          |
| 6. The Contractor is responsible for checking all levels and dimensions on site and shall refer all discrepancies to the Architect. |      |            |                               |          |      |       |       |          |



|                                                                                                                        |                         |                                                                 |  |
|------------------------------------------------------------------------------------------------------------------------|-------------------------|-----------------------------------------------------------------|--|
| <b>Project:</b> 07 131 - Proposed Rear Extension to Flat 2, 68 Priory Road, NW6 3RE<br>For Karl Noonan & Sophie Molloy |                         | <b>Drawing Title:</b> Proposed Elevations (General Arrangement) |  |
| <b>Drawing No:</b> 07131 - PL - 003                                                                                    | <b>Rev:</b> A           | <b>Scale:</b> 1:125 @ A3                                        |  |
| <b>Drawn By:</b> Des Smyth                                                                                             | <b>Status:</b> Planning | <b>Date:</b> 30th Oct '07                                       |  |

SOR Architects, 32 Strandville Avenue, North Strand, Dublin 3. telephone +353 (0)1 819 6716 email info@sorarch.ie

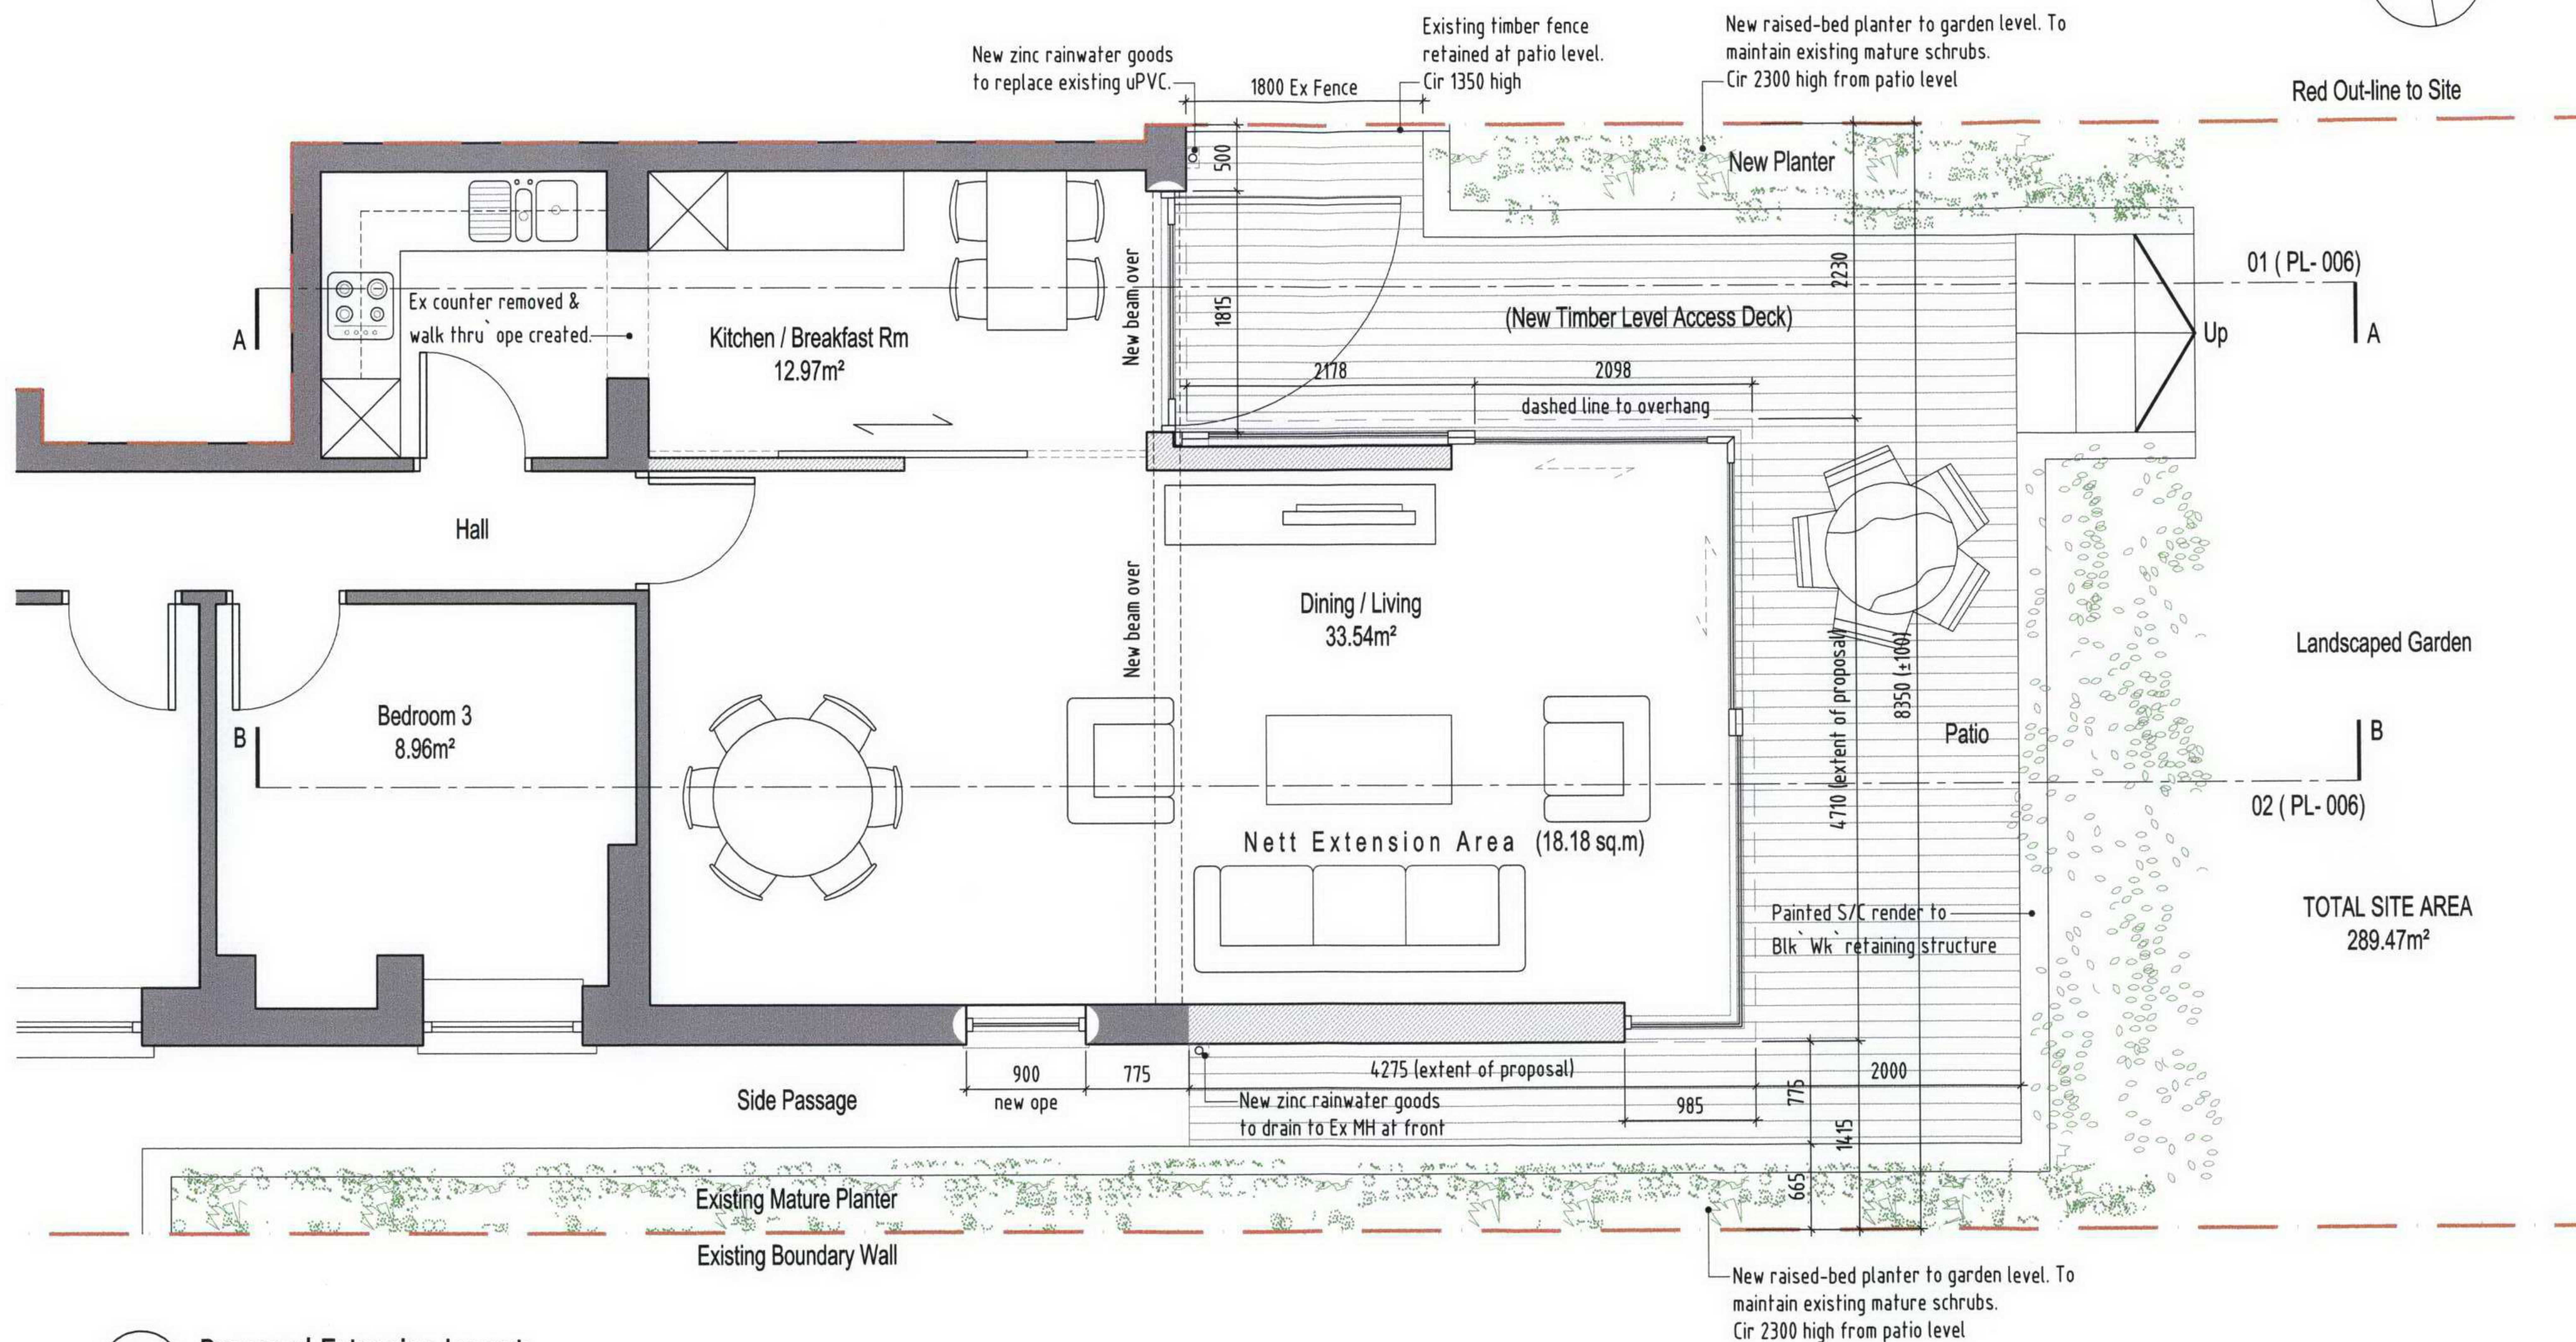

| NOTES                                                                                                                              | Rev: | Date:      | Note:                         | Initial: | Rev: | Date: | Note: | Initial: |
|------------------------------------------------------------------------------------------------------------------------------------|------|------------|-------------------------------|----------|------|-------|-------|----------|
| 1. Copyright reserved.                                                                                                             | A    | 30 Oct '07 | Issued for Planning Approval. | DS       |      |       |       |          |
| 2. Work to figured dimensions only. Do not scale drawing.                                                                          |      |            |                               |          |      |       |       |          |
| 3. For Structural, Mechanical & Electrical details, refer to Engineers drawings.                                                   |      |            |                               |          |      |       |       |          |
| 4. Proprietary items shall be fixed in strict accordance with the Manufacturers Instructions.                                      |      |            |                               |          |      |       |       |          |
| 5. Sizes of proprietary items shall be checked with Manufacturer.                                                                  |      |            |                               |          |      |       |       |          |
| 6. The Contractor is responsible for checking all levels and dimensions on site and shall refer all discrepancies to the Architect |      |            |                               |          |      |       |       |          |

 
|                                                                                                                                 |                         |                                                                                       |              |
|---------------------------------------------------------------------------------------------------------------------------------|-------------------------|---------------------------------------------------------------------------------------|--------------|
| <b>Project:</b> 07 131 - Proposed Rear Extension to Flat 2, 68 Priory Road, NW6 3RE<br>For Karl Noonan & Sophie Molloy          |                         |  |              |
| <b>Drawing Title:</b> Proposed Floor Plan                                                                                       |                         |                                                                                       |              |
| <b>Drawing No:</b> 07131 - PL - 004                                                                                             | <b>Rev:</b> A           | <b>Scale:</b>                                                                         | 1:50 @ A3    |
| <b>Drawn By:</b> Des Smyth                                                                                                      | <b>Status:</b> Planning | <b>Date:</b>                                                                          | 30th Oct '07 |
| SOR Architects, 32 Strandville Avenue, North Strand, Dublin 3. <b>telephone</b> +353 (0)1 819 6716 <b>email</b> info@sorarch.ie |                         |                                                                                       |              |

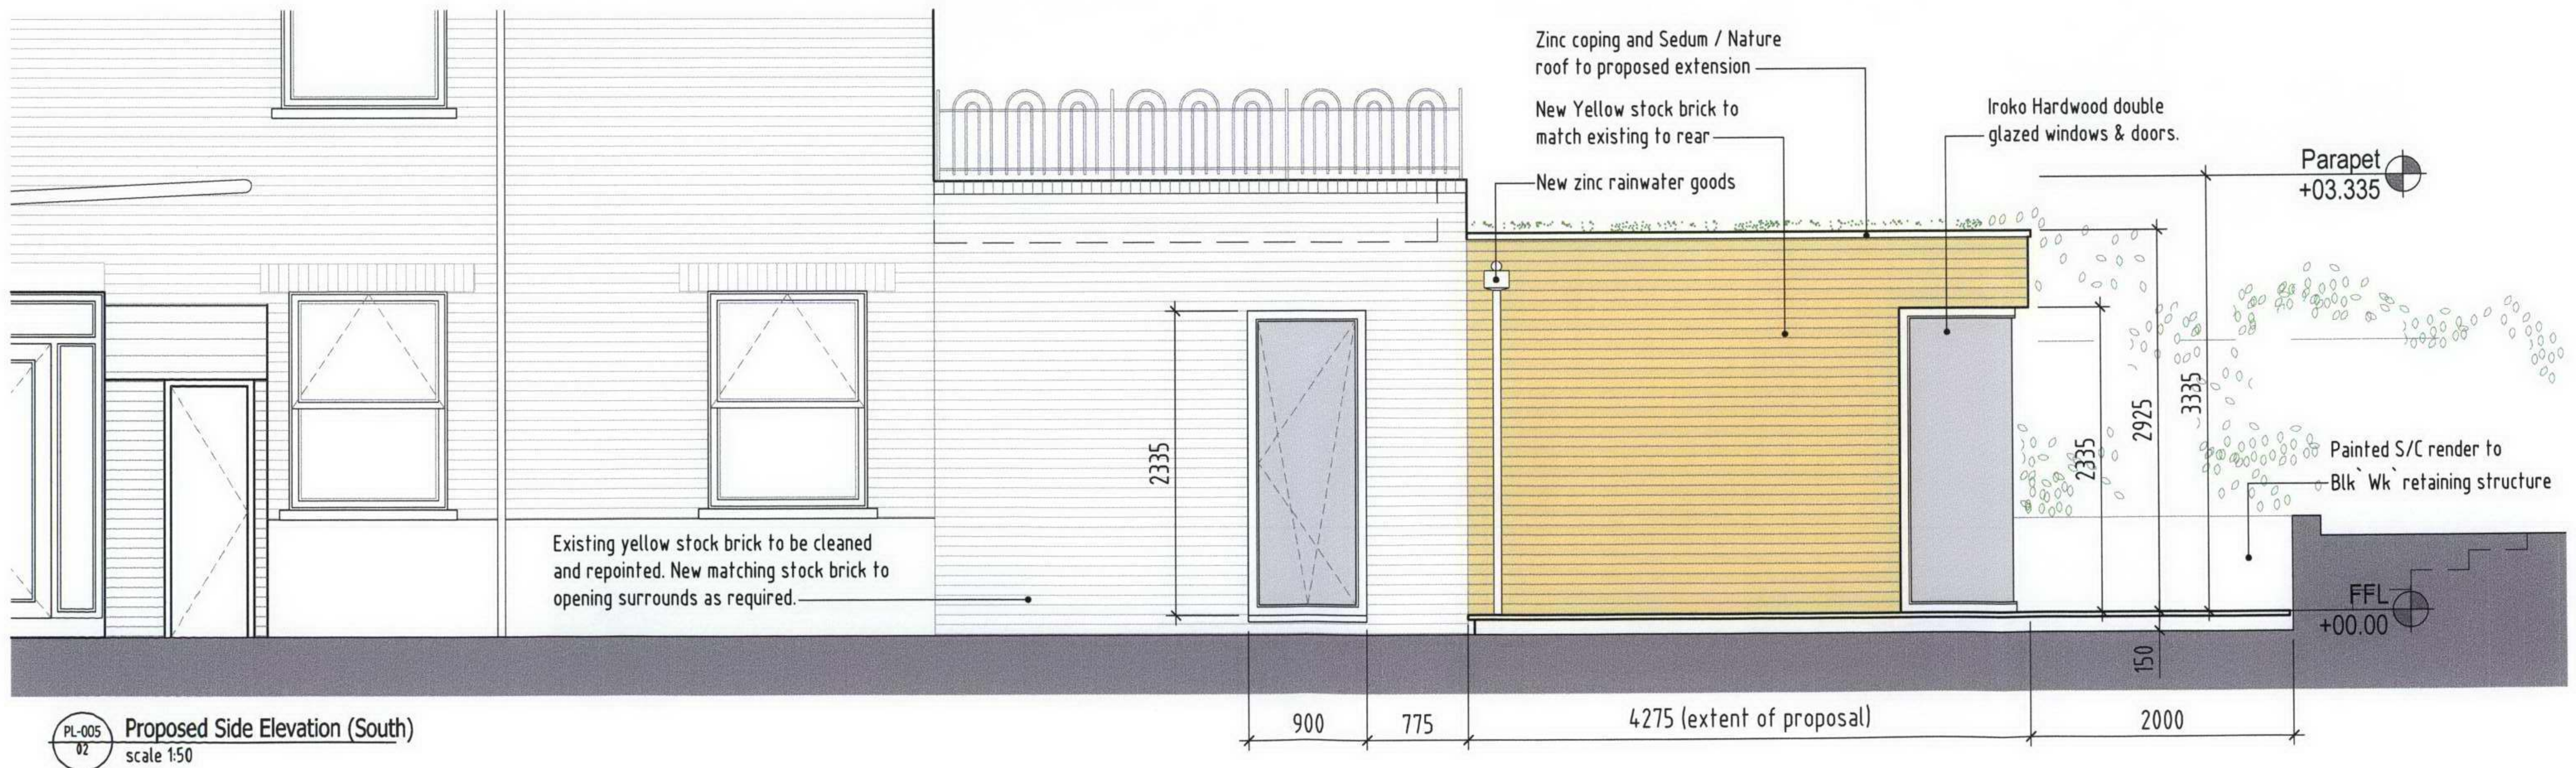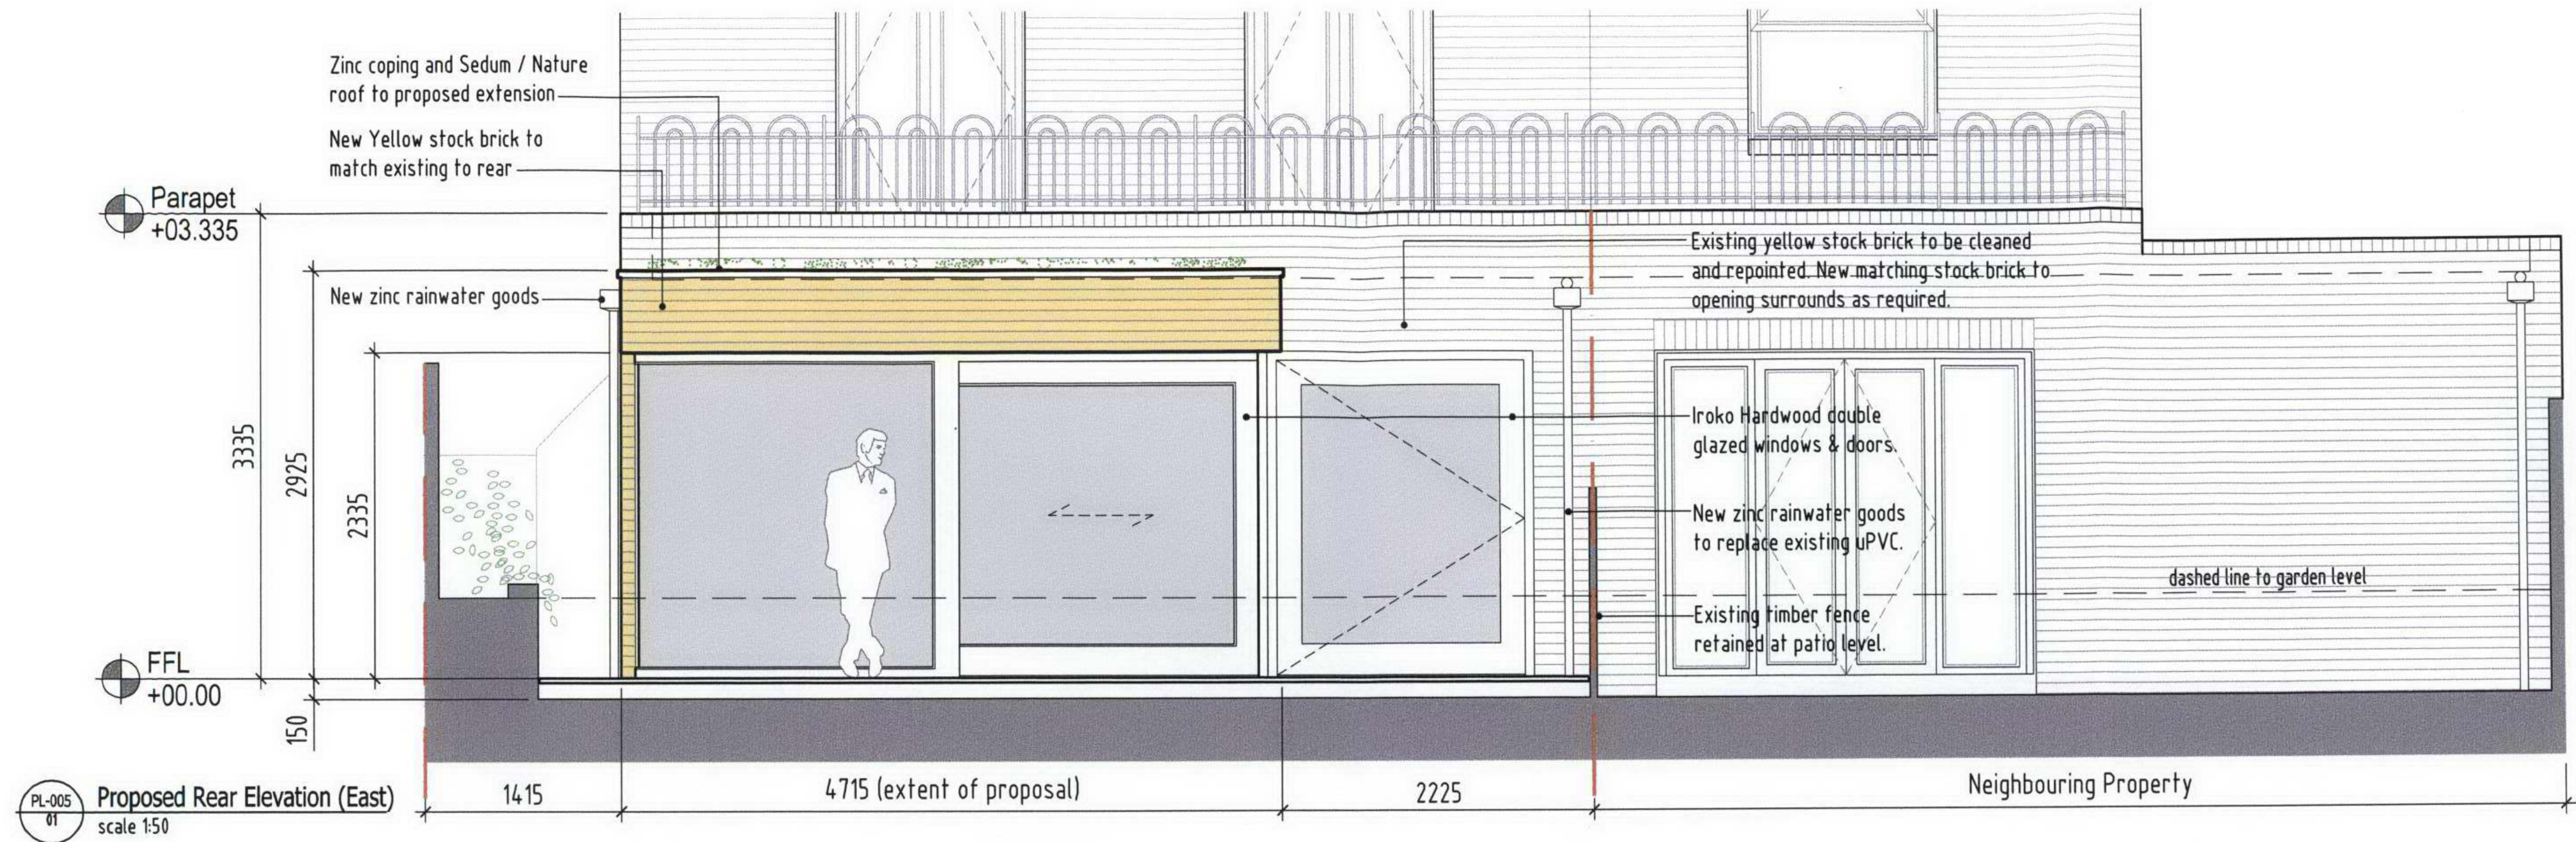


| NOTES                                                                                                                               | Rev: | Date:      | Note:                         | Initial: | Rev: | Date: | Note: | Initial: |
|-------------------------------------------------------------------------------------------------------------------------------------|------|------------|-------------------------------|----------|------|-------|-------|----------|
| 1. Copyright reserved.                                                                                                              | A    | 30 Oct '07 | Issued for Planning Approval. | DS       |      |       |       |          |
| 2. Work to figured dimensions only. Do not scale drawing.                                                                           |      |            |                               |          |      |       |       |          |
| 3. For Structural, Mechanical & Electrical details, refer to Engineers drawings.                                                    |      |            |                               |          |      |       |       |          |
| 4. Proprietary items shall be fixed in strict accordance with the Manufacturers Instructions.                                       |      |            |                               |          |      |       |       |          |
| 5. Sizes of proprietary items shall be checked with Manufacturer.                                                                   |      |            |                               |          |      |       |       |          |
| 6. The Contractor is responsible for checking all levels and dimensions on site and shall refer all discrepancies to the Architect. |      |            |                               |          |      |       |       |          |

|                       |                                                                                                        |                |          |               |                                                                                       |
|-----------------------|--------------------------------------------------------------------------------------------------------|----------------|----------|---------------|---------------------------------------------------------------------------------------|
| <b>Project:</b>       | 07 131 - Proposed Rear Extension to Flat 2, 68 Priory Road, NW6 3RE<br>For Karl Noonan & Sophie Molloy |                |          |               |  |
| <b>Drawing Title:</b> | Proposed Elevations                                                                                    |                |          |               |                                                                                       |
| <b>Drawing No:</b>    | 07131 - PL - 005                                                                                       | <b>Rev:</b>    | A        | <b>Scale:</b> | 1:50 @ A3                                                                             |
| <b>Drawn By:</b>      | Des Smyth                                                                                              | <b>Status:</b> | Planning | <b>Date:</b>  | 30th Oct '07                                                                          |

SOR Architects, 32 Strandville Avenue, North Strand, Dublin 3. telephone +353 (0)1 819 6716 email info@sorarch.ie

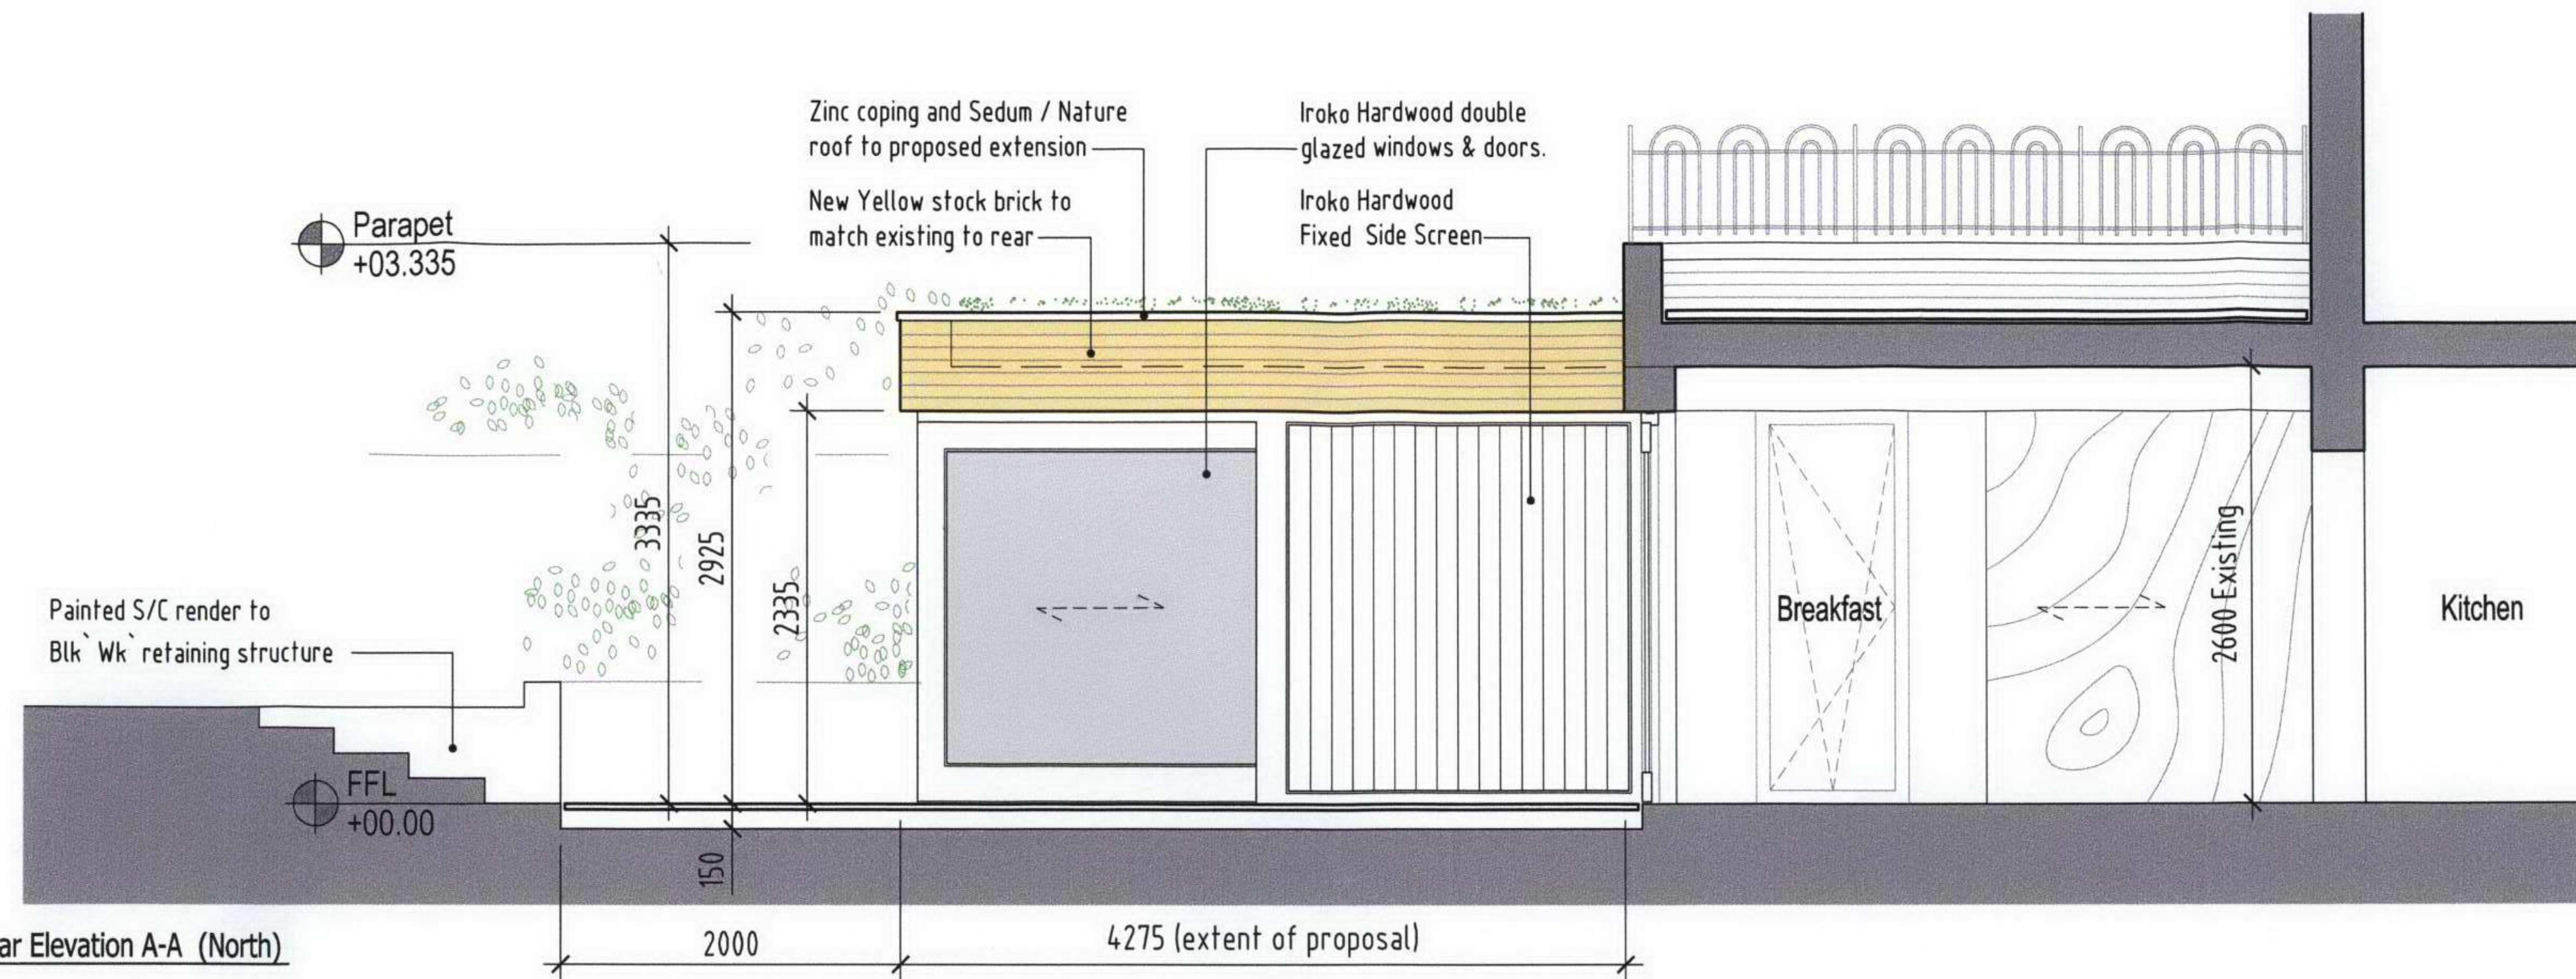

PL-006  
01 Proposed Rear Elevation A-A (North)  
scale 1:50

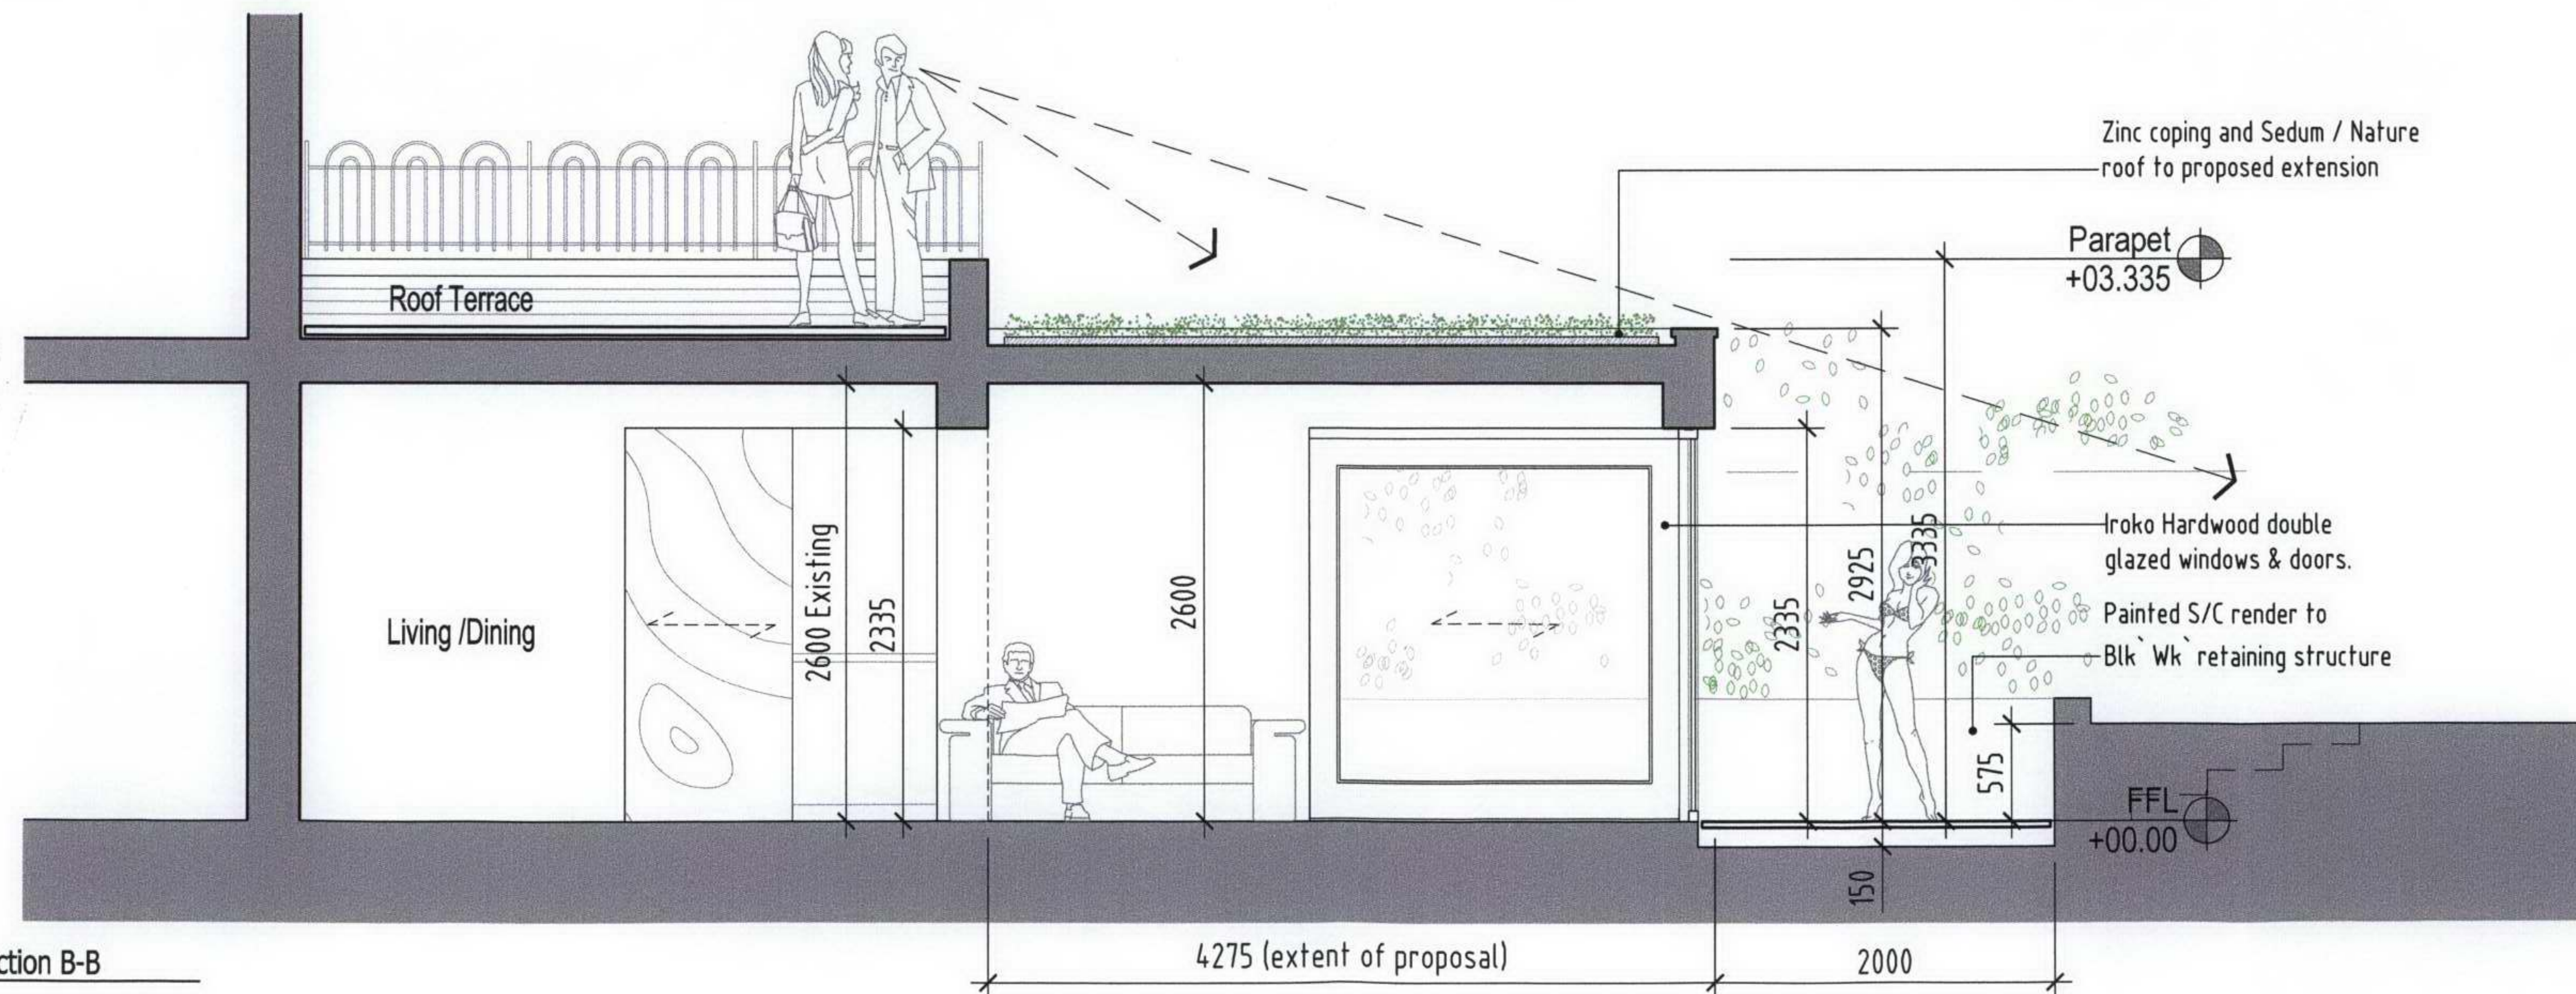

PL-006  
02 Proposed Section B-B  
scale 1:50

| NOTES                                                                                                                               | Rev: | Date:      | Note:                         | Initial: | Rev: | Date: | Note: | Initial: |
|-------------------------------------------------------------------------------------------------------------------------------------|------|------------|-------------------------------|----------|------|-------|-------|----------|
| 1. Copyright reserved.                                                                                                              | A    | 30 Oct '07 | Issued for Planning Approval. | DS       |      |       |       |          |
| 2. Work to figured dimensions only. Do not scale drawing.                                                                           |      |            |                               |          |      |       |       |          |
| 3. For Structural, Mechanical & Electrical details, refer to Engineers drawings.                                                    |      |            |                               |          |      |       |       |          |
| 4. Proprietary items shall be fixed in strict accordance with the Manufacturers Instructions.                                       |      |            |                               |          |      |       |       |          |
| 5. Sizes of proprietary items shall be checked with Manufacturer.                                                                   |      |            |                               |          |      |       |       |          |
| 6. The Contractor is responsible for checking all levels and dimensions on site and shall refer all discrepancies to the Architect. |      |            |                               |          |      |       |       |          |

**Project:** 07 131 - Proposed Rear Extension to Flat 2, 68 Priory Road, NW6 3RE  
For Karl Noonan & Sophie Molloy



**Drawing Title:** Proposed Sections & Elevations

**Drawing No:** 07131 - PL - 006

**Drawn By:** Des Smyth

**Rev:** A

**Status:** Planning

**Scale:** 1:50 @ A3

**Date:** 30th Oct '07

SOR Architects, 32 Strandville Avenue, North Strand, Dublin 3. telephone +353 (0)1 819 6716 email info@sorarch.ie