




THIS DRAWING MUST NOT BE REPRODUCED WITHOUT PRIOR CONSENT.
DO NOT SCALE FROM THIS DRAWING.
THIS DRAWING IS COPYRIGHT. ©
GENERAL NOTES

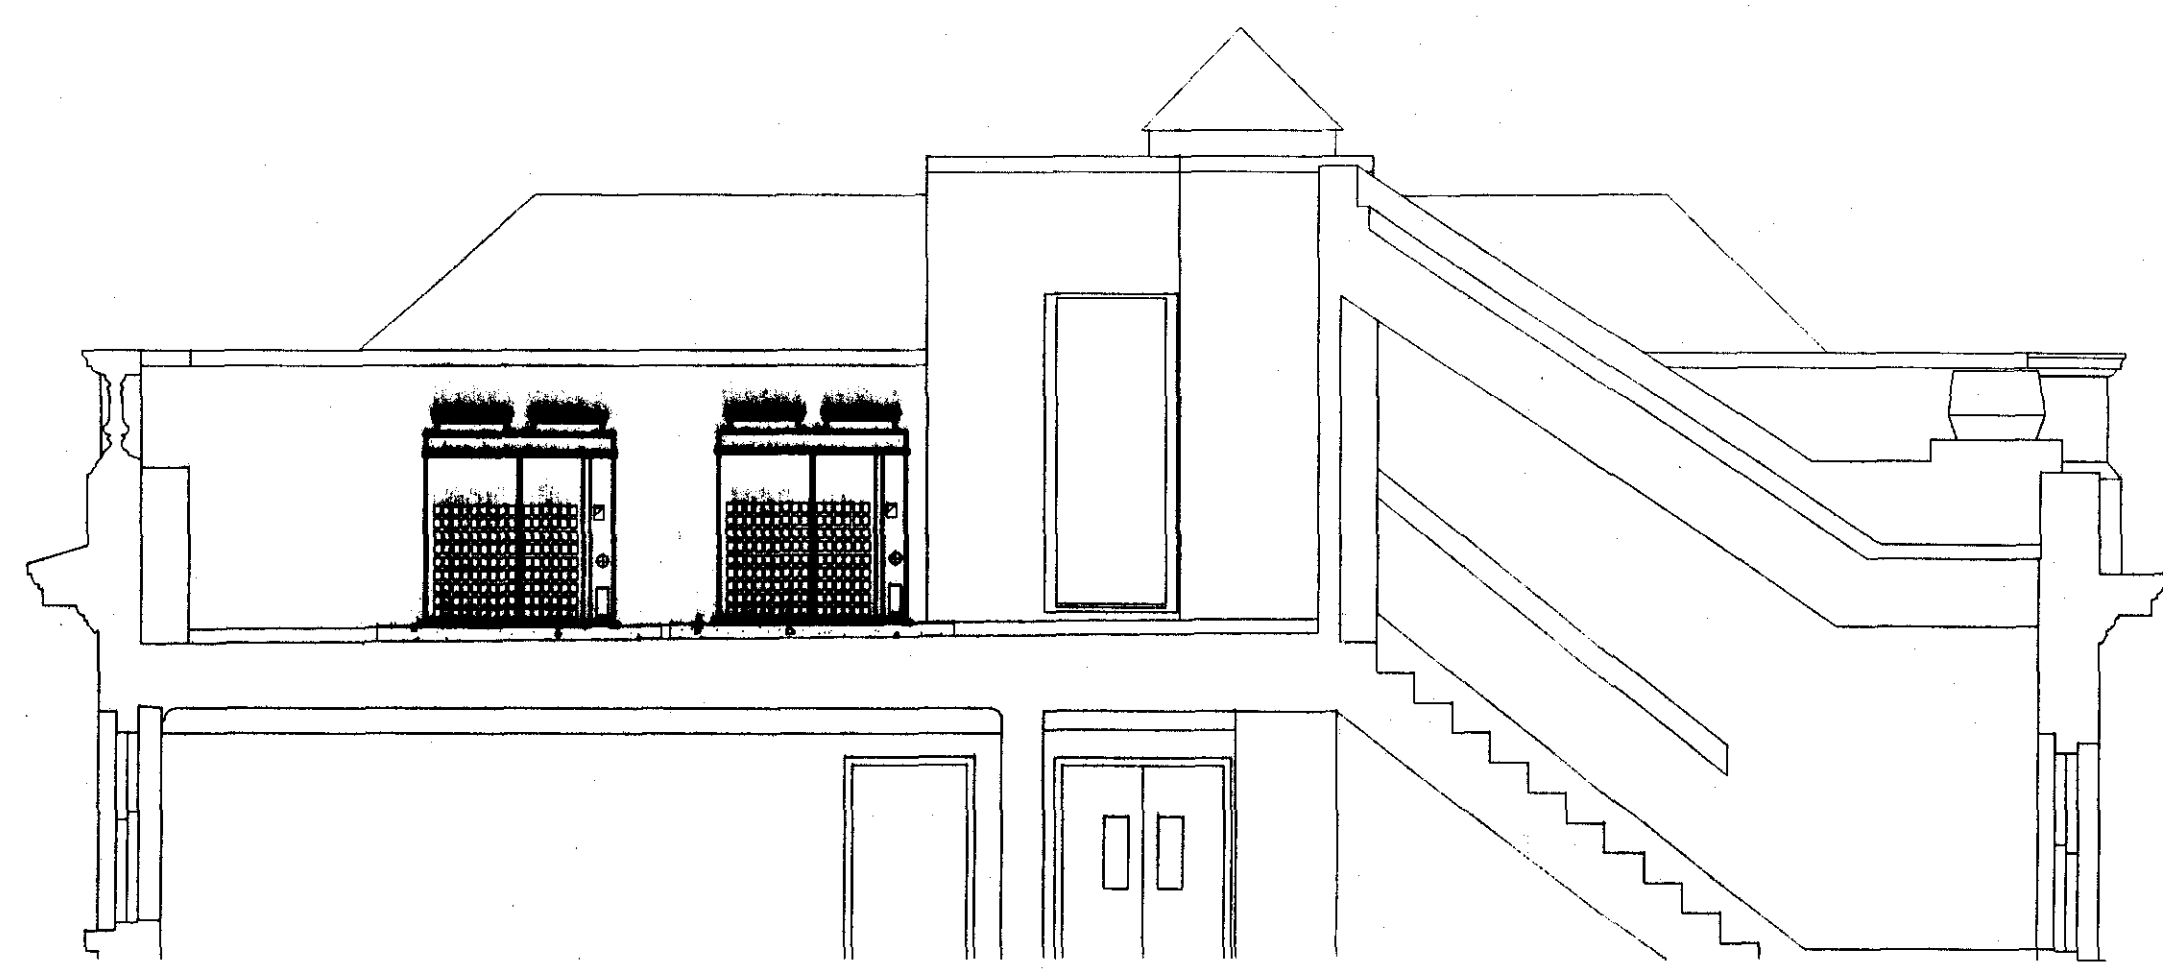


SECTION A-A

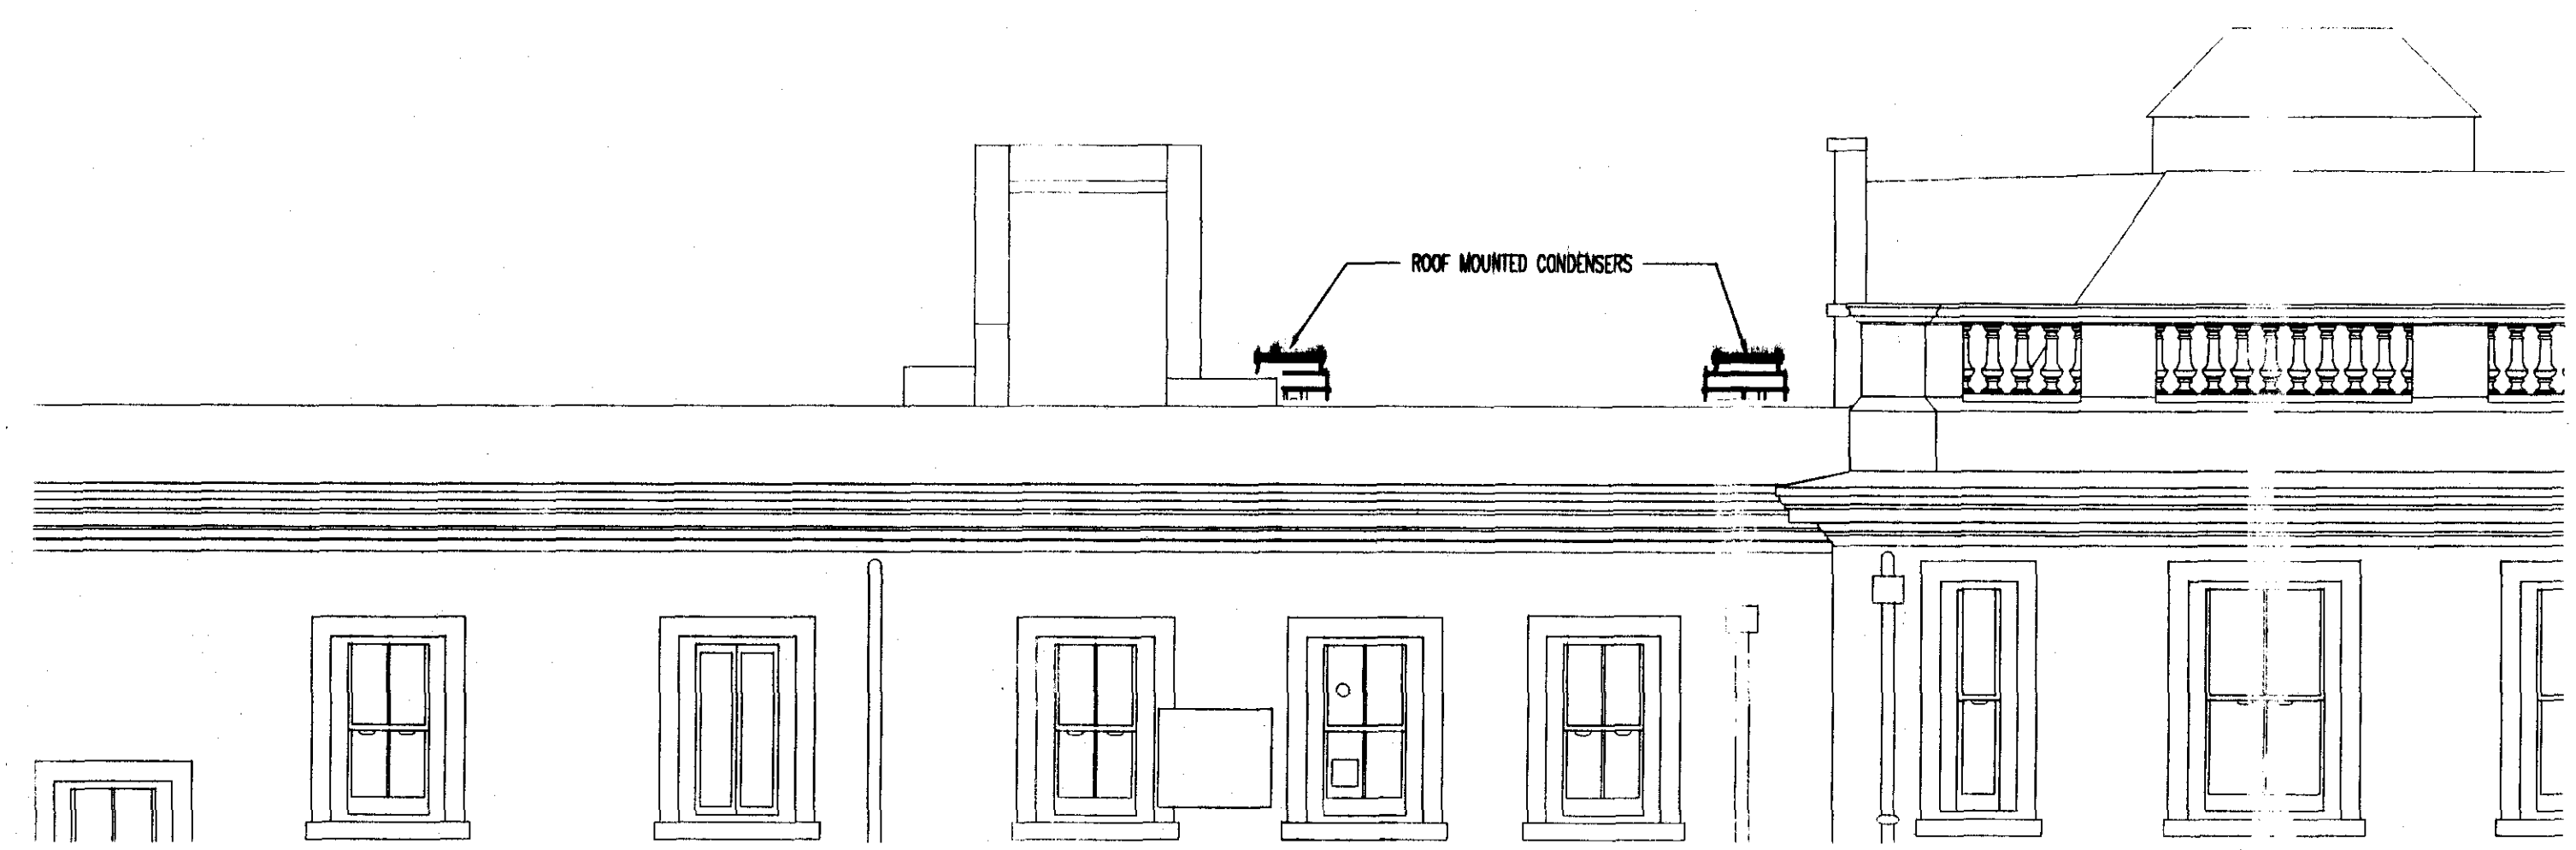

SECTION B-B

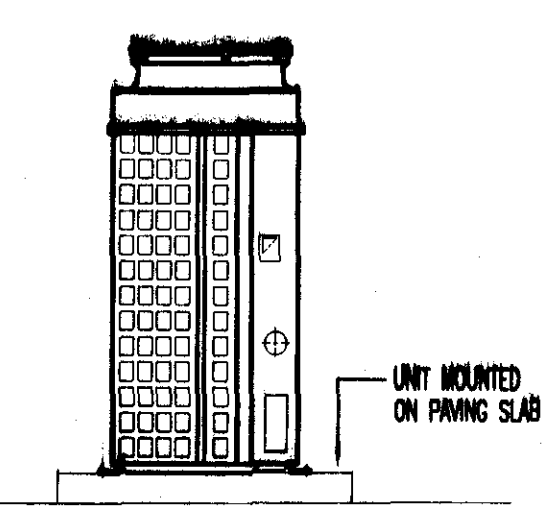

CONDENSER UNIT DETAIL

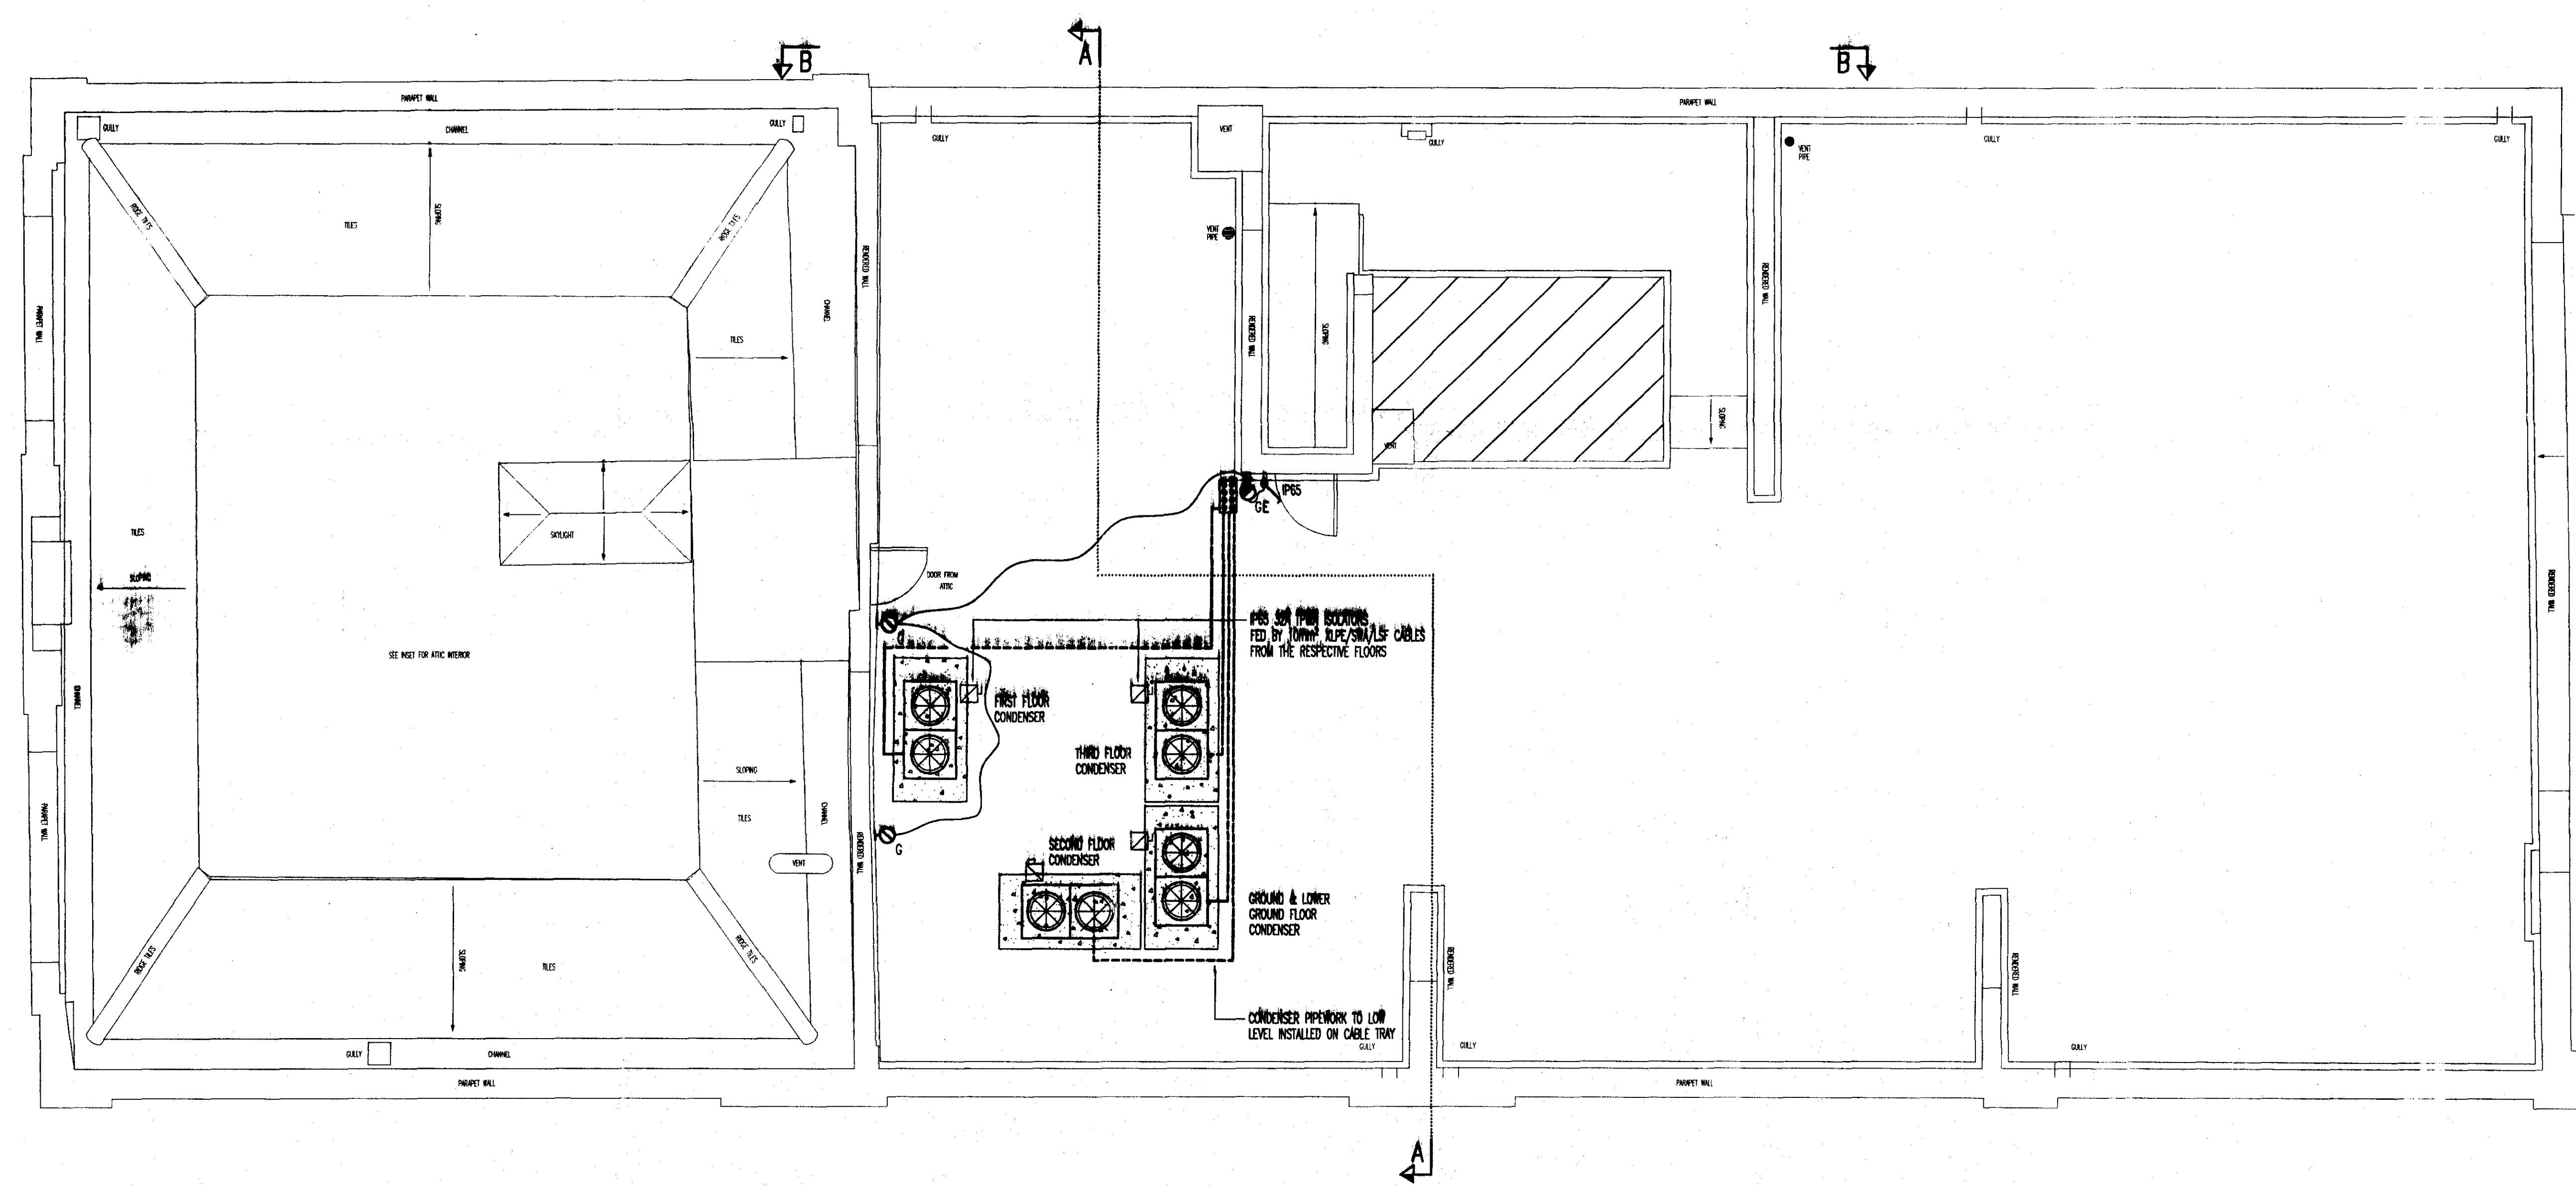

PLANNING

Rev	Date	Description
F	APR.07	CONDENSER UNIT DETAIL ADDED, SECTION A-A INDICATED
E	MAR.07	CONDENSERS RELOCATED TO MORE CENTRAL ZONE ON ROOF
D	FEB.07	CONDENSERS RELOCATED IN TO CENTRAL ZONE OF ROOF TO AVOID VIEWING FROM STREET LEVEL
C	OCT.06	TENDER ISSUE
B	SEP.06	PARAPET ELEVATION CORRECTED
A	APR.06	REAR ELEVATION ADDED
O	MAR.06	PRELIMINARY ISSUE

TPS

Taylor Project Services

No.1 Cornhill
London EC3V 3ND
Tel 020 7743 6602 Fax 020 7743 6603 Mobile 07778 667683

Project
**74-77 GREAT RUSSELL STREET
LONDON**

Drawing title
**ROOF LEVEL
PROPOSED
CONDENSER COMPOUND
LAYOUT (GROUND-3RD OPTION)**

Scale	1:50	Date	08.03.08
Drawn	E.M.	Checked	G.N.T.


Drawing Status
PLANNING

Revision	A	B	C	D	E	F



Drawing No.
TPS/GRS/E/R



THIS DRAWING MUST NOT BE REPRODUCED WITHOUT PRIOR CONSENT.
DO NOT SCALE FROM THIS DRAWING.
THIS DRAWING IS COPYRIGHT ©
GENERAL NOTES

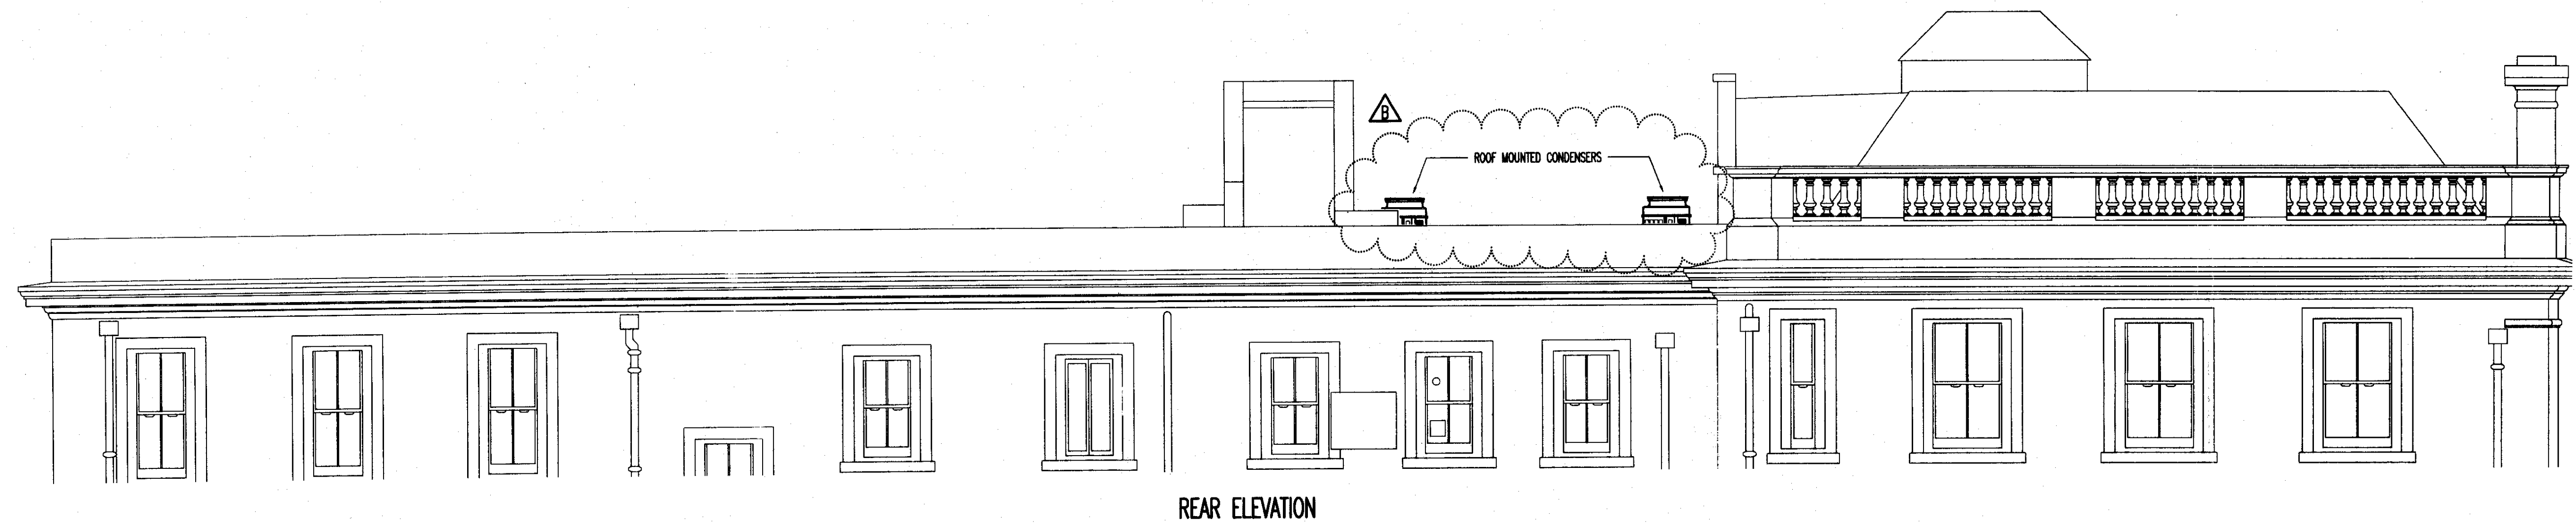

REAR ELEVATION

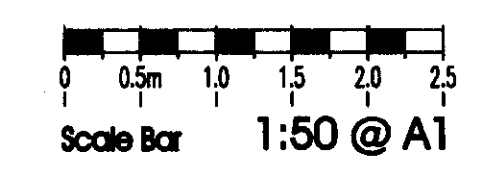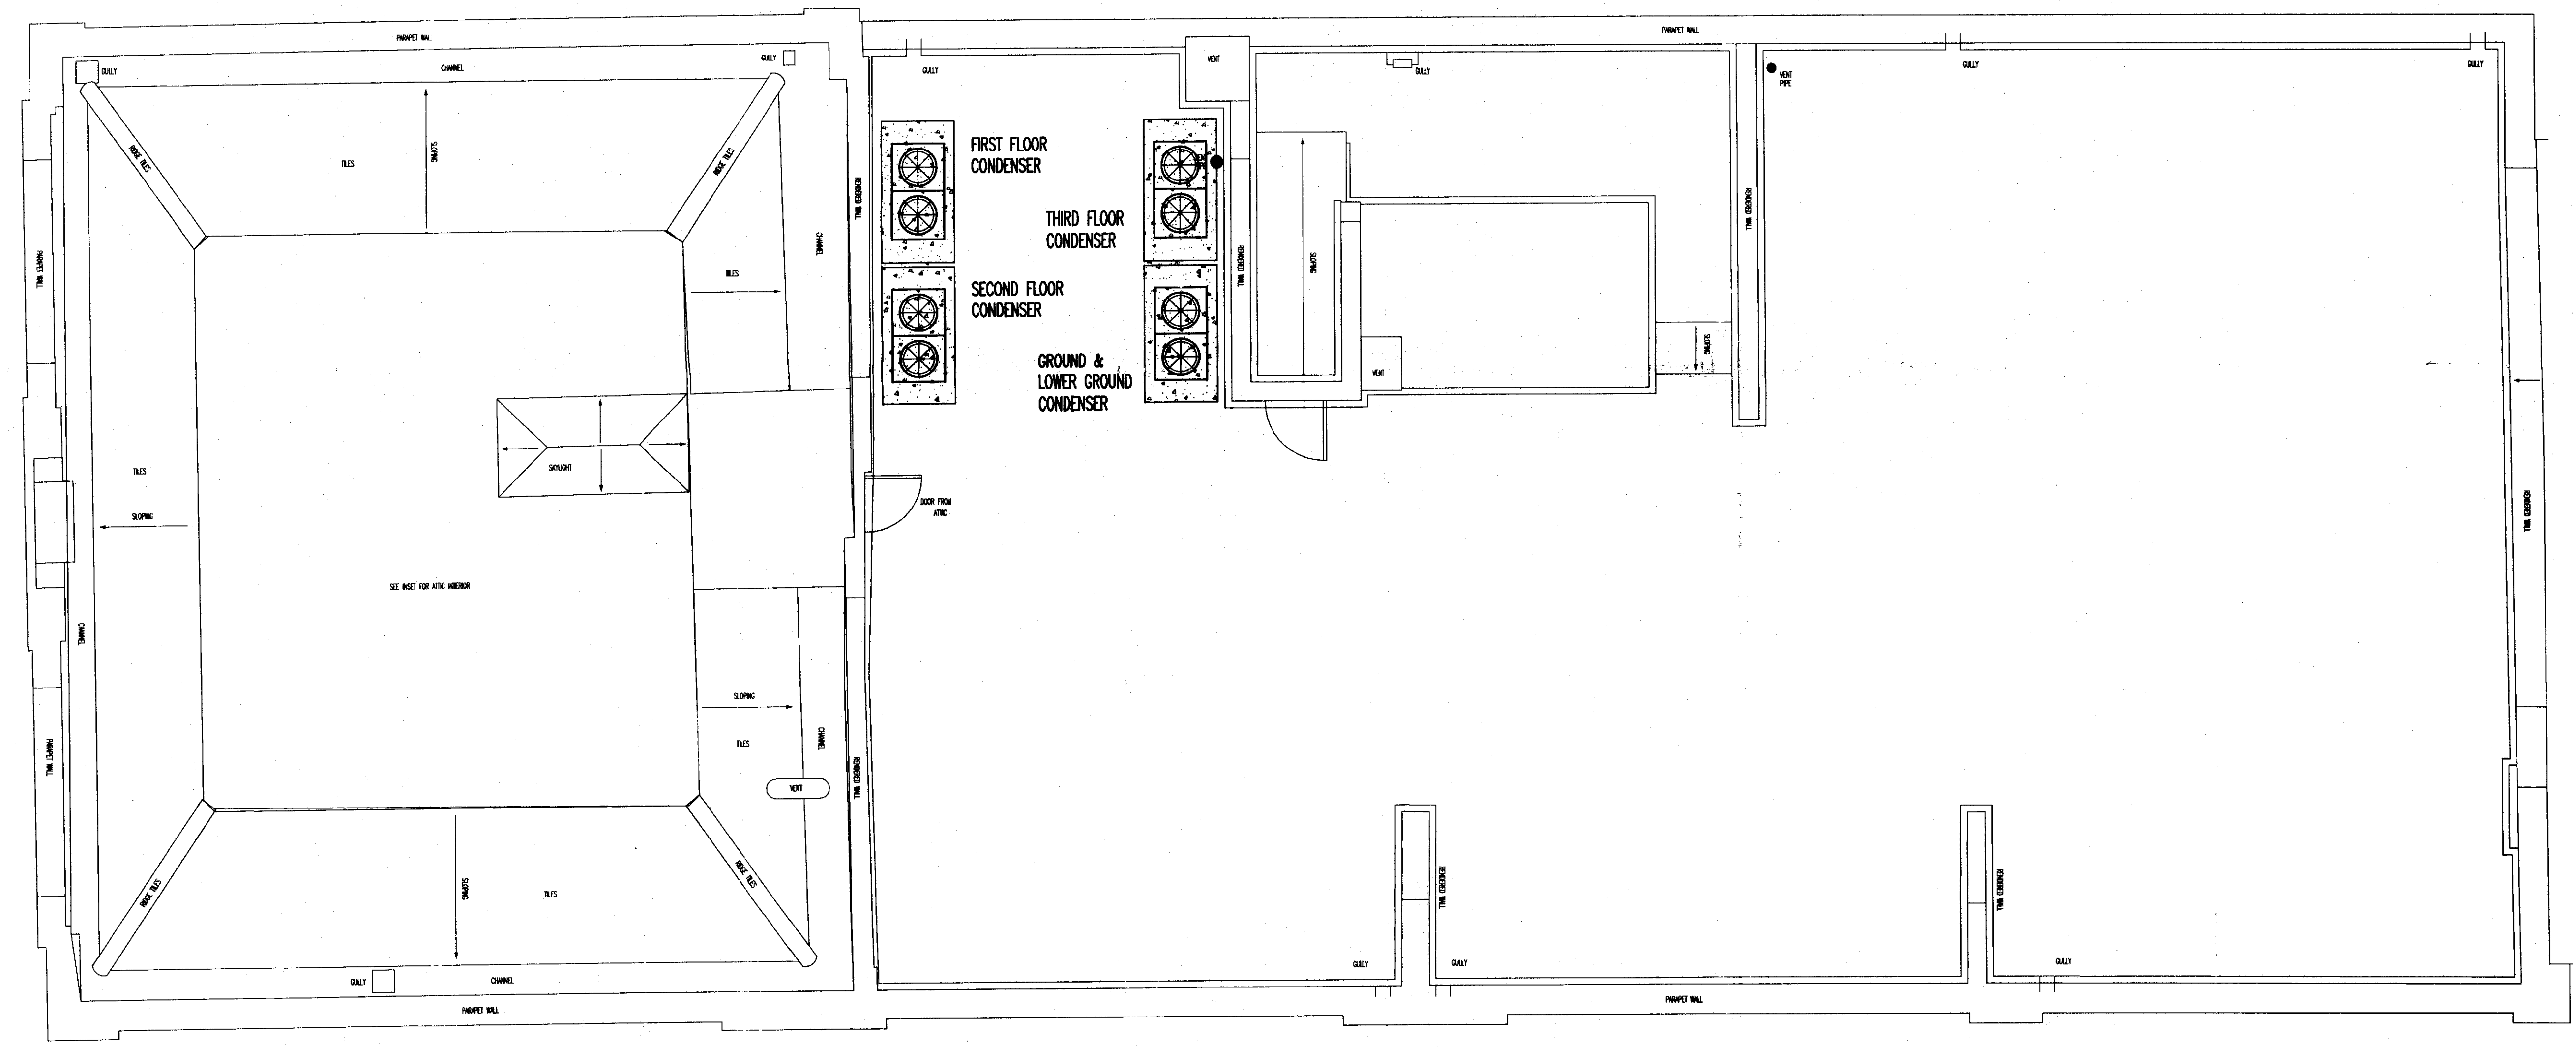

PLANNING		
Rev	Date	Description
B	SEP.06	PARAPET ELEVATION CORRECTED
A	APR.06	REAR ELEVATION ADDED
0	MAR.06	PRELIMINARY ISSUE

TPS
Taylor Project Services
No.1 Cornhill
London EC3V 3ND
Tel 020 7743 6602 Fax 020 7743 6603 Mobile 07778 667683

Project
**74-77 GREAT RUSSELL STREET
LONDON**

Drawing Title
**ROOF LEVEL
PROPOSED
CONDENSER COMPOUND
LAYOUT**

Scale	1:50	Date	08.03.06
Drawn	E.M.	Checked	G.N.T.
Drawing Status PLANNING			
Revision	0	A	B
Drawing No. R.MH.01			