



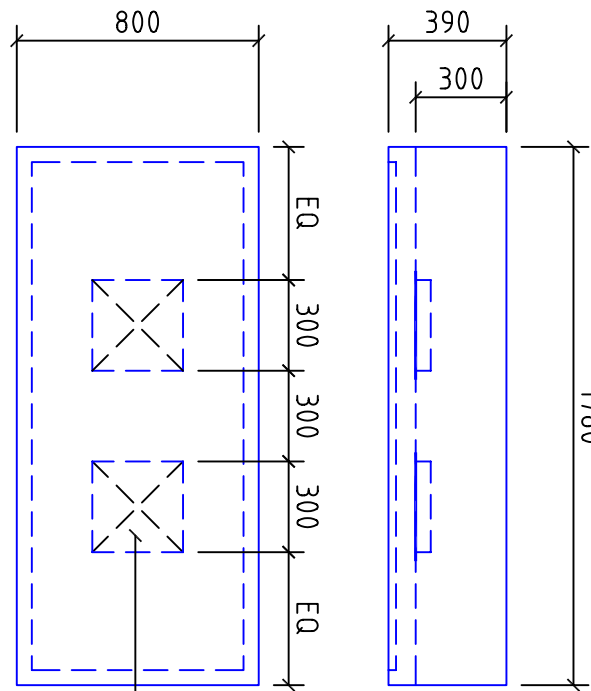


2 No 300X300 STAINLESS STEEL
CONDENSE HOODS
ALLOW FOR LIGHTS TO BE FITTED
INSIDE CANOPY


GROUND FLOOR STEAMER CONDENSE HOOD PLAN

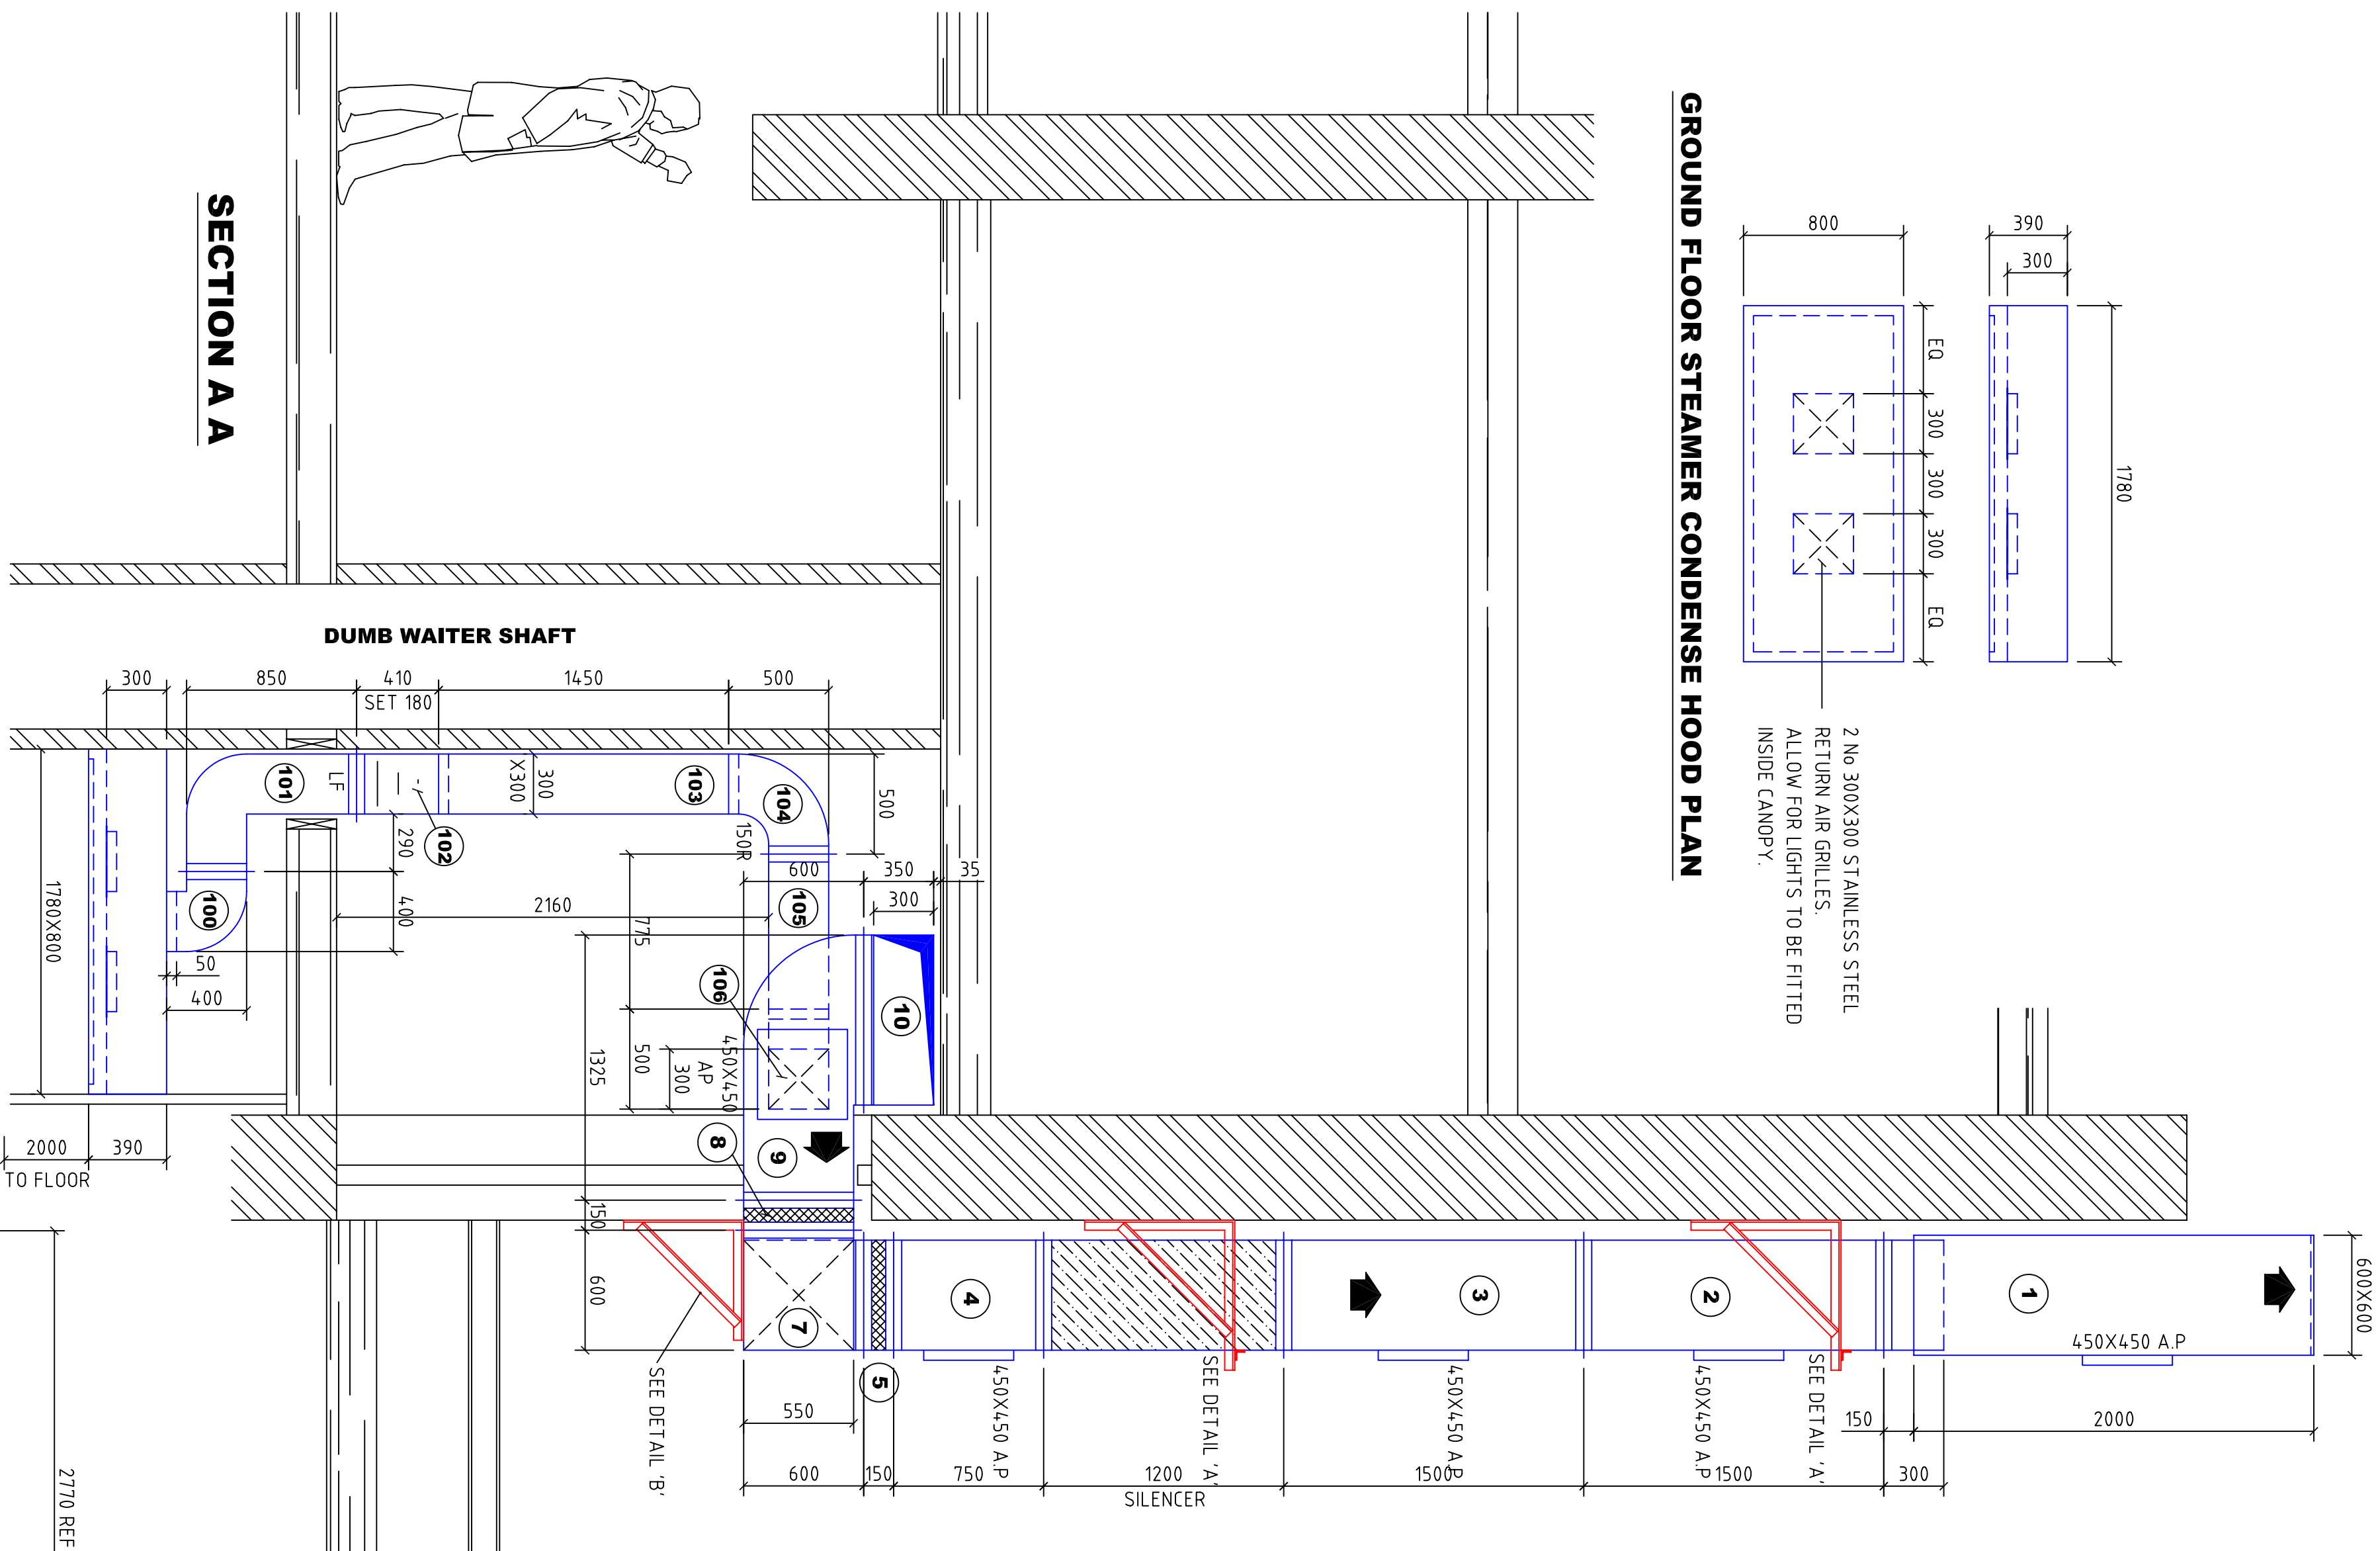

SECTION A A

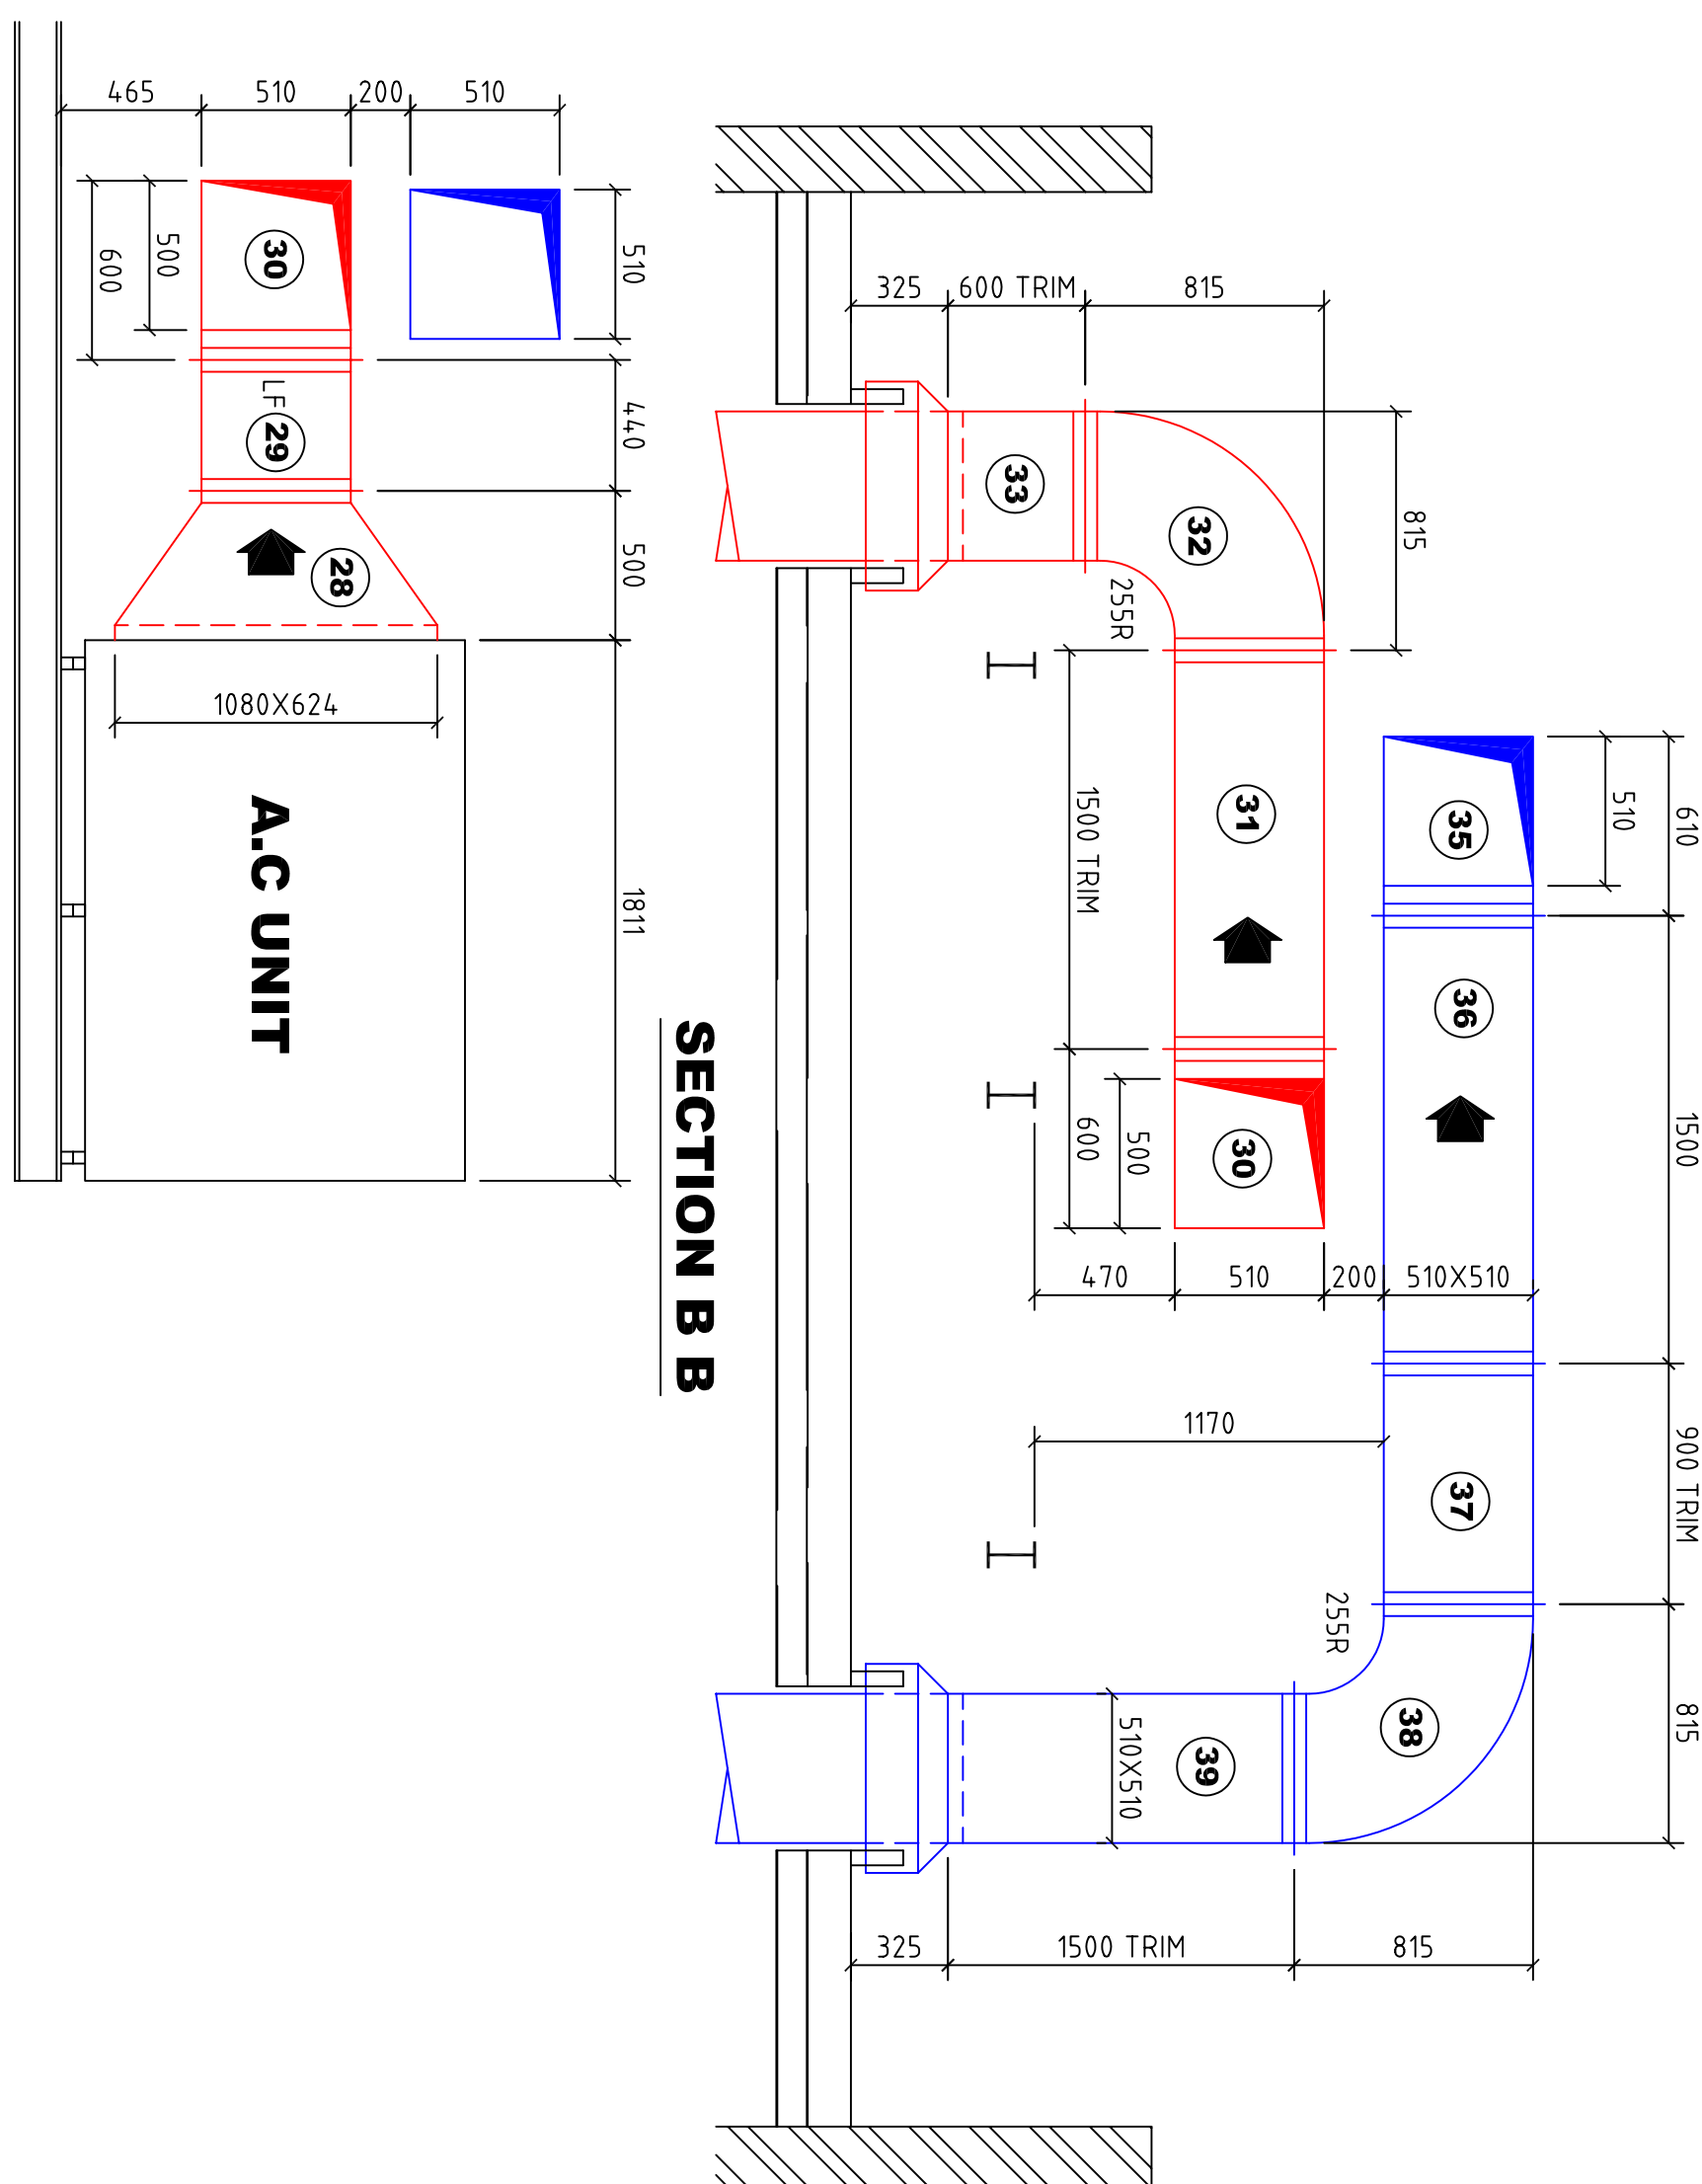


SECTION B B

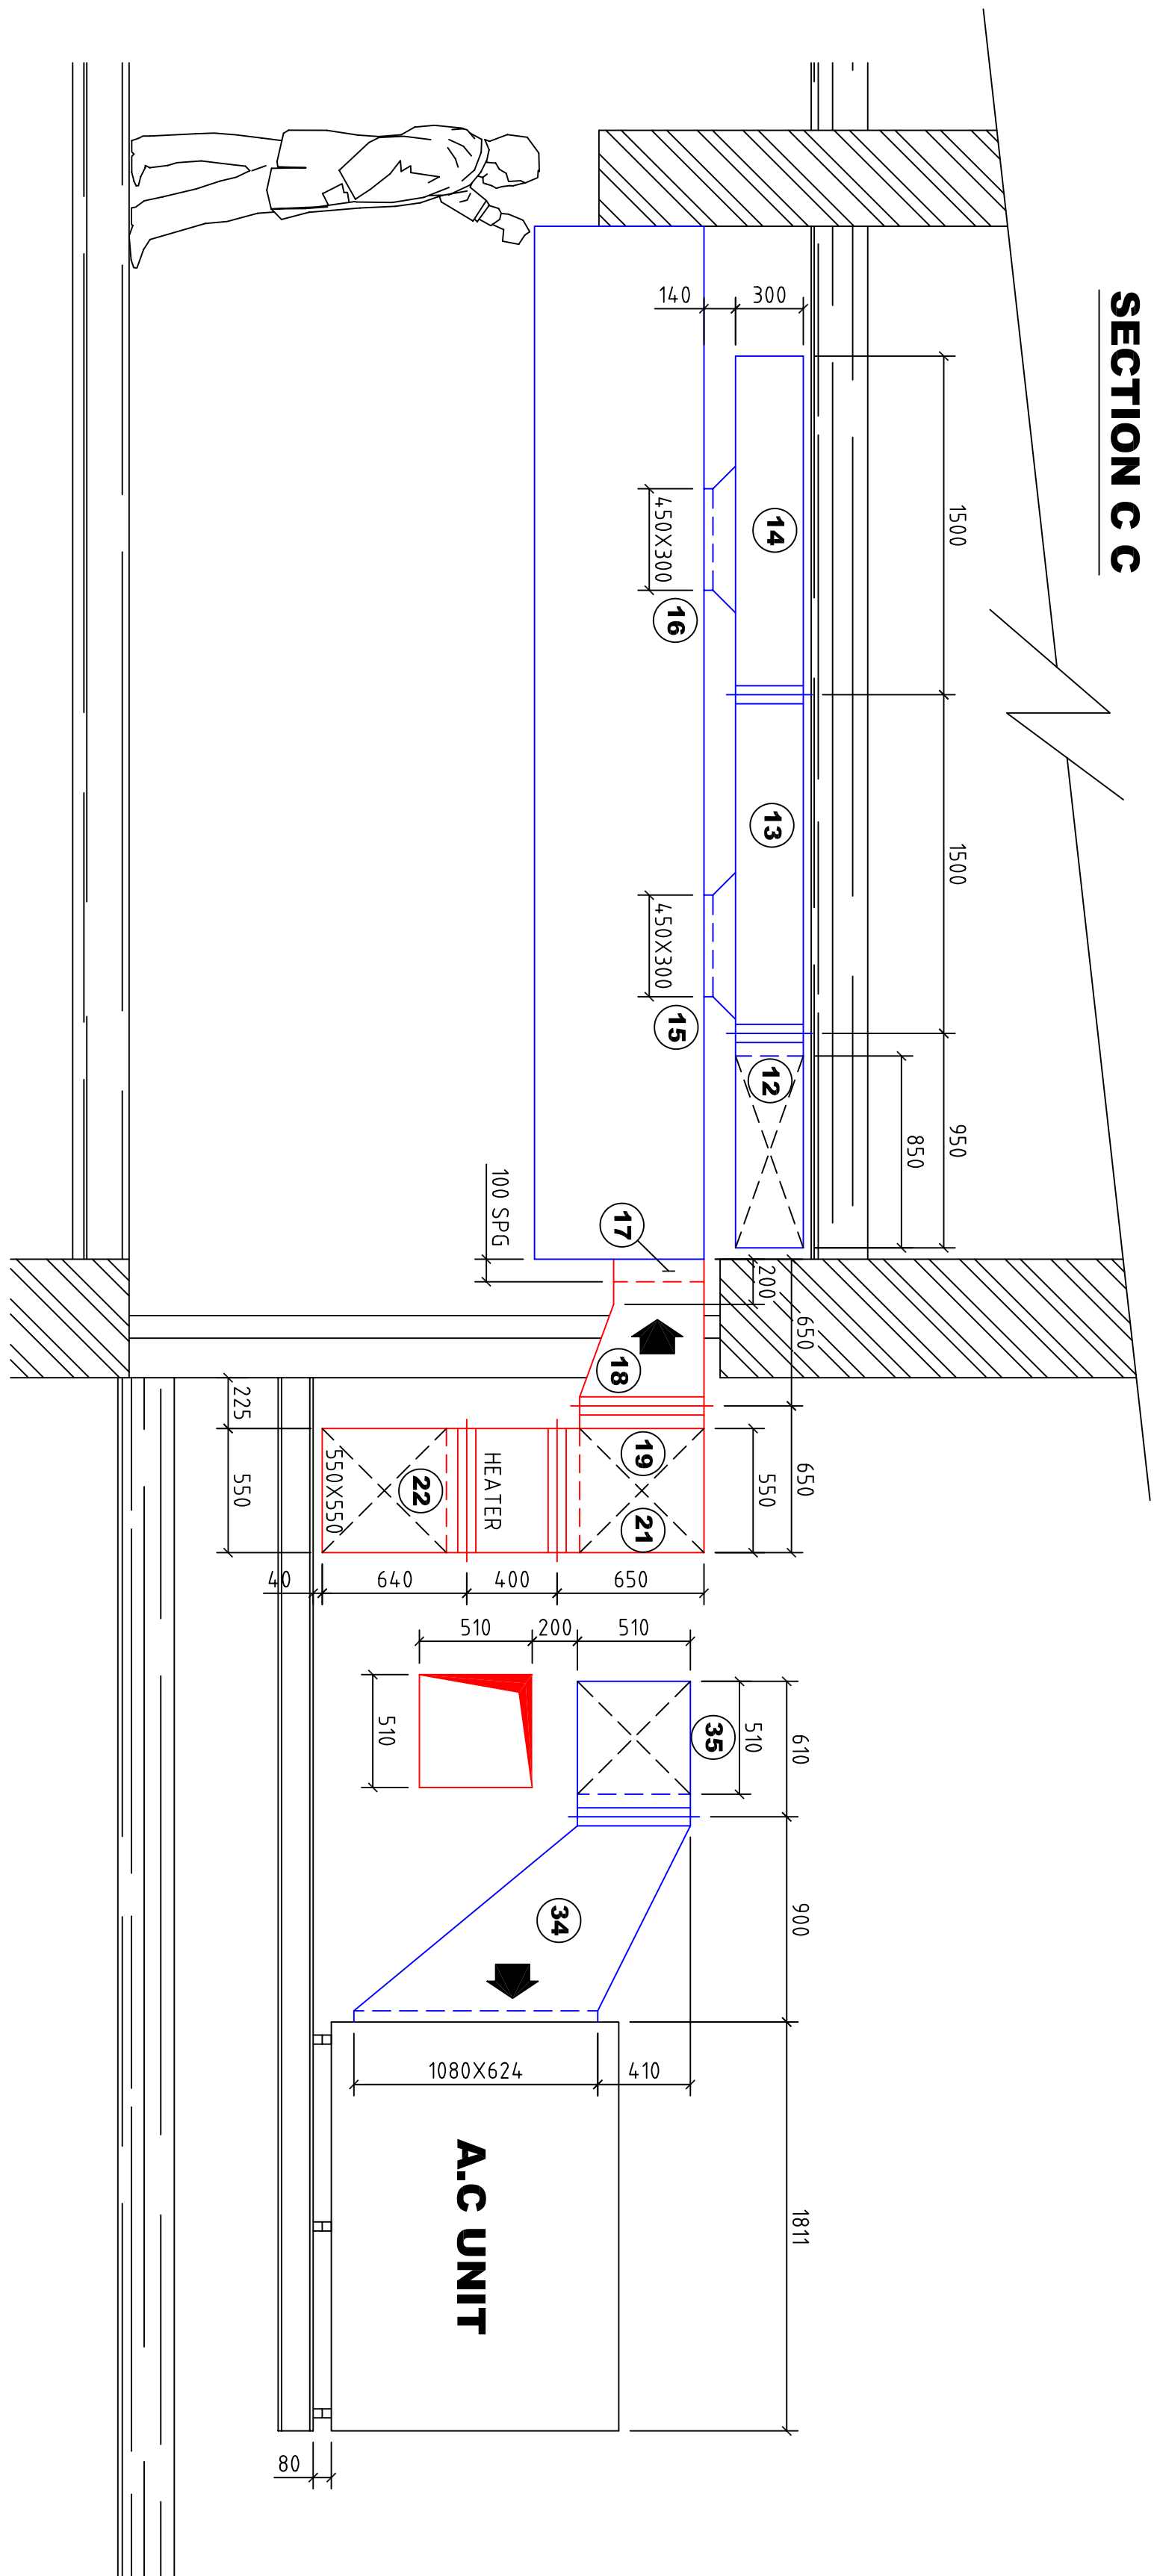


SECTION C C

SECTION D D

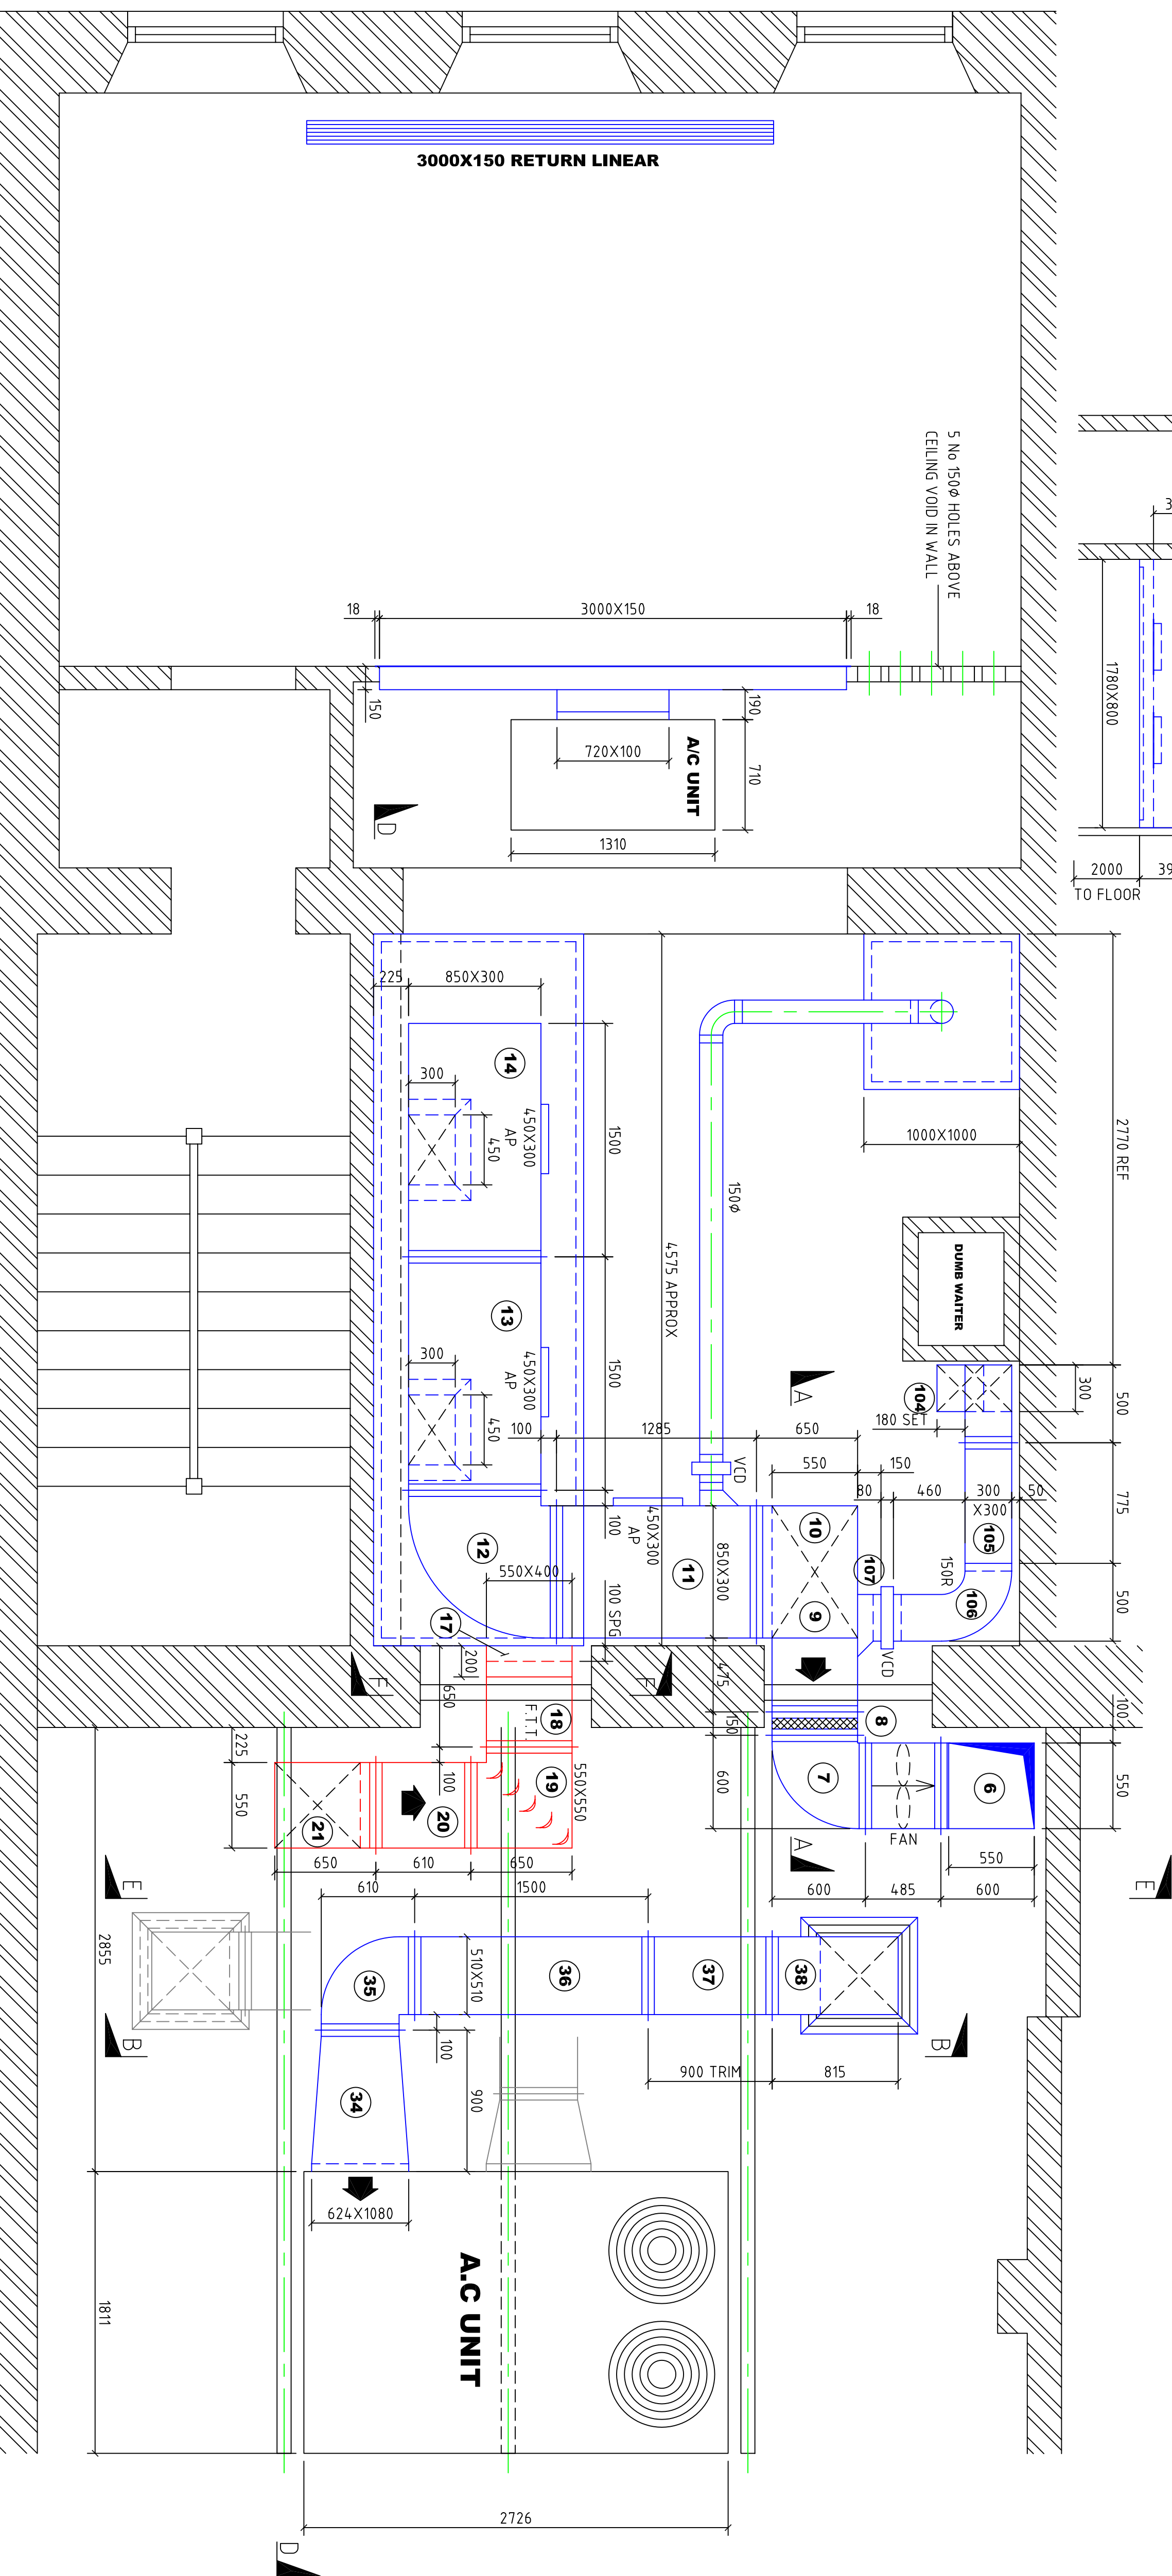


KITCHEN & FLAT ROOF PLAN AT HIGHER LEVEL

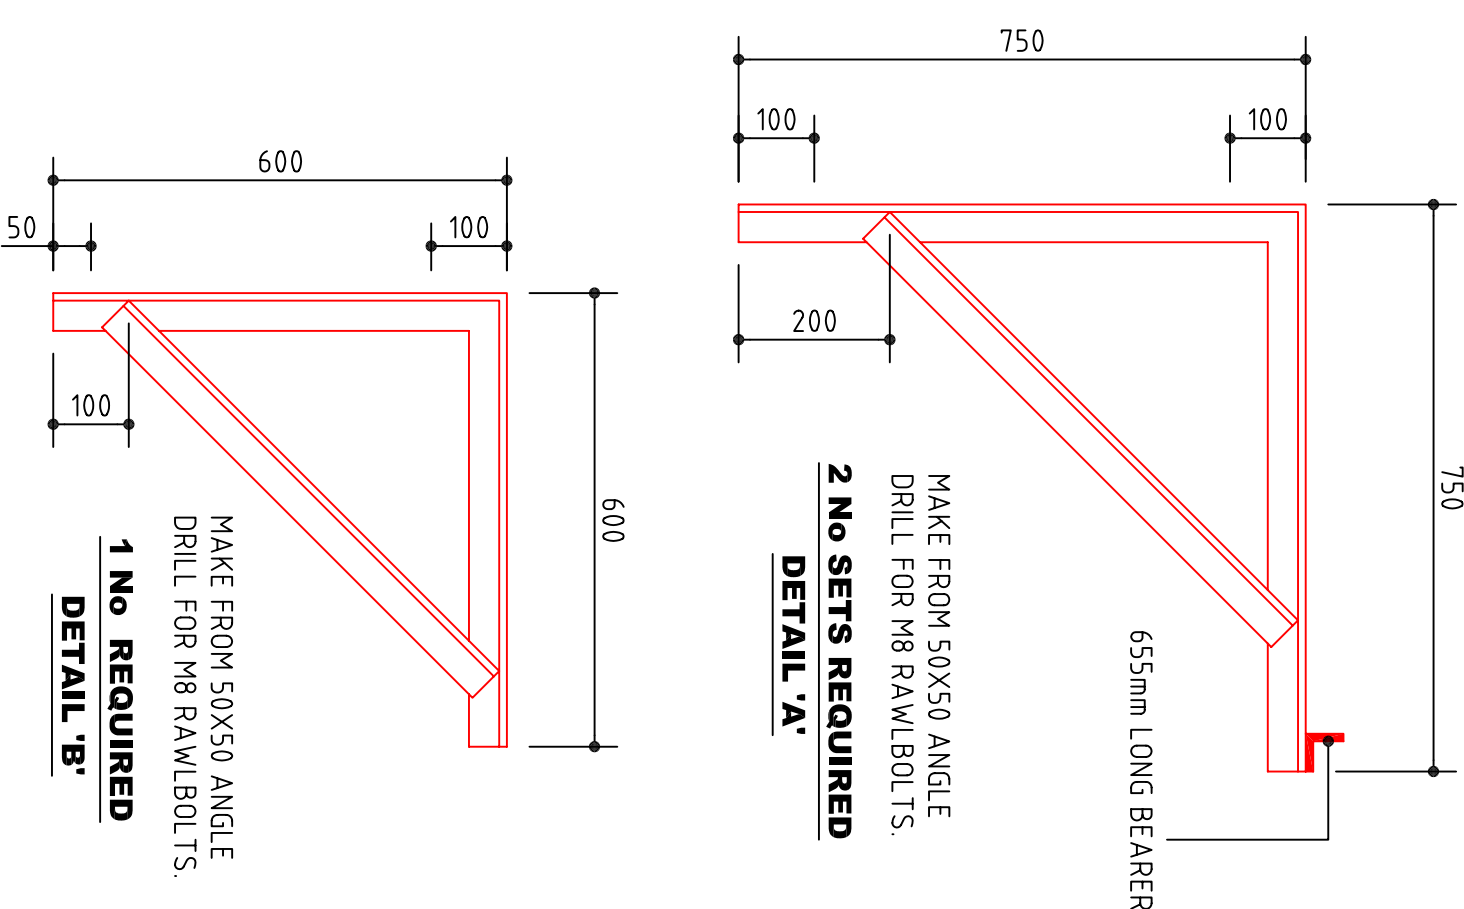


MAKE FROM 50X50 ANGLE
DRILL FOR M8 SAMBOLTS
2 No SETS REQUIRED
DETAIL 'A'


MAKE FROM 50X50 ANGLE
DRILL FOR M8 SAMBOLTS
1 No REQUIRED
DETAIL 'B'

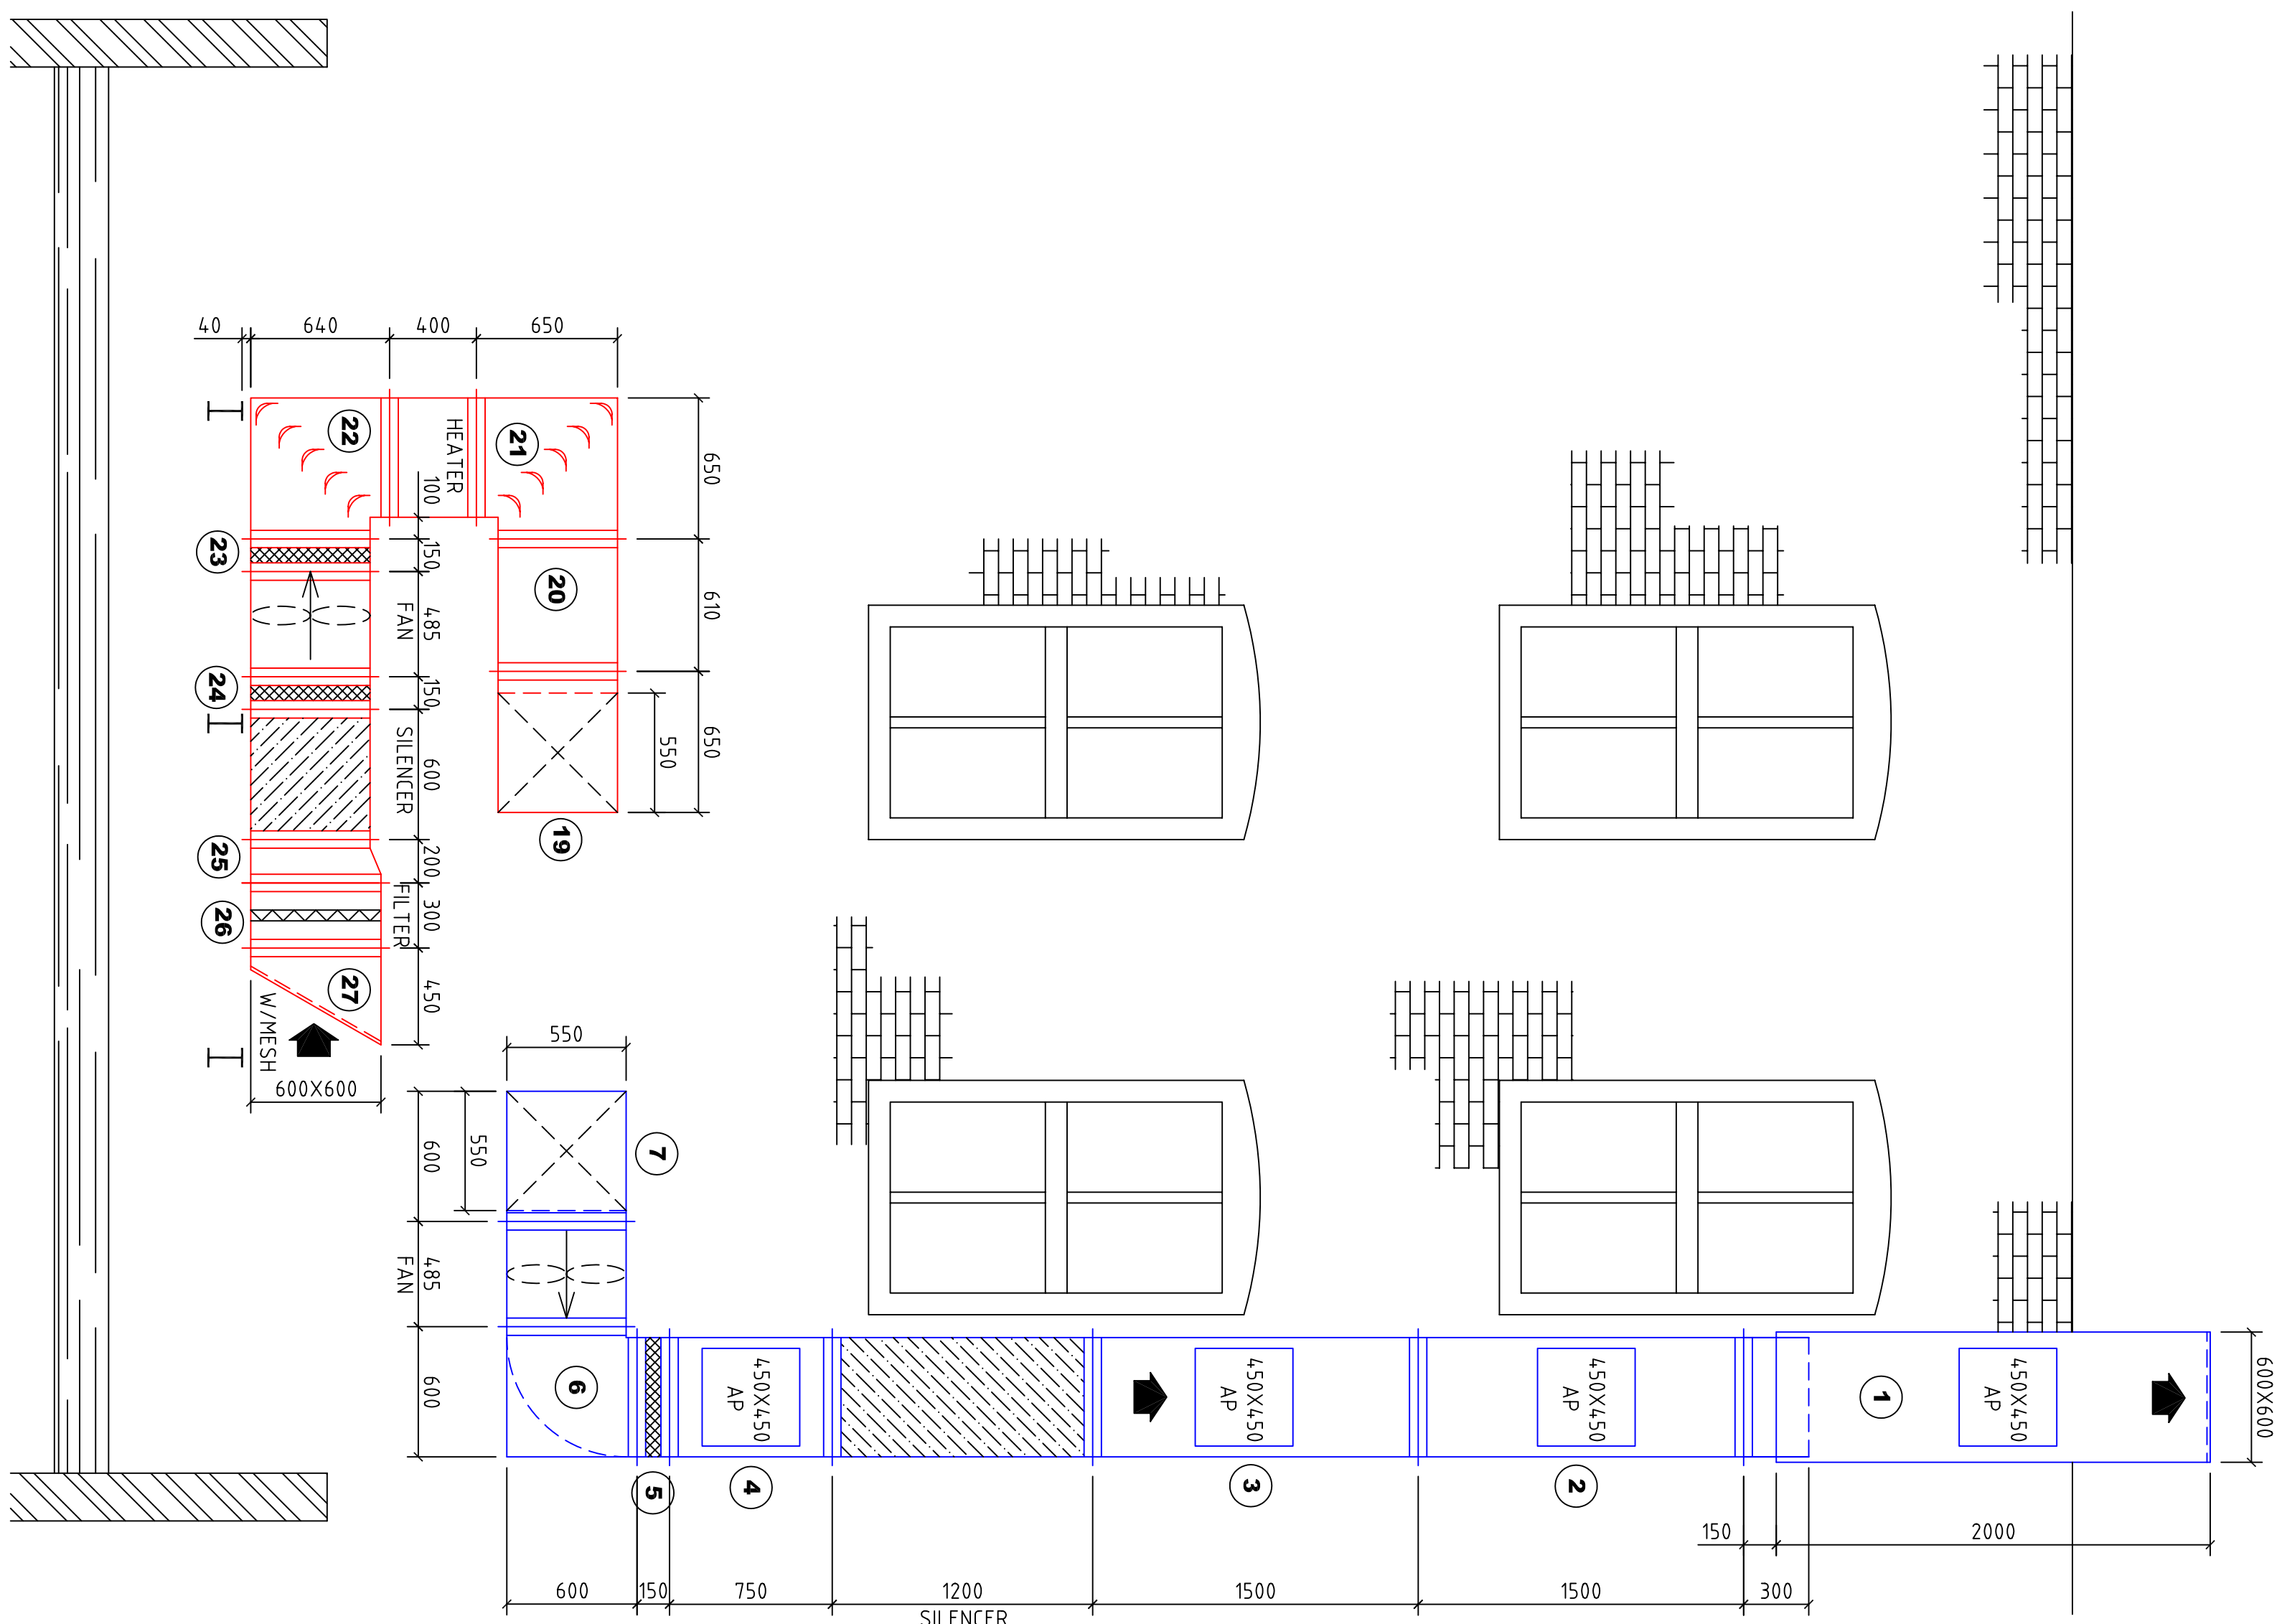

SECTION E E

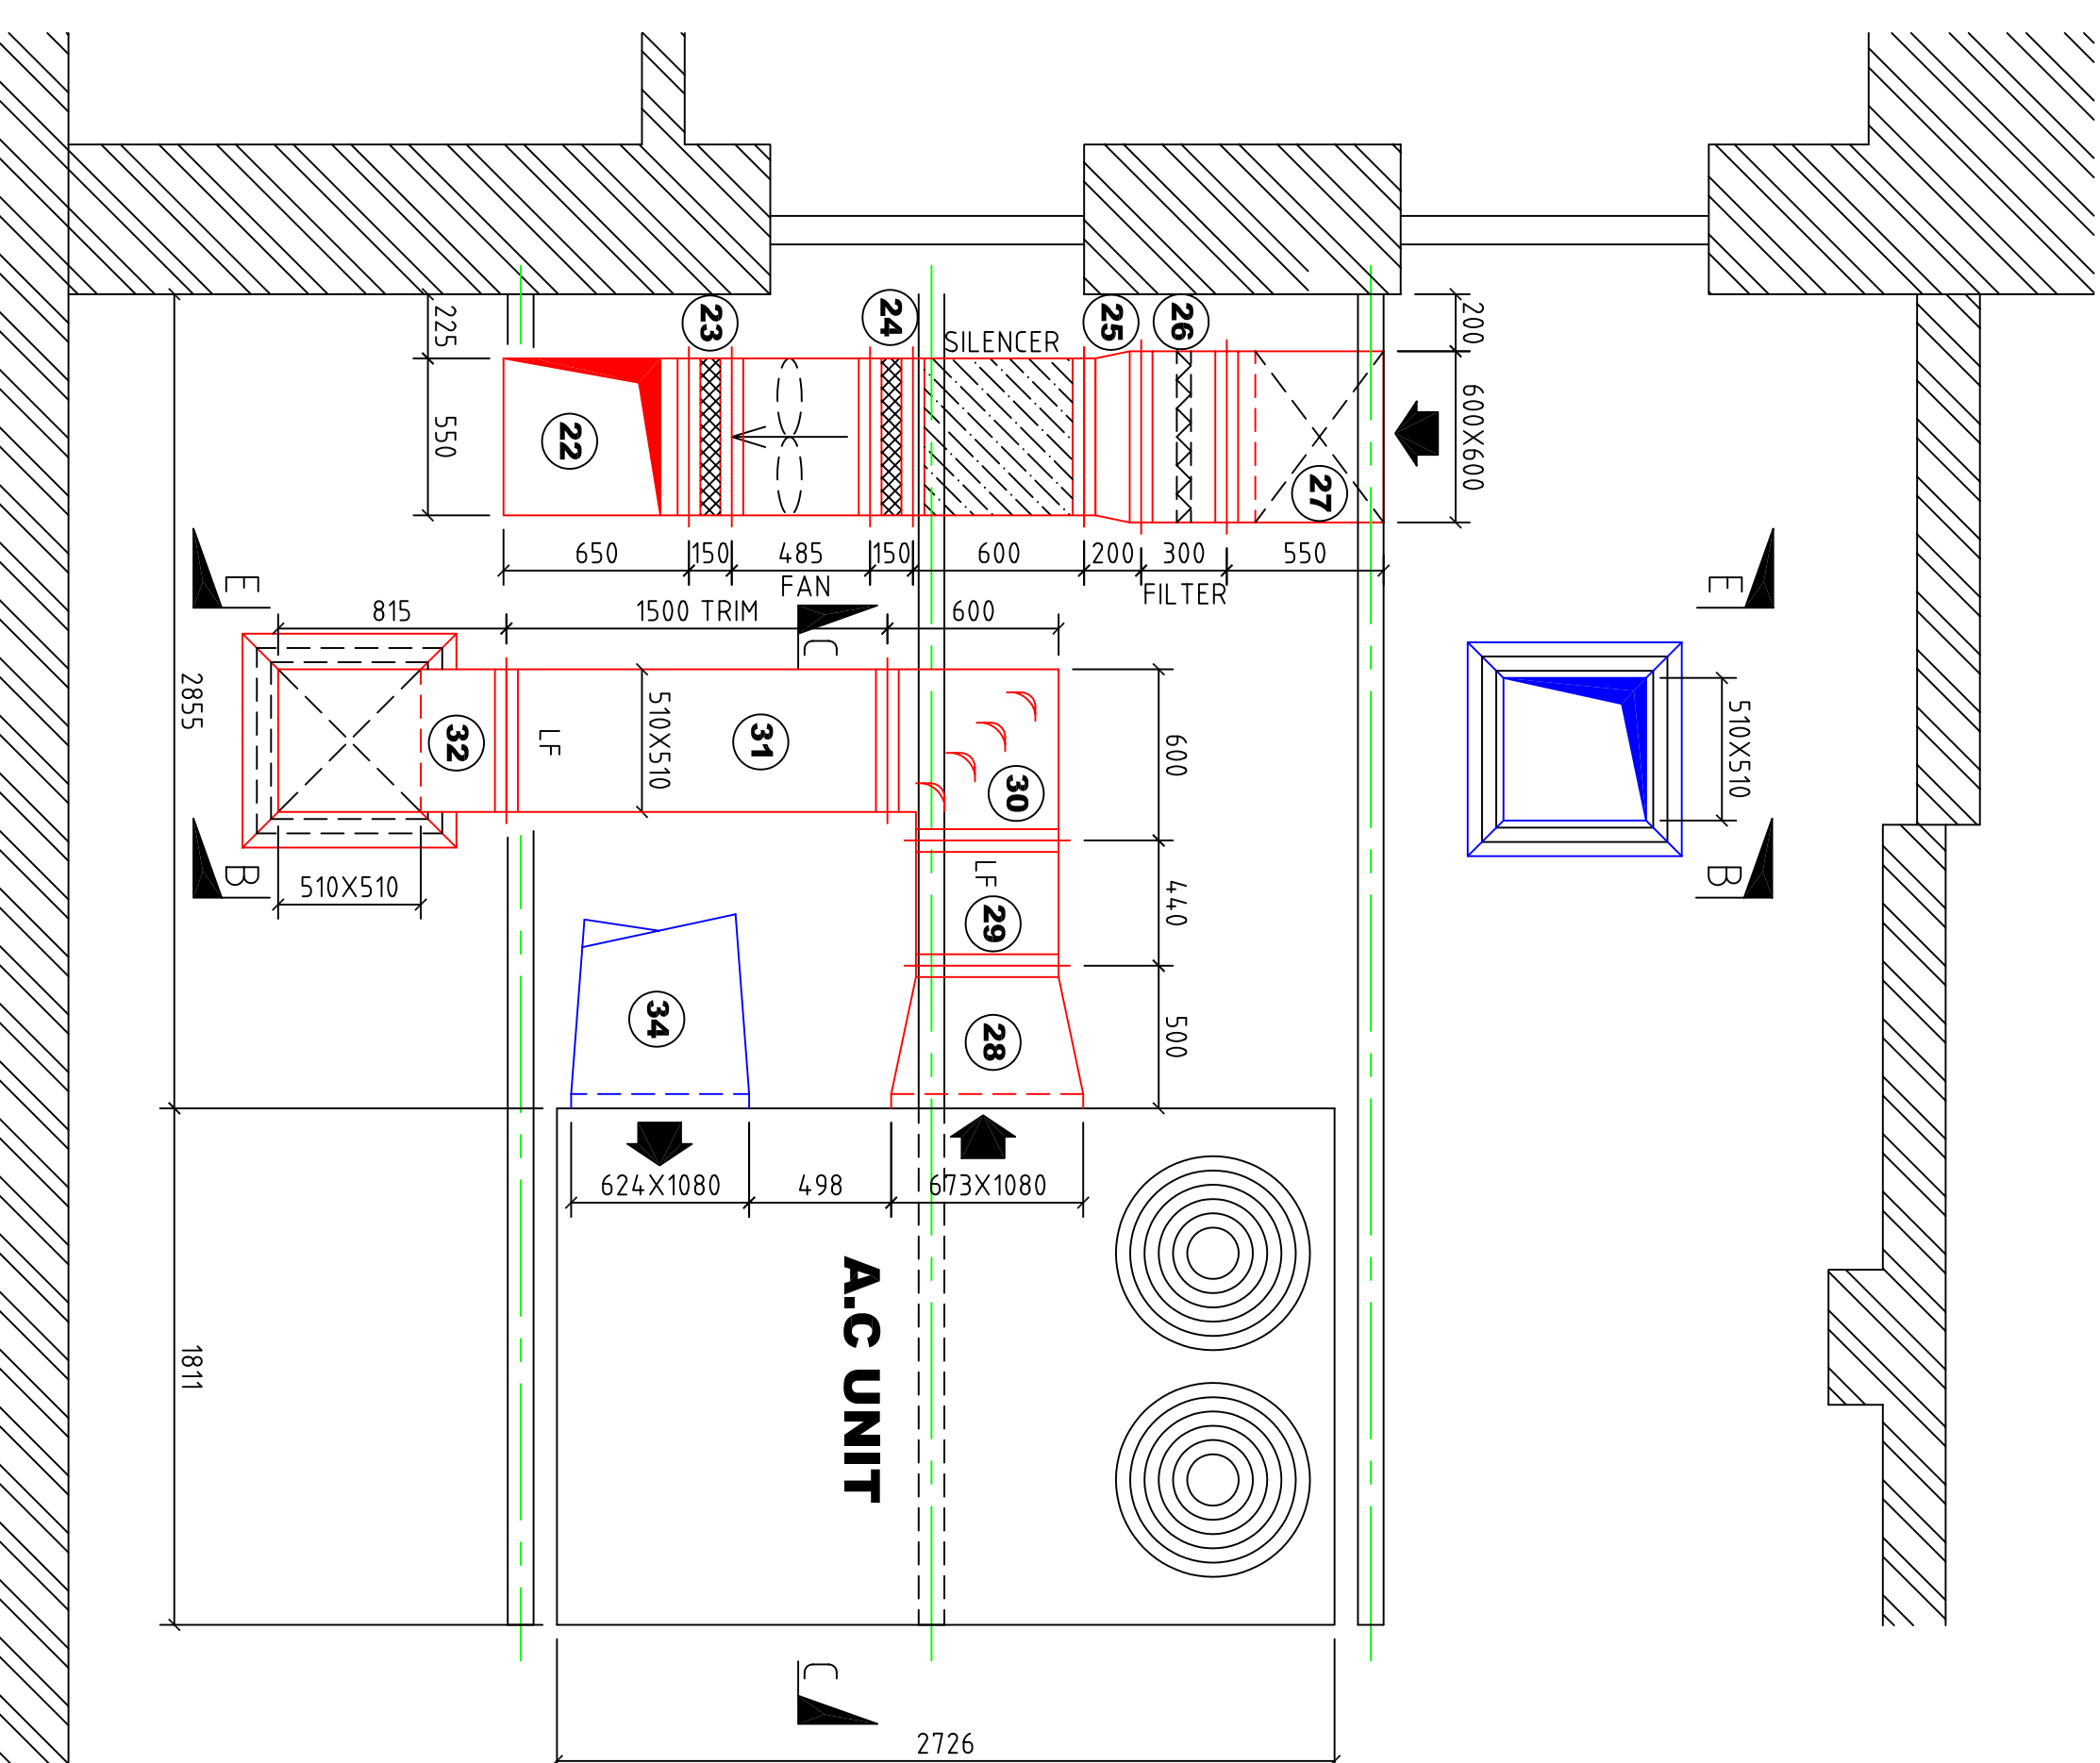

FLAT ROOF PLAN AT LOWER LEVEL

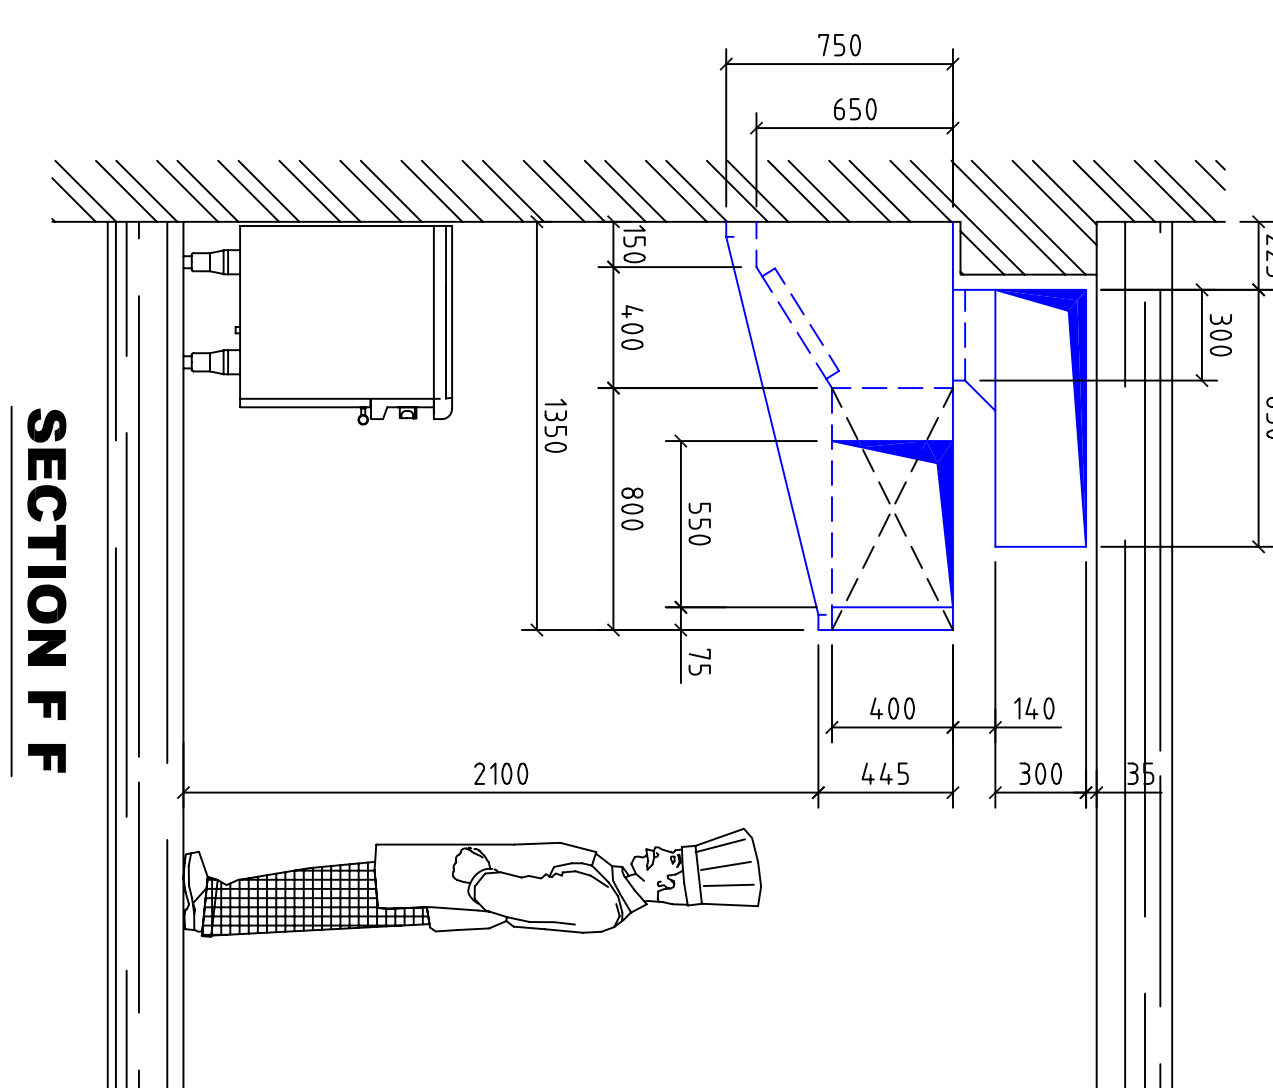

SECTION F F

32 CHARLOTTE STREET		13/6/04	
DETAIL OF KITCHEN VENTILATION.		10/6/04	
SCALE		SPECIFICATION	
1:25 AT A0		Rob Bonner	
DATE		DW/171	
SITE		REVISION	
C		MEETING ROOM DUCT MODIFIED	
B		PART Nos 100 TO 107 ADDED	
A		KITCHEN EXTRACT ALTERED	
REF		DATE	
12/5/2004		25/5/04	
DRG. No		5912/2	
BOATMAN		REVISION	
AIRCONDITIONING LTD		C	
UNIT 13, Ashway, 17, Green Lane, London, SE26 5TW, Telephone 0208 778 8877			