
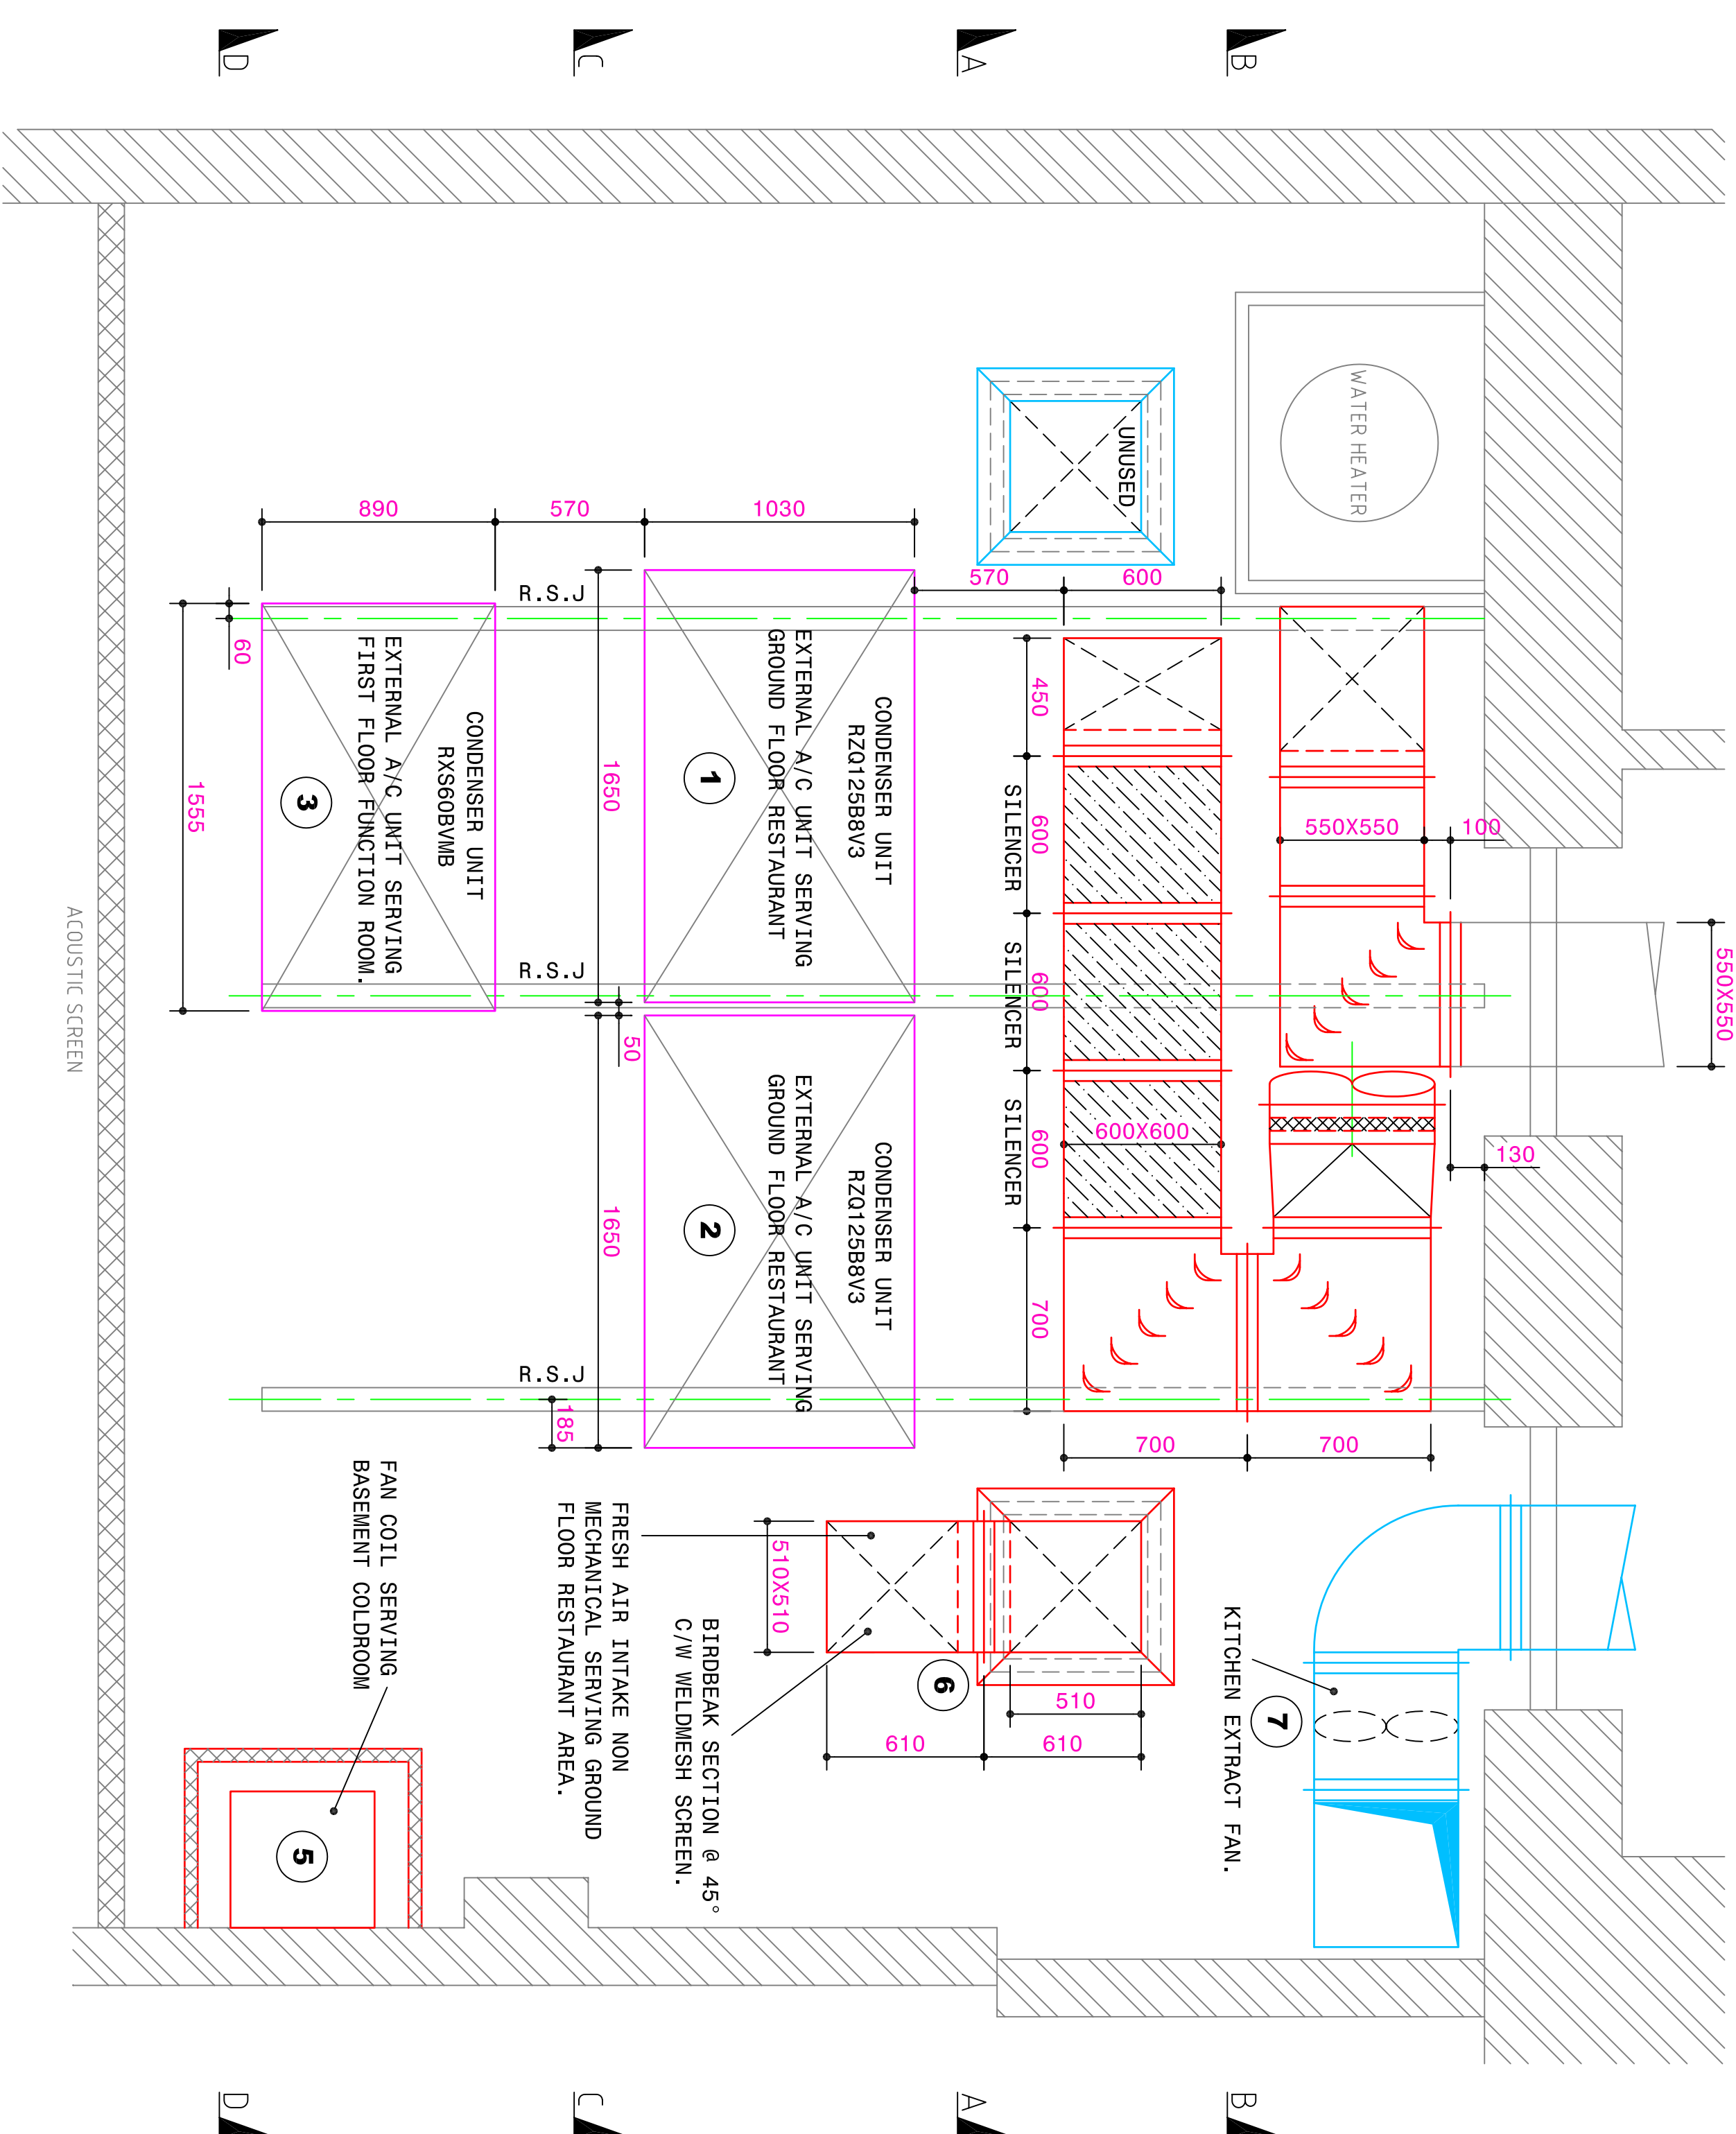
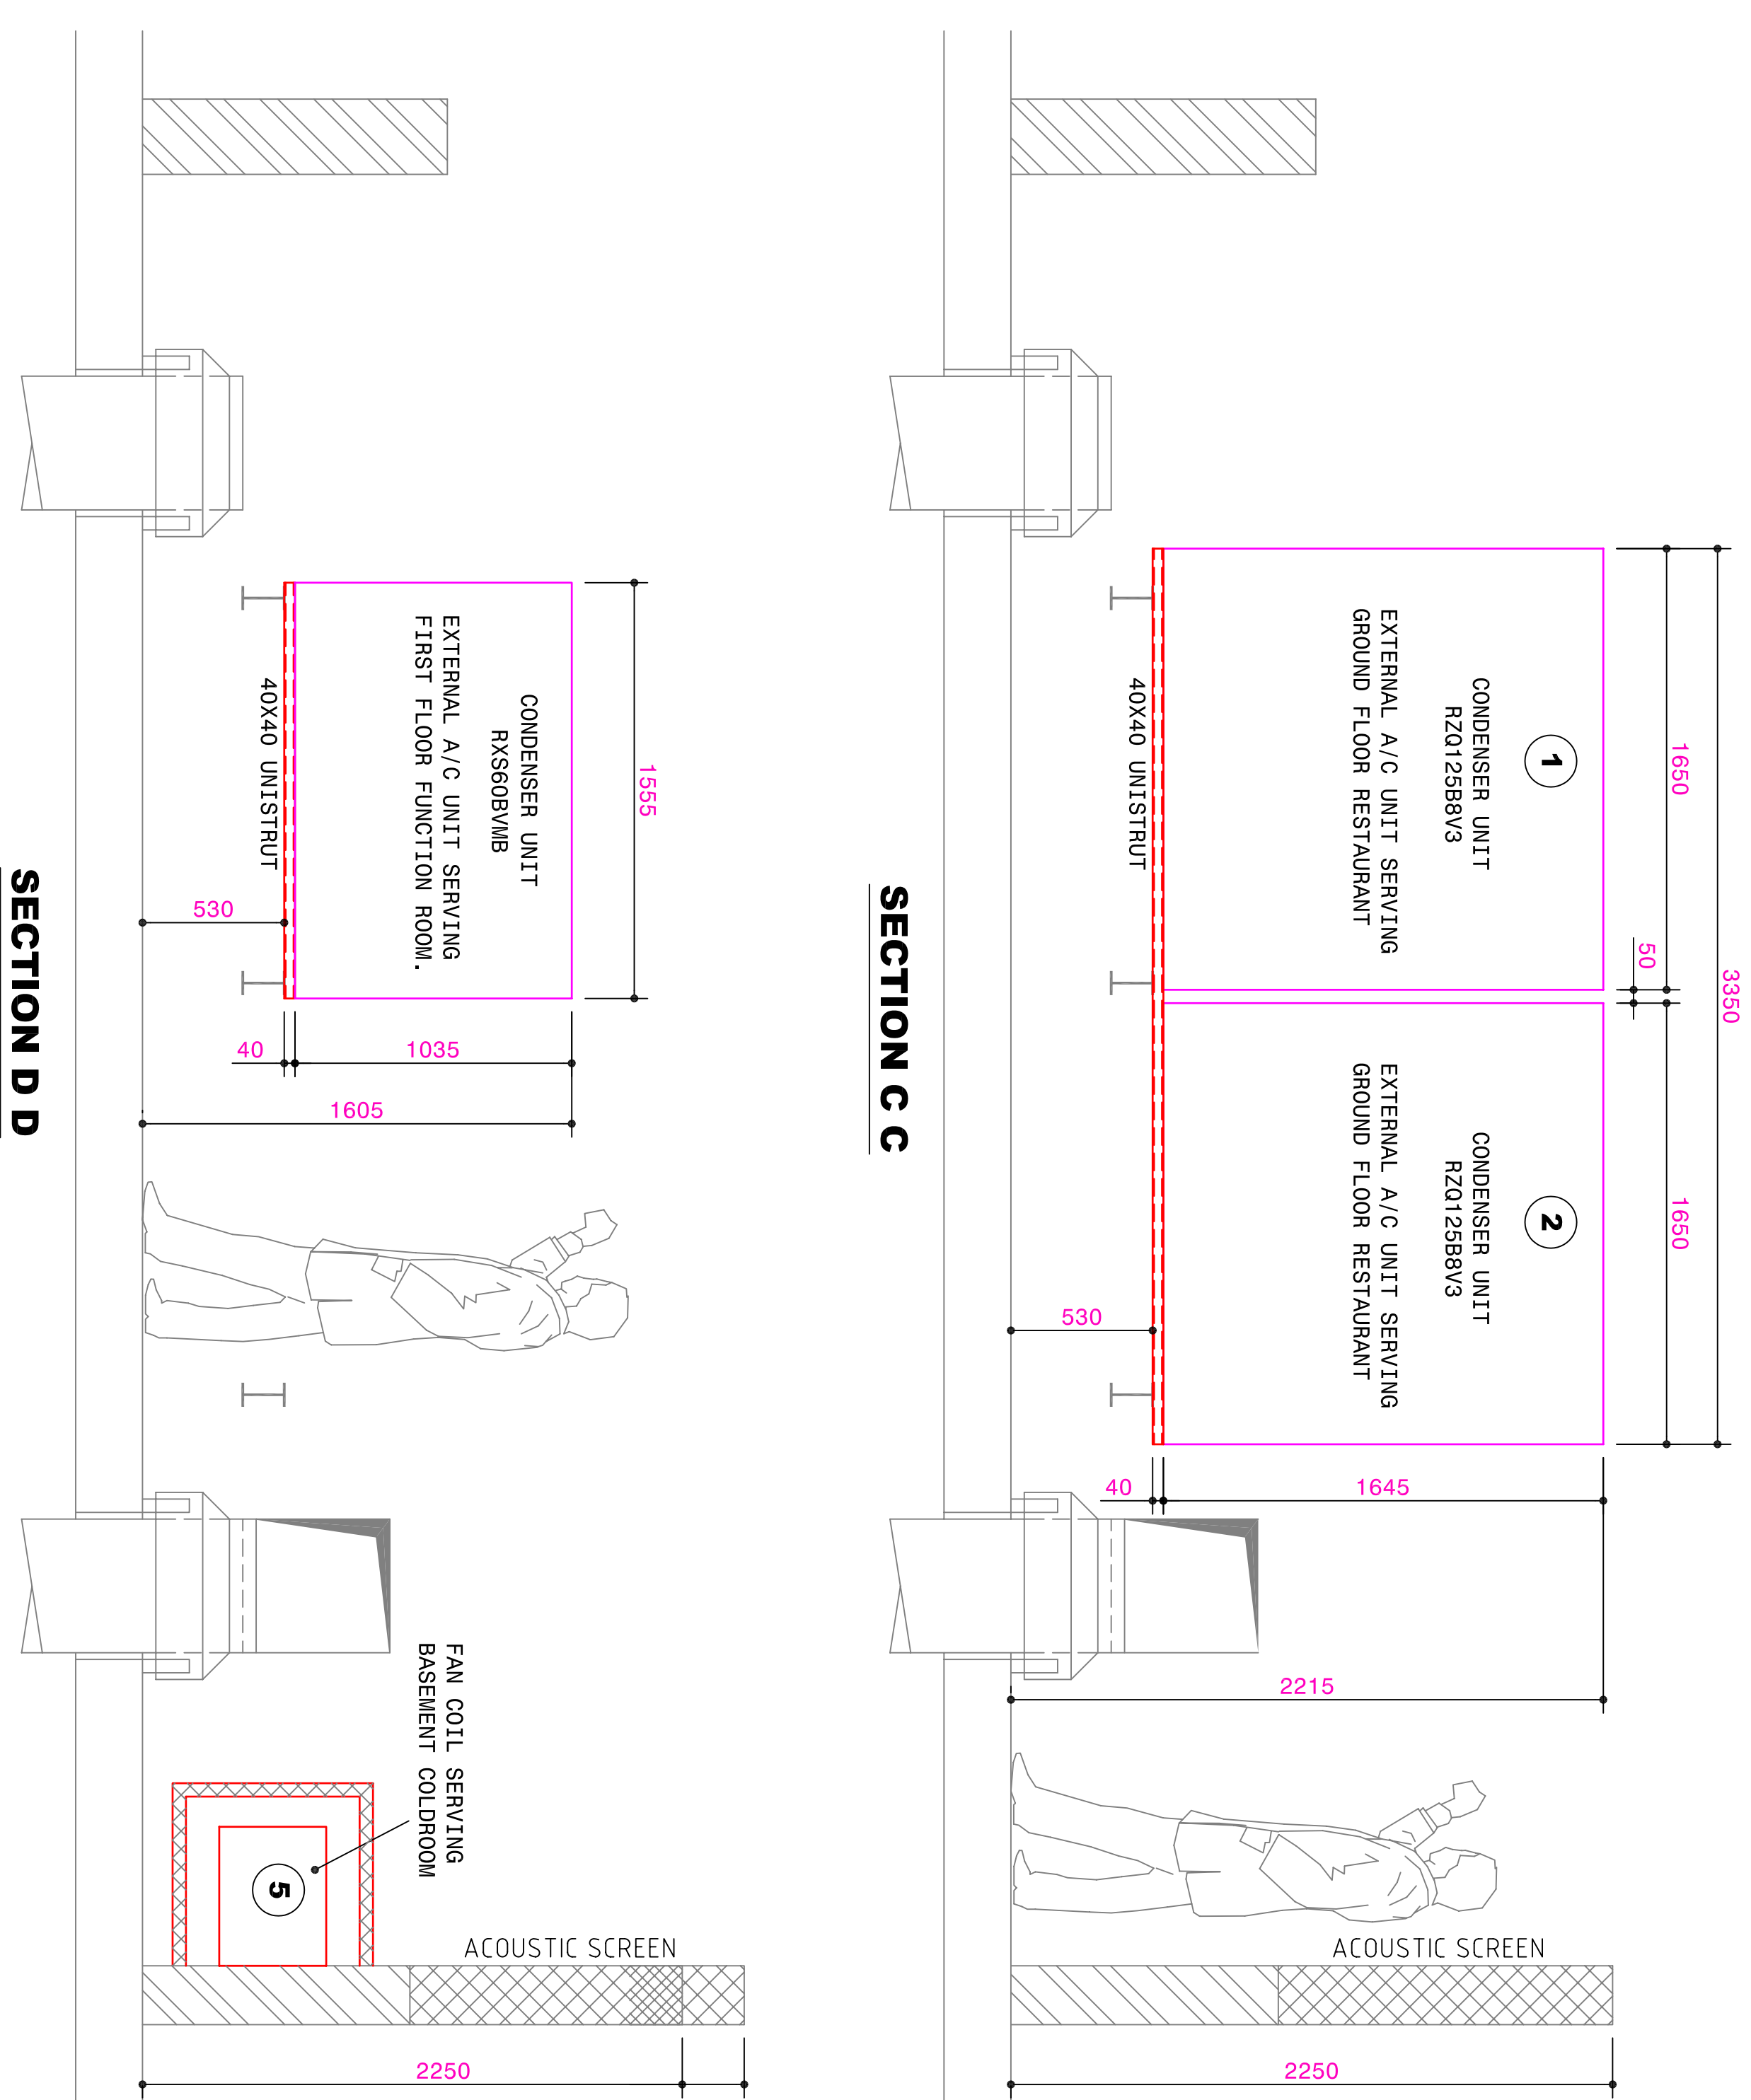


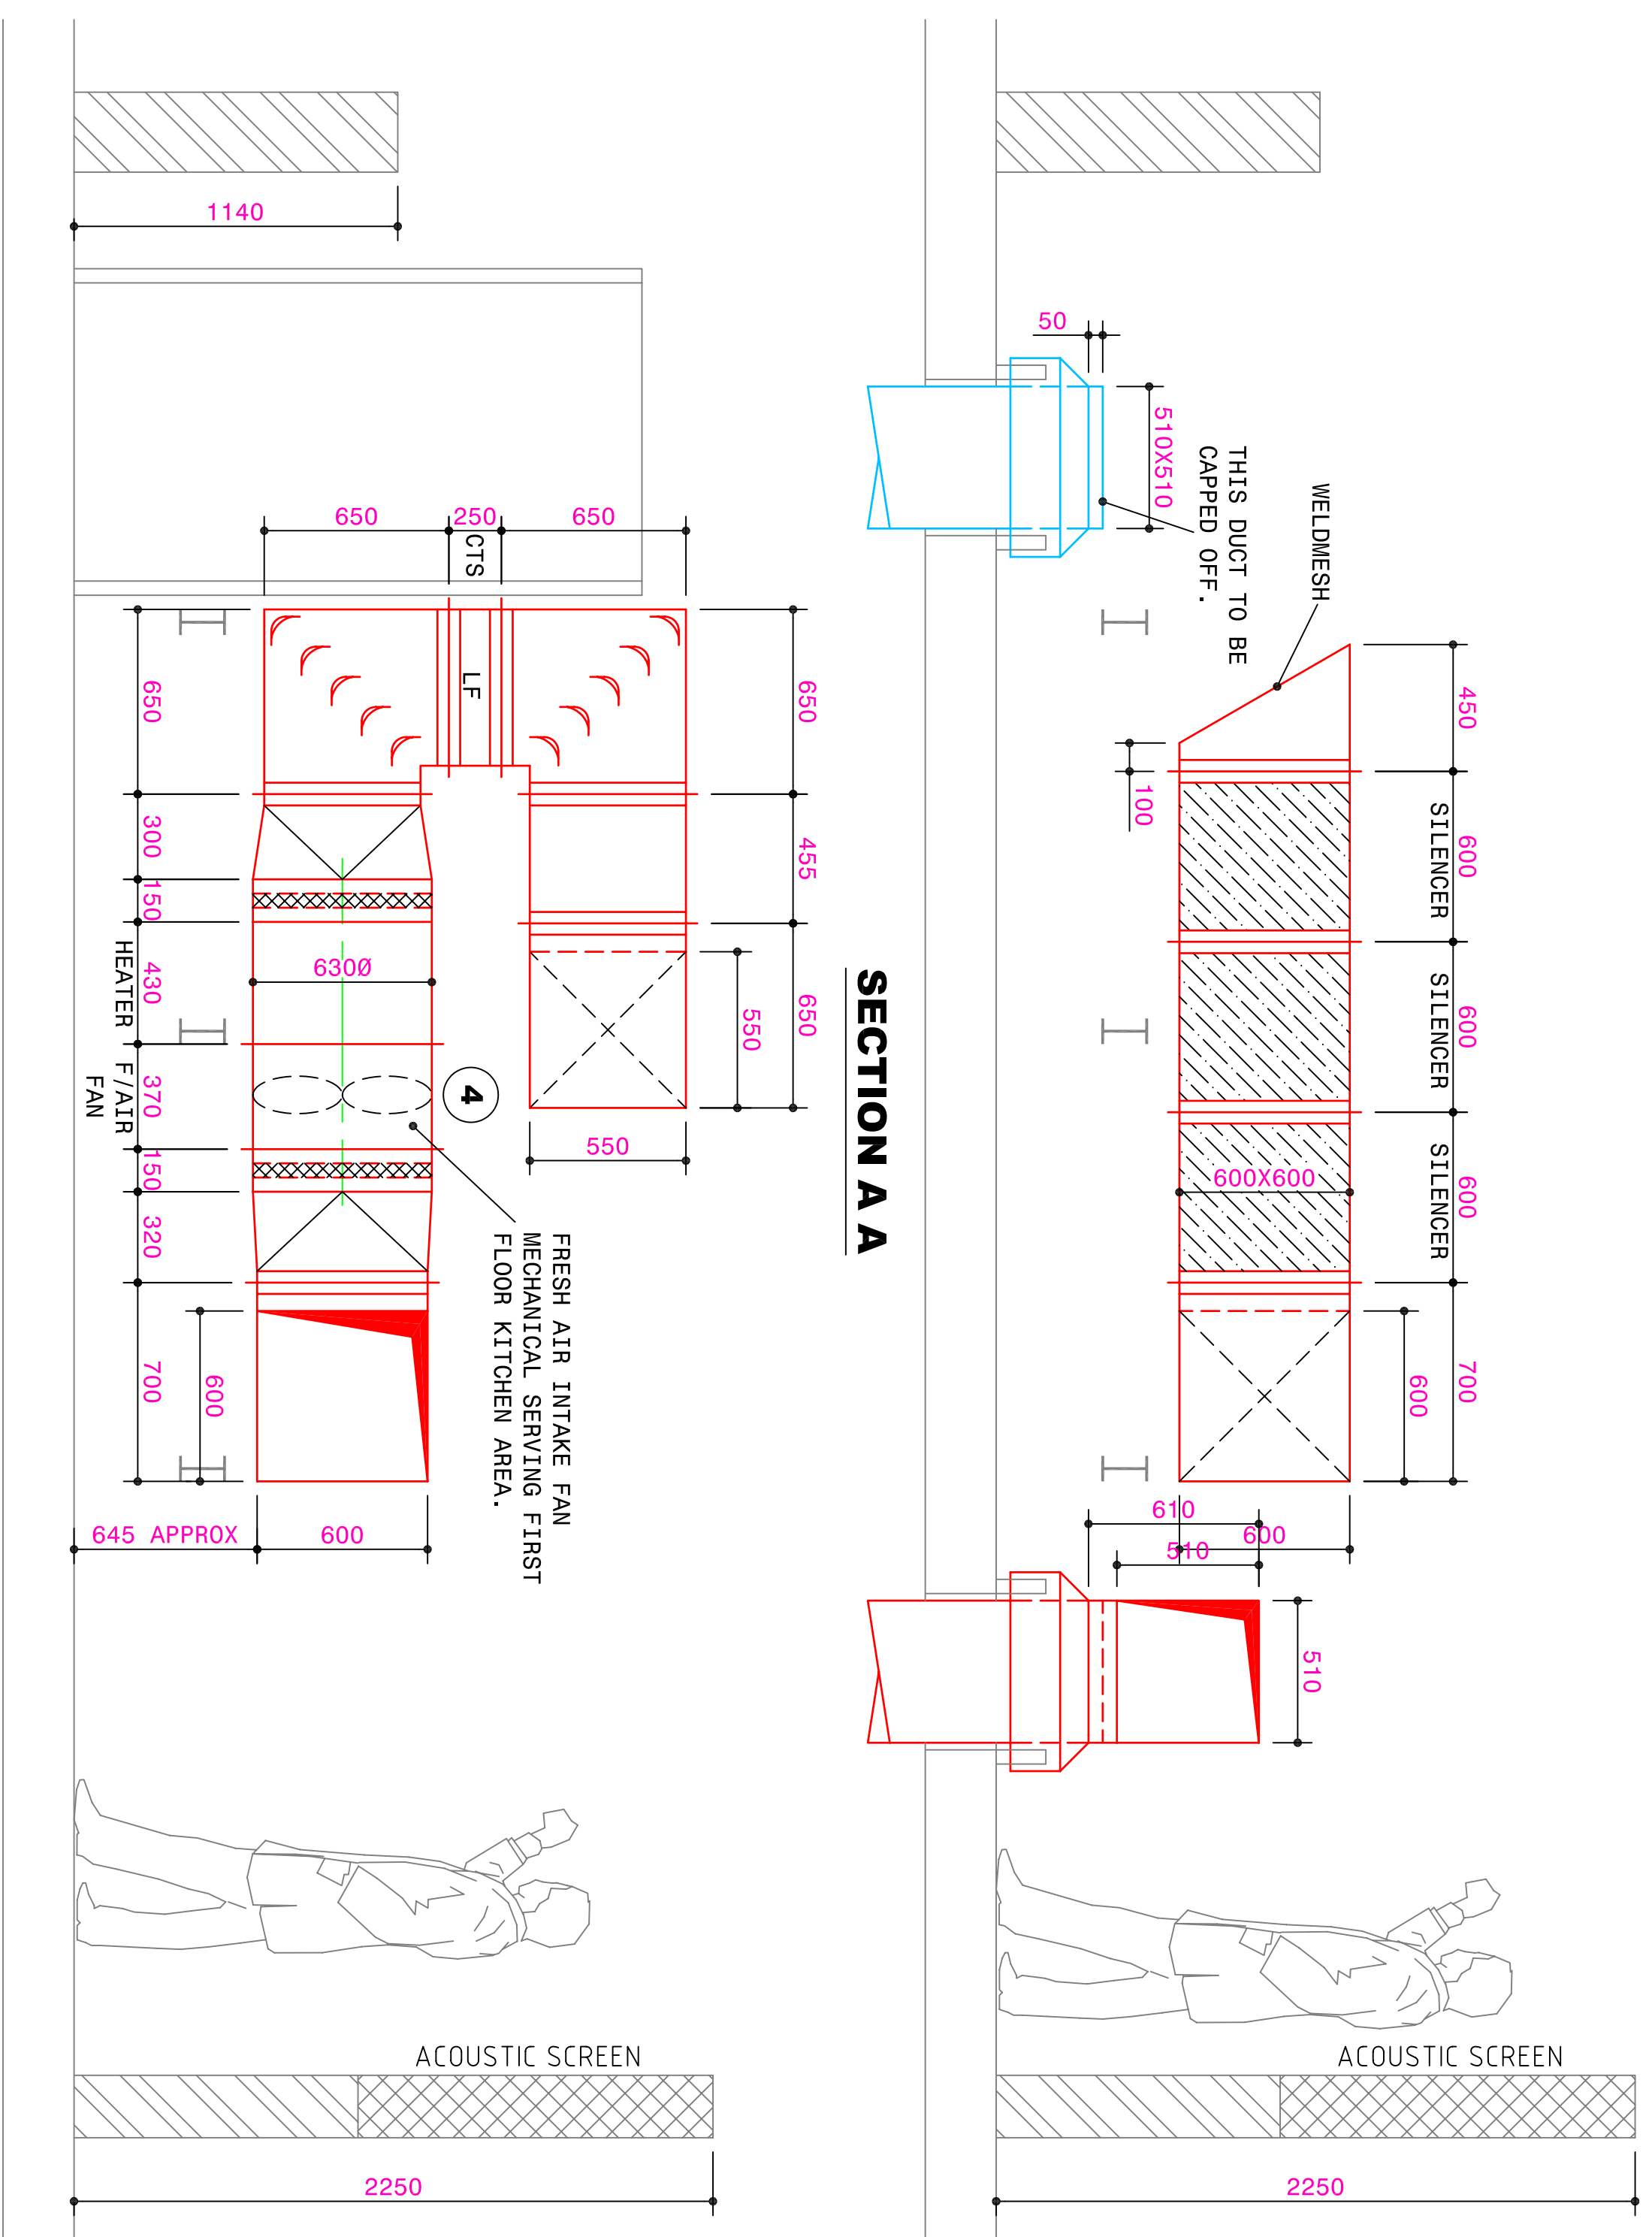

PLAN OF FLAT ROOF

DATE	13/1/2007	SPECIFICATION	DW171
DATE	1-20 AT AO	DRAWN BY	Rob Bonne
DETAIL OF NEW VENTILATION PLANT ON FLAT ROOF.			
32 CHARLOTTE STREET			
DATE	DIM T		
CLIENT	DIM T		
REF	REF		
REVISION	REVISION		
DATE	DATE		