


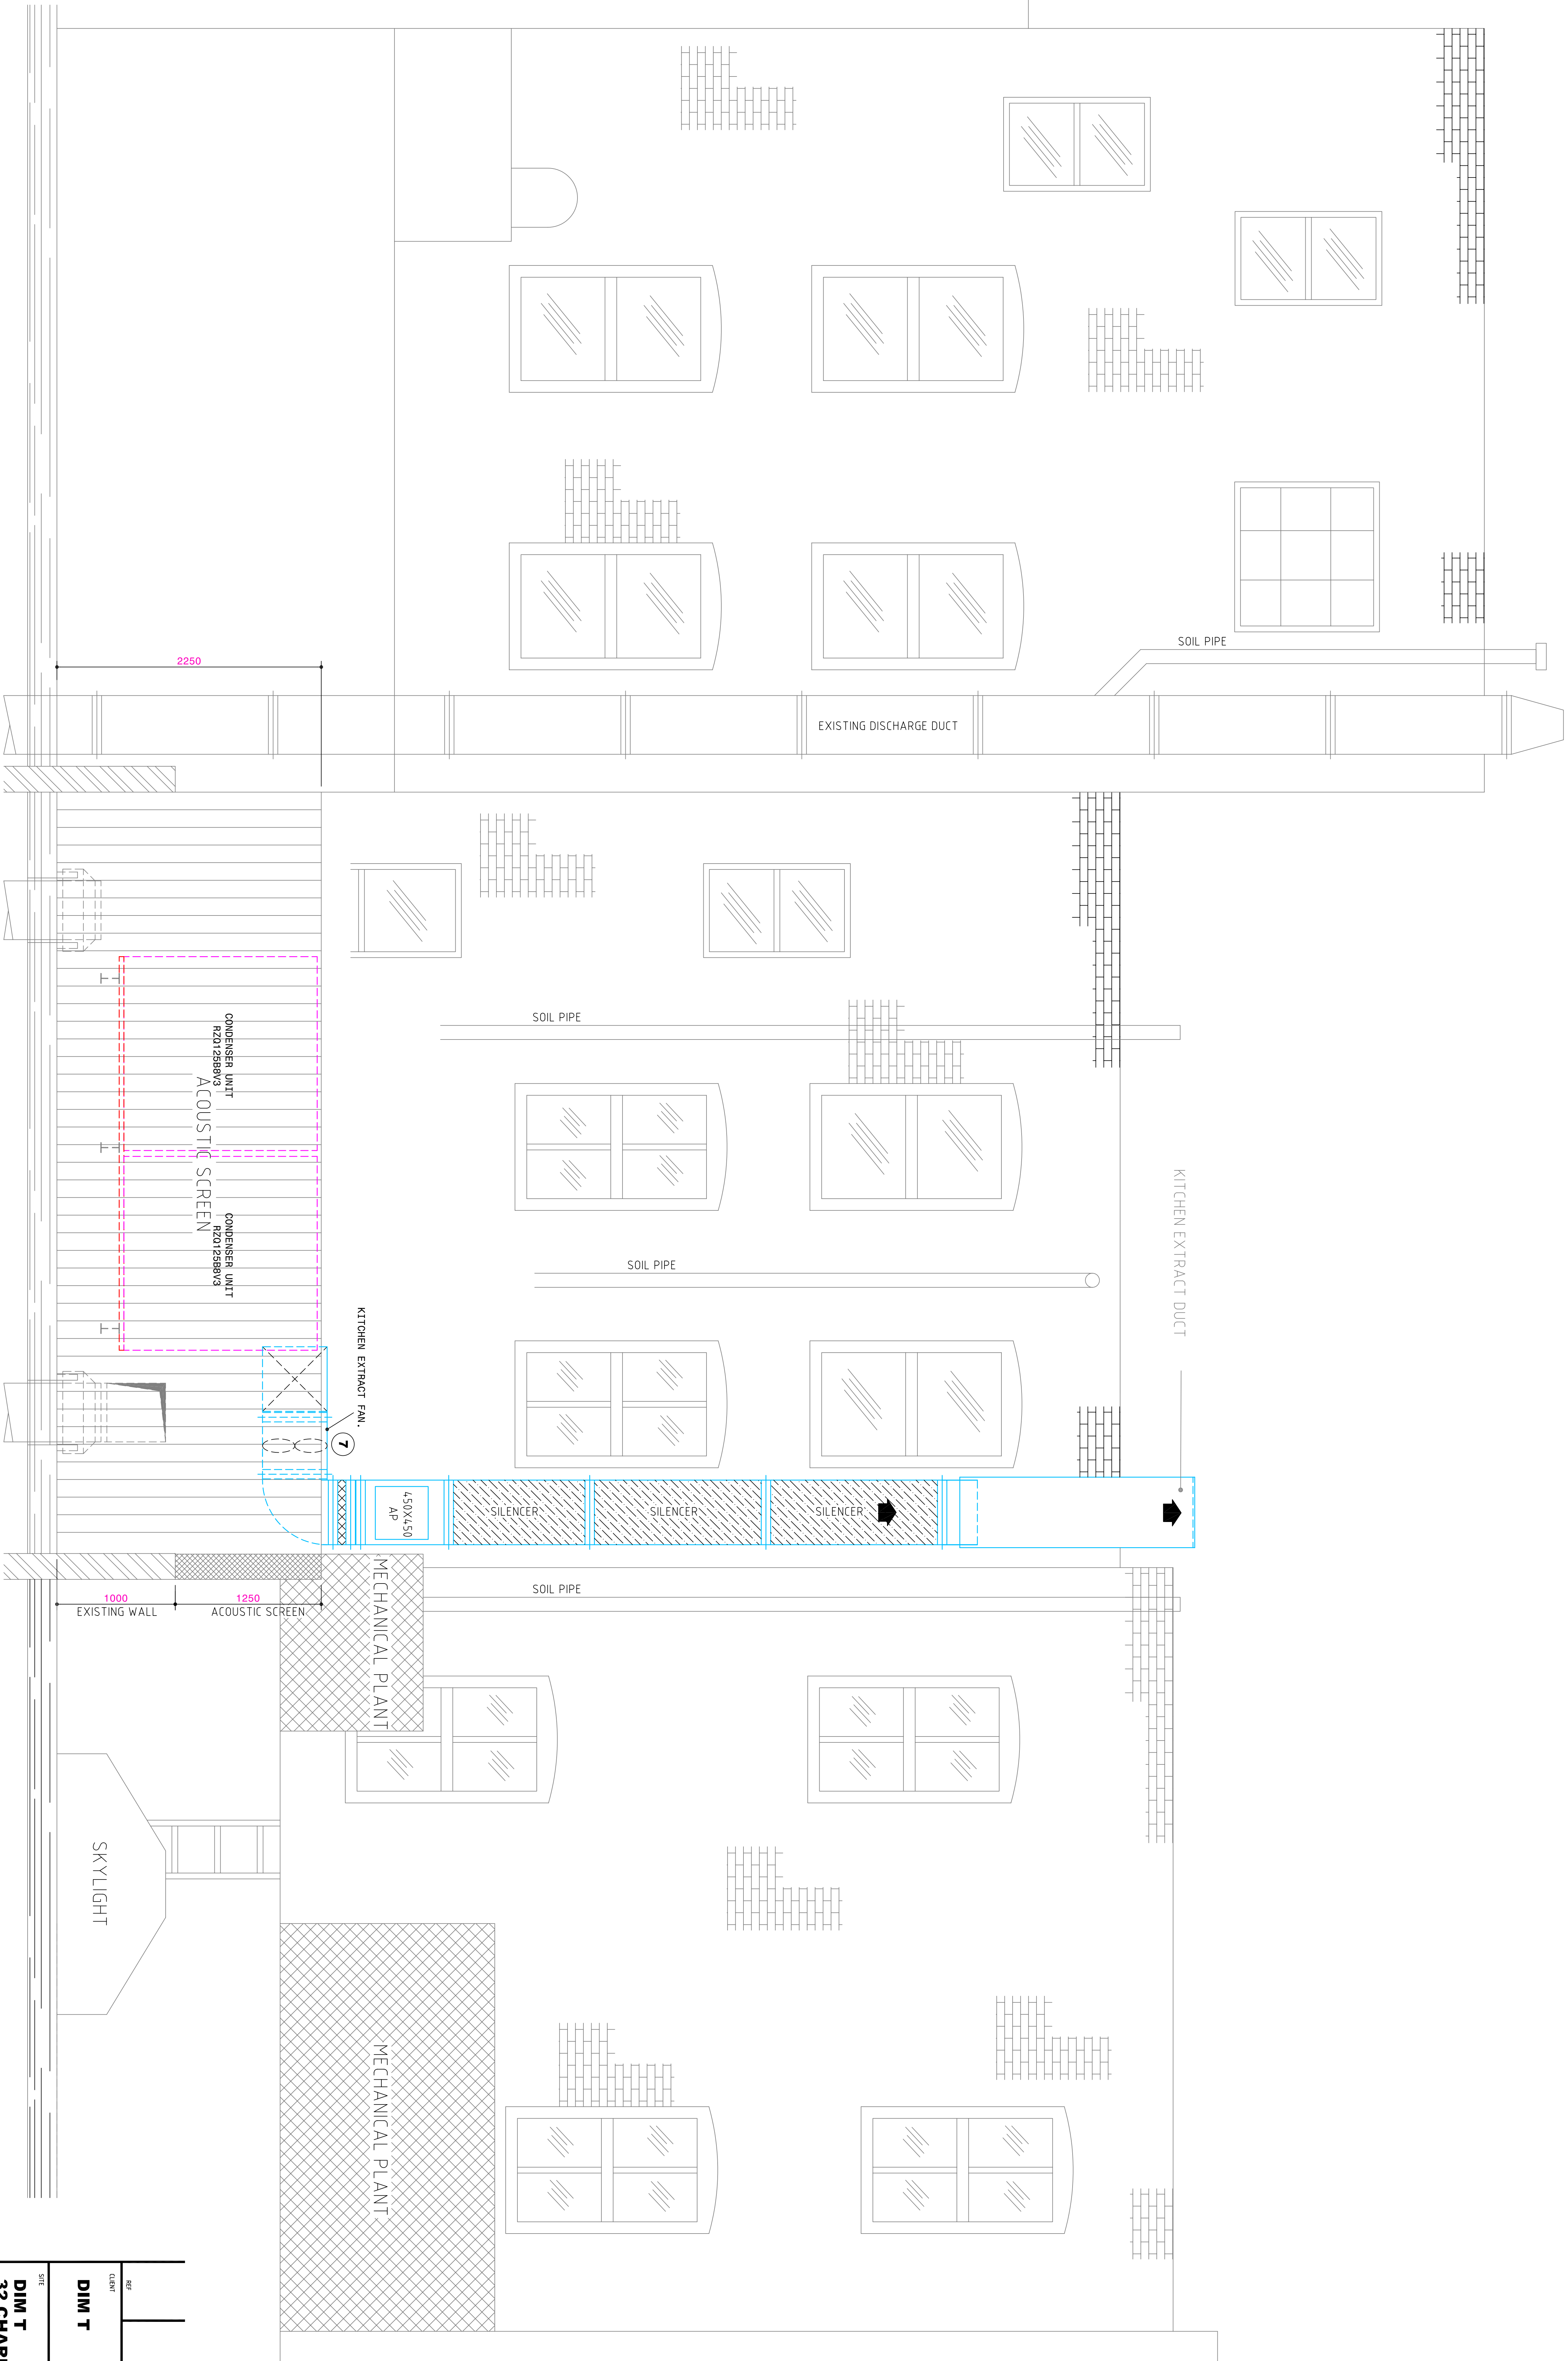

REF	REVISION	DATE
CLEAR		
DIM T		

SITE
DIM T
32 CHARLOTTE STREET

TITLE
DETAIL OF NEW VENTILATION PLANT ON FLAT ROOF.

SCALE	DRAWN BY
1:20 AT A0	Rob Bonner
DATE	SPECIFICATION
13/1/2007	DW171

BOATMAN AIRCONDITIONING LTD
UNIT 13, Ainslie Industrial Estate,
Bell Green Lane, London, SE 51W. Telephone 0208 778 8871

DRG. No	5964/2	REVISION
---------	--------	----------