


PARTITION LEGEND

- Plasterboard wall
- Plasterboard wall with ply board
- 10mm silicone jointed glass wall
- Boundary of site

E V E R S H O L T S T R E E T

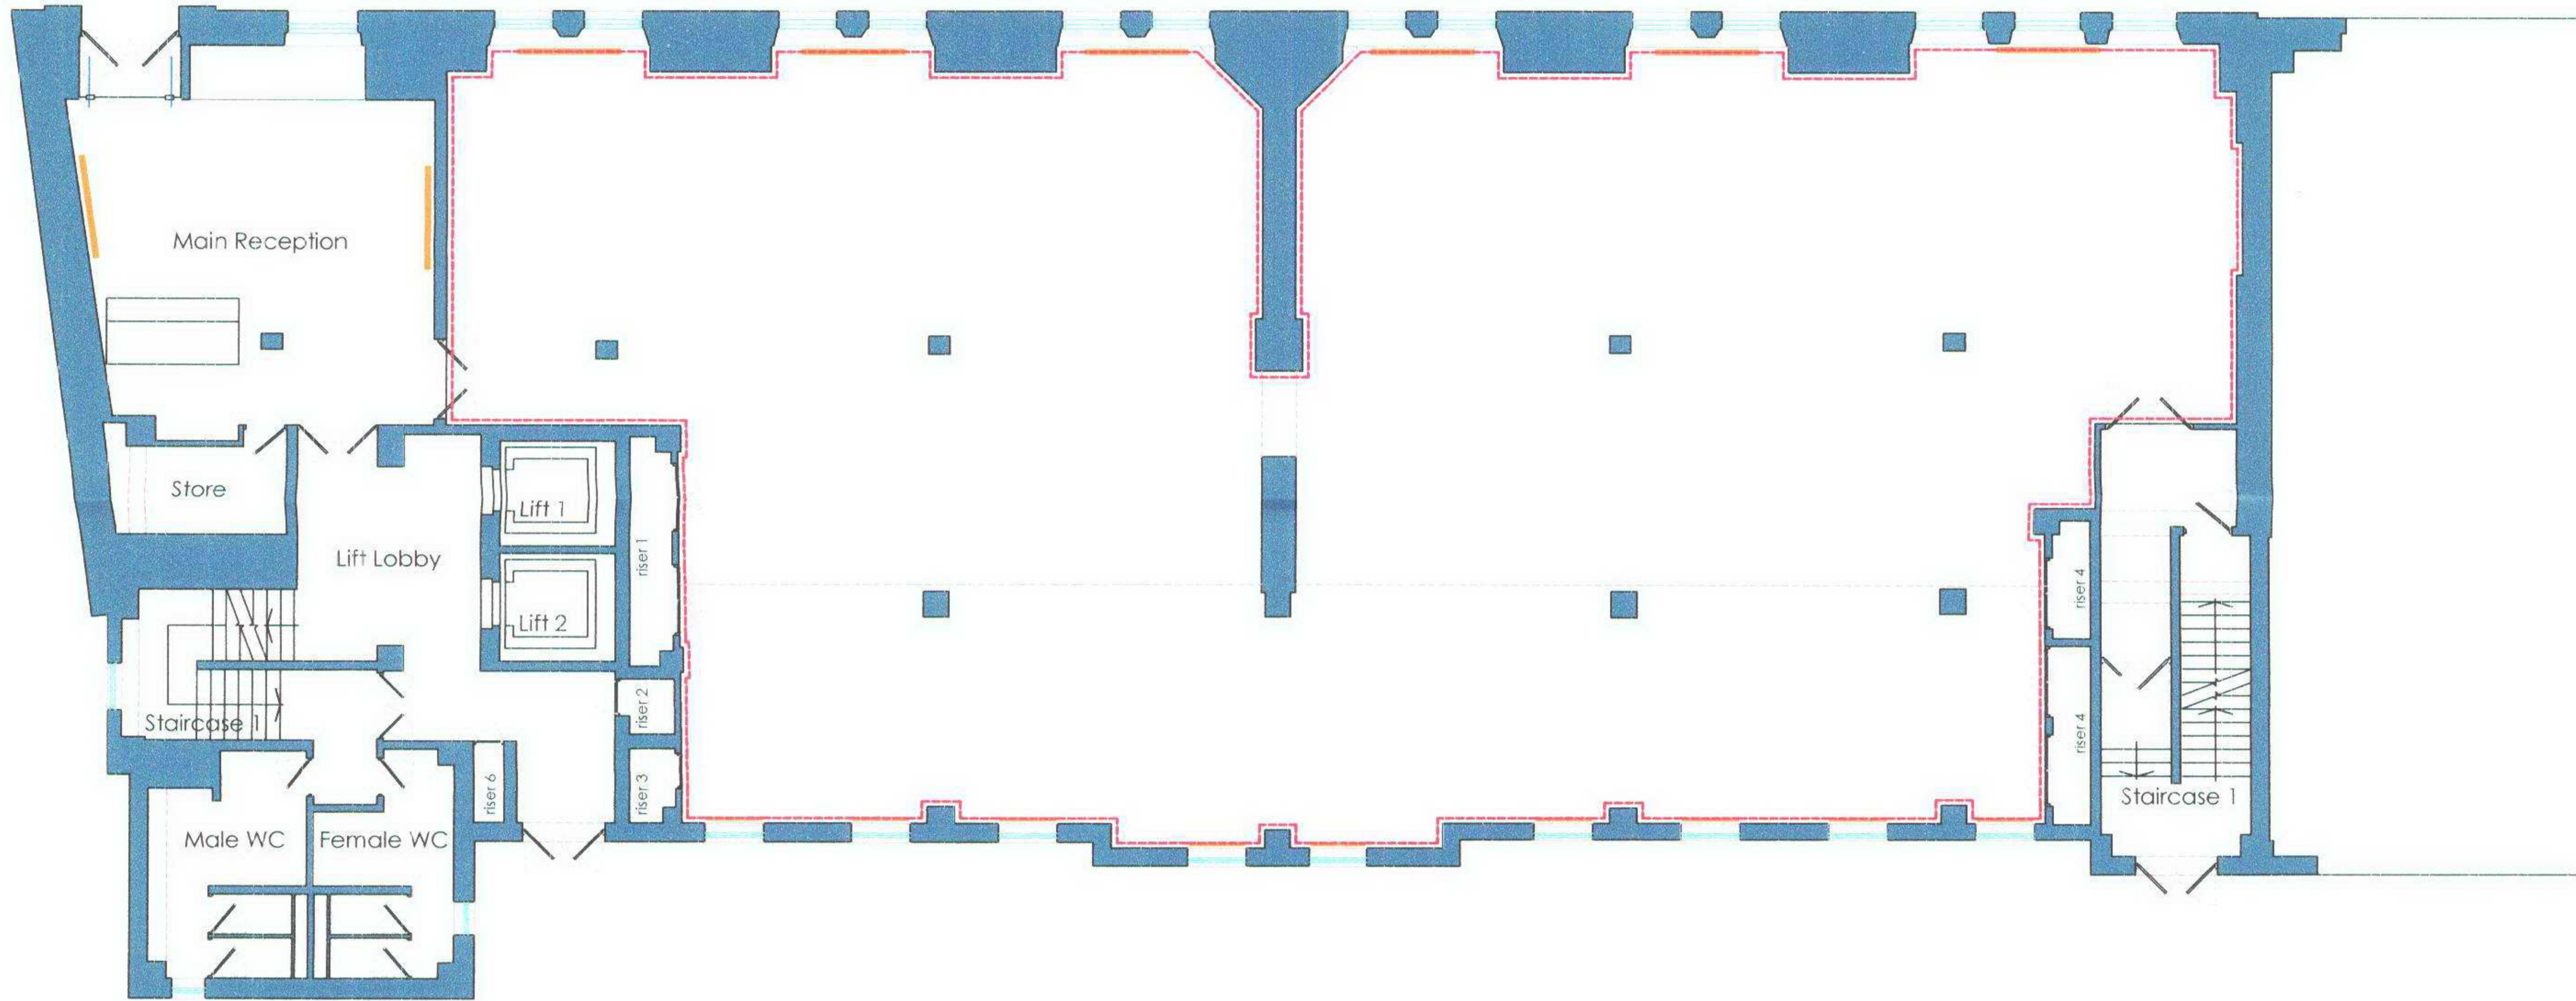


HVAC LEGEND

Existing Radiator

GROUND FLOOR
EXISTING LAYOUT

LAYOUT SUBJECT TO
LOCAL AUTHORITY APPROVALS

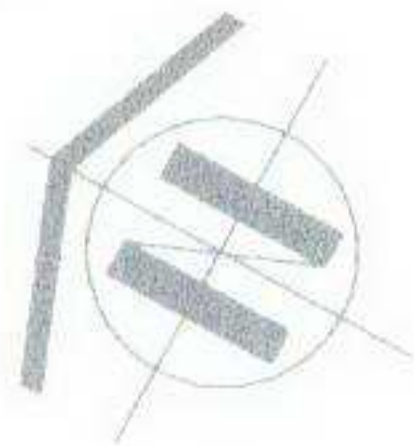

6m

RECEIVED
14 MAR 2007

REV	DESCRIPTION	DATE
Landmark Education Corp.		
CLIENT		
203 Eversholt Street		
London NW1 1BU		
SITE ADDRESS		
Layout to Ground Floor		
DRAWING TITLE		
LEC 132	EX-G 001	
PROJECT NO.	DRAWING NO.	REV.
1:100	Existing	
SCALE	DESCRIPTION	
A.V	25 Jan 07	
DRAWN	DATE	
T 020 7487 3222		
F 020 7487 3556		
BASEINTERIORS		
BASE		
5 OLDBURY PLACE LONDON W1U 5PE		