


FOR CONTINUATION REFER TO DRG. No. 23101/DD/M/20312


WHERE INDICATED SERVICES DISTRIBUTION WITHIN EACH ROOM ARE BASED ON SCHEME DESIGN LAYOUTS. FINAL LAYOUTS TO BE AGREED.

WITHIN OTHER AREAS FINAL SERVICES DISTRIBUTION PROPOSALS WITHIN ROOM TO BE CONFIRMED.

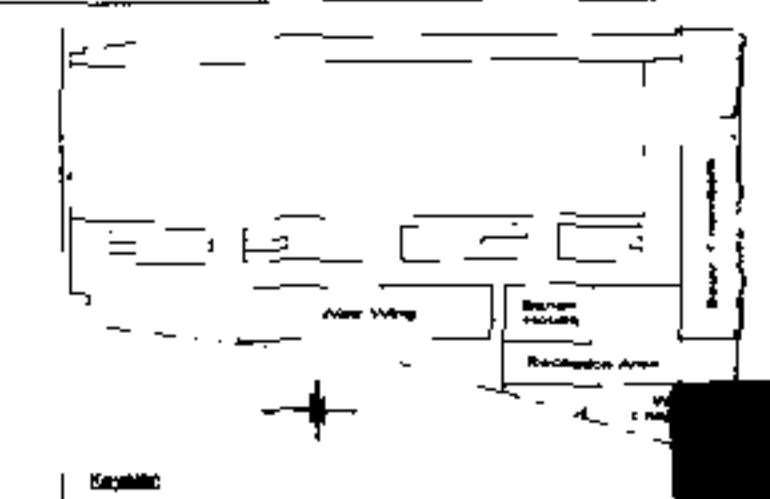

NOTES

1. DRAWING TO FOLLOW DIMENSIONS ONE *
2. THIS DRAWING TO BE READ IN CONJUNCTION WITH ALL RELEVANT ARCHITECTURAL & STRUCTURAL ENGINEERS DRAWINGS
3. THIS DRAWING TO BE READ IN CONJUNCTION WITH ALL RELEVANT AIRPORT MASTER PLAN DRAWINGS
4. THIS DRAWING TO BE READ IN CONJUNCTION WITH RELEVANT AERONAUTIC DRAWINGS
5. FOR TYPICAL DETAILS & REFER TO DRAWING No 2318 104000030000

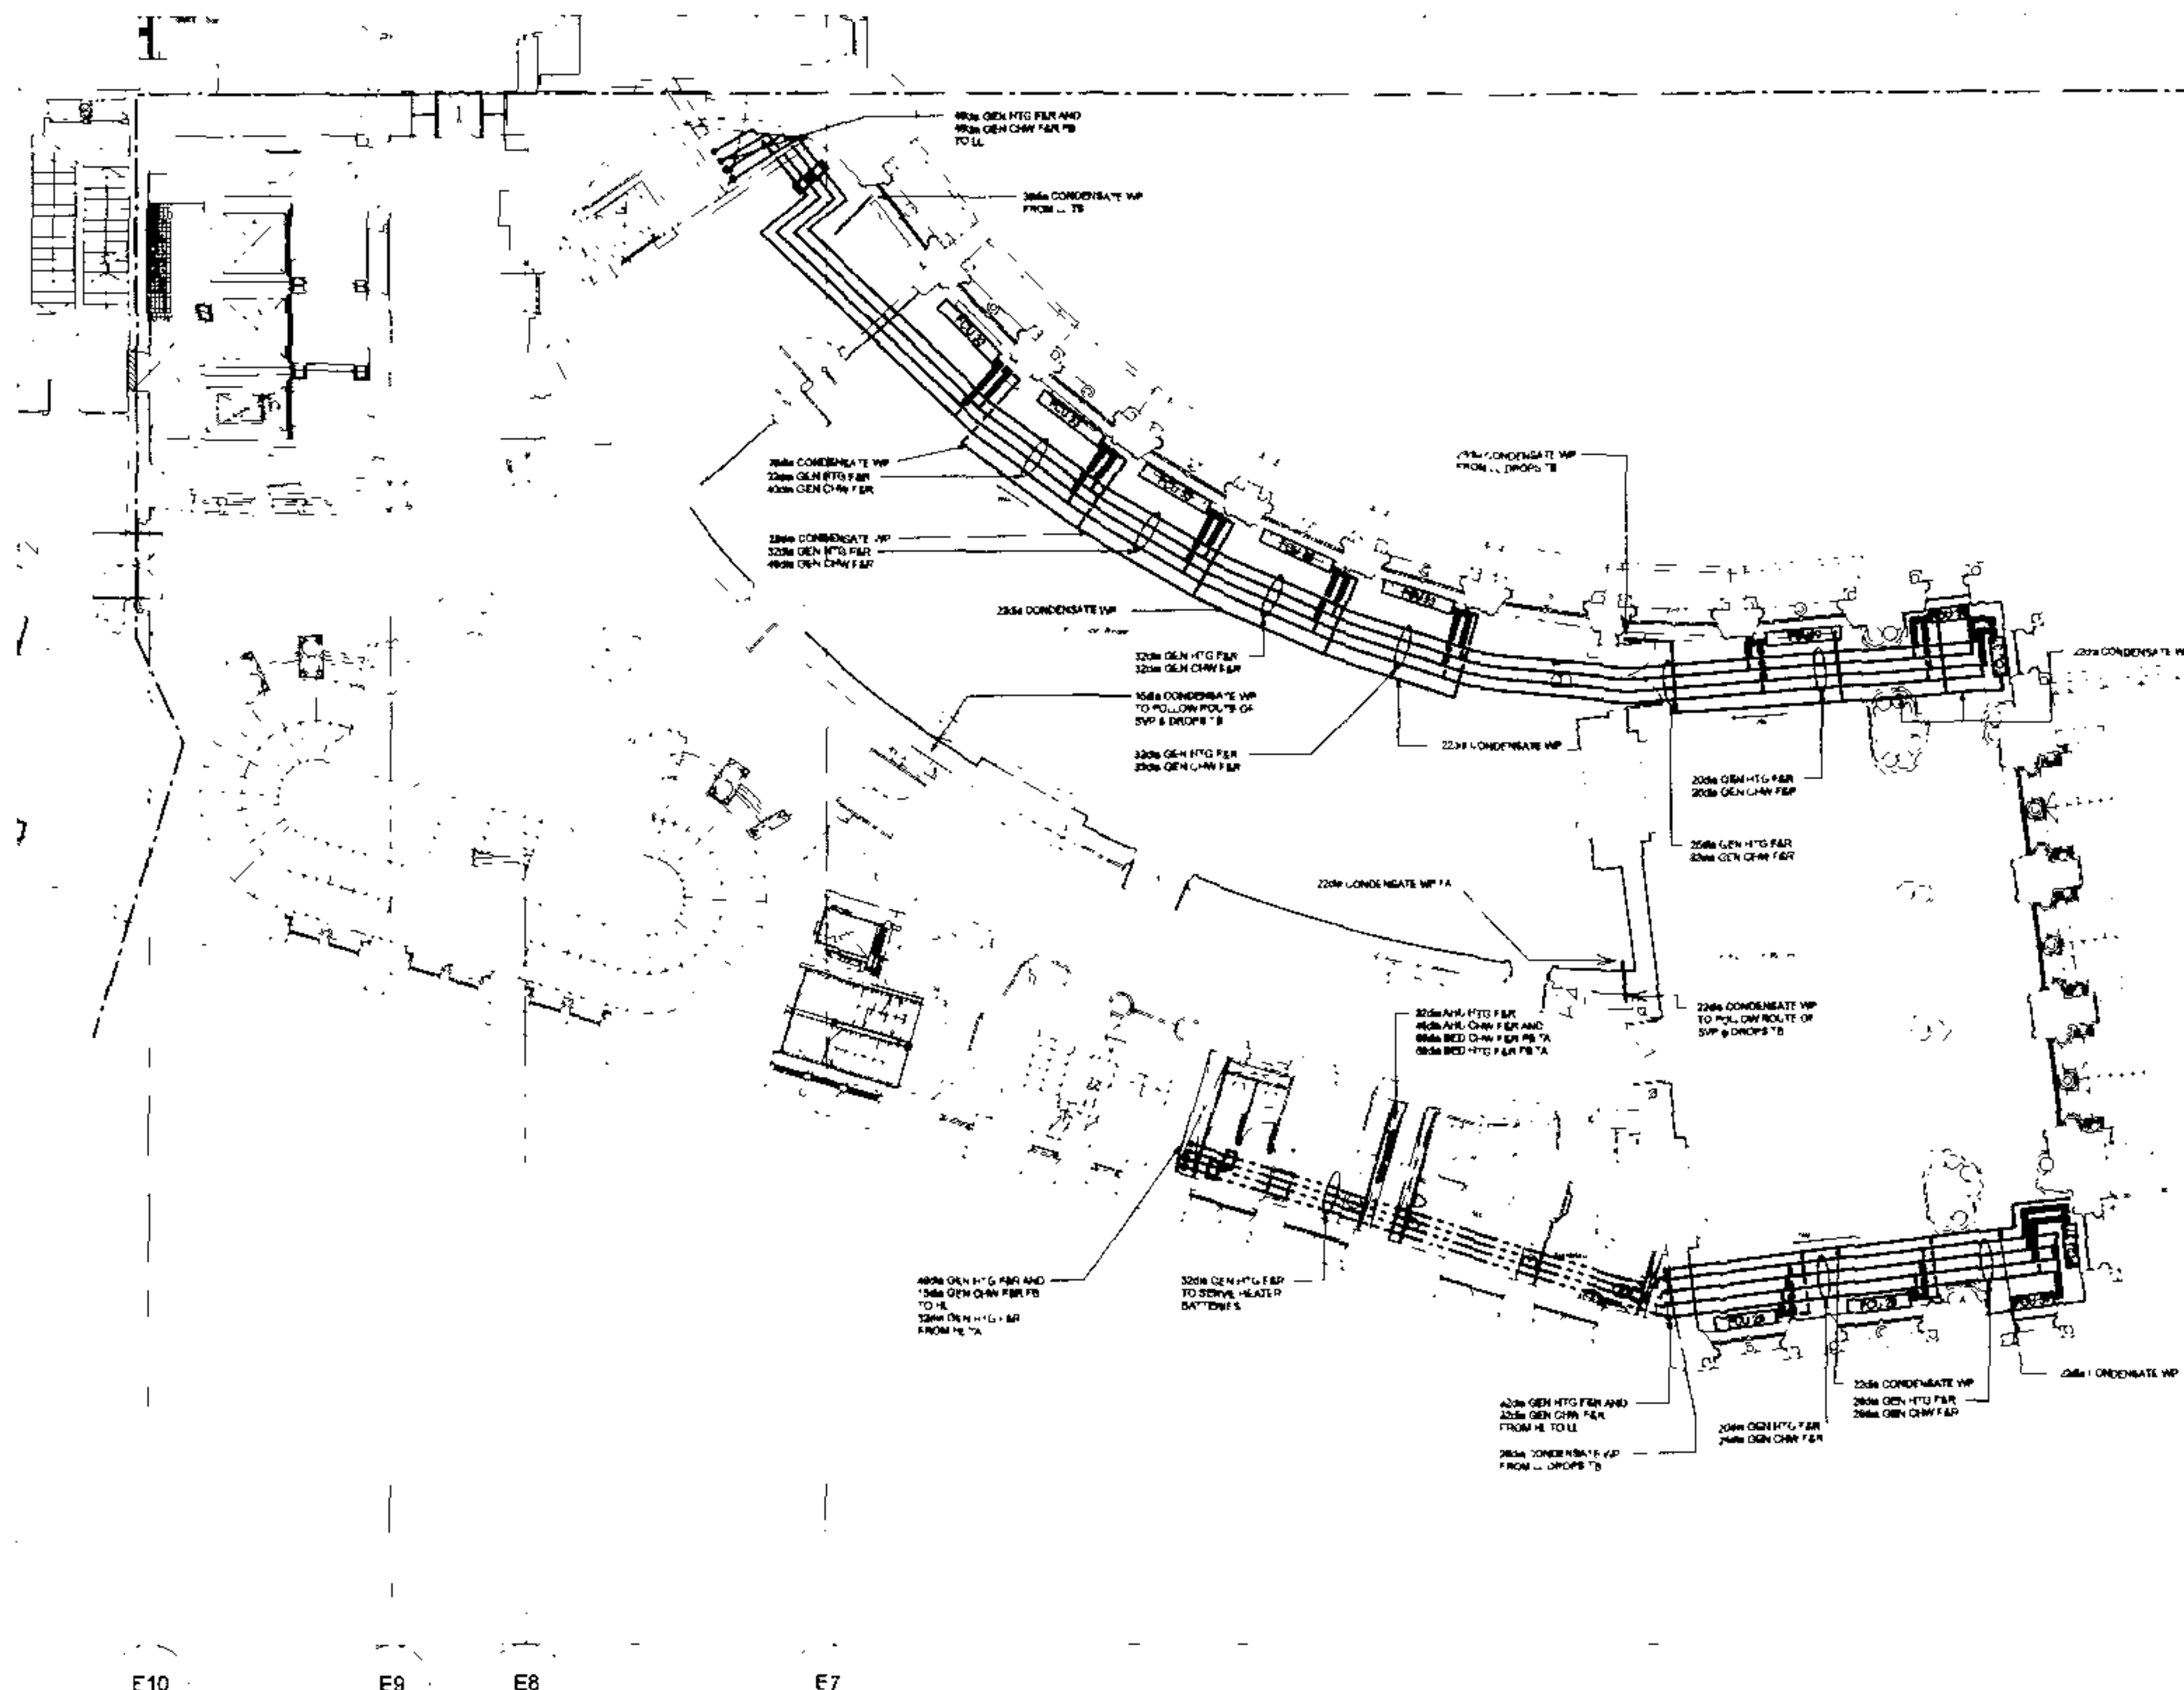


E10

E9

E8

E7

E7

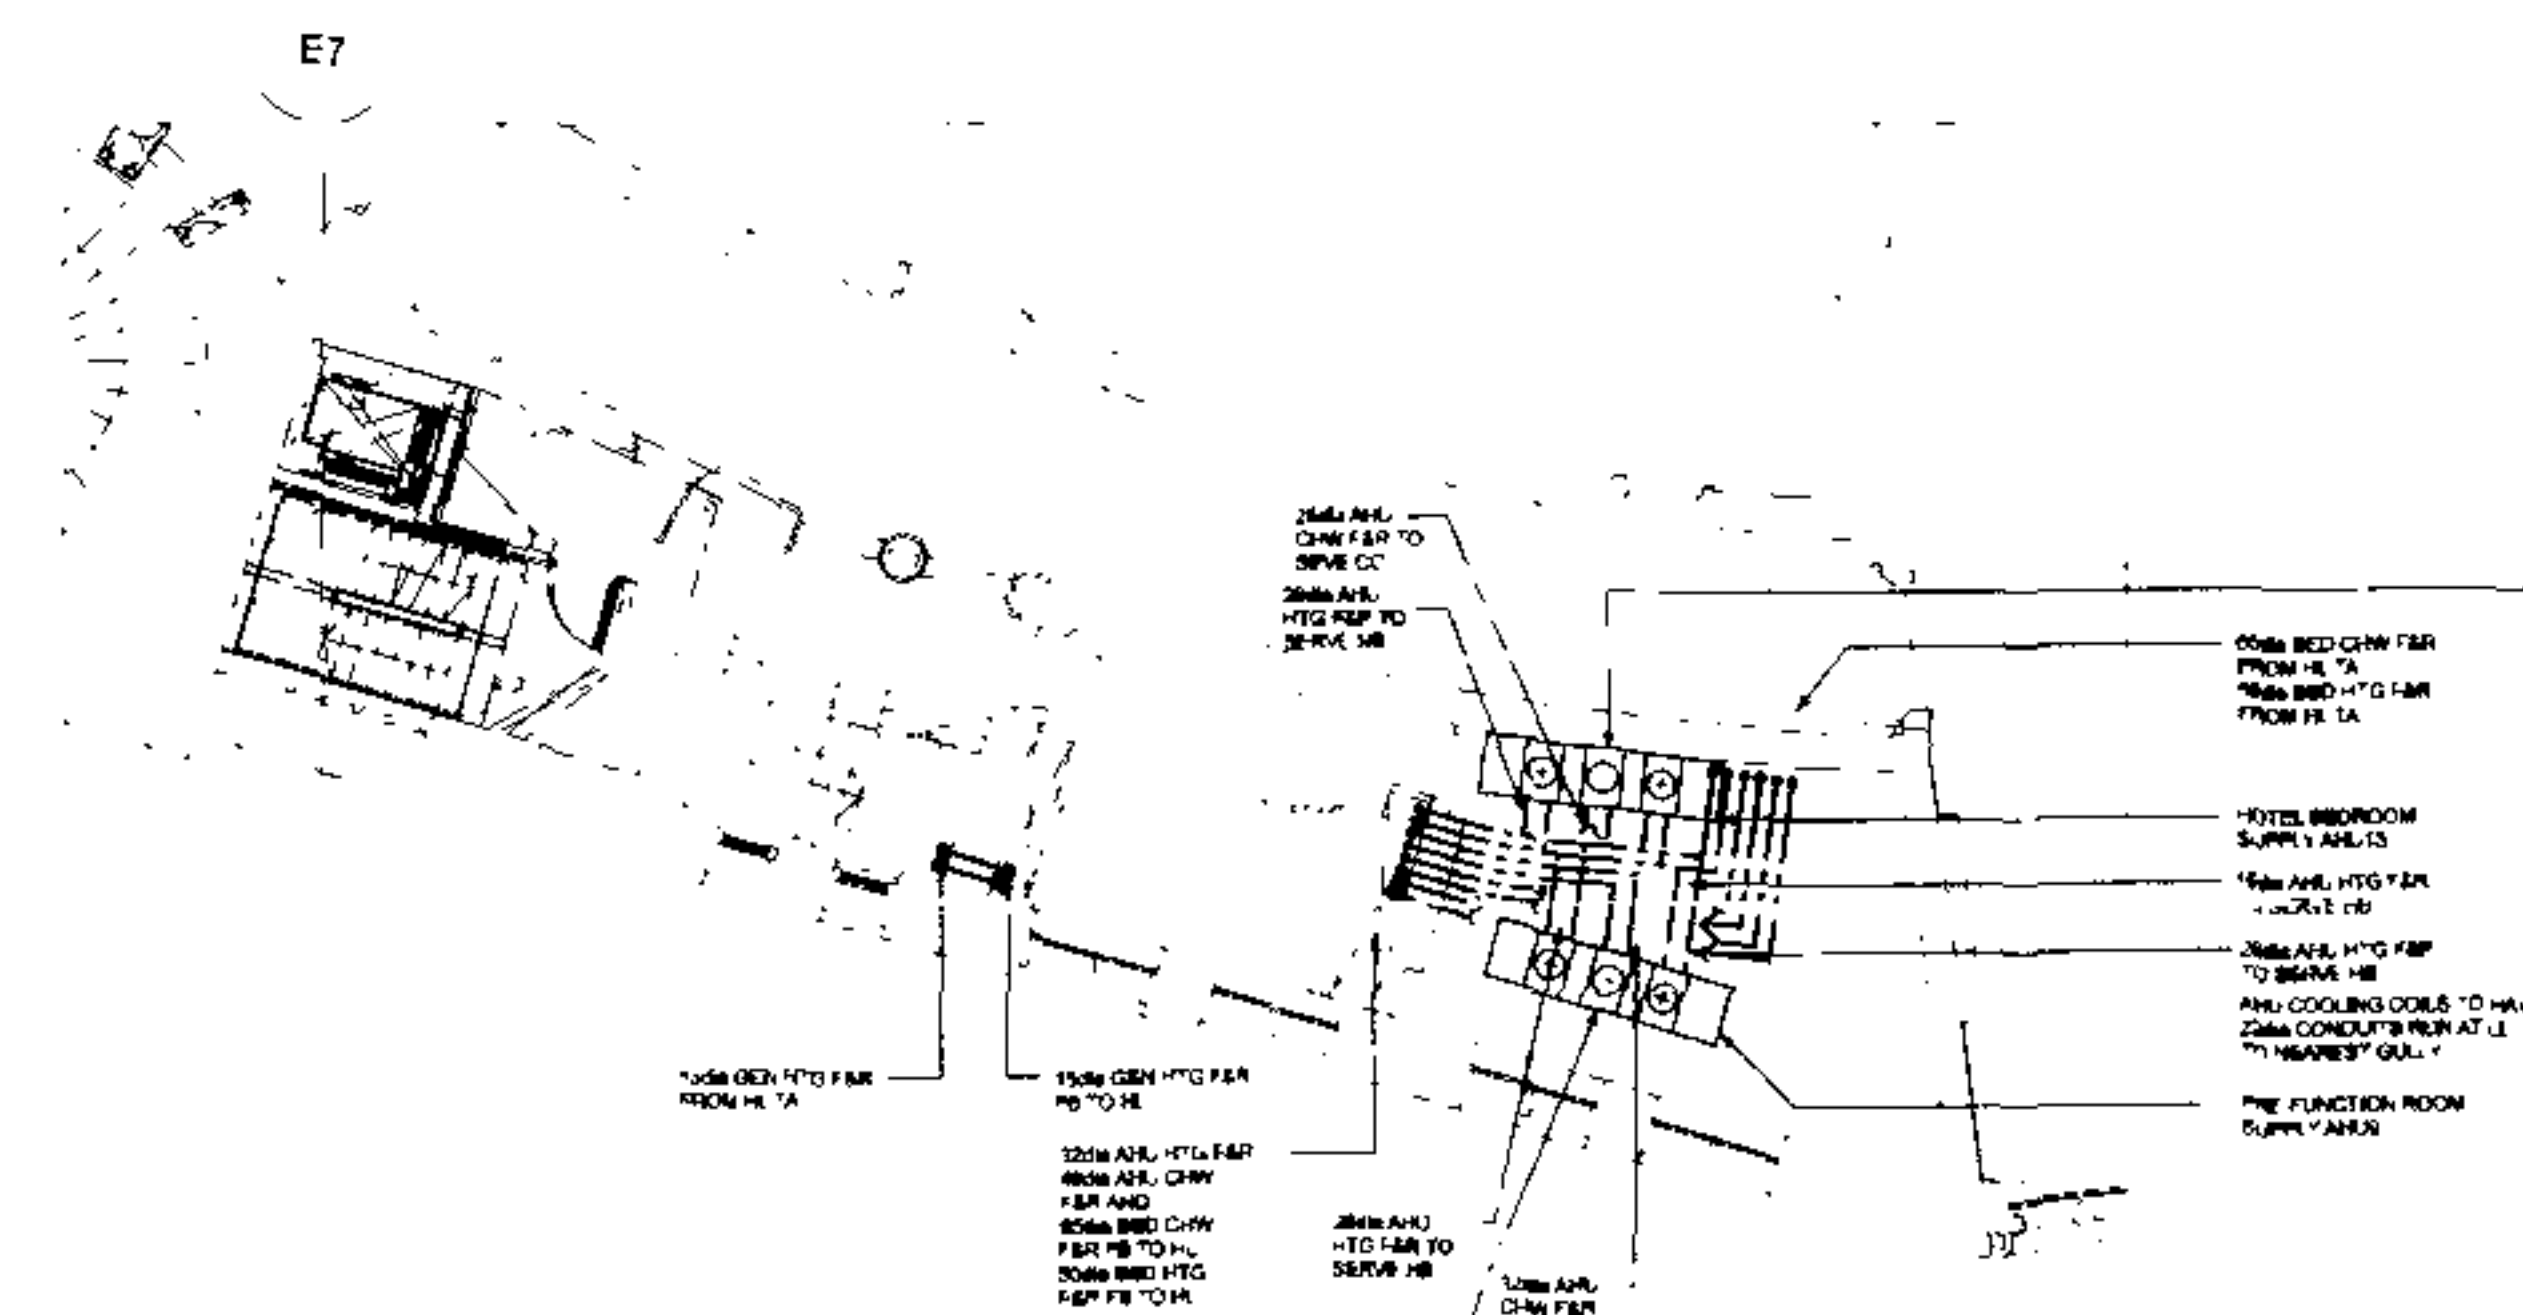

ALL HORIZONTAL ABOVE BATHROOMS, FLOORS 0 HAVE 2284
CONDENSATE WASTE PIPE FROM HL TO DISCHARGE TO DRAIN
VIA THE WASTE OUTLET VIA GRAVITY. ALL RETAINING
FLOORS TO HAVE 2284 CONDENSATE WASTE PIPES FROM HL TO

Aug 14		DCC 4 - Webster Pharmaceuticals added for pricing		12	
Rev	Costs	Details	Issued	Chd	Age
Status					

Status **TENDER
DRAWING**

Architect
RHW Architects
and
RICHARD GRIFFITHS ARCHITECTS
7 Canal Street, Suite 1000, NYC, NY 10014
Tel: 212 279 1000 Fax: 212 279 1001

Client
Manhattan Loft
Corporation Limited

Project

St Pancras Chambers

Title WEST CHAMBERS
FIRST FLOOR
HEATING AND COOLING
LAYOUT
Sheet 1 of 2

Made	SC			CAD	SC
Cr'd	mach	elec	ph	Scale	1:10
	A.F.				
App	DTE			Date	MAY


FABER MAUNSELL | **AECO**

23101/DD/M/203/1

NOTE

WHERE INDICATED SERVICES DISTRIBUTION WITHIN EACH ROOM ARE BASED ON SCHEME DESIGN LAYOUTS. FINAL LAYOUTS TO BE AGREED.

WITHIN OTHER AREAS FINAL SERVICES DISTRIBUTION PROPOSALS WITHIN ROOM TO BE CONFIRMED


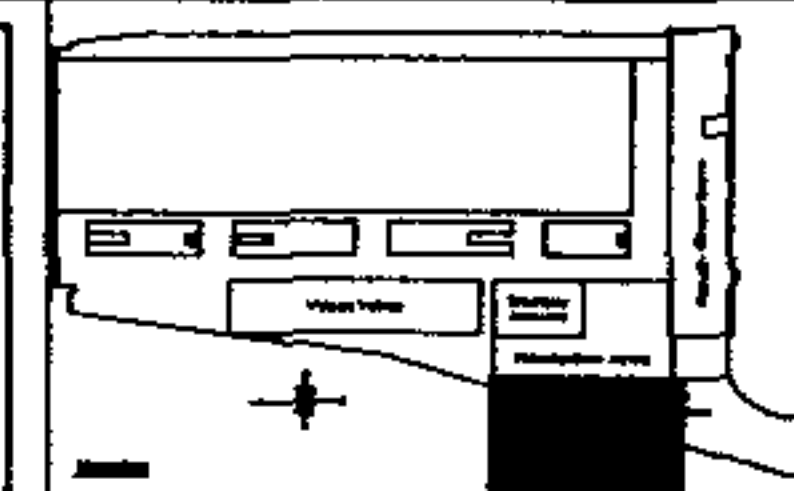


BASE DRAWINGS


USED IN COMPLETION OF THIS DRAWING

NOTES

1. WORK TO PROPOSED CHAMBERS ONLY.
2. THIS DRAWING TO BE IN CONJUNCTION WITH ALL RELEVANT BASE DRAWINGS AND STRUCTURAL DRAWINGS.
3. THIS DRAWING TO BE IN CONJUNCTION WITH ALL RELEVANT BASE DRAWINGS AND STRUCTURAL DRAWINGS.
4. THIS DRAWING TO BE IN CONJUNCTION WITH ALL RELEVANT BASE DRAWINGS AND STRUCTURAL DRAWINGS.
5. FOR TYPICAL DETAILS REFER TO DRAWING NO. 23101/DD/M/203/1

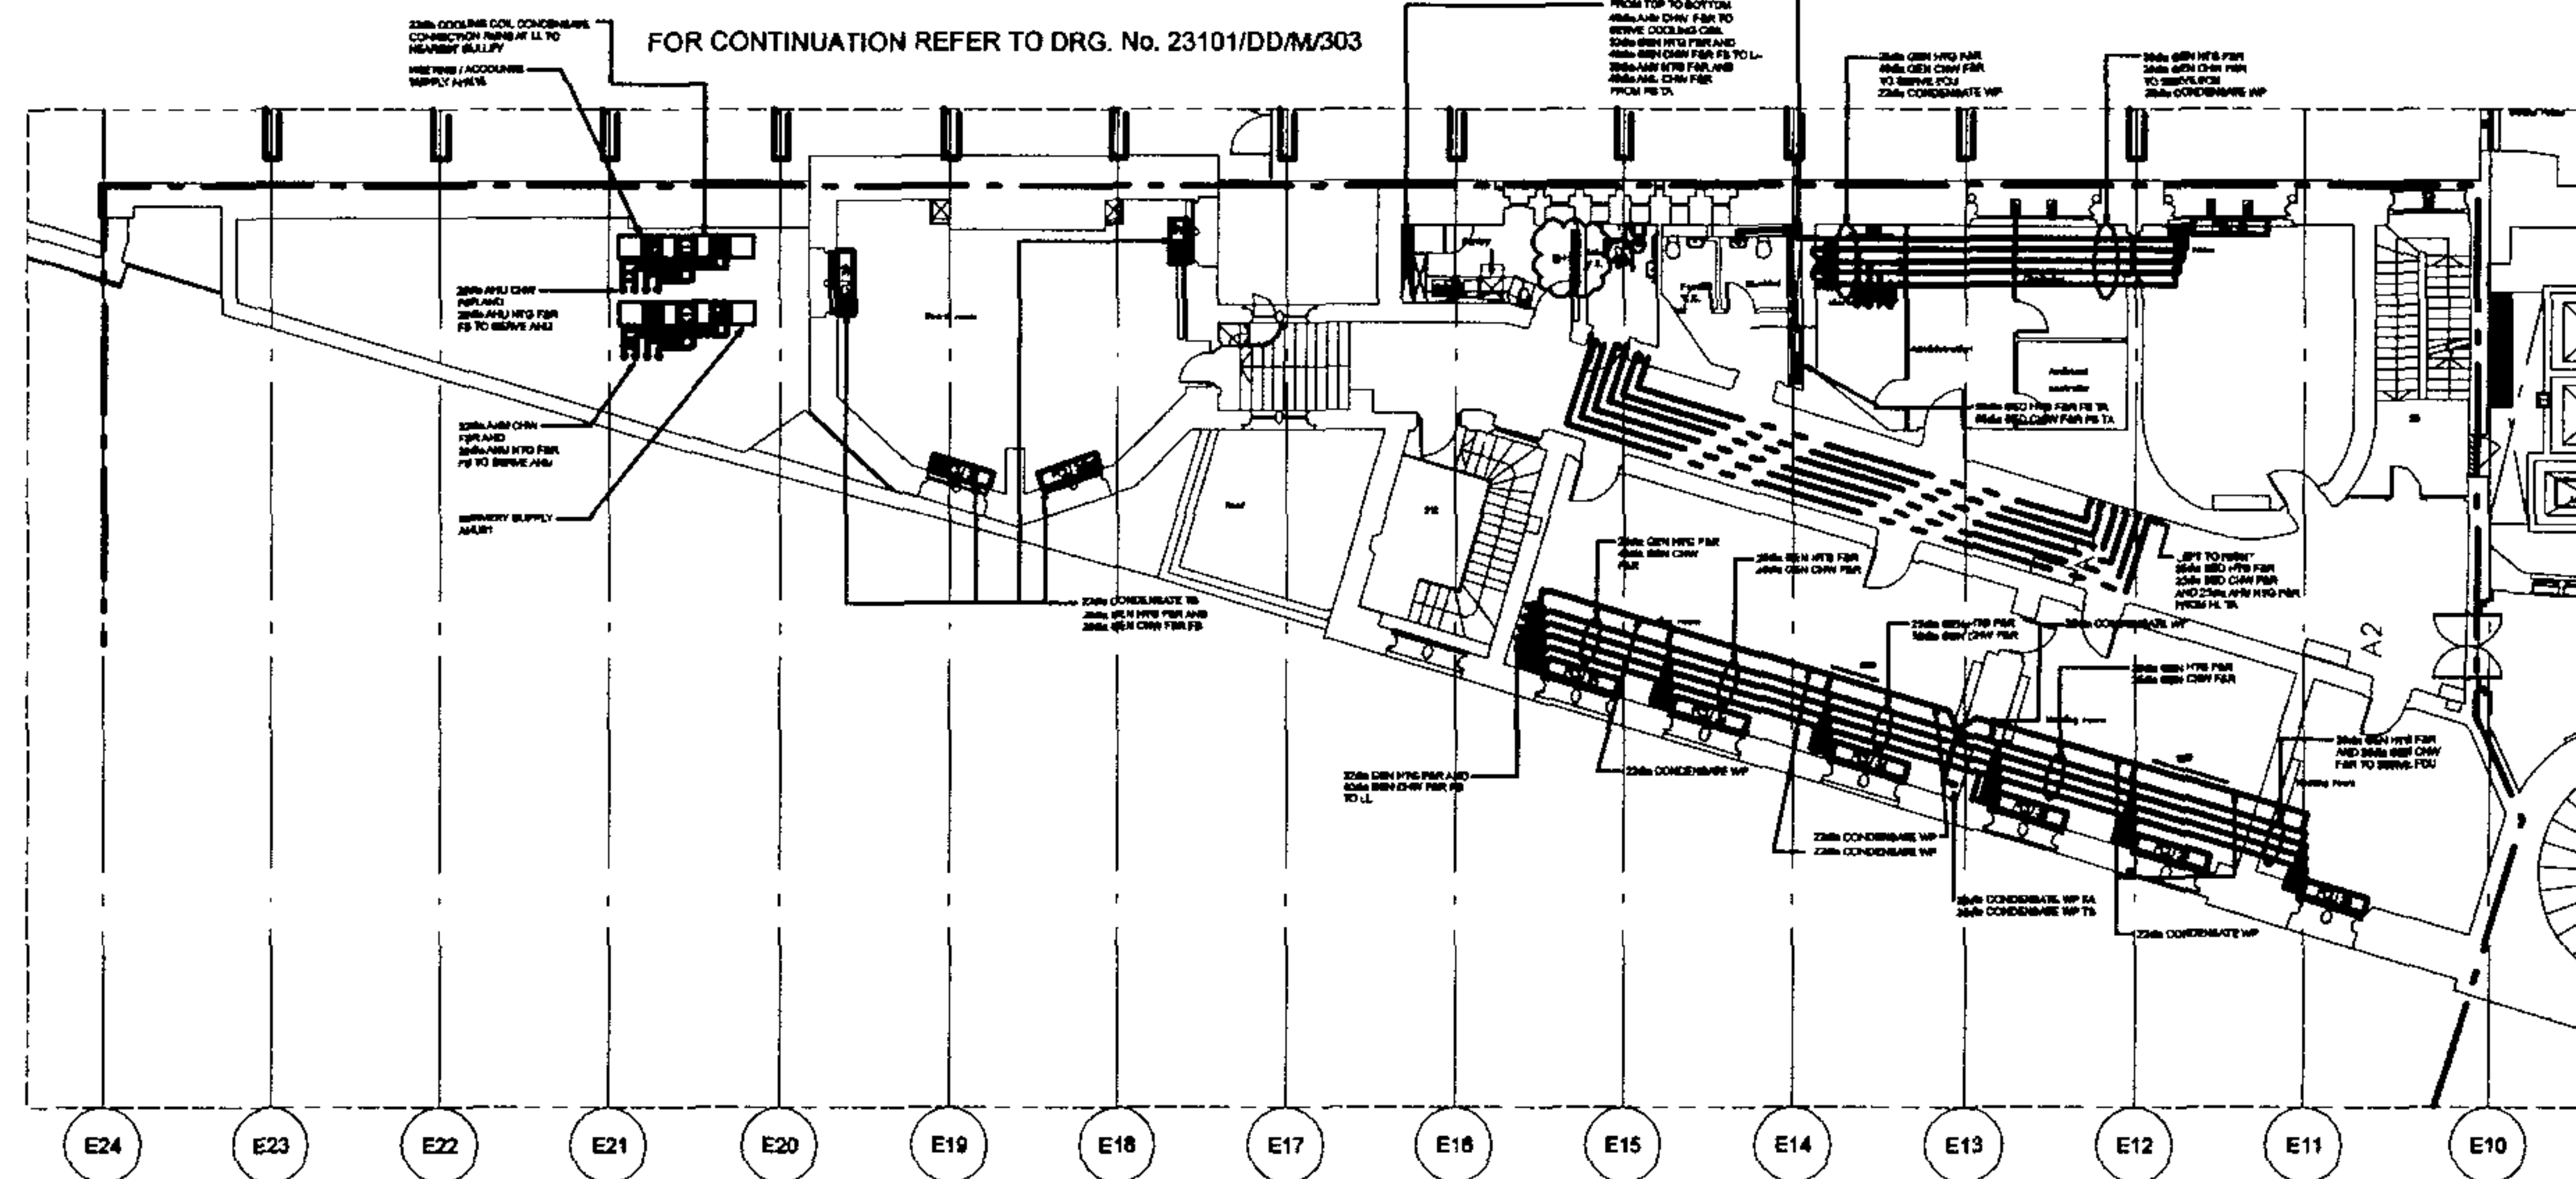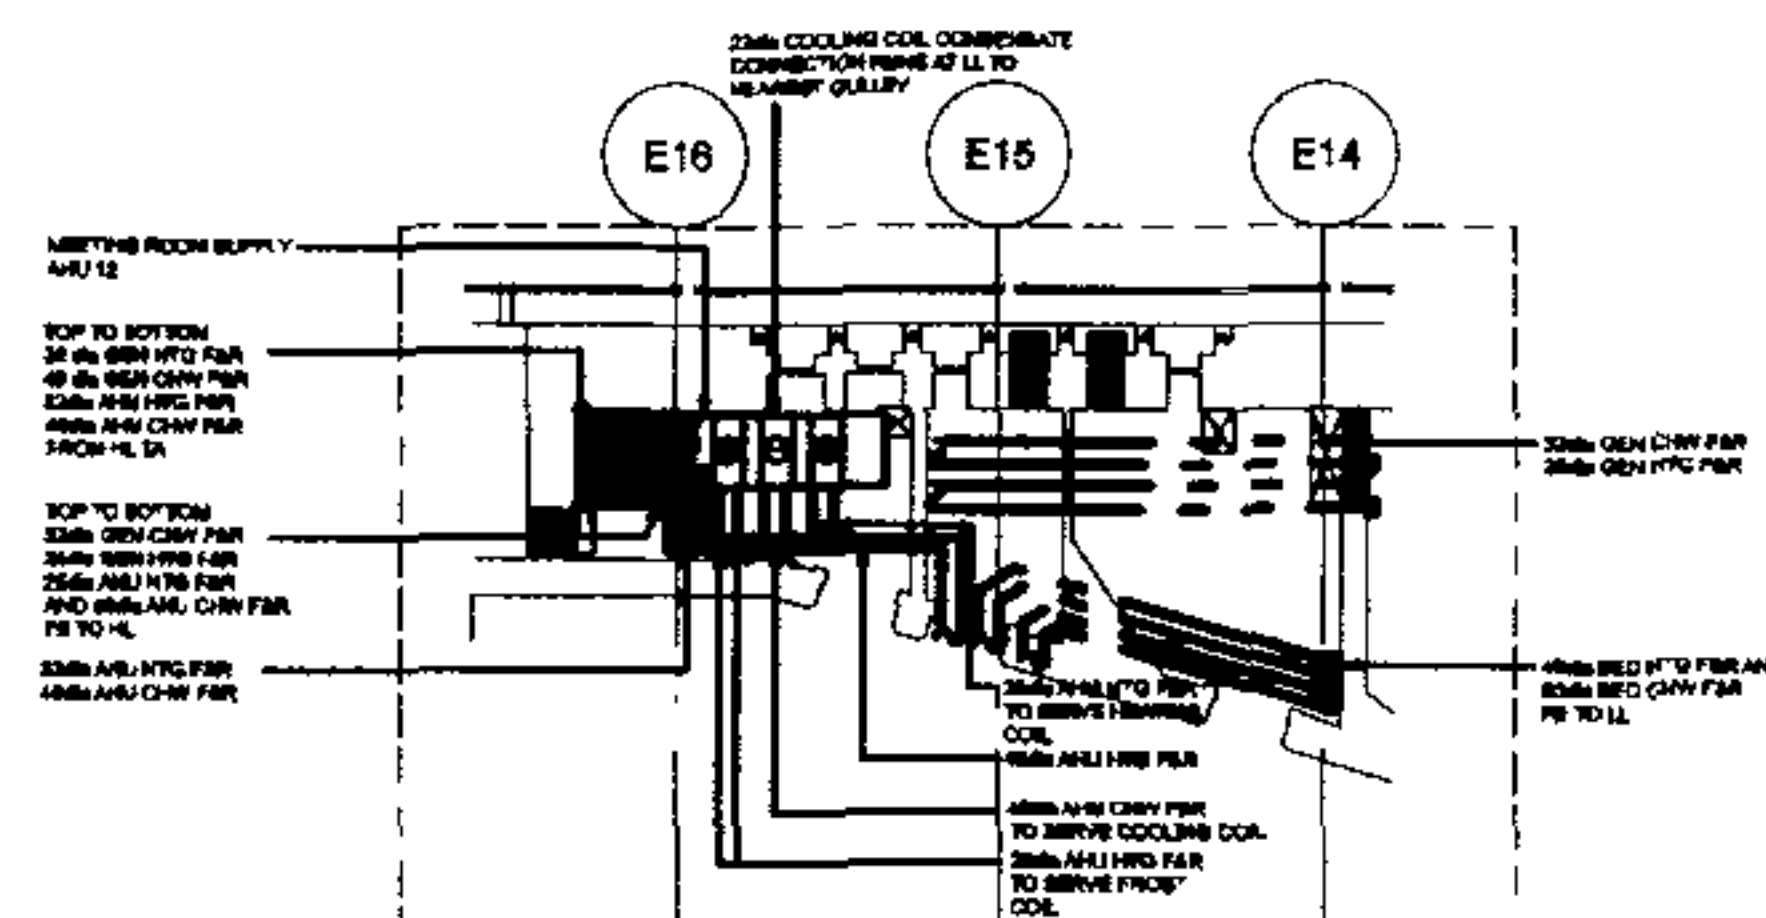

FOR CONTINUATION REFER TO DRG. No. 23101/DD/M/203/1

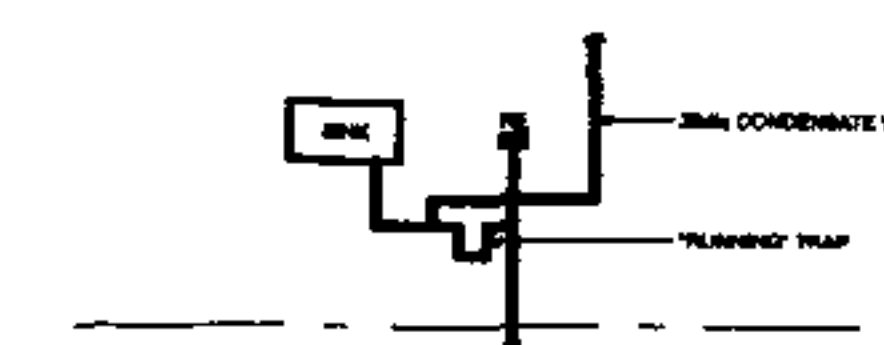


EGU CONDENSATE DETAIL

ALL HORIZONTAL PIPING SUBSEQUENT TO THIS FLOOR SHALL HAVE 2% FALL TO THE RIGHT OR LEFT AS SHOWN TO DISCHARGE TO THE STREET OR TO THE SEWER. ALL PIPING SHALL BE 150mm DIA. UNLESS OTHERWISE STATED.

Rev	Date	Description	By	Check
1	10/01/01	ISSUED FOR TENDER	JP	
2	10/01/01	REVISED	JP	
3	10/01/01	REVISED	JP	
4	10/01/01	REVISED	JP	
100	10/01/01	REVISED	JP	

WHERE INDICATED SERVICES DISTRIBUTION WITHIN EACH ROOM ARE BASED ON SCHEME DESIGN LAYOUTS FINAL LAYOUTS TO BE AGREED.

WITHIN OTHER AREAS FINAL SERVICES DISTRIBUTION PROPOSALS WITHIN ROOM TO BE CONFIRMED.

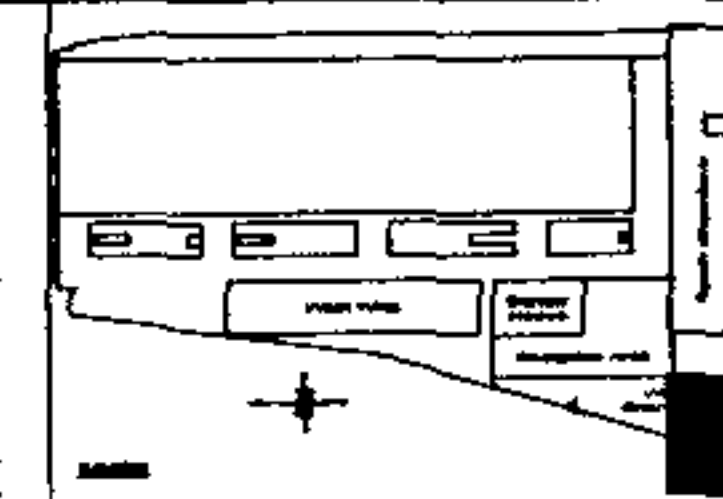


NOTES

1. WORK TO PROPOSED DIMENSIONS ONLY
2. THIS DRAWING TO BE READ IN CONJUNCTION WITH ALL RELEVANT ARCHITECTURAL AND STRUCTURAL DRAWINGS
3. THIS DRAWING TO BE READ IN CONJUNCTION WITH ALL RELEVANT PARTIAL MANHOLE DRAWINGS
4. THIS DRAWING TO BE READ IN CONJUNCTION WITH RELEVANT SECTION TO DRAWINGS
5. FOR TYPICAL DETAILS REFER TO DRAWING No. 2100000000000000

[illegible]

FOR CONTINUATION REFER TO DRG. No. 23101/DD/M/213/2

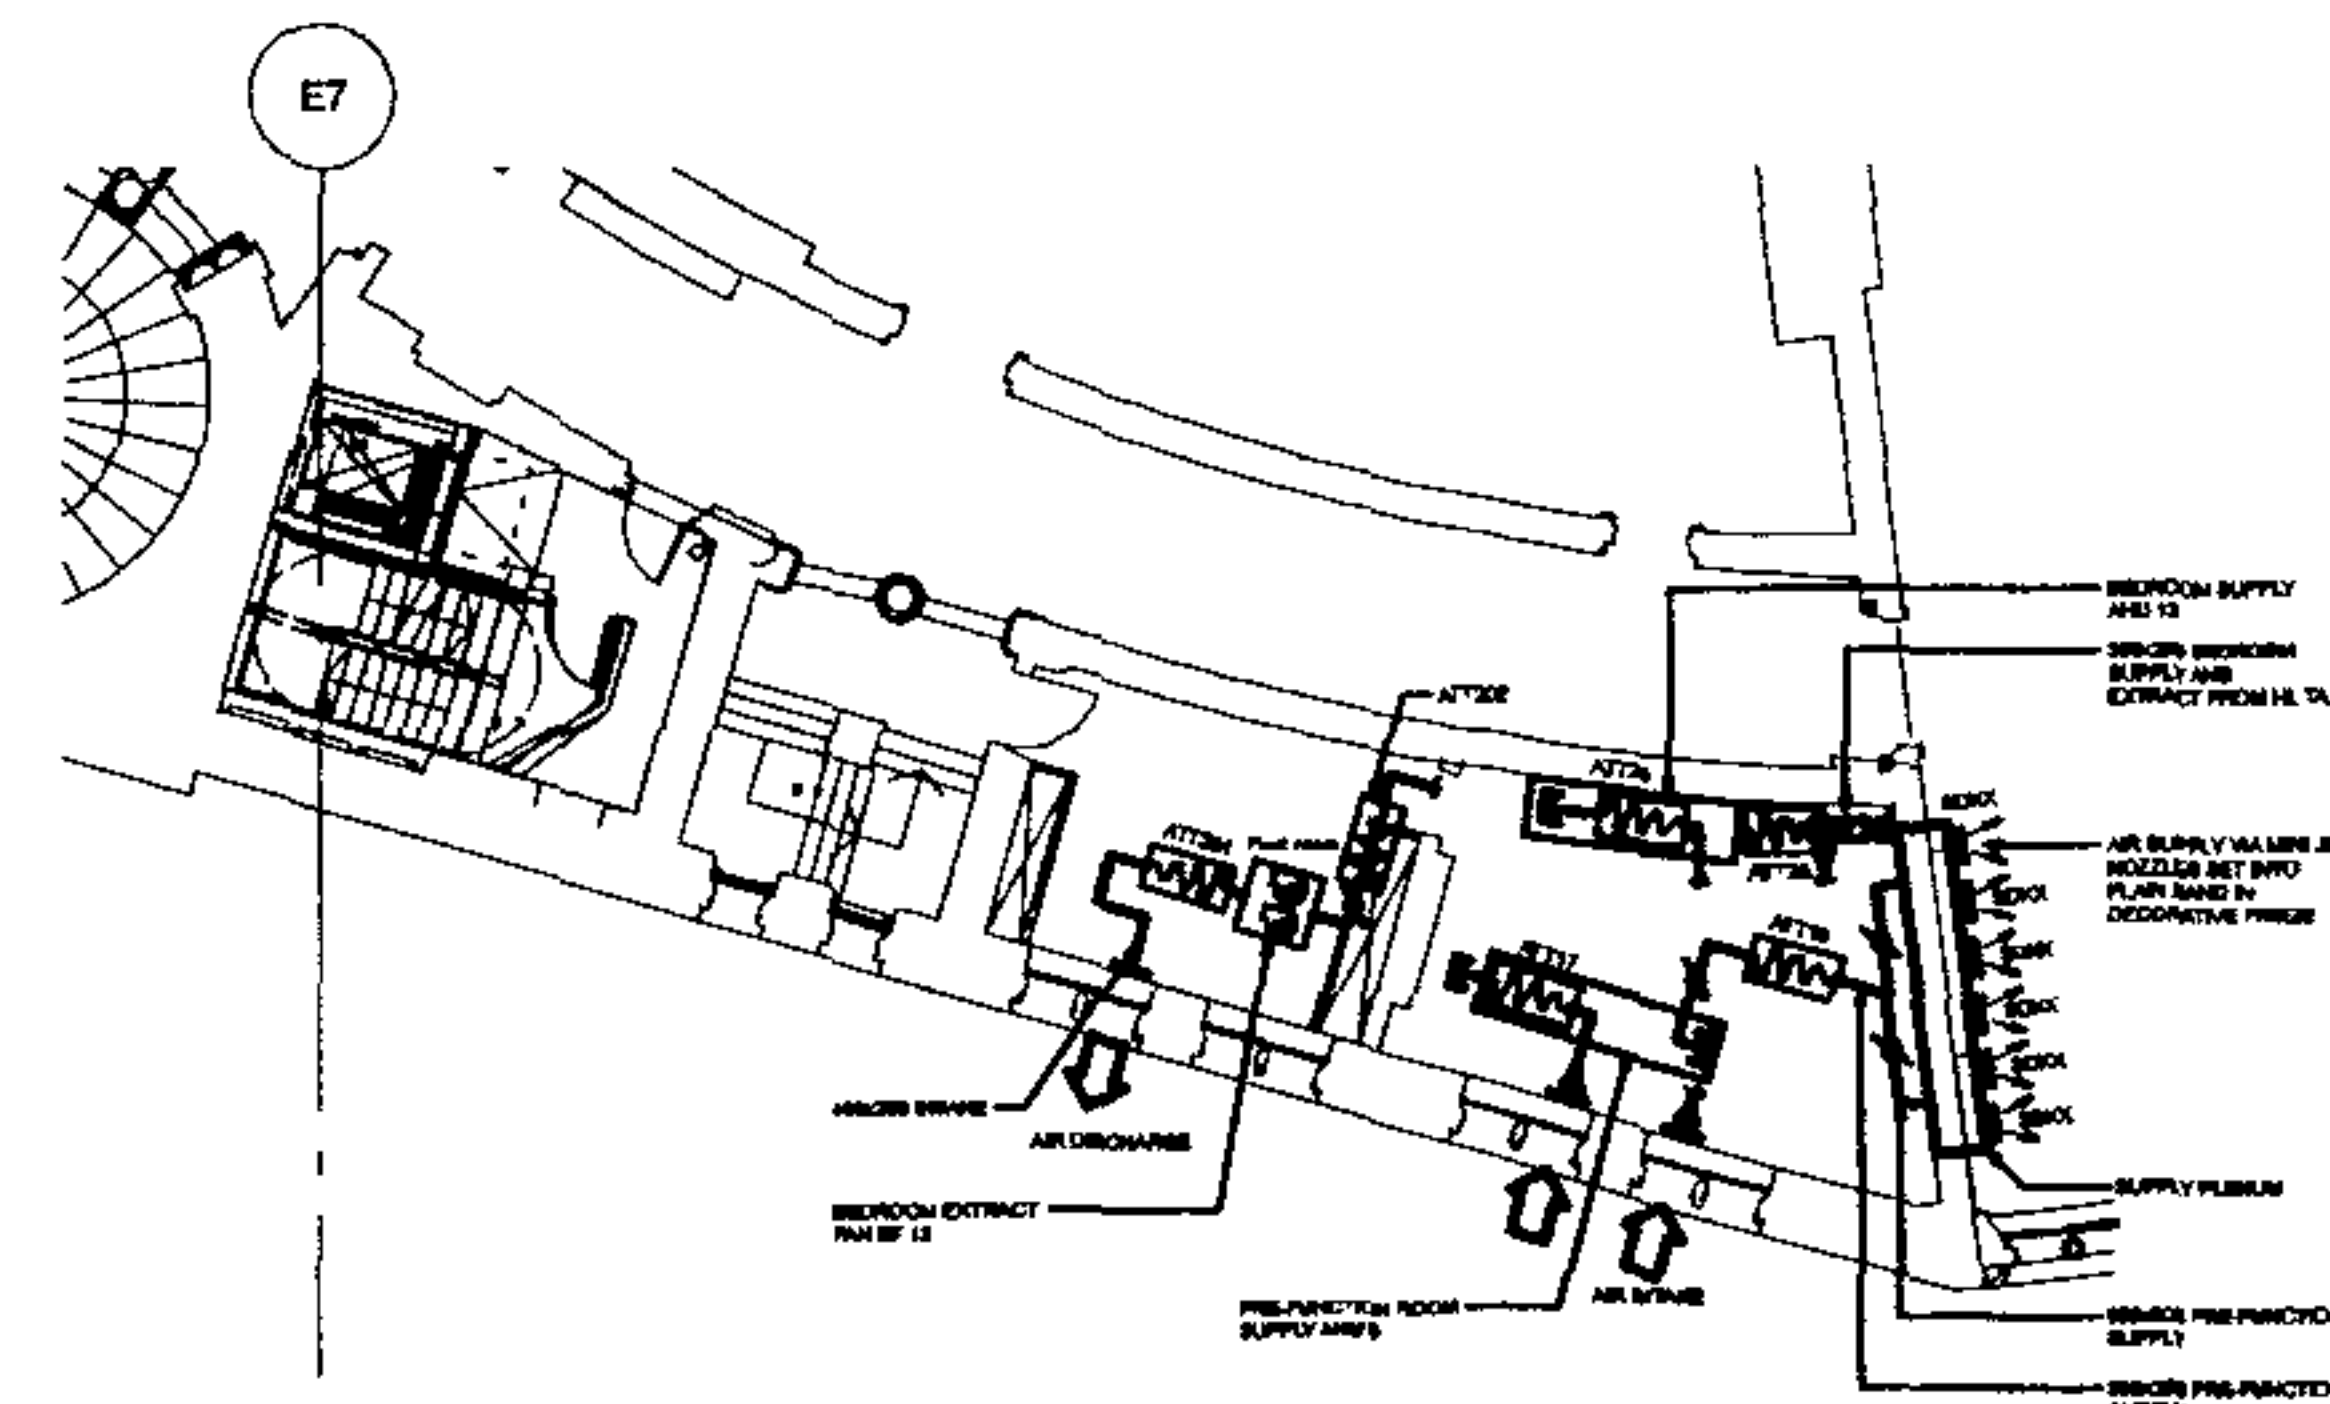

FIRST FLOOR MEZZANINE

Architect
RHAWL Architects
and
RICHARD GRIFFITHS ARCHITECTS
77 Bond Street, London WC2N 6BE
T. 01-583 9600 F. 01-583 9606

Client
**Manhattan Loft
Corporation Limited**

Project	St Pancras Chambers
---------	---------------------

**WEST CHAMBERS
FIRST FLOOR
VENTILATION
LAYOUT**
Sheet 1 of 2

Made	SC	C.A.D.	J.Z.
CYD		Scale	1:100
App.	D.T.E.	Date	MAY 01

FABER MALINSELL | AECO

Northrup Grumman Corp.	Y +0.6	12/10/94	12/10/94
Northrup Grumman Corp.	Y +0.6	12/10/94	12/10/94

10/1/2011 10:11 AM

NO. 23101/DDMW213/1

Page 100-00000000

NOTES

- [illegible]

FOR CONTINUATION REFER TO DRG No. 23101/DD/PH/303

FOR CONTINUATION REFER TO DRG. NO. 23101/DD/PH/203/2

E7

E7

FIRST FLOOR MEZZANINE

TENDER DRAWING

Architect
RHWL Architects
and
RICHARD GRIFFITHS ARCHITECTS
77 Delft Street London WC2E 8EZ
T 020 7293 7000 F 020 7293 0001

Client
Manhattan Loft
Corporation Limited

Project

St Pancras Chambers

WEST CHAMBERS
FIRST FLOOR
PUBLIC HEALTH
SERVICES LAYOUT
sheet 1 of 2

Made	B. U.	C.A.D.	AD
Ch'd	mech	elec	ph. Bu
App	CFD	Date	MAY 10


FABER MAUNSELL | AECOM

IN: 23101/DD/PH/203/1

NOTE

WHERE INDICATED SERVICES DISTRIBUTION WITHIN EACH ROOM ARE BASED ON SCHEME DESIGN LAYOUTS. FINAL LAYOUTS TO BE AGREED.

WITHIN OTHER AREAS FINAL SERVICES DISTRIBUTION PROPOSALS WITHIN ROOM TO BE CONFIRMED

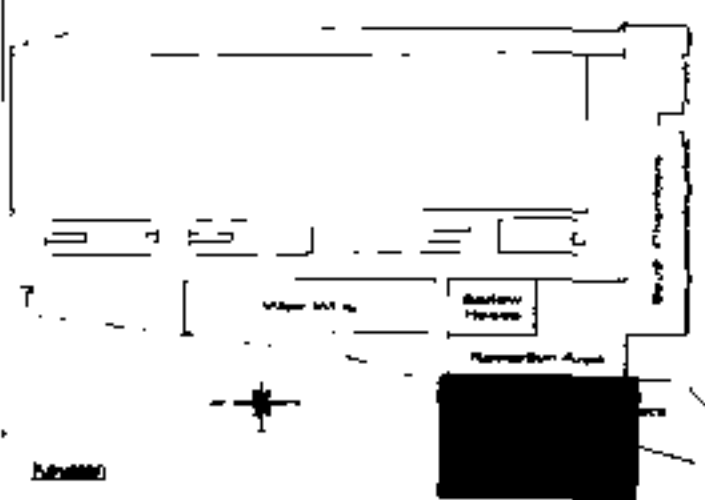


BASE DRAWINGS

USED IN COMPLETION OF THIS DRG

NOTES

- 1. WORK TO BE DONE BY OTHERS ONLY
- 2. THIS DRAWING TO BE READ IN CONJUNCTION WITH ALL RELEVANT SPECIFICATIONS AND STRUCTURAL DRAWINGS
- 3. THIS DRAWING TO BE READ IN CONJUNCTION WITH ALL RELEVANT PLUMBING, MECHANICAL, ELECTRICAL, AND SANITARY DRAWINGS
- 4. THIS DRAWING TO BE READ IN CONJUNCTION WITH ALL RELEVANT SCHEMATIC DRAWINGS
- 5. FOR TYPICAL DETAILS REFER TO DRAWING No. 23101/00/00/00/00
- 6. MAIN CORRIDORS FROM R/W, DOOR IN 2 COR. DRIP TRAY TO NEAREST FLOOR LEVEL

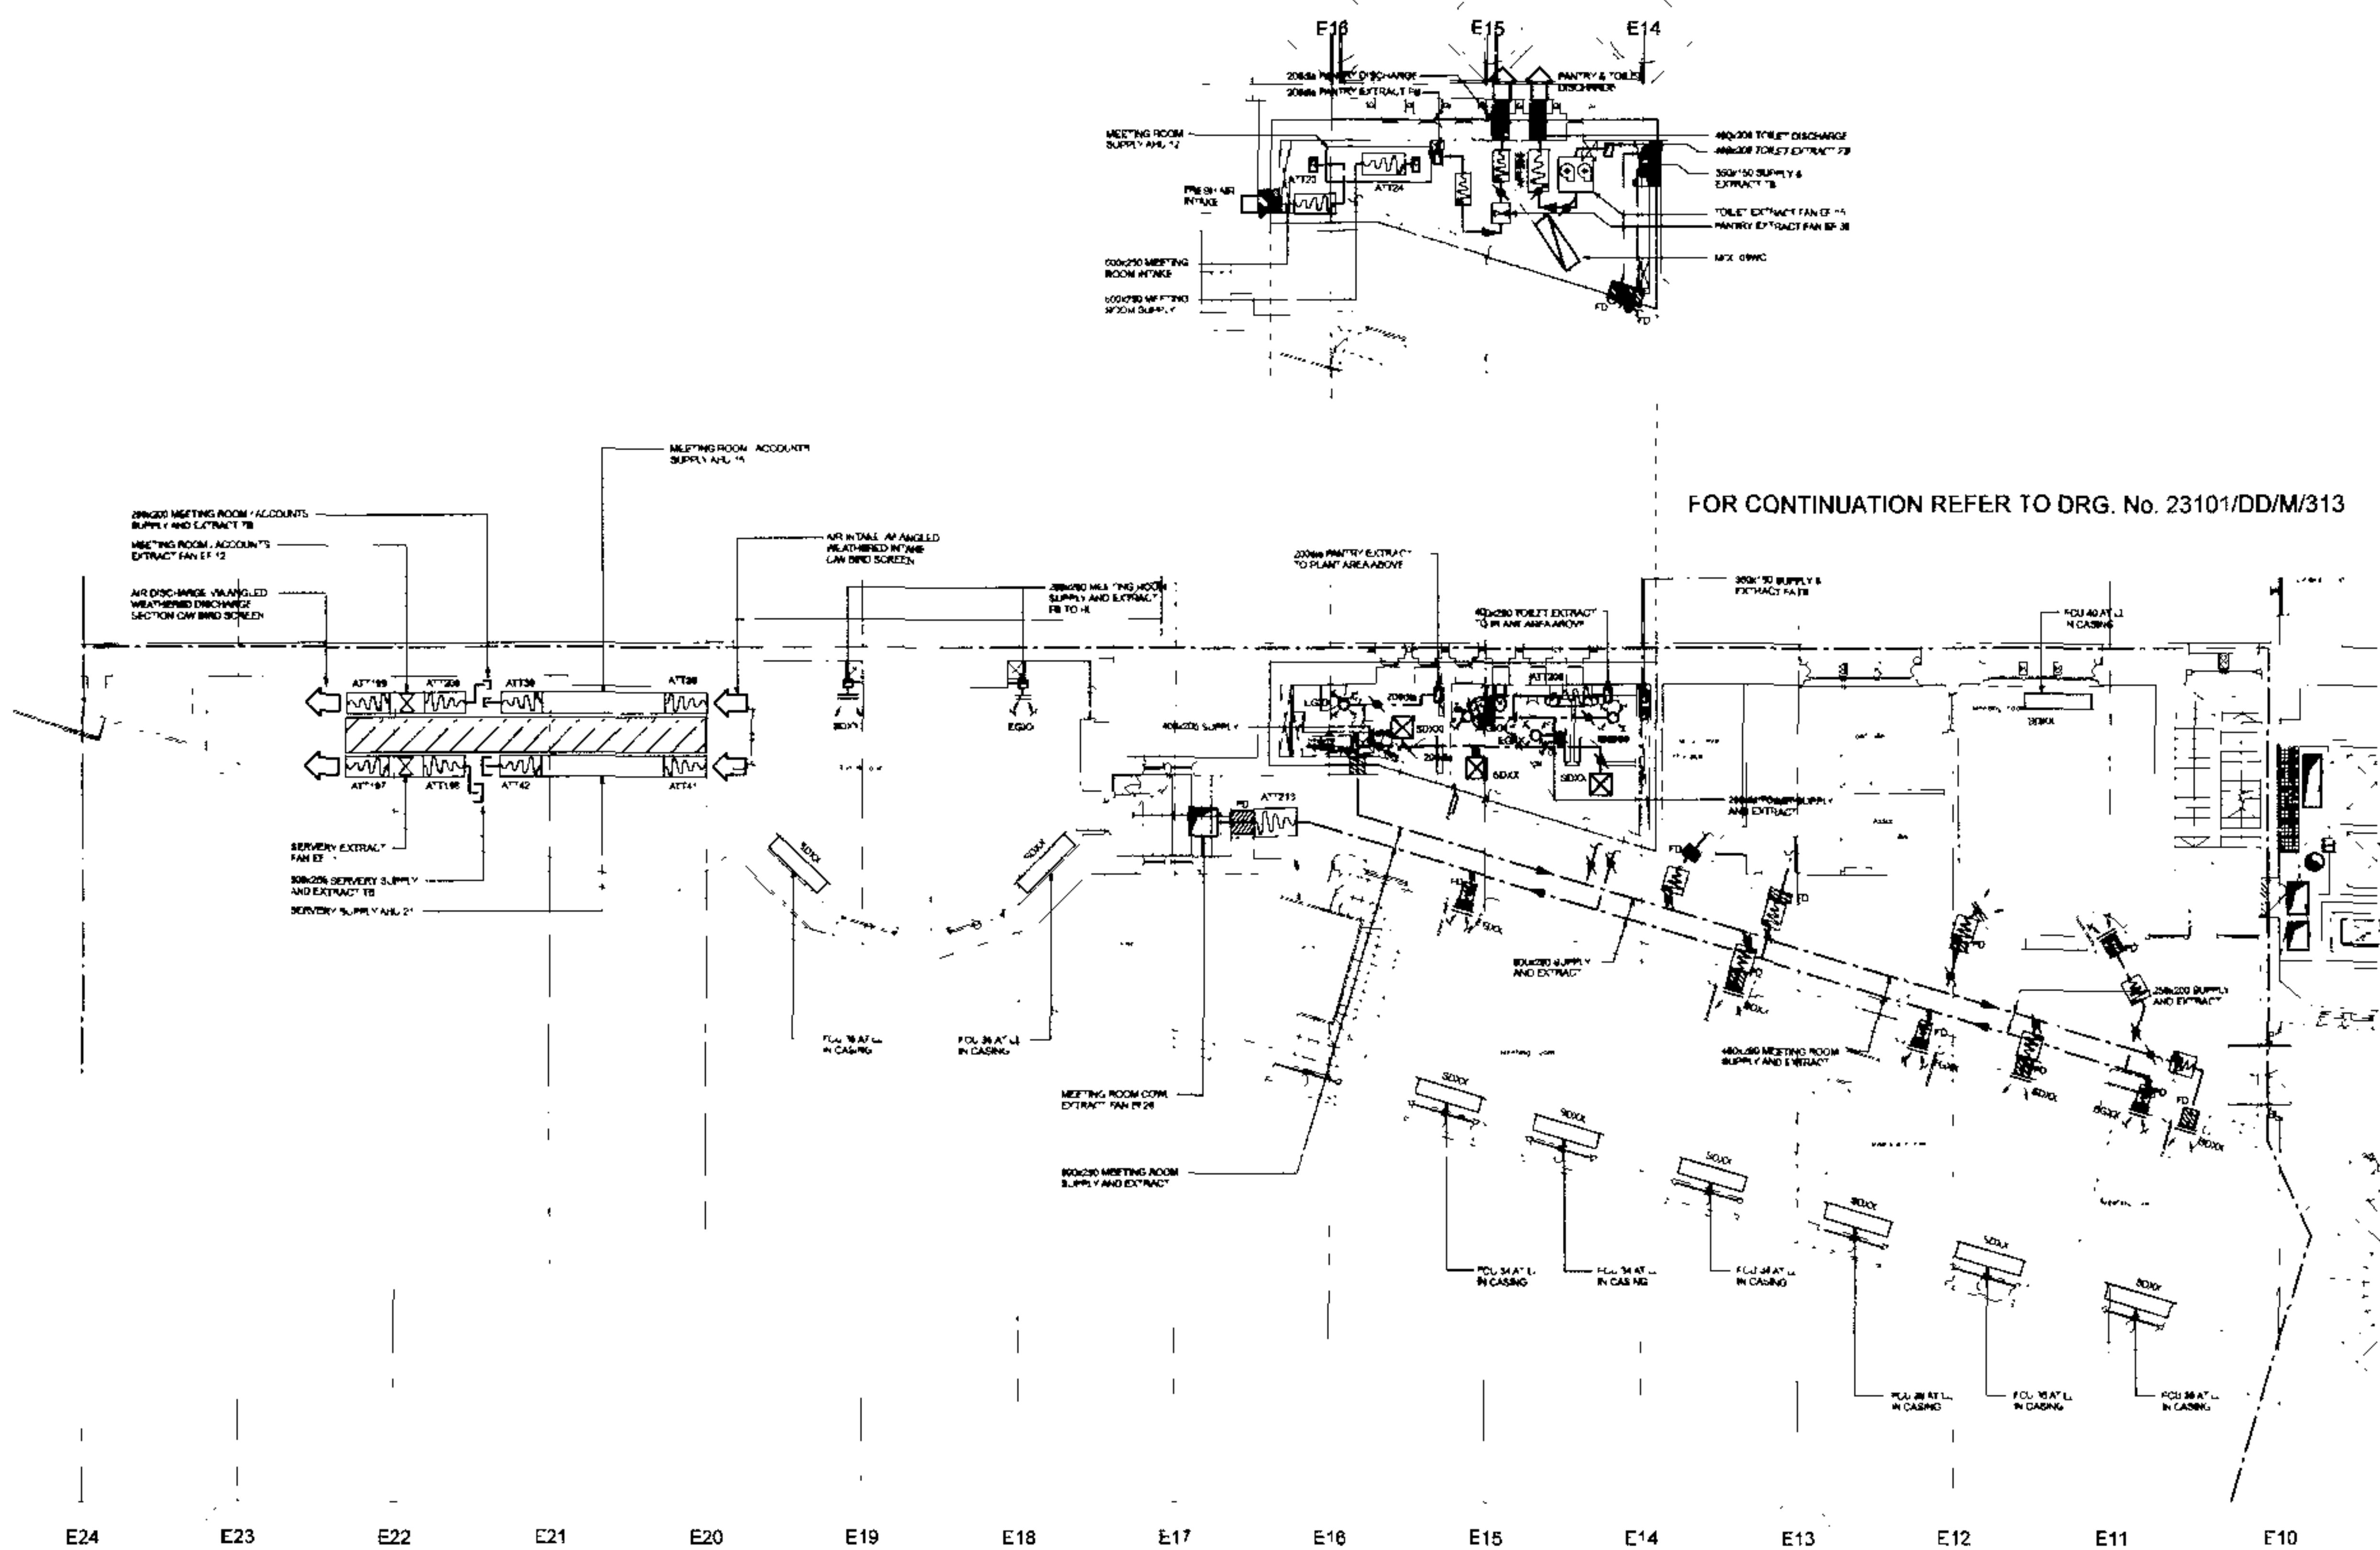

FOR CONTINUATION REFER TO DRG. No. 23101/DD/M/313

FOR CONTINUATION REFER TO DRG. No. 23101/DD/M/213/1

TENDER DRAWING

Architect
RHWL Architects
RICHARD GRUFFITHS ARCHITECTS
11, Canal Street, London E14 6AE
Tel: 020 7553 1000 Fax: 020 7553 1001

Client
Manhattan Loft Corporation Limited

Project
St Pancras Chambers

Title
WEST CHAMBERS
FIRST FLOOR
VENTILATION
LAYOUT
Sheet 2 of 2

Made SC C.A.D. J.F.
App. D.T. Scale 1:100
Date MAY 05

FABER MAUNSELL AECOM
Faber Maunsell
1, The Quadrant, London E1 1JY
Tel: 020 7553 1000 Fax: 020 7553 1001

23101/DD/M/213/2 0

FOR CONTINUATION REFER TO DRG. No. 23101/DD/FP/202/2

FOR CONTINUATION REFER TO DRG. No. 23101/DD/FP/302



BASE DRAWINGS

USED IN COMPLETION OF THIS DRG

NOTES

1. NOTES TO INCLUDE DIMENSIONS ONLY
2. THIS DRAWING TO BE READ IN CONJUNCTION WITH ALL RELEVANT ARCHITECTURAL AND STRUCTURAL ENGINEERING DRAWINGS
3. THIS DRAWING TO BE READ IN CONJUNCTION WITH ALL RELEVANT TENDER DOCUMENTS
4. THIS DRAWING TO BE READ IN CONJUNCTION WITH RELEVANT SCHEDULED DRAWINGS
5. THESE DRAWINGS INDICATE MAIN PIPEWORK ROUTING FOR SPRINKLER AND FIRE ALARM SYSTEMS. LOCATIONS TO BE DEVELOPED WITH SPECIALIST TENDERS FOR CONTINUAL

STATUS

TENDER
DRAWING

ARCHITECT

RHWL Architects
RICHARD GRIFITHS ARCHITECTS
100 West Street, London EC2A 3DF
T: 020 779 8888 F: 020 779 8889

CLIENT

Manhattan Loft
Corporation Limited

PROJECT

St Pancras Chambers

TITLE

WEST CHAMBERS
PLATFORM LEVEL
FIRE PROTECTION
LAYOUT
sheet 1 of 4 LOW LEVEL

MADE


PL C.A.D. PL
C.V.S. D.T.E. Scale 1:100
App. Date MAY 06

FABER MAUNSELL

AECOM
Faber Maunsell & Partners
100 West Street, London EC2A 3DF
T: 020 779 8888 F: 020 779 8889

NO.


23101/DD/FP/202/1 0

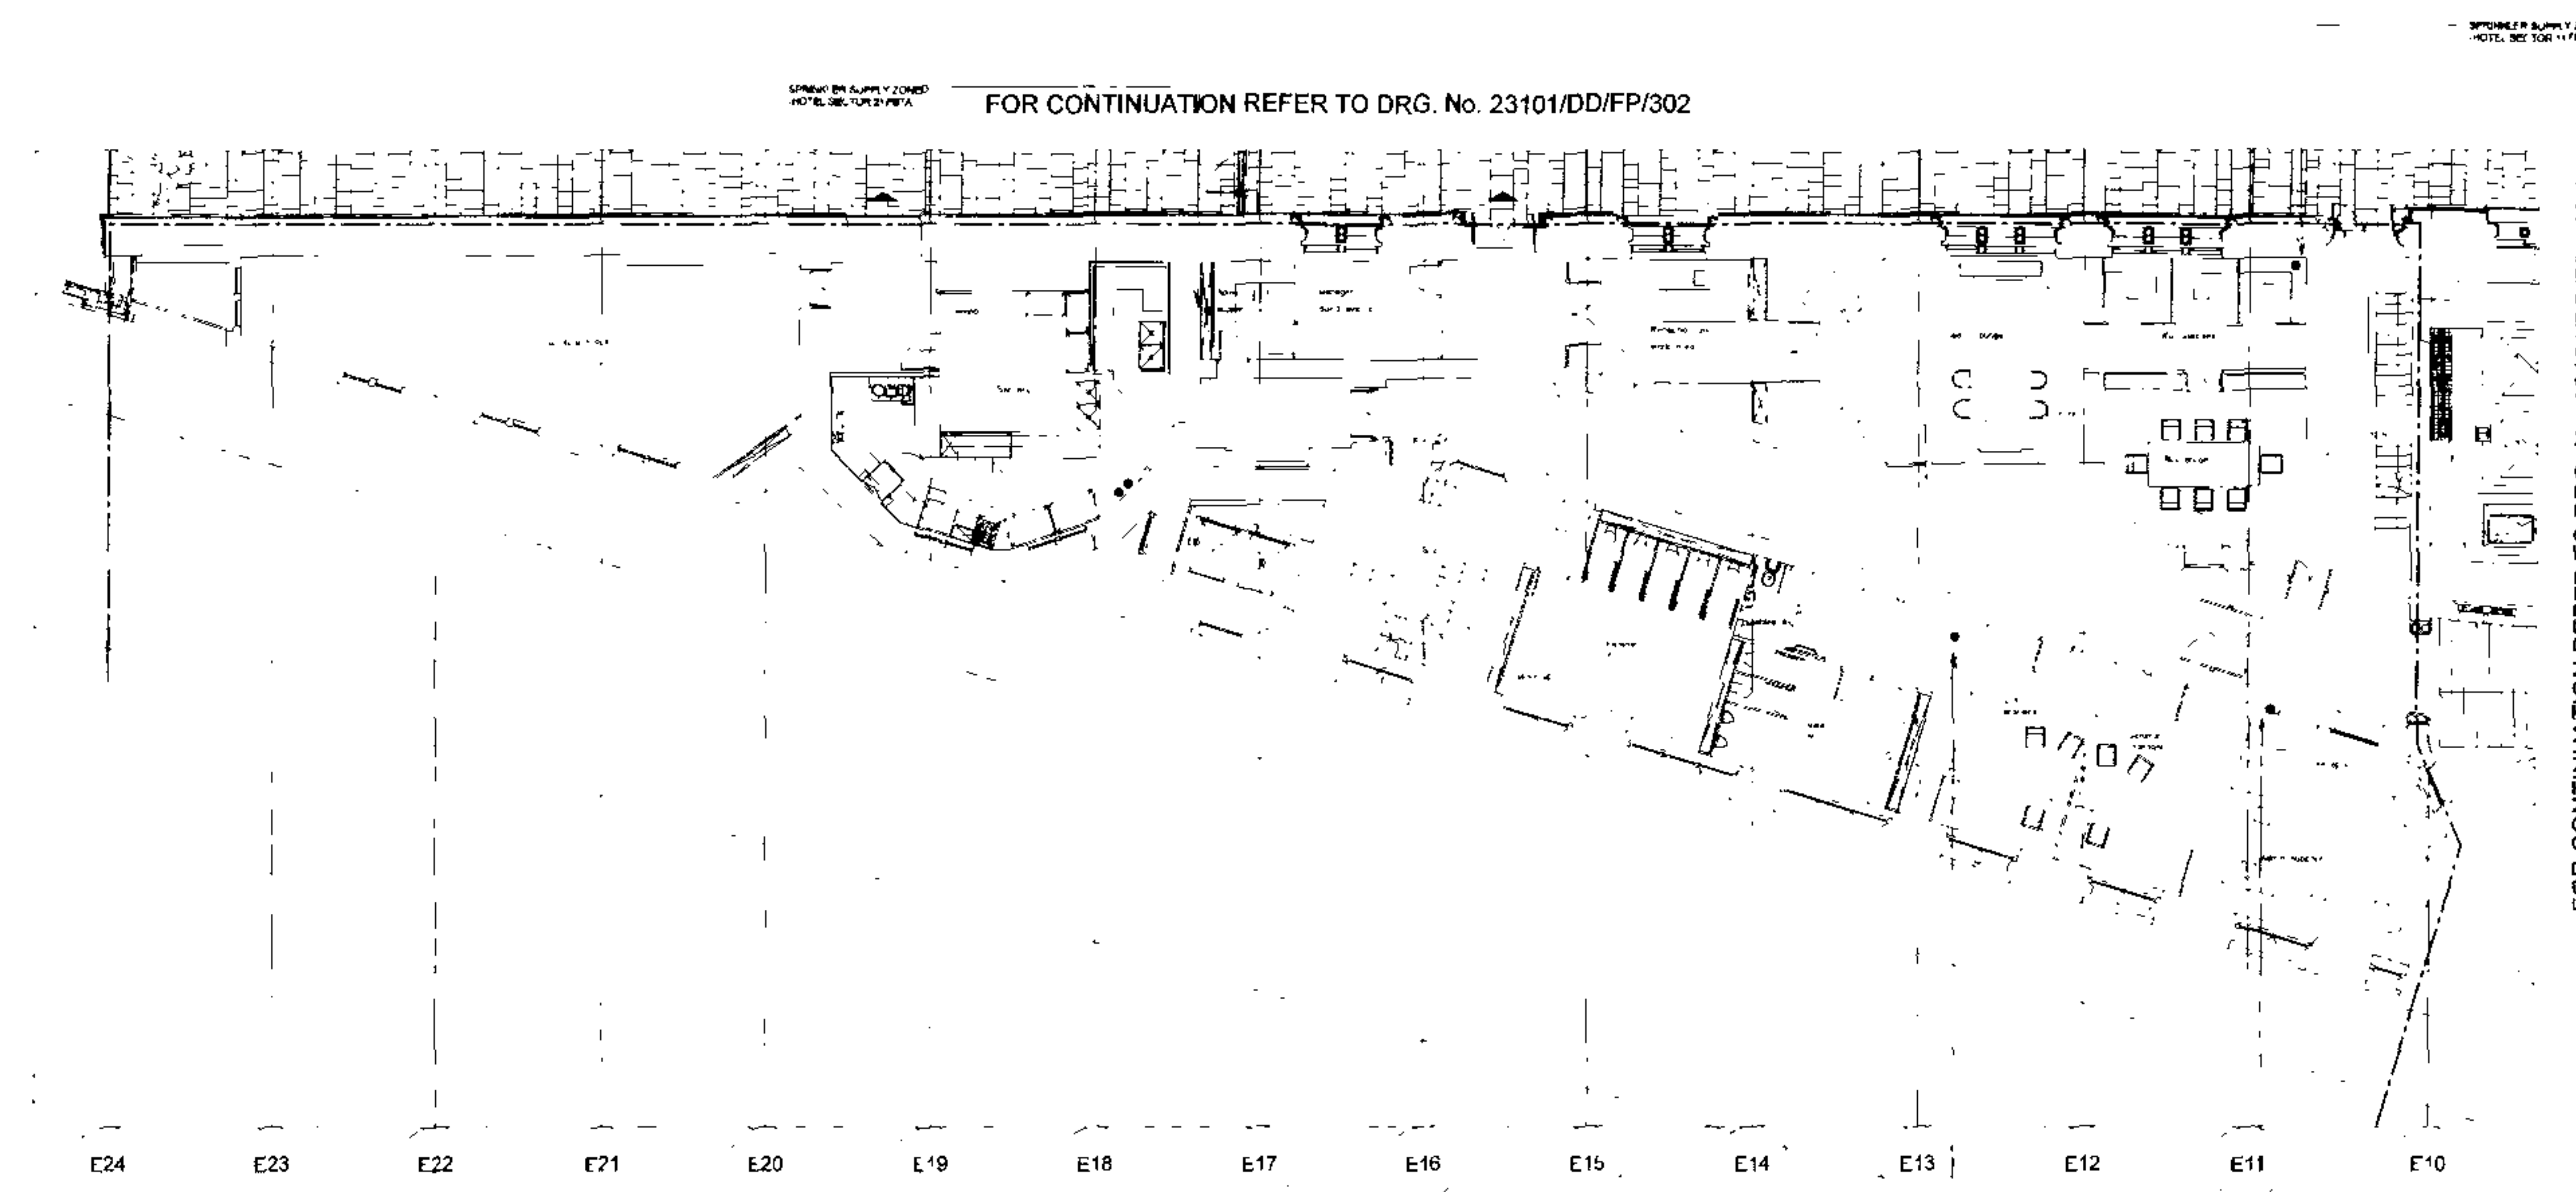

PLATFORM LOW LEVEL



PLATFORM MEZZANINE LOW LEVEL

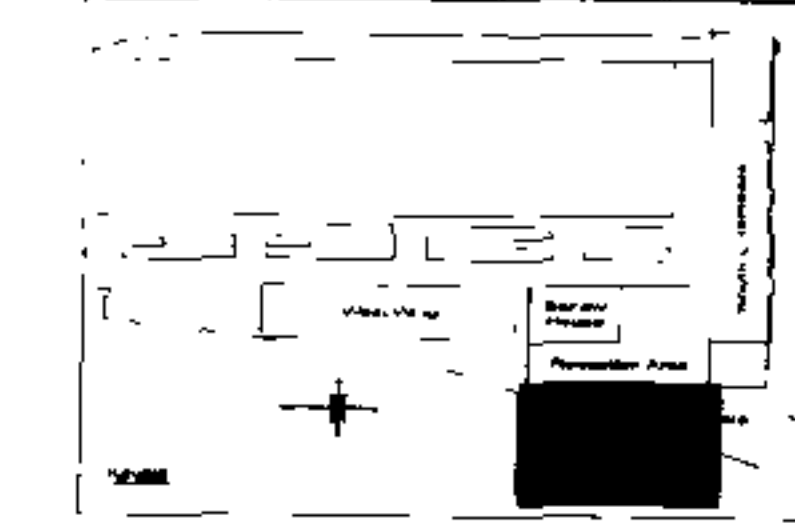


BASE DRAWINGS
SHALL BE COMPLETED BY THE DRG

NOTES


1. WORK TO FOLLOW DIMENSIONS ONLY
2. THIS DRAWING TO BE READ IN CONJUNCTION WITH ALL RELEVANT ARCHITECTURAL AND STRUCTURAL DRAWINGS
3. THIS DRAWING TO BE READ IN CONJUNCTION WITH ALL RELEVANT FABRIC MAINTENANCE DRAWINGS
4. THIS DRAWING TO BE READ IN CONJUNCTION WITH RELEVANT SCHEMATIC DRAWINGS
5. THESE DRAWINGS INDICATE SPRINKLER WORKING HOUSING FOR SPRINKLER SYSTEMS. SPRINKLER HEAD LOCATIONS TO BE DETERMINED WITH SPECIALIST SPRINKLER CONSULTANT

No.	Date	Details	Revised	Chk	App
TENDER DRAWING					
Architect RHWL Architects and RICHARD GRIFFITHS ARCH-TELCTS 1, Lomb Street, London EC6A 3LL Tel: 020 779 1999 • Fax: 020 779 1999					
Client Manhattan Loft Corporation Limited					
Project St Pancras Chambers					
Title WEST CHAMBERS PLATFORM AND MEZZANINE FIRE PROTECTION LAYOUT sheet 2 of 4 LOW LEVEL					
Make	PI	C.A.D.	PI		
CHKD	DRG	APP	APP	Scale	1:100
App:	DTE	Date	MAY 06		
FABER MAUNSELL AECOM					
Headquarters: Faber Maunsell 1, Lomb Street, London EC6A 3LL Tel: 020 779 1999 • Fax: 020 779 1999 www.fabermaunsell.com					
7-111 020 879 0794 7-111 020 879 0794 www.fabermaunsell.com					
No. 23101/DD/FP/202/2					
0					

FOR CONTINUATION REFER TO DRG No. 23101/DD/FP/302

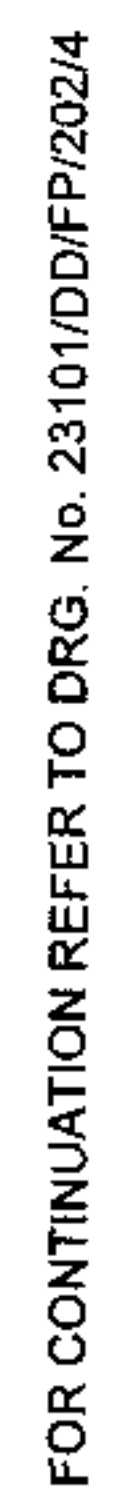

PLATFORM LEVEL
HIGH LEVEL

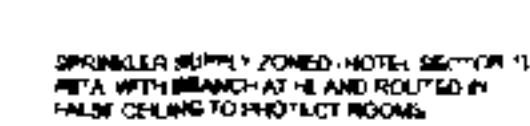

PLATFORM MEZZANINE

Project	Client	Contract	Rev	Page
TENDER DRAWING				
Architect RHWL Architects RICHARD GRAY LITTLE ARCHITECTS 7 West Street, 4th Floor, NYC, NY 10038 Tel: 212 768 1100 Fax: 212 768 1101				
Owner Manhattan Loft Corporation Limited				
Project St Pancras Chambers				
Title WEST CHAMBERS PLATFORM LEVEL FIRE PROTECTION LAYOUT sheet 3 of 4 HIGH LEVEL				
Made Ck'd App	PL 2000 DTE	C.A.D. Scale Date	PL 1:100 MAY 08	
FABER MAUNSELL AECOM				
Metropolitan Region Upper Manhattan Planning 100 West Street, 10th Floor, New York, NY 10038		Tel: 212 663 2700 Fax: 212 663 2701 Email: info@fma.com www.fma.com		
No				
23101/DD/FP/202/3 0				