



FOR CONTINUATION REFER TO DRG. No. 23101/DD/E/302

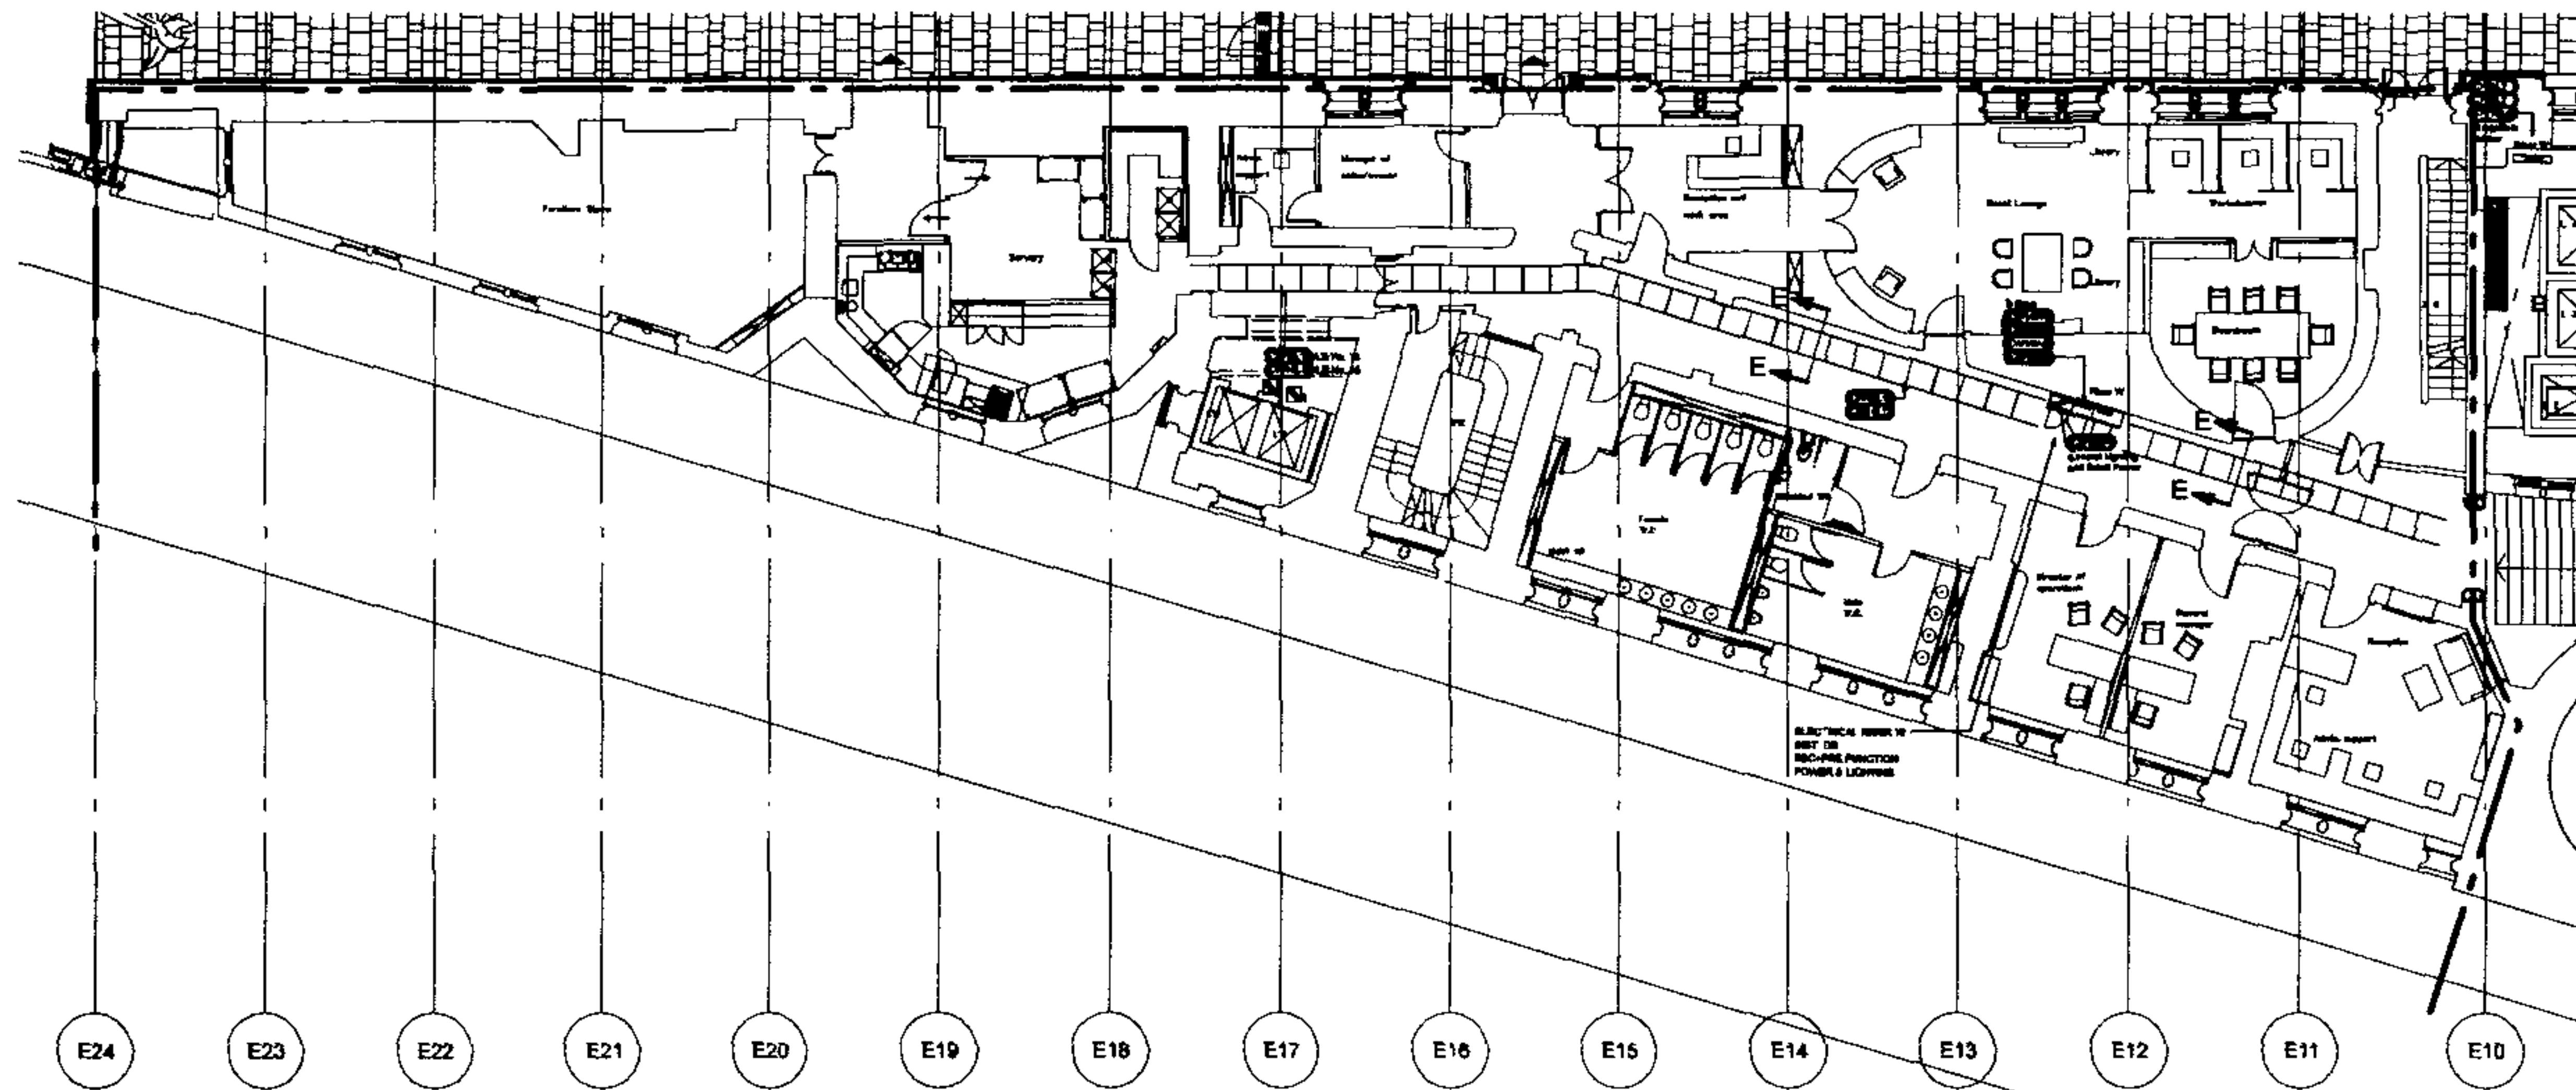

FOR CONTINUATION REFER TO DRG. No. 23101/DD/E/202/1


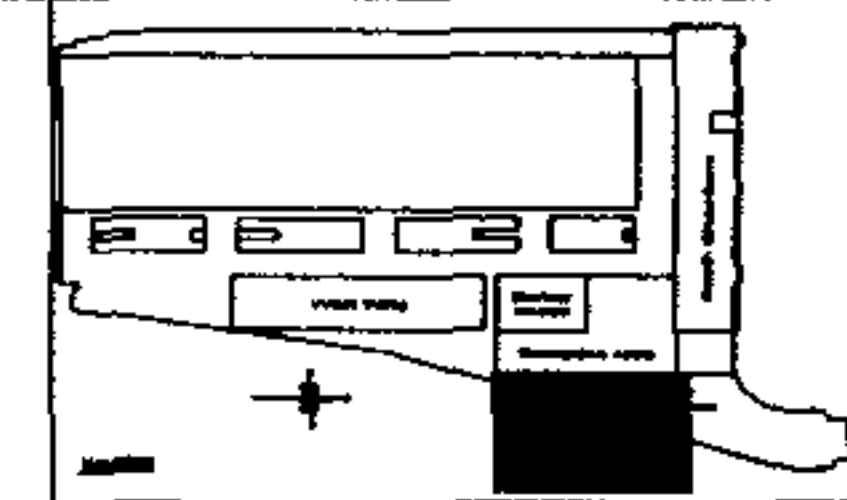


BASE DRAWINGS

BASE IS COMPLETION OF THIS DATE
10/10/10, 10/10/10, 10/10/10
10/10/10, 10/10/10, 10/10/10
10/10/10, 10/10/10, 10/10/10

NOTES

1. REFER TO PREVIOUS DRAWINGS ONLY
2. THIS DRAWING TO BE USED IN CONJUNCTION WITH ALL PREVIOUS DRAWINGS AND SPECIFICATIONS
3. THIS DRAWING TO BE USED IN CONJUNCTION WITH ALL PREVIOUS DRAWINGS AND SPECIFICATIONS
4. THIS DRAWING TO BE USED IN CONJUNCTION WITH ALL PREVIOUS DRAWINGS AND SPECIFICATIONS
5. FOR MORE DETAILS REFER TO DRG. No. 23101/DD/E/202/1 AND 23101/DD/E/202/2

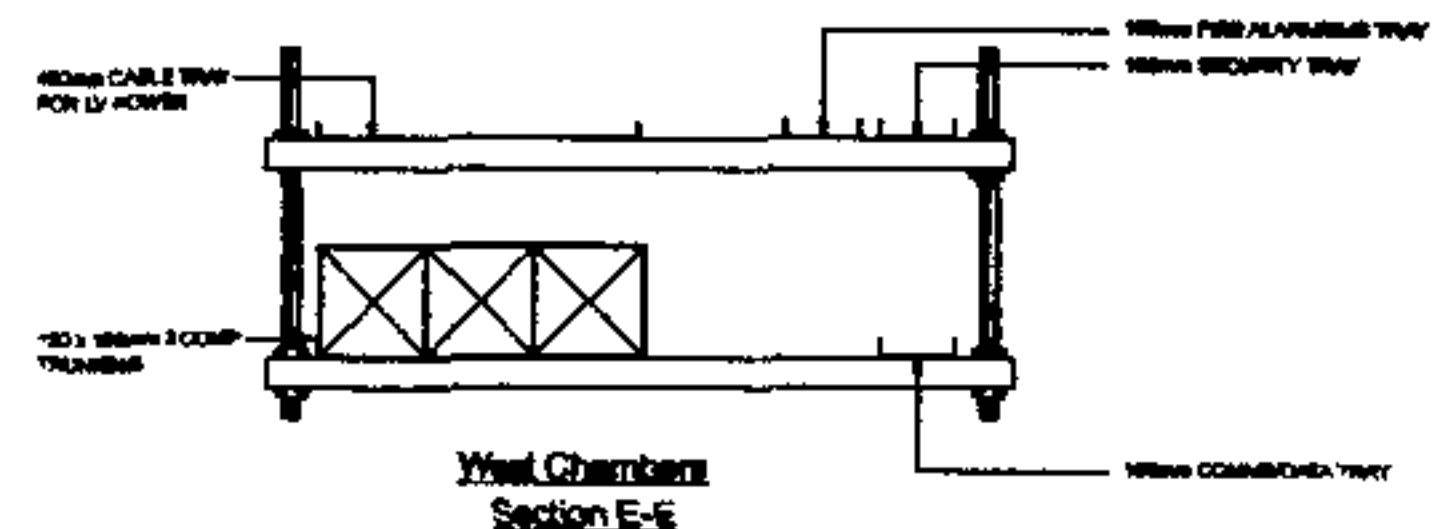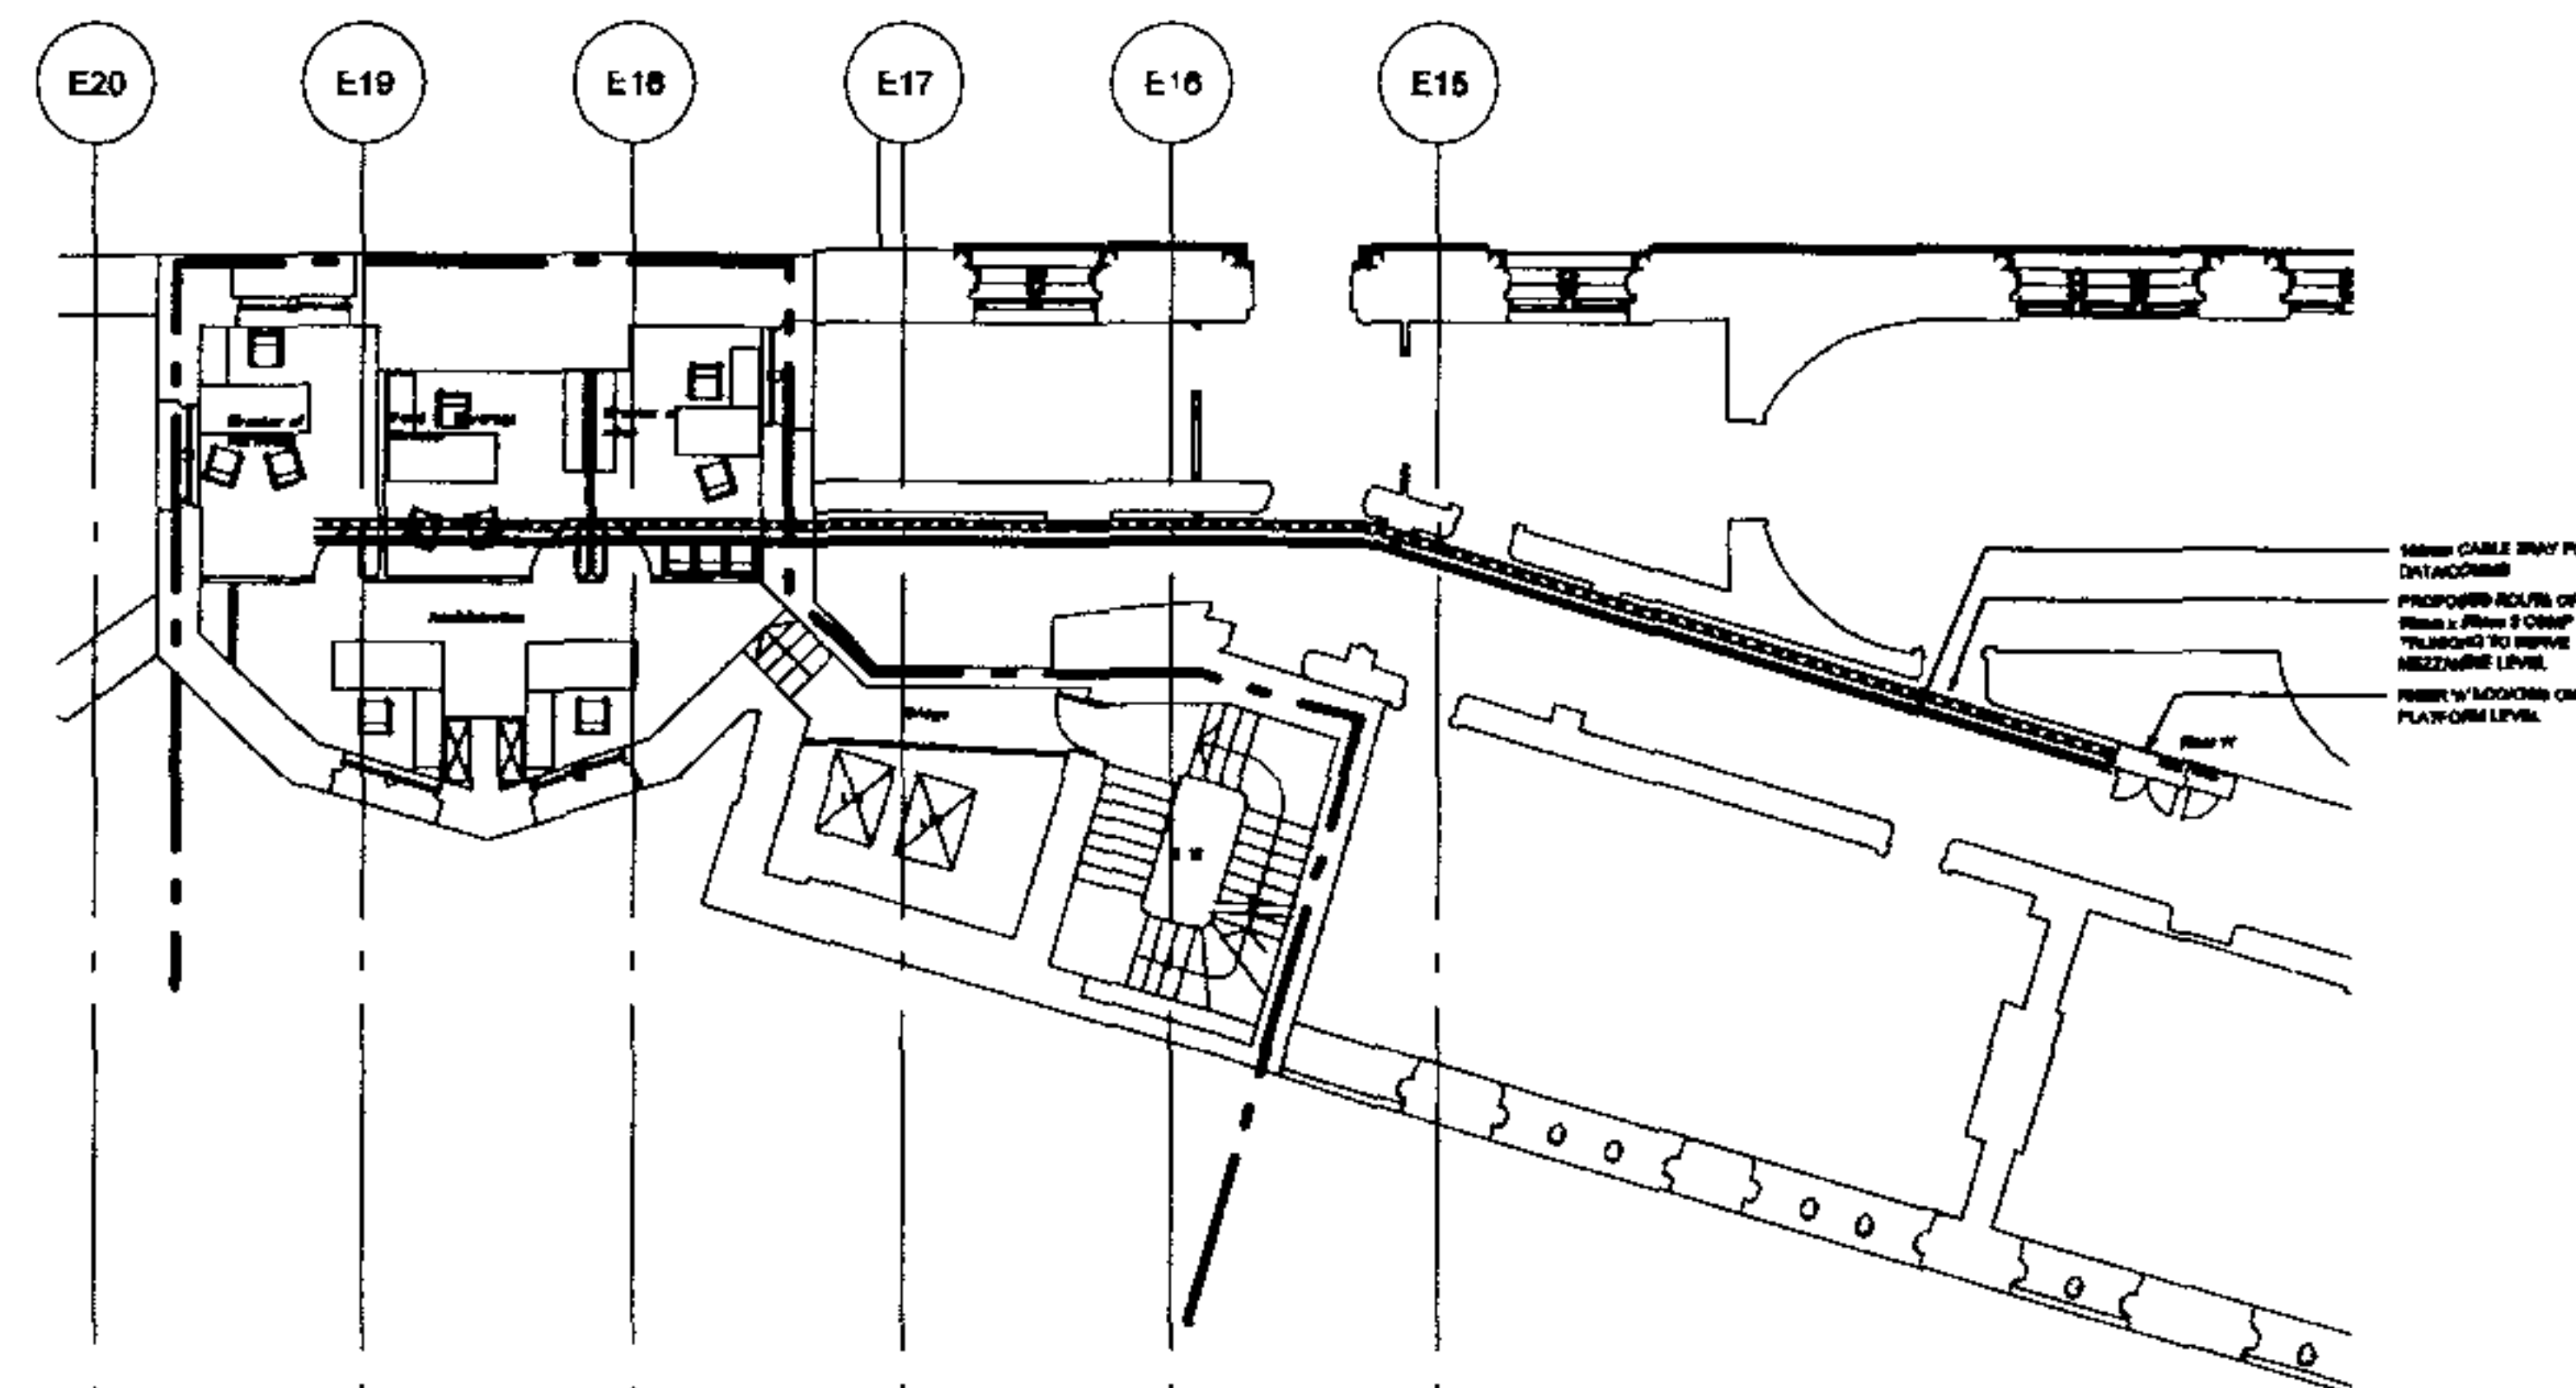

TENDER DRAWING

Architect
RHWL Architects
RICHARD GRIMPHYS ARCHITECTS
77 Great Street, London, EC1A 3JF
T: 020 7463 4444 F: 020 7463 4445

Client
Manhattan Loft
Corporation Limited

Project
St Pancras Chambers

Title
WEST CHAMBERS
PLATFORM & MEZZ.
ELECTRICAL DISTRIBUTION
LAYOUT
sheet 2 of 2

Made R.T.G. C.A.D. P.C.
C.V.G. Scale 1:100
App. S.P. Date 10/10/10

FABER MAUNSELL AECOM
100, 101, 102, 999, 1000

N 23101/DD/E/202/2 0

This is a technical site plan or map, possibly a military installation or industrial complex. The drawing is oriented with North at the top. A large, irregularly shaped area is shaded with diagonal lines, possibly indicating a restricted zone or a specific terrain feature. The drawing shows various buildings, roads, and infrastructure. A scale bar is visible in the upper right corner. The drawing is labeled with 'E10', 'E9', 'E8', and 'E7' along the bottom edge.

E10	E9	E8	E7
-----	----	----	----

10104_02 GA 02 nov 2	stop clinic
02 10104_02 GA 02 nov 2	giving & the above
10104_02 GA 02 nov 2	floor plan
02 10104_02 GA 02 nov 2	lighting & the above

1. WORK TO SQUARED DIMENSIONS ONLY
2. THIS DRAWING TO BE READ IN CONJUNCTION WITH ALL RELEVANT ARCHITECTS AND STRUCTURAL ENGINEER'S DRAWINGS
3. THIS DRAWING TO BE READ IN CONJUNCTION WITH ALL RELEVANT FINDER MINORIAL DRAWINGS
4. THIS DRAWING TO BE READ IN CONJUNCTION WITH ALL SCHEMATIC DRAWINGS


DESIGNS AREAS TO BE DESIGNED
BY A DESIGN SPECIALIST

Architect
RHWL Architects
and
RICHARD GRIFFITHS ARCHITECTS
7 Lehigh Street, Suite 400-50
• 400-727-7990 • Fax 763-6811


Project	St Pancras Chambers
---------	---------------------

Made	D.B.N			C.A.D.	D.B.N
Ck'd	month	year	pt	Scale	1:100
App	S.P			Date	MAY 06

Marlborough Finance
 Jacobs Marlborough Finance
 91 Albany, Marlborough, MA 01501
 T +44 (0)208 8784 5784
 F +44 (0)208 8784 5709
 www.jacobsmarbl.com

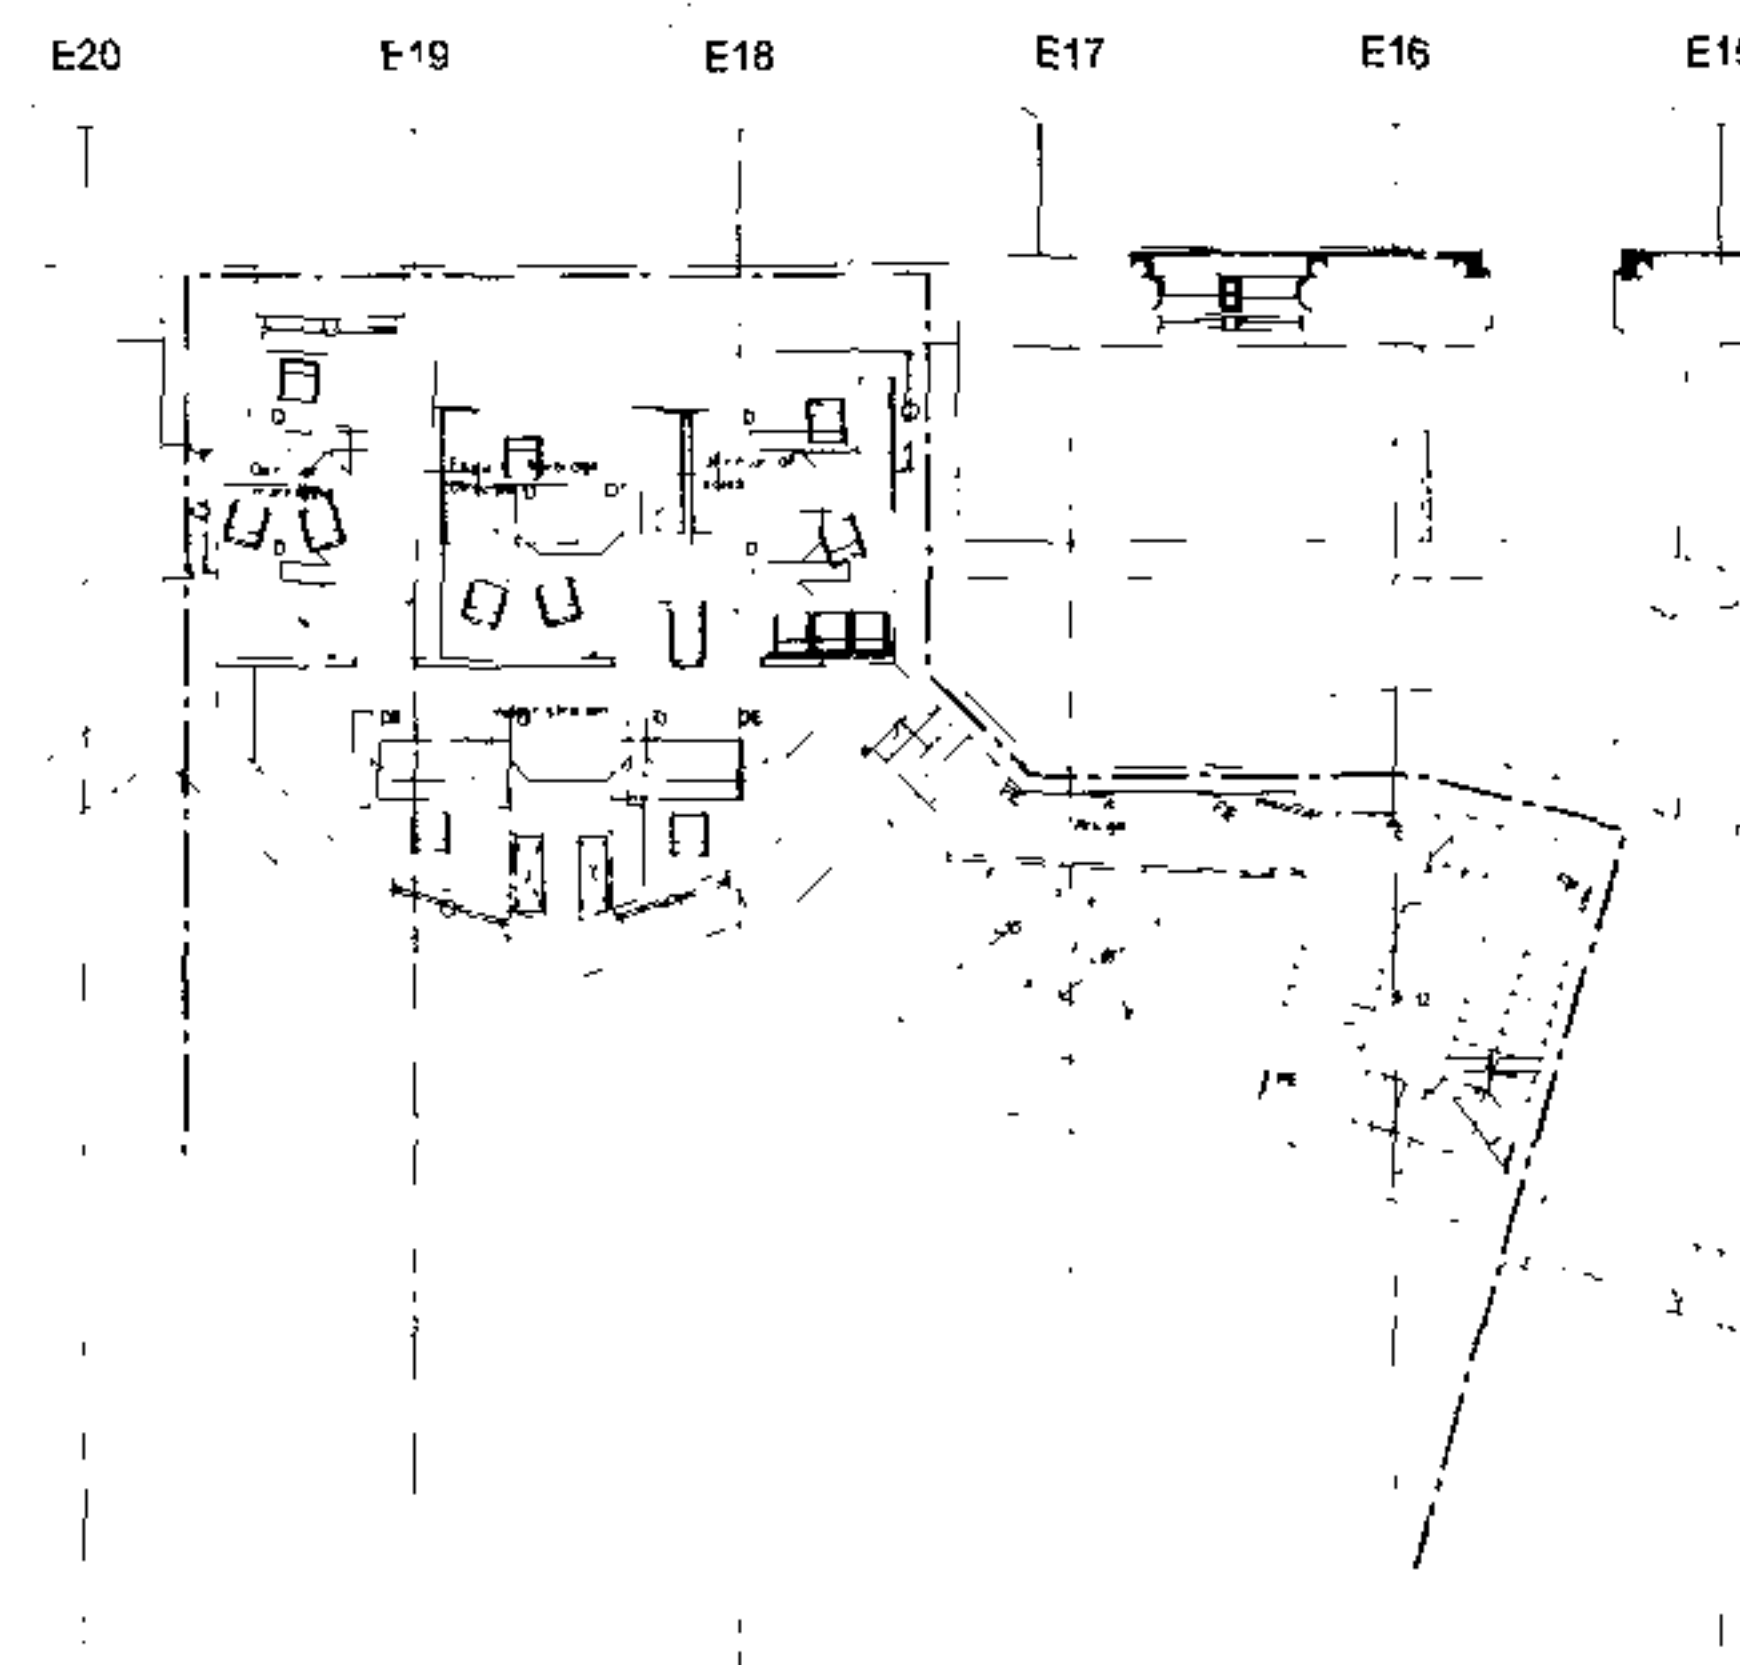

FOR CONTINUATION REFER TO DRG. No. 23101/DD/E/212/1

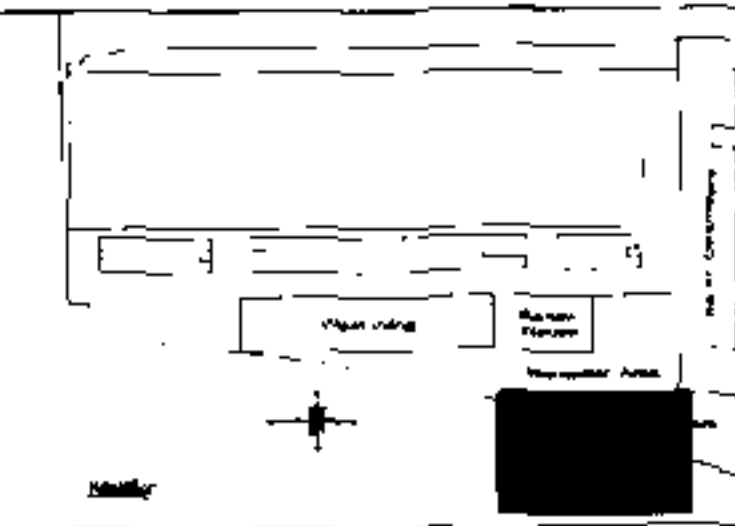

BASE DRAWINGS
USED IN COMPLETION OF THIS DRG
1. BASE & 2. ON 23101/DD/E/312
3. BASE & 2. ON 23101/DD/E/312
4. BASE & 2. ON 23101/DD/E/312
5. BASE & 2. ON 23101/DD/E/312

- NOTES
1. REFER TO RELATED DIMENSIONS ONLY
 2. THIS DRAWING TO BE USED BY CONSULTANT WITH ALL RELEVANT ARCHITECTS AND STRUCTURAL ENGINEERS DRAWINGS
 3. THIS DRAWING TO BE READ IN CONJUNCTION WITH ALL RELEVANT ARCHITECTURAL DRAWINGS
 4. THIS DRAWING TO BE READ IN CONJUNCTION WITH ALL RELEVANT ELECTRICAL DRAWINGS

DETAILS ARE TO BE DESIGNED BY LIGHTING SPECIALIST

Rev	Date	By	Check	App
Status				
TENDER DRAWING				
Architect RHWL Architects RICHARD GRIFFITHS ARCHITECTS 11 Great Street, London, EC2A 3DF 020 7739 1000 / 020 7739 4000				
Client Manhattan Loft Corporation Limited				
Project St Pancras Chambers				
Title WEST CHAMBERS PLATFORM & MEZZ. LIGHTING & FIRE ALARM LAYOUT sheet 2 of 2				
Made	RIG	CAD	D.B.N	
Drawn	RIG	Scale	1:100	
App	S.P	Date	MAY 06	
FABER MAUNSELL AECOM				
23101/DD/E/212/2				
0				

This architectural floor plan depicts the 1st floor of a building, likely a university campus. The plan is oriented with a grid system labeled E10 through E24 along the bottom edge. The building's layout includes several large, irregularly shaped rooms, some of which are labeled with numbers (e.g., 101, 102, 103, 897, 898

USED IN COMPLETION OF THIS LINE

99999_9_00_0A_00000000	Year 1999
000000_0000000000000000	Quarter 3
99999_9_00_0A_00000000	Year 1999
000000_0000000000000000	Quarter 3

1. WORK TO REQUIRED DIMENSIONS ONLY
2. USE INSTRUMENTS TO PREPARE IN CONJUNCTION WITH A
RELATIVE ARCHITECTURE AND STRUCTURAL ENGINEER
DRAWINGS.
3. USE INSTRUMENTS TO PREPARE IN CONJUNCTION WITH A
RELATIVE FIBER MANUFACTURING DRAWINGS.
4. USE INSTRUMENTS TO PREPARE IN CONJUNCTION WITH A
STRUCTURAL DRAWINGS.
5. SECURITY EQUIPMENT PROVIDED FOR COMPLEX
ON-SITE LOCATION AND POWER REQUIREMENTS TO BE
COMPLETED.
6. WHERE A SAFETY ISOLATOR IS INDICATED, A
FOR A SAFETY ISOLATOR IS INDICATED, A
FOR A SAFETY ISOLATOR IS INDICATED, A


DETAILS
 DEDUCTED EMPLOYEE IS SUPPLIED FROM LOCAL
 HIGH-SCHOOL GRAD. EMPLOYMENT BOARD.

REMOVES AIRCRAFT IS SUPPLIED FROM LOCAL
REVENUE CONTRIBUTION BOARD

DANONE BONDANT TYPE 1

NOTE
CONTENTS CONTINUE FROM 2

THE UNIVERSITY OF CHICAGO

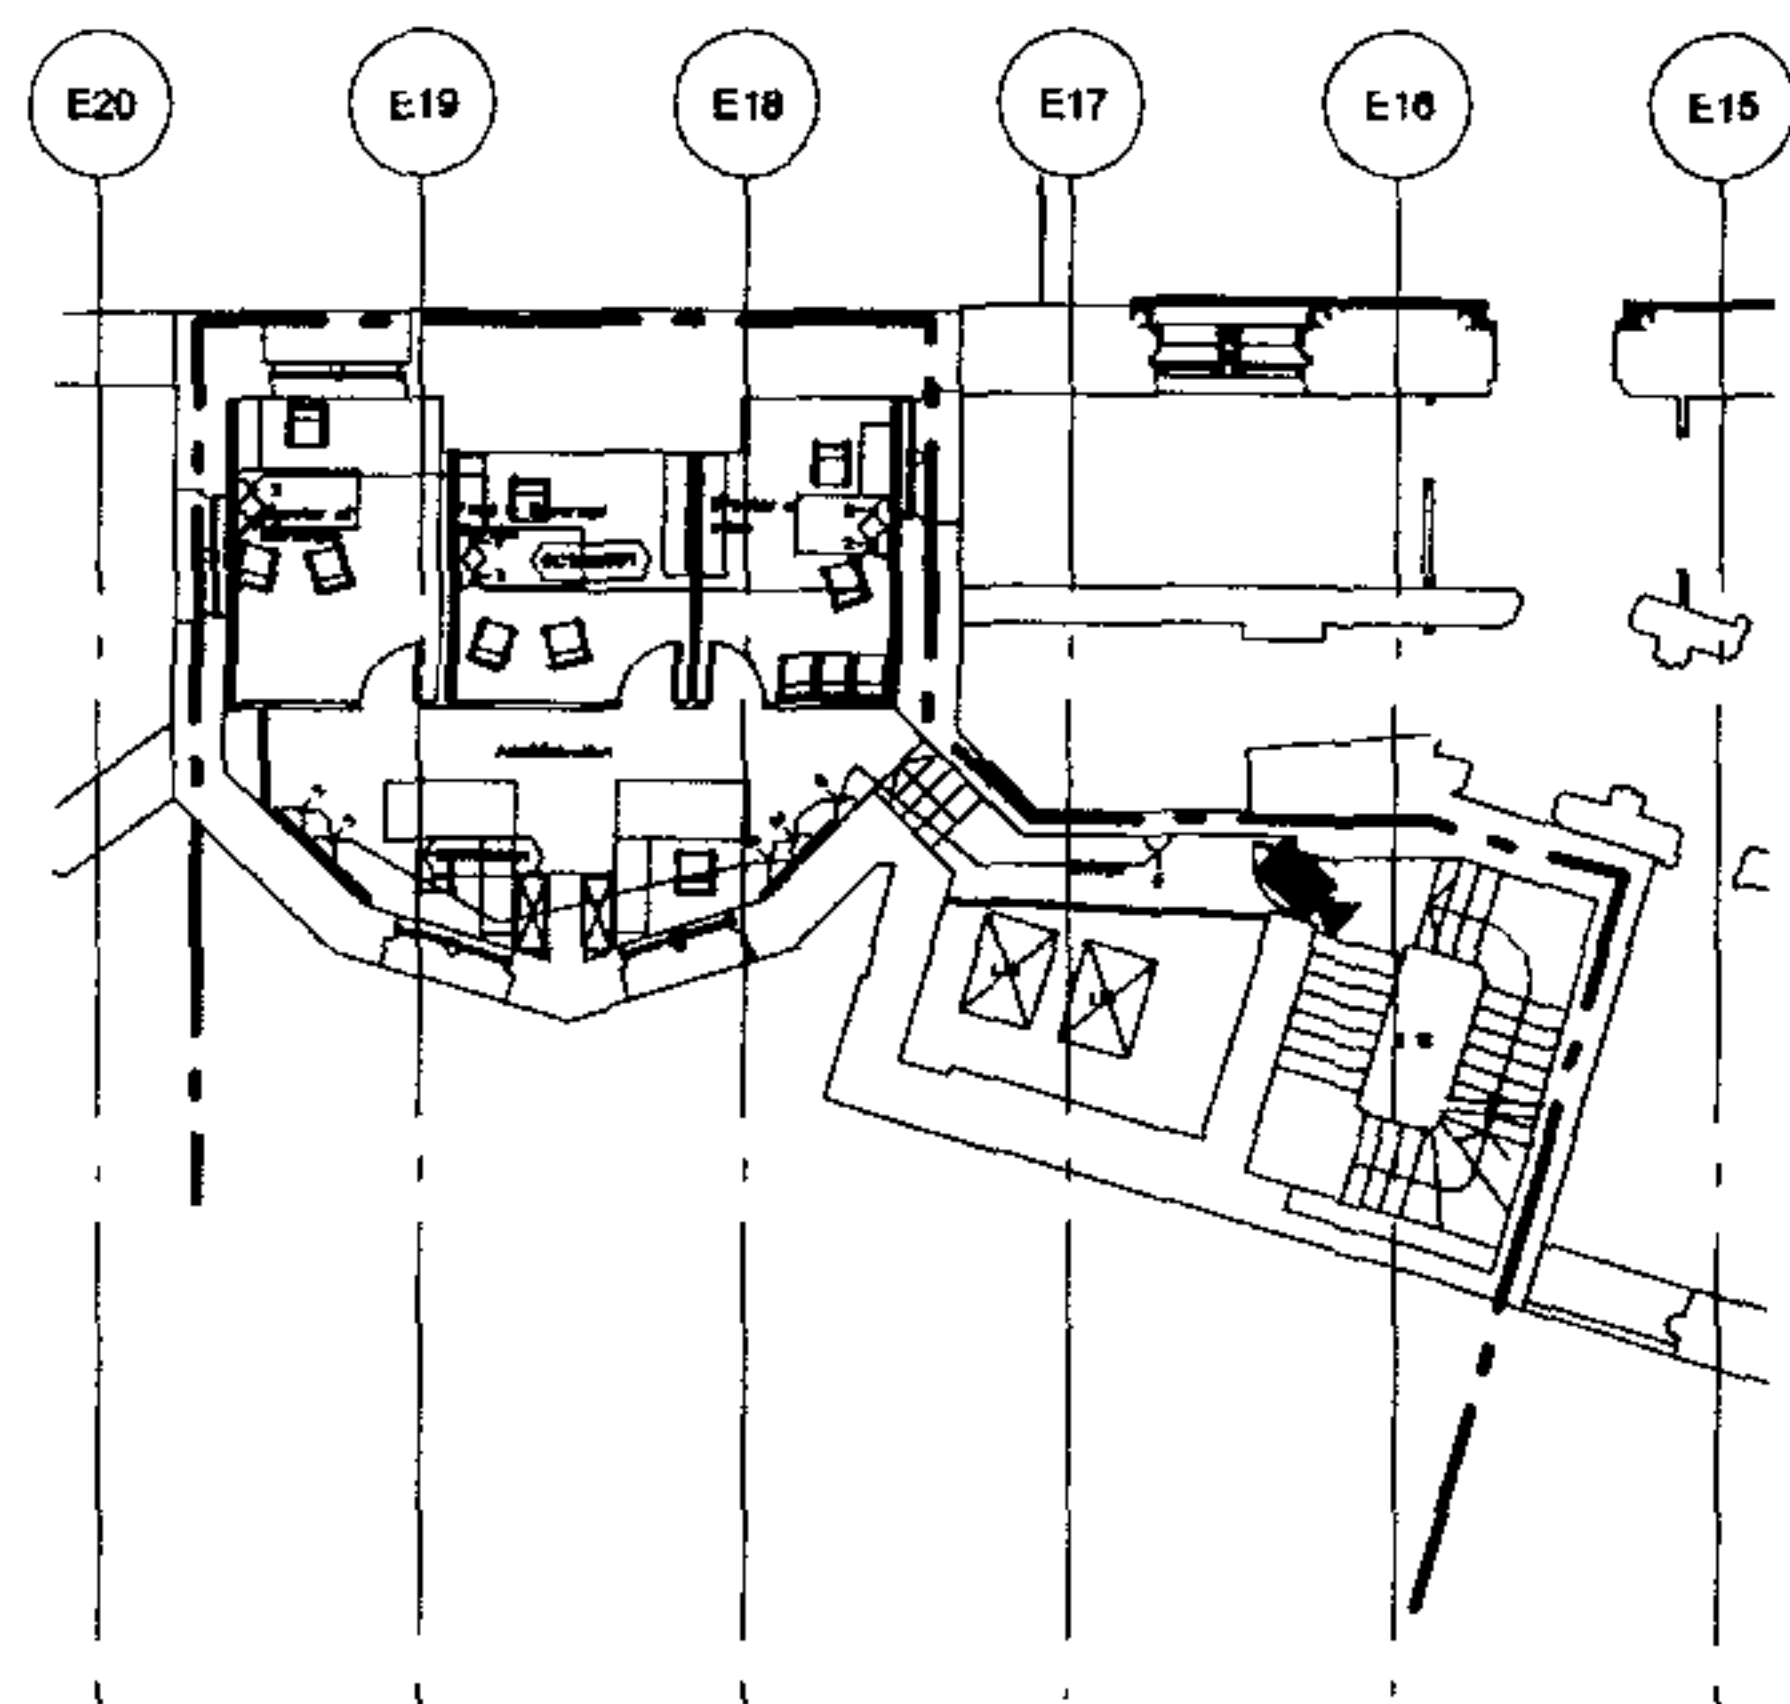

Architect
RHML Architects
and
RICHARD GRIFFITHS ARCHITECTS
77 Royal Street London WC2R 9BE
T 020 7766 2000 F 020 7766 0001

Client
**Manhattan Loft
Corporation Limited**

Project

St Pancras Chambers

WEST CHAMBERS
PLATFORM & MEZZ.
SMALL POWER &
MISCELLANEOUS LAYO
sheet 2 of 2

Made	P.C.	C.A.D.	P.C.
City	State	Scale	1:10
App.	E.P.	Date	10/1/81

FABER MALINSSELL | AECO

NO. 23101/DD/E/222/2

1	2	3	100
---	---	---	---	---	---	---	---	---	----	----	-----

WHERE INDICATED SERVICES DISTRIBUTION WITHIN EACH ROOM ARE BASED ON SCHEME DESIGN LAYOUTS. FINAL LAYOUTS TO BE AGREED.

WITHIN OTHER AREAS FINAL SERVICES DISTRIBUTION PROPOSALS WITHIN ROOM TO BE CONFIRMED

NOTES

1. NOTE TO PREPARE DIMENSIONS ONLY.
2. THIS DRAWING TO BE READ IN CONJUNCTION WITH ALL RELEVANT PROJECTS AND STRUCTURAL DIMENSIONING DRAWINGS.
3. THIS DRAWING TO BE READ IN CONJUNCTION WITH ALL RELEVANT PLANT INSTALLATION DRAWINGS.
4. THIS DRAWING TO BE READ IN CONJUNCTION WITH RELEVANT SCHEMATIC DRAWINGS.
5. FOR TYPICAL DETAILS REFER TO SPARSING AND ZONE/DETAILED/0000

FOR CONTINUATION REFER TO DRG. No. 23101/DD/M/20212

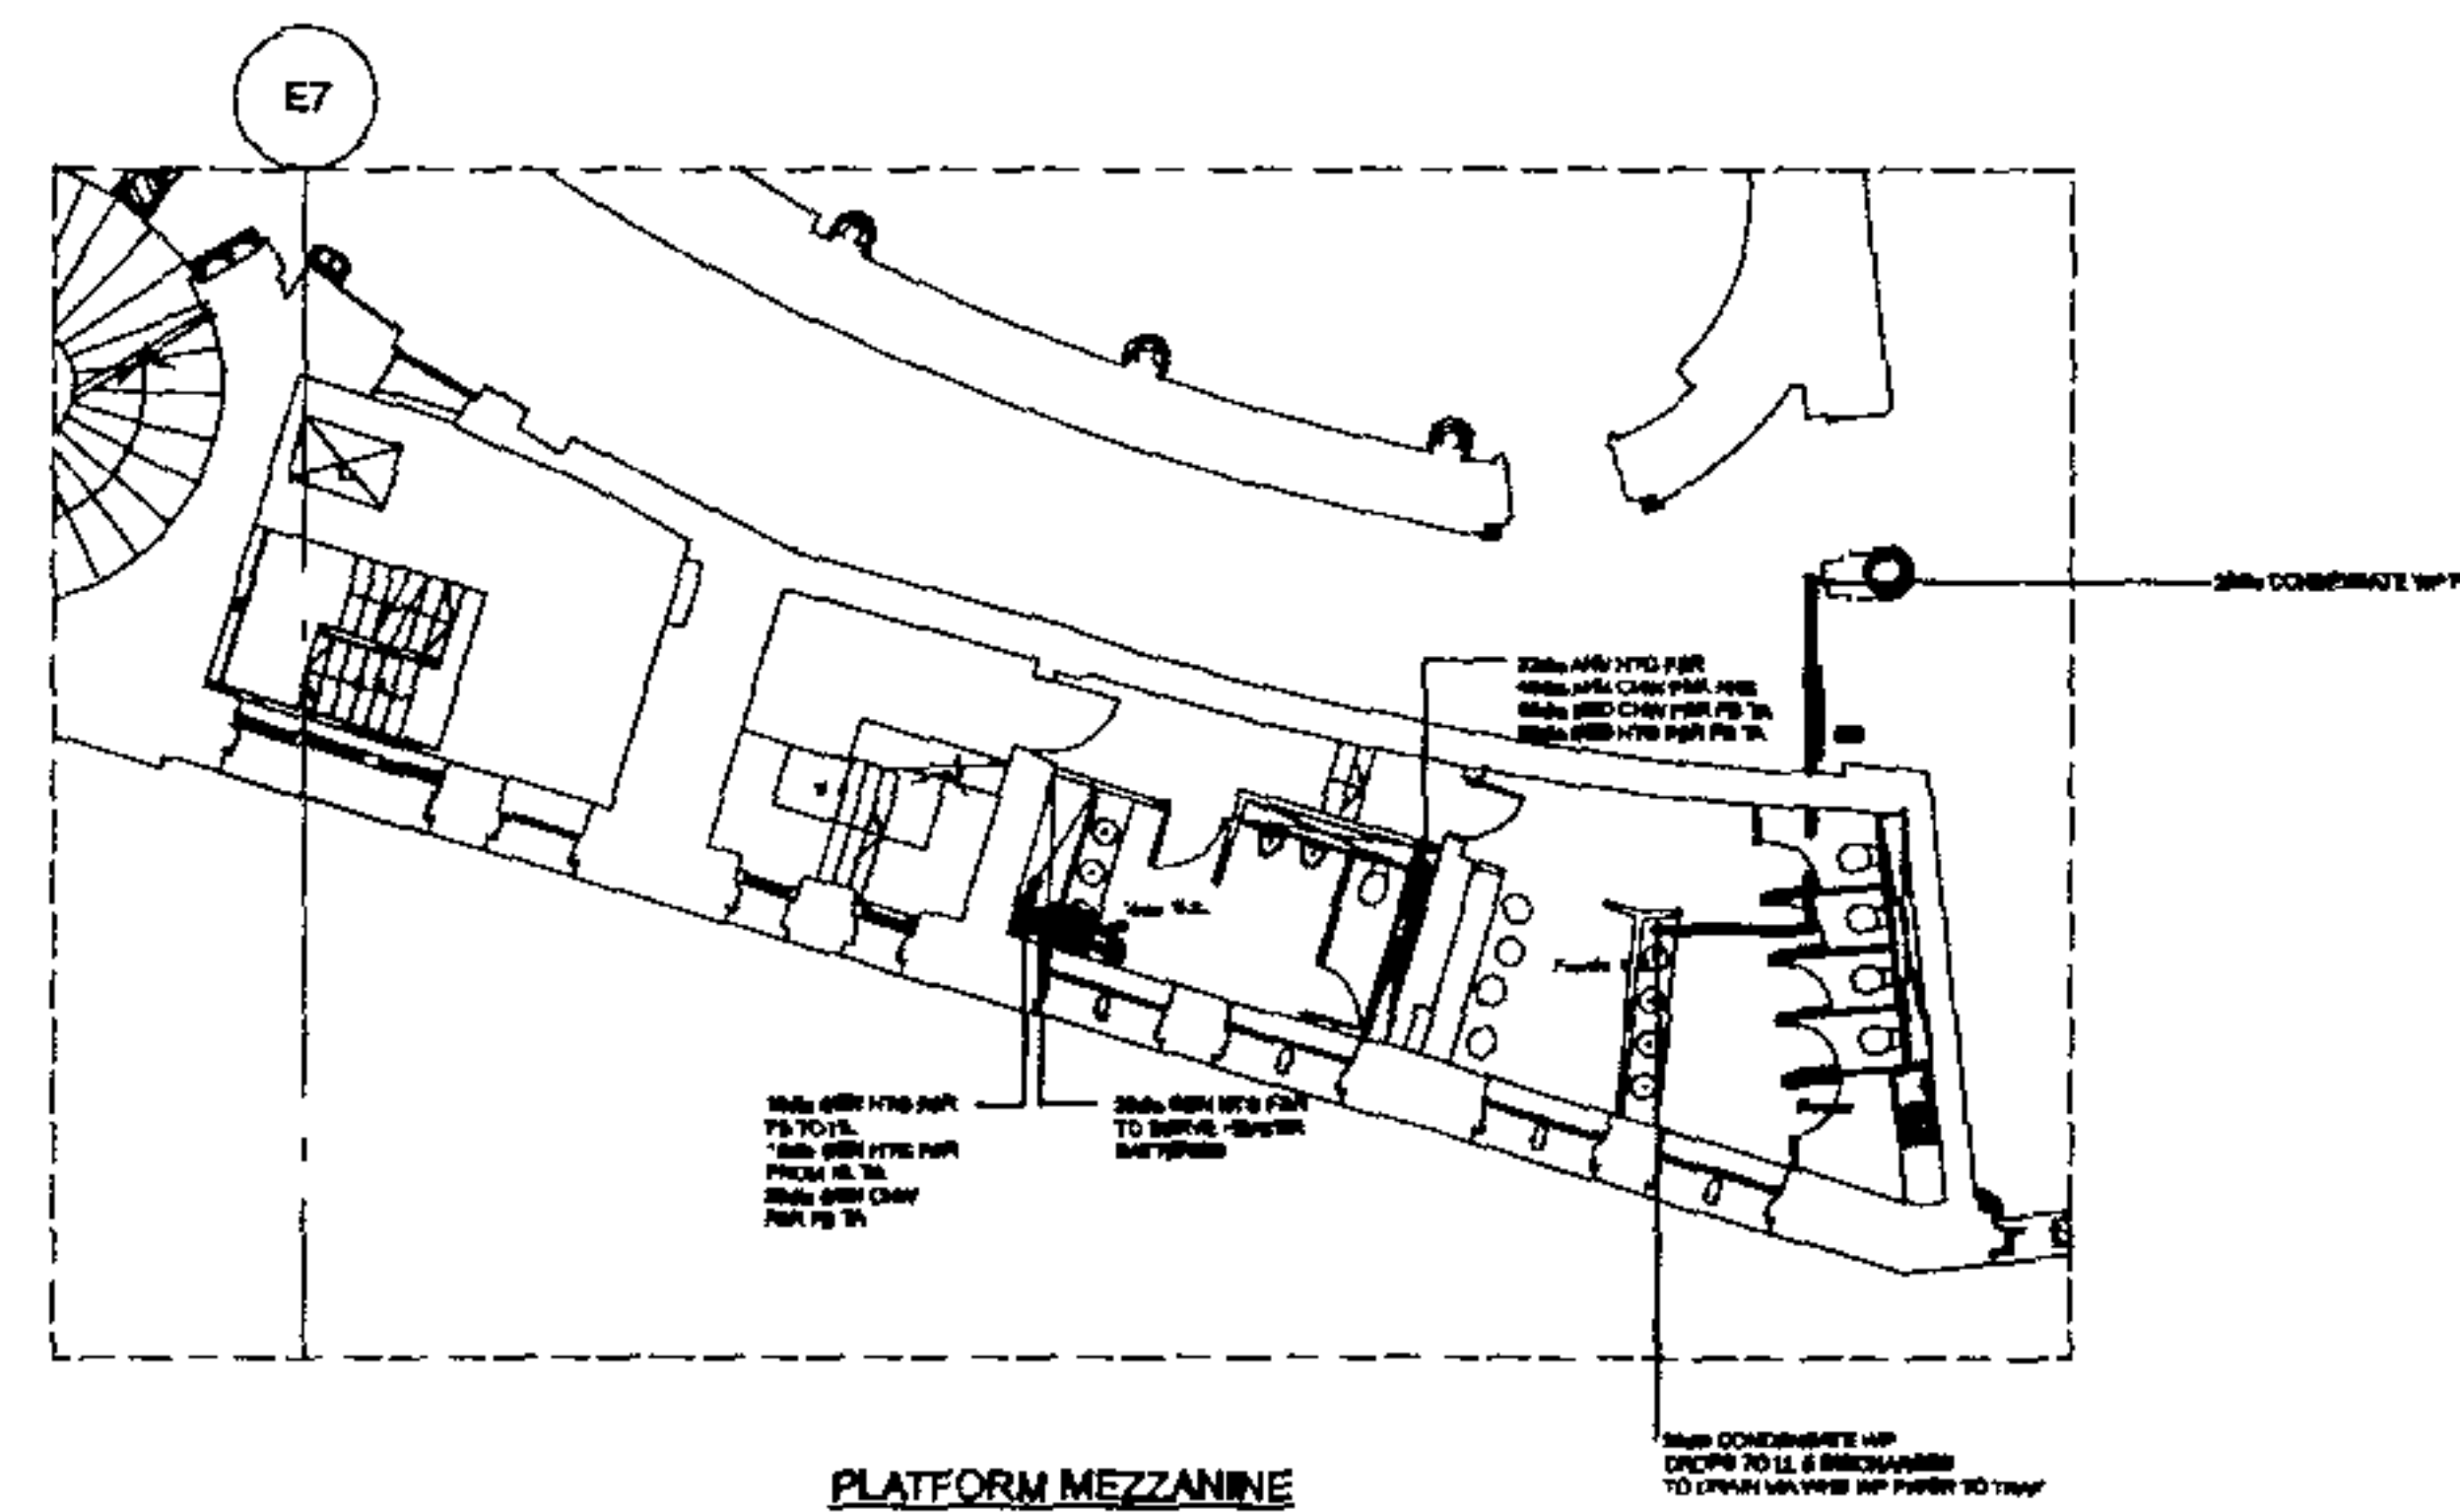
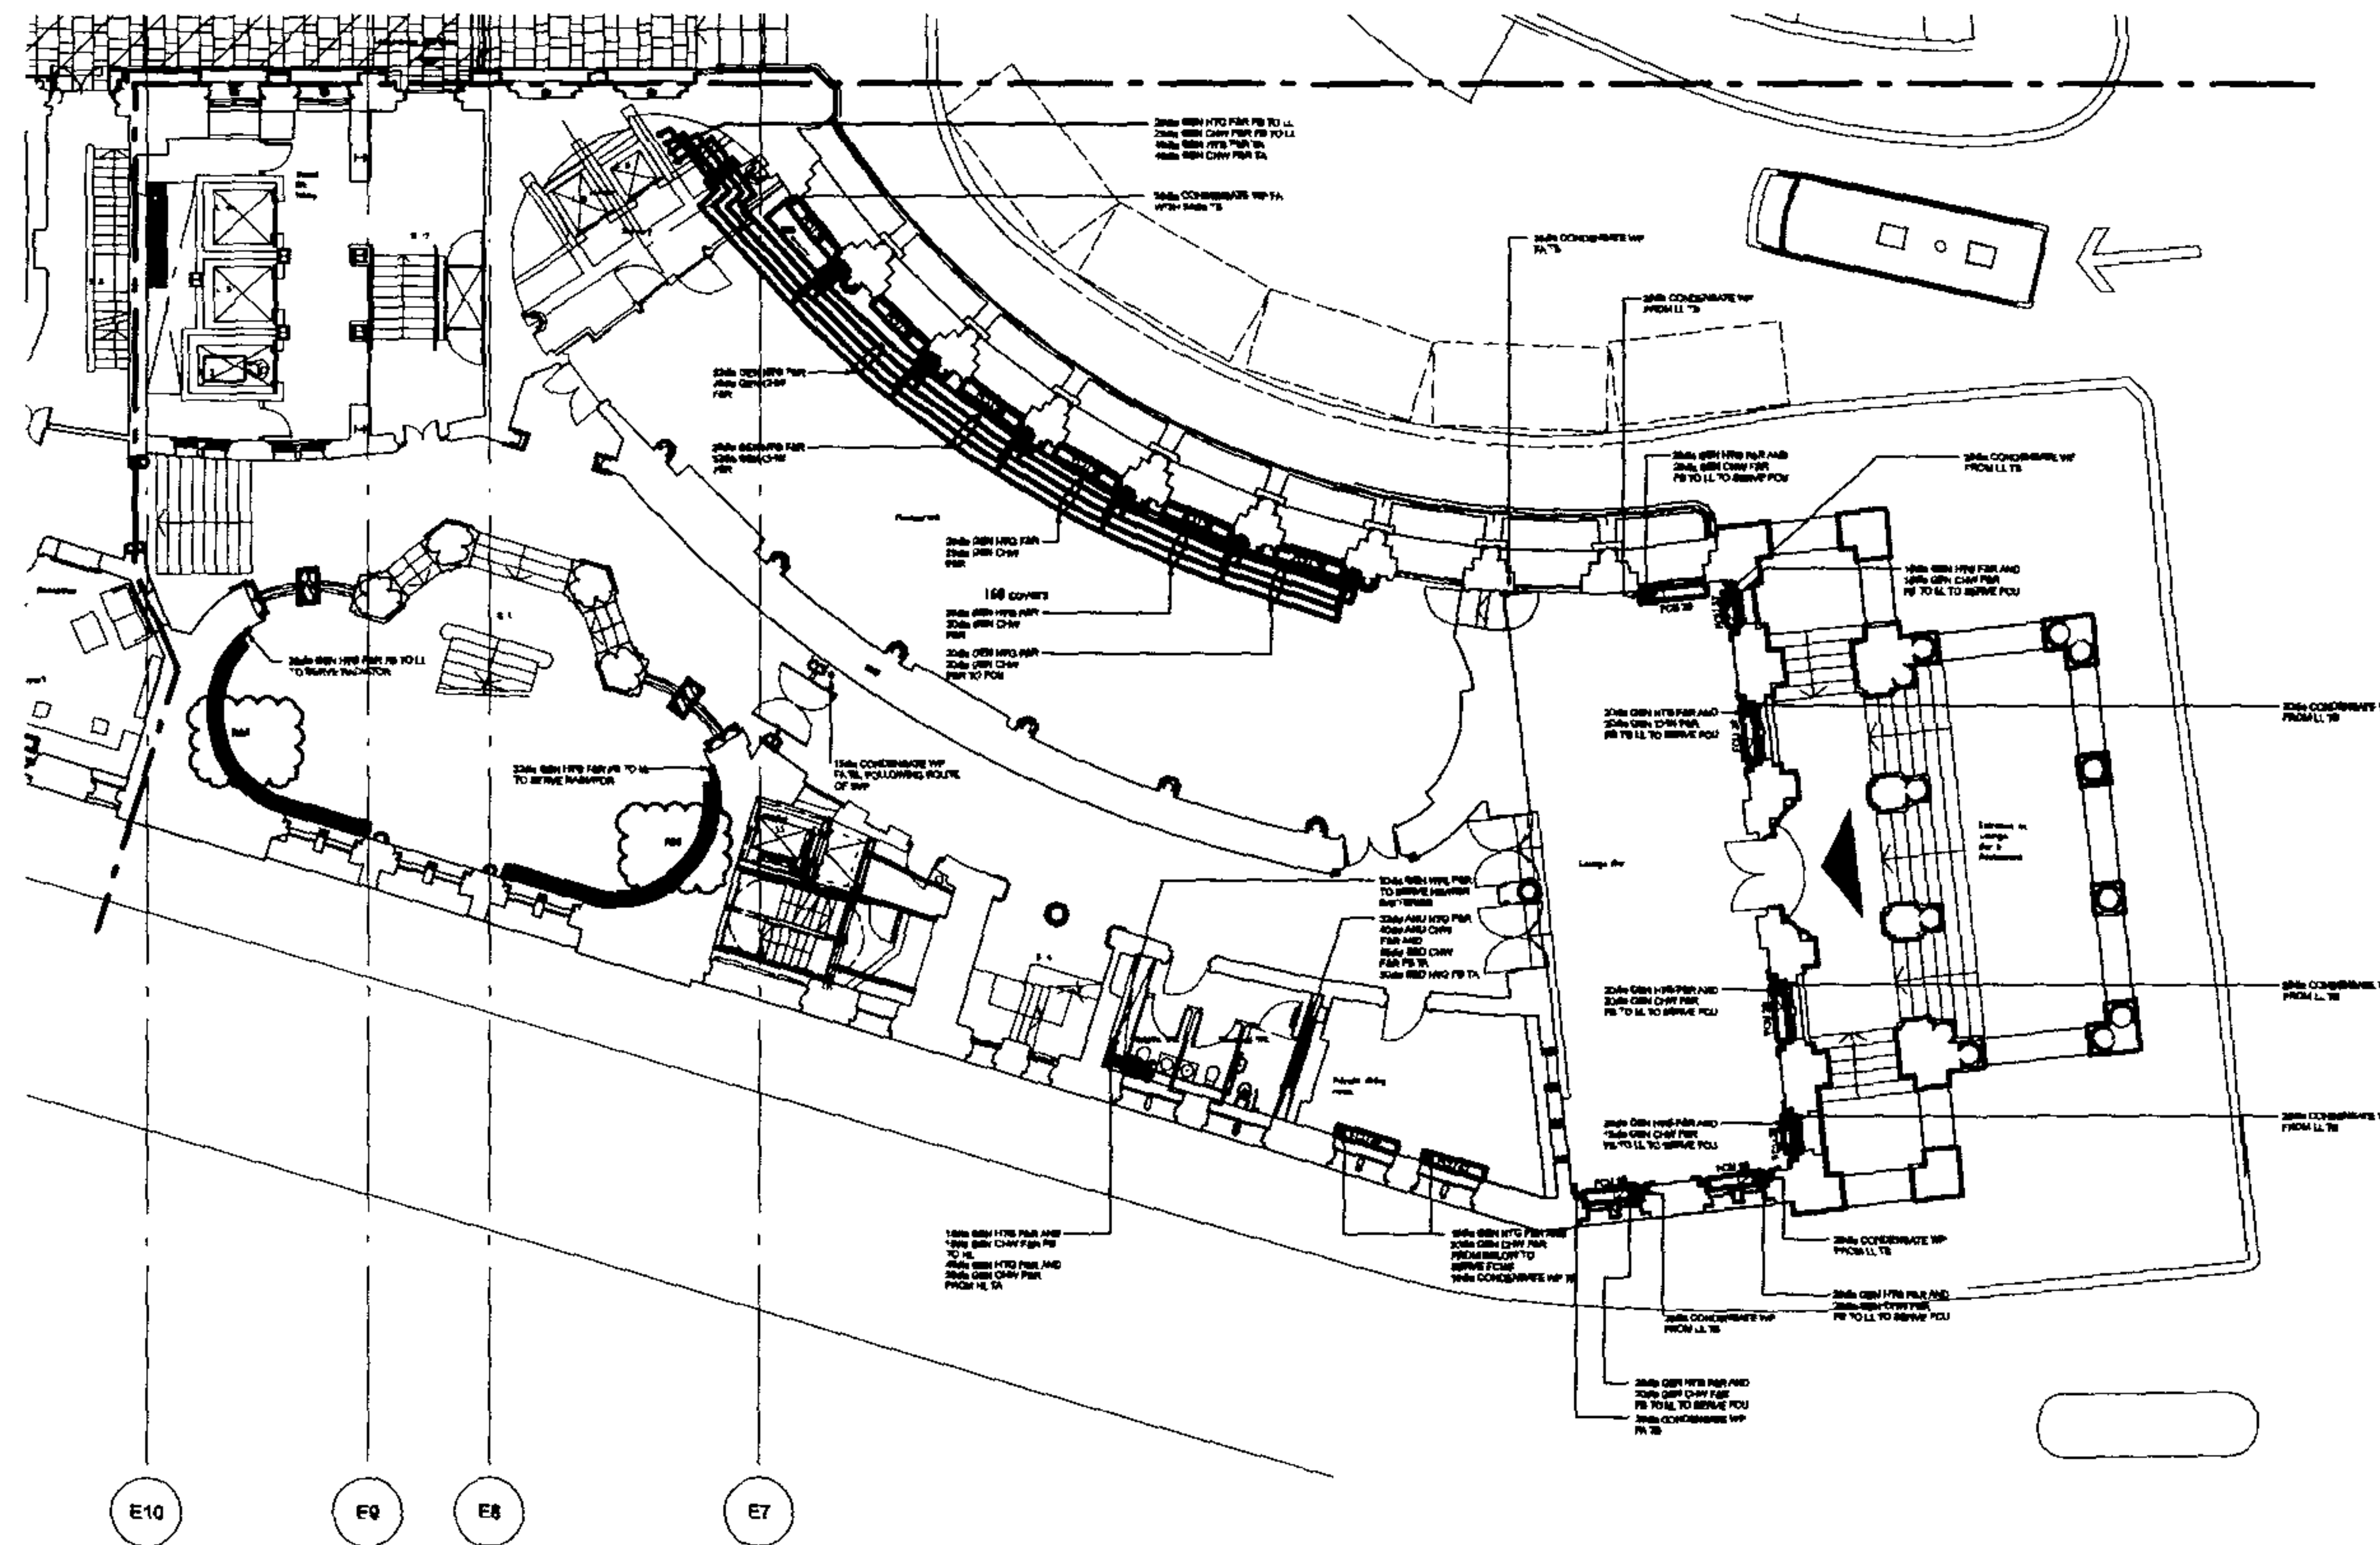


Diagram illustrating the wastewater treatment process:

- Pond**: The source of wastewater.
- Pump**: The mechanism that moves wastewater from the pond to the treatment tanks.
- Daily Collection Tank**: A tank that receives wastewater from the pump.
- Treatment Tank**: A tank where the wastewater undergoes treatment.

Architect
RHWL Architects
and
RICHARD GRIFFITHS ARCHITECTS
77 State Street, 10th Floor, New York, NY 10038
Tel: 212 693 1000 Fax: 212 693 1001

Project
St Pancras Chambers

Memo	SC	C.A.D.	SC
CTK	27	Scale	1:100
App.	D.T.E.	Date	MAY 1961


Maryland: 410.326.7300
 Fax: 410.326.7301
 88 Adams, Philadelphia, PA 19106
 www.philadelphiapost.com

NO. 231015100420211


NOTE

WHERE INDICATED SERVICES DISTRIBUTION WITHIN EACH ROOM ARE BASED ON SCHEME DESIGN LAYOUTS. FINAL LAYOUTS TO BE AGREED.

WITHIN OTHER AREAS FINAL SERVICES DISTRIBUTION PROPOSALS WITHIN ROOM TO BE CONFIRMED.

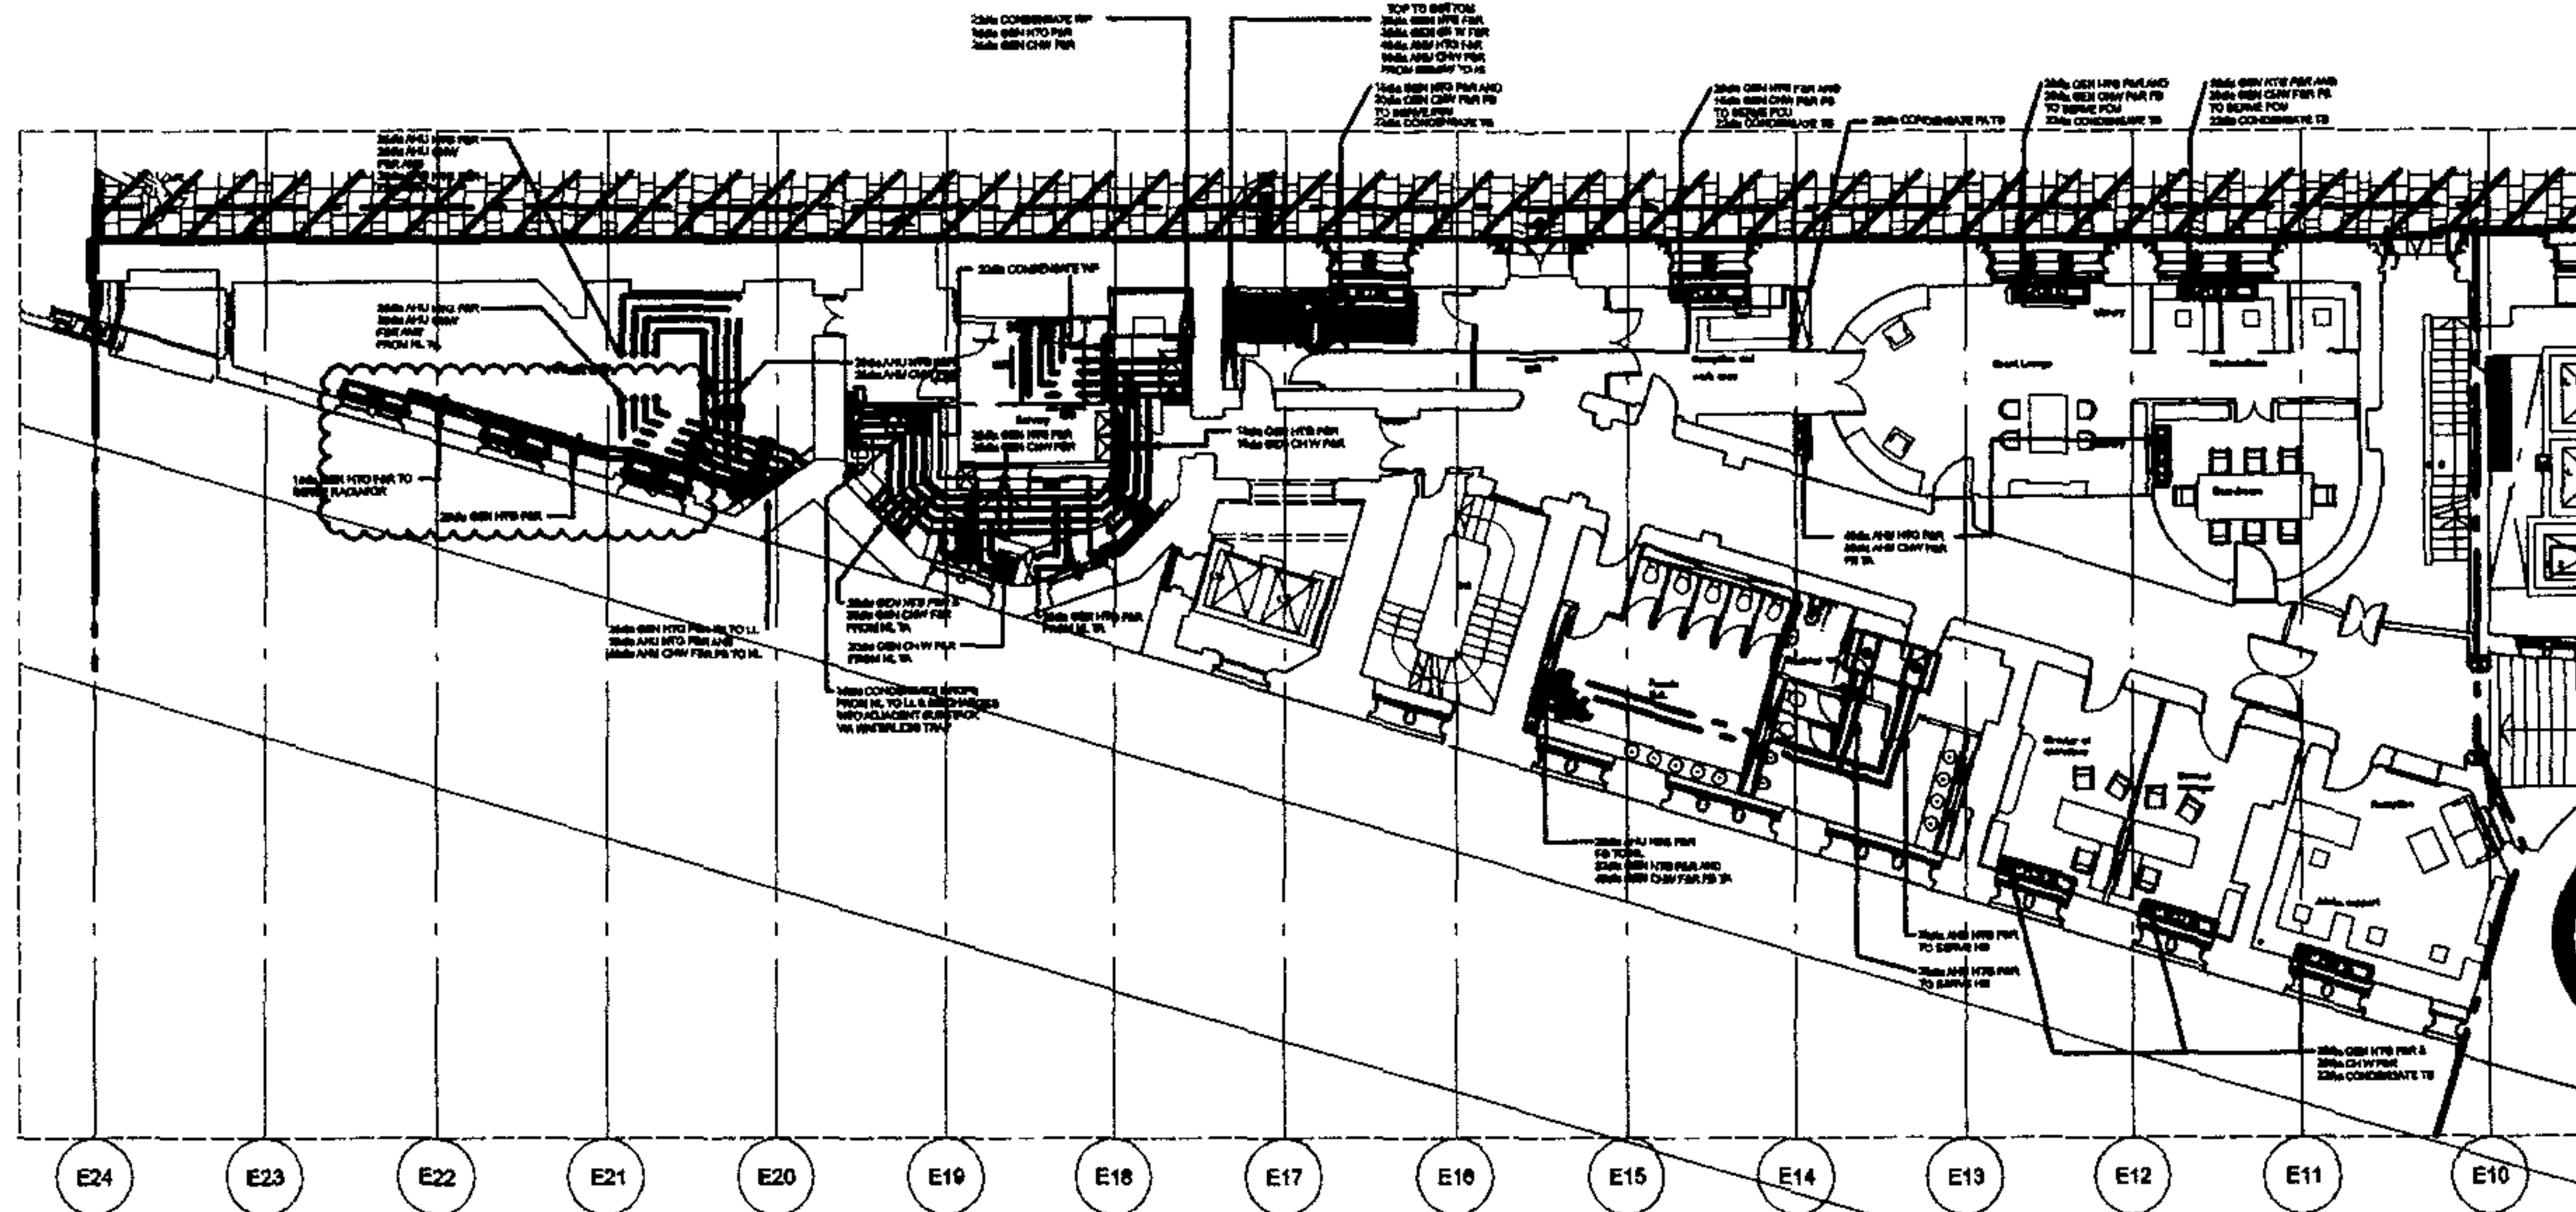


FOR CONTINUATION REFER TO DRG. No. 23101/DDM/2021

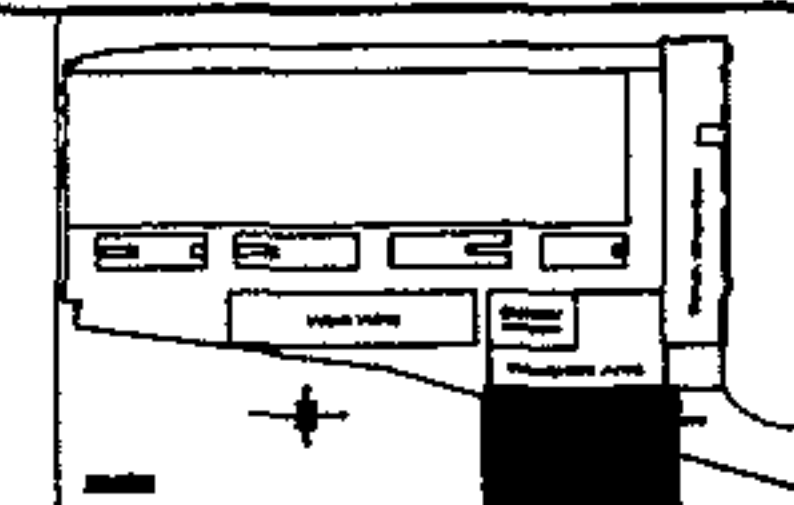


BASE DRAWINGS

USED IN COMPLETION OF THIS DRG.

- NOTES
1. WORK TO PROPOSED DIMENSIONS ONLY.
 2. THIS DRAWING TO BE READ IN CONJUNCTION WITH ALL RELEVANT ARCHITECTURAL AND STRUCTURAL EXISTENCE DRAWINGS.
 3. THIS DRAWING TO BE READ IN CONJUNCTION WITH ALL RELEVANT MECHANICAL DRAWINGS.
 4. THIS DRAWING TO BE READ IN CONJUNCTION WITH ALL RELEVANT ELECTRICAL DRAWINGS.
 5. FOR SPECIAL DETAILS REFER TO DRAWING NO. 23101/DDM/2021

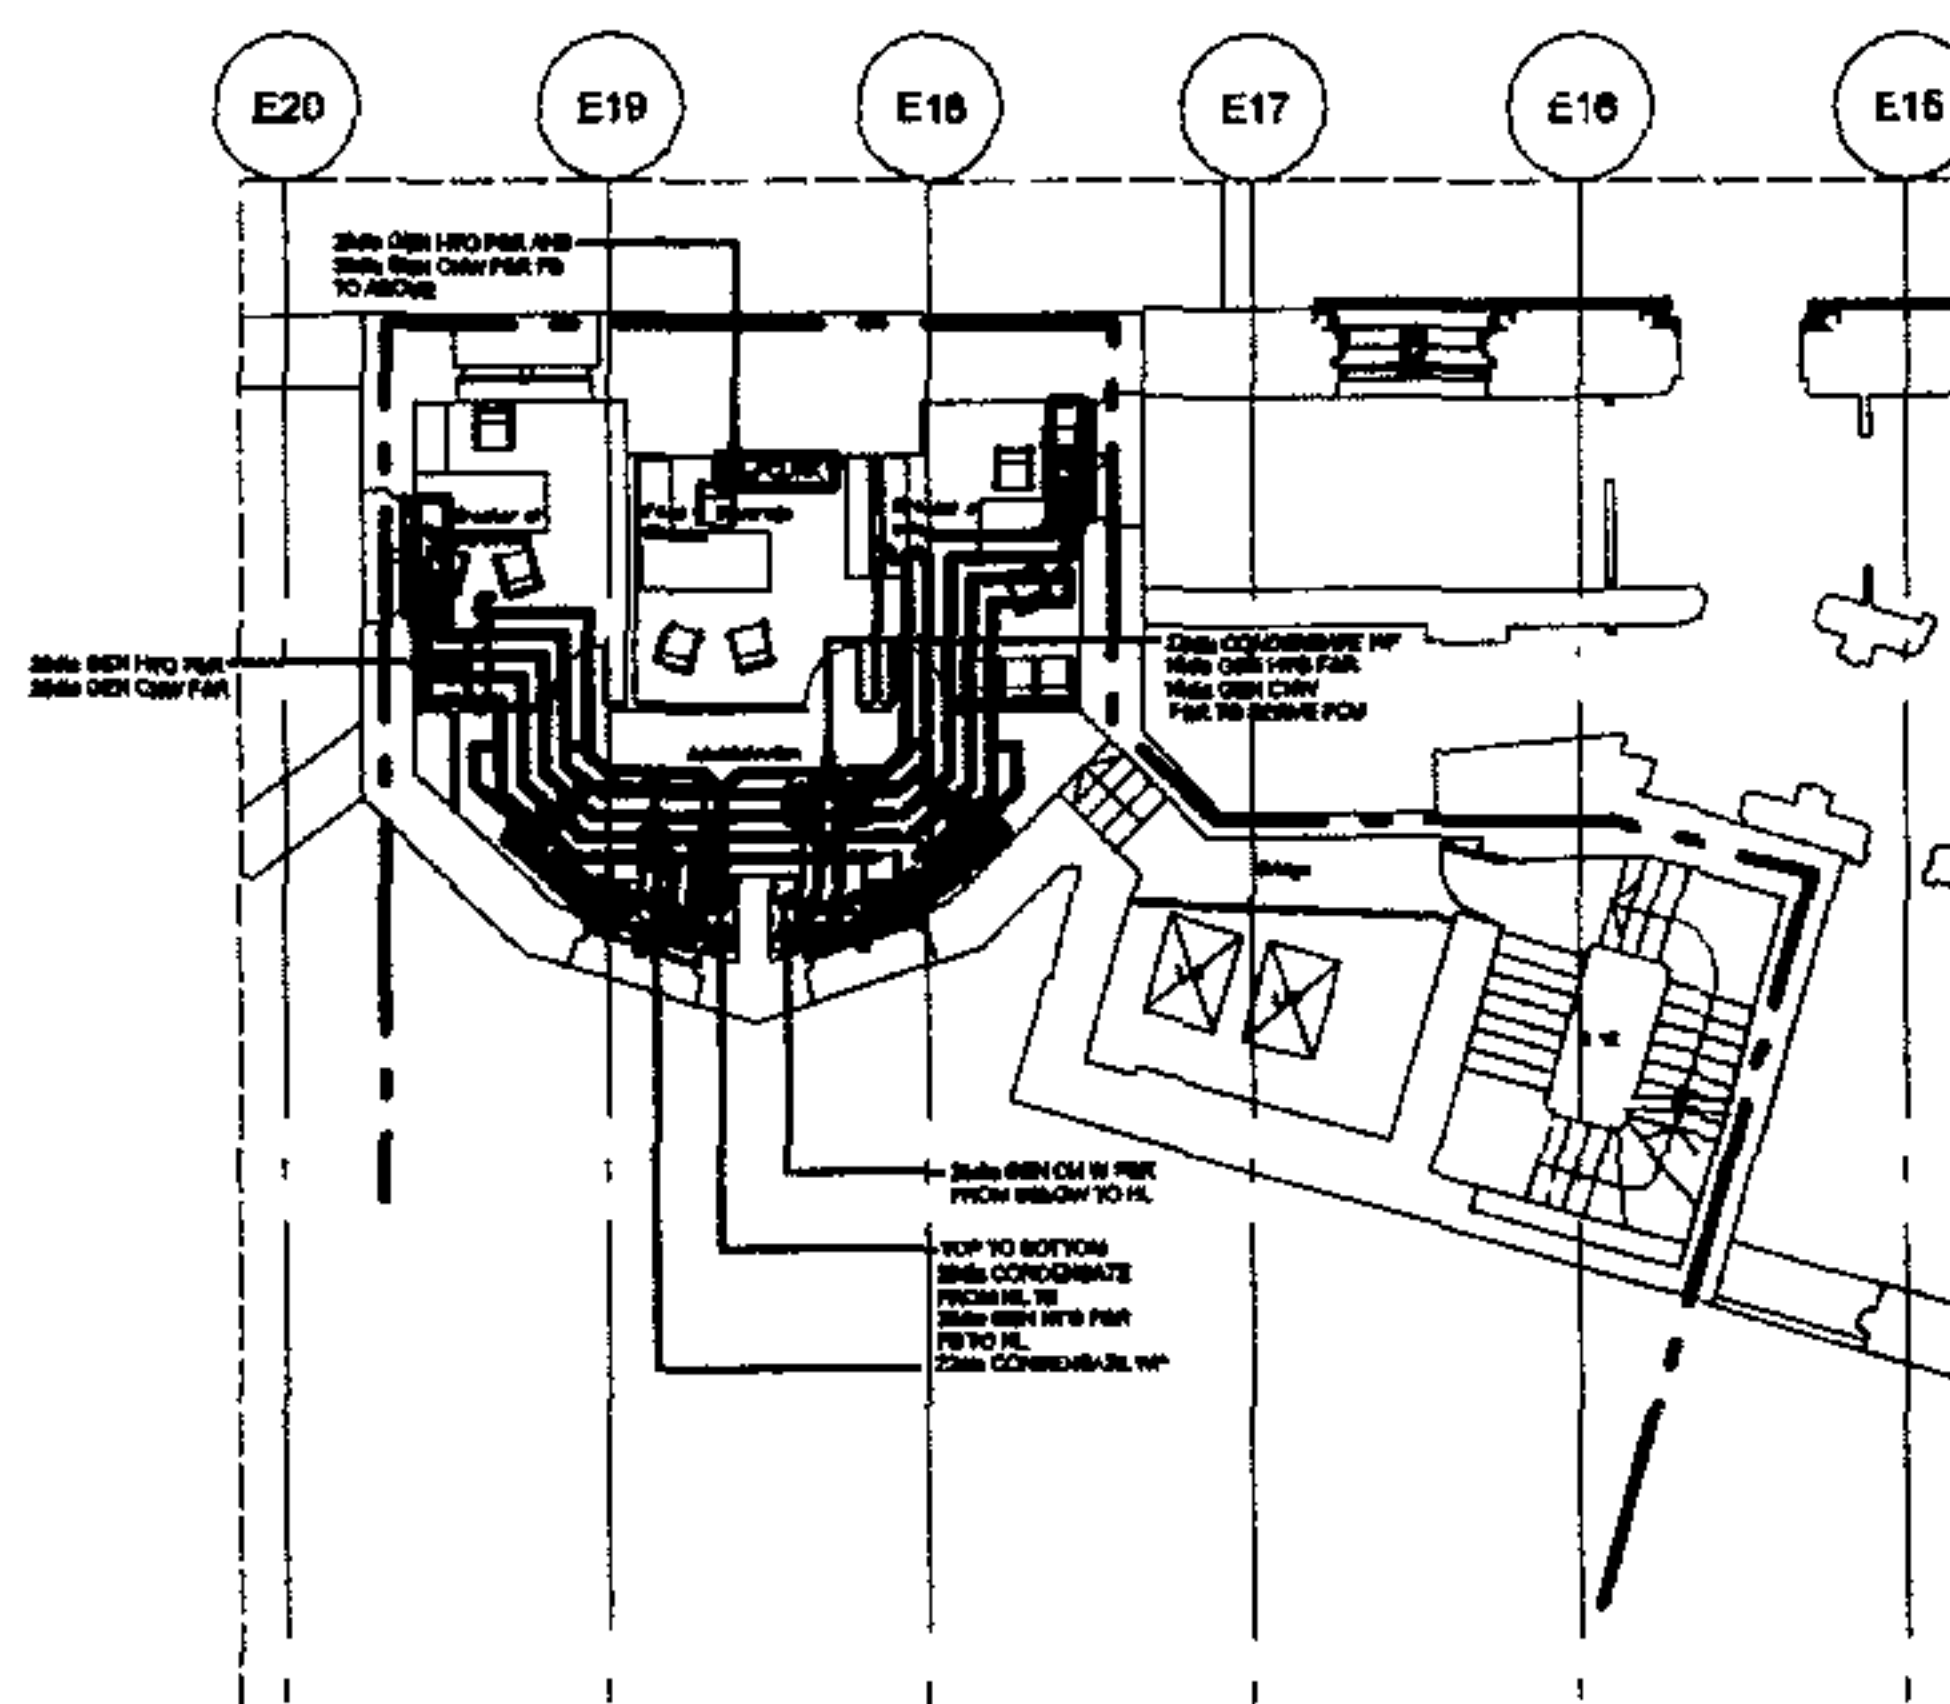

PLATFORM MEZZANINE

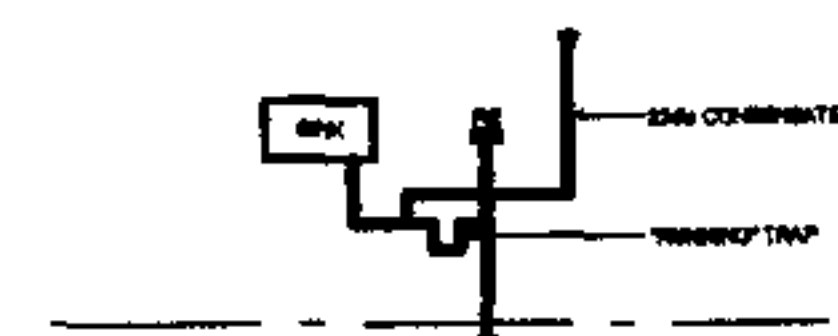

ECU CONDENSATE DETAIL

ALL HORIZONTAL SERVICE CONNECTIONS FROM THE MEZZANINE TO THE ECU CONDENSATE DETAIL ARE TO BE MADE IN CONFORMANCE WITH THE RELEVANT MECHANICAL DRAWINGS. ALL HORIZONTAL SERVICE CONNECTIONS FROM THE MEZZANINE TO THE ECU CONDENSATE DETAIL ARE TO BE MADE IN CONFORMANCE WITH THE RELEVANT ELECTRICAL DRAWINGS.

TENDER DRAWING	
Architect	RHW Architects RICHARD GRIFITHS ARCHITECTS 17 West End Street, London E1 2AB
Client	Manhattan Loft Corporation Limited
Project	St Pancras Chambers
Title	WEST CHAMBERS PLATFORM AND MEZZANINE HEATING AND COOLING LAYOUT SHEET 2 of 2

Made	SC	CAD	SC
Cycle	1	Scale	1:100
App.	D.T.E.	Date	MAY '98

FABER MALINSSELL	AECOM
------------------	-------

Project No.	23101/DDM/2021
Sheet No.	0

Scale	1:100
-------	-------

WHERE INDICATED SERVICES DISTRIBUTION WITHIN EACH ROOM ARE BASED ON SCHEMATIC DESIGN LAYOUTS. FINAL LAYOUTS TO BE AGREED.

WITHIN OTHER AREAS FINAL SERVICES DISTRIBUTION PROPOSALS WITHIN ROOM TO BE CONFIRMED.

[illegible]

NOTES

- 1 WORK TO FIGURED DIMENSIONS ONLY
- 2 THIS DRAWING TO BE READ IN CONJUNCTION WITH ALL RELEVANT ARCHITECTS AND STRUCTURAL ENGINEERING DRAWINGS
- 3 THIS DRAWING TO BE READ IN CONJUNCTION WITH ALL RELEVANT MECHANICAL DRAWINGS
- 4 THIS DRAWING TO BE READ IN CONJUNCTION WITH RELEVANT SCHEMATIC DRAWINGS
- 5 FOR TYPICAL DETAILS REFER TO DRAWING NO. 23101000000000000000

E10	E9	E8	E7
-----	----	----	----


Rev	Date	Comments	Issued	Link	Appr
STATUS TENDER DRAWING					
Architect RHWL Architects RICHARD GRIFITHS ARCHITECTS 7 Dand Street, Level 10/11/12 Tel: 001 754 741 1111 Fax: 001 754 741 1111					
Client Manhattan Loft Corporation Limited					
Project St Pancras Chambers					
1 file WEST CHAMBERS PLATFORM LEVEL VENTILATION LAYOUT Sheet 1 of 2					
Made Scale		SG DATE		C.A.D. Scale	
1:100		1:100		1:100	
Appr.		D.T.E		Date	
				MAC/08	
FABER MAUNSELL AECOM					
Manhattan Loft - Faber 100, Victoria Embankment, Strand London, W.C2R 2LH, U.K.			Tel: 020 7553 3131 Fax: 020 7553 3132 Tel: +44 (0)20 7553 3132 www.faber-maunsell.com		
Rev					
N.S. 23101/DD/M/2121					0
Appr					
AG					

WHERE INDICATED SERVICES DISTRIBUTION WITHIN EACH ROOM ARE BASED ON SCHEME DESIGN LAYOUTS. FINAL LAYOUTS TO BE AGREED.

WITHIN OTHER AREAS FINAL SERVICES DISTRIBUTION PROPOSALS WITHIN ROOM TO BE CONFIRMED

[illegible]

FOR CONTINUATION REFER TO DRG. NO. 23101/DD/M/212/1

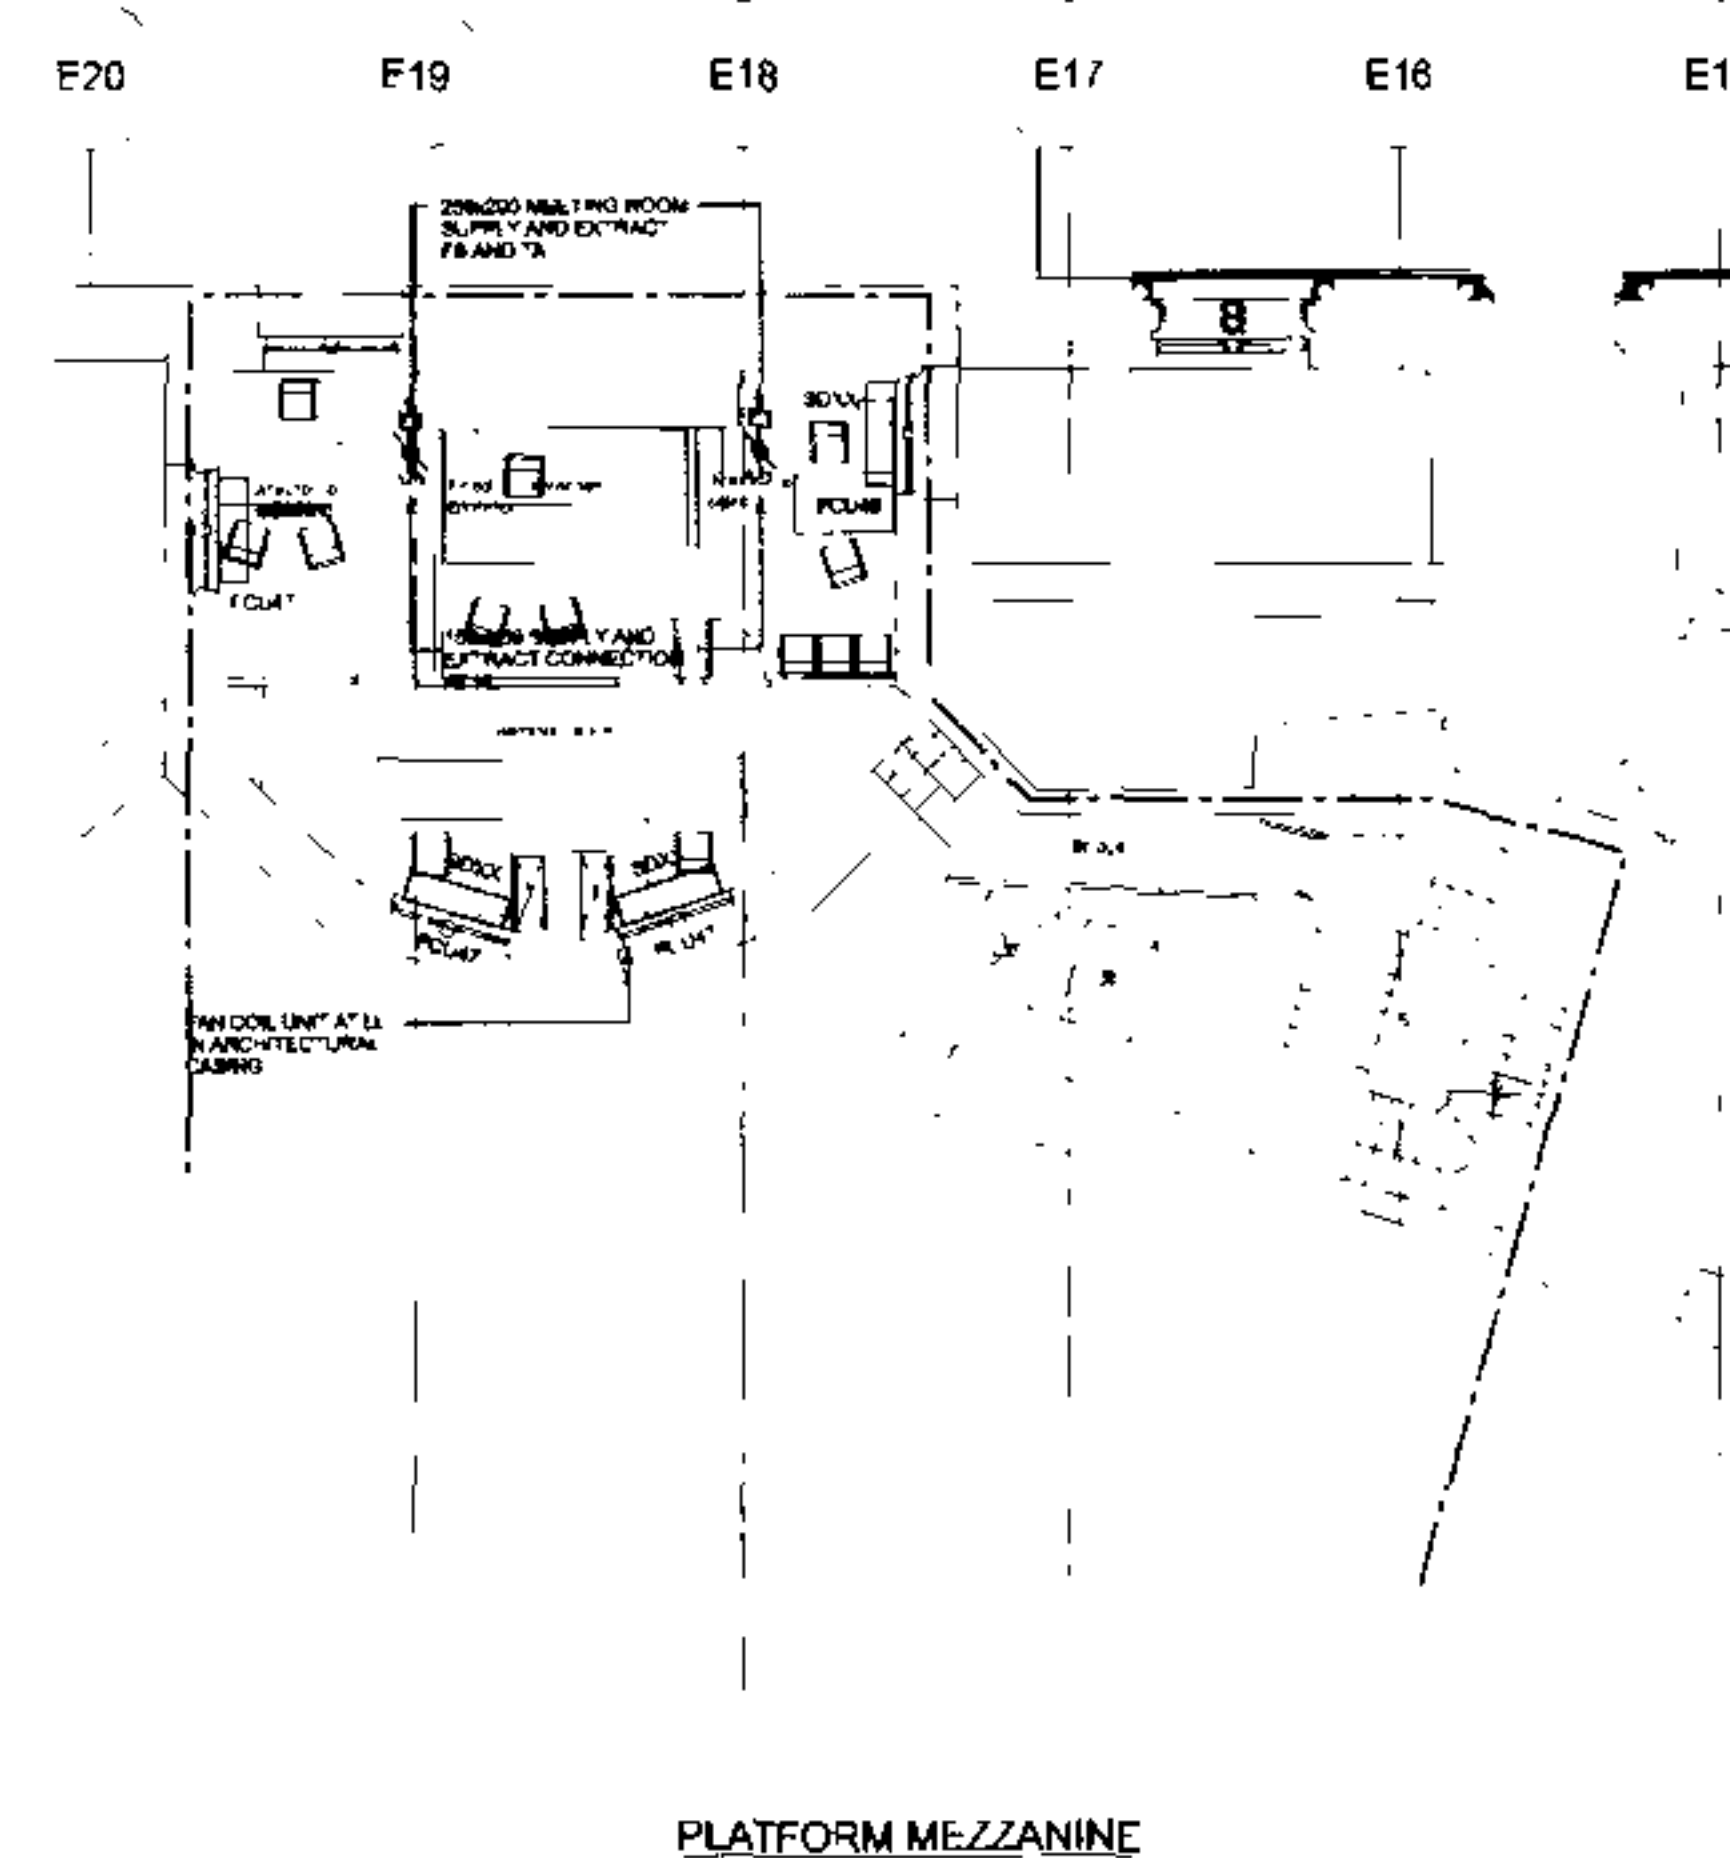

BASE DRAWINGS
 IN COMBINATION OF THIS PAGE

[illegible]

Status **TENDER DRAWING**

Architect
RHWL Architects
RICHARD GRIFFITHS ARCHITECTS
7 Laurel Street, Suite 1000, NYC 10022
Tel: 212.691.1000 Fax: 212.691.1001

Manhattan Loft
Corporation Limited

Project	St Pancras Chambers
---------	---------------------

Title **WEST CHAMBERS
PLATFORM AND
MEZZANINE
VENTILATION LAYOUT**
Sheet 2 of 2

Made	SC			C.A.D	JZ
Cr'd	cash	dr	pr	Scale	1 100
App.	D.T.E.			Date	MAY 06


FABER MAUNSELL | ALCOM

N C. 23101/DD/M/212/2


[illegible]

E10 E9 E8 E7

PLATFORM MEZZANINE

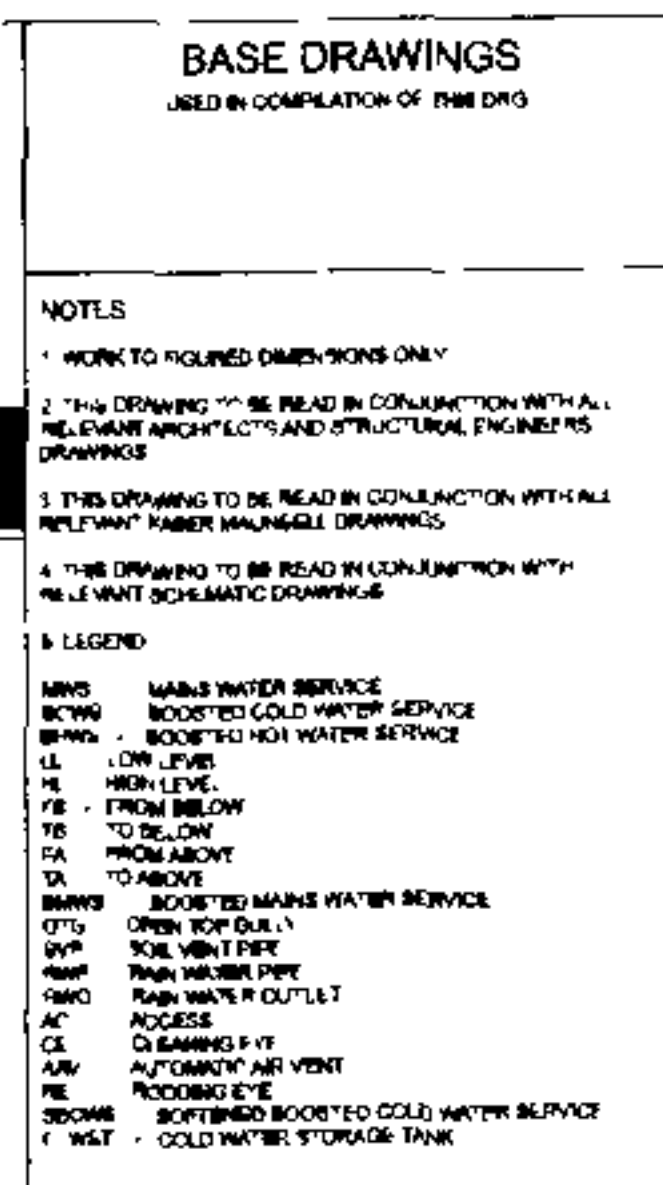

Name	Date	Design	Material	Chd
Startup				
TENDER DRAWING				
Architect				
RHWL Architects 1800 NORTH BRISTOL ST APT 100-1003 1000 BOSTON AVE, NEW YORK, NY 10003 TEL: 212 778 7881 / FAX: 212 778 8811				
Client				
Manhattan Loft Corporation Limited				
Project				
St Pancras Chambers				
Title				
WEST CHAMBERS PLATFORM PUBLIC HEALTH SERVICES LAYOUT sheet 1 of 2				
Model	B	CAD	AUD	
City	Arch	Site	Pl	Scale
App	Geo	Dat	Mat	1:100
Date:				MAY 08
FABER MUNSELL AECOM				
Manhattan, New York 1000 North Broadway, Suite 1300 New York, New York 10003-6801		Tel: +1 212 778 7881 Fax: +1 212 778 8811 Email: manhattan@aecom.com		
No. 23101/DB/PH/2021				

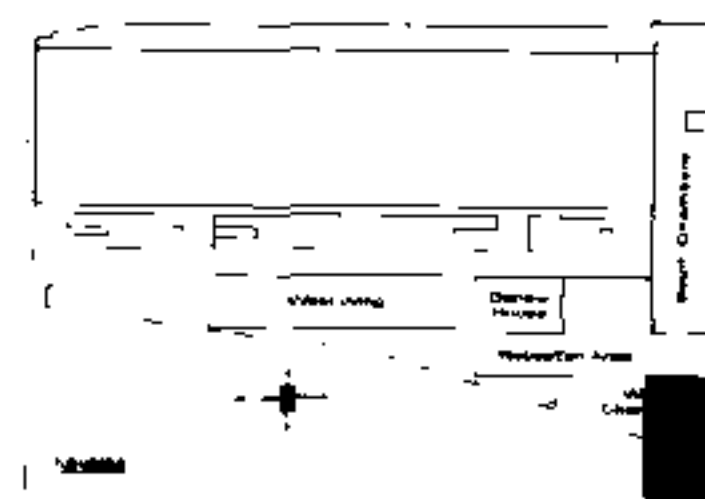


BASE DRAWINGS
USED IN COMPLETION OF THIS DRY

- NOTES
1. WORK TO FOLLOW DIMENSIONS ONLY.
 2. THIS DRAWING TO BE READ IN CONJUNCTION WITH ALL PRELIMINARY ARCHITECTURAL AND STRUCTURAL DRAWINGS.
 3. THIS DRAWING TO BE READ IN CONJUNCTION WITH ALL RELEVANT MECHANICAL DRAWINGS.
 4. THIS DRAWING TO BE READ IN CONJUNCTION WITH ALL RELEVANT ELECTRICAL DRAWINGS.
 5. THESE DRAWINGS INCLUDE MAIN PIPE WORK ROUTING FOR SPRINKLER SYSTEM. SPRINKLER HEAD LOCATIONS TO BE DEVELOPED WITH SPRINKLER CONTRACTOR.



FOR CONTINUATION REFER TO DRG. No 23101/DD/FP/104/1 & 23101/DD/FP/104/1

FOR CONTINUATION REFER TO DRG. No 23101/DD/FP/204/2

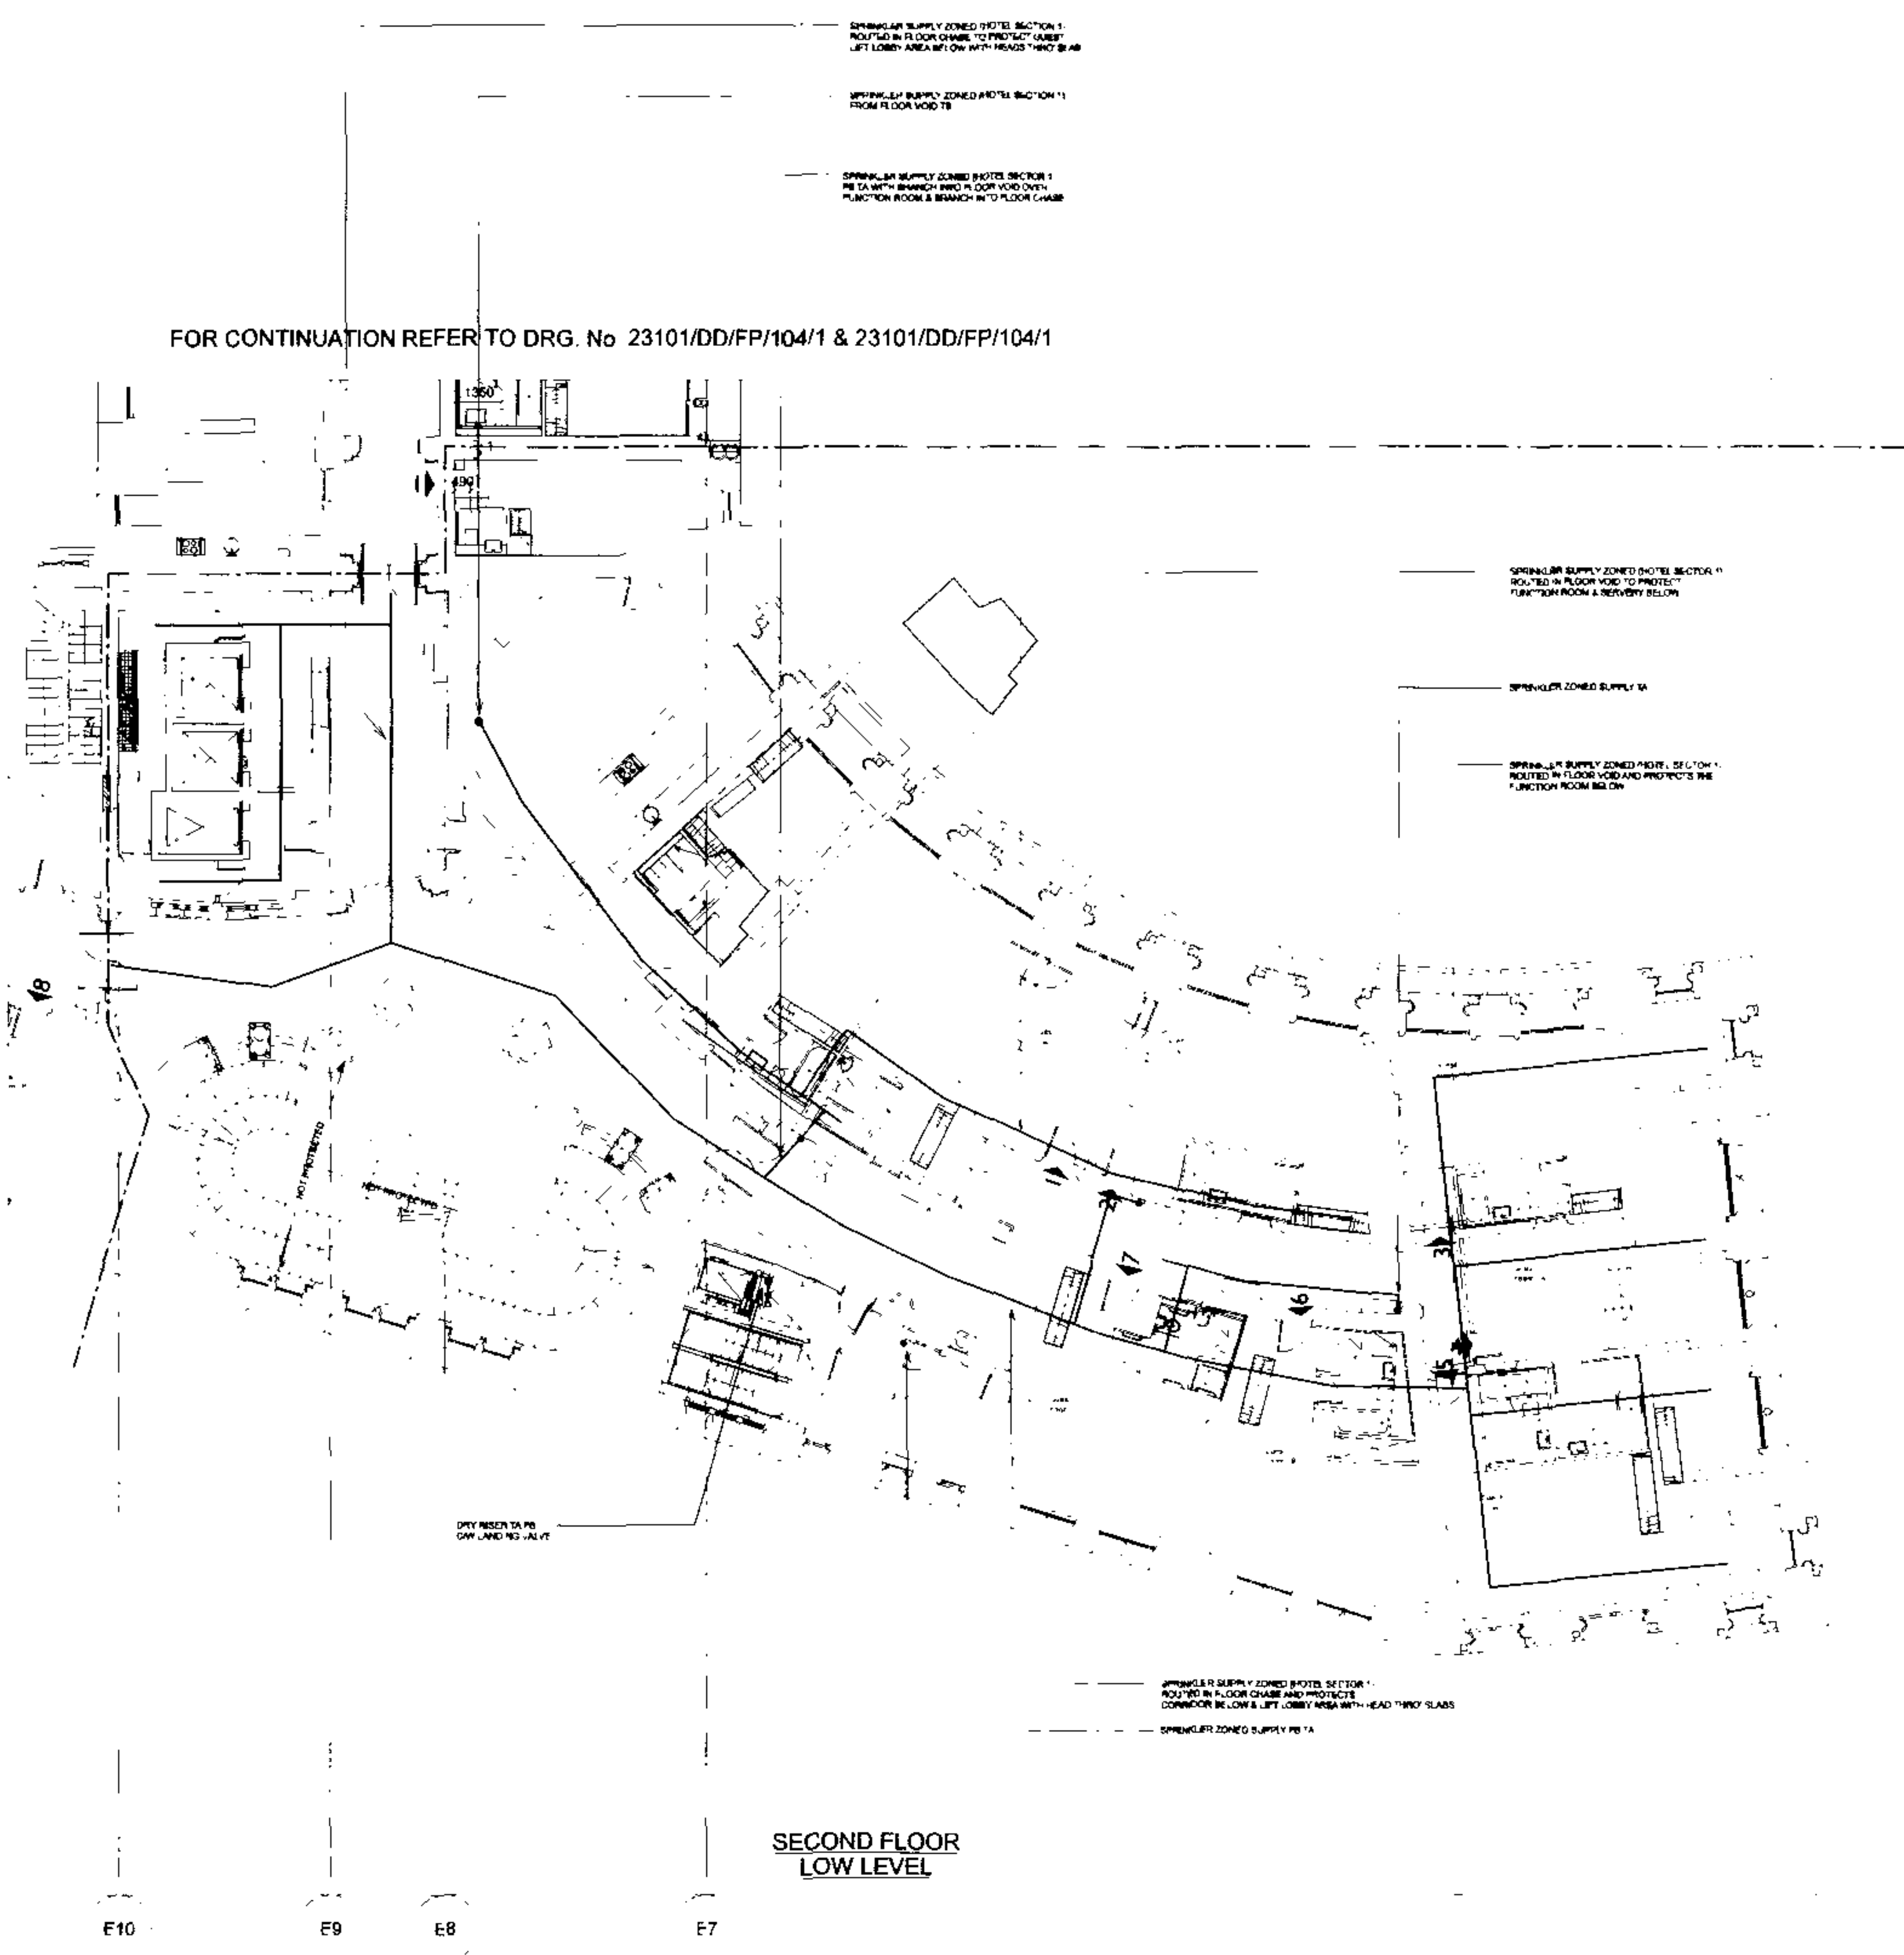

SECOND FLOOR
LOW LEVEL

Rev	1	Date	01/05/08	Drawn	CH	Check	CH
Status							
TENDER DRAWING							
Architect RHWL Architects and RICHARD GRIFFITHS ARCHITECTS 11 Great Street, London WC2E 7BN T: 020 7582 1000 F: 020 7582 1001							
Client Manhattan Loft Corporation Limited							
Project St Pancras Chambers							
Title WEST CHAMBERS SECOND FLOOR FIRE PROTECTION LAYOUT sheet 1 of 4 LOW LEVEL							
Make	PL	CAD	PL				
C% of	100	100	100	Scale	1:100		
App.	DT	Dyle	MAY 08				
FABER MAUNSELL AECOM							
© 23101/DD/FP/204/1 0							

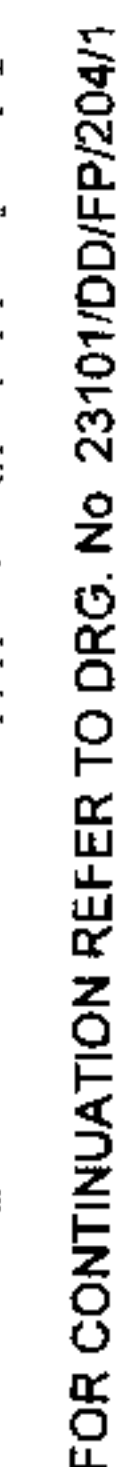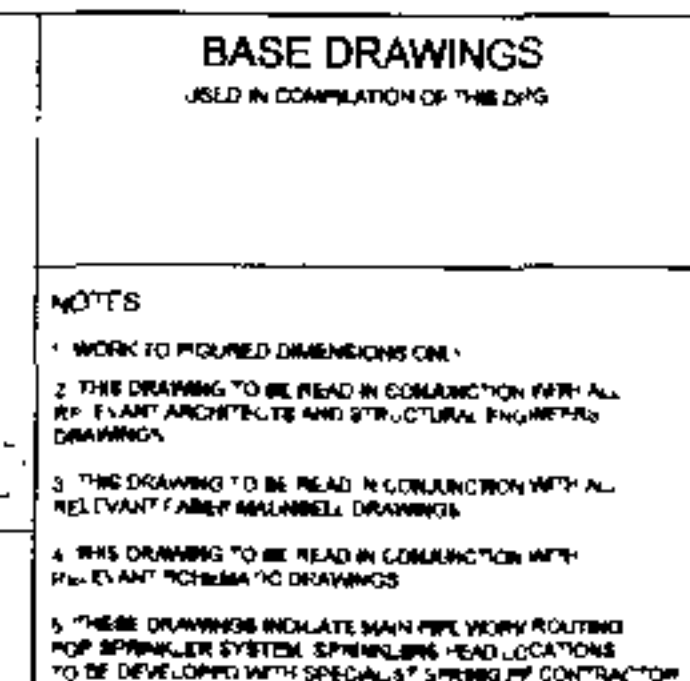

SECOND FLOOR
LOW LEVEL