




BASE DRAWINGS
USED IN COMPLETION OF THIS DRG

- NOTES
1. WORK TO INCLUDE DIMENSIONS ONLY
 2. THIS DRAWING TO BE READ IN CONJUNCTION WITH ALL RELEVANT ARCHITECTURAL AND STRUCTURAL DRAWINGS
 3. THIS DRAWING TO BE READ IN CONJUNCTION WITH ALL RELEVANT FABRICATION DRAWINGS
 4. THIS DRAWING TO BE READ IN CONJUNCTION WITH ALL RELEVANT SCHEMATIC DRAWINGS
 5. THESE DRAWINGS INDICATE MAIN PIPE WORK ONLY, AND FOR SPRINKLER SYSTEMS SPRINKLER HEAD LOCATIONS TO BE DEVELOPED WITH SPECIALIST SPRINKLER CONTRACTOR

FOR CONTINUATION REFER TO DRG. No. 23101/DD/FP/104/1 & 23101/DD/FP/104/2

FOR CONTINUATION REFER TO DRG. No. 23101/DD/FP/204/4

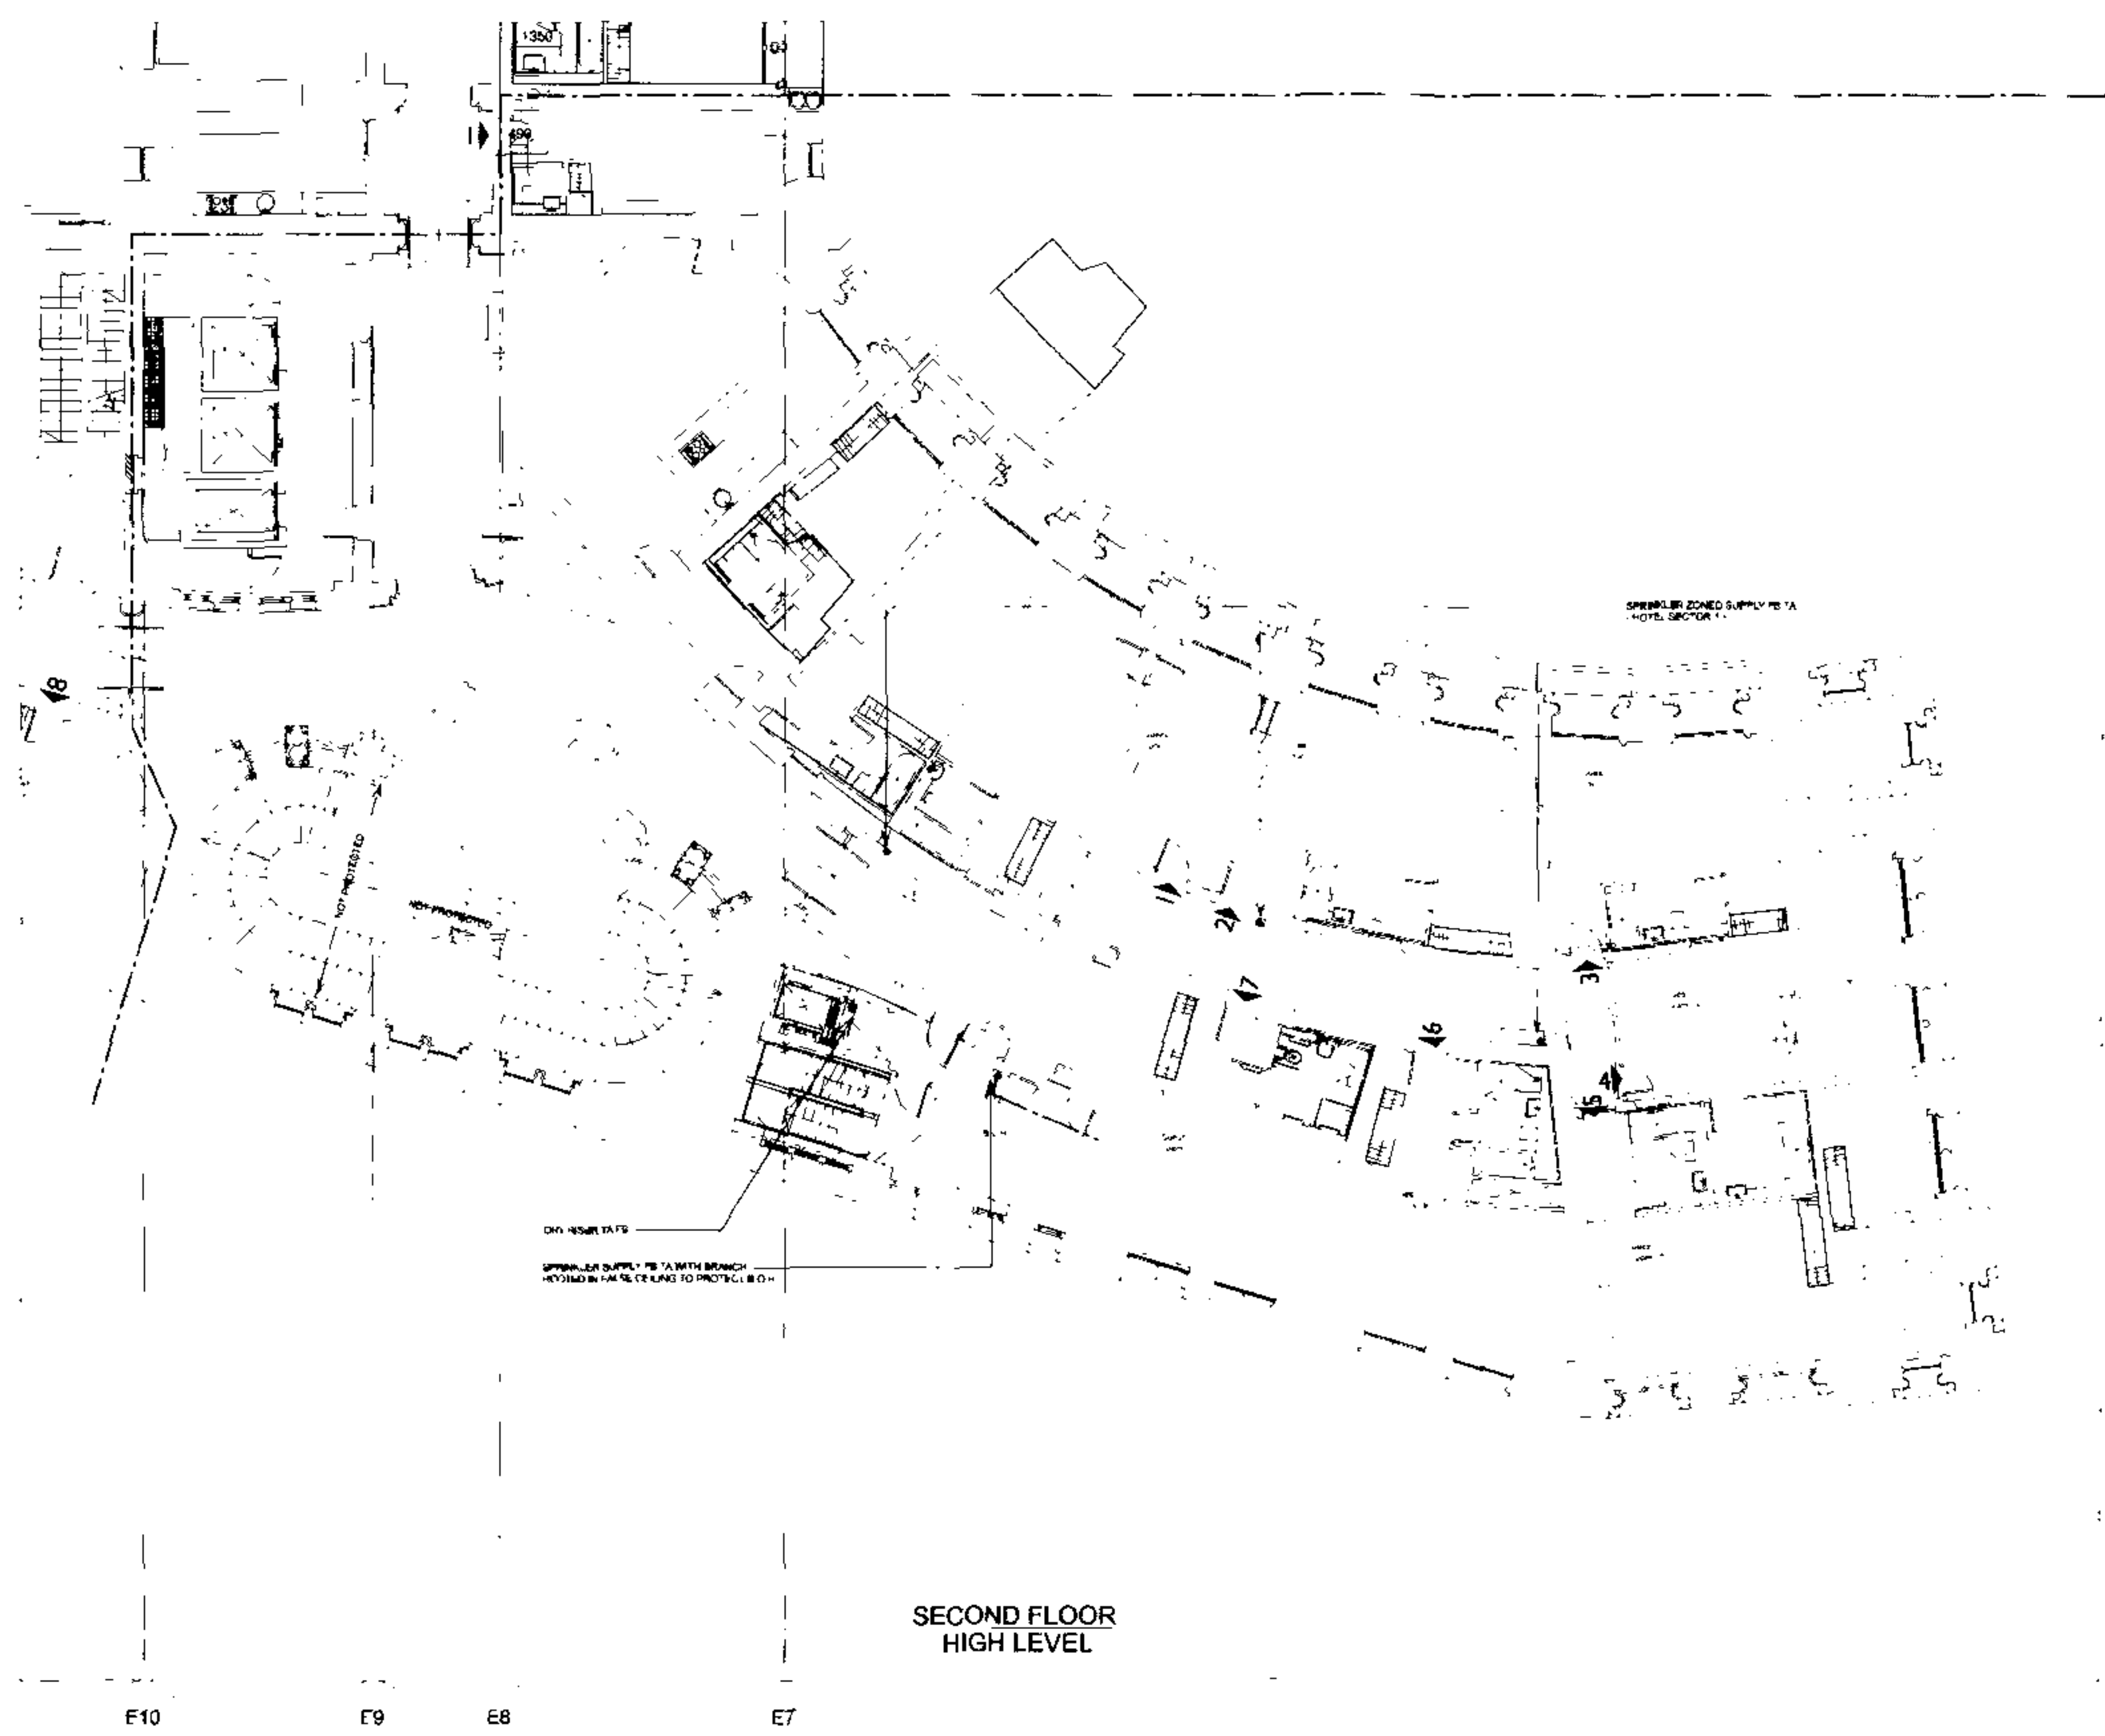

SECOND FLOOR
HIGH LEVEL


Rev	Class	Design	Drawn	Chk	App
STATUS					
TENDER DRAWING					
Architect RHWL Architects or RICHARD GRIFFITHS ARCHITECTS 11 Canal Street, 4th Floor, NEWCASTLE Tel: 01672 779111 Fax: 01672 779111					
Client Manhattan Loft Corporation Limited					
Project St Pancras Chambers					
Title WEST CHAMBERS SECOND FLOOR FIRE PROTECTION LAYOUT sheet 3 of 4 HIGH LEVEL					
Made	Pl	CAD	Pl		
Chk'd	Rev	Scale	1:100		
App	DTF	Date	MAY 06		
FABER MAUNSELL AECOM					
Manhattan Loft 11 Canal Street, 4th Floor NEWCASTLE, Tyne & Wear, NE1 3AF Tel: 01672 779111 Fax: 01672 779111 www.manhattanloft.co.uk					
No. 23101/DD/FP/204/3 0					



BASE DRAWINGS
ISSUED IN COMPLETION OF THIS DRG

NOTES

1. WORK TO PLANNED DIMENSIONS ONLY
2. THIS DRAWING TO BE READ IN CONJUNCTION WITH ALL RELEVANT ARCHITECT'S AND STRUCTURAL ENGINEER'S DRAWINGS
3. THIS DRAWING TO BE READ IN CONJUNCTION WITH ALL RELEVANT FABRIC MANUFACTURER'S DRAWINGS
4. THIS DRAWING TO BE READ IN CONJUNCTION WITH RELEVANT SCHEMATIC DRAWINGS
5. THESE DRAWINGS INDICATE MAIN PIPE ROUTING FOR FIREPROOF LIFELINES. SPRINKLER HEADS LOCATED TO BE SUPPLIED WITH 'SPECIALIST' SPRINKLER HEADS FOR

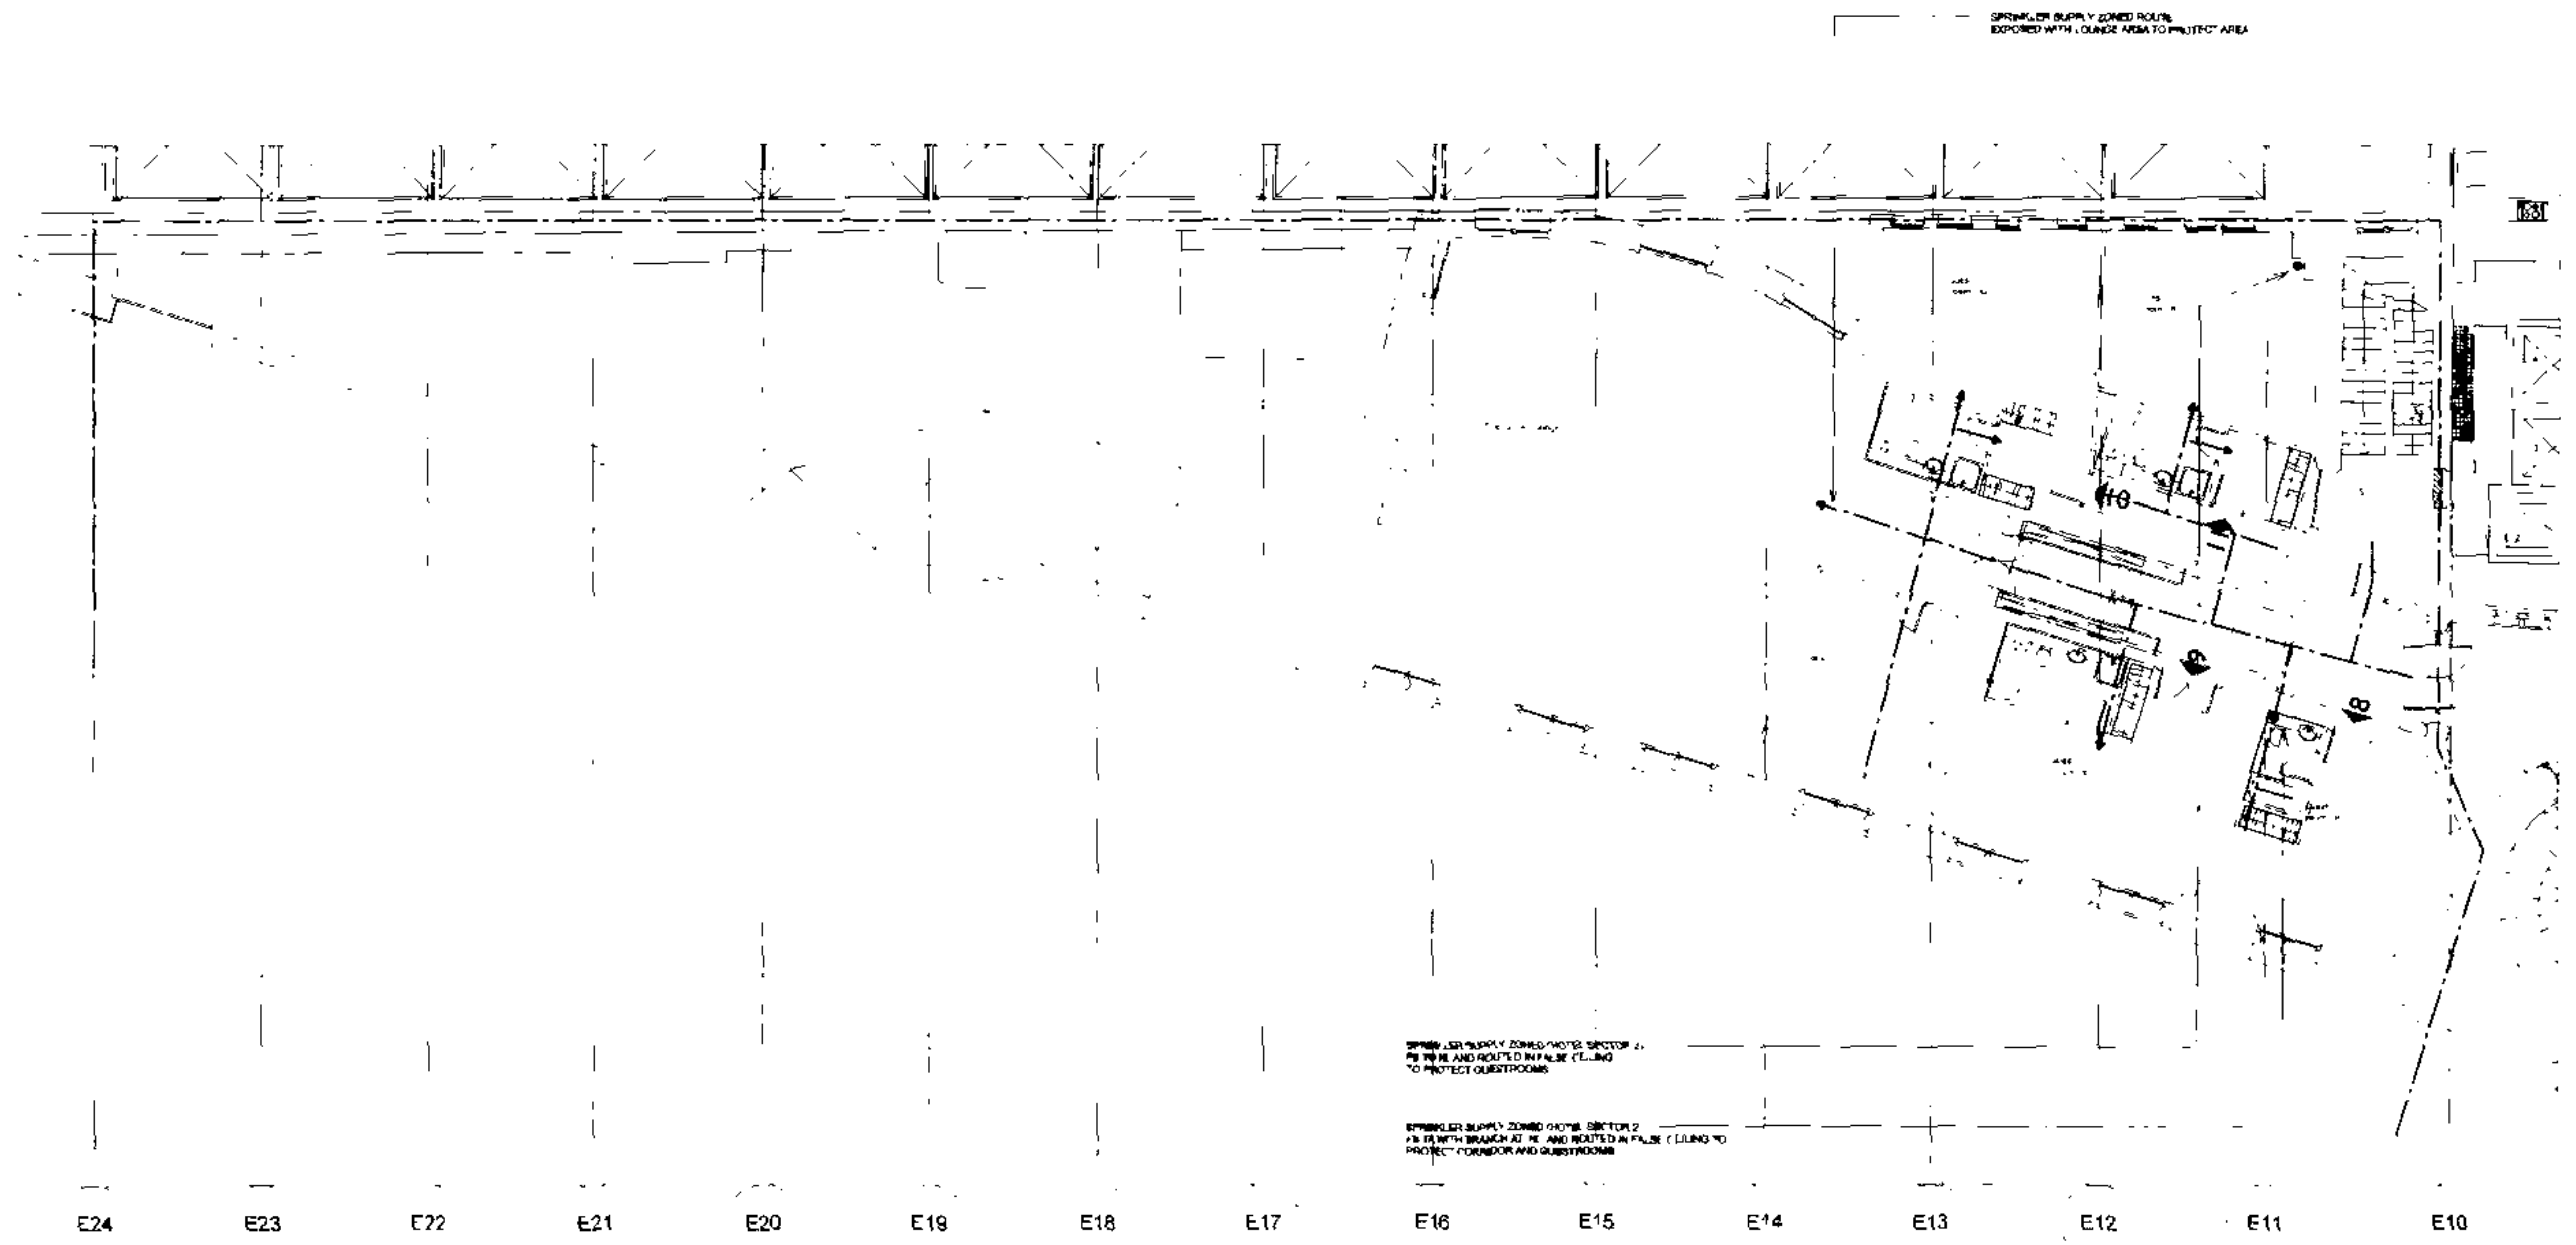


FOR CONTINUATION REFER TO DRG No 23101/DD/FP/204/4



**SECOND FLOOR
HIGH LEVEL**

Status	
TENDER DRAWING	
Architect RHWL Architects and RICHARD GRIFFITHS ARCHITECTS 7 Luffield Road, London WC1E 3BT T: 020 7779 1000 F: 020 7779 1001	
Client Manhattan Loft Corporation Limited	
Project St Pancras Chambers	
Title WEST CHAMBERS SECOND FLOOR FIRE PROTECTION LAYOUT sheet 4 of 4 HIGH LEVEL	
Drawn	PL
Checked	PL
App'd	DTE
Date	MAY 08
Scale 1:100	
FABER MAUNSELL AECOM	
Head Office: 100 Broad Street, Birmingham B1 2HT Tel: 0121 635 5700 Fax: 0121 635 5701 www.fabermaunsell.com	
Project Office: 23101/DD/FP/204/4	
Revision 0	

This document is the property of Faber Maunsell and is to be used for the purpose for which it was prepared. It is not to be used for any other purpose without the written consent of Faber Maunsell. This document shall not be reproduced, stored in a retrieval system, or transmitted in any form or by any means, electronic, mechanical, photocopying, recording, or by any information storage and retrieval system, without the prior written permission of Faber Maunsell.

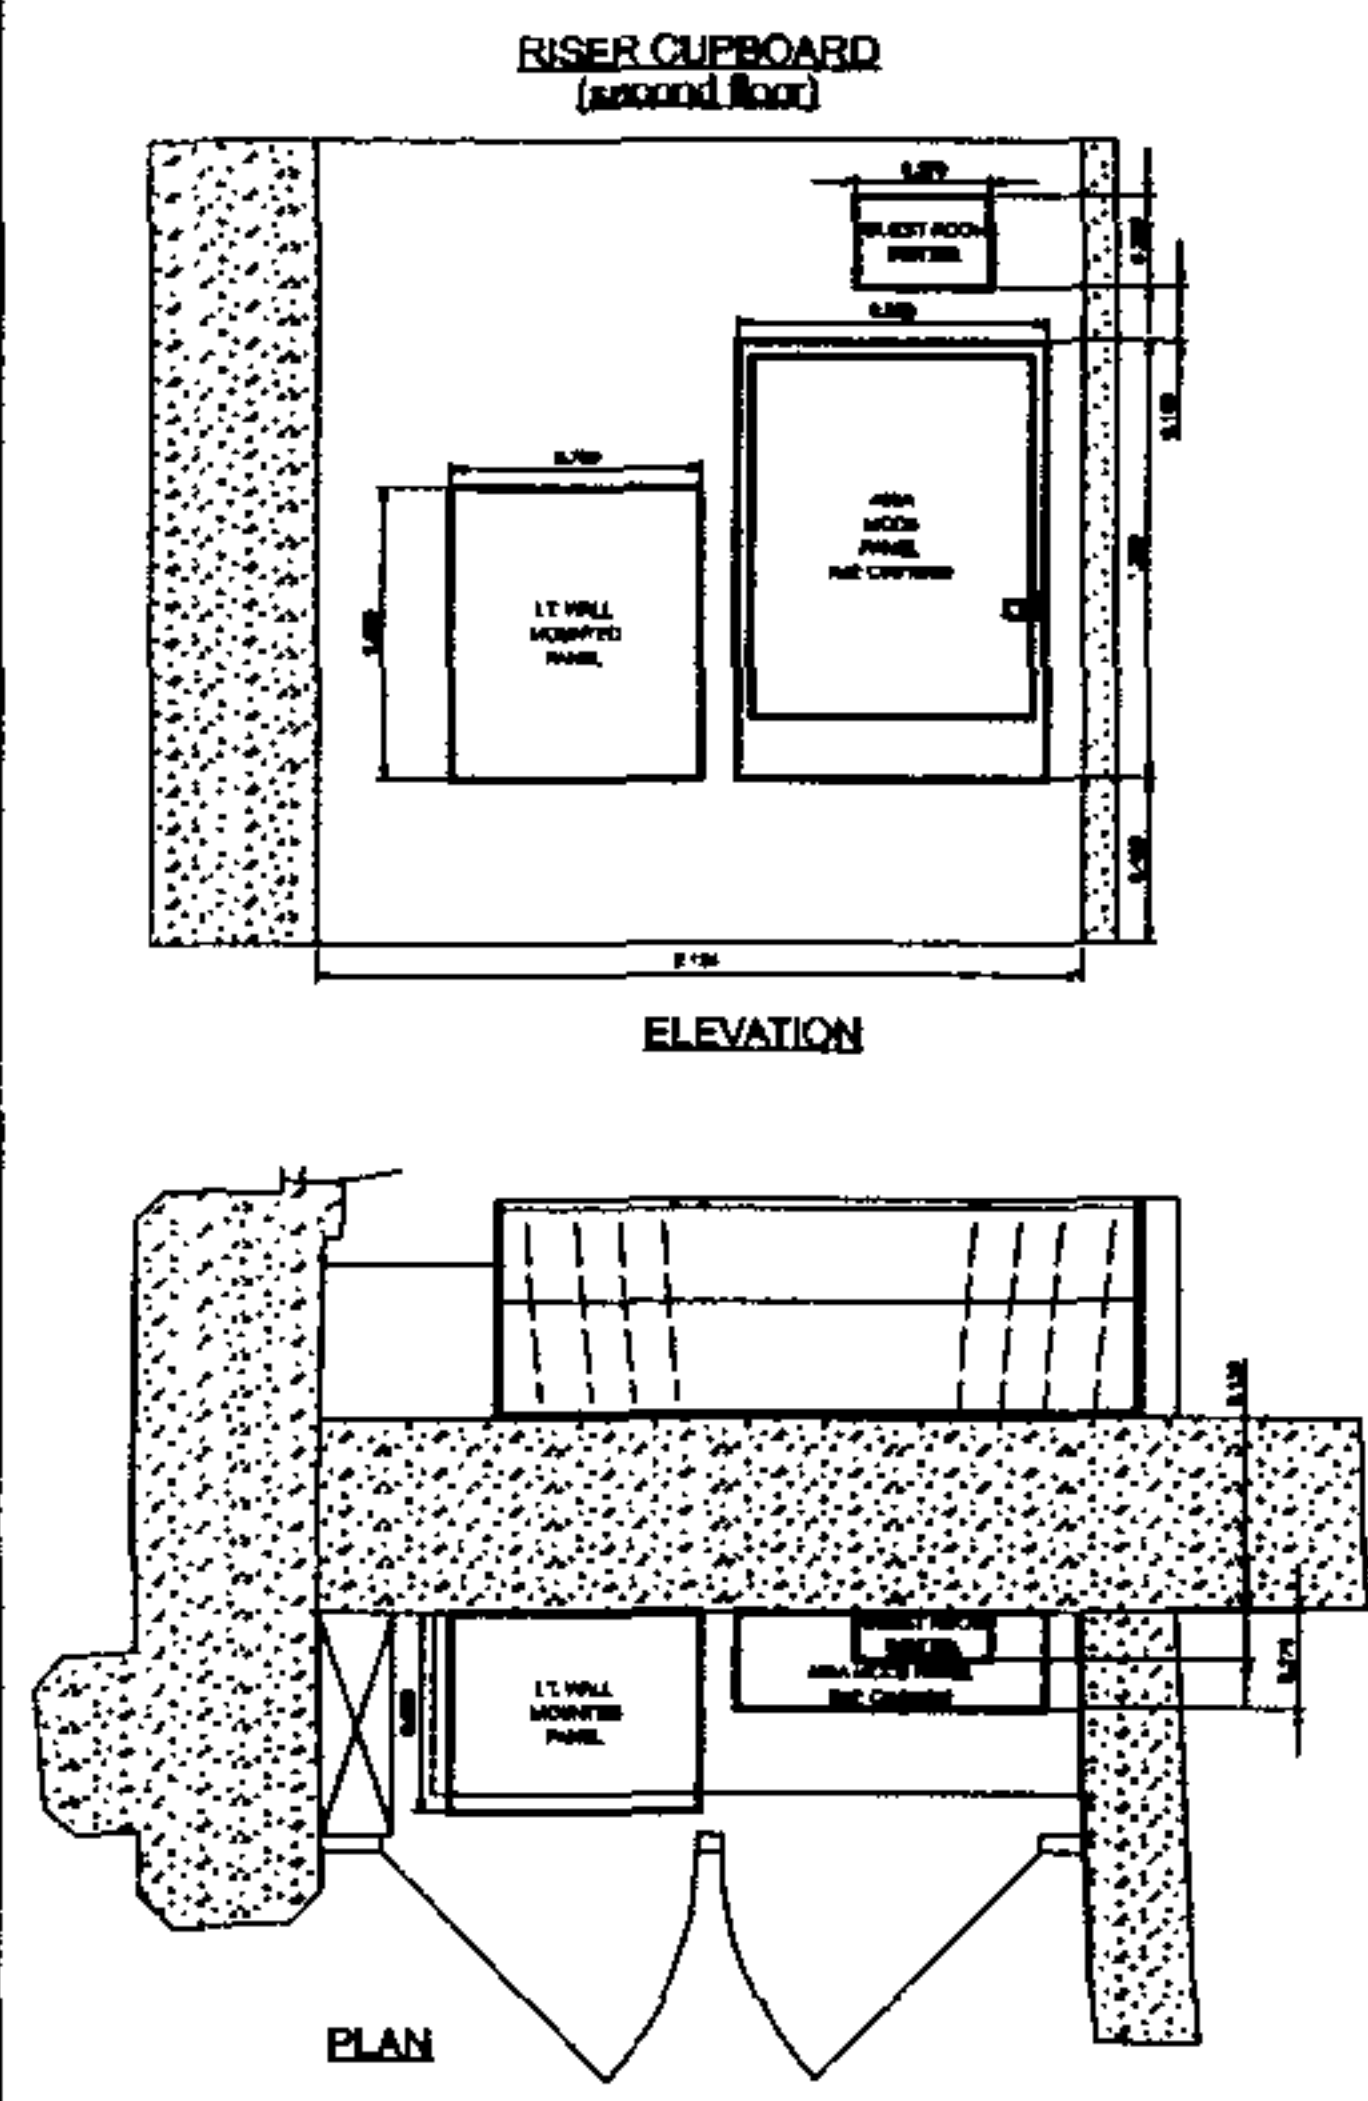

FOR CONTINUATION REFER TO DRG. No. 23101/DD/E/204/2

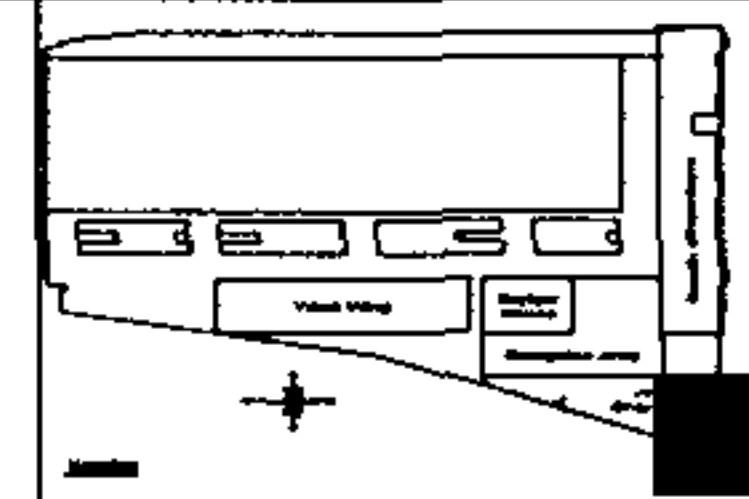
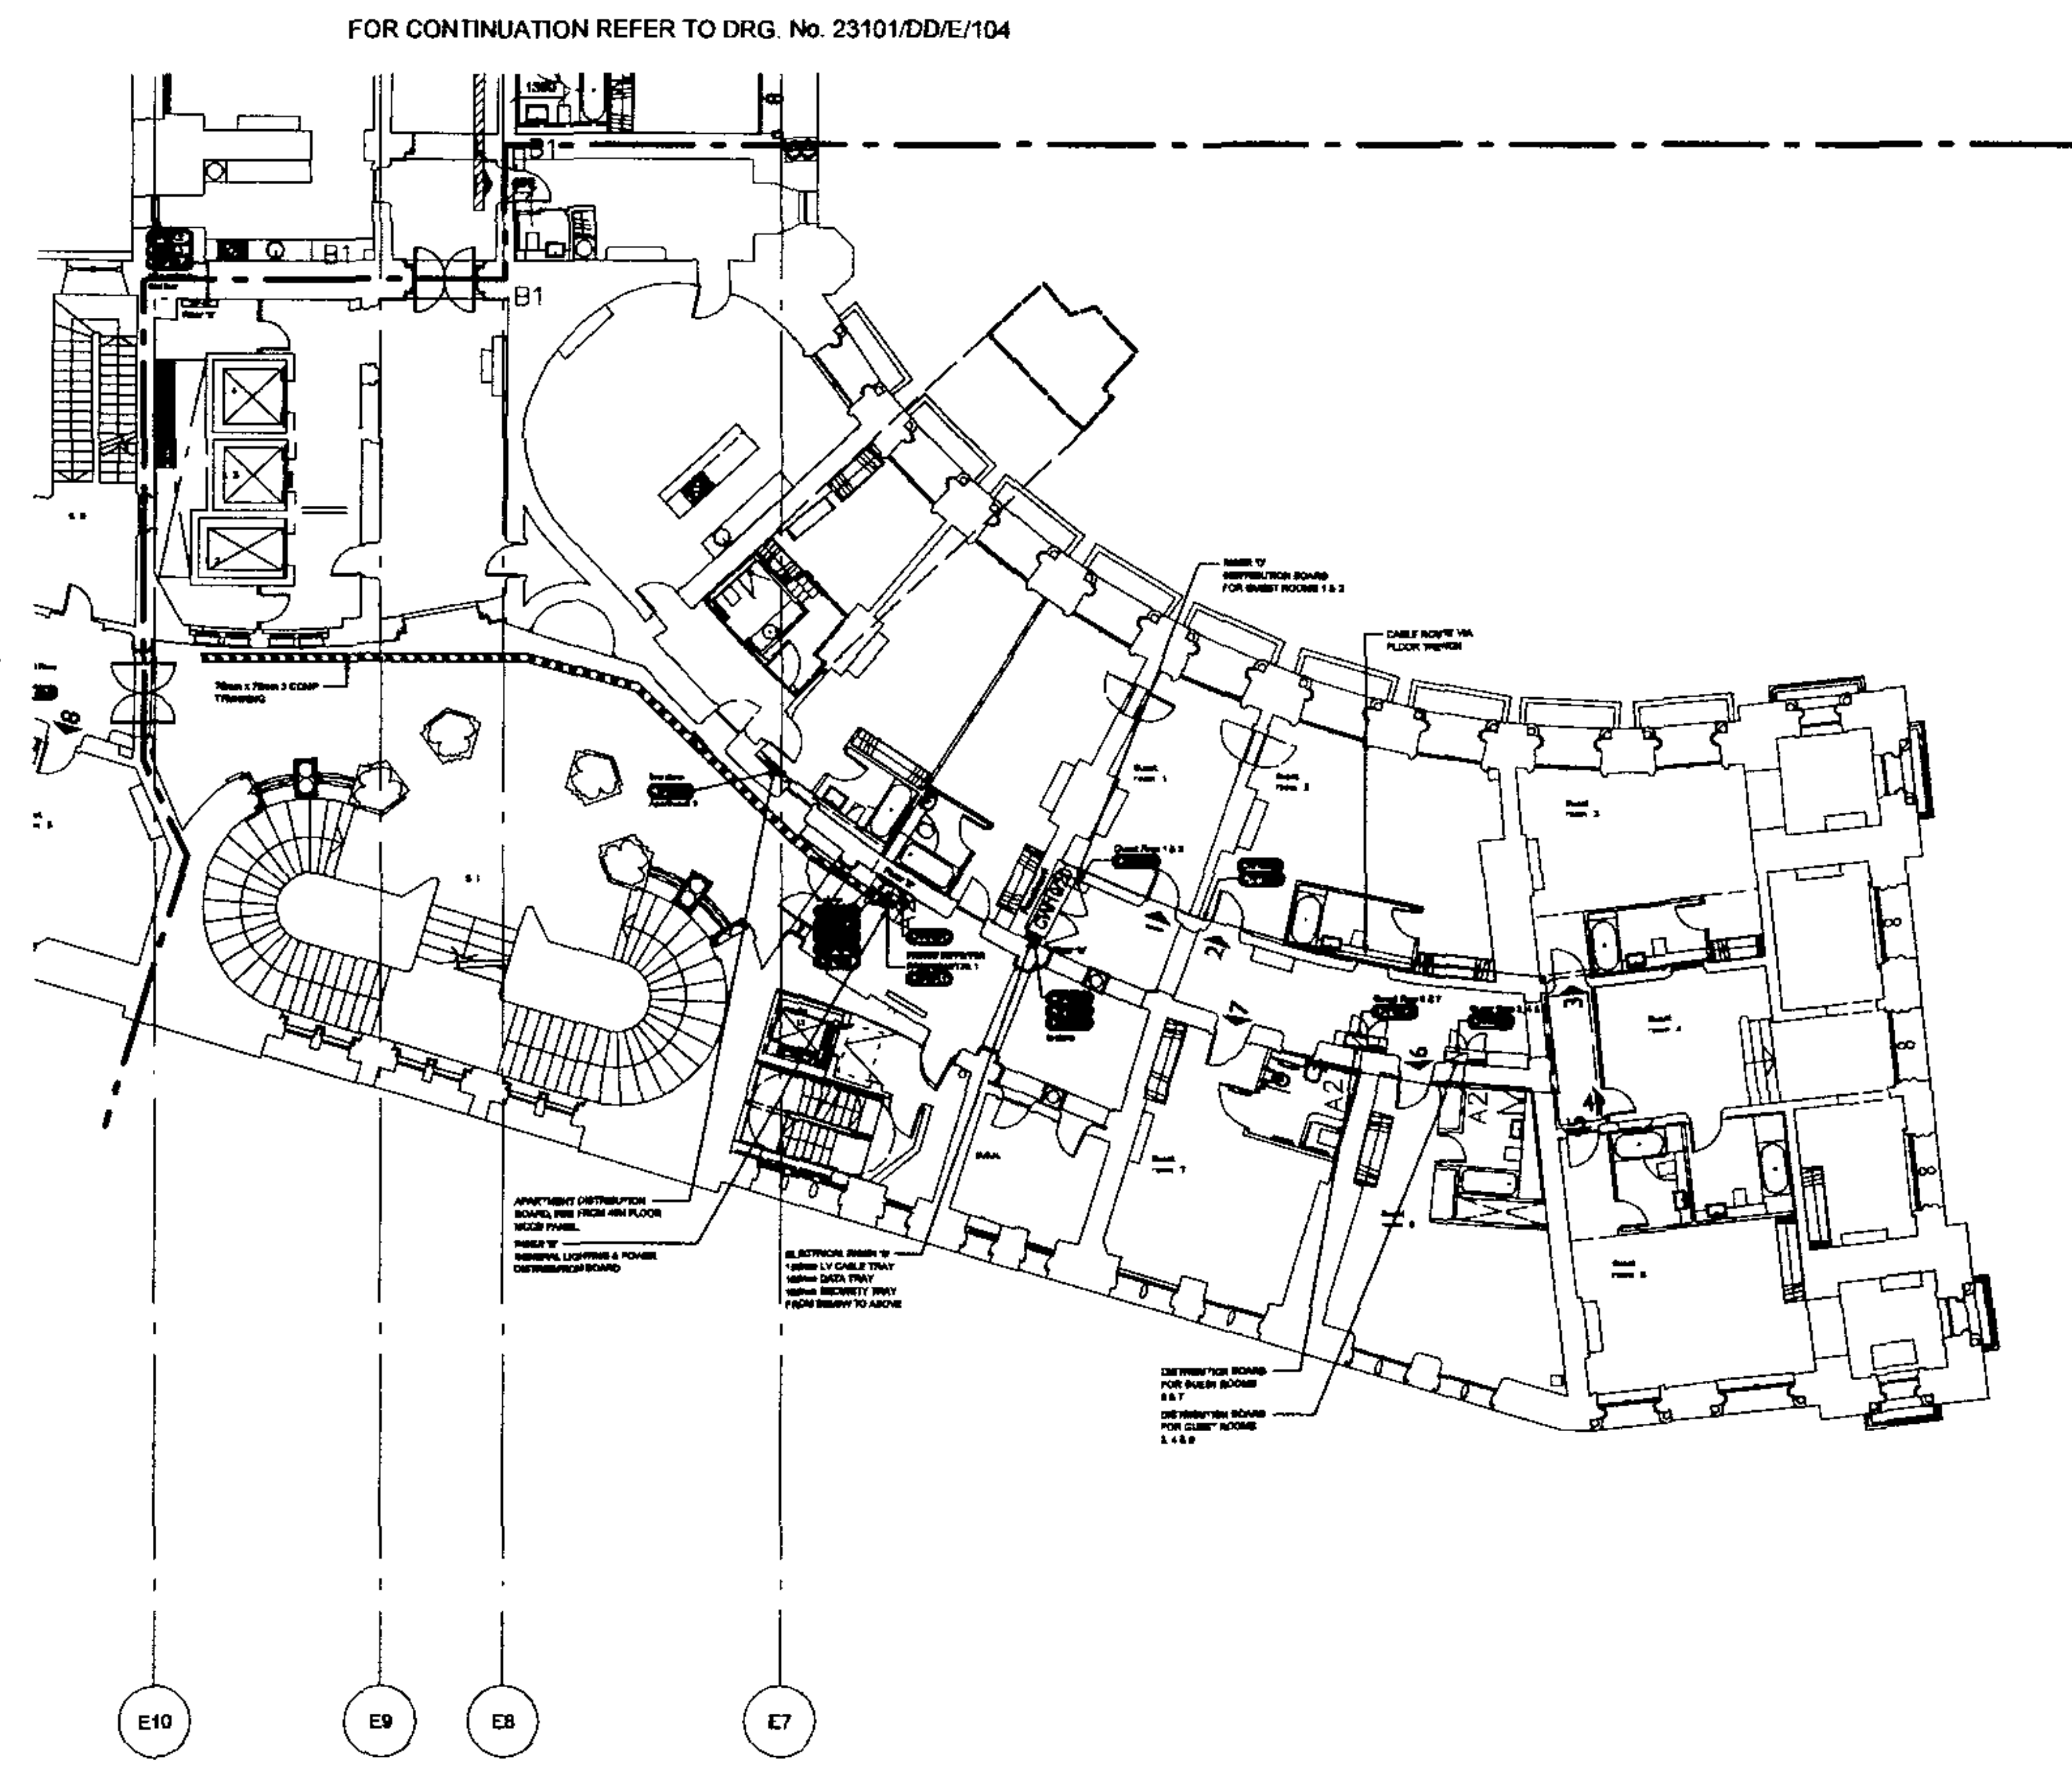


BASE DRAWINGS
USED IN CONJUNCTION OF THIS ONE
THIS PLAN, DRG. No. 23101/DD/E/104
AND 23101/DD/E/105

NOTES

1. WORK TO BE DONE IN CONJUNCTION WITH ALL RELEVANT ARCHITECTURAL AND STRUCTURAL DRAWINGS.
2. THIS DRAWING TO BE USED IN CONJUNCTION WITH ALL RELEVANT ELECTRICAL DRAWINGS.
3. FOR MORE DETAILS REFER TO DRG. No. 23101/DD/E/104 AND 23101/DD/E/105.

No.	Rev.	Date	By	Chk.	App.
TENDER DRAWING					
Architect RHWL Architects and RICHARD GRIFFITHS ARCHITECTS 7, Broad Street, London, W1C 1JH Tel: 020 7493 8888 Fax: 020 7493 8889					
Client Manhattan Loft Corporation Limited					
Project St Pancras Chambers					
Title WEST CHAMBERS SECOND FLOOR ELECTRICAL DISTRIBUTION LAYOUT sheet 1 of 2					
Drawn	R.T.G.	C.A.D.	P.C.		
Check	R.T.G.	Scale	1:100		
App.	S.P.	Date	MAY 08		
FABER MALINSSELL AECOM					
N°. 23101/DD/E/204/1 0					

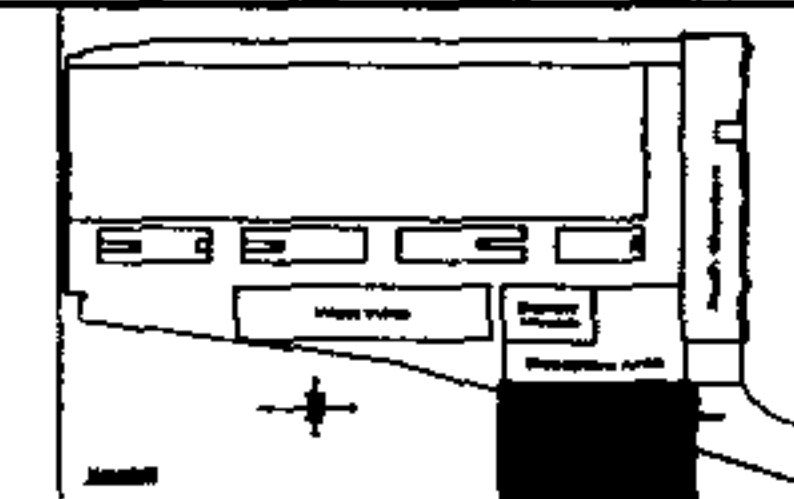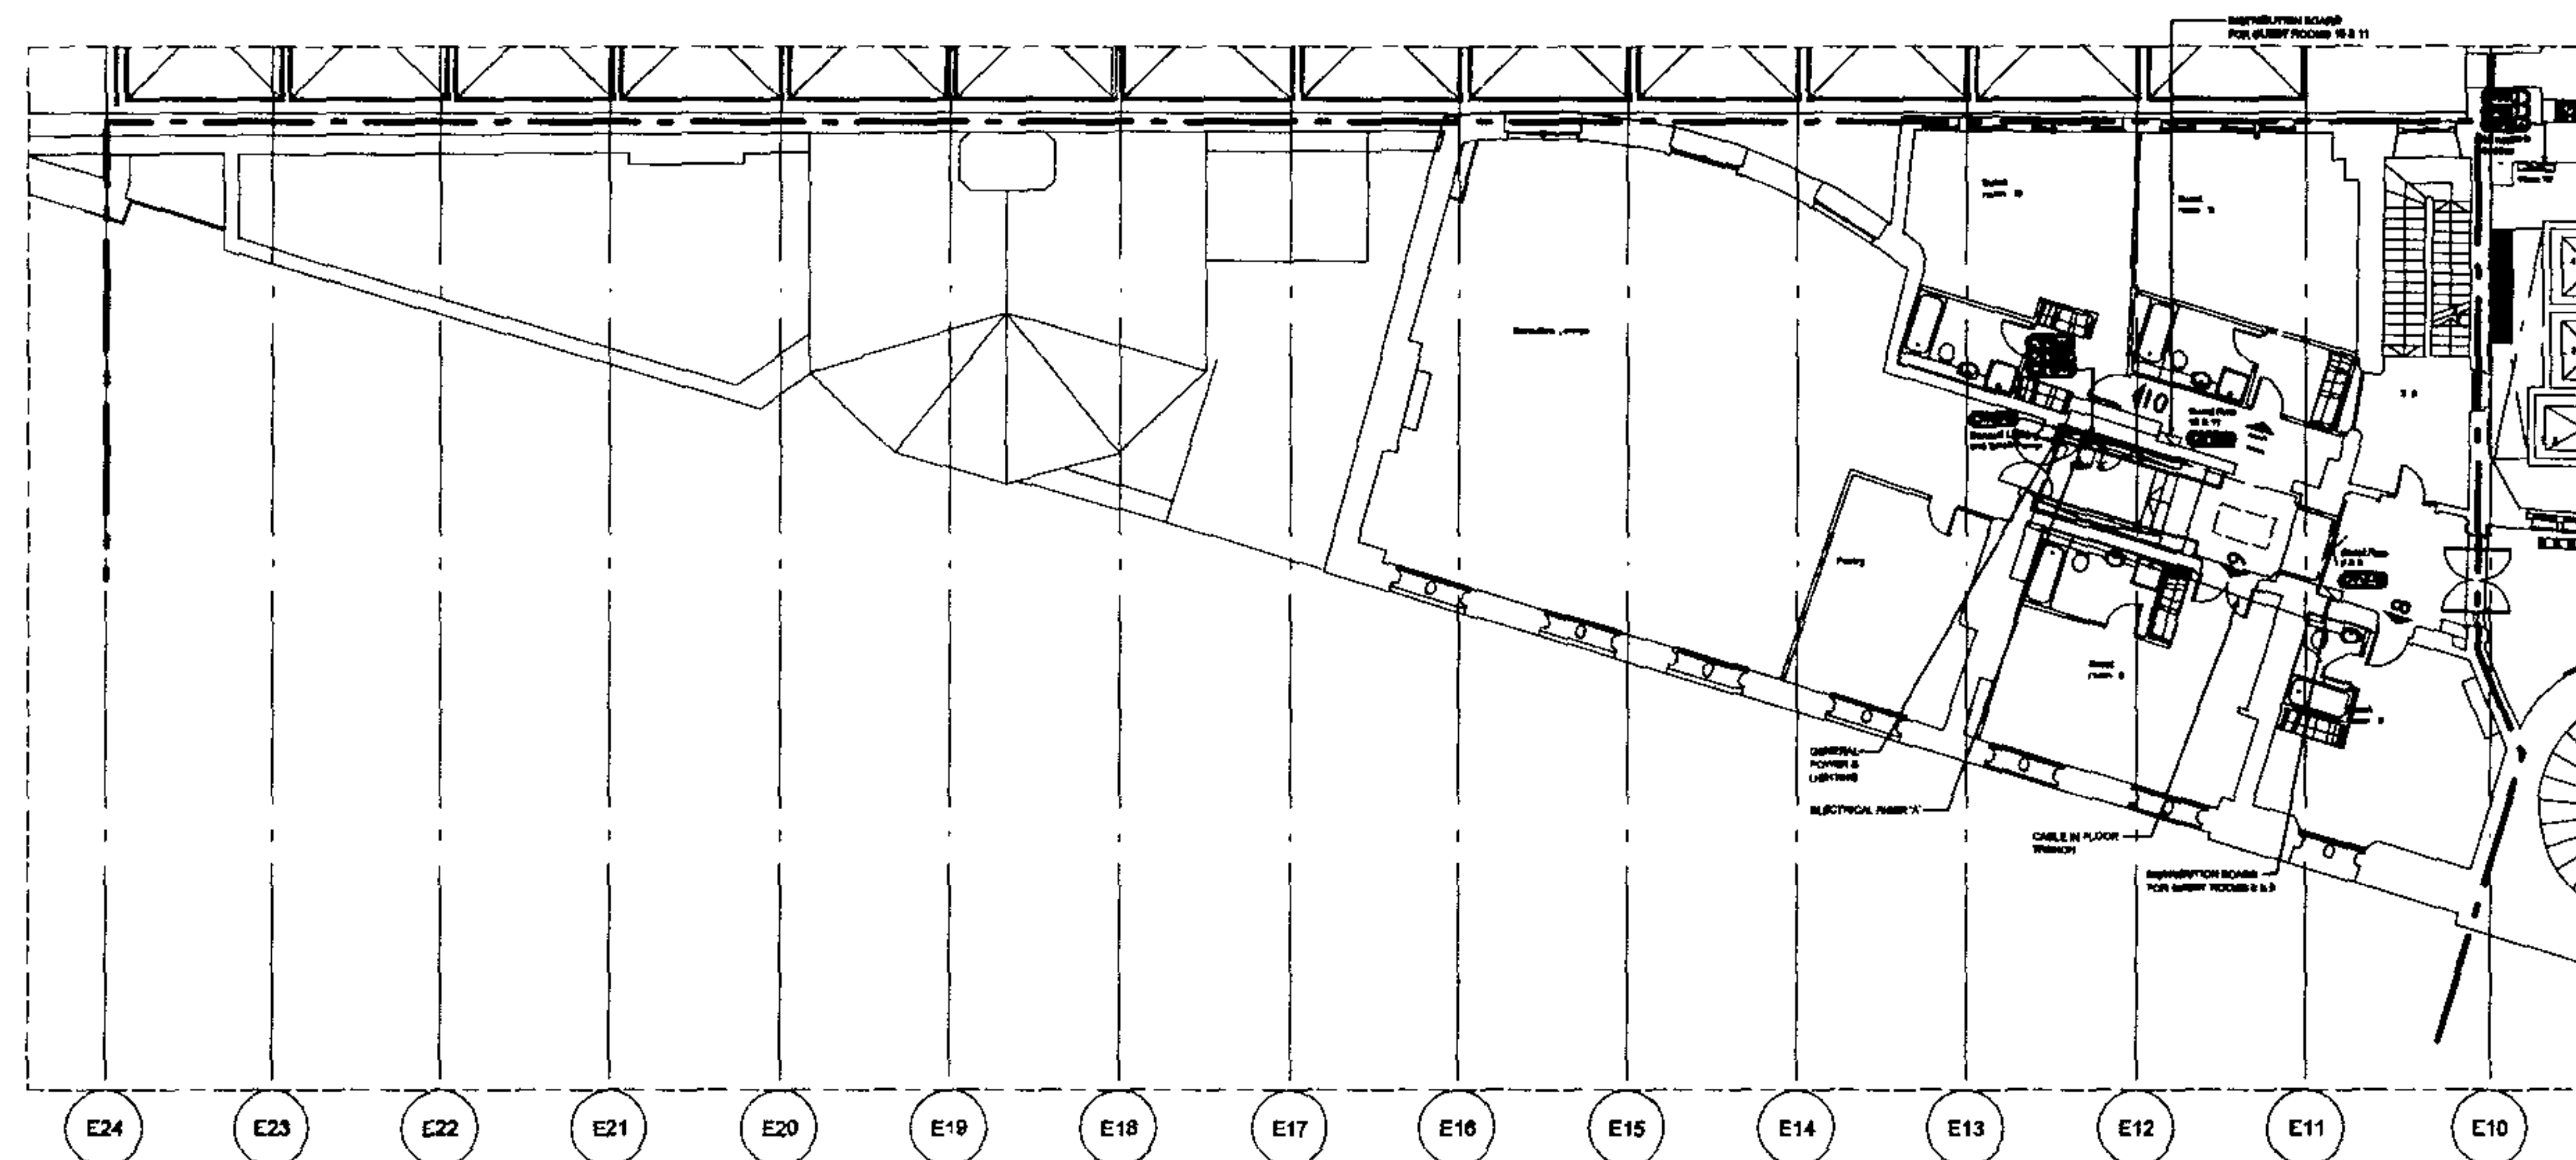

	BASE DRAWINGS
--	---------------

1940 IN COMPLETION OF THIS CASE

On 10/17/2008 10:00:00 AM, [REDACTED] wrote:

NOTES

1. WORDS TO PRINTED ORIGINATOR ONLY.
2. THIS EMPLOYER TO BE READ IN COMPLETION OF

RELEVANT ARCHITECTS AND STRUCTURAL ENGINEERS.

2. THE SHAPING TO BE DONE IN CONSTRUCTION OF
FOLLOWING FORMS MANUSCRIPT UPON

4. THIS DOCUMENT IS TO BE READ IN CONJUNCTION WITH
SERIALS-6700 DISPOSITION.

5 FOR FURTHER DETAILS REFER TO DND FORMS Z310-6
AND Z310-6C/D/E/F/G/H/I/J/K/L/M/N/O/P/Q/R/S/T/U/V/W/X/Y/Z.

1. *Journal of the American Medical Association*, 2000; 283: 2689-2693.

1. *Journal of Management Studies*, 1990, 27, 1, 1-14.

1. *Journal of the American Medical Association*, 2000; 283: 2686-2692.

1. *Journal of the American Medical Association*, 2000; 284: 2689-2695.

Row	State	Debit	Credit	Cost

**TENDER
DRAWING**

Architect
RHWA Architects
and
RICHARD GRIFFITHS ARCHITECT
17 South Street, London WC2N 6EE
T. 020 7490 7000 F. 020 7490 4000

Client:
**Manhattan Loft
Corporation Limited**


Project	St Pancras Chamber
---------	--------------------

Title WEST CHAMBERS
SECOND FLOOR
ELECTRICAL DISTRIBUTION
LAYOUT
sheet 2 of 2

Modo	R.T.G.	C.A.D.
Ckd	Scale	1
App.	S.P.	Date

FABER MALINSELL AE
 Birmingham House
 1000 Montgomery Road
 Birmingham, North Carolina 27501-3097
 T 404 882 2100
 F 404 882 2101
 WWW.FABERMALINSELL.COM


No. 23101/DD/E/2042

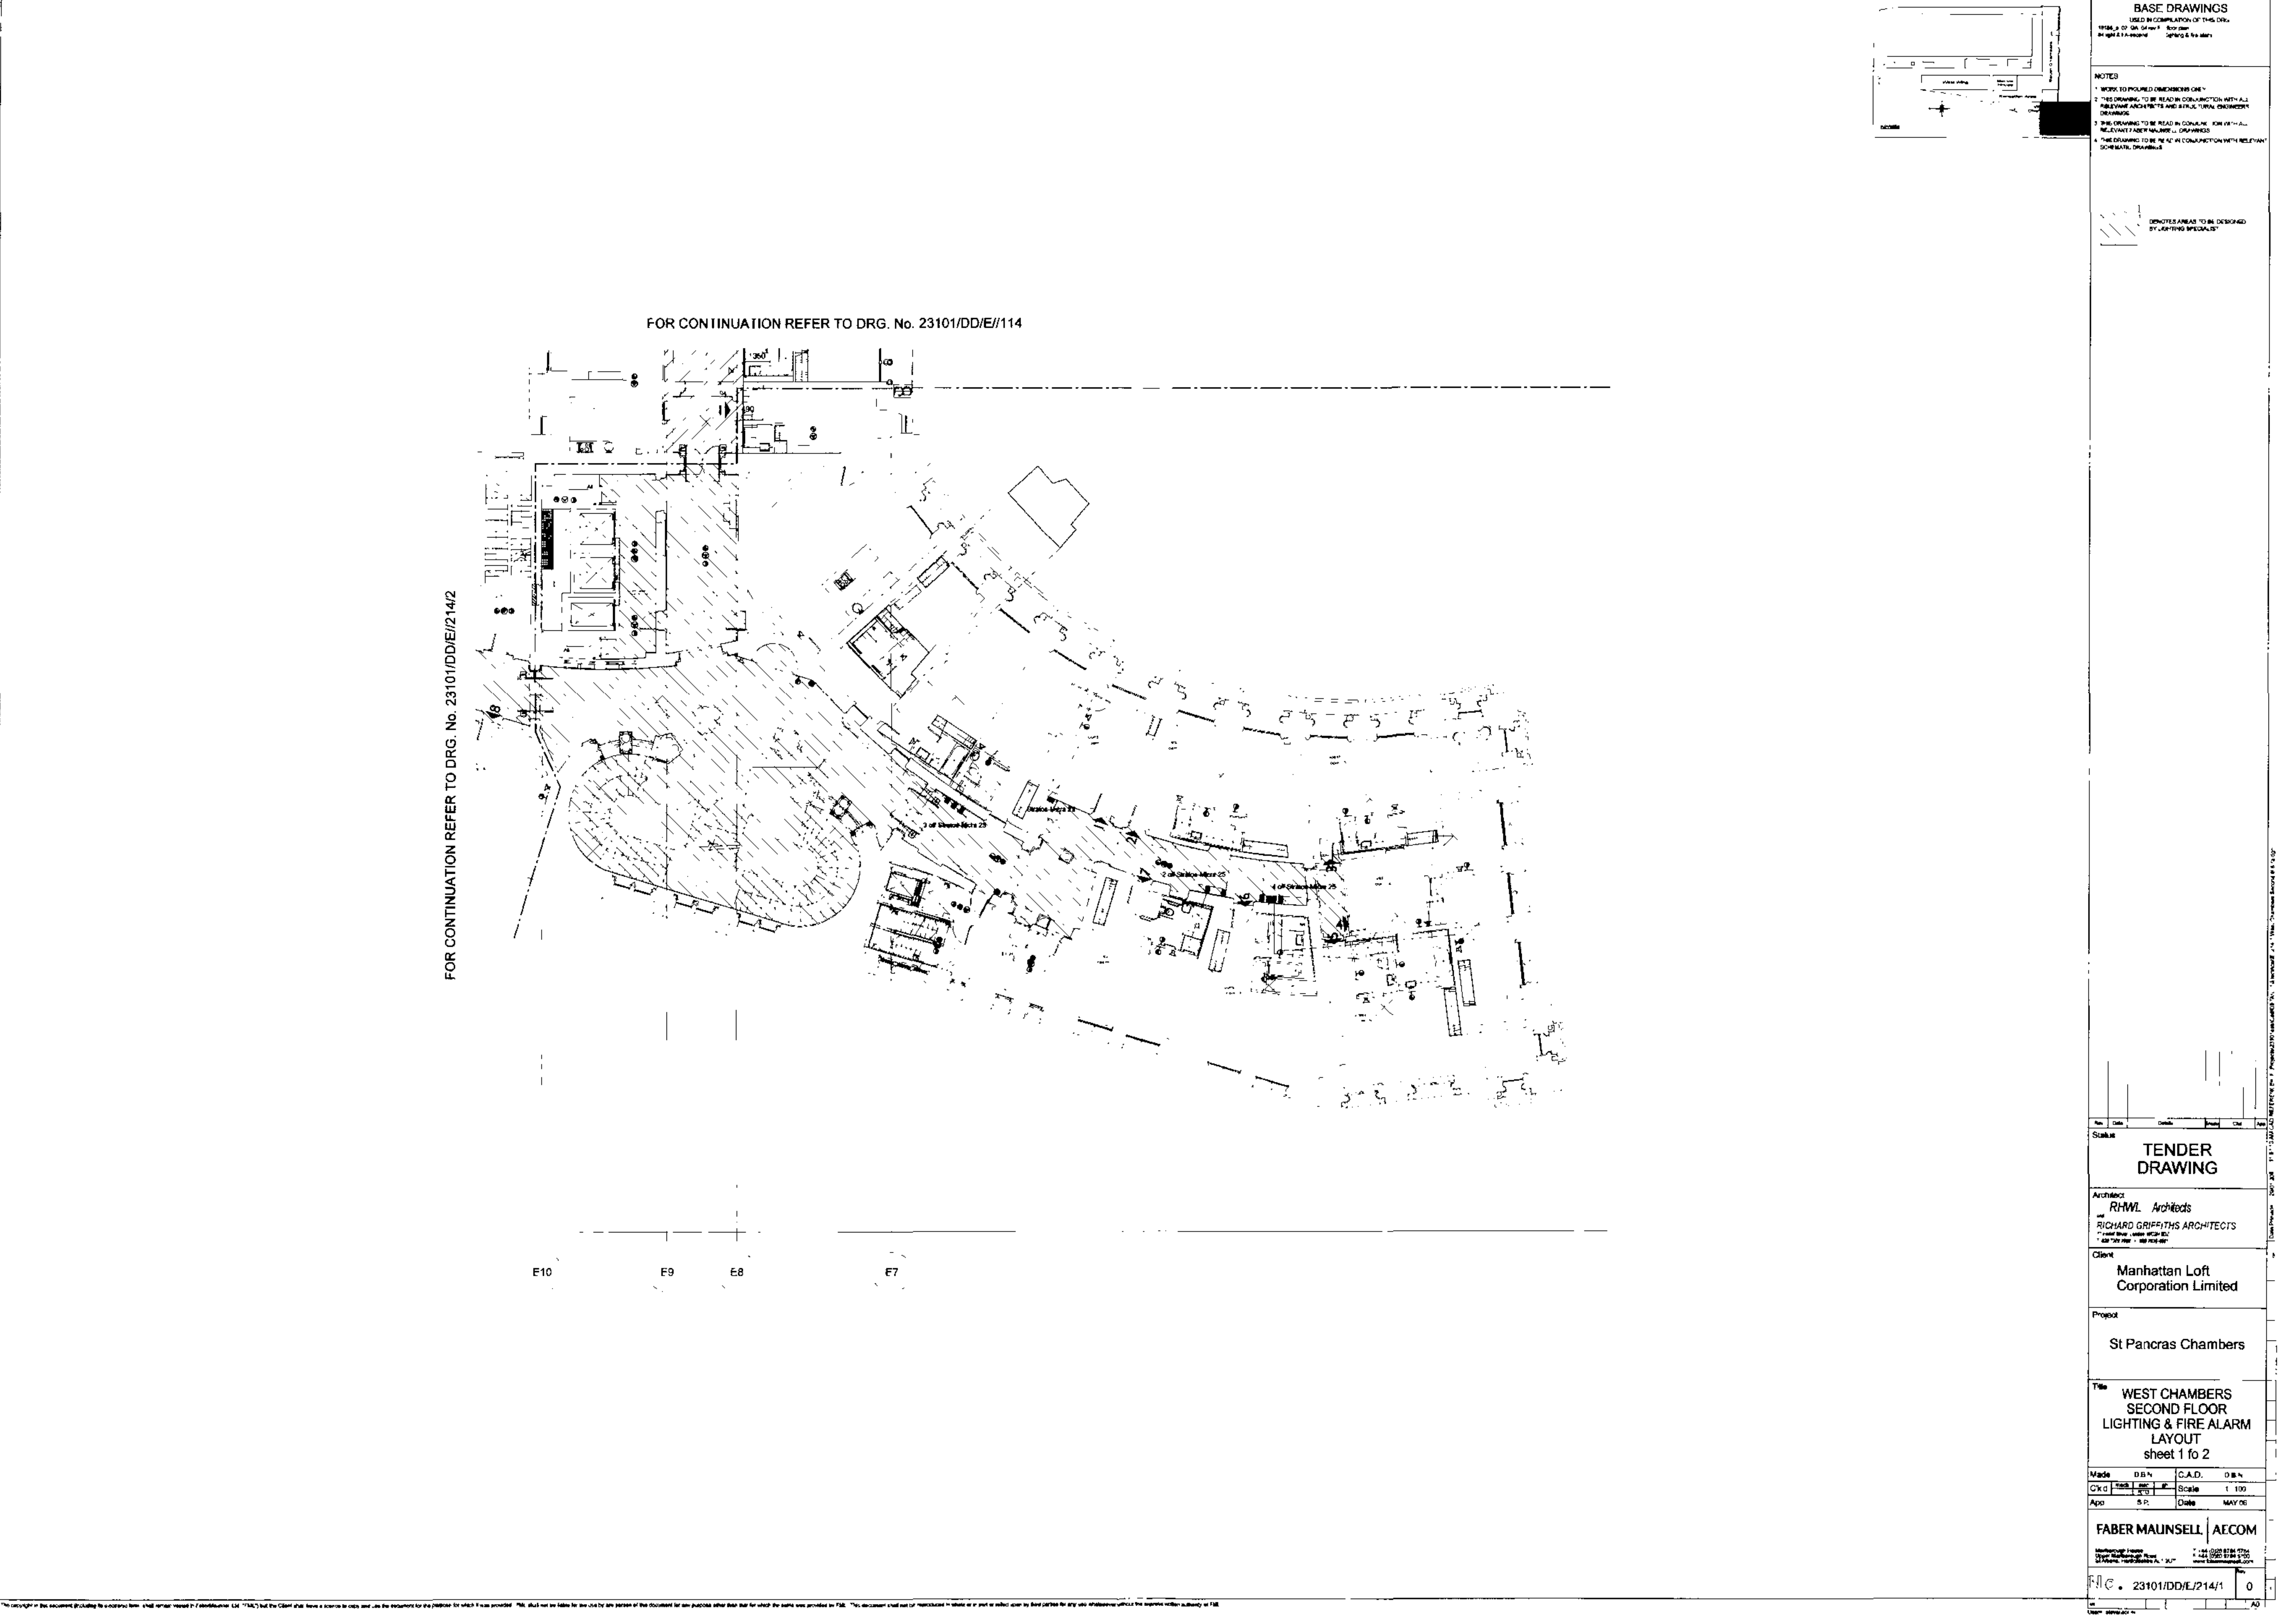

FOR CONTINUATION REFER TO DRG. No. 23101/DD/E/114

FOR CONTINUATION REFER TO DRG. No. 23101/DD/E/214/2

E10 E9 E8 E7

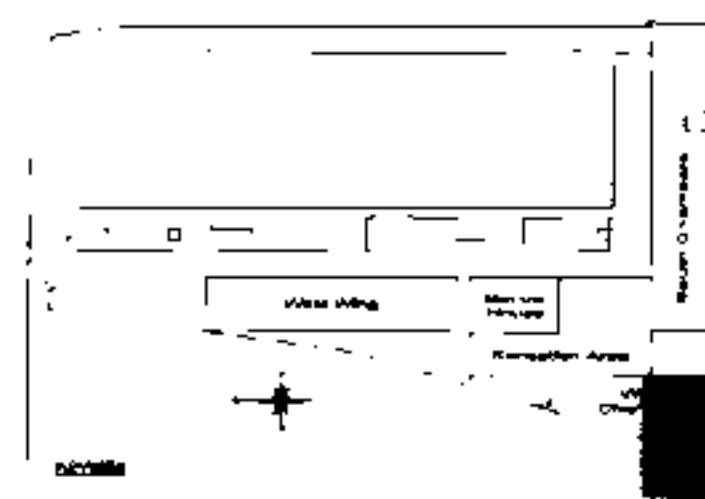


BASE DRAWINGS
USED IN COMPLETION OF THIS DRAWING
1. BASE DRAWING
2. BASE DRAWING
3. BASE DRAWING
4. BASE DRAWING

NOTES
1. WORK TO POLYMER DIMENSIONS ONE
2. THIS DRAWING TO BE READ IN CONJUNCTION WITH ALL
RELEVANT ARCHITECTURAL AND STRUCTURAL DRAWINGS
3. THIS DRAWING TO BE READ IN CONJUNCTION WITH ALL
RELEVANT ELECTRICAL DRAWINGS
4. THIS DRAWING TO BE READ IN CONJUNCTION WITH ALL
RELEVANT MECHANICAL DRAWINGS

1
2
3
100

1
2
3
100

Rev	Date	Details	Drawn	Check	By
Status					
TENDER DRAWING					
Architect RHWL Architects RICHARD GRIFFITHS ARCHITECTS 100 West Street, London EC2A 3DF T: 020 7460 1000 F: 020 7460 1001					
Client Manhattan Loft Corporation Limited					
Project St Pancras Chambers					
Title WEST CHAMBERS SECOND FLOOR LIGHTING & FIRE ALARM LAYOUT sheet 1 of 2					
Made	DBN	CAD	DBN		
Chk'd	DBN	Scale	1:100		
App'd	S.P.	Date	MAY 06		
FABER MAUNSELL AECOM					
Project No. 23101/DD/E/214/1					
Sheet No. 0					

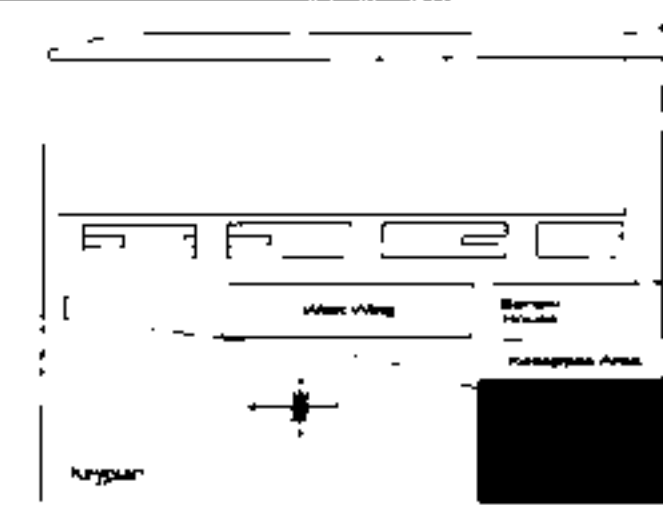

BASE DRAWINGS


USED IN COMBINATION OF THE DRG
1000, 200, 300, 400, 500, 600, 700, 800, 900, 1000
OR ANY OF THE ABOVE

NOTES

1. WORK TO REQUIRED DIMENSIONS ONLY
2. THIS DRAWING TO BE READ IN CONJUNCTION WITH ALL
RELEVANT ARCHITECT'S AND STRUCTURAL ENGINEER'S
DRAWINGS
3. THIS DRAWING TO BE READ IN CONJUNCTION WITH ALL
ELECTRICAL PARTS MANUFACTURING DRAWINGS
4. THIS DRAWING TO BE READ IN CONJUNCTION WITH ALL
SCHEMATIC DRAWINGS




STRUCTURE TO BE DEMOLISHED
BY EXISTING SYSTEM

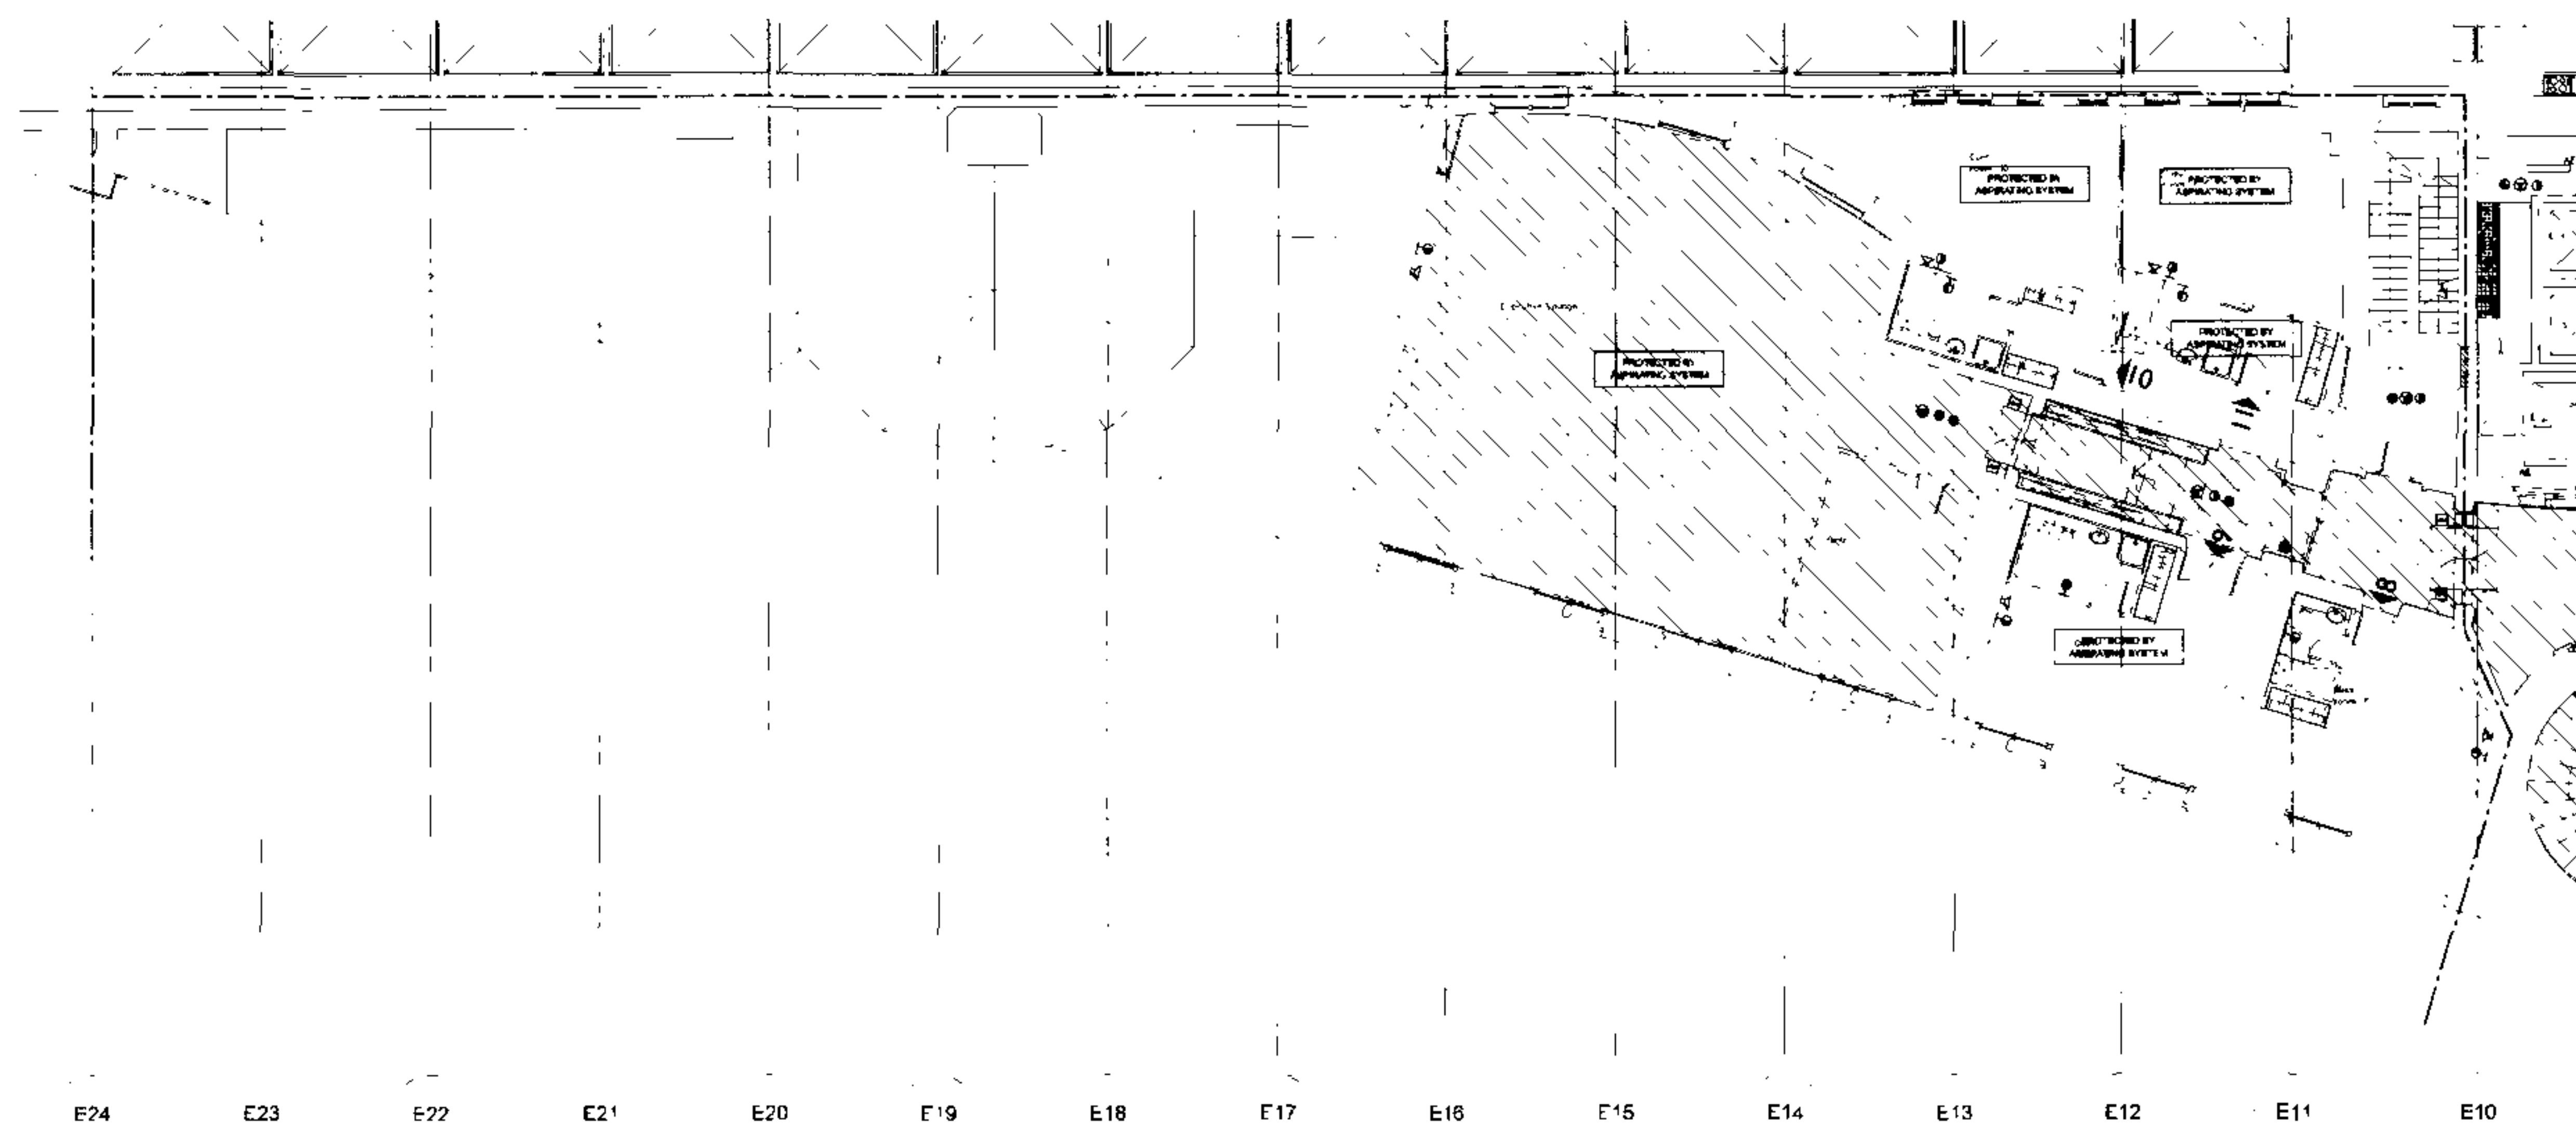

FOR CONTINUATION REFER TO DRG No 23101/DD/E/21/4/1

Rev	1	2	3	100
Status																																																																																																				
TENDER DRAWING																																																																																																				
Architect RHWL Architects RICHARD GRIFFITHS ARCHITECTS 100, 101, 102, 999, 1000																																																																																																				
Client Manhattan Loft Corporation Limited																																																																																																				
Project St Pancras Chambers																																																																																																				
Title WEST CHAMBERS SECOND FLOOR LIGHTING & FIRE ALARM LAYOUT sheet 2 to 2																																																																																																				
Made D.B.N. C.A.D. D.B.N.																																																																																																				
Scale 1:100																																																																																																				
Date MAY 08																																																																																																				
FABER MAUNSELL AECOM																																																																																																				
23101/DD/E/21/4/2 0																																																																																																				

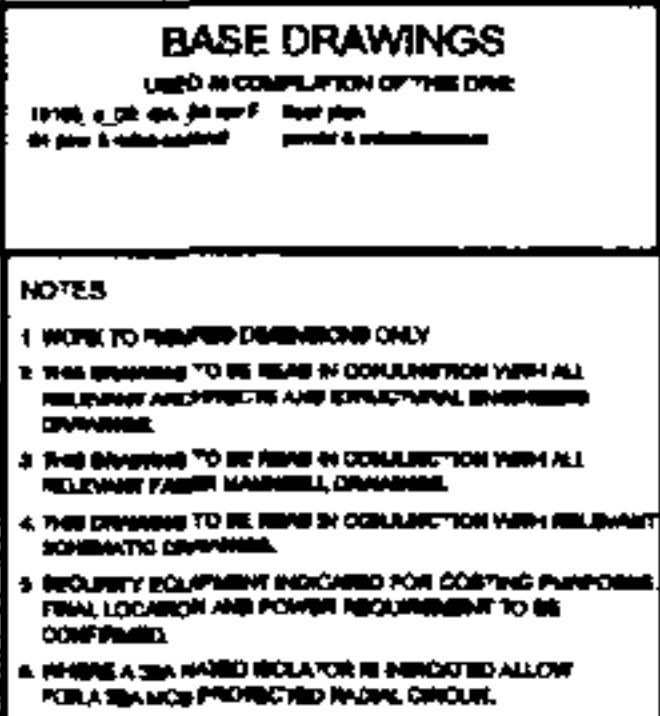

DESCRIPTION

CIRCUIT TYPE

GENPROB CIRCUIT IS SUPPLIED FROM LOCAL NON-ESSENTIAL DISTRIBUTION BOARD.

CIRCUIT

GENPROB CIRCUIT IS SUPPLIED FROM LOCAL ESSENTIAL DISTRIBUTION BOARD.

DATA

GENPROB CIRCUIT TYPE 1


32 AMPERE FUSAL CIRCUIT PROTECTED BY SEA/GENPROB WITH 250A FUSE.

NOTE


GENPROB CIRCUIT TYPE 2

32 AMPERE FUSAL CIRCUIT PROTECTED BY SEA/GENPROB WITH 250A FUSE.


FOR CONTINUATION REFER TO DRG. NO. 23101/DD/E/224/2

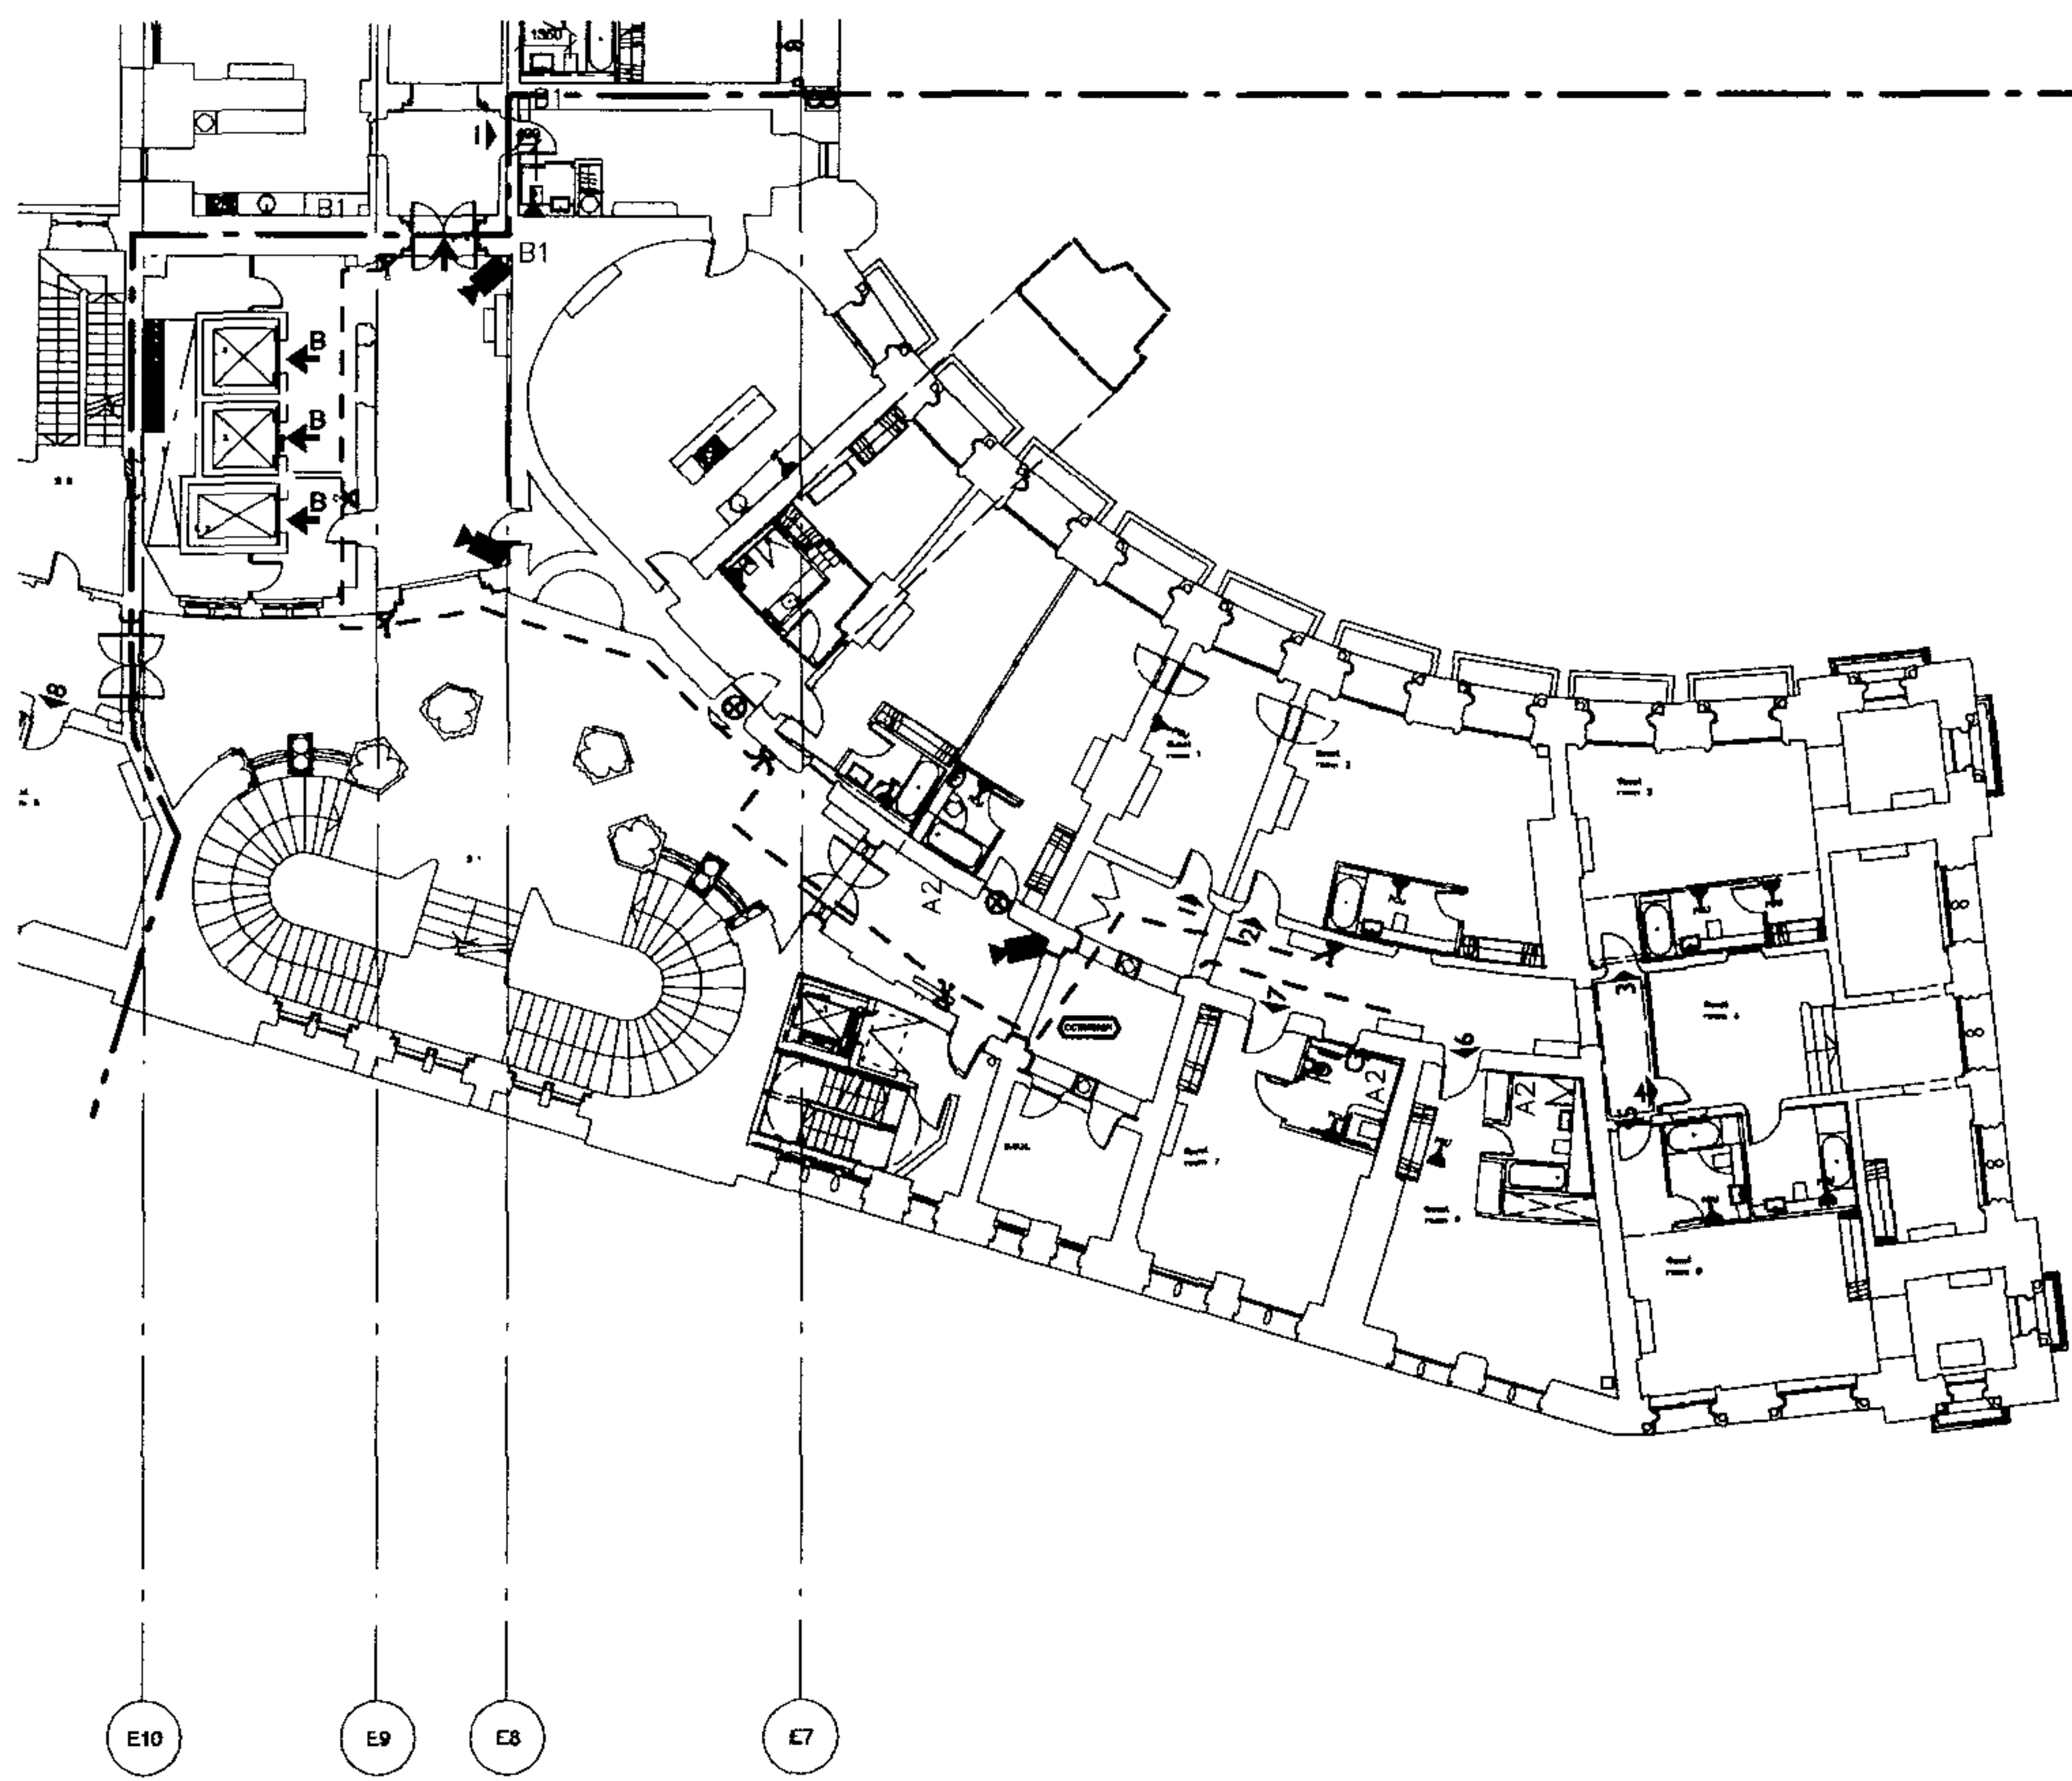

Rev	Revs	Details	Notes	Chg	By
Status TENDER DRAWING					
Architect RHM Architects and RICHARD GRIFFITHS ARCHITECTS 17 Orchard Lane, VICARAGE 1400 NEWTON 1 400 788 686					
Client Manhattan Loft Corporation Limited					
Project St Pancras Chambers					
Title WEST CHAMBERS SECOND FLOOR SMALL POWER & MISCELLANEOUS LAYOUT sheet 1 of 2					
Made	P.C.	C.A.D.	P.C.		
Cy'd		Graded	5: 300		
App.	S.P.	Date	MAY 88		
FABER MAUNSELL			AECON		
Engineering Office 87/88A, Victoria Road, N. 1 071 400 1000		17 Orchard Lane, VICARAGE 1400 NEWTON 1 400 788 686			
N^o. 23101AD/E/224/1					

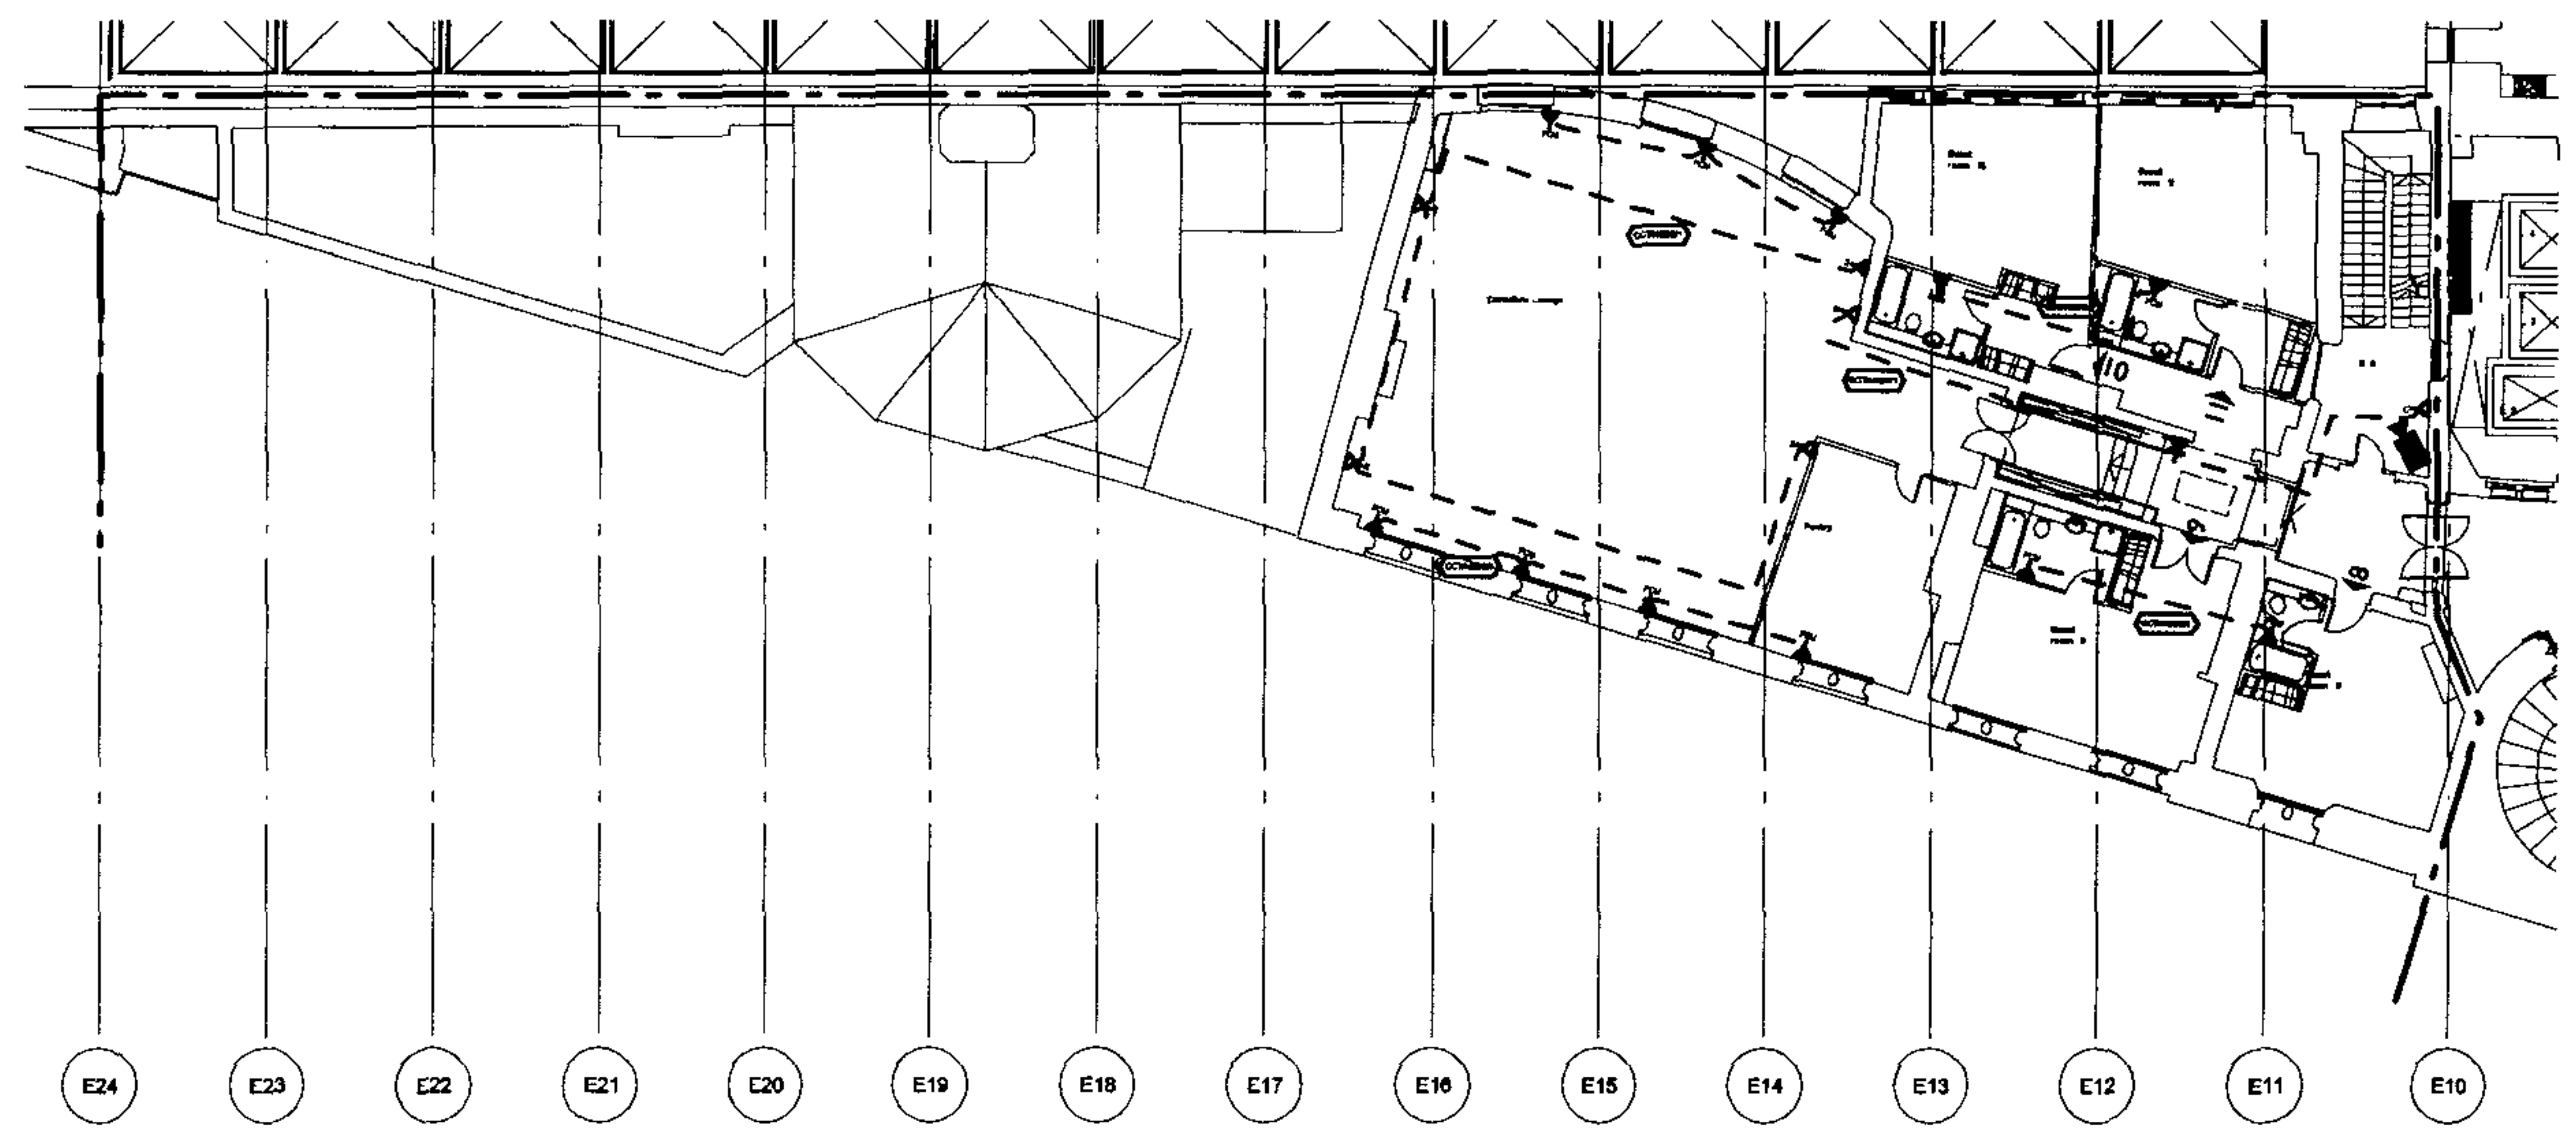

FOR CONTINUATION REFER TO DRG. No. 23101/DD/E/224/1

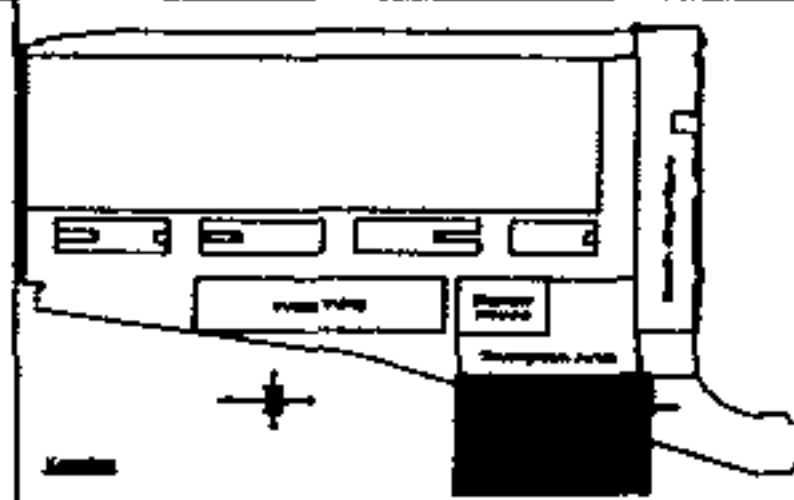

CIRCUIT BREAKER
CIRCUIT BREAKER IS SUPPLIED FROM LOCAL
DISTRIBUTION BOARD.
CONDUIT
CONDUIT IS SUPPLIED FROM LOCAL
DISTRIBUTION BOARD.
CONDUIT
CONDUIT IS SUPPLIED FROM LOCAL
DISTRIBUTION BOARD.
CONDUIT
CONDUIT IS SUPPLIED FROM LOCAL
DISTRIBUTION BOARD.
CONDUIT
CONDUIT IS SUPPLIED FROM LOCAL
DISTRIBUTION BOARD.

BASE DRAWINGS
1. THIS DRAWING IS TO BE USED IN CONSTRUCTION ONLY.
2. THIS DRAWING IS TO BE USED IN CONSTRUCTION ONLY.
3. THIS DRAWING IS TO BE USED IN CONSTRUCTION ONLY.
4. THIS DRAWING IS TO BE USED IN CONSTRUCTION ONLY.
5. THIS DRAWING IS TO BE USED IN CONSTRUCTION ONLY.
6. THIS DRAWING IS TO BE USED IN CONSTRUCTION ONLY.
7. THIS DRAWING IS TO BE USED IN CONSTRUCTION ONLY.
8. THIS DRAWING IS TO BE USED IN CONSTRUCTION ONLY.
9. THIS DRAWING IS TO BE USED IN CONSTRUCTION ONLY.
10. THIS DRAWING IS TO BE USED IN CONSTRUCTION ONLY.


NOTES
1. THIS DRAWING IS TO BE USED IN CONSTRUCTION ONLY.
2. THIS DRAWING IS TO BE USED IN CONSTRUCTION ONLY.
3. THIS DRAWING IS TO BE USED IN CONSTRUCTION ONLY.
4. THIS DRAWING IS TO BE USED IN CONSTRUCTION ONLY.
5. THIS DRAWING IS TO BE USED IN CONSTRUCTION ONLY.
6. THIS DRAWING IS TO BE USED IN CONSTRUCTION ONLY.
7. THIS DRAWING IS TO BE USED IN CONSTRUCTION ONLY.
8. THIS DRAWING IS TO BE USED IN CONSTRUCTION ONLY.
9. THIS DRAWING IS TO BE USED IN CONSTRUCTION ONLY.
10. THIS DRAWING IS TO BE USED IN CONSTRUCTION ONLY.

TENDER DRAWING
Architect
RHWL Architects
RICHARD GRIFITHS ARCHITECTS
71 Broad Street, London, EC2A 4DF
T: 020 7460 1000 F: 020 7460 1001
Client
Manhattan Loft Corporation Limited
Project
St Pancras Chambers
Title
**WEST CHAMBERS
SECOND FLOOR
SMALL POWER &
MISCELLANEOUS LAYOUT
sheet 2 of 2**
Made
PC
C.A.D.
PC
Scale
1:100
Date
14/01/02
FABER MAUNSELL AECOM
N 23101/DD/E/224/2 0

NOTE

WHERE INDICATED SERVICES DISTRIBUTION WITHIN EACH ROOM ARE BASED ON SCHEME DESIGN LAYOUTS. FINAL LAYOUTS TO BE AGREED.

WITHIN OTHER AREAS FINAL SERVICES DISTRIBUTION PROPOSALS WITHIN ROOM TO BE CONFIRMED.

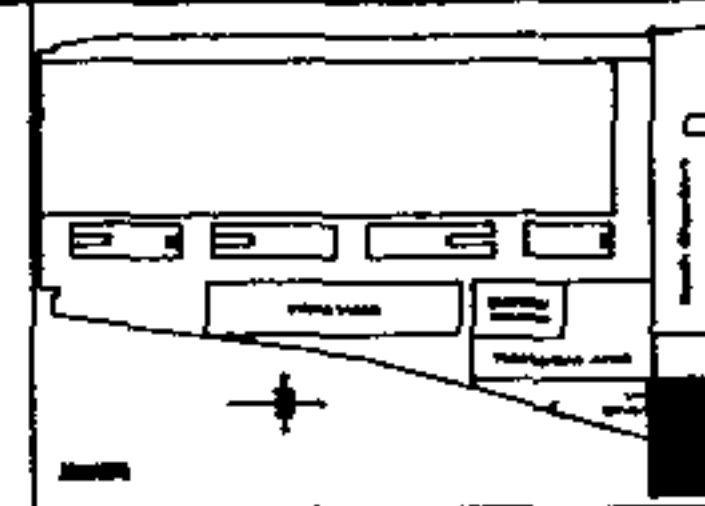

BASE DRAWINGS



USED IN COMPLETION OF THIS DRAWING

- NOTES
1. WORK TO REMAIN DIMENSIONS ONLY
 2. THIS DRAWING TO BE USED IN CONNECTION WITH ALL RELEVANT VERTICALS AND STRUCTURAL INFORMATION
 3. THIS DRAWING TO BE USED IN CONNECTION WITH ALL RELEVANT TYPICAL DETAILS
 4. THIS DRAWING TO BE USED IN CONNECTION WITH ALL RELEVANT SCHEDULES
 5. FOR TYPICAL DETAILS REFER TO DRAWINGS IN COMPLETION

- LEGEND
- ELECTRIC UNDERFLOOR HEATING
 - ELECTRIC HEATED TOWEL RAIL
 - LOW LEVEL ELECTRIC HEATER

FOR CONTINUATION REFER TO DRG. No. 23101/DD/M/104

FOR CONTINUATION REFER TO DRG. No. 23101/DD/M/204/2

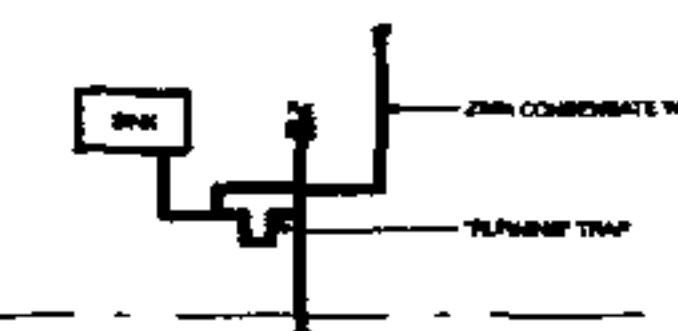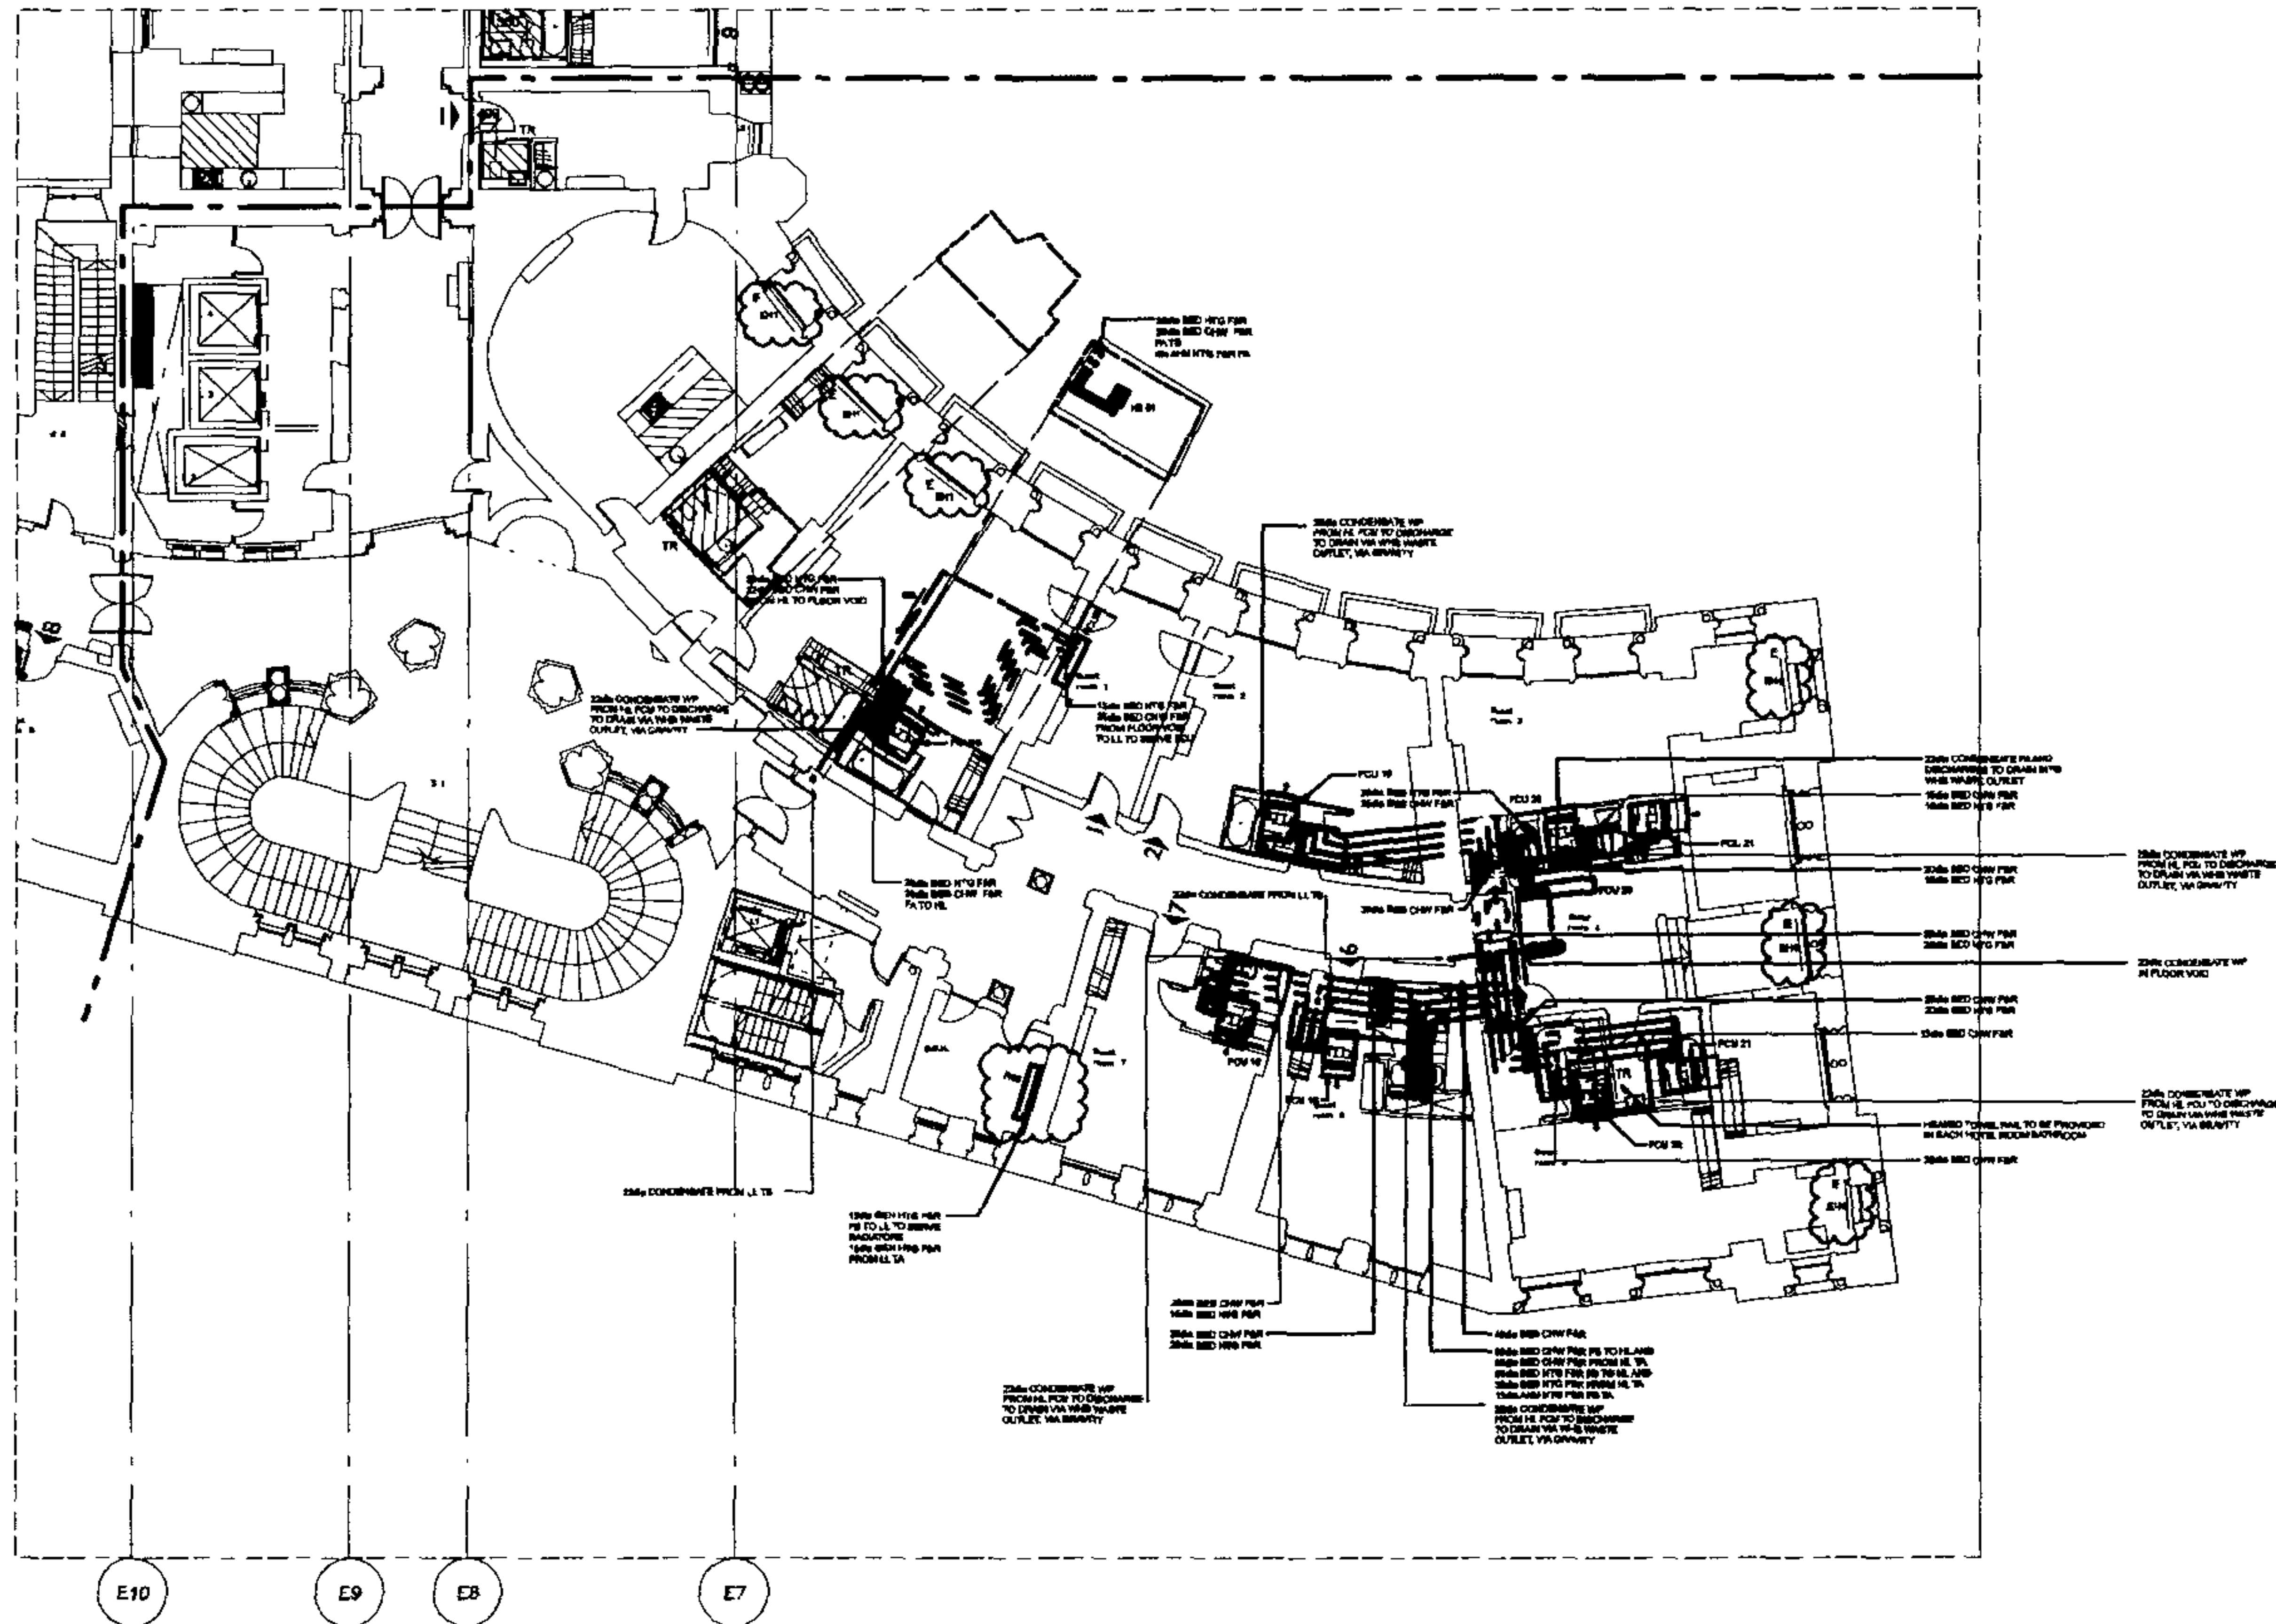

FOR CONDENSATE DETAIL

ALL CONDENSATE DETAIL TO BE PROVIDED IN EACH ROOM TO DISCHARGE TO DRAIN VIA WASTE OUTLET, VIA GRABTY

TENDER DRAWING

Architect
RHWL Architects
RICHARD GRIFITHS ARCHITECTS
71 Broad Street, London, W1C 1JF
Tel: 020 7493 1111

Client
Manhattan Loft
Corporation Limited

Project
St Pancras Chambers

Title
WEST CHAMBERS
SECOND FLOOR
HEATING AND COOLING
LAYOUT
Sheet 1 of 2

Scale
1:100

Author
D.T.E.

Check
D.T.E.

Drawn
D.T.E.


Scale
1:100

Scale
1:100

NOTE

WHERE INDICATED SERVICES DISTRIBUTION WITHIN EACH ROOM ARE BASED ON SCHEME DESIGN LAYOUTS. FINAL LAYOUTS TO BE AGREED.

WITHIN OTHER AREAS FINAL SERVICES DISTRIBUTION PROPOSALS WITHIN ROOM TO BE CONFIRMED.

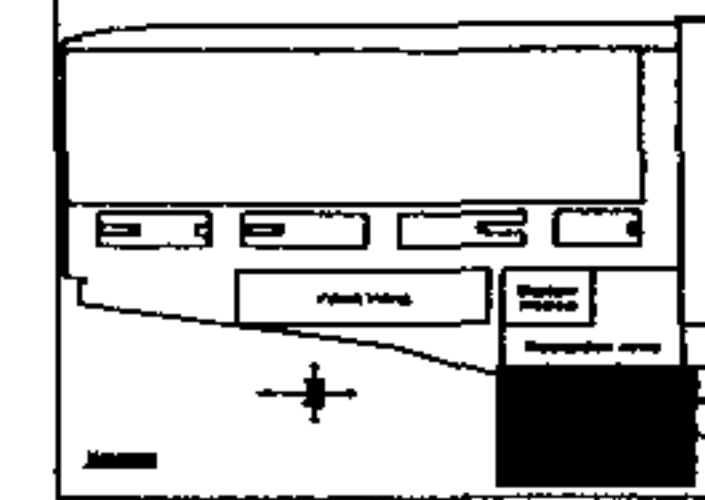


BASE DRAWINGS


USED IN COMPLETION OF THIS ONE

NOTES

1. WORK TO REMAIN DISTRIBUTION ONLY
2. IF NO CONDENSATE TO BE READ IN DISSECTION WITH ALL BUILDING ARCHITECTS AND STRUCTURAL ENGINEERS
3. IF NO CONDENSATE TO BE READ IN DISSECTION WITH ALL BUILDING ARCHITECTS AND STRUCTURAL ENGINEERS
4. IF NO CONDENSATE TO BE READ IN DISSECTION WITH ALL BUILDING ARCHITECTS AND STRUCTURAL ENGINEERS
5. FOR TYPICAL DETAIL REFER TO DRAWING NO. 23101/DDM/204/1

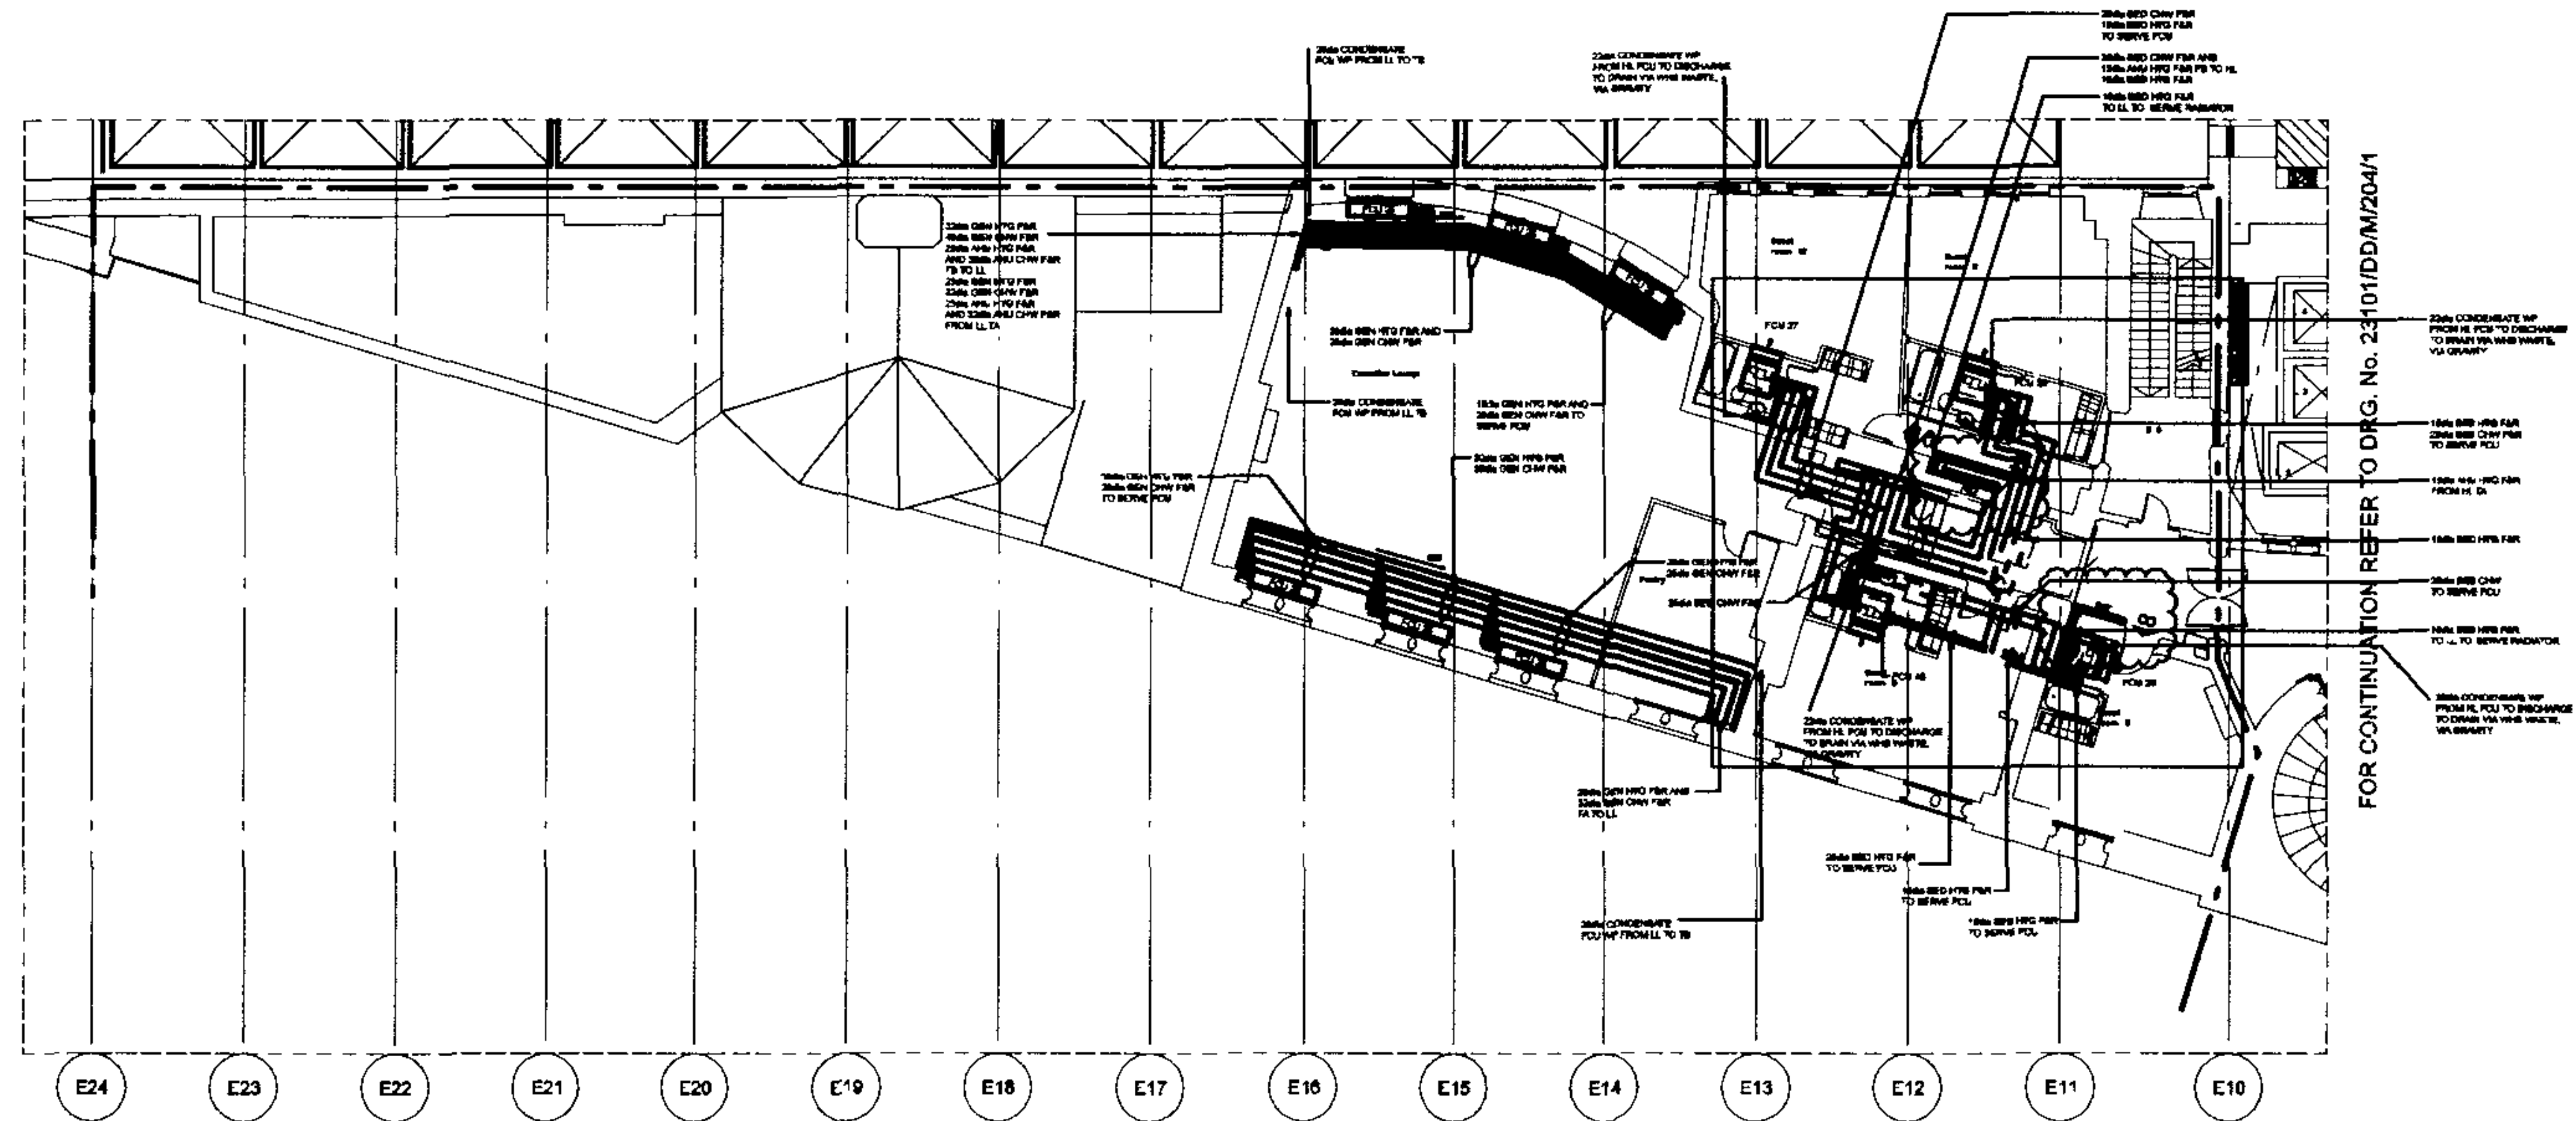

FOR CONTINUATION REFER TO DRG. No. 23101/DDM/204/1

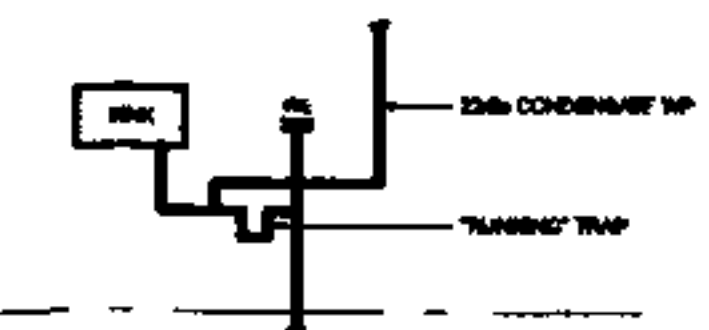

FCU CONDENSATE DETAIL

ALL CONDENSATE FROM FCUs MUST BE DISCHARGED TO DRAIN VIA VENTILATION SYSTEM. ALL CONDENSATE FROM FCUs MUST BE DISCHARGED TO DRAIN VIA VENTILATION SYSTEM. ALL CONDENSATE FROM FCUs MUST BE DISCHARGED TO DRAIN VIA VENTILATION SYSTEM.

Rev	Date	By	Check	Appr
1	Apr 16	DOC & Revise	Revise	Revise
2	Apr 16	DOC & Revise	Revise	Revise
3	Apr 16	DOC & Revise	Revise	Revise
100	Apr 16	DOC & Revise	Revise	Revise

TENDER DRAWING

Architect:
RHWL Architects
RICHARD GRIFFITHS ARCHITECTS
17 South Street, London EC3A 3AF
T: 020 7858 1100 F: 020 7858 1101

Client:
Manhattan Loft
Corporation Limited

Project:
St Pancras Chambers

Title:
WEST CHAMBERS
SECOND FLOOR
HEATING AND COOLING
LAYOUT
Sheet 2 of 2

Made: 30 CA D: 30
C/D: 30 Scale: 1:100
App: D.T.E. Date: MAY 09

FABER MALINSSELL AECOM

© 23101/DDM/204/2 0

WHERE INDICATED SERVICES DISTRIBUTION WITHIN EACH ROOM ARE BASED ON SCHEME DESIGN LAYOUTS FINAL LAYOUTS TO BE AGREED

WITHIN OTHER AREAS FINAL SERVICES DISTRIBUTION PROPOSALS WITHIN ROOM TO BE CONFIRMED




NOTES

- 1 WORK TO FIGURED DIMENSIONS ONLY
- 2 THIS DRAWING TO BE READ IN CONJUNCTION WITH ALL RELEVANT ARCHITECT AND STRUCTURAL ENGINEERING DRAWINGS
- 3 THIS DRAWING TO BE READ IN CONJUNCTION WITH ALL RELEVANT FABRIC MANUFACTURE DRAWINGS
- 4 THIS DRAWING TO BE READ IN CONJUNCTION WITH RELEVANT SCHEMATIC DRAWINGS
- 5 FOR TYPICAL DETAILS REFER TO DRAWING NO 23104004000000000000

FOR CONTINUATION REFER TO DRG. No. 23101/DD/M/114

FOR CONTINUATION REFER TO DRG. No. 23101/DD/M/214/2

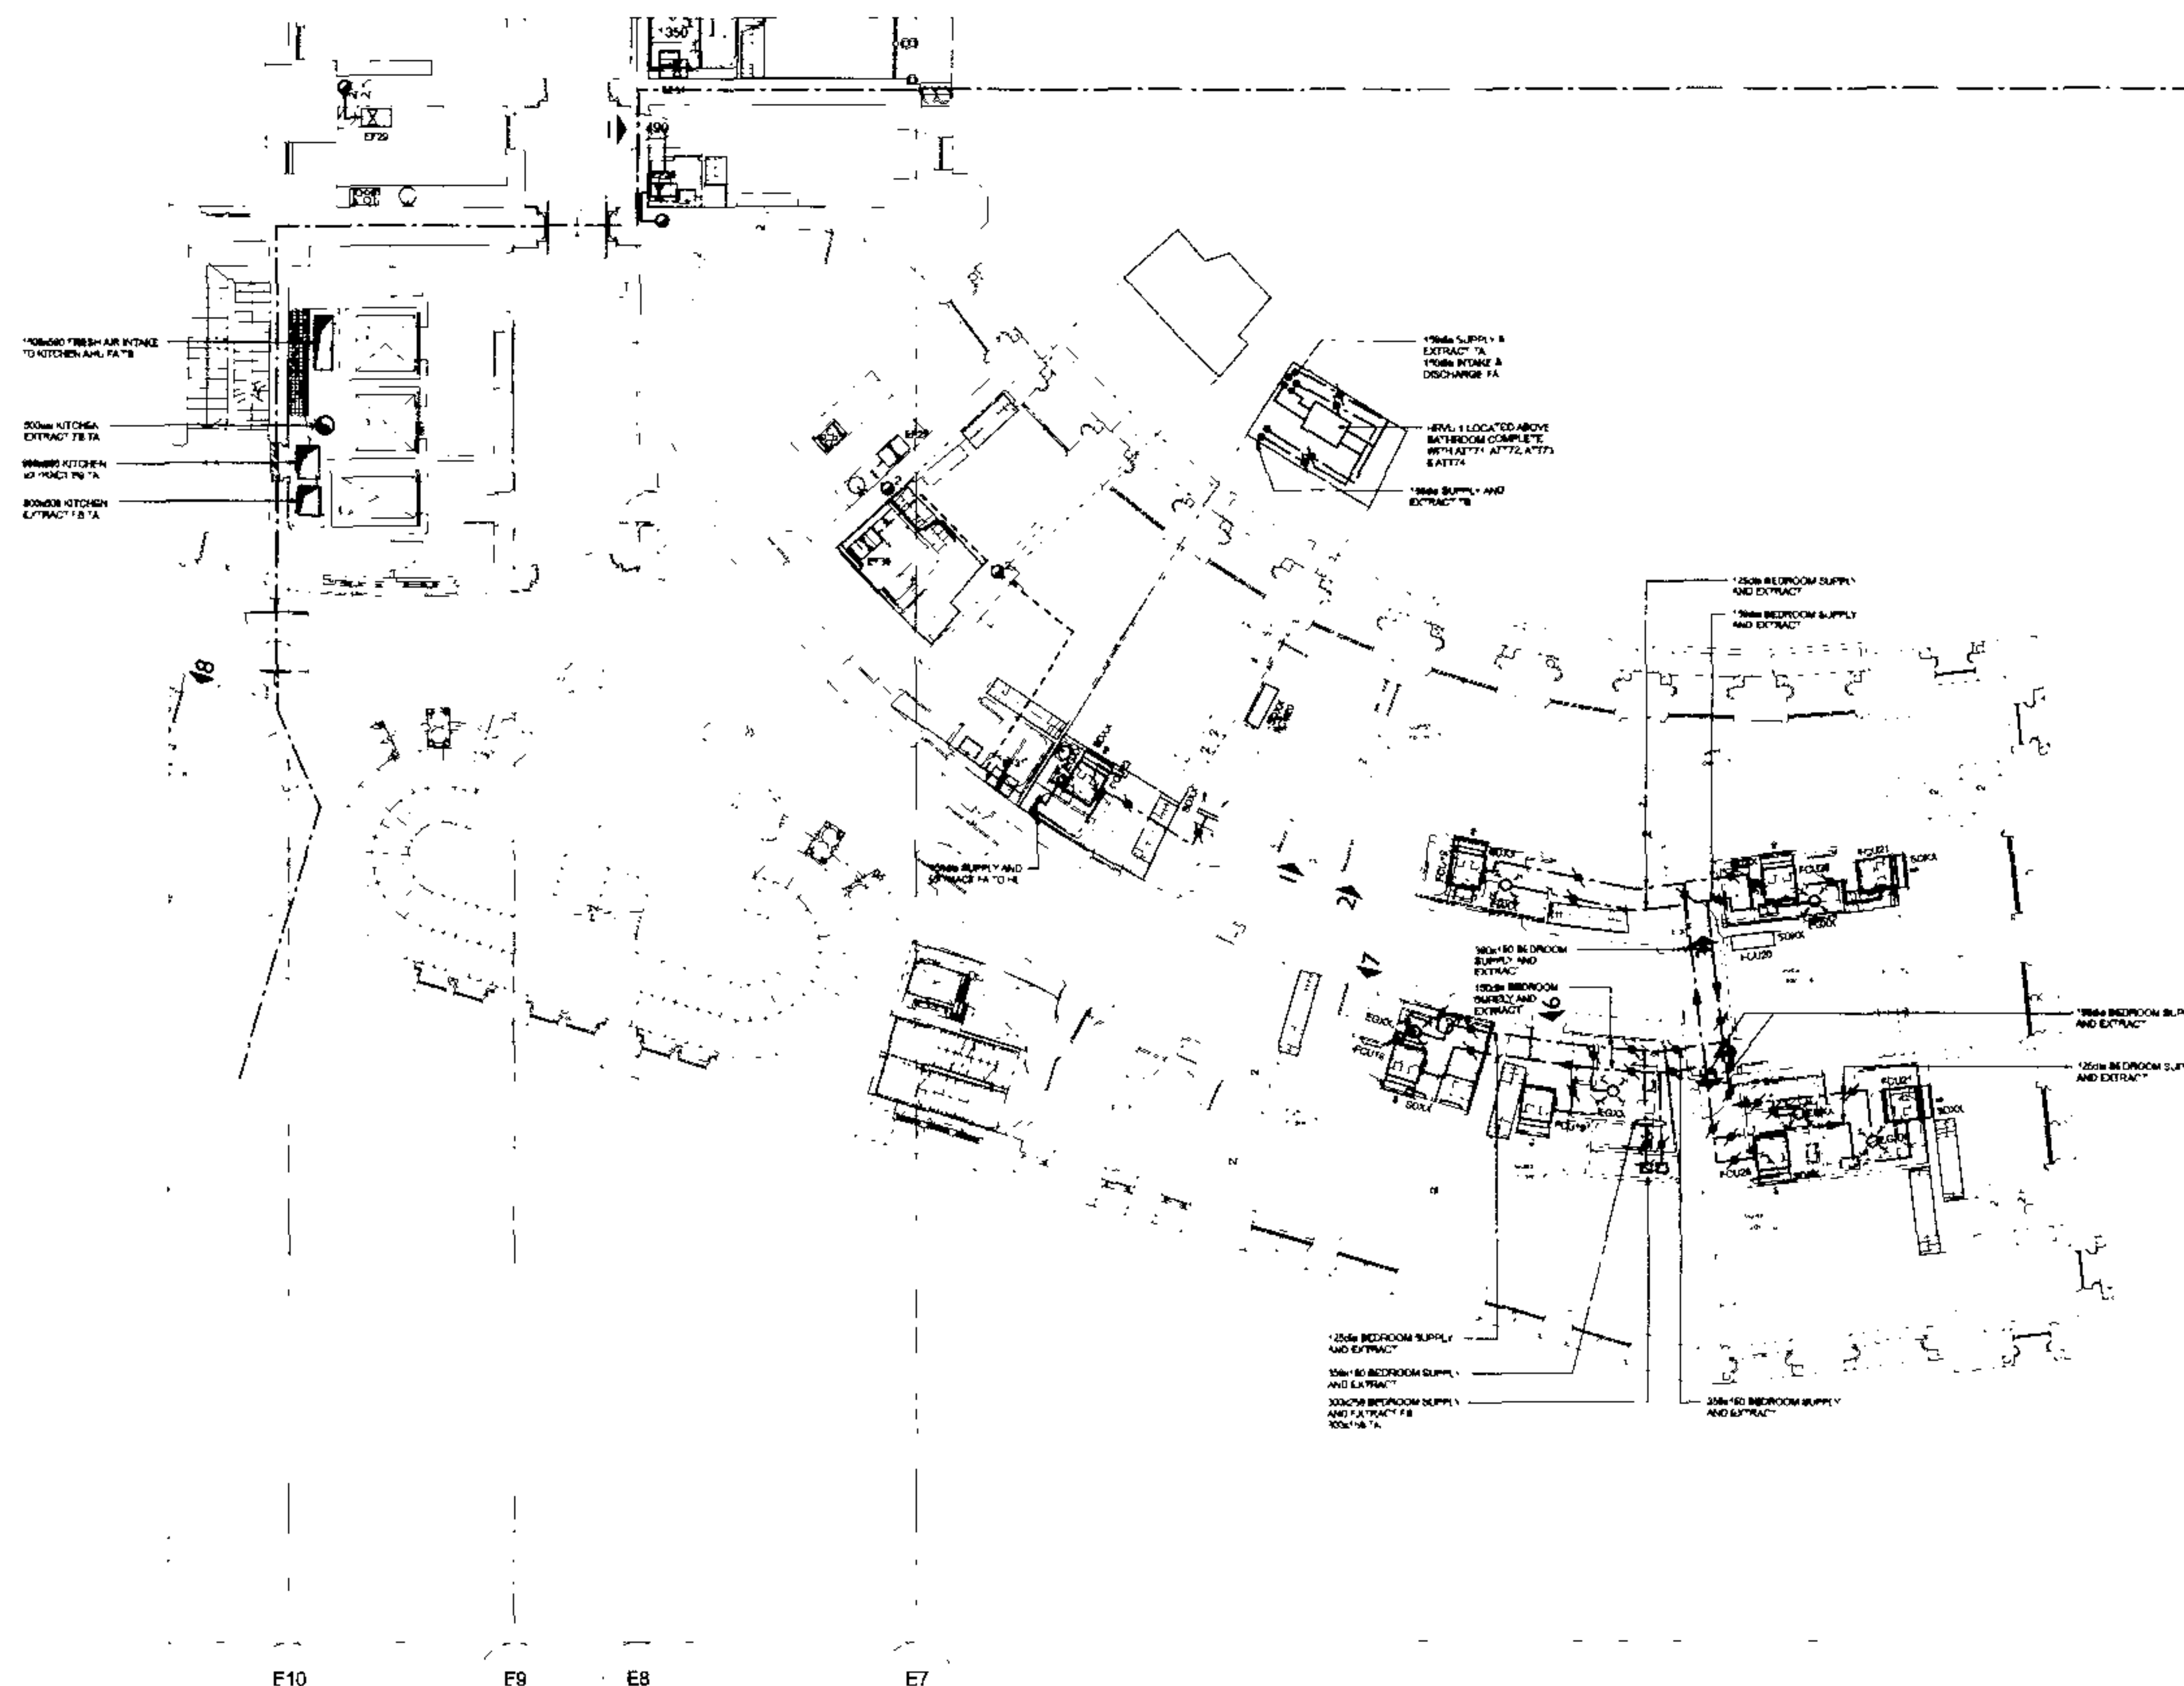

Name	Company		Phone	Fax	
Status					
TENDER DRAWING					
Architect					
RHWL Architects 100 West 42nd Street, Suite 1000 New York, NY 10018-3601 Tel: 212 693 1000 Fax: 212 693 1001					
Client					
Manhattan Loft Corporation Limited					
Project					
St Pancras Chambers					
Title					
WEST CHAMBERS SECOND FLOOR VENTILATION LAYOUT Sheet 1 of 2					
Make	SC	CAD	F2		
CAD	2000	2000	2000	Scale	1:100
App	DTE	Date	May 05		
FABER MAUNSELL			AECOM		
Manhattan 100 West 100 West 42nd Street New York, NY 10018-3601 Tel: 212 693 1000 Fax: 212 693 1001			Tel: 212 693 1000 Fax: 212 693 1001 New York, NY 10018-3601 www.fabermaunsell.com		
23101/DD/M214/1					
					0
					AO

WHERE INDICATED SERVICES DISTRIBUTION WITHIN EACH ROOM ARE BASED ON SCHEME DESIGN LAYOUTS. FINAL LAYOUTS TO BE AGREED


WITHIN OTHER AREAS FINAL SERVICES DISTRIBUTION PROPOSALS WITHIN ROOM TO BE CONFIRMED



BASE DRAWINGS
JAIL IN COMPIATION OF THIS CRG

NOTES

1. WORK TO FOURED DIMENSIONS ONLY
2. THIS DRAWING TO BE READ IN CONJUNCTION WITH ALL RELEVANT ARCHITECT'S AND STRUCTURAL ENGINEERS DRAWINGS
3. THIS DRAWING TO BE READ IN CONJUNCTION WITH ALL RELEVANT FABRIC MAINLINE DRAWINGS
4. THIS DRAWING TO BE READ IN CONJUNCTION WITH RELEVANT SCHEMATIC DRAWINGS
5. FOR TYPICAL DETAILS REFER TO DRAWING No. 23101000-000000000000

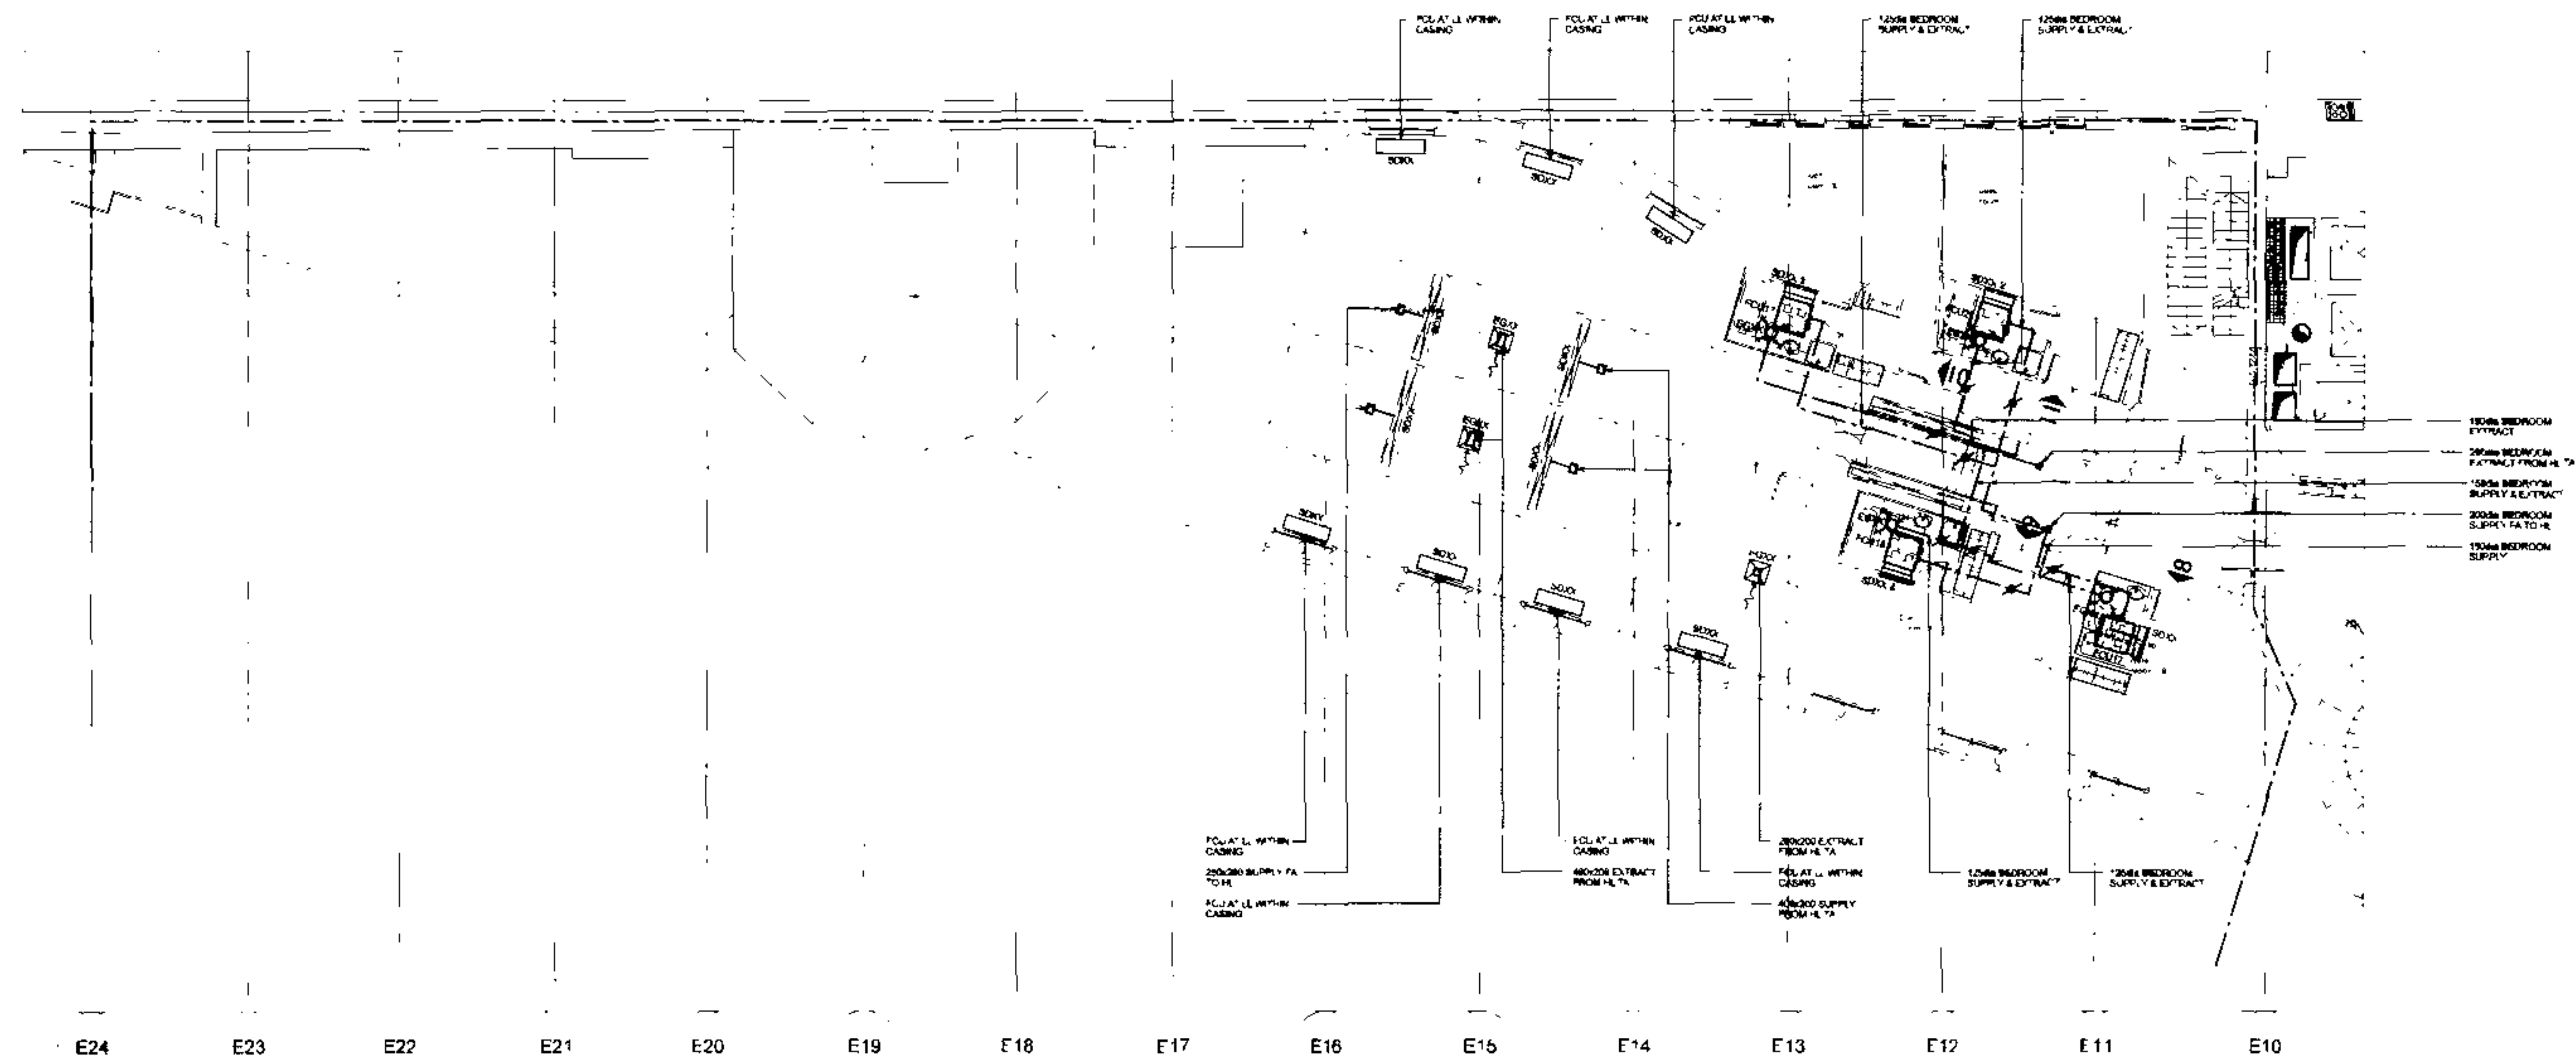

FOR CONTINUATION REFER TO DRG. No. 23101/DD/M/214/1

Name	Date	Drawn	Issued	Clad	Page
Status					
TENDER DRAWING					
Architect RHWL Architects and RICHARD GRIFFITHS ARCHITECTS 7 Great Street - London WC2D-6JZ T: 020 7798 1795 F: 020 7780 6885					
Client Manhattan Loft Corporation Limited					
Project St Pancras Chambers					
Title WEST CHAMBERS SECOND FLOOR VENTILATION LAYOUT Sheet 2 of 2					
Made	A2	C.A.D.	Sch		
C'd by	REV	DATE	SCALE	1 : 160	
App'd	D.T.E.	Date	MAY 06		
FABER MAUNSELLALCOM Headquarters "London" 25 Abchurch Lane, EC4N 3DF Tel: 020 7460 8000 Fax: 020 7460 8001 E-mail: faber@faber.co.uk alcom@aicom.com					
N.C. 23101/DD/M/214/2 0					



NOTES

WORK TO FURTHER DETERMINE ONLY

1. YES DRAINING TO BE RE-IGN IN CONNECTION WITH ALL RELEVANT ARCHITECTS AND STRUCTURAL ISSUES

2. YES DRAINING TO BE RE-IGN IN CONNECTION WITH ALL RELEVANT PAVING MATERIALS - DRAINAGE

3. YES DRAINING TO BE RE-IGN IN CONNECTION WITH ALL RELEVANT RE-PAVING DRAINAGE

4. YES/NO

5. YES/NO

6. YES/NO

96. YES/NO


97. YES/NO

98. YES/NO

99. YES/NO


100. YES/NO

FOR CONTINUATION REFER TO DRG. No. 23101/DD/PH//104

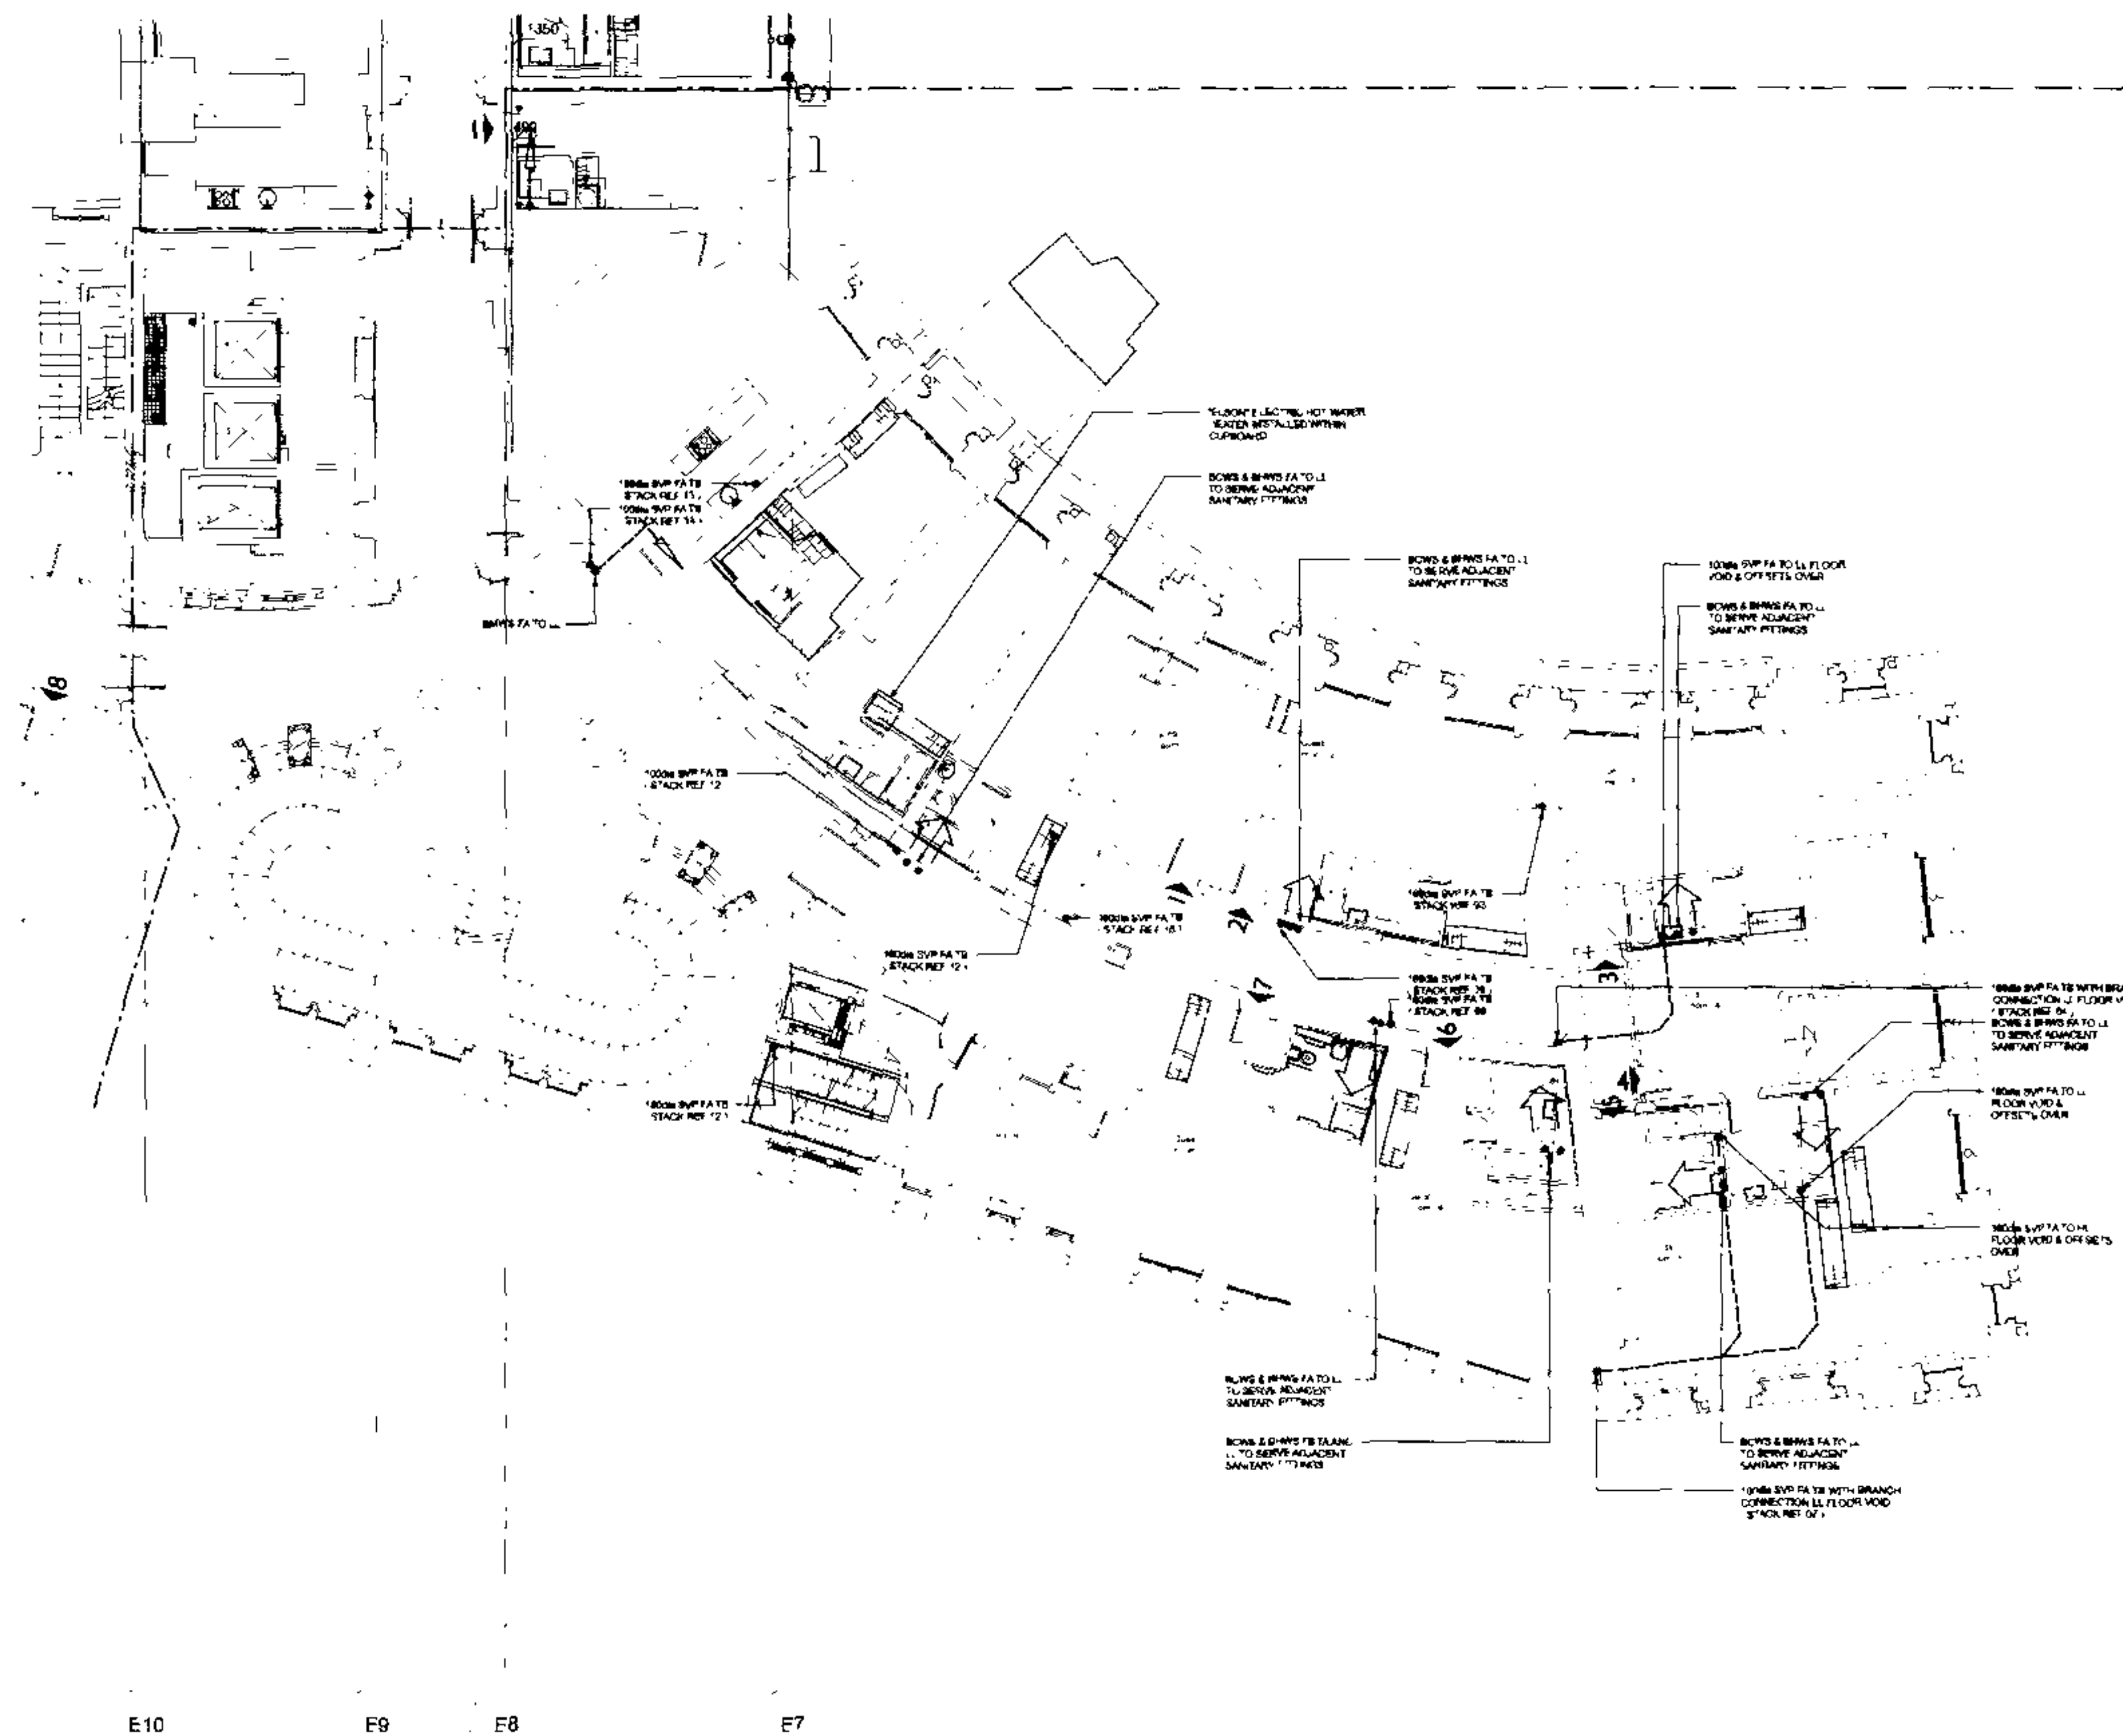


FOR CONTINUATION REFER TO DRG No 23101/DD/PH//204/2

No.	Date	Client	Project	City
Status TENDER DRAWING				
Architect RHWL Architects RICHARD GRIFFITHS ARCHITECTS 11 Grand Street, 10th Floor New York, NY 10013 Tel: 212 759 7886 Fax: 212 759 4887				
Client Manhattan Loft Corporation Limited				
Project St Pancras Chambers				
Title WEST CHAMBERS SECOND FLOOR PUBLIC HEALTH SERVICES LAYOUT sheet 1 of 2				
Scale 1/8" = 1'-0"	Scale A.D.	Scale 1/8" = 1'-0"		
App GFD	Date MAY 1987			
FABER MAUNSELL		AECOM		
Manhattan Engineering Services 110 West 42nd Street, 10th Floor New York, NY 10018-3611		110 West 42nd Street, 10th Floor New York, NY 10018-3611		
N 2 • 23101/DD/PH/204/1		No		

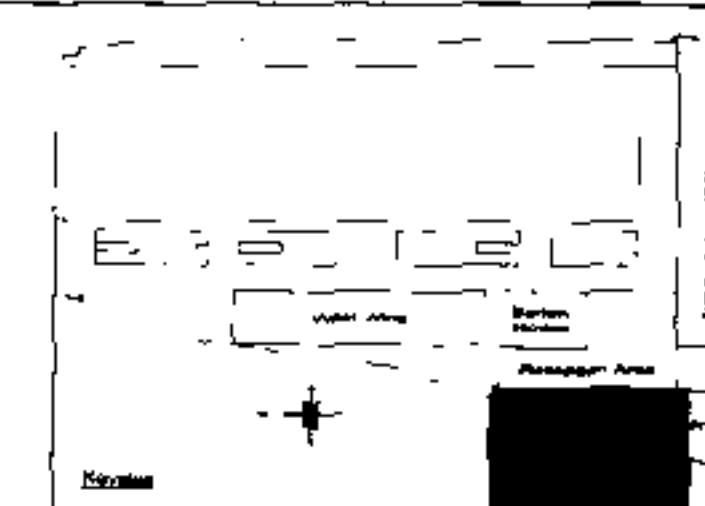

NOTES

2. WORK TO FOLLOW DISCUSSED ONLY
3. THIS DRAWING TO BE READ IN CONJUNCTION WITH ALL RELEVANT ARCHITECTS AND STRUCTURAL ENGINEERS DRAWINGS
4. THIS DRAWING TO BE READ IN CONJUNCTION WITH ALL RELEVANT PLUMBING, ELECTRICAL, MECHANICAL, AND HVAC DRAWINGS
5. THIS DRAWING TO BE READ IN CONJUNCTION WITH ALL RELEVANT CIVIL AND LANDSCAPE DRAWINGS
6. LEGEND:
- MEANS MAINE WATER SERVICE
BOWS BOICOTED COLD WATER SERVICE
BOWS BOICOTED HOT WATER SERVICE
LH LOW LEVEL
PB - FROM BELOW
PB - FROM ABOVE
PB - FROM ABOVE
BOWS BOICOTED MAINE WATER SERVICE
CYS OPEN TOP CULV
CYS NOT OPEN TOP
PREF - BASE W/STAIN PROOF
AC MAIN LINE TO CULV
AC
CUL TO FURNISHING OF
AUV AUTOMATIC AUV
BOWS BOICOTED
BOWS BOICOTED BOICOTED COLD WATER SERVICE
BOWS BOICOTED BOICOTED HOT WATER SERVICE

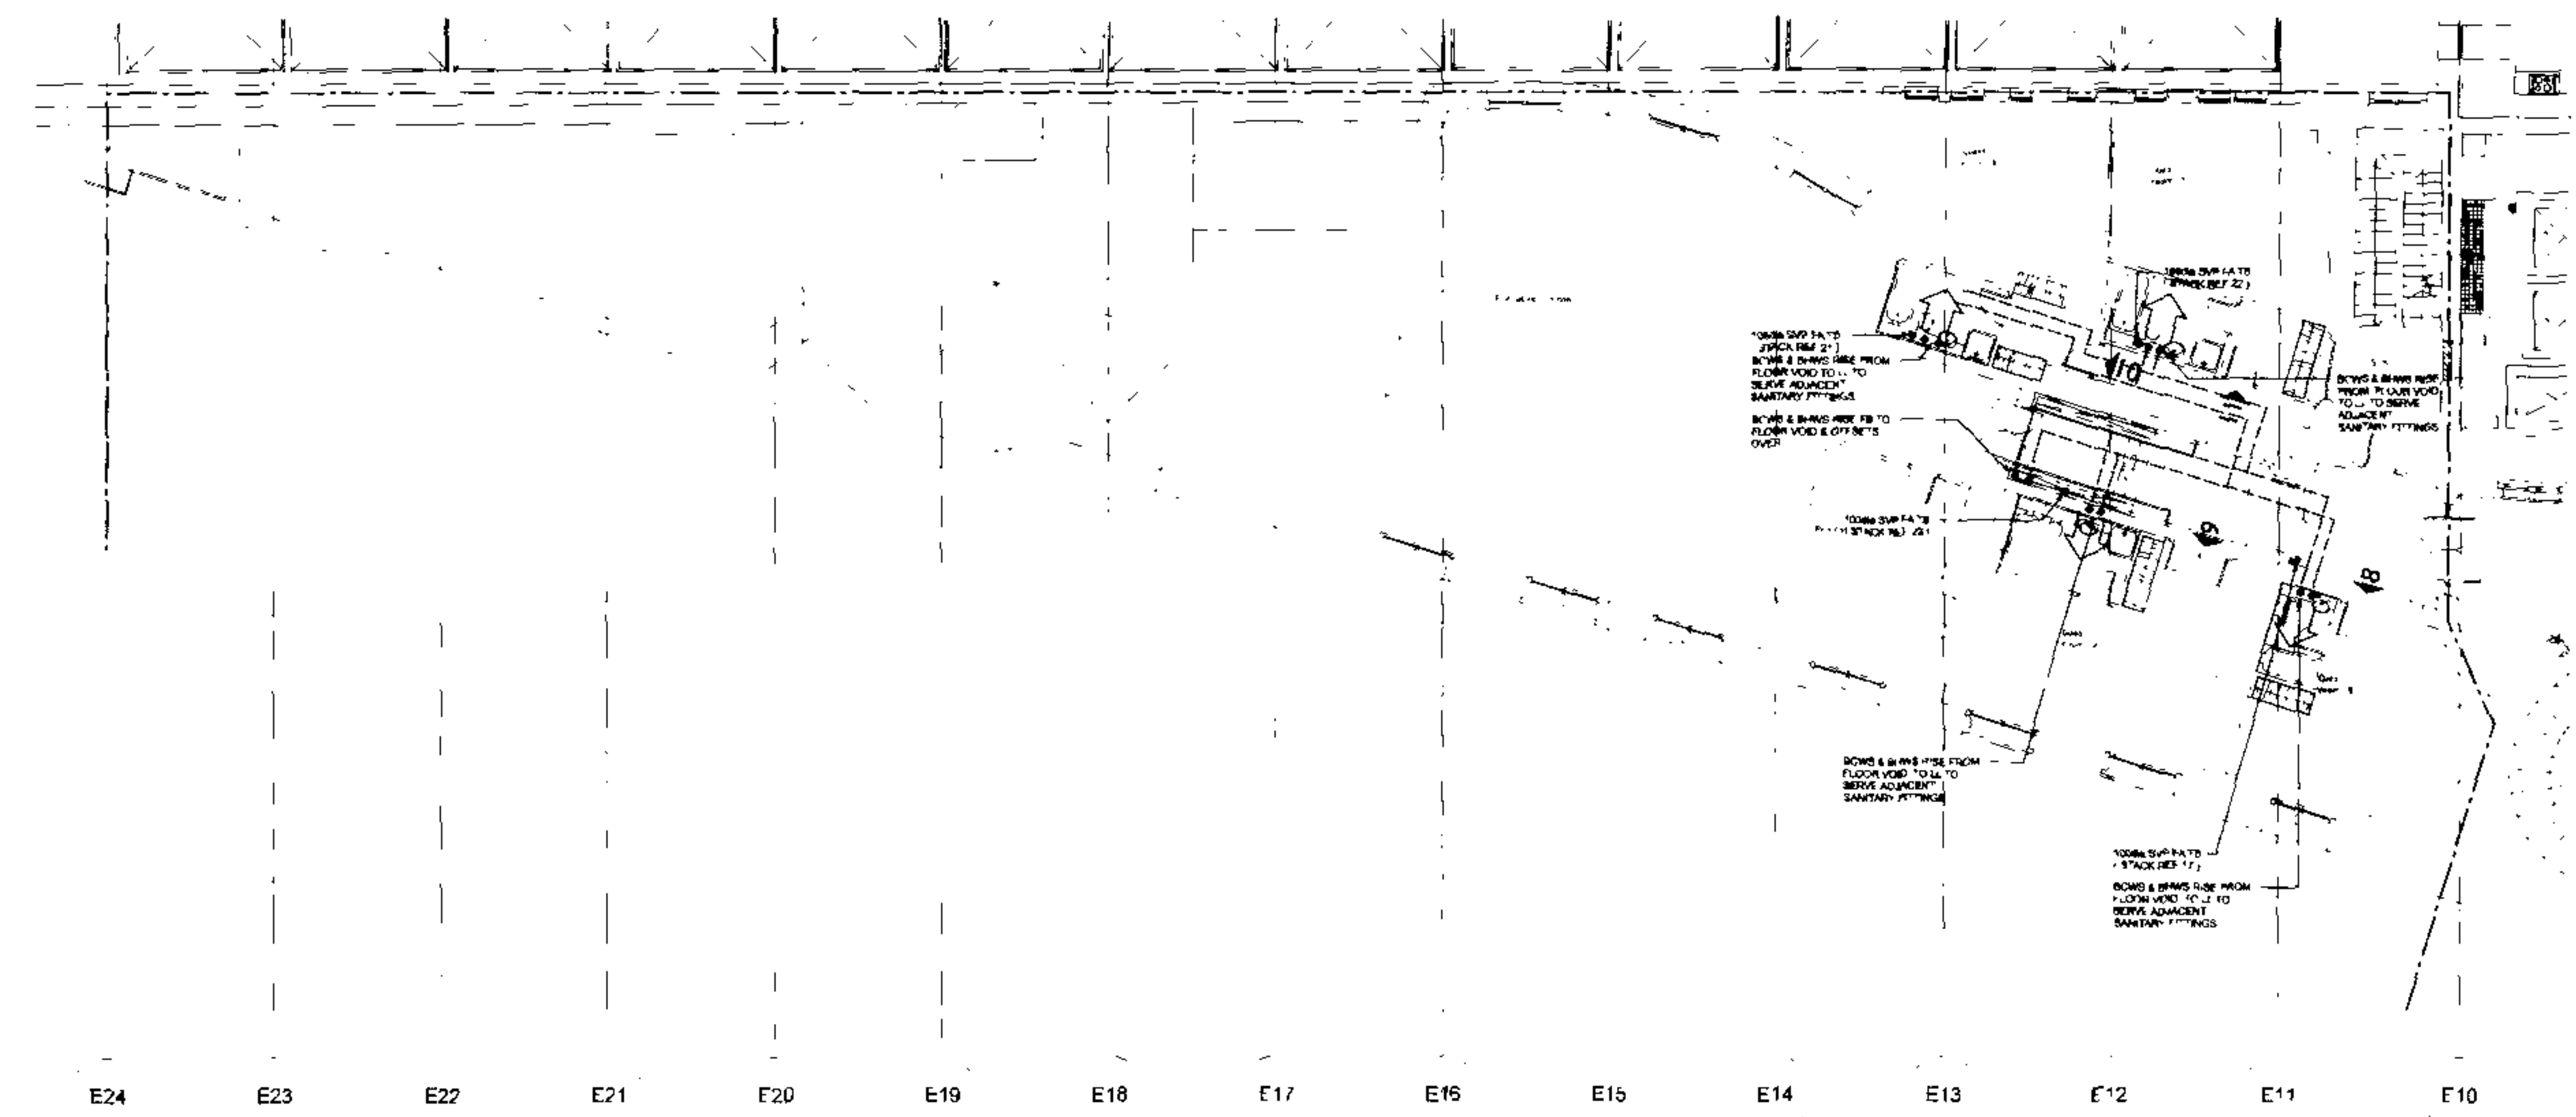

FOR CONTINUATION REFER TO DRG No 23101/DD/PH/204/1


Rev	Code	Details	Revised	By	Appr
TENDER DRAWING					
Architect					
RHWL Architects 77 Lefferts Rd. Suite 402B-62 Astoria, OR 97103-4601					
Client					
Manhattan Loft Corporation Limited					
Project					
St Pancras Chambers					
Title					
WE ST PANCRAS CHAMBERS SECOND FLOOR PUBLIC HEALTH SERVICES LAYOUT sheet 2 of 2					
Master	B.U.	C.A.D.	A.D.		
Appr.	DATE DATE	Scale	1" = 10'		
Arch.	C.D.	Date	MAX 96		
FABER MANUSSELL AECOM					
Manhattan House 25 Nassau Street, Suite 200 New York, NY 10038-3001			+1 212 693 2100 +1 212 693 2101 www.fabermanusell.com		
NO. 23101/DD/PH/204/2					
					0

FOR CONTINUATION REFER TO DRG. No. 23101/DD/FP/105/1 & 23101/DD/FP/105/1




THIRD FLOOR
LOW LEVEL

Über Stellenform

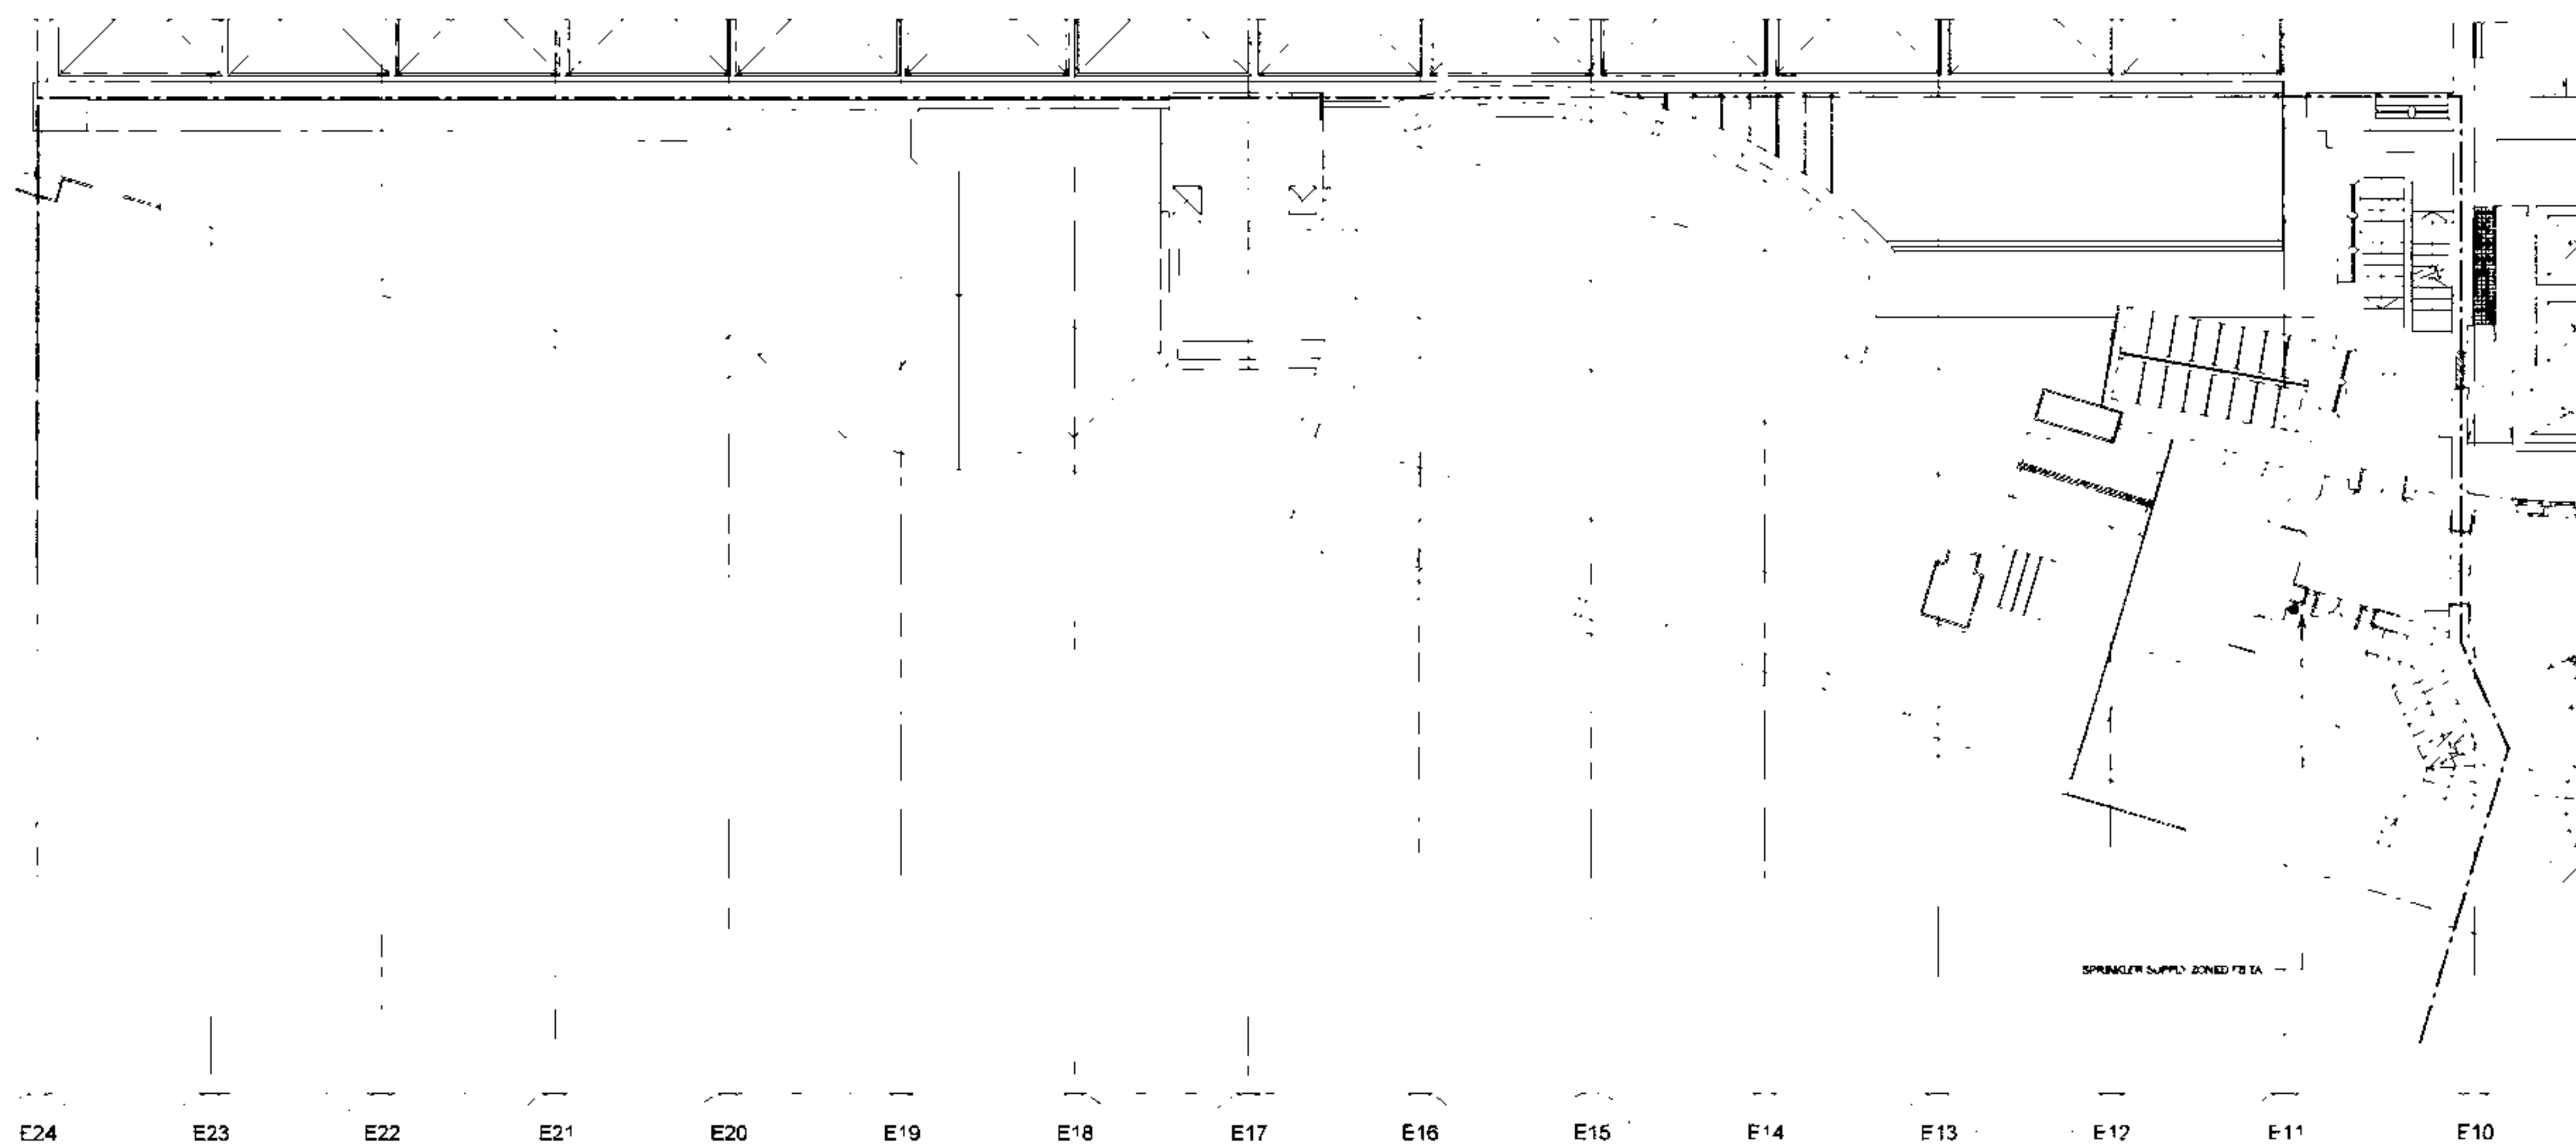

THIRD FLOOR
LOW LEVEL

FOR CONTINUATION REFER TO DRG No 23101/DD/FP/205/1

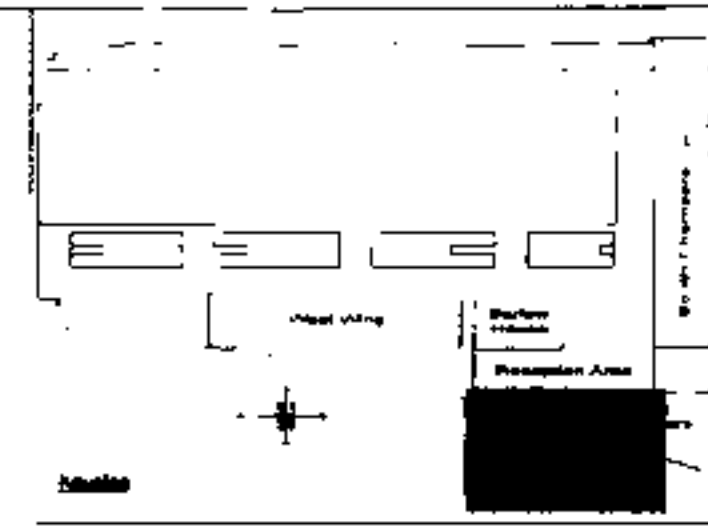


- BASE DRAWINGS**
USED IN COMBINATION OF THIS DRG
- NOTES**
1. WORK TO FIGURED DIMENSIONS ON 1
 2. THIS DRAWING TO BE READ IN CONJUNCTION WITH ALL RELEVANT ARCHITECTURAL AND STRUCTURAL DRAWINGS
 3. THIS DRAWING TO BE READ IN CONJUNCTION WITH ALL RELEVANT ELECTRICAL DRAWINGS
 4. THIS DRAWING TO BE READ IN CONJUNCTION WITH ALL RELEVANT MECHANICAL DRAWINGS
 5. THESE DRAWINGS INDICATE THE WORK REQUIRED FOR THE PROPOSED SYSTEM. THE CONTRACTOR SHALL BE RESPONSIBLE FOR THE DESIGN OF THE SYSTEM AND THE CONTRACTOR SHALL BE RESPONSIBLE FOR THE DESIGN OF THE SYSTEM.

Rev	Date	Drawn	Check	App
Status				
TENDER DRAWING				
Architect RHWL Architects or RICHARD GRIFFITHS ARCHITECTS 100 West Street, London EC4A 3DF T: 020 7553 7000 F: 020 7553 4000				
Client Manhattan Loft Corporation Limited				
Project St Pancras Chambers				
Title WEST CHAMBERS THIRD FLOOR FIRE PROTECTION LAYOUT sheet 2 of 4 LOW LEVEL				
Mod	PK	CAD	PK	
CKD	10/05/05	10/05/05	10/05/05	Scale 1:100
App	DTS	Date	MAY 05	
FABER MAUNSELL AECOM				
Faber Maunsell - a division of AECOM 100 West Street, London EC4A 3DF T: 020 7553 7000 F: 020 7553 4000 www.fabermaunsell.com				
© 23101/DD/FP/205/2				0

NOTES

1. WORK TO FOURED DIMENSIONS ONLY.
2. THE DRAWING TO BE READ IN CONJUNCTION WITH ALL RELEVANT FABRIC DETAILS AND STRUCTURAL ENGINEERING DRAWINGS.
3. THE DRAWING TO BE READ IN CONJUNCTION WITH ALL RELEVANT FABRIC MANUFACTURE DRAWINGS.
4. THE DRAWING TO BE READ IN CONJUNCTION WITH ALL RELEVANT SCHEMATIC DRAWINGS.
5. THESE DRAWINGS INDICATE MAIN POINTS FOR FOLDING FOR IMPROVED FITTING. OTHER FITTED DRAUGHTS ARE TO BE DEVELOPED AFTER SPECIFIC SPREADS AND CONTRASTS.

FOR CONTINUATION REFER TO DRG. No. 23101/DD/FP/205/4

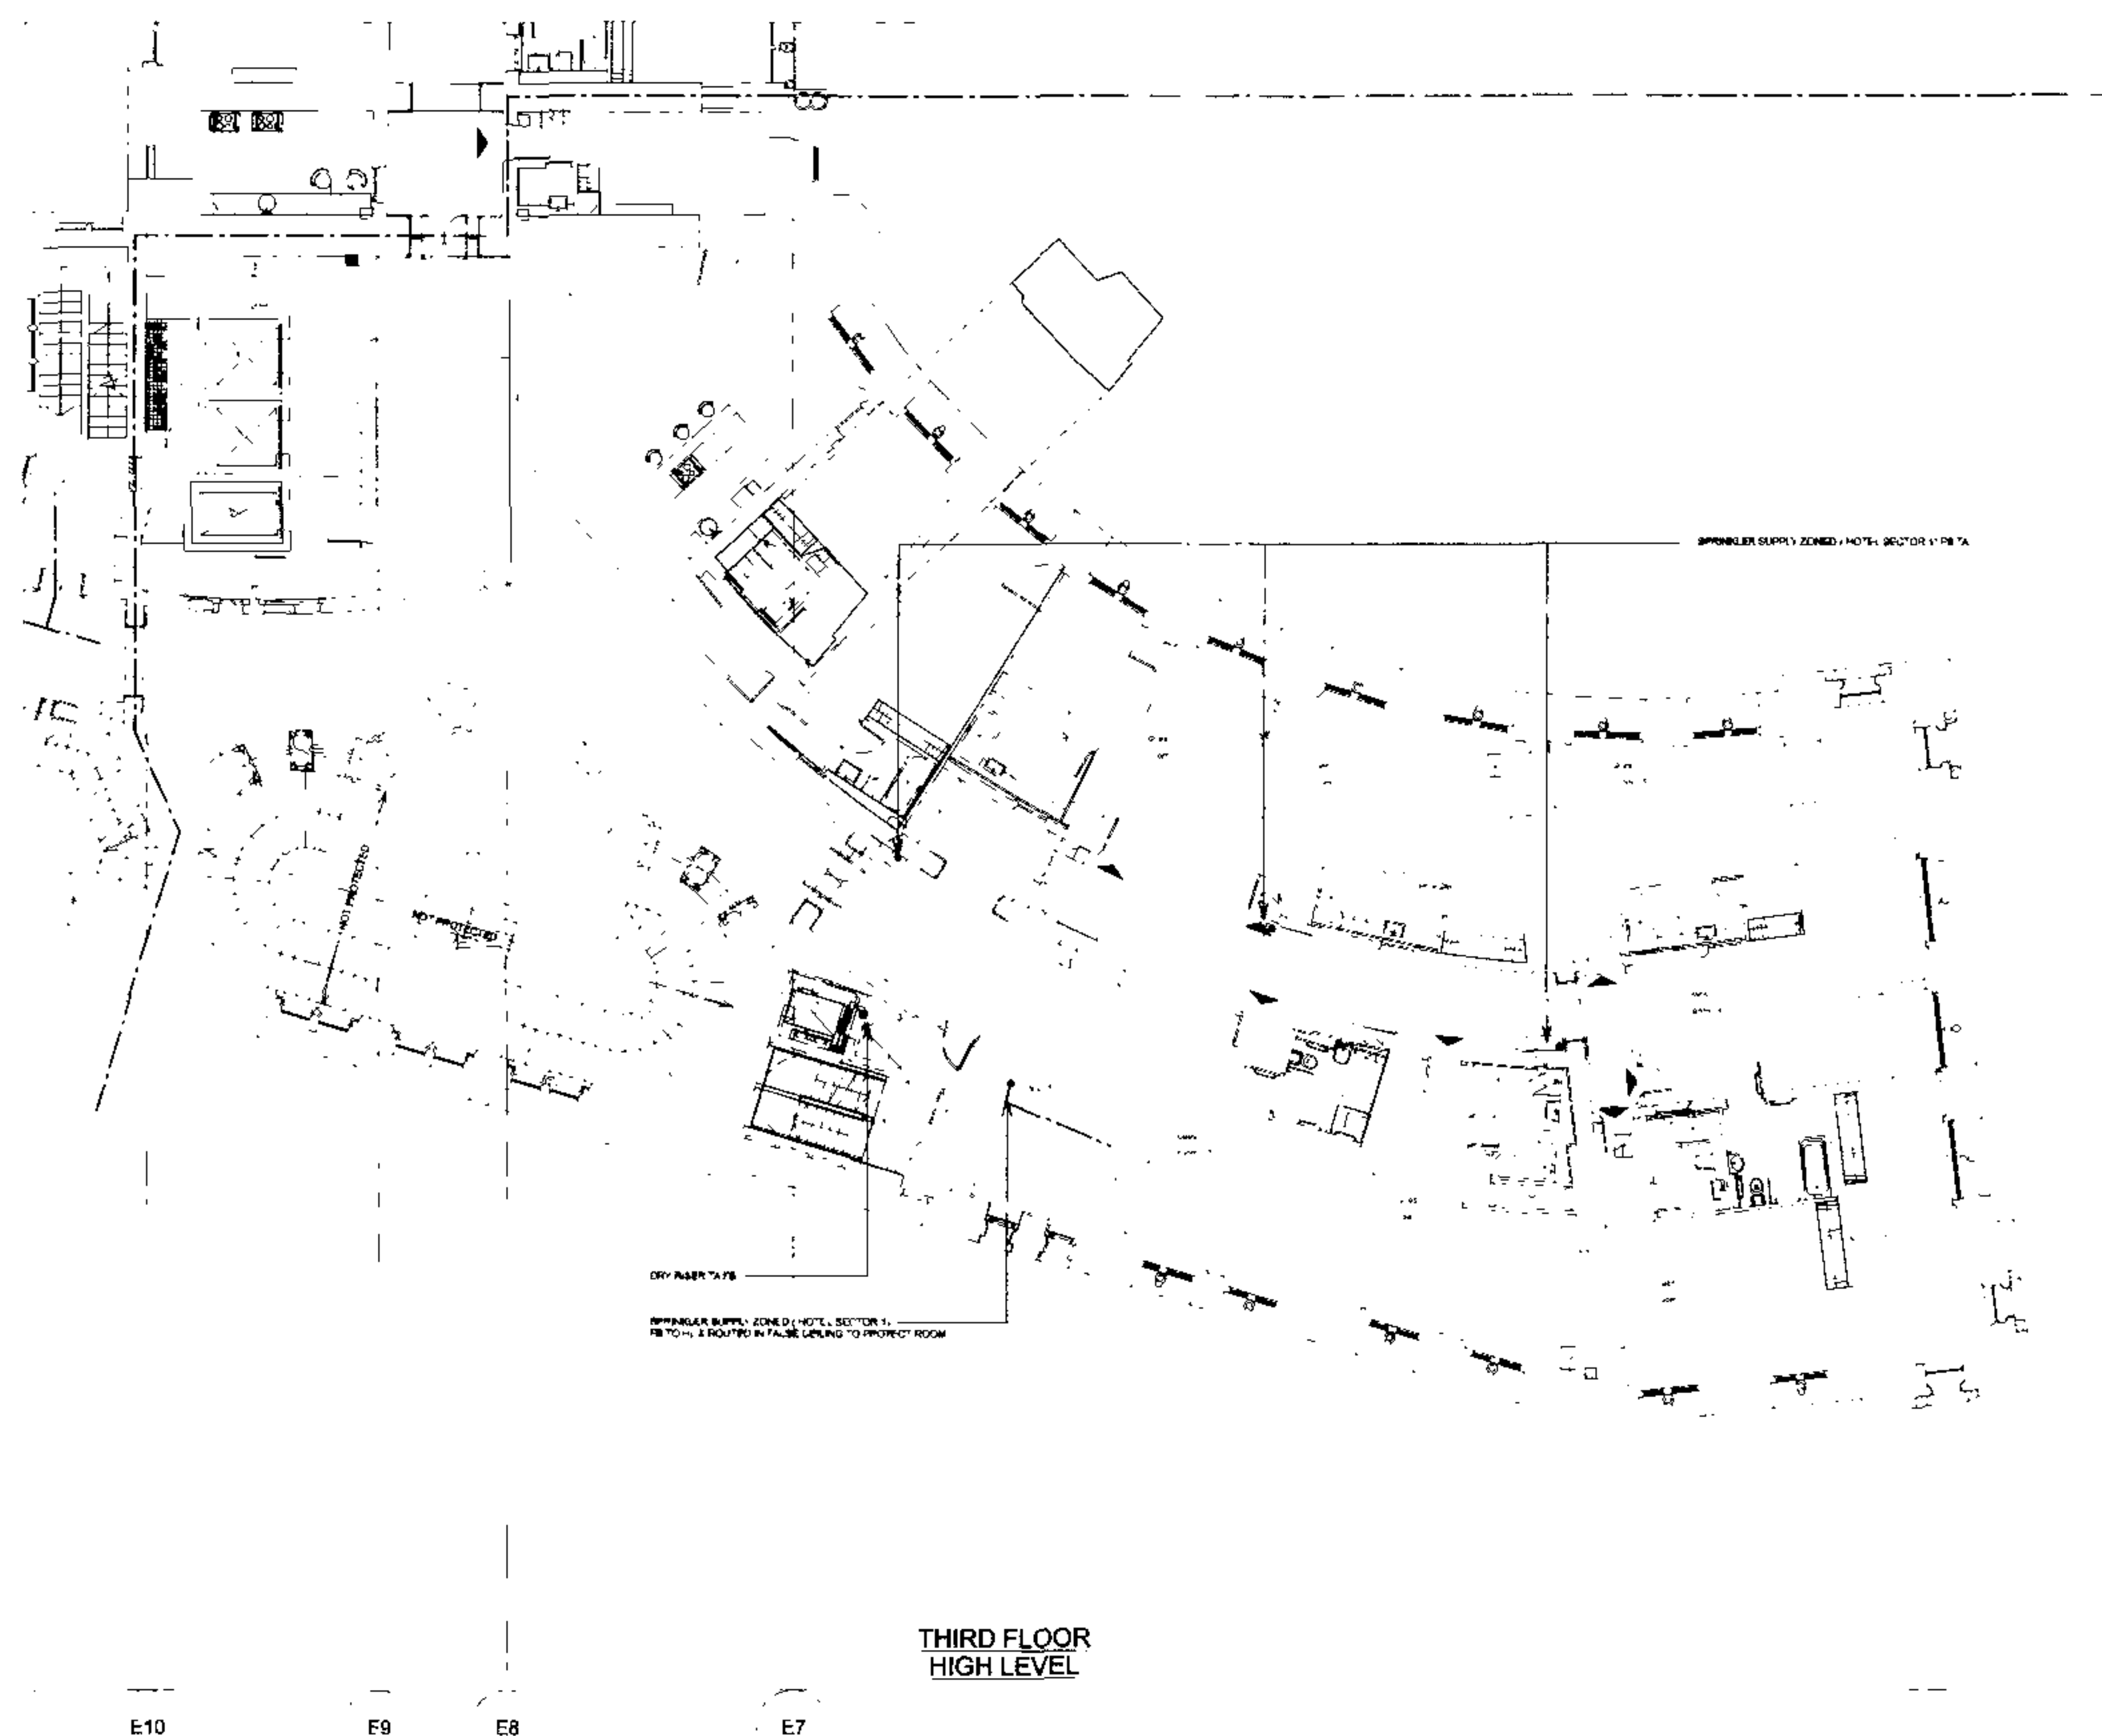

THIRD FLOOR
HIGH LEVEL

E10

F9

F8

E7

Place	Date	Details	Amount	Chq	Bank
-------	------	---------	--------	-----	------

**TENDER
DRAWING**

Architect
RHWL Architects
and
RICHARD GRIFFITHS ARCHITECTS
77 Andover Street, Lower Weymouth, MA 02578
Tel: 508-727-7888 Fax: 508-727-8844

Client
**Manhattan Loft
Corporation Limited**

Project

St Pancras Chambers

WEST CHAMBERS
THIRD FLOOR
FIRE PROTECTION
LAYOUT
sheet 3 of 4 HIGH LEVEL

Made	Pl			CAD	Pl
CK'd	check	alloc	pr CFO	Scale	1:100
App	DTE			Date	MAY 06


FABER MAUNSELL | AECOM

Marlborough House
Janet Marlborough Ross
30 Myers, Marlborough A. 1 SU
T 444 7029 8734 5734
F 444 7020 8734 2700
www.marlborough.com


N/C. 23101/DD/FP/205/3	0
------------------------	---

[illegible]

Uditer + uterivastichiter

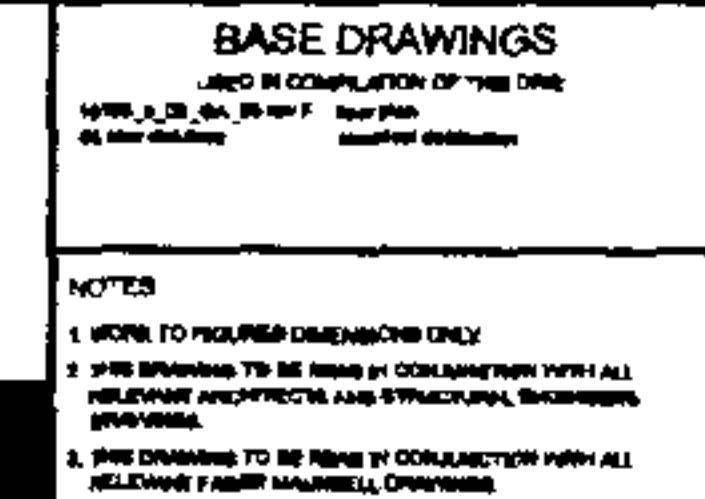

 4. THIS DRAWING TO BE READ IN CONNECTION WITH RELATED SCHEMATIC DRAWINGS.
5. FOR FURTHER DETAILS REFER TO SPEC. DIV. 22-00000-00001 AND 25-00000-00000.



Status			
TENDER DRAWING			
Architect RHWL Architects and RICHARD GRIFFITHS ARCHITECTS 17 West Road, London W12 8JF T 01-235 2000 ext. 2 fax 01-235 2001			
Client Manhattan Loft Corporation Limited			
Project St Pancras Chambers			
Title WEST CHAMBERS THIRD FLOOR ELECTRICAL DISTRIBUTION LAYOUT sheet 1 to 2			
Made	R.T.G.	C.A.D.	P.C.
Civil		Scale	1:100
App.	S.F.	Date	MAY 08
FABER MANUSCRIPT		AECOM	
Manufacturing Manual 100000, Project No. 100000		7 2000 0000 0000 0000 0000 0000 0000 0000	
N.C.		23101/AD/E/206/1	0