

BASE DRAWINGS
USED IN COMPLETION OF THIS DRG
1. DRG. NO. 23101/DD/E/215/1
2. DRG. NO. 23101/DD/E/215/2
3. DRG. NO. 23101/DD/E/215/3
100. DRG. NO. 23101/DD/E/215/100

NOTES
1. WORK TO YOUR OWN DIMENSIONS ONLY
2. THIS DRAWING TO BE PLACED IN CONJUNCTION WITH ALL RELEVANT ARCHITECTS AND ELECTRICAL ENGINEERS DRAWINGS
3. THIS DRAWING TO BE READ IN CONJUNCTION WITH ALL RELEVANT MECHANICAL ENGINEERS DRAWINGS
4. THIS DRAWING TO BE READ IN CONJUNCTION WITH ALL RELEVANT STRUCTURAL ENGINEERS DRAWINGS


UNNOTED AREAS TO BE DESIGNED BY LEASING SPECIALIST

FOR CONTINUATION REFER TO DRG. No. 23101/DD/E/115

FOR CONTINUATION REFER TO DRG. No. 23101/DD/E/215/2



Rev	Code	Drawn	Checked	By
1				
Status				
TENDER DRAWING				
Architect				
RHWL Architects and RICHARD GRIFFITHS ARCHITECTS 17 Broad Street, London EC4A 3DF T: 020 7553 1000 F: 020 7553 1001				
Client				
Manhattan Loft Corporation Limited				
Project				
St Pancras Chambers				
Title				
WEST CHAMBERS THIRD FLOOR LIGHTING & FIRE ALARM LAYOUT sheet 1 of 2				
Made	RIG	CAD	DBN	
Check	SP	Scale	1:100	
App.	SP	Date	MAY 05	
FABER MAUNSELL AECOM				
Faber Maunsell 17 Broad Street, London EC4A 3DF T: 020 7553 1000 F: 020 7553 1001 www.fabermaunsell.com				
23101/DD/E/215/1 0				

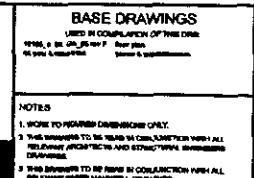


NOTES


1. WORK TO BE DONE DRAINAGE ONLY.
2. THIS DRAWING TO BE READ IN CONJUNCTION WITH ALL RELEVANT ARCHITECTURAL AND STRUCTURAL DRAWINGS.
3. THIS DRAWING TO BE READ IN CONJUNCTION WITH ALL RELEVANT POWER MAINS/DRAINAGE.
4. THIS DRAWING TO BE READ IN CONJUNCTION WITH RELEVANT ROADSIDE DRAINAGE.
5. SECURITY EQUIPMENT PROVIDED FOR CORRESPONDING PURPOSES. FIREWORKS AND POWER RESERVEMENT TO BE COMPLETED.
6. WHERE A SEALED BOLLARD IS INDICATED ALLOW FOR A SEALING PROTECTED BOLLARD, CONCRETE.

CIRCUIT NUMBER
CIRCUIT
CIRCUIT CIRCUIT IS SUPPLIED FROM LOCAL
NON-CAPITAL DISTRIBUTION BOARD
CIRCUIT
CIRCUIT CIRCUIT IS SUPPLIED FROM LOCAL
CIRCUIT CIRCUIT BOARD
CIRCUIT
CIRCUIT CIRCUIT TYPE =
SIR CIRCUIT CIRCUIT PROTECTED BY
SIR CIRCUIT CIRCUIT BOARD
CIRCUIT
CIRCUIT CIRCUIT TYPE =
SIR CIRCUIT CIRCUIT PROTECTED BY
SIR CIRCUIT CIRCUIT BOARD

FOR CONTINUATION REFER TO DRG. No. 23101/DD/E/225/2

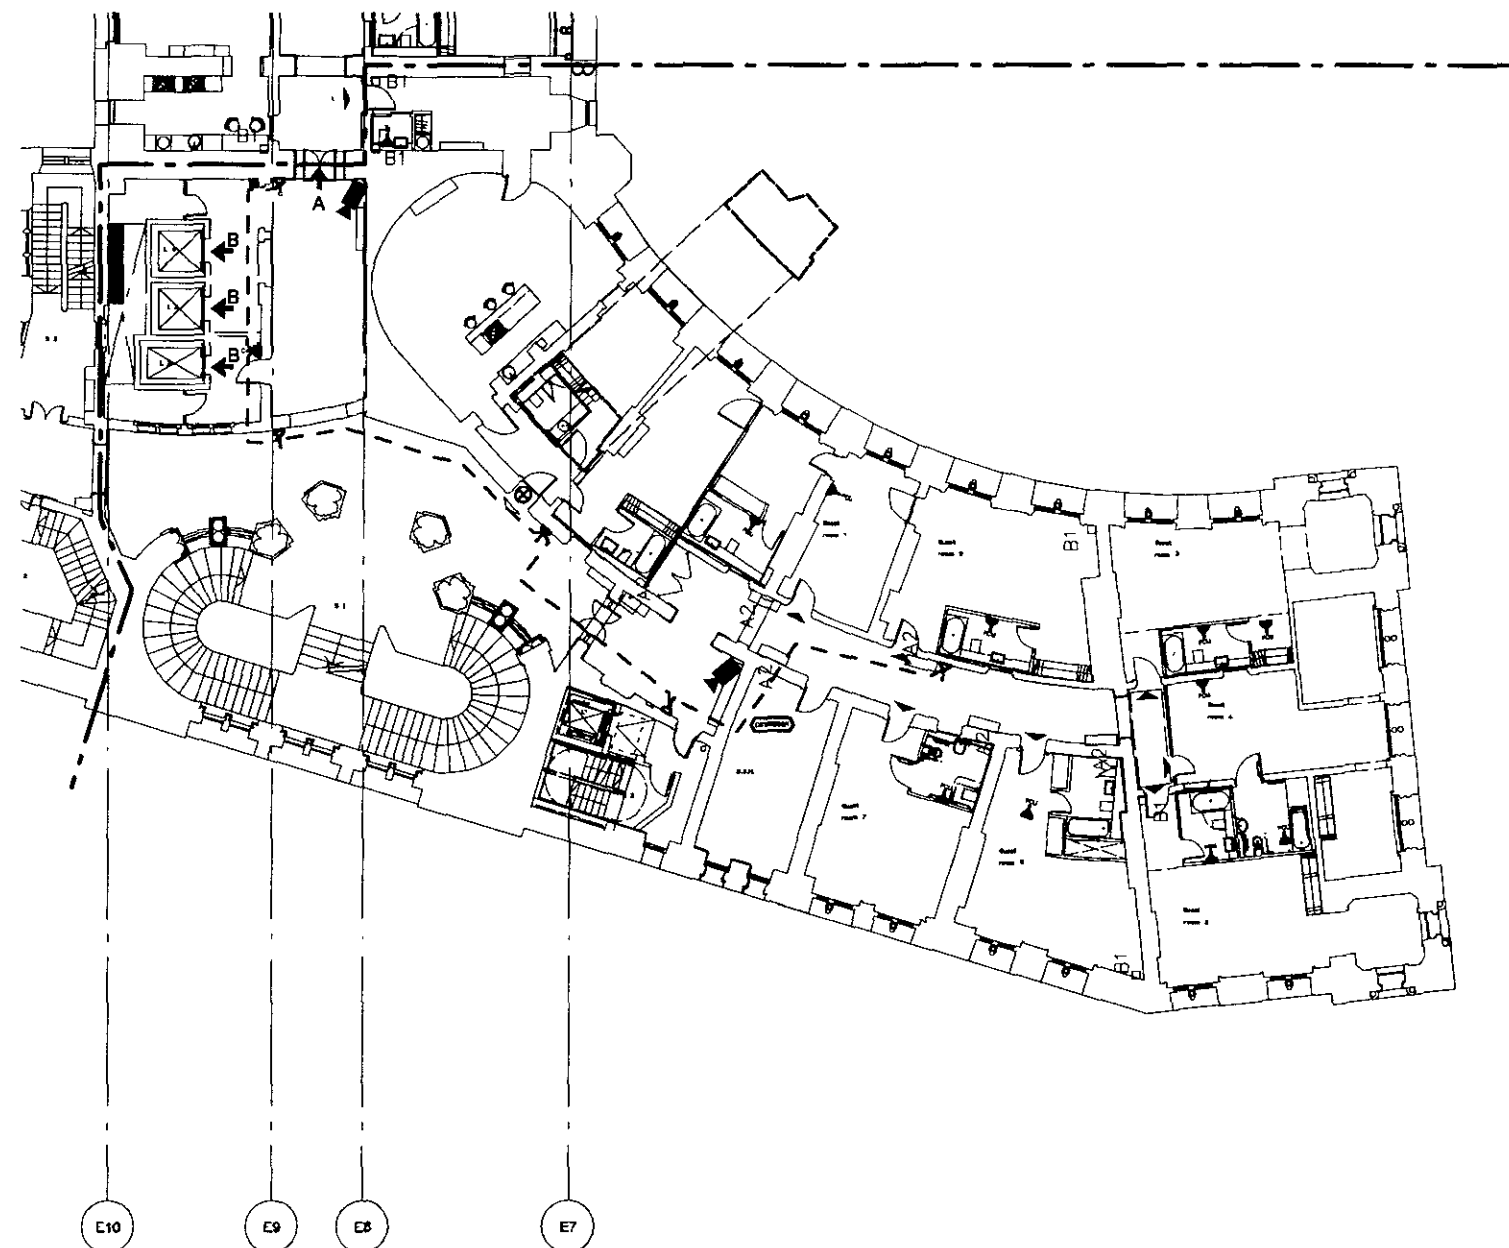

No.	Date	Revised	Scale	Qty	Proj.
Status					
TENDER DRAWING					
Architect: RHAWL Architects and RICHARD GRIFFITHS ARCHITECTS 7 North Street, Suite 1000 100-100 New York, N.Y. 10021					
Client: Manhattan Loft Corporation Limited					
Project: St Pancras Chambers					
Title: WEST CHAMBERS THIRD FLOOR SMALL POWER & MISCELLANEOUS LAYOUT sheet 1 of 2					
Materials	P.C.	C.A.D.		P.C.	
CAD	1:1	Scale	1:1 MD		
App.	R.P.	Date	MAY 08		
FABER MALINSSELL AECOM					
preparatory drawing 1/1000, 1/2000, 1/500 1/1000, 1/2000, 1/500 1/1000, 1/2000, 1/500					
NO. 23101/DD/E/225/1					0

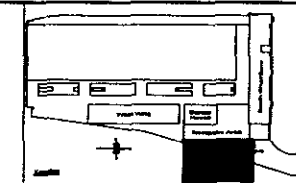

BASE DRAWINGS


USED IN COMPLETION OF THIS ONE
1. THIS DRAWING IS THE PROPERTY OF THE CLIENT
2. THIS DRAWING IS NOT TO BE REPRODUCED OR COPIED IN ANY MANNER WITHOUT THE WRITTEN PERMISSION OF THE CLIENT
3. THIS DRAWING IS NOT TO BE USED FOR ANY OTHER PROJECT WITHOUT THE WRITTEN PERMISSION OF THE CLIENT
4. THIS DRAWING IS NOT TO BE USED FOR ANY OTHER PROJECT WITHOUT THE WRITTEN PERMISSION OF THE CLIENT
5. THIS DRAWING IS NOT TO BE USED FOR ANY OTHER PROJECT WITHOUT THE WRITTEN PERMISSION OF THE CLIENT
6. THIS DRAWING IS NOT TO BE USED FOR ANY OTHER PROJECT WITHOUT THE WRITTEN PERMISSION OF THE CLIENT
7. THIS DRAWING IS NOT TO BE USED FOR ANY OTHER PROJECT WITHOUT THE WRITTEN PERMISSION OF THE CLIENT
8. THIS DRAWING IS NOT TO BE USED FOR ANY OTHER PROJECT WITHOUT THE WRITTEN PERMISSION OF THE CLIENT
9. THIS DRAWING IS NOT TO BE USED FOR ANY OTHER PROJECT WITHOUT THE WRITTEN PERMISSION OF THE CLIENT
10. THIS DRAWING IS NOT TO BE USED FOR ANY OTHER PROJECT WITHOUT THE WRITTEN PERMISSION OF THE CLIENT

NOTES

1. WORK TO POWER DISTRIBUTION PANEL
2. THIS DRAWING TO BE READ IN CONJUNCTION WITH ALL RELEVANT ELECTRICAL AND STRUCTURAL DRAWINGS
3. THIS DRAWING TO BE READ IN CONJUNCTION WITH ALL RELEVANT ELECTRICAL DRAWINGS
4. THIS DRAWING TO BE READ IN CONJUNCTION WITH ALL RELEVANT ELECTRICAL DRAWINGS
5. SECURITY EQUIPMENT PROVIDED FOR CORRIDOR FLUORESCENT FINAL LOCATIONS AND POWER REQUIREMENT TO BE COMPLETED
6. WHERE A BALANCED ISOLATOR IS INDICATED ALLOW FOR A BALANCED PROTECTED RADIAL CIRCUIT

LEGEND

- DISCONNECT**
DISCONNECT CIRCUIT IS SUPPLIED FROM LOCAL NON-REVERSIBLE SWITCHBOARD PANEL
- DISCONNECT**
DISCONNECT CIRCUIT IS SUPPLIED FROM LOCAL NON-REVERSIBLE SWITCHBOARD PANEL
- DISCONNECT**
DISCONNECT CIRCUIT TYPE 1
25A FUSE FINAL CIRCUIT PROTECTED BY 25A DISCONNECT WITH 100A MCB
- DISCONNECT**
DISCONNECT CIRCUIT TYPE 1
25A FUSE FINAL CIRCUIT PROTECTED BY 25A DISCONNECT WITH 100A MCB

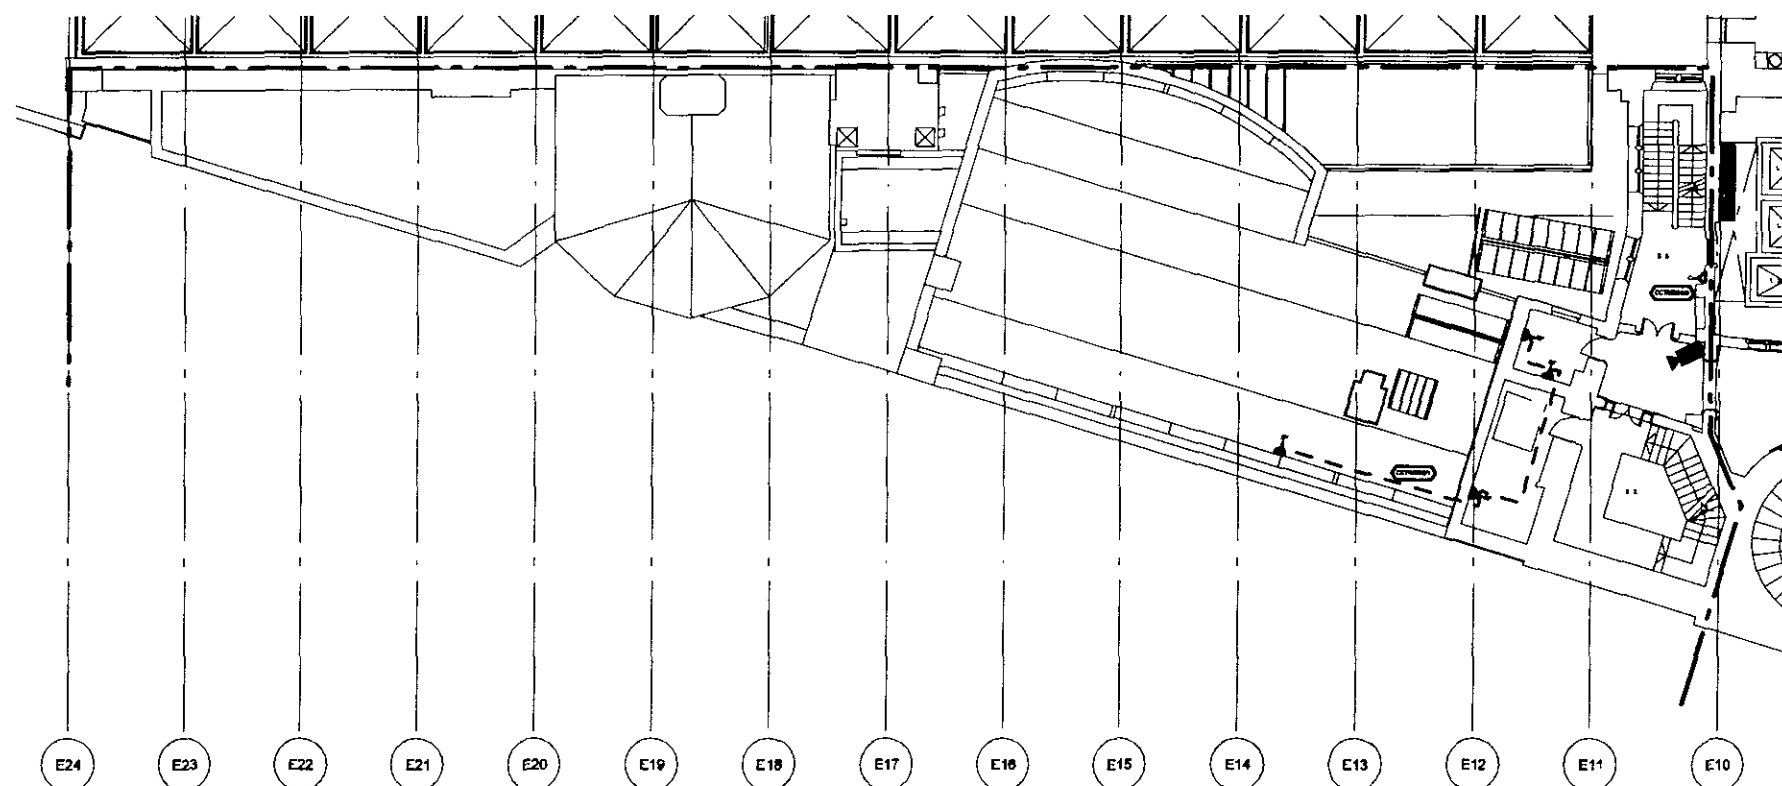

FOR CONTINUATION REFER TO DRG. No. 23101/DD/E/225/1

Rev	Date	By	Check	Drawn

TENDER DRAWING

Architect
RHML Architects
RICHARD GRIFFITHS ARCHITECTS
11 West Street London WC2E 8NE
T: 020 7553 2000 F: 020 7553 2001

Client
Manhattan Loft Corporation Limited

Project
St Pancras Chambers

Title
**WEST CHAMBERS
THIRD FLOOR
SMALL POWER &
MISCELLANEOUS LAYOUT
sheet 2 of 2**


Design	PC	C.A.D.	PD
Check	Scale	1:100	
App.	Date		

FABER MALINSSELL **AECOM**

Project No. 23101/DD/E/225/2 0

WHERE INDICATED SERVICES DISTRIBUTION WITHIN EACH ROOM ARE BASED ON SCHEME DESIGN LAYOUTS. FINAL LAYOUTS TO BE AGREED.

WITHIN OTHER AREAS FINAL SERVICES DISTRIBUTION PROPOSALS WITHIN ROOM TO BE CONFIRMED.

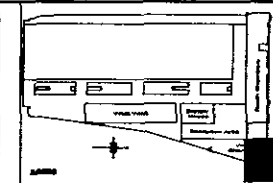

BASE DRAWINGS

TO PERSONS DISSEMINATING ONLY

NOT TO BE READ IN CONJUNCTION WITH AND
BY ARCHITECTS AND STRUCTURAL ENGINEERS

NOT TO BE READ IN CONJUNCTION WITH ALL
FBIER MEMBERSHIP DISSEMINATING

NOT TO BE READ IN CONJUNCTION WITH
STRUCTURAL ENGINEERS

FOR DETAILS REFER TO DISSEMINATING IN
DISSEMINATING

FOR CONTINUATION REFER TO DRG. No 23101/DD/M/105

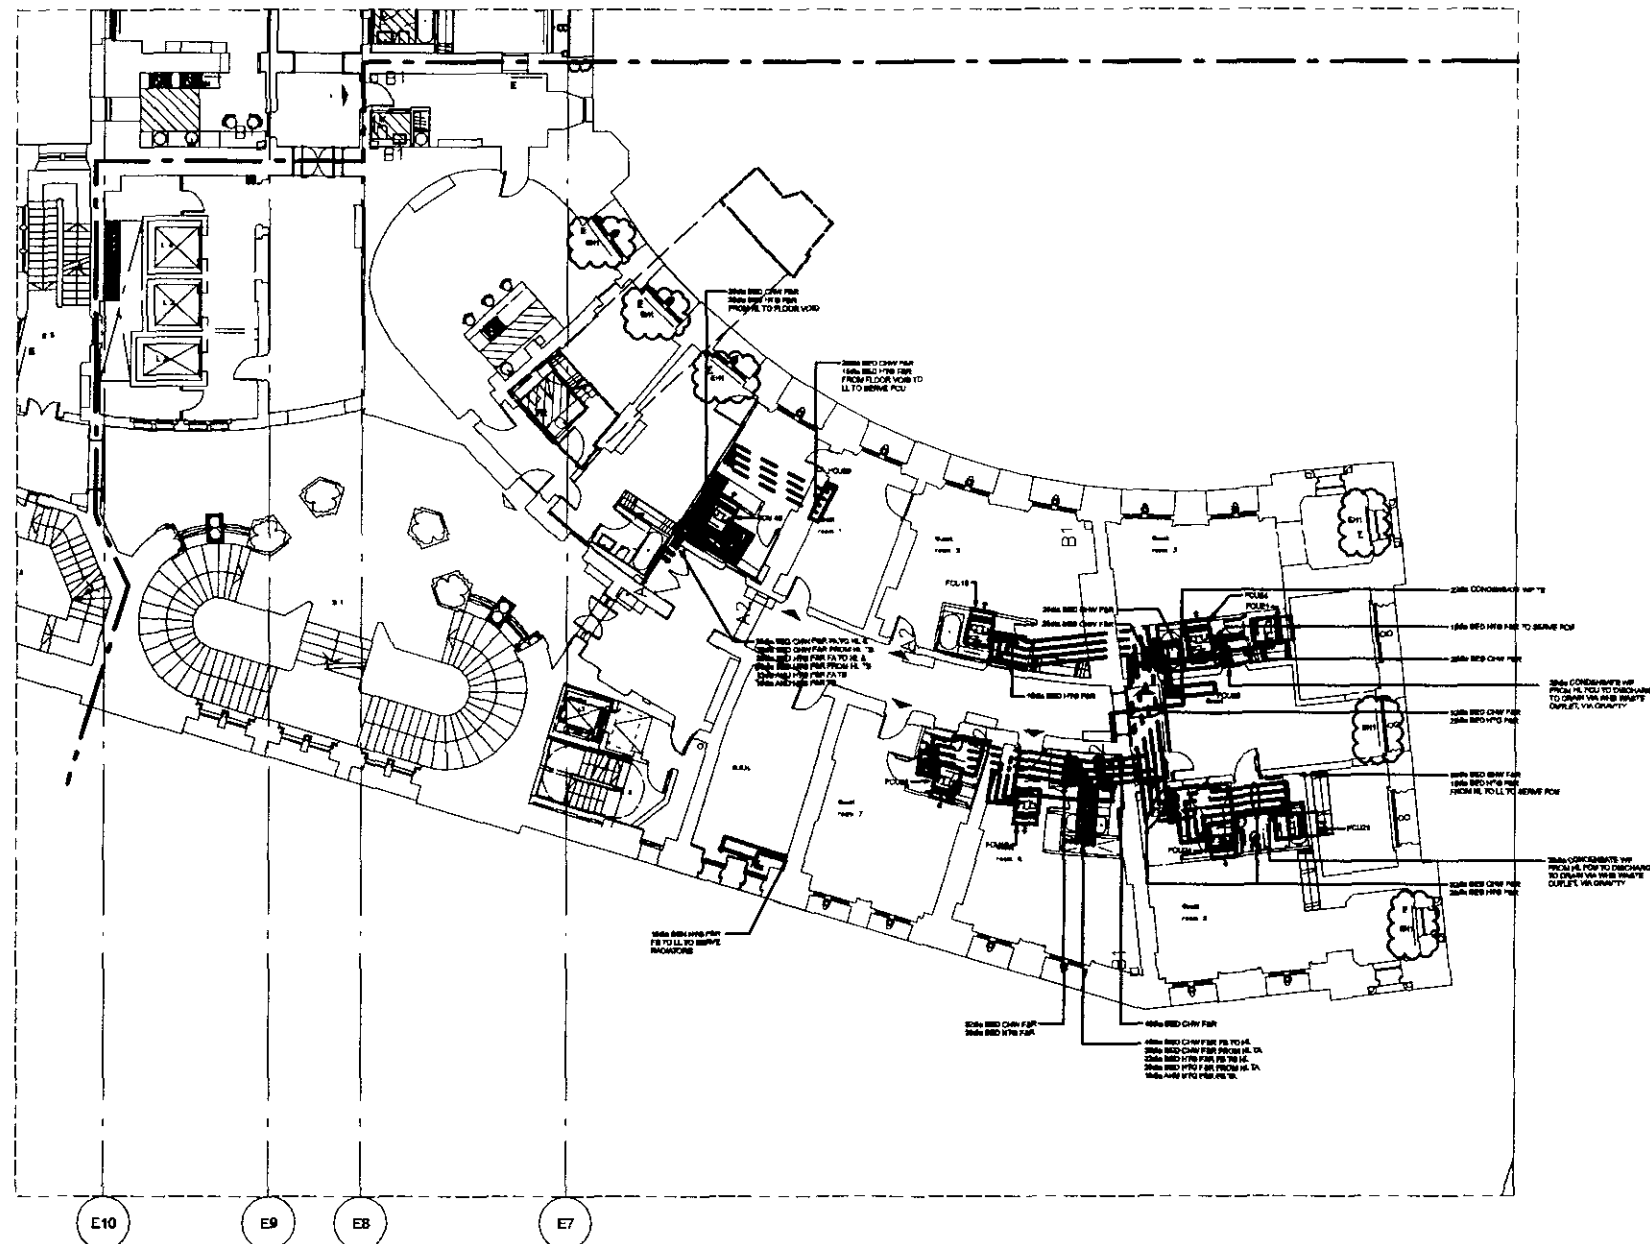


Diagram illustrating the installation of a steam trap. The trap is connected to a main condensate line and a discharge line.


FCU CONDENSATE DETAIL

1	Arch	ENC 3 Member/Architects under the program	AF		
Rev	Rev	Rev	Rev	Clad	Page
STATUS TENDER DRAWING					
Architect RHWL Architects and RICHARD GRIFFITHS ARCHITECTS 7 West Street, Suite 200 1000 West 4th Street, Suite 200					
Client Manhattan Loft Corporation Limited					
Project St Pancras Chambers					
Title WEST CHAMBERS THIRD FLOOR HEATING AND COOLING LAYOUT Sheet 1 of 2					
Scale SC CAD ☒ MAN ☐ SCALE 1:100		C.A.D. SC Scale 1:100			
App. D.T.E.		Date MAY 08			
FABER DAINSELLE AECOM					
Technical/Design/Drawings Department		7 West Street, Suite 200 1000 West 4th Street, Suite 200 New York, New York, NY 10014			
NO. 23101/MDV/M/205/1 Rev 0					
DR		AD			

NOTE

WHERE INDICATED SERVICES DISTRIBUTION WITHIN EACH ROOM ARE BASED ON SCHEME DESIGN LAYOUTS. FINAL LAYOUTS TO BE AGREED.

WITHIN OTHER AREAS FINAL SERVICES DISTRIBUTION PROPOSALS WITHIN ROOM TO BE CONFIRMED

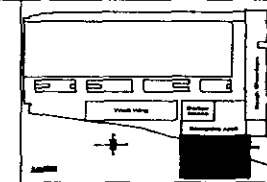


BASE DRAWINGS

USED IN COMPLETION OF THIS ONE

NOTES

1. WORK TO BE AGREED ON DRAWINGS ONLY
2. THIS DRAWING TO BE USED IN CONSTRUCTION WITH ALL NECESSARY ARCHITECTURAL AND STRUCTURAL BASIS DRAWINGS
3. THIS DRAWING TO BE USED IN CONSTRUCTION WITH ALL NECESSARY FINISH DRAWINGS... DRAWINGS
4. THIS DRAWING TO BE USED IN CONSTRUCTION WITH NECESSARY ELECTRICAL DRAWINGS
5. FOR FURTHER DETAILS REFER TO DRAWING IN 231101/000/205/1

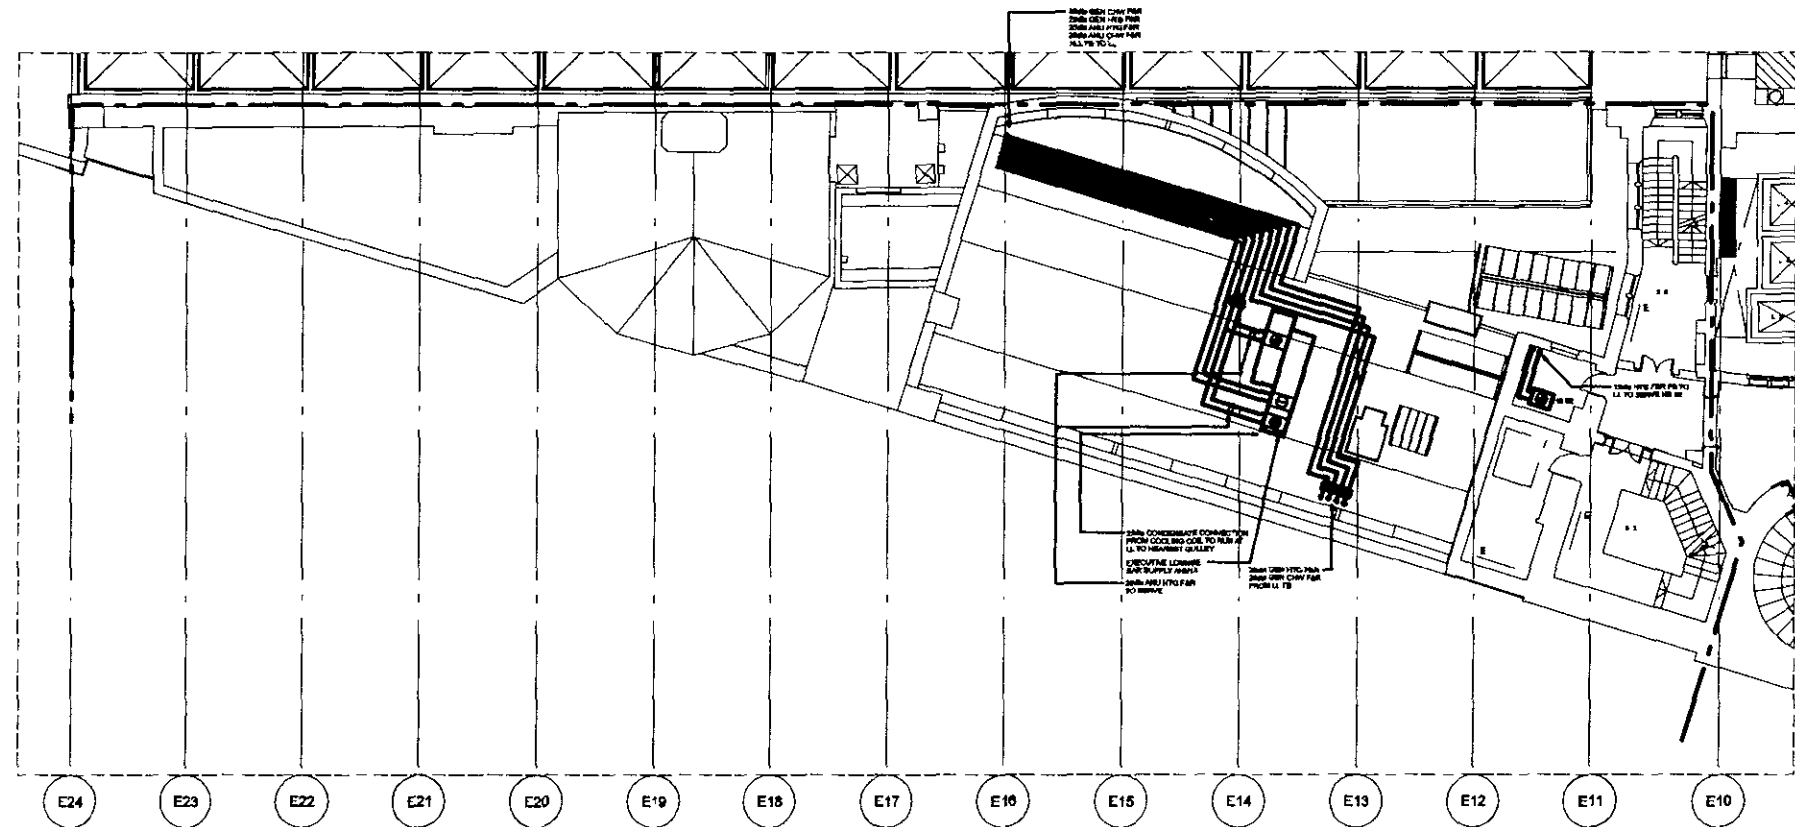

Rev	Desc	Rev	Desc
1	Issue	1	Issue

TENDER DRAWING

Architect
RHWL Architects
RICHARD GRUFFITHS ARCHITECTS
11, 12, 13, 99, 100

Client
Manhattan Loft Corporation Limited

Project
St Pancras Chambers

Title
WEST CHAMBERS
THIRD FLOOR
HEATING AND COOLING
LAYOUT
Sheet 2 of 2

Maker
S.C. C.A.D. S.C.
C.V.D. L.S. S.C. Scale 1:100
App. D.T.S. Date MAY 08

FABER MALINSSELL AECOM

231101/000/205/2

0

FOR CONTINUATION REFER TO DRG No 23101/DD/PH/105

FOR CONTINUATION REFER TO DRG. No. 23101/DD/PH/205/2

E7

Issue	Date	Content	Initiating	Close
Status				

TENDER
DRAWING

Architect
RHWL Architects
and
RICHARD GRIFFITHS ARCHITECTS
77 Oxford Street London W1C 2BS
Tel 020 779 7000 • Fax 020 7726 4802

Client
Manhattan Loft
Corporation Limited

Project	St Pancras Chambers
---------	---------------------


Title WEST CHAMBERS
THIRD FLOOR
PUBLIC HEALTH
SERVICES LAYOUT
sheet 1 of 2

Name	B. J.	C.A.D	AD
Gr'd	SECH	SEC	100
App	C.F.D	Date	MAY 01


FABER MAUNSELL AECO

Mailborough House
Upper Mailborough Road
St Albans, Hertfordshire AL1 3JY
T +44 (0)20 8704 8700
F +44 (0)20 8704 5000
www.silverdale.co.uk

N. C. 23101/DD/PH/205/1

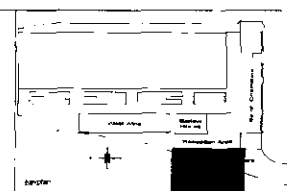

- BASE DRAWINGS**
USED IN COMPLETION OF THIS DRG
- NOTES**
1. WORK TO REQUIRED DIMENSIONS ONLY
 2. THIS DRAWING TO BE READ IN CONJUNCTION WITH ALL RELEVANT ARCHITECT'S AND STRUCTURAL SPECIFICATIONS
 3. THIS DRAWING TO BE READ IN CONJUNCTION WITH ALL RELEVANT PAPER MAINTAINED DRAWINGS
 4. THIS DRAWING TO BE READ IN CONJUNCTION WITH ALL RELEVANT SCALE DRAWINGS
- LEGEND**
- WWS - MAIN WATER SERVICE
 - WWS - BOOSTED COLD WATER SERVICE
 - WWS - BOOSTED HOT WATER SERVICE
 - WWS - LOW LEVEL
 - WWS - HIGH LEVEL
 - WWS - FROM BELOW
 - WWS - TO BELOW
 - WWS - FROM ABOVE
 - WWS - TO ABOVE
 - WWS - BOOSTED MAIN WATER SERVICE
 - WWS - COLD TOP GULLY
 - WWS - HOT TOP GULLY
 - WWS - RAIN WATER PIPE
 - WWS - RAIN WATER OUTLET
 - WWS - ACCESS
 - WWS - CLEANING EYE
 - WWS - AUTOMATIC AIR VENT
 - WWS - FLOODING EYE
 - WWS - BOOSTED BOOSTED COLD WATER SERVICE
 - WWS - COLD WATER STORAGE TANK

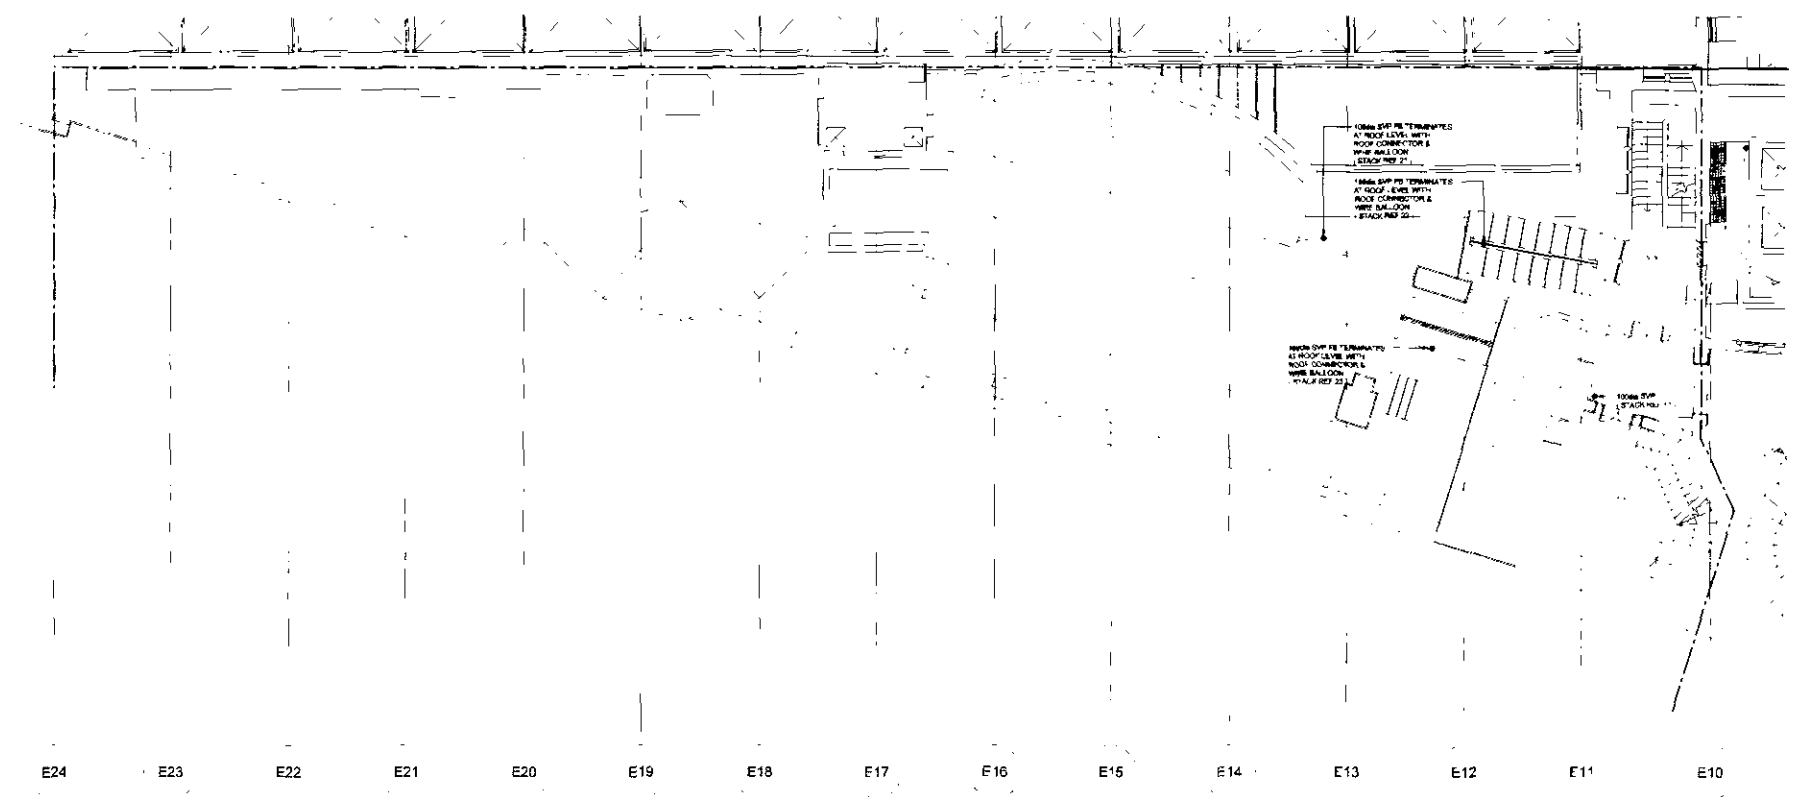


FOR CONTINUATION REFER TO DRG No. 23101/DD/PH/205/1

Status	
TENDER DRAWING	
Architect	
RHWL Architects RICHARD GRIFFITHS ARCHITECTS 100 Broad Street, W2D 1RQ 020 7734 1000 / 020 7734 1001	
Client	
Manhattan Loft Corporation Limited	
Project	
St Pancras Chambers	
Title	
WEST CHAMBERS THIRD FLOOR PUBLIC HEALTH SERVICES LAYOUT sheet 2 of 2	
Made	By
Checked	By
App	Date
FABER MAUNSELL ACCOM	
23101/DD/PH/205/2	
0	

WHERE INDICATED SERVICES DISTRIBUTION WITHIN EACH ROOM ARE BASED ON SCHEME DESIGN LAYOUTS. FINAL LAYOUTS TO BE AGREED

WITHIN OTHER AREAS FINAL SERVICES DISTRIBUTION PROPOSALS WITHIN ROOM TO BE CONFIRMED

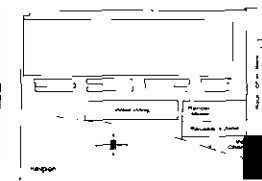


BASE DRAWINGS
USED IN COMPILATION OF THIS DRG

NOTES

1. WORK TO FOURD DIMENSIONS ONLY
2. THIS DRAWING TO BE READ IN CONJUNCTION WITH ALL RELEVANT ARCHITECTS AND STRUCTURAL ENGINEERS DRAWINGS
3. THIS DRAWING TO BE READ IN CONJUNCTION WITH ALL RELEVANT MECHANICAL DRAWINGS
4. THIS DRAWING TO BE READ IN CONJUNCTION WITH RELEVANT SCHEMATIC DRAWINGS
5. FOR TYPICAL DETAILS REFER TO DRAWING NO. 210710060000000004

FOR CONTINUATION REFER TO DRG. No. 23101/DD/M/115

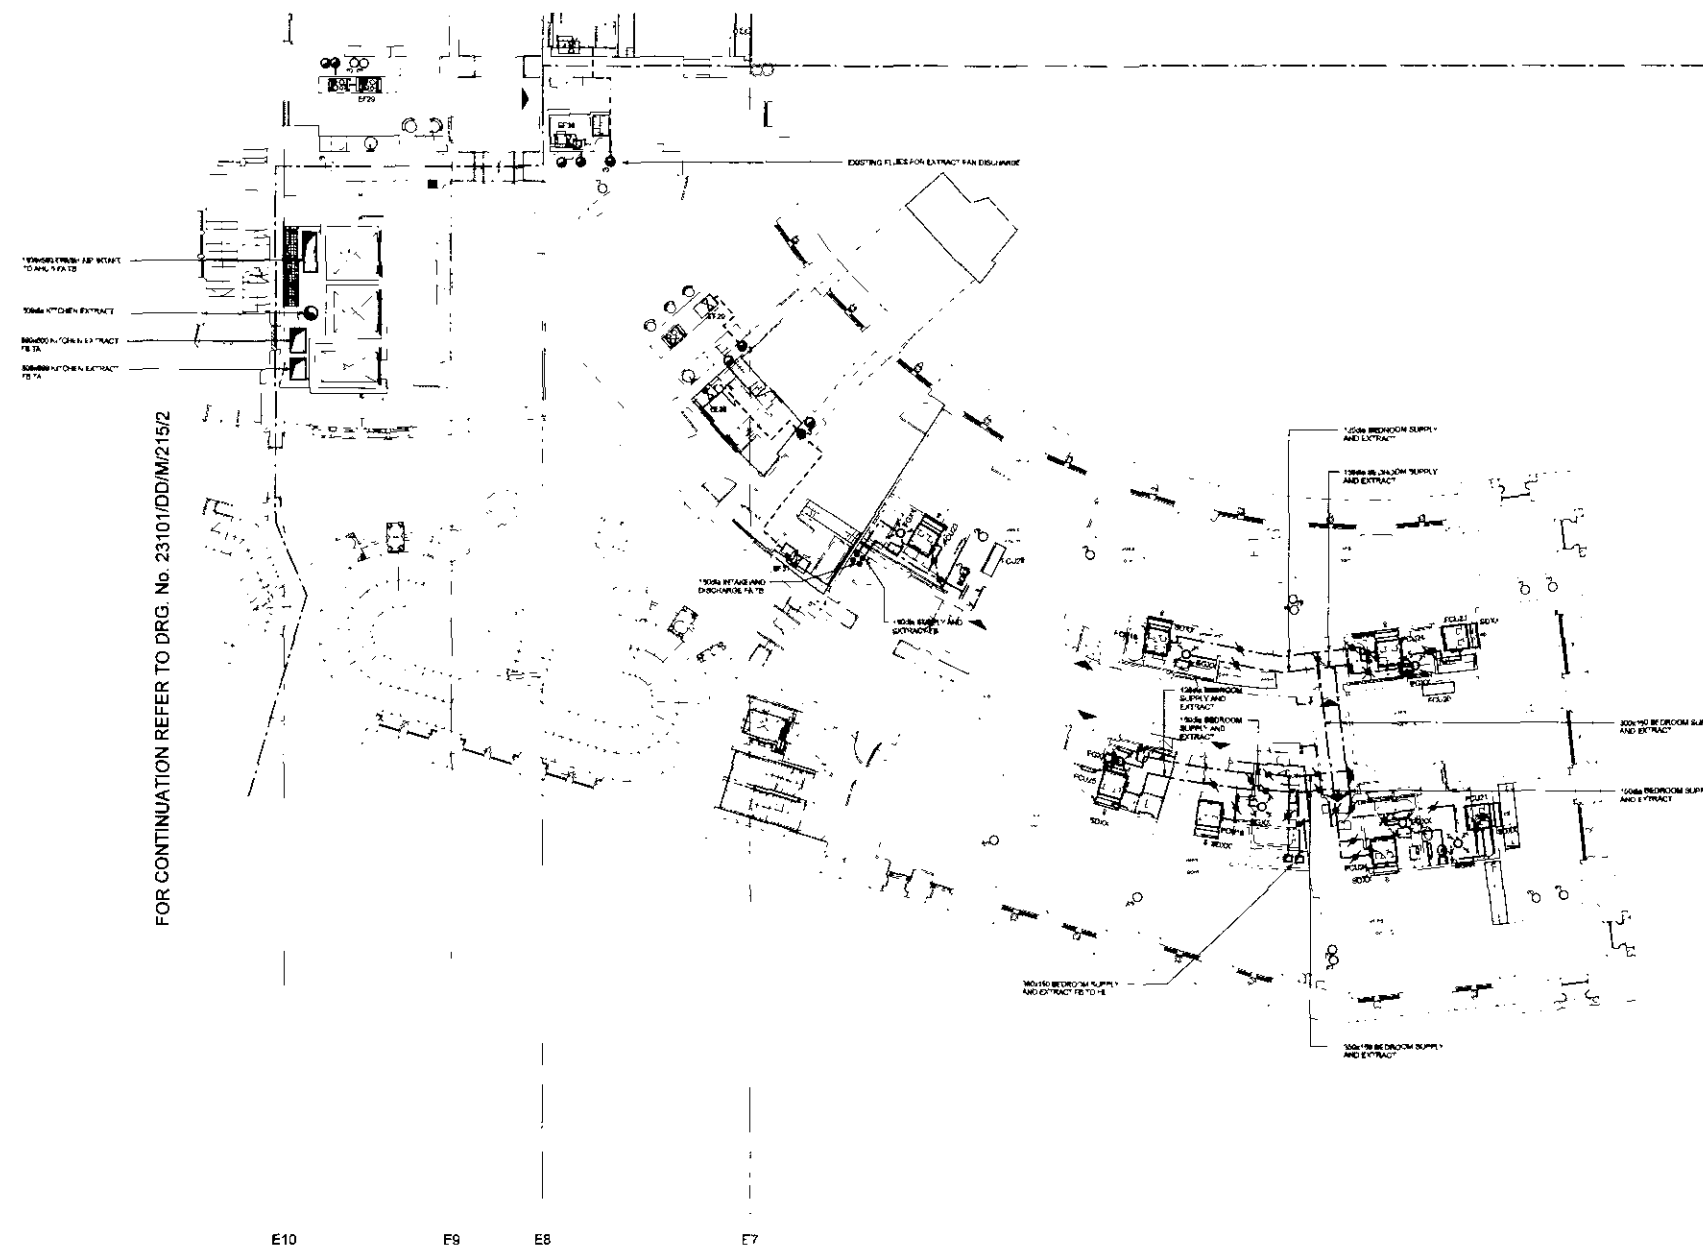

FOR CONTINUATION REFER TO DRG. NO. 23101/DD/M/215/2

Rev.	Date	Drawn	Checked	Cad	Notes
Startups TENDER DRAWING Architect RHWL Architects RICHARD GRIFFITHS ARCHITECTS 1440 West 17th Ave. #210 New York, NY 10011 Tel: 212 758 7878 Fax: 212 758 4882 Client Manhattan Loft Corporation Limited Project St Pancras Chambers Title WEST CHAMBERS THIRD FLOOR VENTILATION LAYOUT Sheet 1 of 2 Made AF CAD P Z Ck'd <u>MB</u> <u>MC</u> <u>P</u> Scale 1/100 App D.T.E. Date MAY 06 FABER MAUNSELL AECOM MacGeeGee Group MacGeeGee House 20 Queensway, London W1 3UJ Tel: 020 7581 8754 Fax: 020 7581 7801 www.mgagroup.co.uk Rev. NO. 2310/1/DD/M/215/1 0					

WHERE INDICATED SERVICES DISTRIBUTION WITHIN EACH ROOM ARE BASED ON SCHEME DESIGN LAYOUTS. FINAL LAYOUTS TO BE AGREED.


WITHIN OTHER AREAS FINAL SERVICES DISTRIBUTION PROPOSALS WITHIN ROOM TO BE CONFIRMED.



BASE DRAWINGS
USED IN COMPIATION OF THIS DPG

NOTES

1. ALWAYS TO PLURED DIMENSIONS ONLY
2. THIS DRAWING TO BE READ IN CONJUNCTION WITH ALL RELEVANT ARCHITECTS AND STRUCTURAL ENGINEERS DRAWINGS
3. THIS DRAWING TO BE READ IN CONJUNCTION WITH ALL RELEVANT FABRIC MANUFACTURER DRAWINGS
4. THIS DRAWING TO BE READ IN CONJUNCTION WITH RELEVANT SCHEMATIC DRAWING
5. FOR TYPICAL USE ALL REFER TO DRAWING NO. 22-0100000000000000

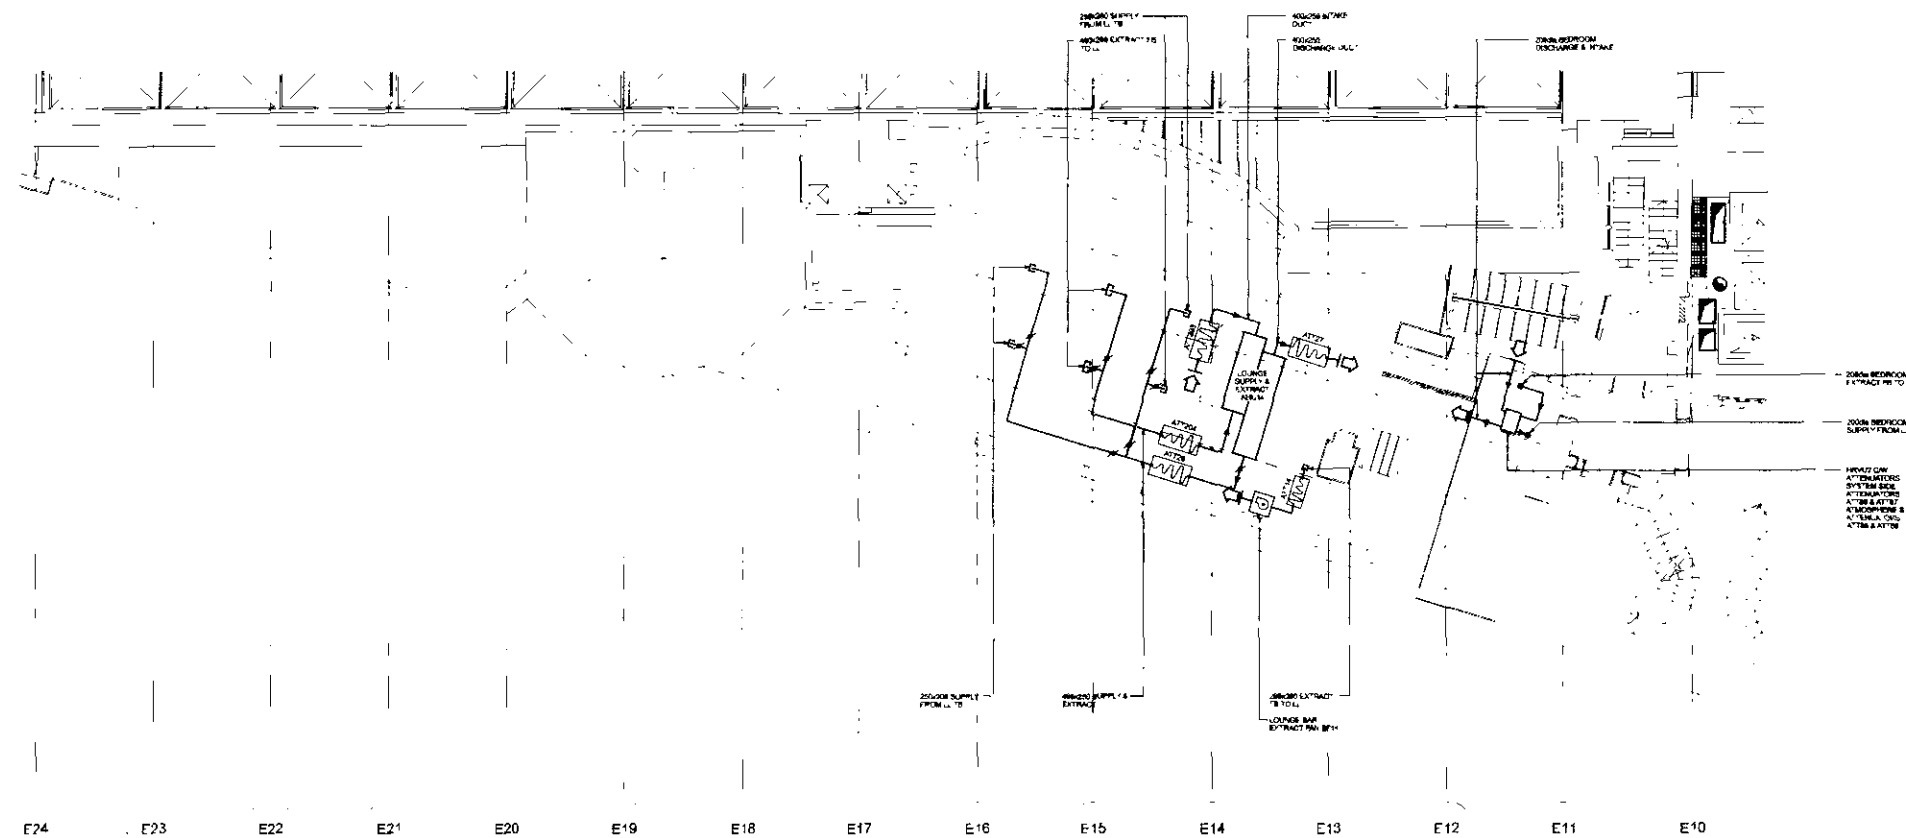

FOR CONTINUATION REFER TO DRG. No. 23101/DD/M/215/1

Page	Case	Notes	Revised	Chd	Drawn
SPECIALS TENDER DRAWING					
Architect RHWL Architects at RICHARD GRIFTHUIS ARCHITECT'S 10001 20th Avenue NW-20 10001 20th Avenue NW-20 10001 20th Avenue NW-20					
Client Manhattan Loft Corporation Limited					
Project St Pancras Chambers					
Title WEST CHAMBERS THIRD FLOOR VENTILATION LAYOUT Sheet 2 of 2					
Made Ckd		AP DATE		CAD Scale	
100% 100%		DATE DATE		100% MAY 02	
FABER MAUNSELL			AICOM		
10001 20th Avenue NW-20 10001 20th Avenue NW-20 10001 20th Avenue NW-20			10001 20th Avenue NW-20 10001 20th Avenue NW-20 10001 20th Avenue NW-20		
23101/DD/M215/2					