



### ELECTRICAL NOTES

1. ANY NEW STEEL WORK / CABLE TRAY / ANTENNA POLES ARE TO BE CONNECTED INTO THE EXISTING LIGHTNING PROTECTION SYSTEM.
2. A NEW DEDICATED 13A SINGLE PHASE POWER SUPPLY IS TO BE INSTALLED WITHIN THE EQUIPMENT ROOM LOCATION AT VIEWING GALLERY LEVEL. THE SITE PROVIDER IS TO CONFIRM EXACTLY WHERE THE SUPPLY IS TO DERIVE FROM AND CONFIRM THE PROPOSED CABLE ROUTE.

### INTERNAL EQUIPMENT SCHEDULE

No.	TYPE	SIZE	OTHER INFORMATION
TBC	TBC	TBC	TBC
-	-	-	-

### ANTENNA KEY

ITEM	ANT. REF	FUNCTION	TYPE/SIZE	AZIMUTH	HEIGHT TO FLOOR	TYPE	LENGTH	No.
1	A1	TBC	BSR	0° EGN	112m AGL*	TBC	TBC	TBC
2	A2	TBC	BSR	120° EGN	112m AGL*	TBC	TBC	TBC
3	A3	TBC	BSR	180° EGN	112m AGL*	TBC	TBC	TBC
4	A4	TBC	BSR	240° EGN	112m AGL*	TBC	TBC	TBC
5	A5	TBC	BSR	300° EGN	112m AGL*	TBC	TBC	TBC
6	A6	TBC	BSR	360° EGN	112m AGL*	TBC	TBC	TBC

### FEEDER KEY

ITEM	DISH REF	FUNCTION	TYPE/SIZE	AZIMUTH	DISH HEIGHT	REMOTE RFU
7	D1	TBC	300mm Ø	TBC	TBC	TBC

### DISH KEY

ITEM	DISH REF	FUNCTION	TYPE/SIZE	AZIMUTH	DISH HEIGHT	REMOTE RFU
7	D1	TBC	300mm Ø	TBC	TBC	TBC

\* HEIGHT TO BE CONFIRMED

EXISTING SIGNAGE CONSISTING OF 80mm BOX SECTIONAL STEELWORK FIXED TO PLATFORM PROJECTING OUT 550mm FROM THE HANDRAIL

PROPOSED URBAN WIMAX ANTENNA A2 FIXED TO NEW STEEL-WORK

140 mm THICK EXISTING HANDRAIL

EXISTING PLANT ROOM AREA

PROPOSED URBAN WIMAX EQUIPMENT (EXACT SIZE TBC)

PROPOSED URBAN WIMAX ANTENNA A1 FIXED TO FLOOR TO CEILING HIGH, 60mm DIA STEEL POLE. PROPOSED URBAN WIMAX DISH D1 ALSO FIXED TO POLE.

PROPOSED URBAN WIMAX ANTENNA A6 FIXED TO NEW STEEL-WORK

EXIT FROM STAIRWELL ONTO VIEWING GALLERY PLATFORM

PROPOSED URBAN WIMAX ANTENNA A3 FIXED TO NEW STEEL-WORK

PROPOSED URBAN WIMAX ANTENNA A4 FIXED TO NEW STEEL-WORK

PROPOSED URBAN WIMAX ANTENNA A5 FIXED TO NEW STEEL-WORK

## 33rd FLOOR VIEWING GALLERY PLAN

SCALE 1:200

NOTE: ORIGINAL DRAWING SIZE A3

### NOTES

### NOTES

A	21.06.08	FIRST ISSUE	MM	SM
Rev	Date	Amendments	Drawn By	Approved By

Consultant  
Trucomm Ltd  
Units 1 / 2  
Inchcross Business Pk  
Bathgate  
EH48 2HR  
PH. 01506 676688  
FAX. 01506 676699

Client  
URBAN WIMAX  
12 Burrell Street  
Covent Garden  
London  
WC2E 7PX

Job Title  
CENTRE POINT  
Centre Point Tower  
101 New Oxford Street  
London  
WC1A 1DR

Drawing Title  
VIEWING GALLERY PLAN

Scale	As Shown	DO NOT SCALE THIS DRAWING	Approved by
Drawn by	MM	Checked by	SM
Date Drawn	21.06.08	Date Checked	21.06.08
Ref	WM-03	Site Code	03
Drawing No.	02	Rev.	PIP(A)

NOTES

A	21.09.06	FIRST ISSUE	MM	SM
---	----------	-------------	----	----

Rev	Date	Amendments	Drawn By	Approved By
-----	------	------------	----------	-------------

Consultant

Trucomm Ltd  
Units 1 / 2  
Inchcross Business Pk  
Bathgate  
EH48 2HR  
PH. 01506 676688  
FAX. 01506 676699

Client	12 Burleigh Street Covent Garden London WC2E 7PX
--------	---

Job Title Centre Point Tower  
101 New Oxford Street  
London  
WC1A 1DR

Drawing Title

EAST ELEVATION

Scale As Shown		DO NOT SCALE THIS DRAWING	
Drawn by MM	Checked by SM	Approved by SM	
Date Drawn 21.06.06	Date Checked 21.06.06	Date Approved 21.06.06	
Ref WM-03	Site Code 03	Drawing No. 03	Rev. PIP(A)

EXISTING STEELWORK ROOFTOP  
STRUCTURE

PROPOSED URBAN WIMAX ANTENNA  
A4 FIXED TO NEW STEEL-WORK

PROPOSED URBAN WIMAX ANTENNA  
A5 FIXED TO NEW STEEL-WORK

PROPOSED URBAN WIMAX ANTENNA  
A6 FIXED TO NEW STEEL-WORK

Roof Level  
1 | 2.708 m AGL

33rd floor  
09.660 m AGL



# CENTREPOINT

CBI CONFERENCE FACILITIES  
BRIDGE BUILDING

Ground Level

EAST ELEVATION  
SCALE 1:200



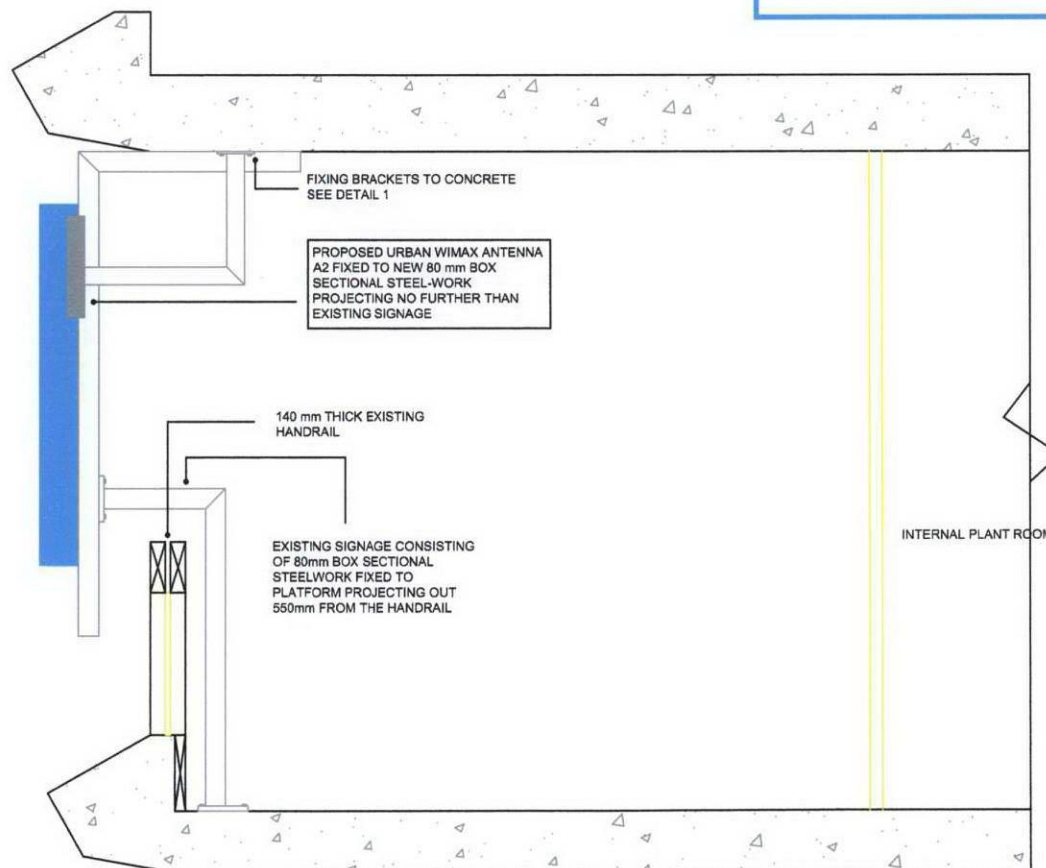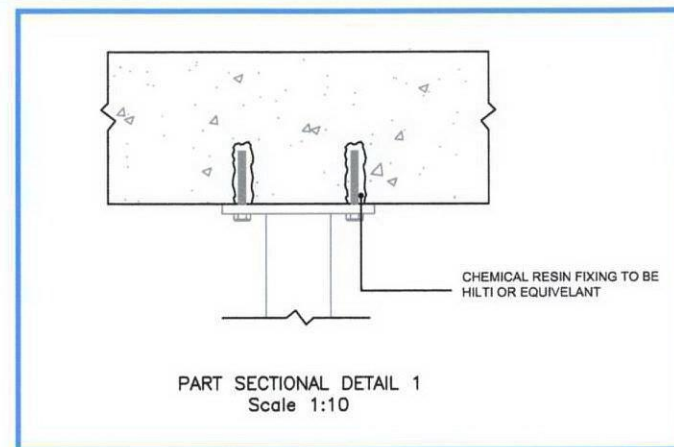

ANTENNA & STEEL FIXING  
Scale 1:20

NOTE: ORIGINAL DRAWING SIZE A3

# NOTES

## NOTES

Rev	Date	Amendments	Drawn By	Approved By
A	21.06.06	FIRST ISSUE	MM	SM

Consultant	Truconn Ltd Units 1 / 2 Inchcross Business Pk Bathgate EH48 2HR PH. 01506 676688 FAX. 01506 676699
------------	--

Client	12 Burrell Street Covent Garden London WC2E 7PX
--------	--

Job Title	Centre Point Tower 101 New Oxford Street London WC1A 1DR
-----------	---

Drawing Title	ANTENNA FIXING DETAILS
---------------	------------------------

Scale	As Shown	DO NOT SCALE THIS DRAWING	Approved by
Drawn by	MM	Checked by	SM
Date Drawn	21.06.06	Date Checked	21.06.06
Ref	WM-03	Site Code	03
		Drawing No.	04
		Rev.	PIP(A)