


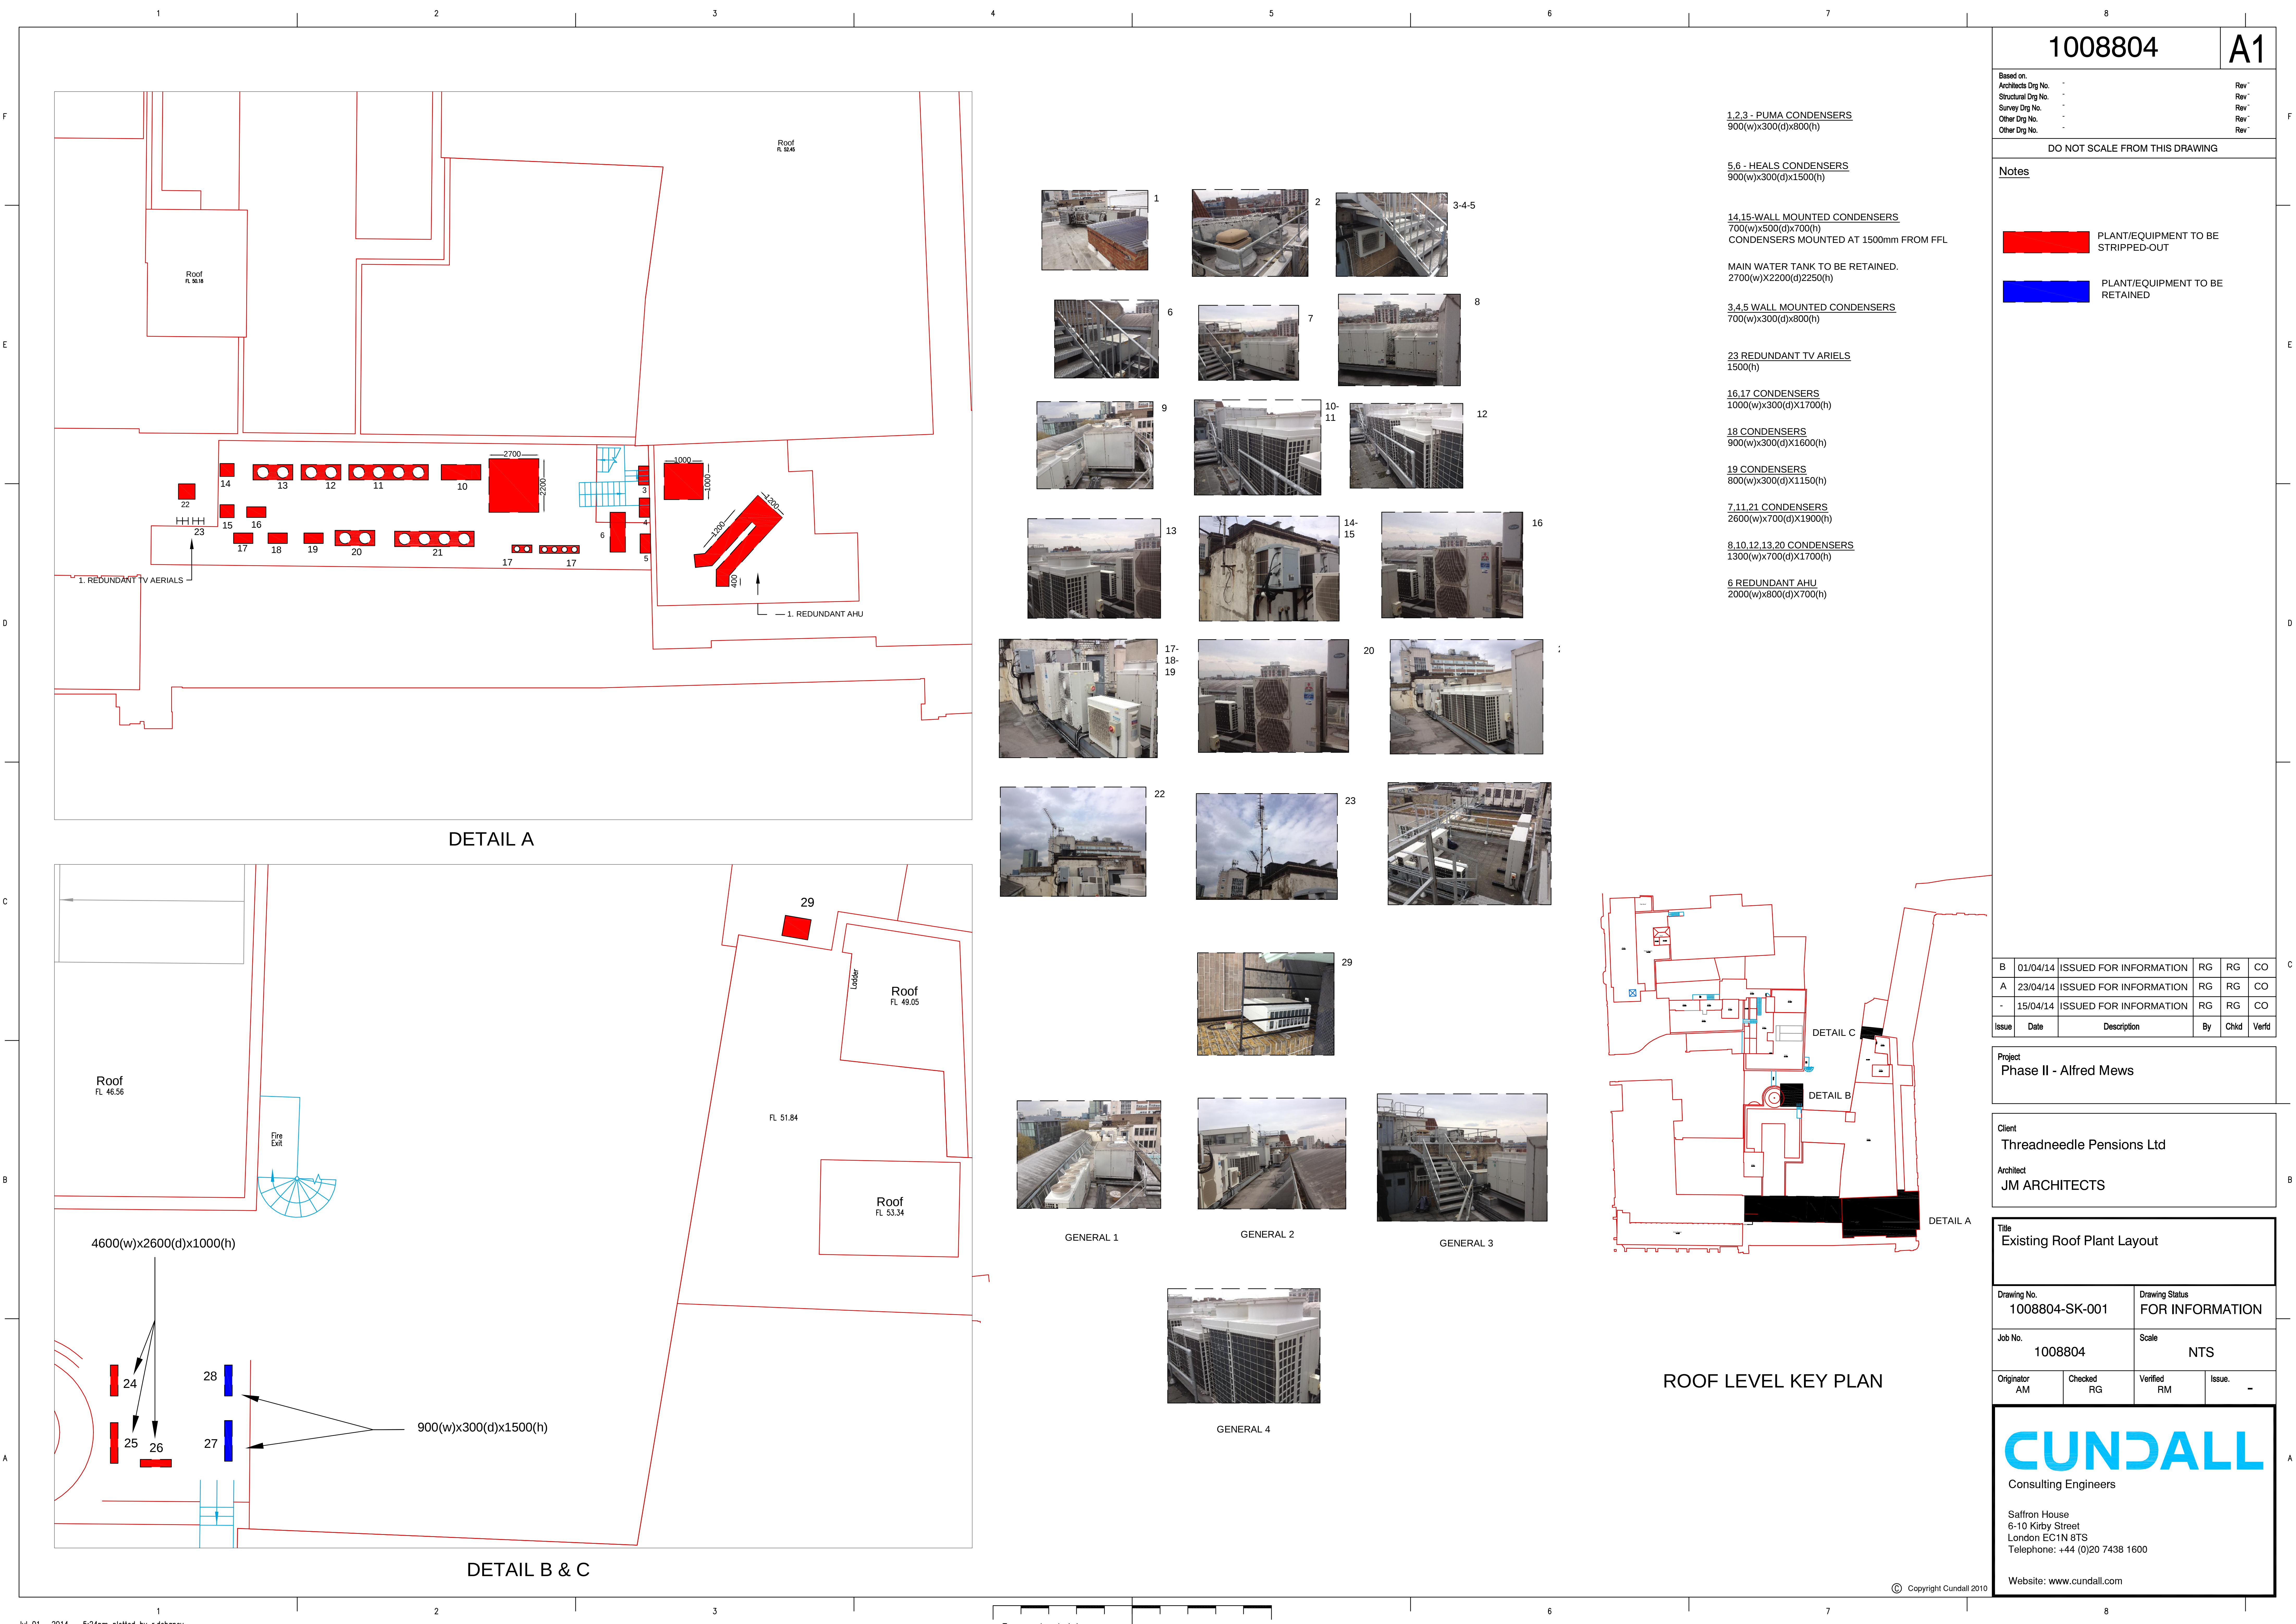

1008804

A1

Based on:	-	Rev'
Architects Dwg No.	-	Rev'
Structural Dwg No.	-	Rev'
Survey Dwg No.	-	Rev'
Other Dwg No.	-	Rev'
Other Dwg No.	-	Rev'

DO NOT SCALE FROM THIS DRAWING

Notes	
	PLANT/EQUIPMENT TO BE STRIPPED-OUT
	PLANT/EQUIPMENT TO BE RETAINED

1,2,3 - PUMA CONDENSERS
900(w)x300(d)x800(h)

5,6 - HEALS CONDENSERS
900(w)x300(d)x1500(h)

14,15-WALL MOUNTED CONDENSERS
700(w)x500(d)x700(h)
CONDENSERS MOUNTED AT 1500mm FROM FFL

MAIN WATER TANK TO BE RETAINED.
2700(w)x2200(d)x2250(h)

3,4,5 WALL MOUNTED CONDENSERS
700(w)x300(d)x800(h)

23 REDUNDANT TV ARIELS
1500(h)

16,17 CONDENSERS
1000(w)x300(d)x1700(h)

18 CONDENSERS
900(w)x300(d)x1600(h)

19 CONDENSERS
800(w)x300(d)x1150(h)

7,11,21 CONDENSERS
2600(w)x700(d)x1900(h)

8,10,12,13,20 CONDENSERS
1300(w)x700(d)x1700(h)

6 REDUNDANT AHU
2000(w)x800(d)x700(h)

B	01/04/14	ISSUED FOR INFORMATION	RG	RG	CO
A	23/04/14	ISSUED FOR INFORMATION	RG	RG	CO
-	15/04/14	ISSUED FOR INFORMATION	RG	RG	CO
Issue	Date	Description	By	Chkd	Verfd

Project	Phase II - Alfred Mews
---------	------------------------

Client	Threadneedle Pensions Ltd
Architect	JM ARCHITECTS

Title	Existing Roof Plant Layout
-------	----------------------------

Drawing No.	1008804-SK-001	Drawing Status	FOR INFORMATION
Job No.	1008804	Scale	NTS
Originator	AM	Checked	RG
Verified	RM	Issue.	-

CUNDALL
Consulting Engineers

Saffron House
6-10 Kirby Street
London EC1N 8TS
Telephone: +44 (0)20 7438 1600
Website: www.cundall.com