


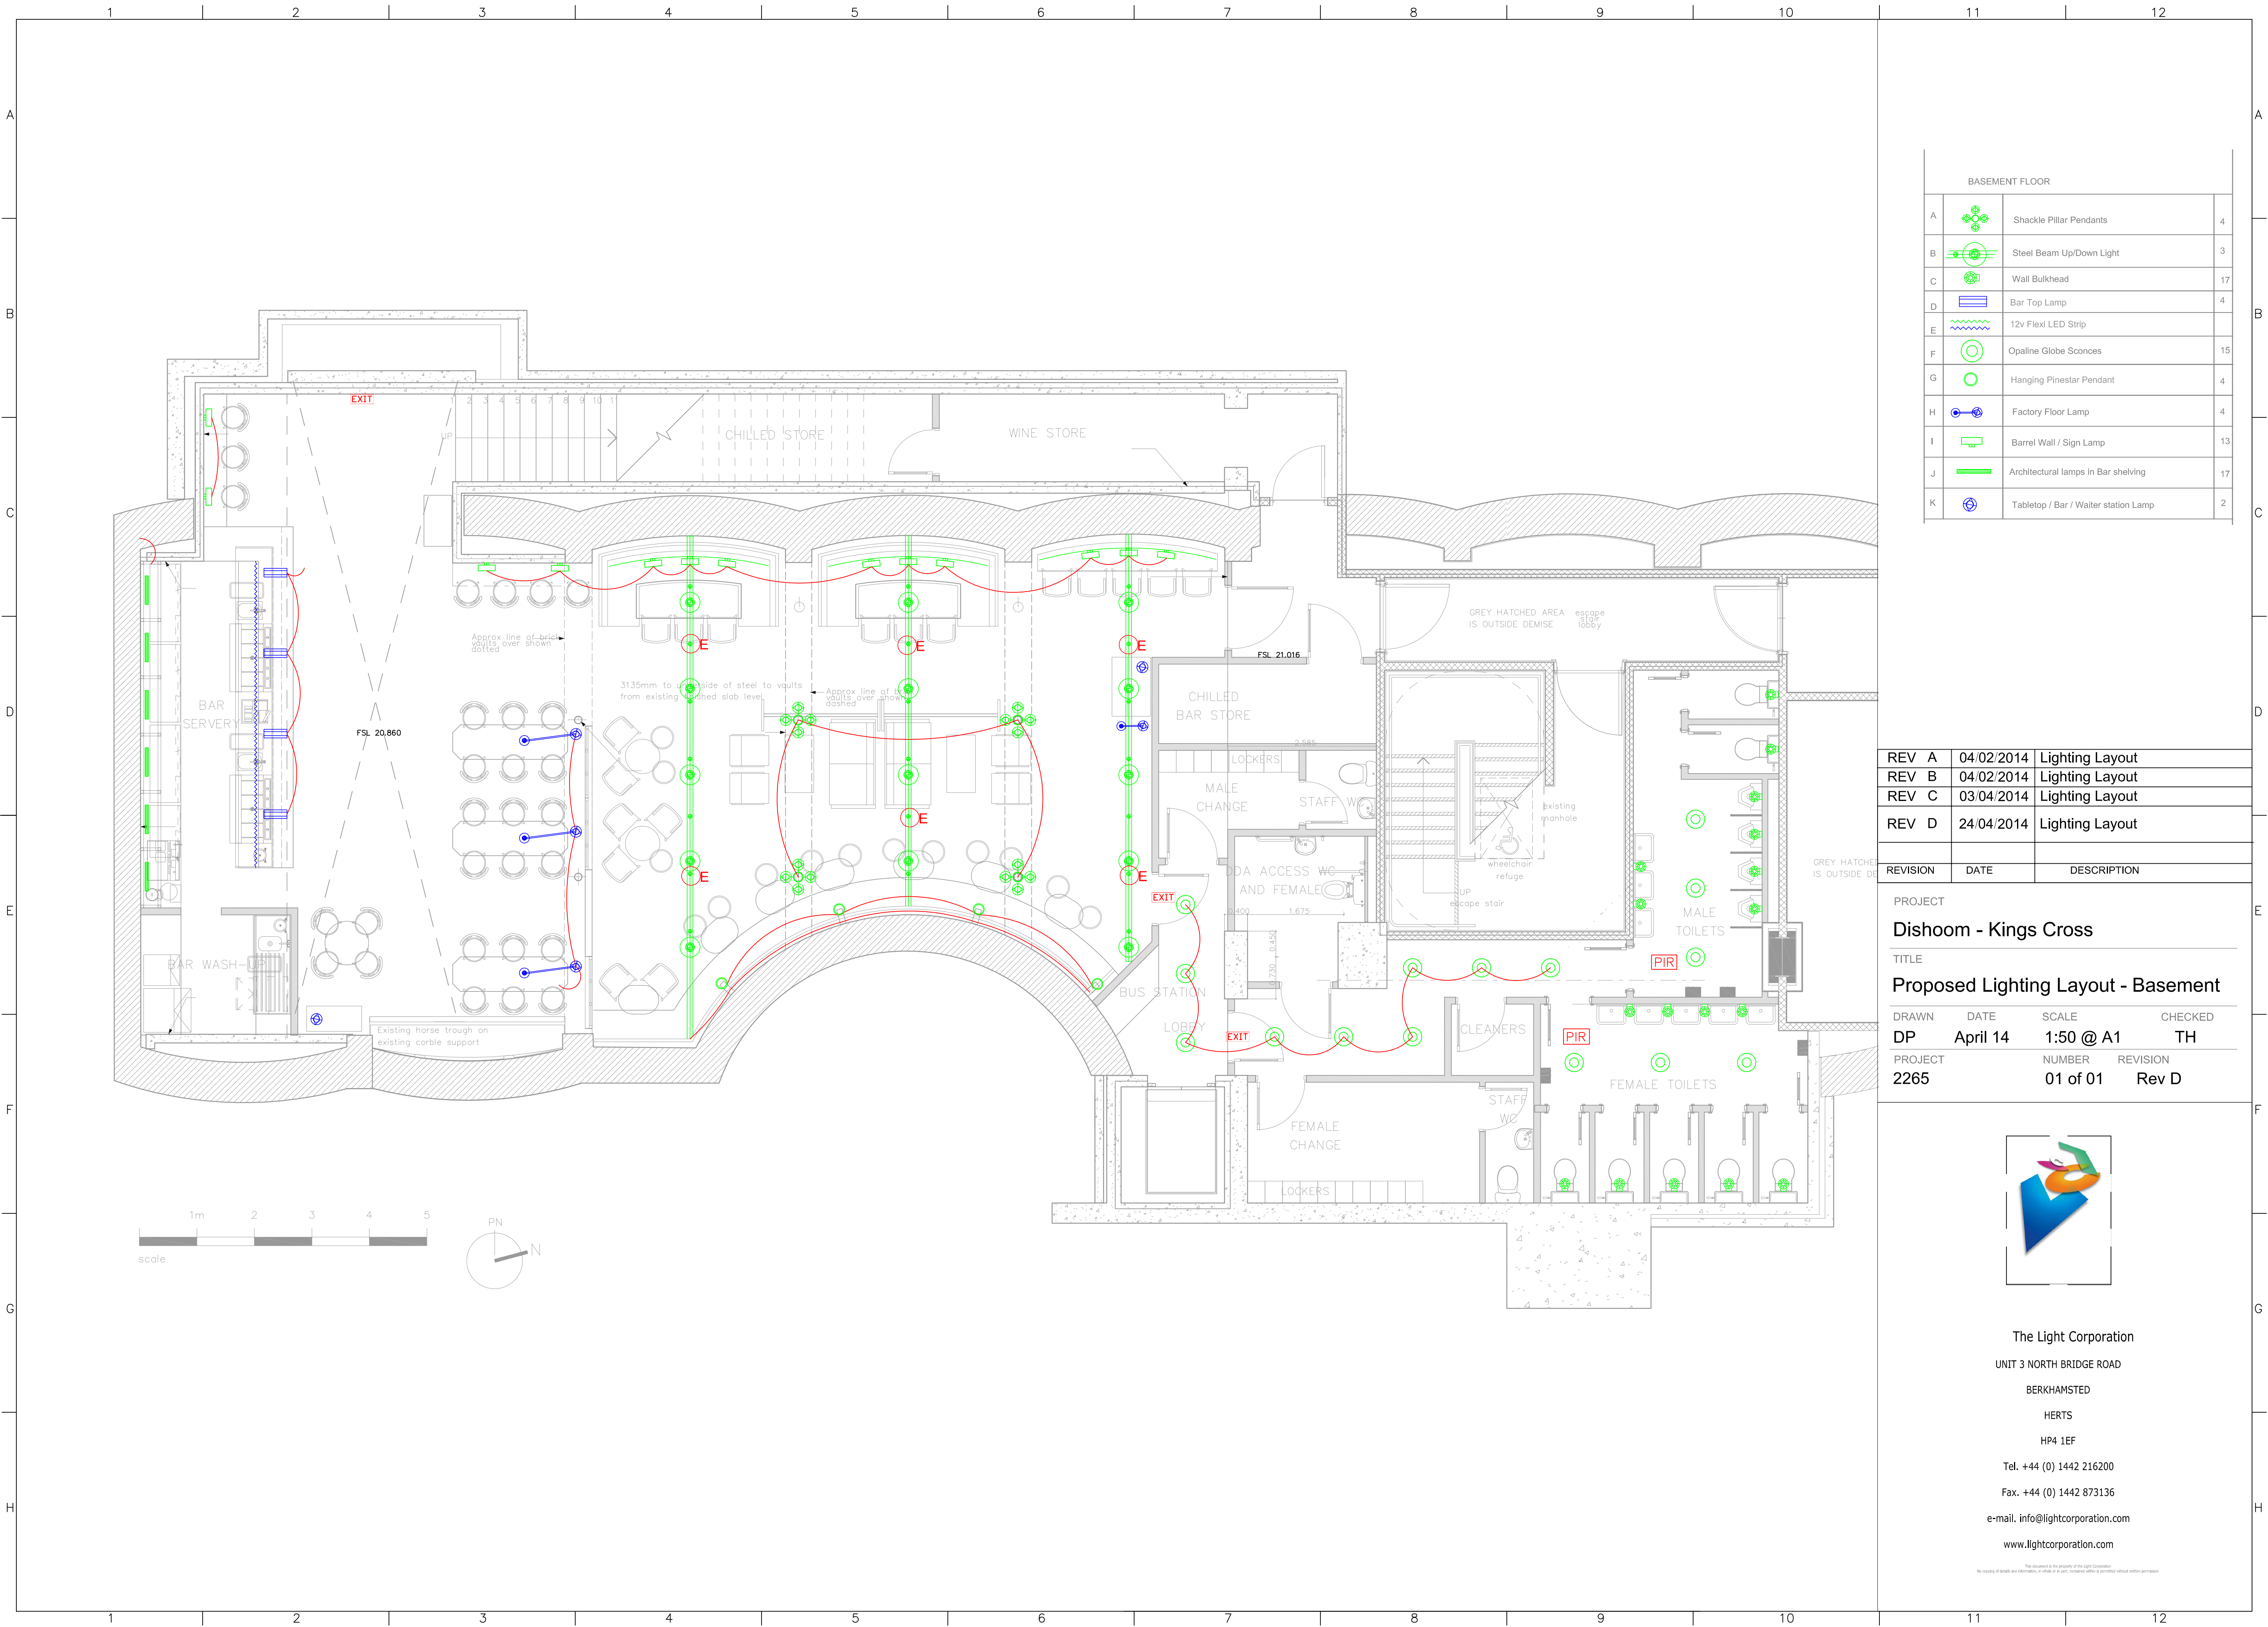

BASEMENT FLOOR			
A		Shackle Pillar Pendants	4
B		Steel Beam Up/Down Light	3
C		Wall Bulkhead	17
D		Bar Top Lamp	4
E		12v Flexi LED Strip	
F		Opaline Globe Sconces	15
G		Hanging Pinestar Pendant	4
H		Factory Floor Lamp	4
I		Barrel Wall / Sign Lamp	13
J		Architectural lamps in Bar shelving	17
K		Tabletop / Bar / Waiter station Lamp	2

REV A	04/02/2014	Lighting Layout
REV B	04/02/2014	Lighting Layout
REV C	03/04/2014	Lighting Layout
REV D	24/04/2014	Lighting Layout

REVISION	DATE	DESCRIPTION
----------	------	-------------

PROJECT			
Dishoom - Kings Cross			
TITLE			
Proposed Lighting Layout - Basement			
DRAWN	DATE	SCALE	CHECKED
DP	April 14	1:50 @ A1	TH
PROJECT	NUMBER	REVISION	
2265	01 of 01	Rev D	



The Light Corporation
UNIT 3 NORTH BRIDGE ROAD
BERKHAMSTED
HERTS
HP4 1EF
Tel. +44 (0) 1442 216200
Fax. +44 (0) 1442 873136
e-mail. info@lightcorporation.com
www.lightcorporation.com

This document is the property of The Light Corporation. No copying of details and information is made or in any manner shall be permitted without written permission.