


Photograph of corner at second floor level where riser will be chased.



Plan of proposed Electrical Riser at Second Floor Level

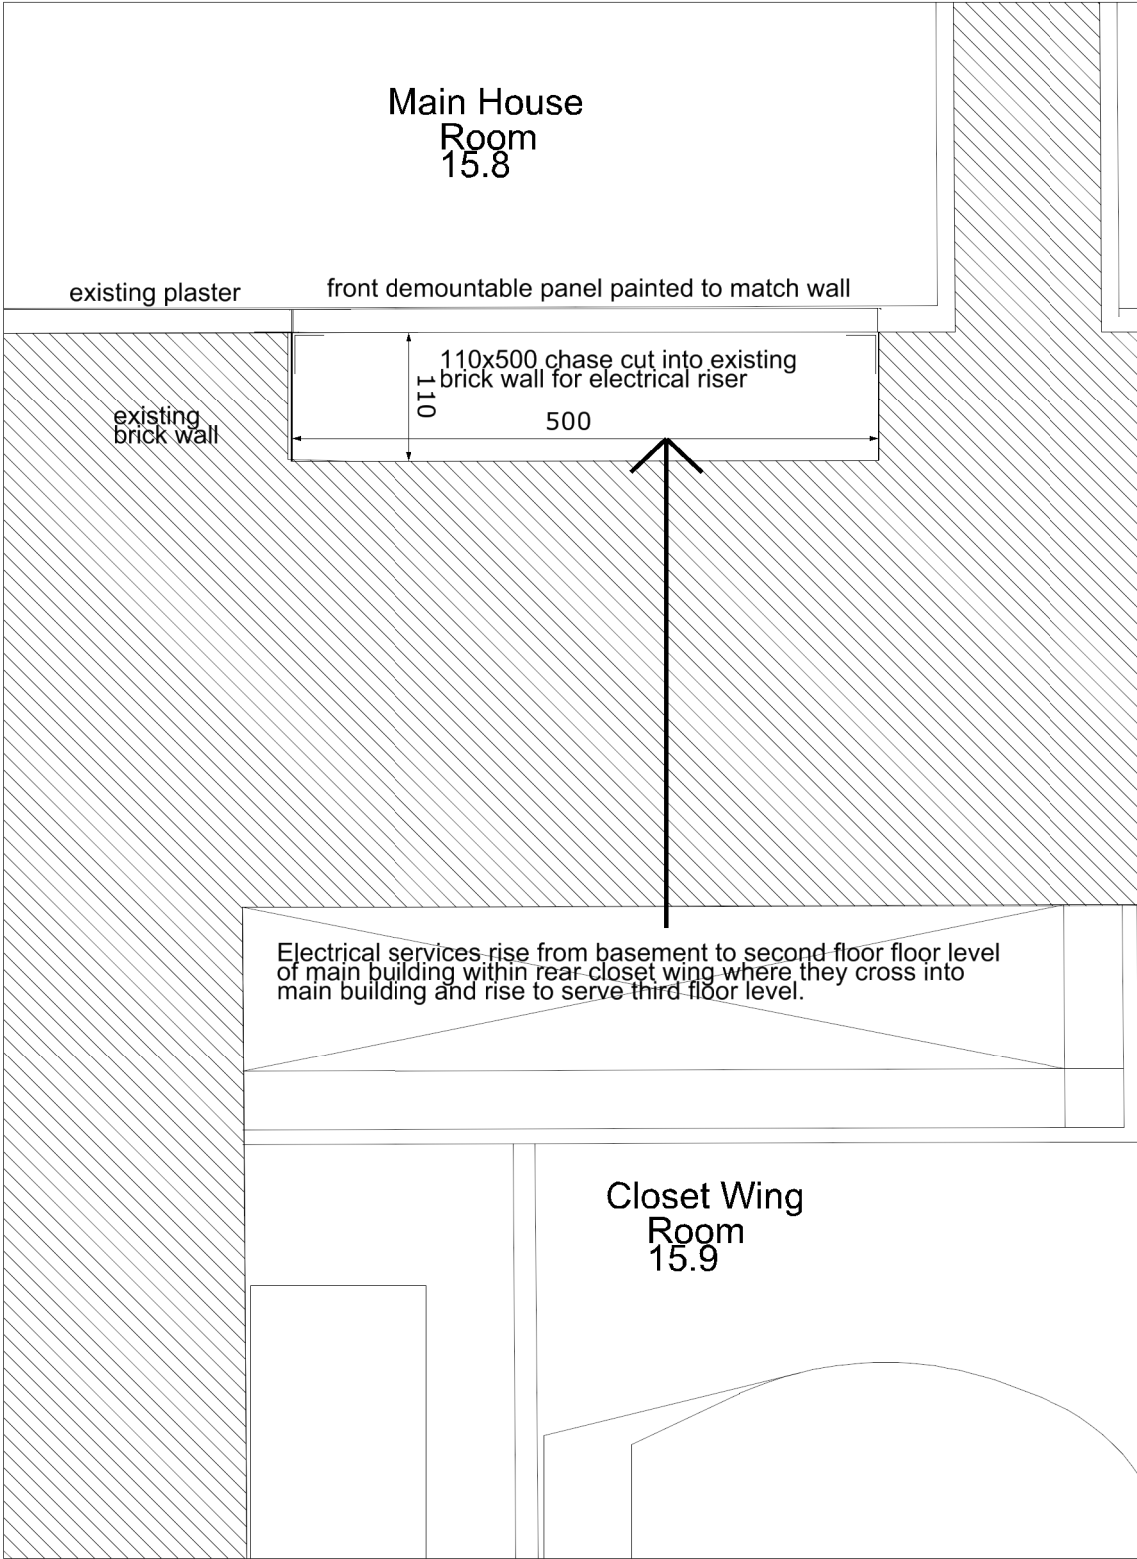

THIS DRAWING AND CAD DATA THEREIN IS PROTECTED BY
COPYRIGHT
AND MUST NOT BE COPIED OR REPRODUCED
WITHOUT THE WRITTEN CONSENT OF
DLG ARCHITECTS
©
NO DIMENSIONS ARE TO BE SCALED FROM THIS DRAWING.
USE FIGURED DIMENSIONS ONLY.
ALL DIMENSIONS AND SIZES ARE TO BE CHECKED ON SITE
AND ANY DISCREPANCIES REPORTED TO THE ARCHITECT
PRIOR TO INITIATION OF ANY WORKS.

2. Revised at Conservation Officer request
1. Issue for construction
REV. DESCRIPTION
Job Name
The Bedford Estates
14 - 15 Bedford Square

HR 02.06.14
AH 16.05.14
INITIALS/ DATE

Drawing Title
Electrical Riser To Rear of No. 15
at Second floor level

Status
Production

Date: 29/04/14
Sheet By: HR
Scale @ Size: NTS

Job Number: 3907
Code: P
Drawing Number: (99) 501
Rev: 02

DLG Architects LLP
128 Southwark Street
London SE1 0SW

t +44(0)20 7620 1236
f +44(0)20 7928 4416
london@dlgarchitects.com

dlgarchitects.com