


PROPOSED PLAN ON NEW STEEL FOR LED SCREEN
(SCALE 1:10 AT A1)

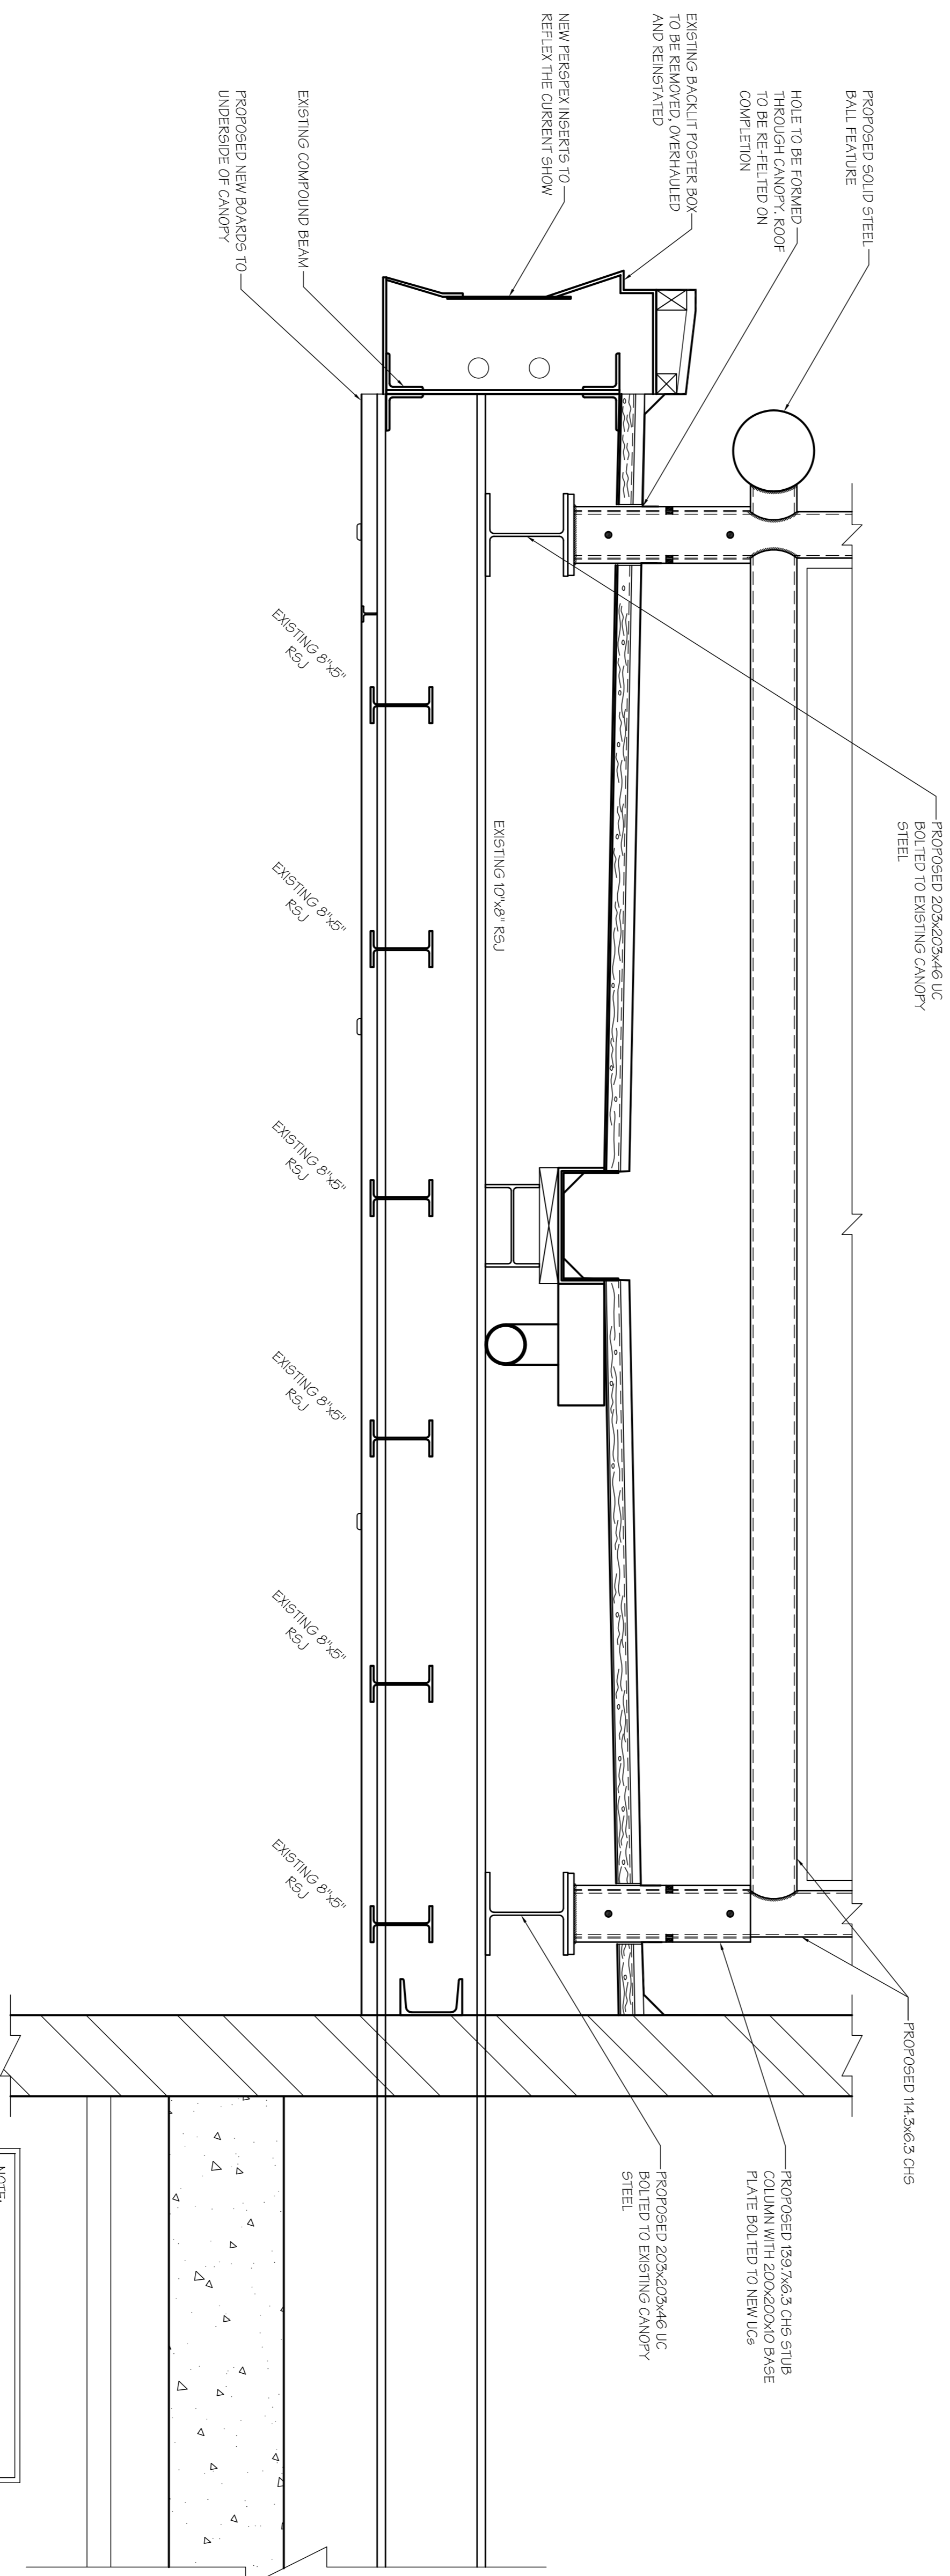

PROPOSED SECTION A-A THROUGH CANOPY
(SCALE 1:10 AT A1)

NOTE:
ALL WORKS ARE TO BE UNDERTAKEN FROM THE TOP OF THE CANOPY

NOTE:
THE CONTRACTOR IS TO ENSURE THE WORKS DO NOT IMPAIR THE NORMAL OPERATION OF THE VENUE

NOTE:
THE CONTRACTOR IS TO ALLOW FOR ALL STABILITY

FOR DISCUSSION
PURPOSES ONLY

Rev	Date	Description	By
Revisions			

Michael Jackson Consulting
Chartered Structural Engineers

204 BOSTON ROAD
MANCHESTER, M20 9BN
Tel: 0161 280 4404
Fax: 0161 280 4405

Client: **NEDERLANDER**

Site: **THE DOMINION THEATRE, LONDON**

Project: **EXTERNAL FRONT ELEVATION WORKS**

Drawing Title: **PROPOSED SIGANGE AND FIXING DETAILS**

Scale: AS SHOWN	Date: APR 14	Drawn: DS	Checked: P
DRG. No.:	2243-03-004		