



01 Roof Plan Layout
Scale 1:500 @ A3

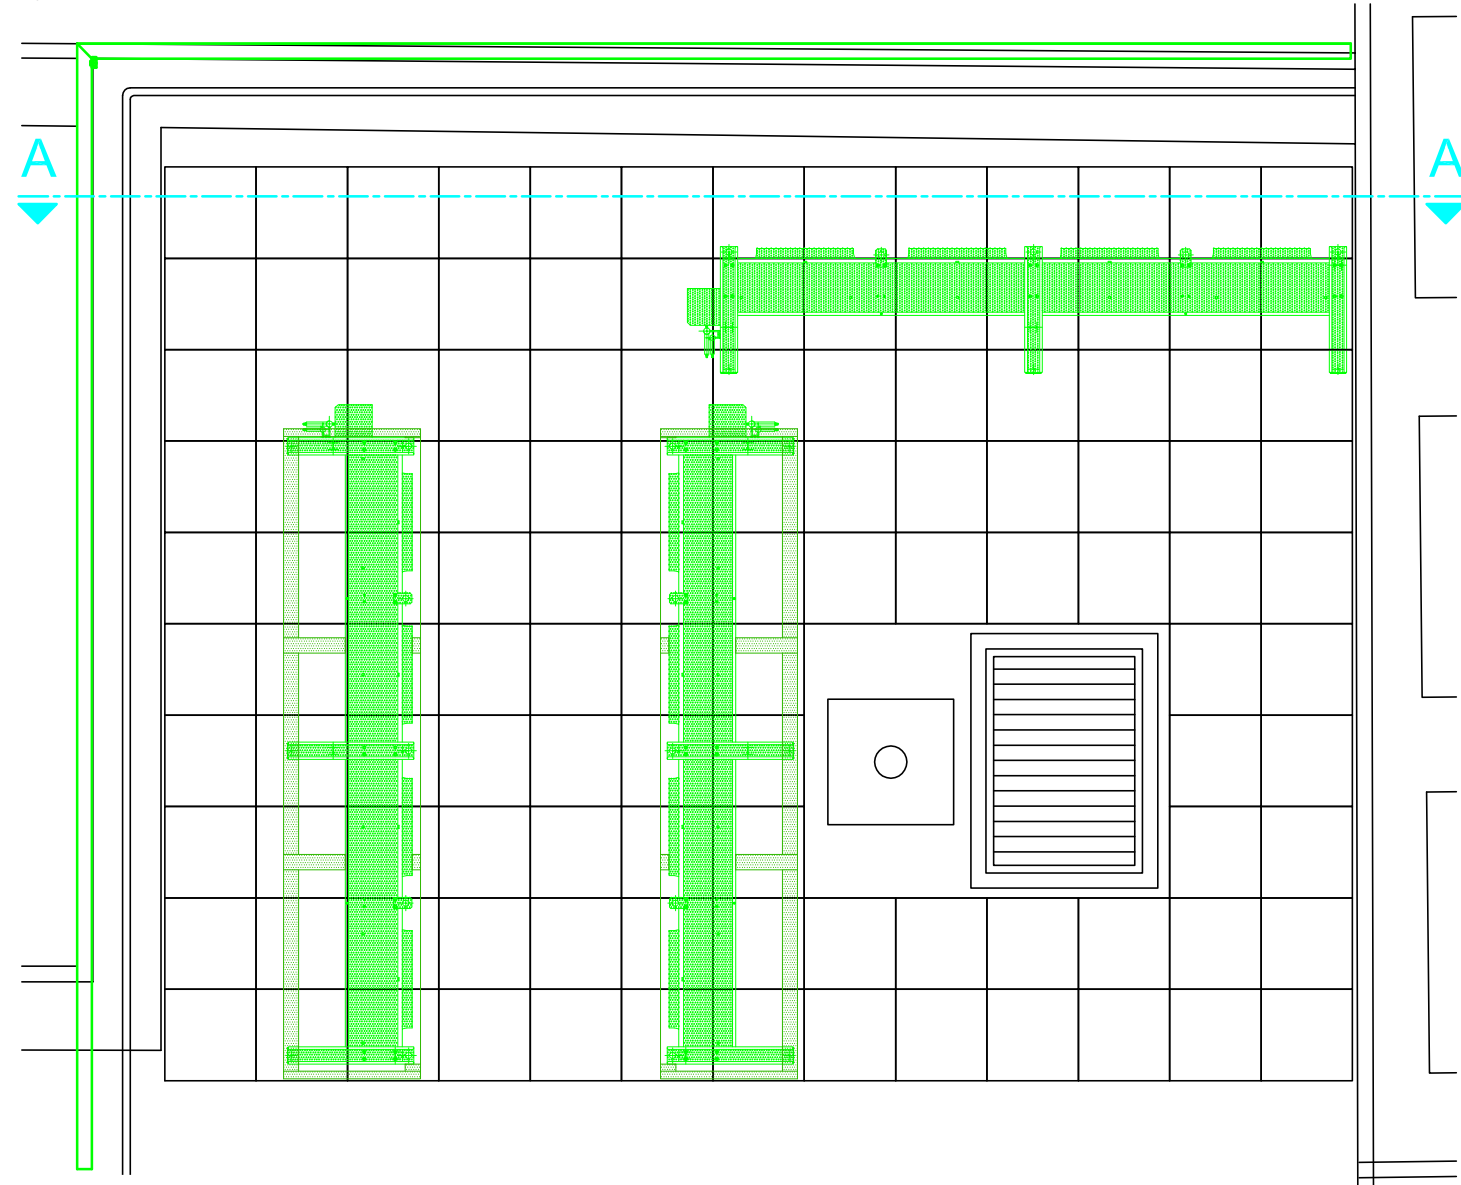

02 Condenser Plan Layout
Scale 1:50 @ A3

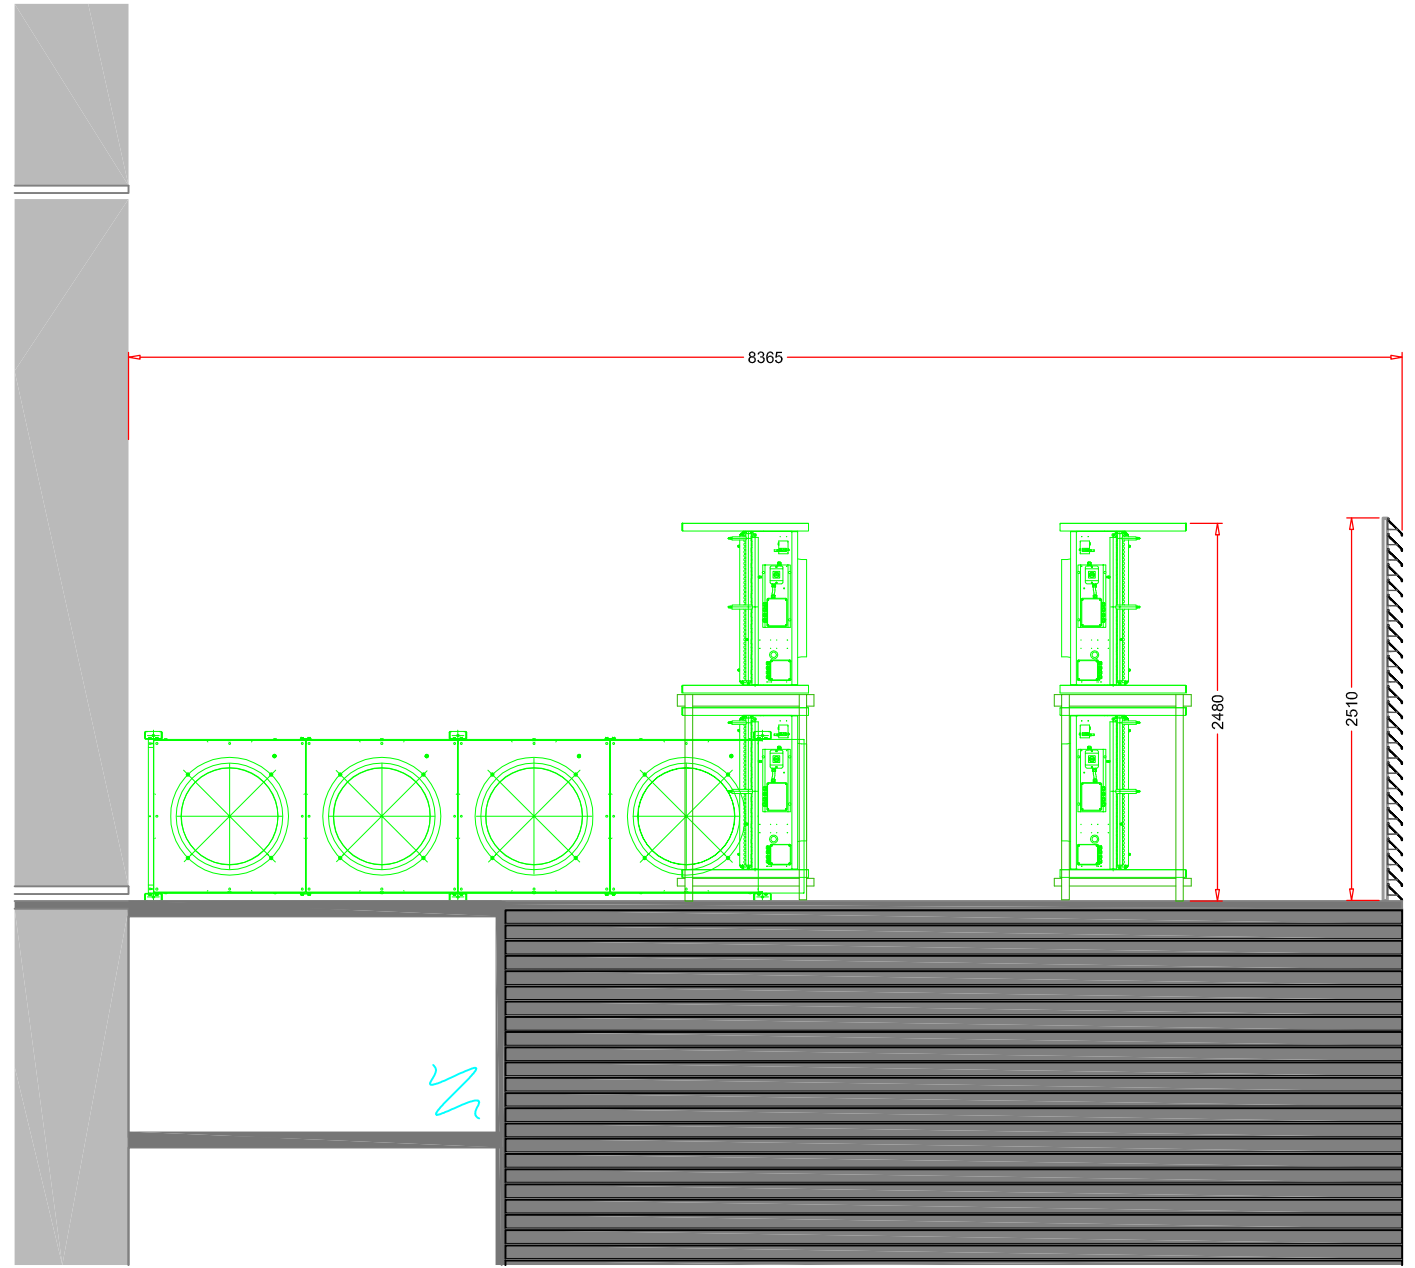


03 Elevation on A-A
Scale 1:50 @ A3

Notes

Rev	Date	Description
A	18.09.14	First Issue

© Copyright
This drawing is the property of FUTURE-TECH and should not be used, copied or reproduced by a third party unless written consent be first obtained.

Client Emerson (Globecast)		 Future-Tech <small>DATA CENTRE DESIGN & CONSTRUCTION</small>
Project New Data Centre		
Drawing Title Mechanical Systems External Condenser Layout	Scale as shown	Eastheath House Eastheath Avenue Wokingham RG41 2PR tel: 0845 9000 127 fax: 0118 9795 480 e-mail: info@future-tech.co.uk
Drawn <i>N Cooper</i>	Drawing No 8271 -211	