




Building Relationships

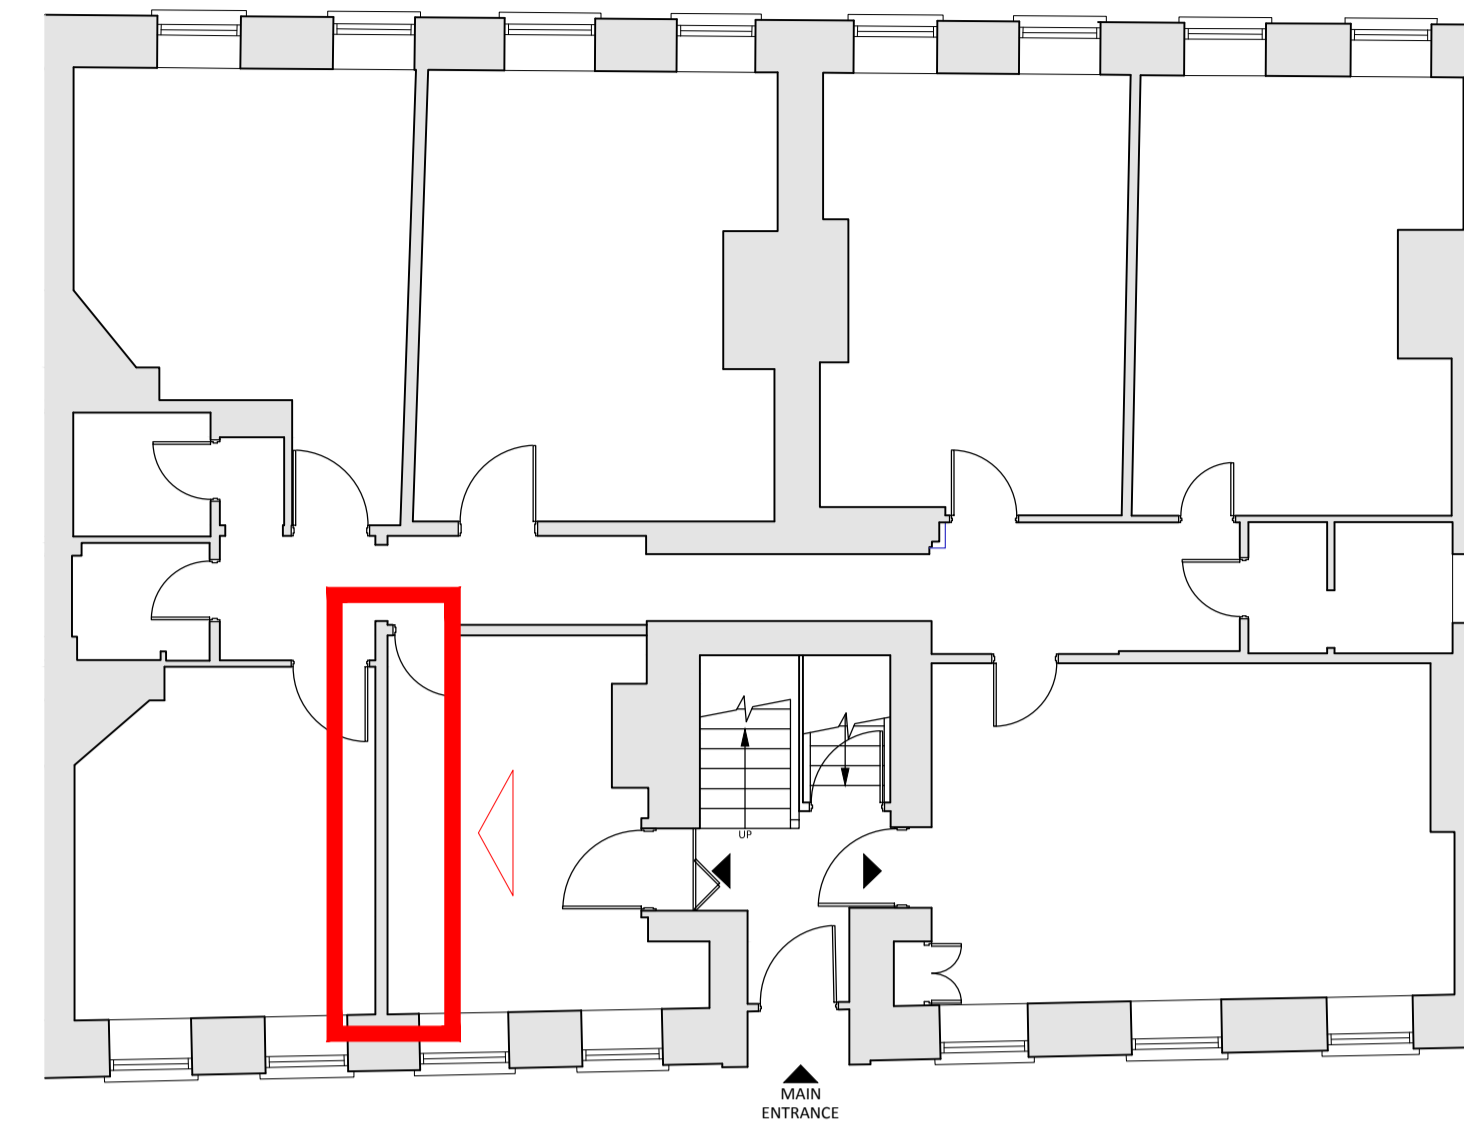

Key Plan

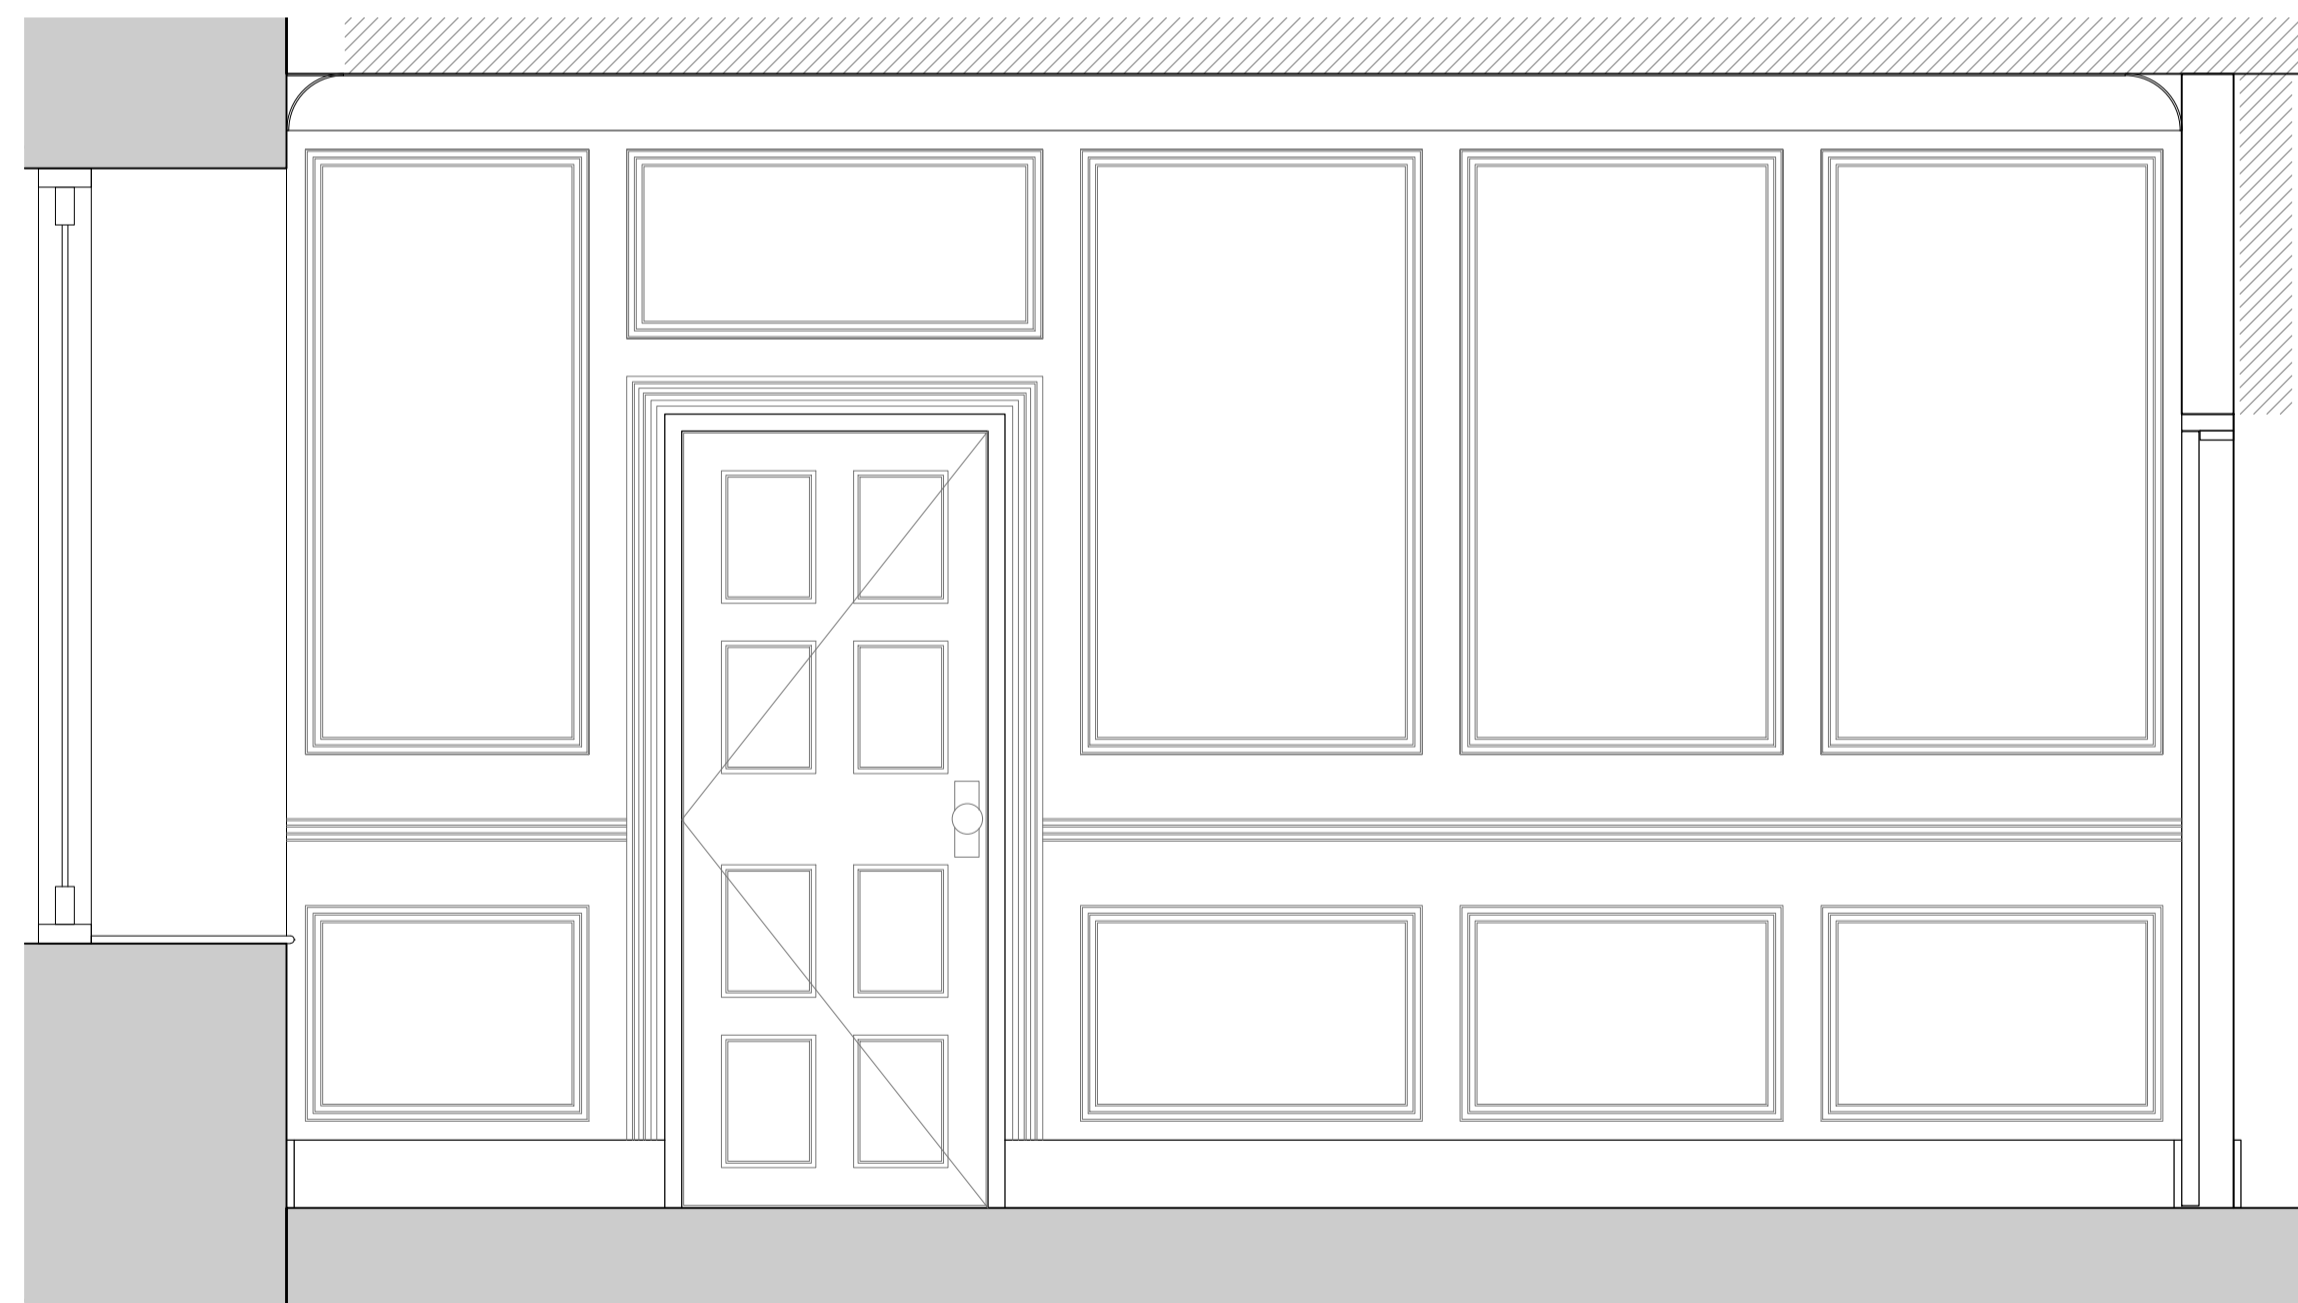

Existing Elevation

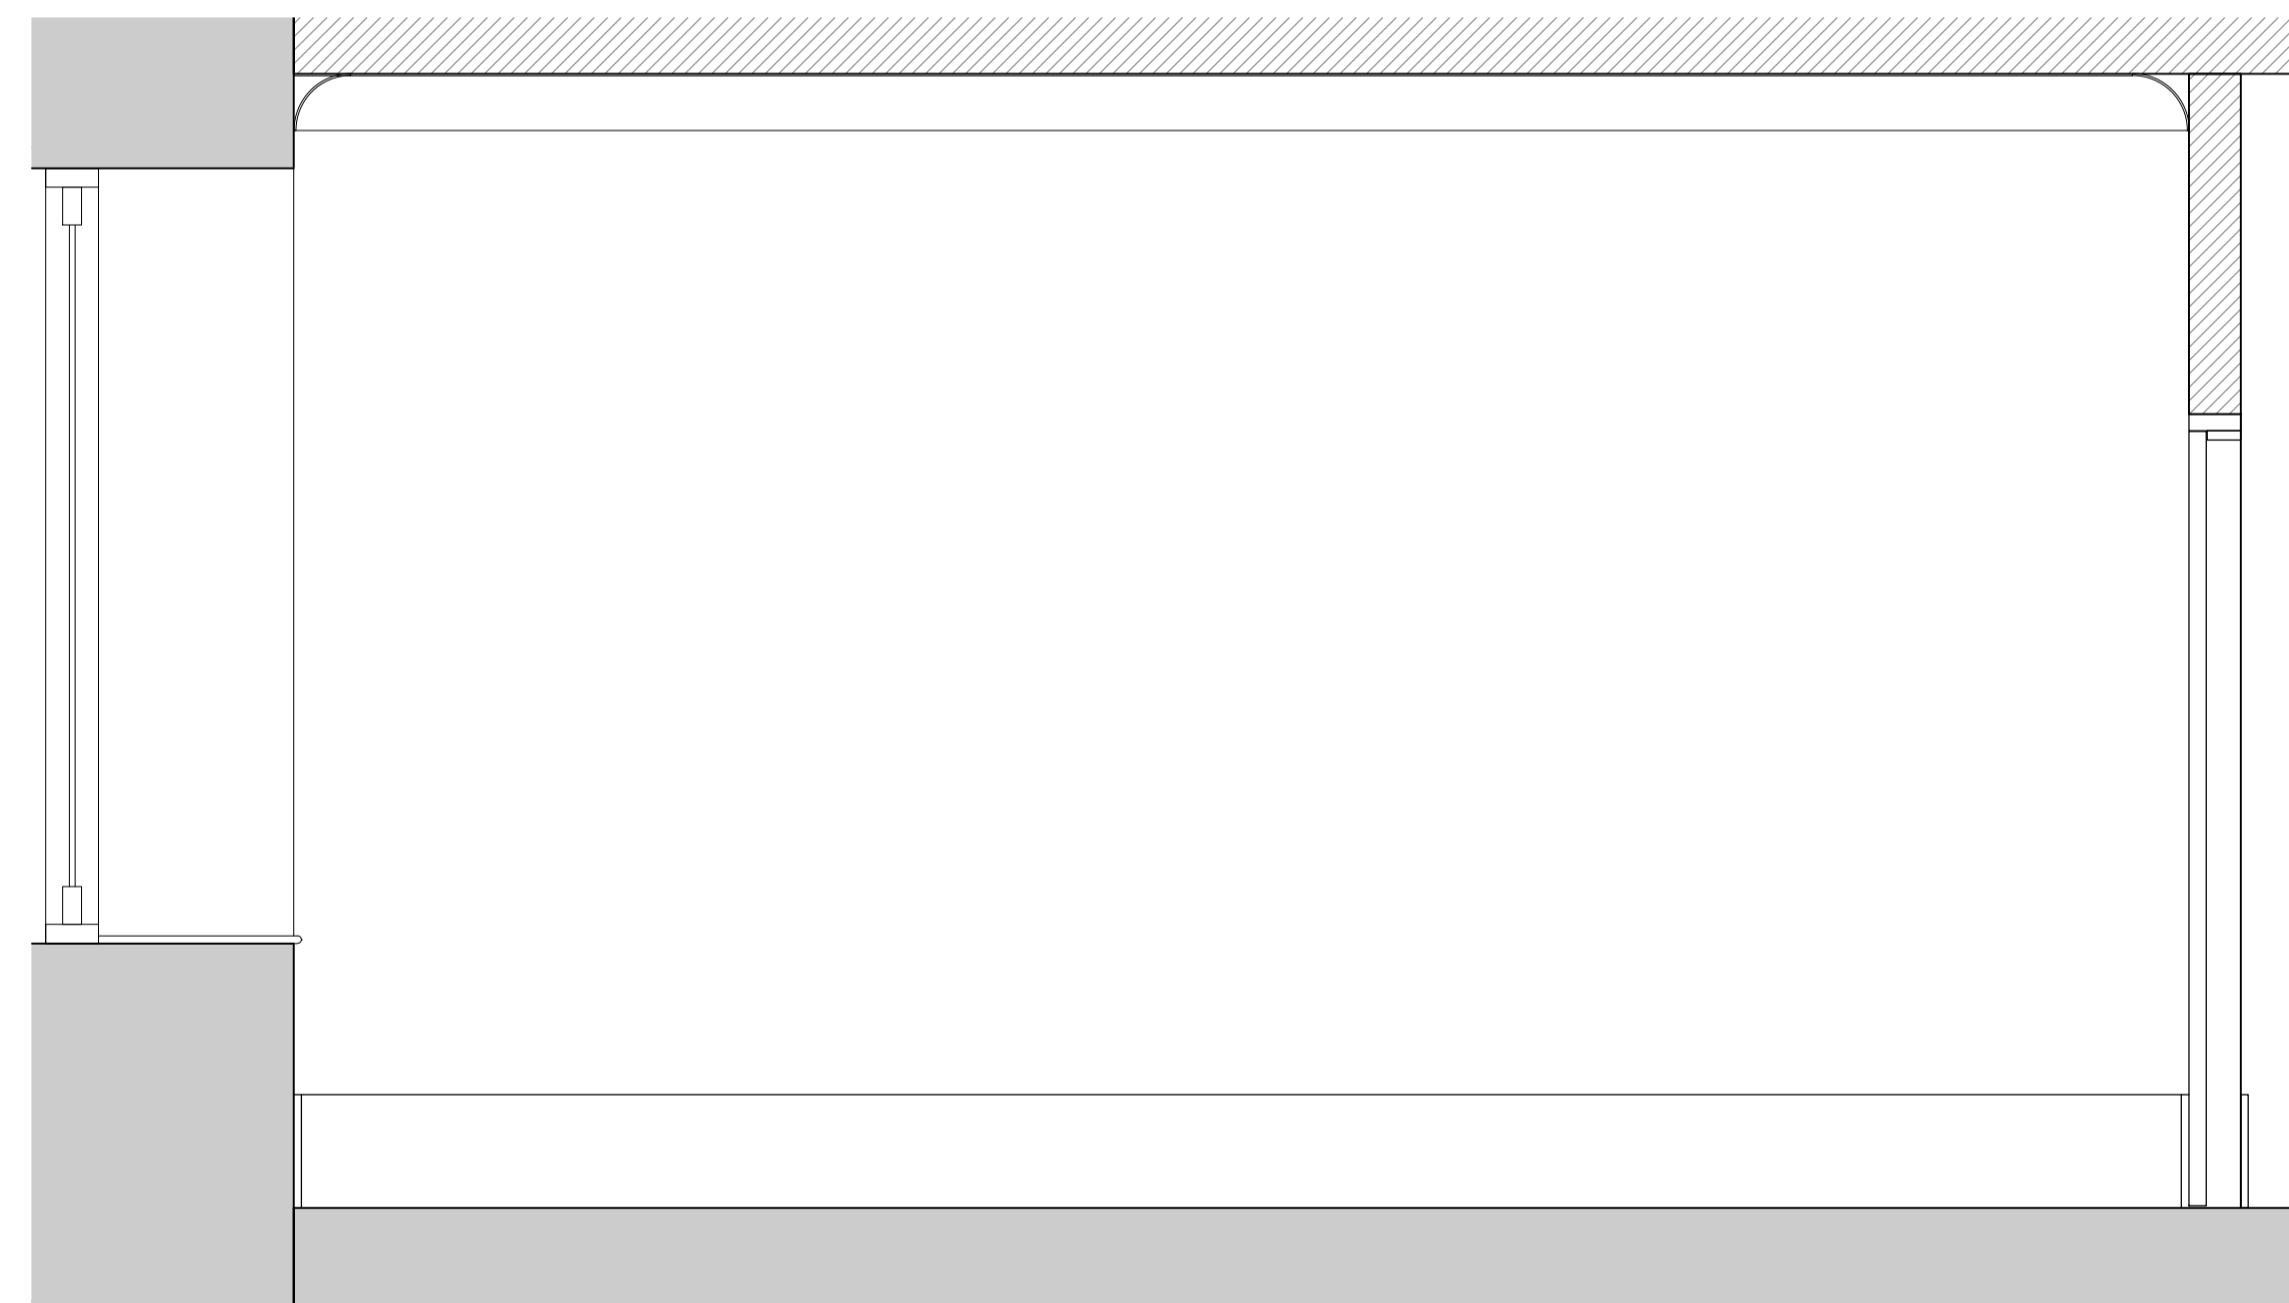


Proposed Elevation

PROPOSED ACOUSTIC WALL INSTALLATION

This drawing and the information contained herein is copyright and cannot be reproduced in part nor whole without the prior written permission of SARACEN INTERIORS LIMITED.

Rev	Date	Amendments	Drawn By
/	22.09.14	Initial Issue	KMc

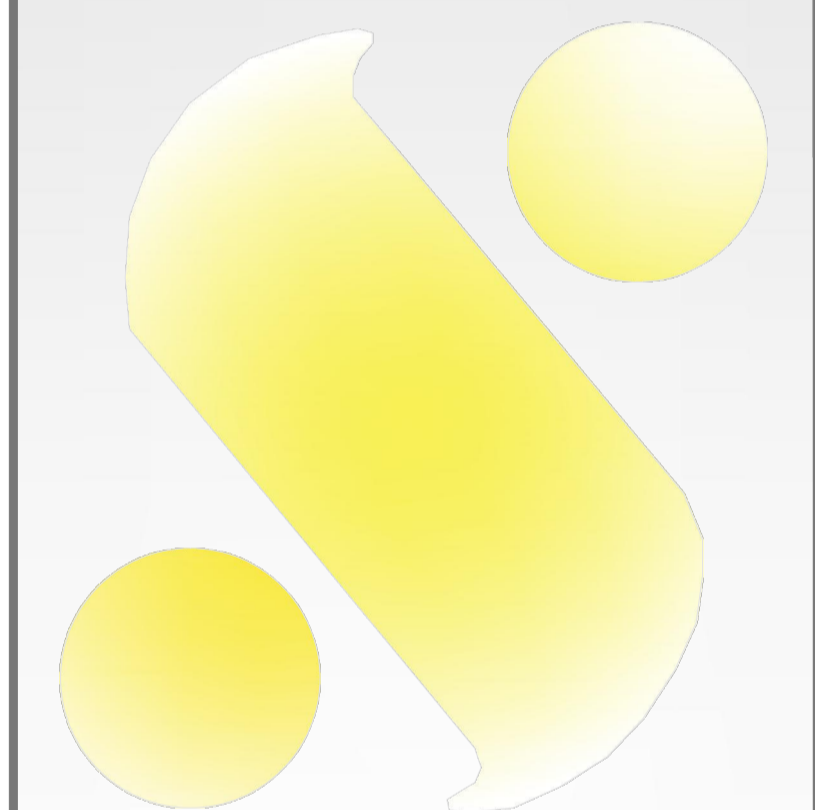

Saracen
interiors

Unit H, Manaway Business Park,
Holder Road, Aldershot,
GU12 4RH
Tel: 0870 743 0920
Fax: 0870 743 0922
www.saraceninteriors.com

Client: Gray's Inn Chambers	Project: Refurbishment
Drawing: Proposed Power & Data Layouts	Number: Sara-Pr-1002
Scale: 1:20 @ A1	Date: 22.09.2014