

THE CONTRACTOR MUST VERIFY ALL DIMENSIONS ON SITE BEFORE MAKING SHOP DRAWINGS OR COMMENCING WORK OF ANY KIND.
NO DIMENSIONS TO BE SCALED FROM THIS DRAWING.

REV. DATE REVISION

PL06 21.09.12 For Client Review
PL07 08.10.12 For Client Review
PL08 12.10.12 Draft Planning Issue
PL09 26.10.12 Planning Issue
PL10 04.07.13 Issued for Client Approval



Legends & Notes:

External Lighting & Electrical Legend	
	Lighting
	Lighting
	CCTV camera
	Fenestration or door reference

EXTERNAL FINISHES LEGEND	
	IBSTOCK PARHAM RED 0708 BRICKWORK IN FLEMISH BOND WITH STRUCK POINTING
	IBSTOCK HAMSEY MIXED 4517 FACE BRICKWORK IN FLEMISH BOND WITH STRUCK POINTING
	HADDOCKSTONE PORTLAND 01 PRE-CAST STONE CLADDING ON CONCEALED METAL FIXINGS
	NATURAL SLATE ROOF TILES ON TIMBER BATTENS
	CLAY CHIMNEY POTS ON A MORTAR BEDDING TO CHIMNEY CORING
	DOUBLE GLAZED TRADITIONAL PAINTED TIMBER DOOR SUITE WITH RECESSED FRAME
	DOUBLE GLAZED TRADITIONAL PAINTED TIMBER BOX SASH WINDOW WITH LEAD WEIGHTS & PULLEYS IN RECESSED FRAME
	CLEAR LAMINATED LOW E GLASS TO MINIMUM BS 5544
	PACIFIED LAMINATED LOW E GLASS TO MINIMUM BS 5544
	PAINTED CAST ALUMINIUM RAIN WATER DOWN PIPES
	PAINTED HARDWOOD TIMBER SURROUND TO DORMER WINDOW
	LEAD CLADDING TO TIMBER STUD FRAME DORMER WINDOW
	PAINTED HARDWOOD TIMBER DOOR WITH RECESSED FIELDED PANELS AND DECORATIVE HIGHLIGHT WINDOW
	LACQUERED HARDWOOD TIMBER DOOR WITH VERTICAL TONGUE & GROOVE SLATS ON CONCEALED FIXINGS
	POWDERCOATED ALUMINIUM HORIZONTAL LOUVRES ON FRAME

ISSUED FOR PLANNING
DATE:--04.07.13

Osel architects and
development consultants

PROJECT:
1 RADLETT PLACE
LONDON
NW8 6BT
CLIENT:
Radlett Holding Ltd

DRAWING:
200 Elevations
ELEVATIONS

DRAWING No.: (700)203
SCALE: 1:100 @ A1
DRAWN: RC
CHECKED: EW
DATE: 06.13
DATE: 06.13


26 Oldbury Place, London W1U 5PR Tel: 020 7224 2447 Fax: 020 7224 2997

E-mail: admin@oselarch.co.uk Web: www.oselarchitecture.co.uk


©COPYRIGHT EXISTS ON THE DESIGNS AND INFORMATION SHOWN ON THIS DRAWING



SOUTH EAST ELEVATION

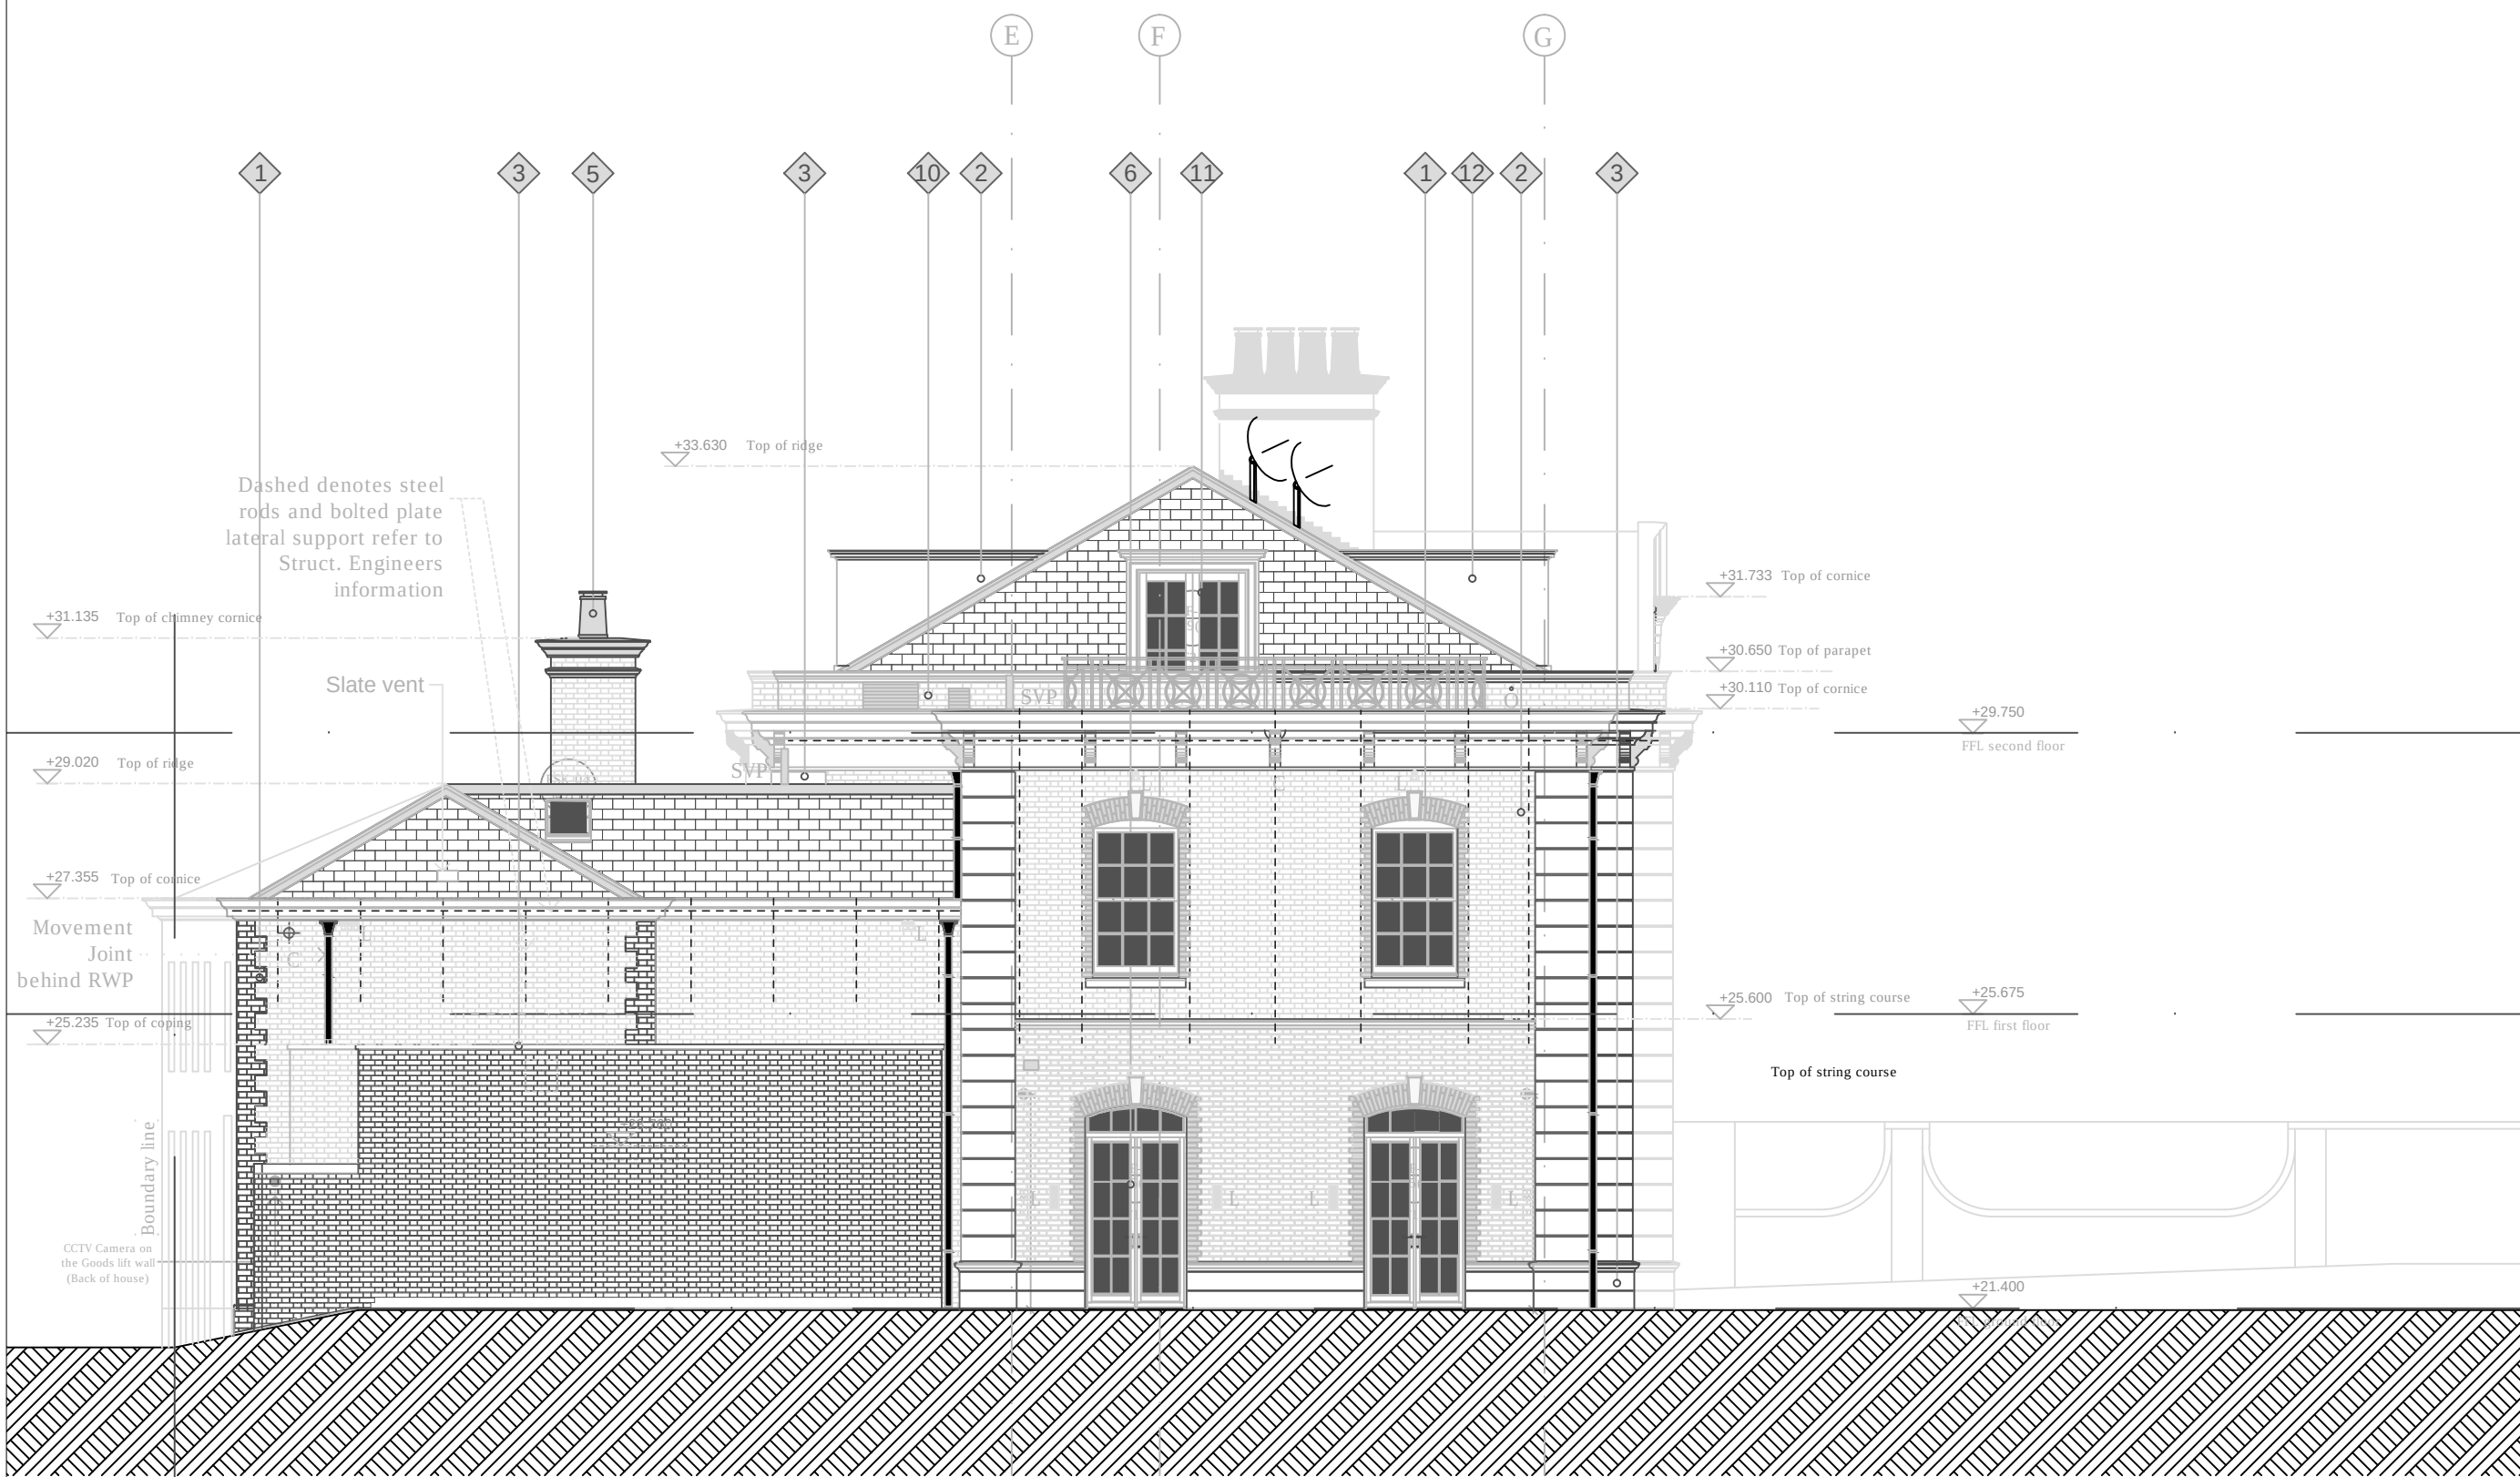

SOUTH WEST ELEVATION

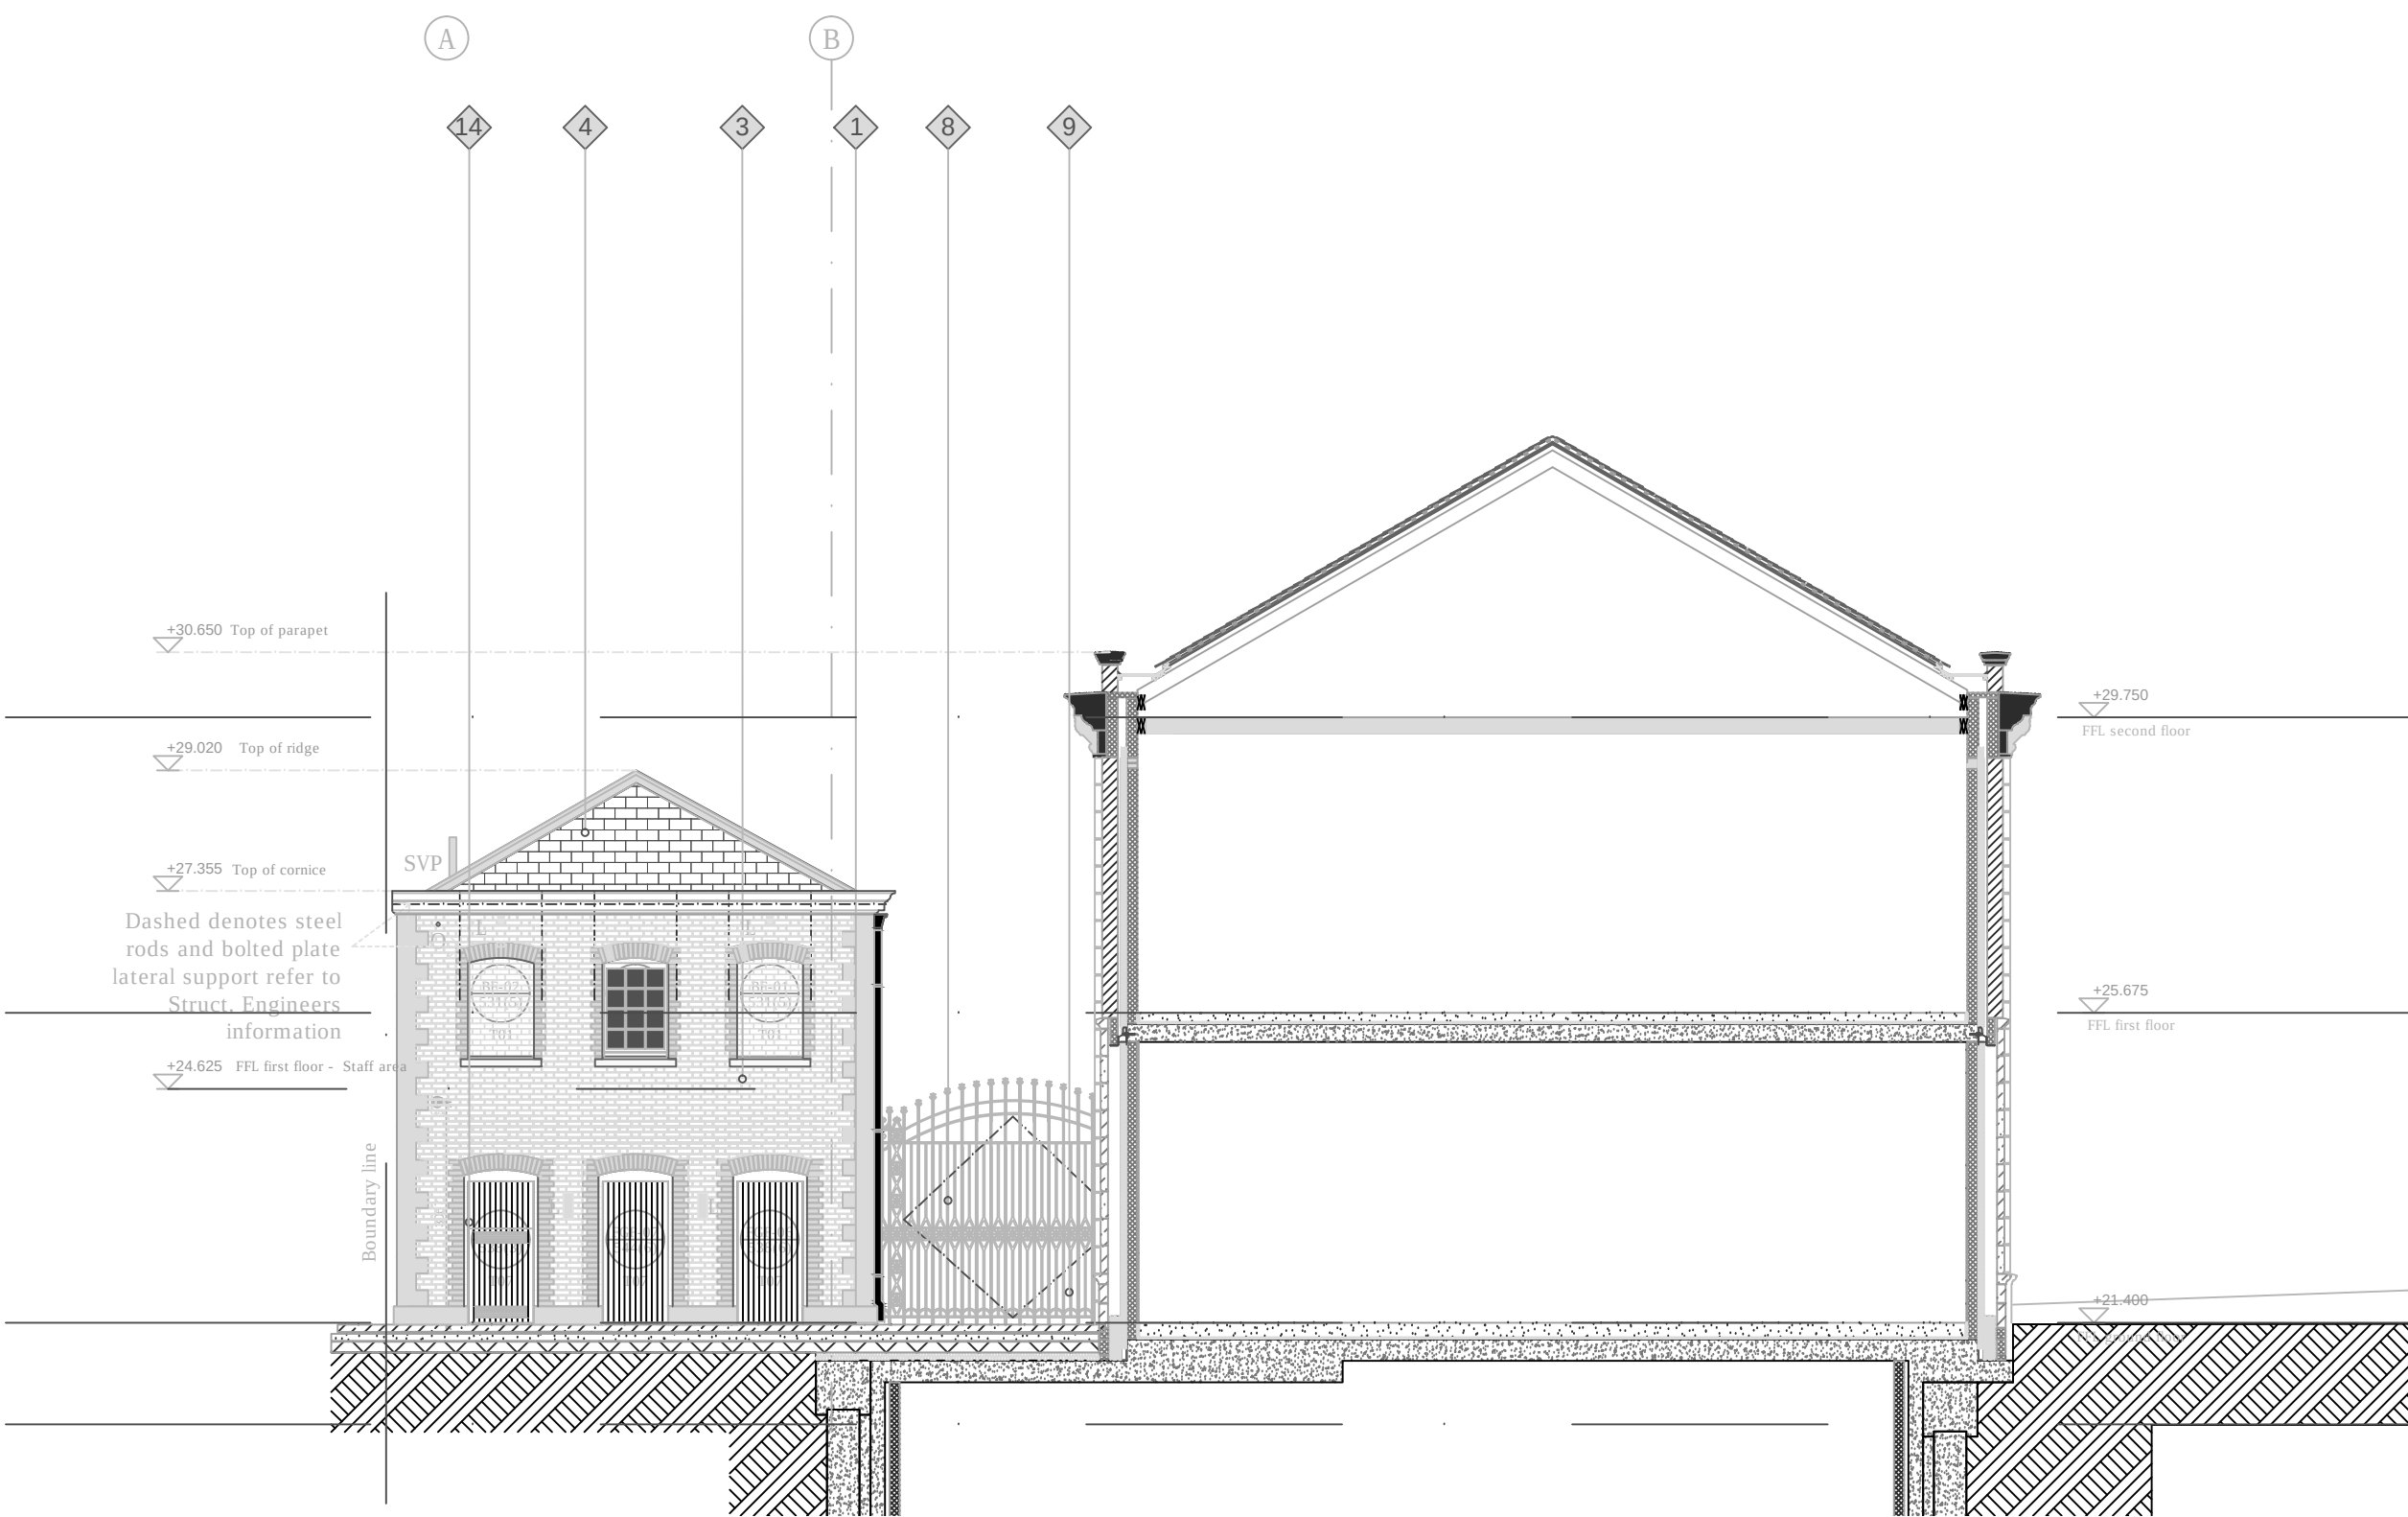

SOUTH WEST COURTYARD ELEVATION