



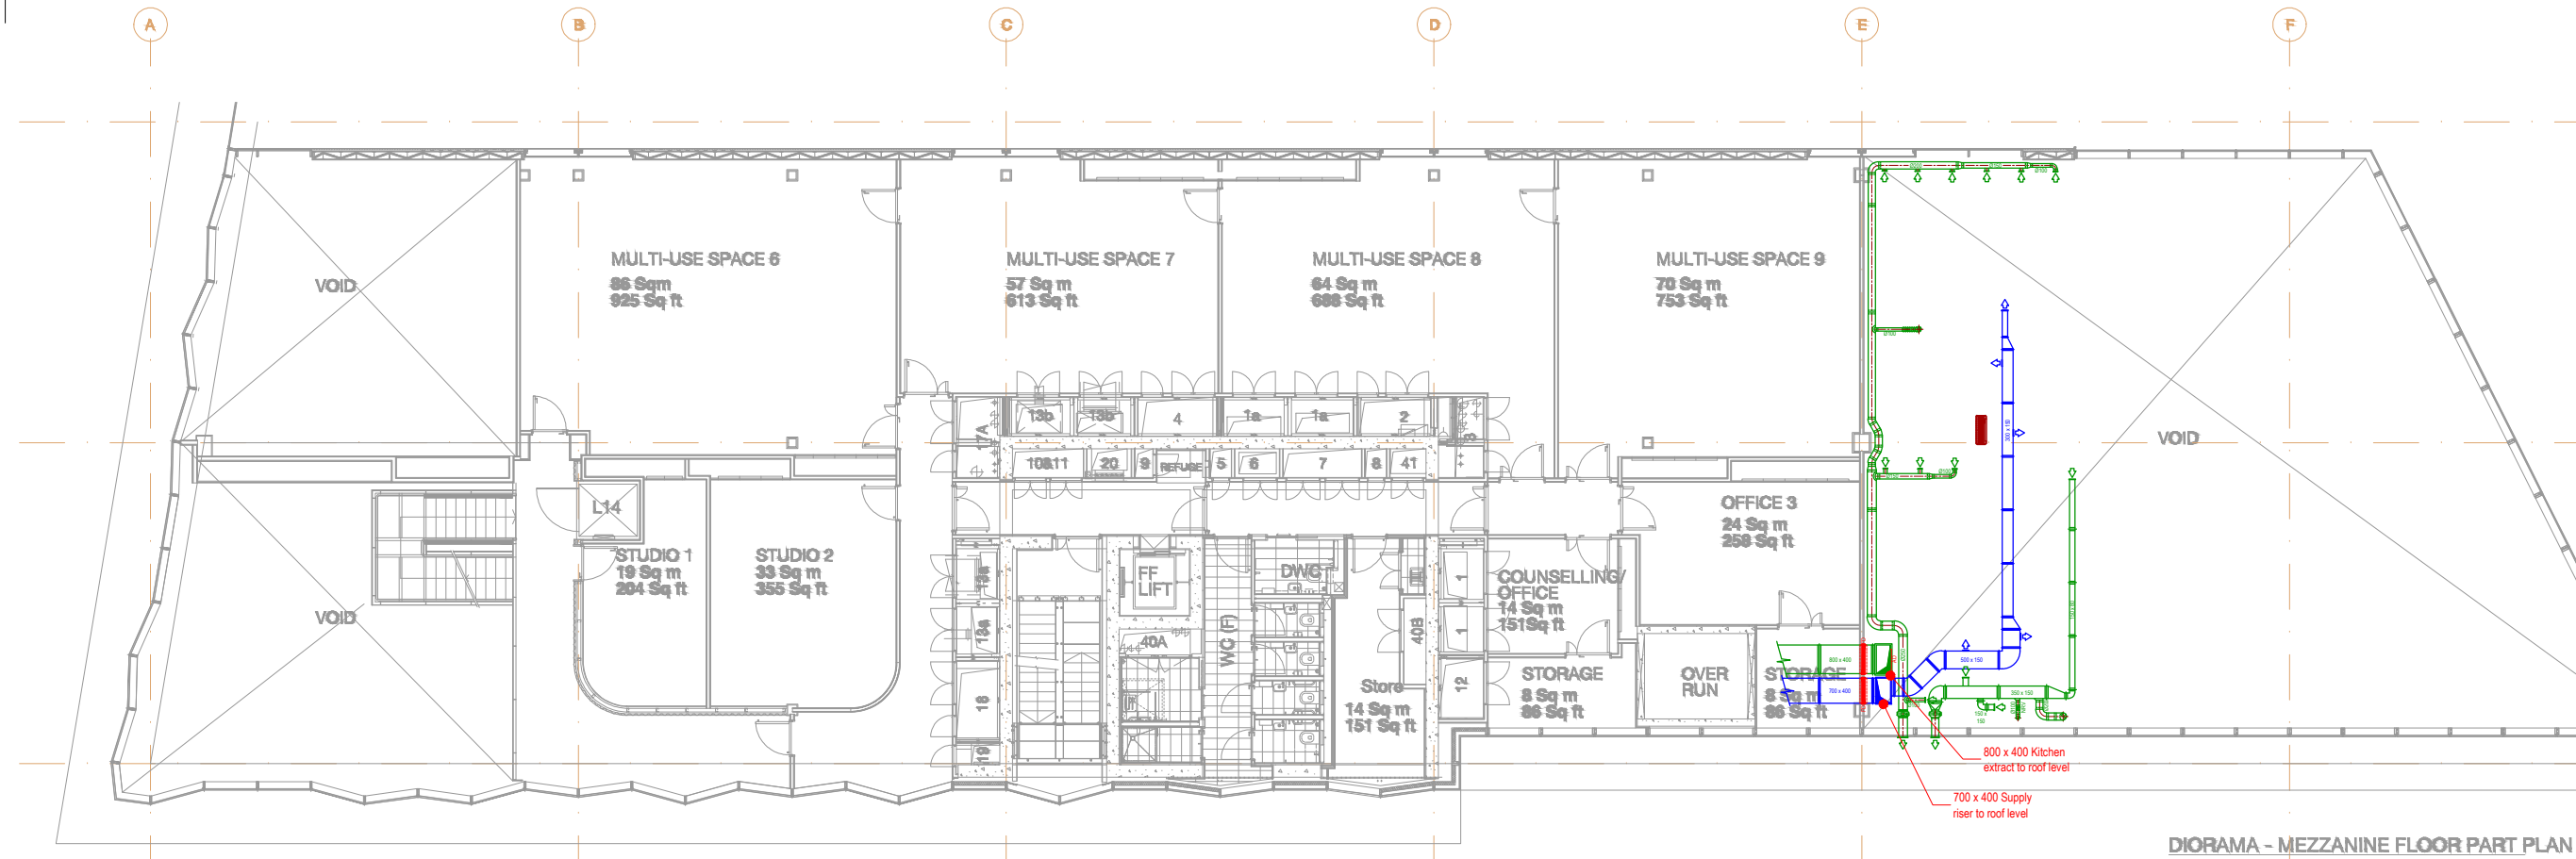

DIORAMA - MEZZANINE FLOOR PART PLAN

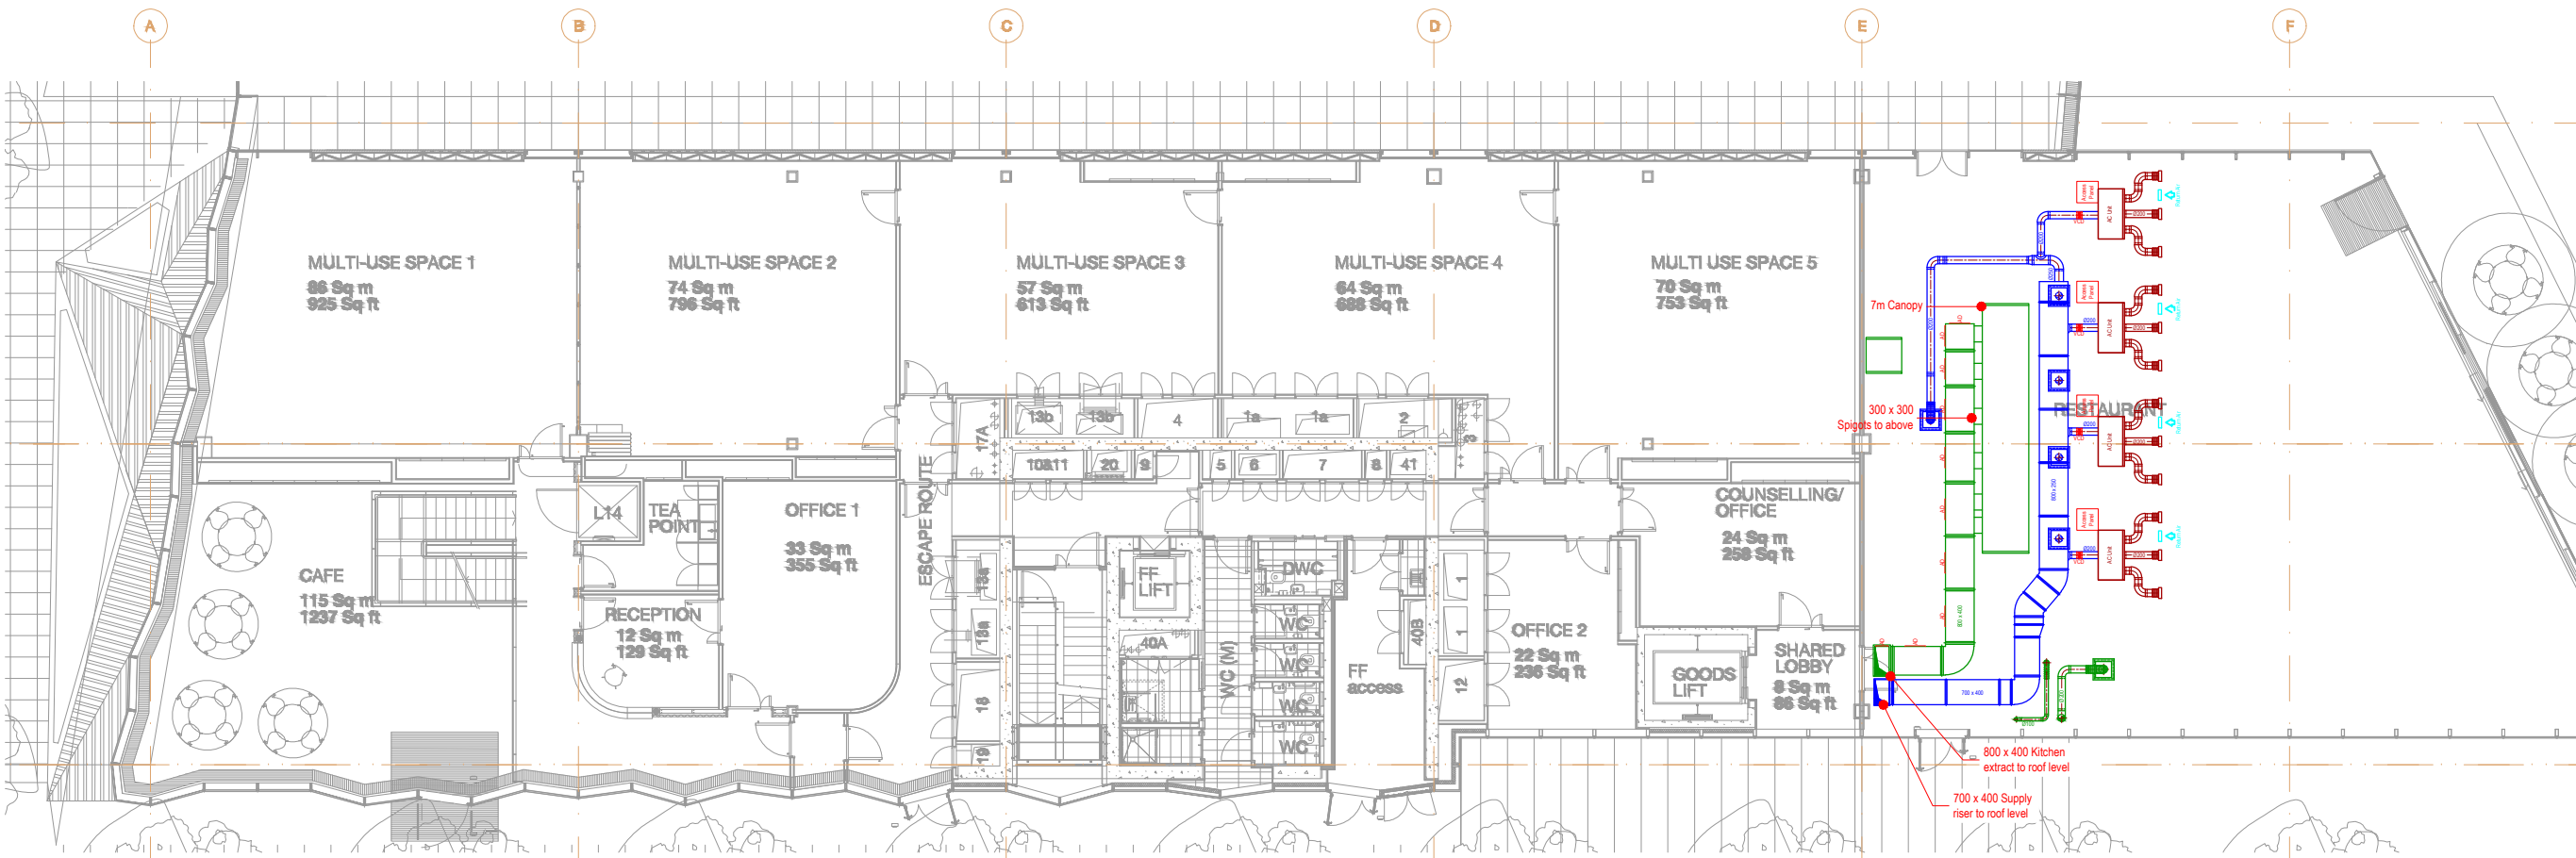

DIORAMA - GROUND FLOOR PART PLAN

C	01-08-14	RF	Revised drawing.
B	30-07-14	RF	Revised drawing no to 007-003-01 from 007-003-001.
A	18-06-14	RF	Revised hatched area on KE duct. Revised supply ducting. Revised notes.

No.	Date	Rev. By	Revision Description
-----	------	---------	----------------------

Client:
Drake & Morgan

Project:
Regents Place

Drawing Title:
Ground Floor & Mezzanine Ventilation Layout

Drawing No.:	Rev:
007-003-01	C
Scale: 1:100 @ A1 1:200 @ A3	
Drawn By: RF	Date: 22/05/14

chapman ventilation
15-20 Woodfield Road
Welwyn Garden City
Hertfordshire AL7 1JQ
Tel: 01707 372858 Fax: 01707 325001
E-mail: info@chapmanventilation.co.uk
Web: www.chapmanventilation.co.uk
Copyright of this drawing resides with Chapman Ventilation Limited