


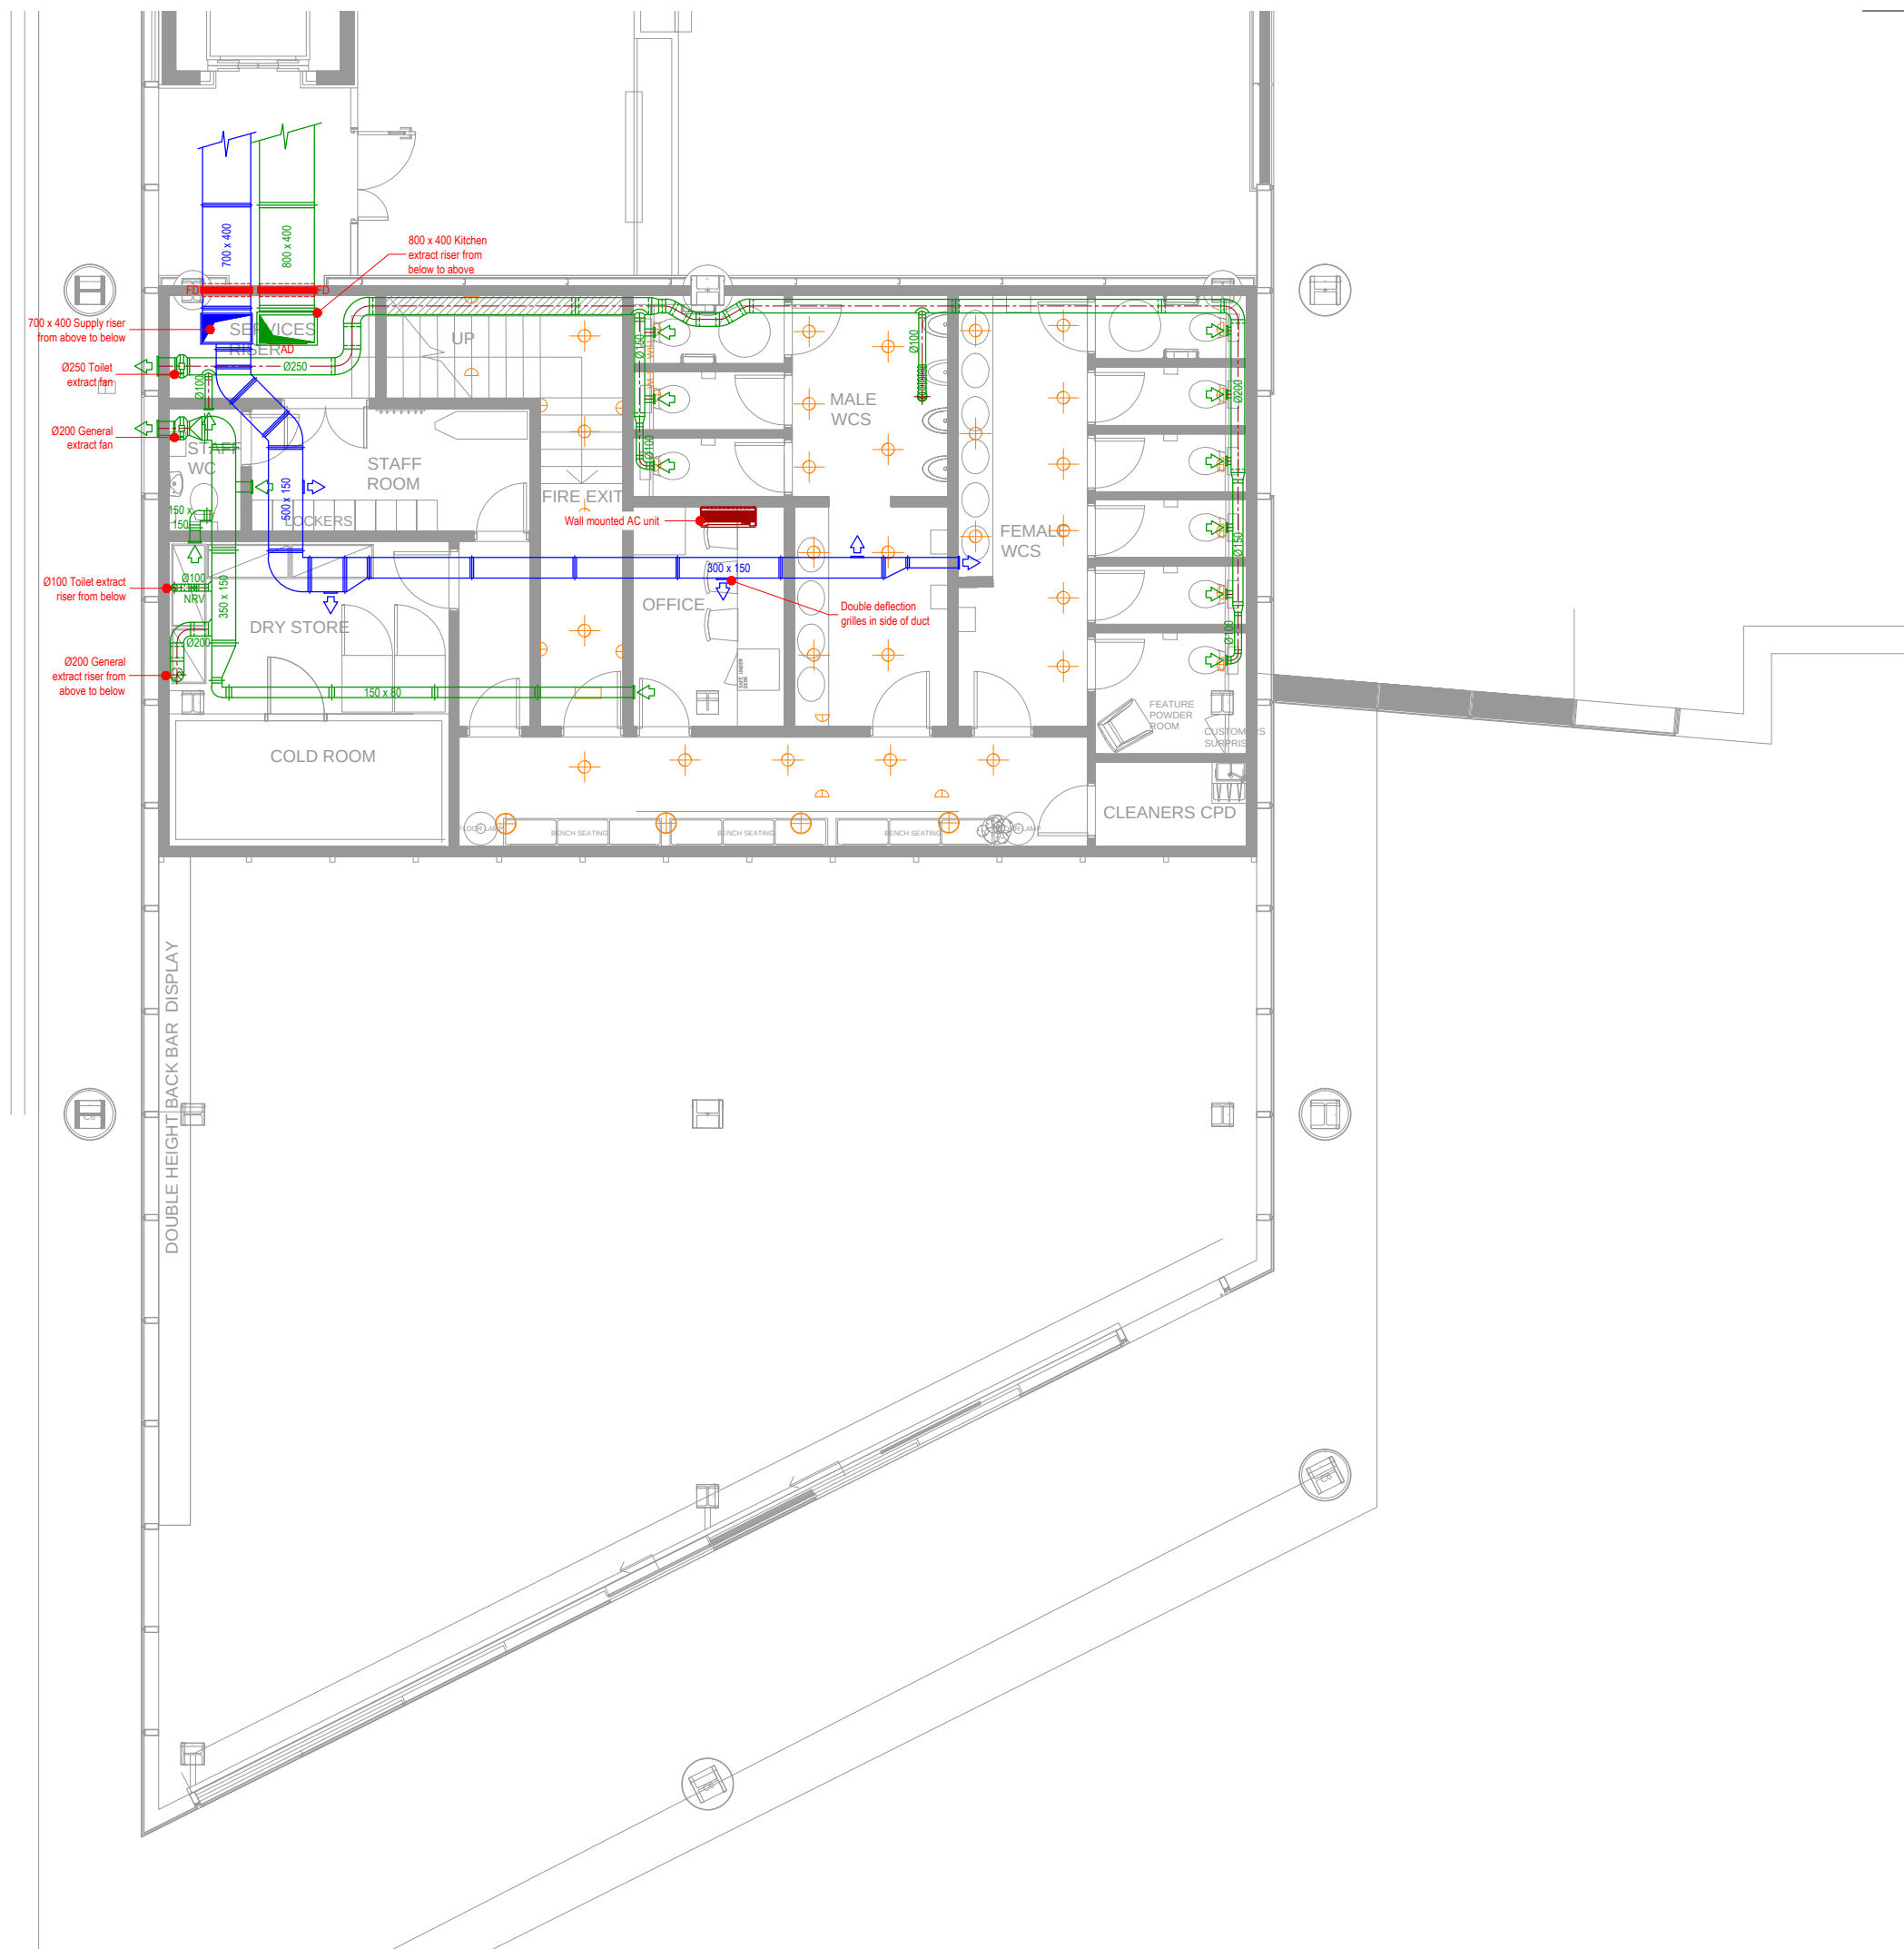

C	01-08-14	RF	Added notes and revised supply riser.
B	30-07-14	RF	Revised drawing no from 007-003-02 to 007-003-06.
A	29-07-14	RF	Revised scheme to suit new GA.
No.	Date	Rev. By	Revision Description

Client:
DRAKE & MORGAN

Project :
Regents Place

Drawing Title :
Mezzanine Ventilation Layout

Drawing No.:	Rev.:
007-003-06	C

Scale: 1:50 @ A1 1:100 @ A3
Drawn By: RF Date: 10/06/14

chapman ventilation
15-20 Woodfield Road
Welwyn Garden City
Hertfordshire AL7 1JQ
Tel: 01707 372858 Fax: 01707 325001
E-mail: info@chapmanventilation.co.uk
Web: www.chapmanventilation.co.uk

Copyright of this drawing resides with Chapman Ventilation Limited ©