

EXISTING FRONT ELEVATION
(SCALE 1:50 AT A1)

EXISTING SECTION A-A
(SCALE 1:50 AT A1)

FOR DISCUSSION
PURPOSES ONLY

Rev	Date	Description	By
Revisions			

Michael Jackson Consulting
204 BOSTON ROAD
MANCHESTER, M20 3BN
Tel: 0161 290 4104
Fax: 0161 290 4405
Chartered Structural Engineers


Niederlander

Site
**THE DOMINION
THEATRE, LONDON**

Project
**EXTERNAL FRONT
ELEVATION WORKS**

Drawing Title
**EXISTING ELEVATION
AND SECTION**

Scale	Date	Drawn	Checked	Passed
A5 SHOWN	APR 14	DS		
DRG. No.	2243-03-002			

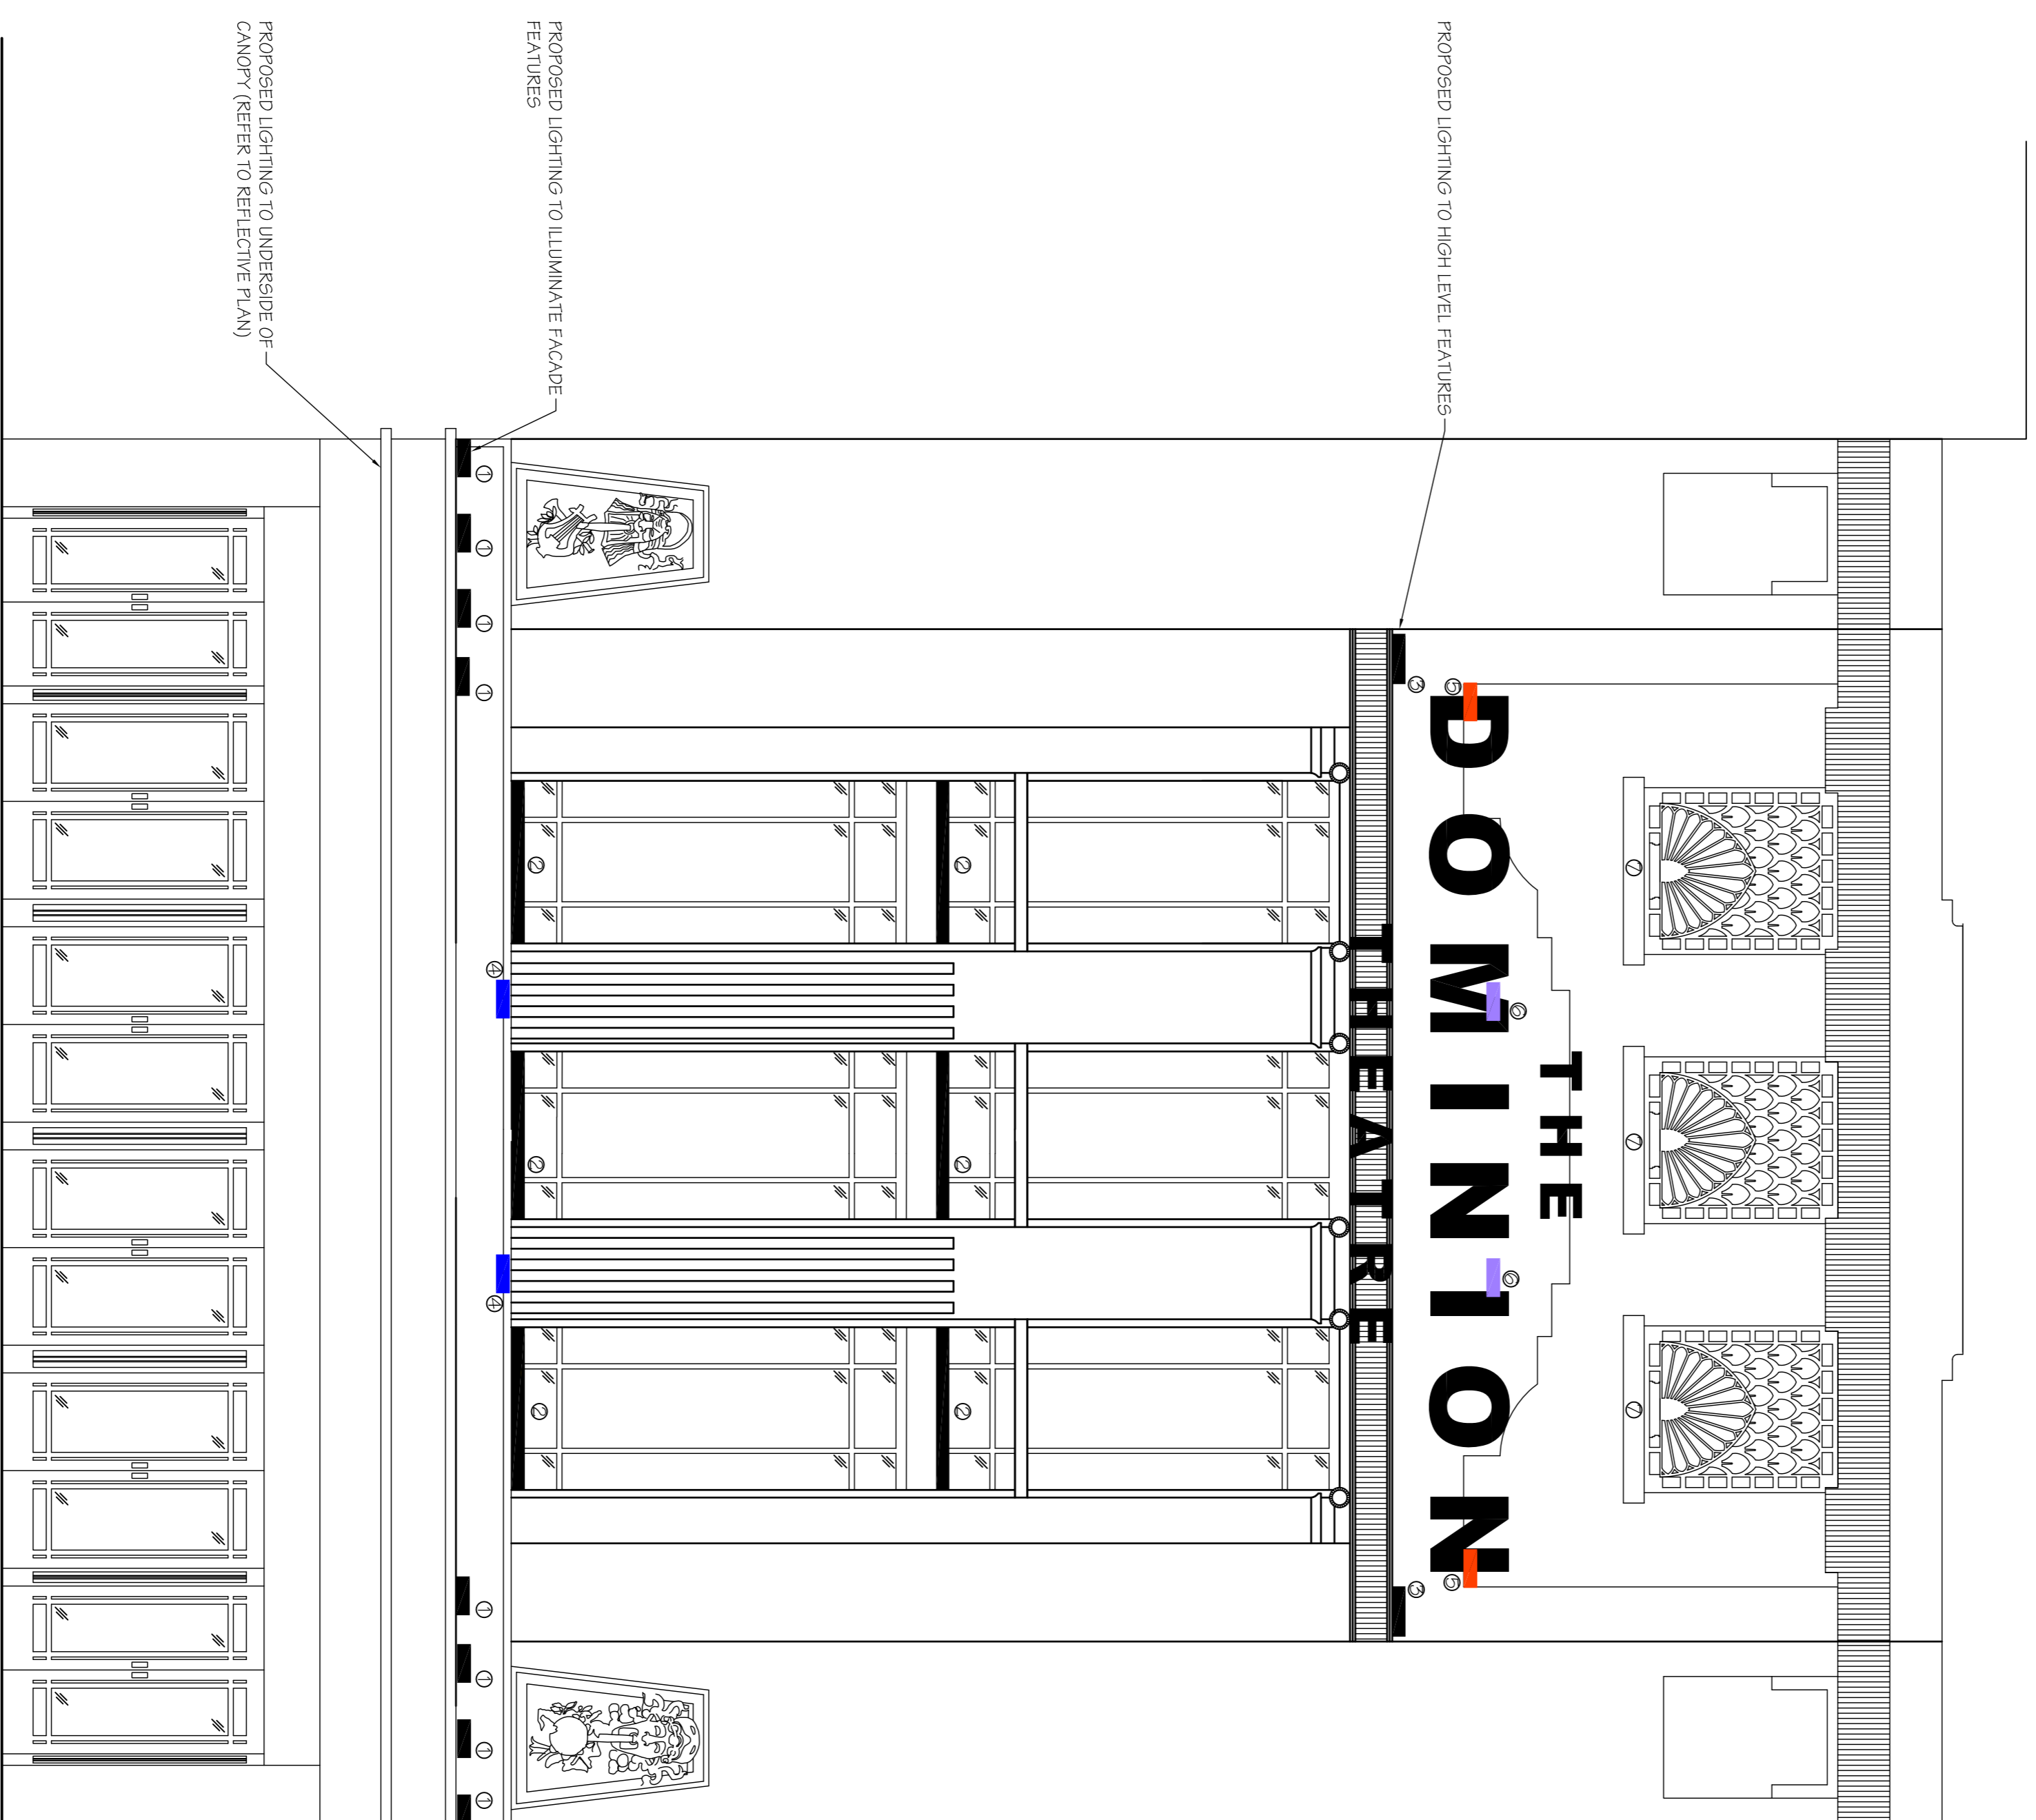

PROPOSED FRONT ELEVATION NOTING LIGHTING SCHEME
(SCALE 1:50 AT A1)

NOTE:
REFER TO PULSAR CHROMA RANGE
BROCHURE FOR LIGHTING SPECIFICATION

REF:

- ① - CHROMAFLOOD 200 TRI COLOUR LED'S SILVER BODY 8 DEGREE OPTICS
- ② - CHROMALINE 1200 1200mm SILVER BODY TRI COLOUR LED'S 10x50 DEGREE OPTIC
- ③ - CHROMABEAM 100 R2P LED'S SILVER BODY 5 DEGREE OPTICS
- ④ - CHROMABATTEN 100 600mm SILVER BODY TRI COLOUR LED'S 10x50 DEGREE OPTICS
- ⑤ - CHROMAFLOOD 100 ROUND TRI COLOUR LED'S SILVER BODY 45 DEGREE OPTICS
- ⑥ - CHROMAFLOOD 100 ROUND TRI COLOUR LED'S SILVER BODY 8 DEGREE OPTICS
- ⑦ - CHROMAFLOOD 200 TRI COLOUR LED'S BLACK BODY 8 DEGREE OPTICS

Rev	Date	Description	By
Revisions			


Client
Michael Jackson Consulting
204 BOSTON ROAD
MANCHESTER, M20 3JN
Tel: 0161 290 4104
Fax: 0161 290 4405
Chartered Structural Engineers

Site
THE DOMINION THEATRE, LONDON

Project
EXTERNAL FRONT ELEVATION WORKS

Drawing Title
PROPOSED ELEVATION NOTING LIGHTING


Scale A5 SHOWN	Date APR 14	Drawn DS	Checked PSS
DRG. No.		2243-03-005 A2	

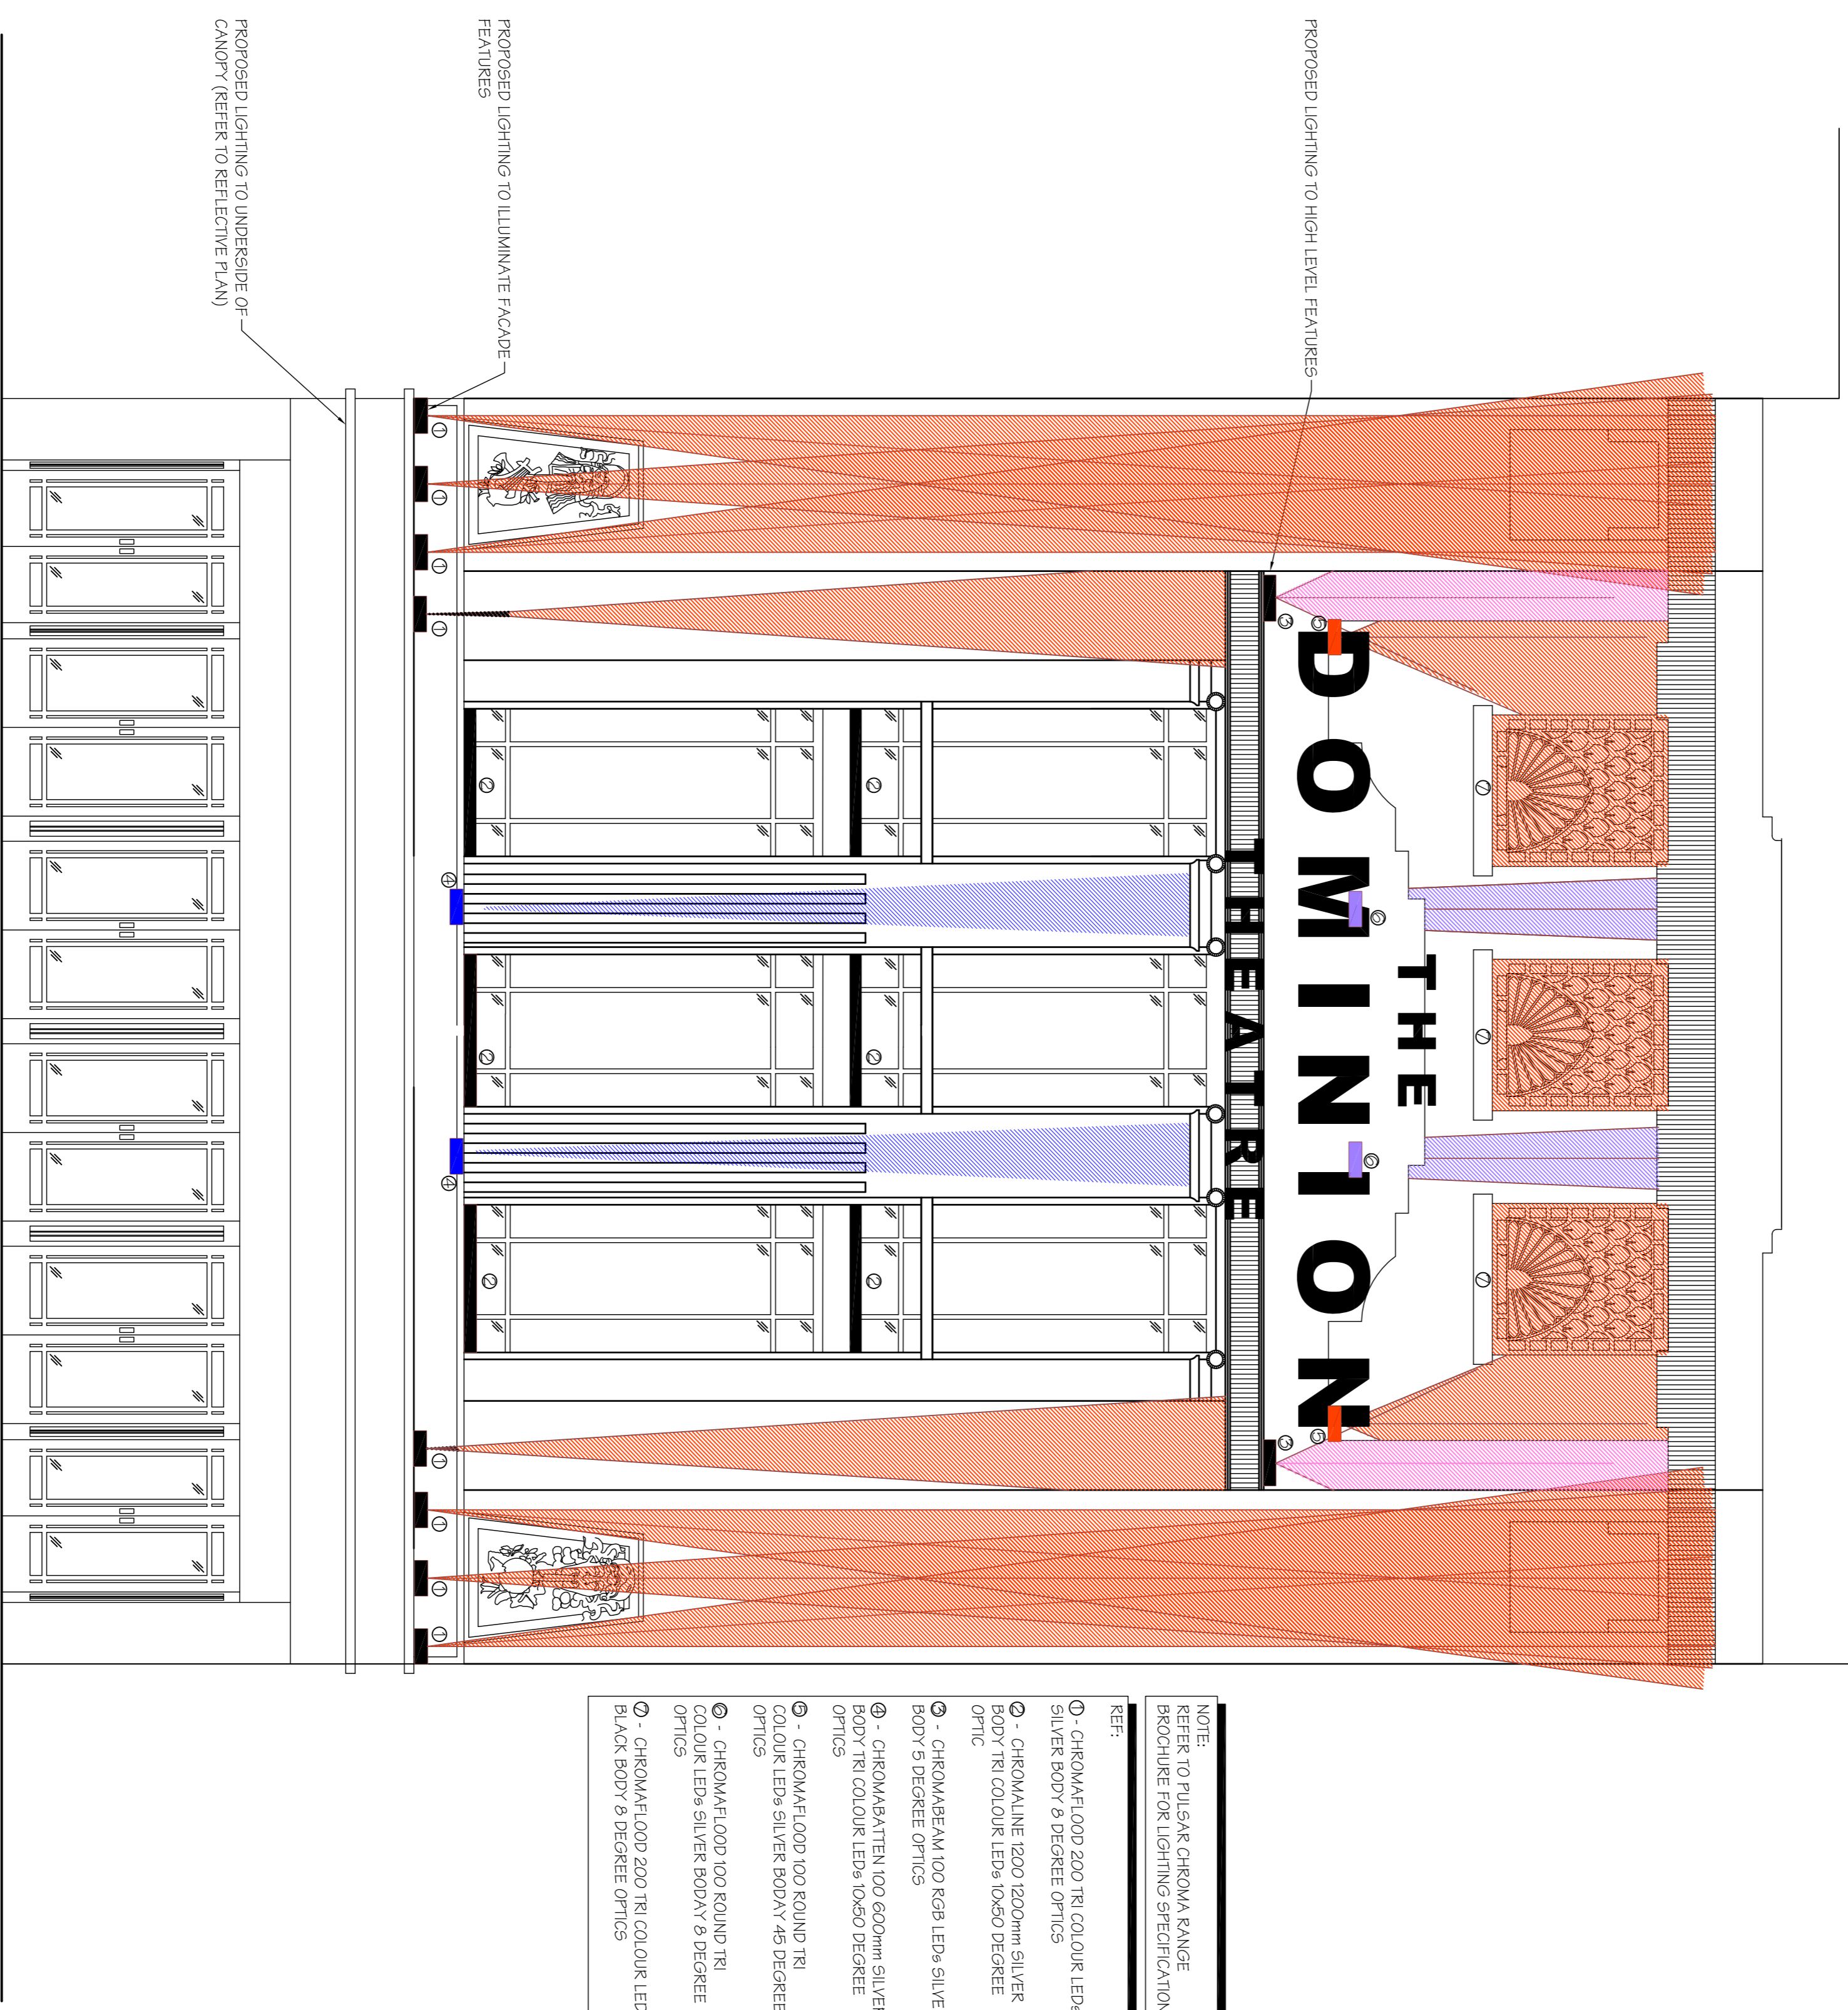

PROPOSED FRONT ELEVATION NOTING LIGHTING SCHEME
(SCALE 1:50 AT A1)


<p>Client MICHAEL JACKSON CONSULTING 204 BOSTON ROAD MANCHESTER, M20 3BN Tel: 0161 290 4104 Fax: 0161 290 4405</p>			
<p>Site THE DOMINION THEATRE, LONDON</p>			
<p>Project EXTERNAL FRONT ELEVATION WORKS</p>			
<p>Drawing Title PROPOSED ELEVATION NOTING LIGHTING</p>			
Scale	Date	Drawn	Checked/Passed
A5 SHOWN	APR 14	DS	
DRG. No.		2243-03-005 A	

Rev	Date	Description	By
Revisions			

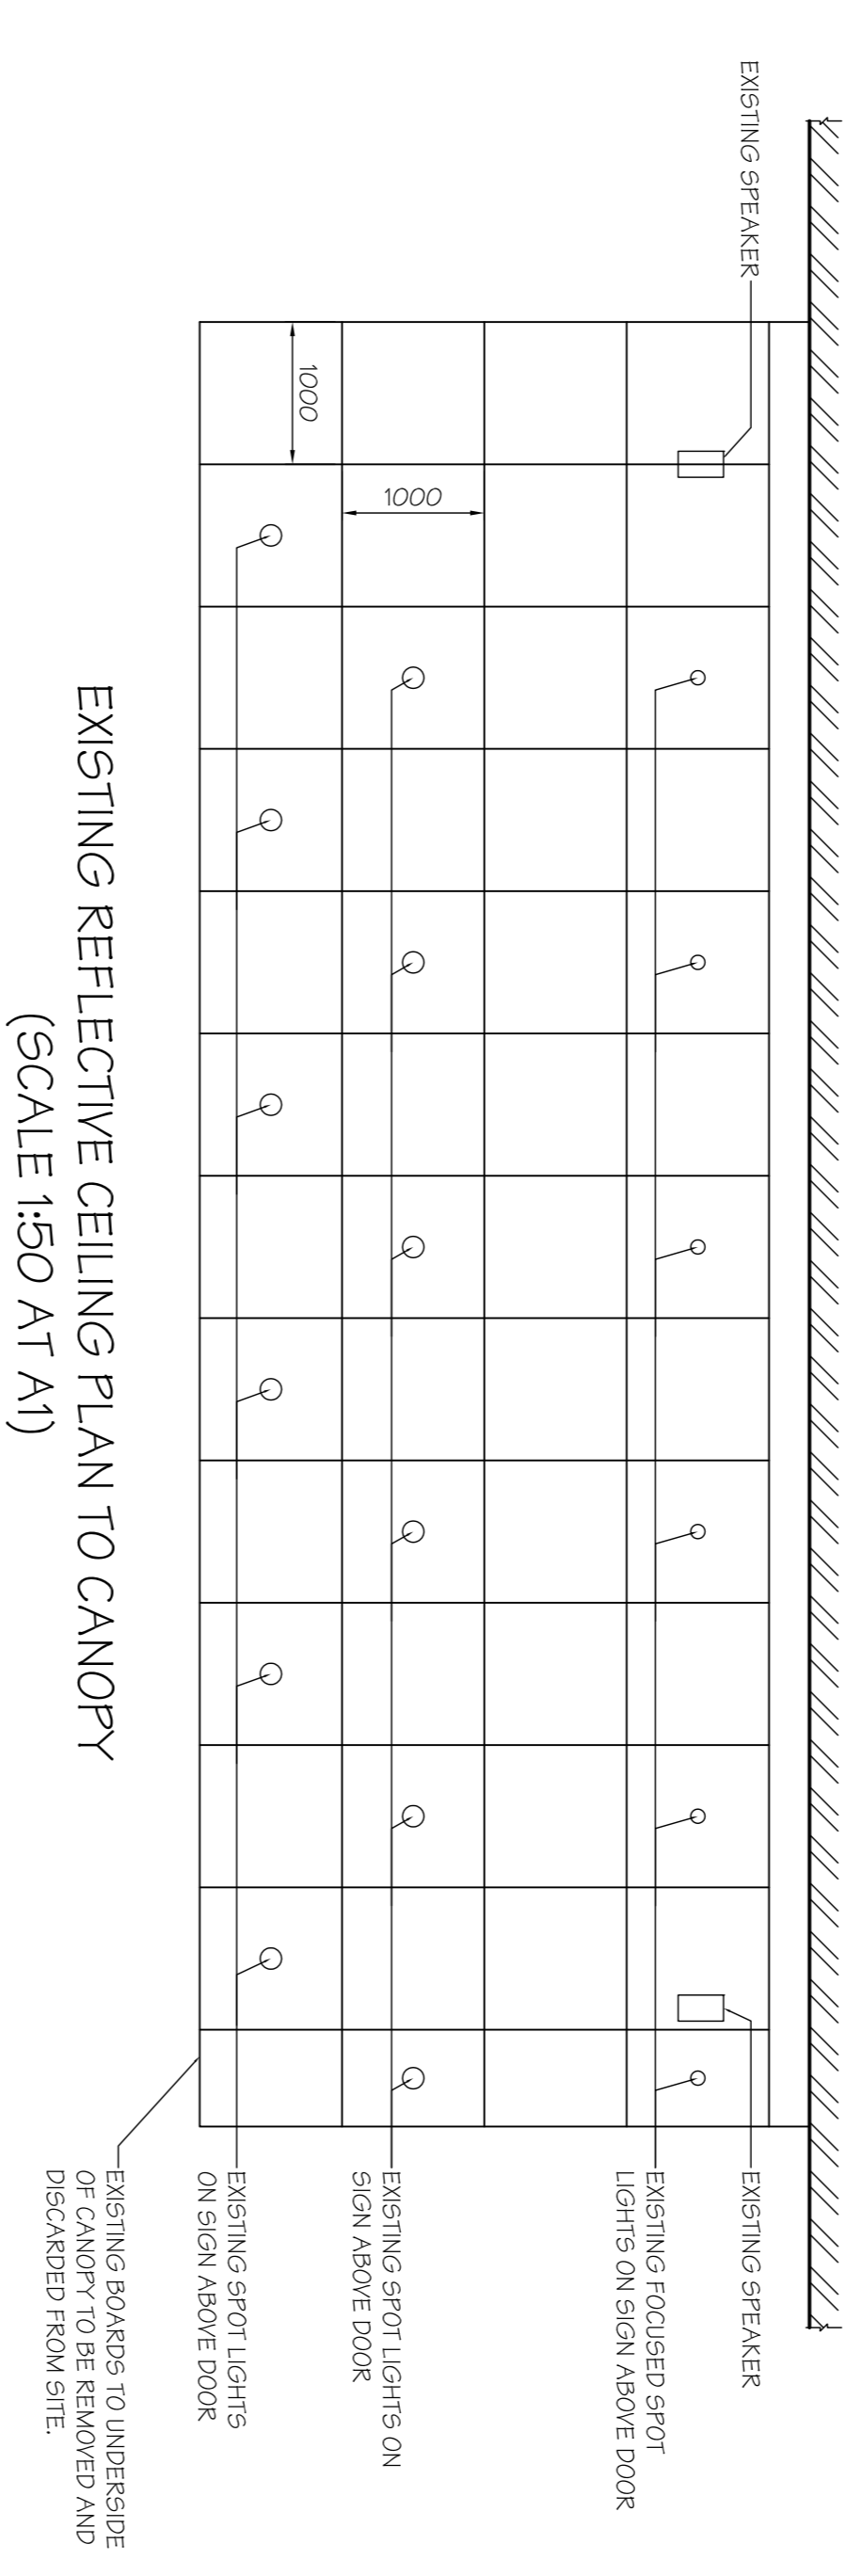


EXISTING REFLECTIVE CEILING PLAN TO CANOPY
(SCALE 1:50 AT A1)

EXISTING SPEAKER
EXISTING FOCUSED SPOT LIGHTS ON SIGN ABOVE DOOR
EXISTING SPOT LIGHTS ON SIGN ABOVE DOOR
EXISTING SPOT LIGHTS ON SIGN ABOVE DOOR
EXISTING BOARDS TO UNDERSIDE OF CANOPY TO BE REMOVED AND DISCARDED FROM SITE.

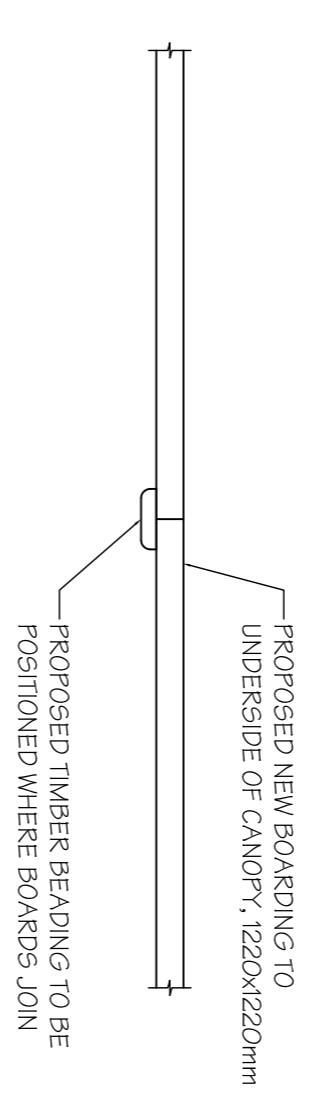

PROPOSED SECTION NOTING BEADING
(SCALE 1:5 AT A1)

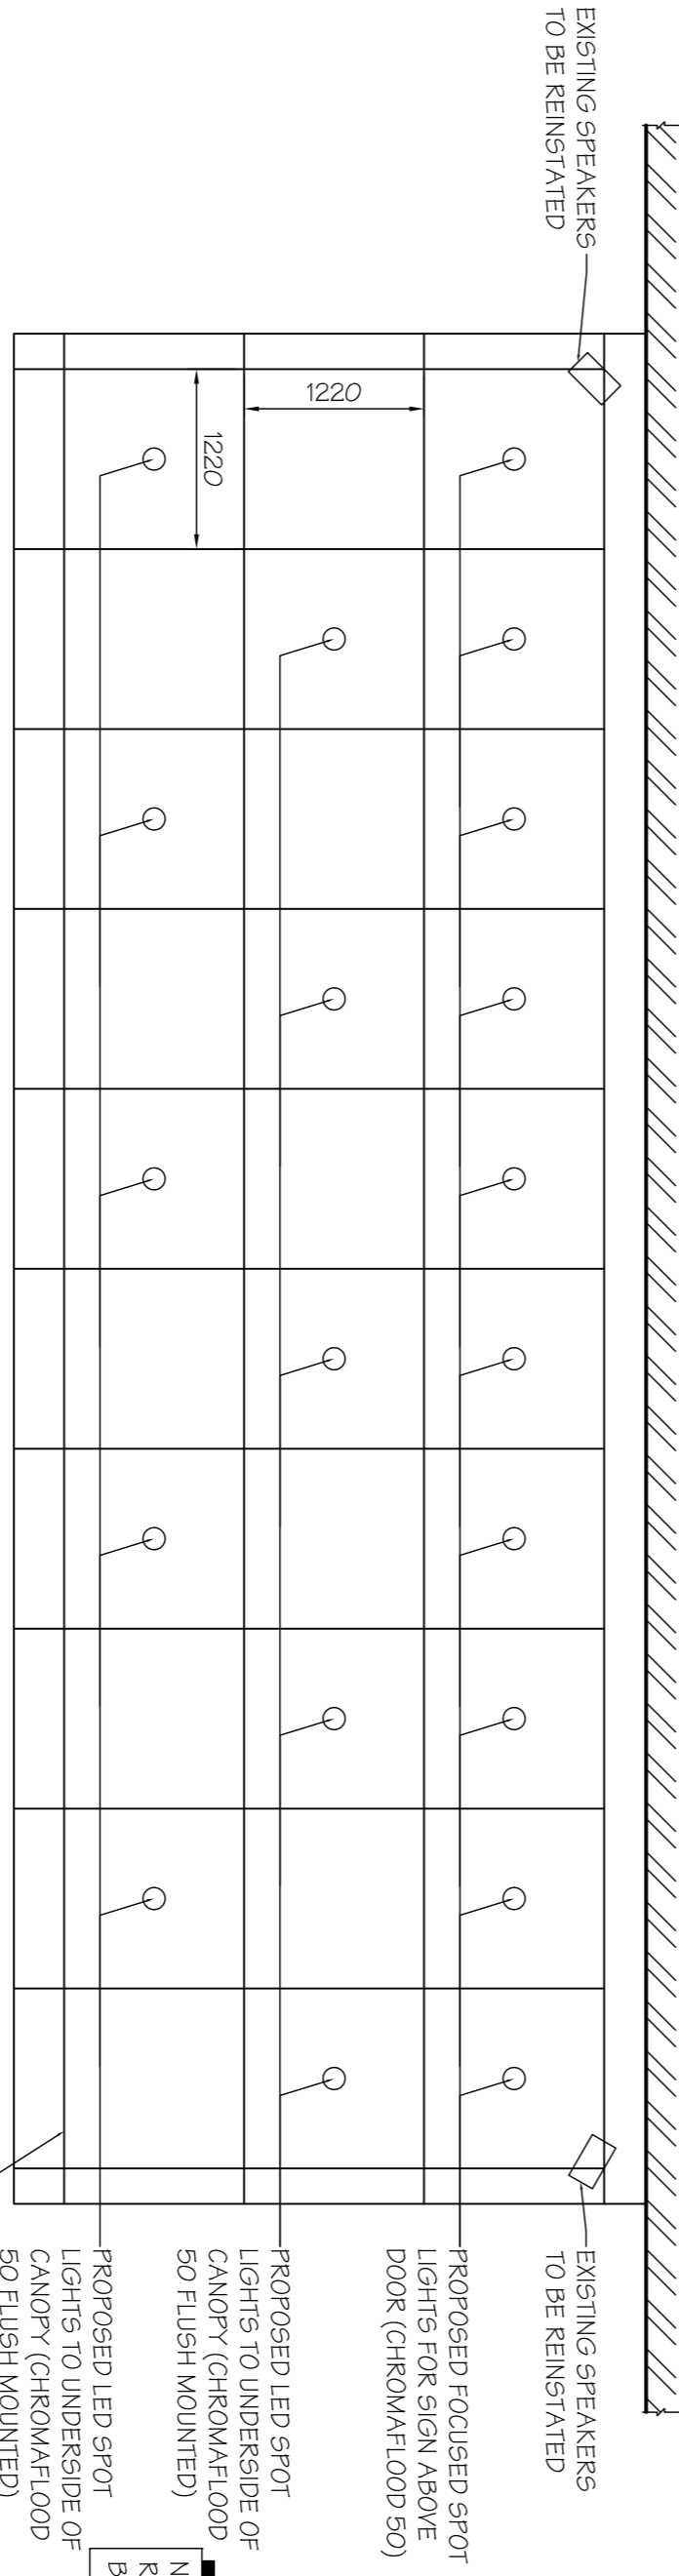

PROPOSED REFLECTIVE CEILING PLAN TO CANOPY
(SCALE 1:50 AT A1)

EXISTING SPEAKERS TO BE REINSTATED
PROPOSED FOCUSED SPOT LIGHTS FOR SIGN ABOVE DOOR (CHROMA/LOAD 50)
PROPOSED LED SPOT LIGHTS TO UNDERSIDE OF CANOPY (CHROMA/LOAD 50 FLUSH MOUNTED)
PROPOSED LED SPOT LIGHTS TO UNDERSIDE OF CANOPY (CHROMA/LOAD 50 FLUSH MOUNTED)
PROPOSED NEW BOARDS TO UNDERSIDE OF CANOPY, HARE AND HUMPHREYS TO AGREE COLOURS WITH CONSERVATION OFFICER.

NOTE:
REFER TO PULSAR CHROMA RANGE BROCHURE FOR LIGHTING SPECIFICATION

FOR DISCUSSION
PURPOSES ONLY

Rev	Date	Description	By

Client
Michael Jackson Consulting
204 BOSTON ROAD
MANCHESTER, M20 9BN
Tel: 0161 290 4104
Fax: 0161 290 4405
Chartered Structural Engineers

Project
Niederlander
THE DOMINION
THEATRE, LONDON

Site
EXTERNAL FRONT
ELEVATION WORKS

Drawing Title
**LIGHTING TO
UNDERSIDE OF
CANOPY**

Scale
AS SHOWN
Date
APR 14
Drawn
DS
Checked
PSS
DRG. No.
2243-03-008