


1

2

 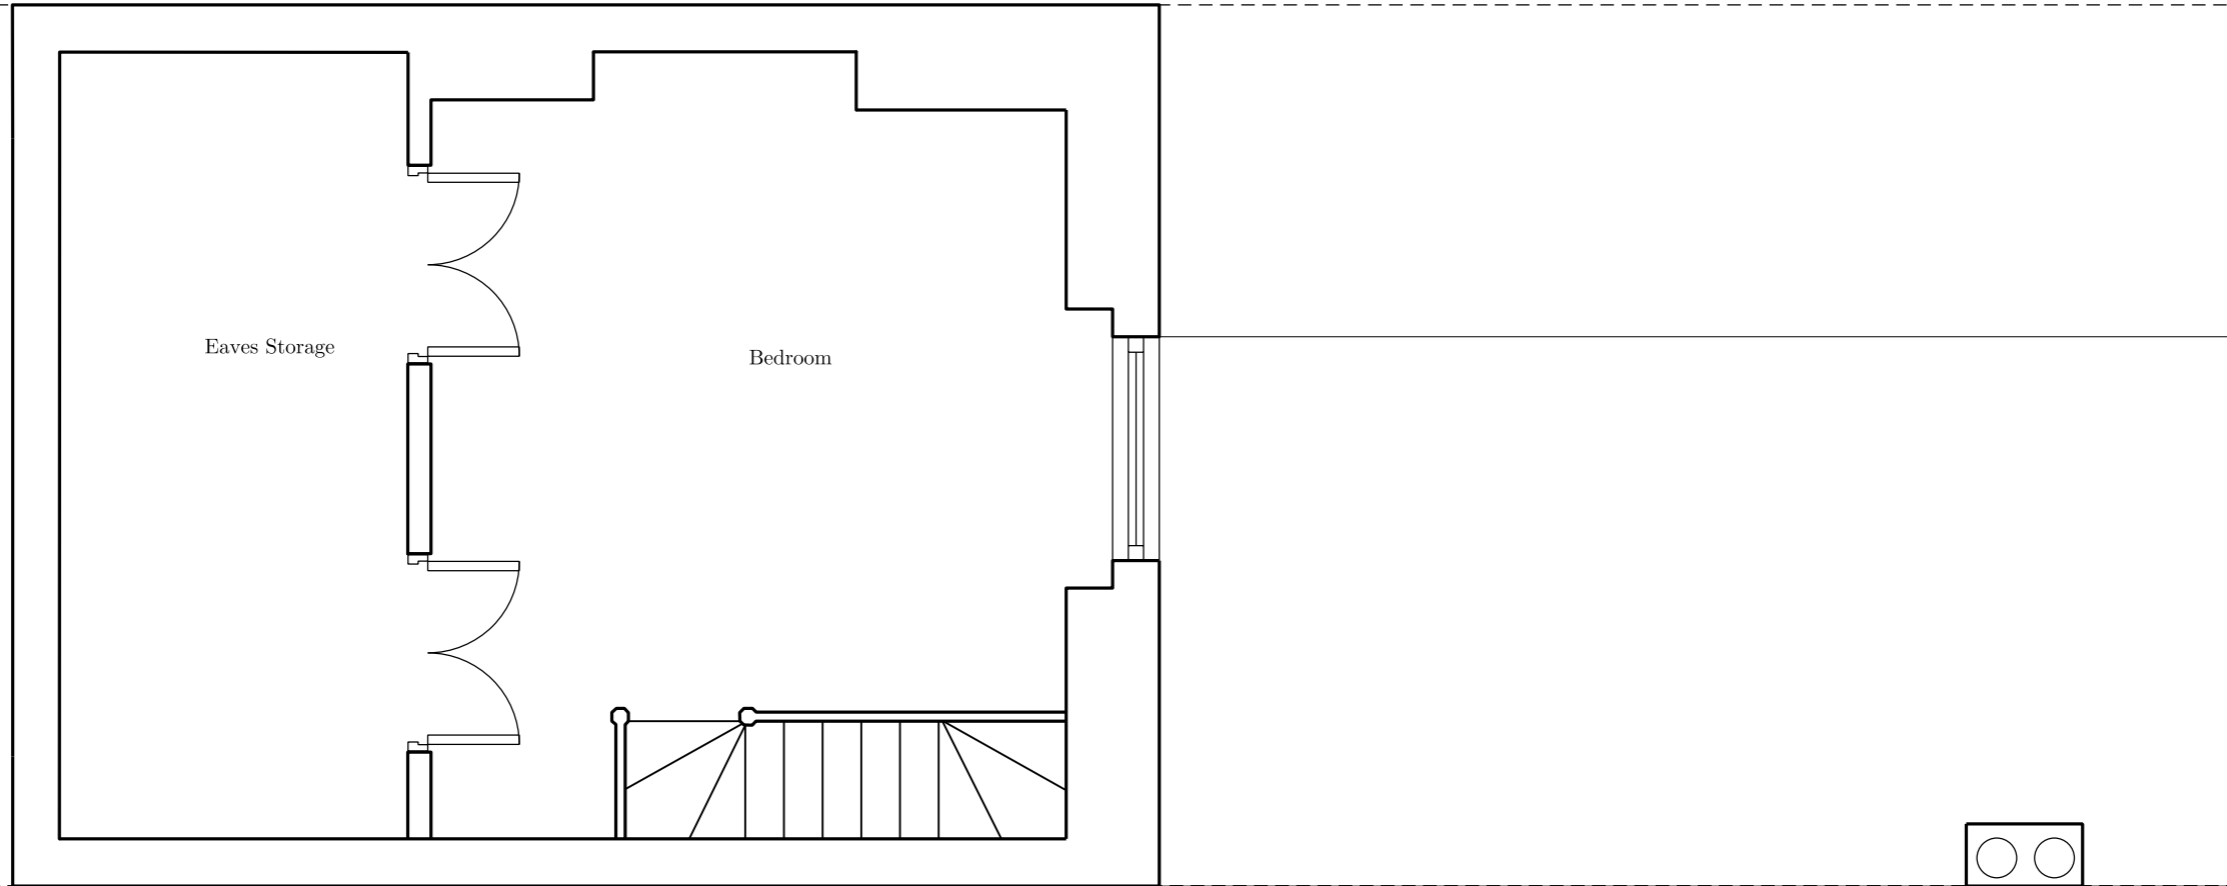


Revision description	Date	Init	Rev
----------------------	------	------	-----

rcka 3 Dyers Buildings T +44 (0) 20 7831 7002
 London F +44 (0) 20 7060 1940
 EC1N 2JT W www.rcka.co.uk

Title Third Floor Plan General Arrangement As Existing			
Project Mansfield Road		Client Panamax Limited	
Date 15.08.2014	Drawn by AB	Checked -	Scale 1:50@ A3
Job No 1421	Drwg No PL-GA-003	Revision -	

Scale 1:50



©2014 RCKa. This drawing is not to be scaled - use written dimensions only. Any discrepancies to be reported to the architect. All dimensions to be checked on site.